


DEPARTMENT OF VETERANS AFFAIRS MEDICAL CENTER

1400 BLACK HORSE HILL ROAD
COATESVILLE, PA 19320

BUILDING 69
HVAC UPGRADE

PROJECT NO. 542-09-102
MARCH 14, 2012

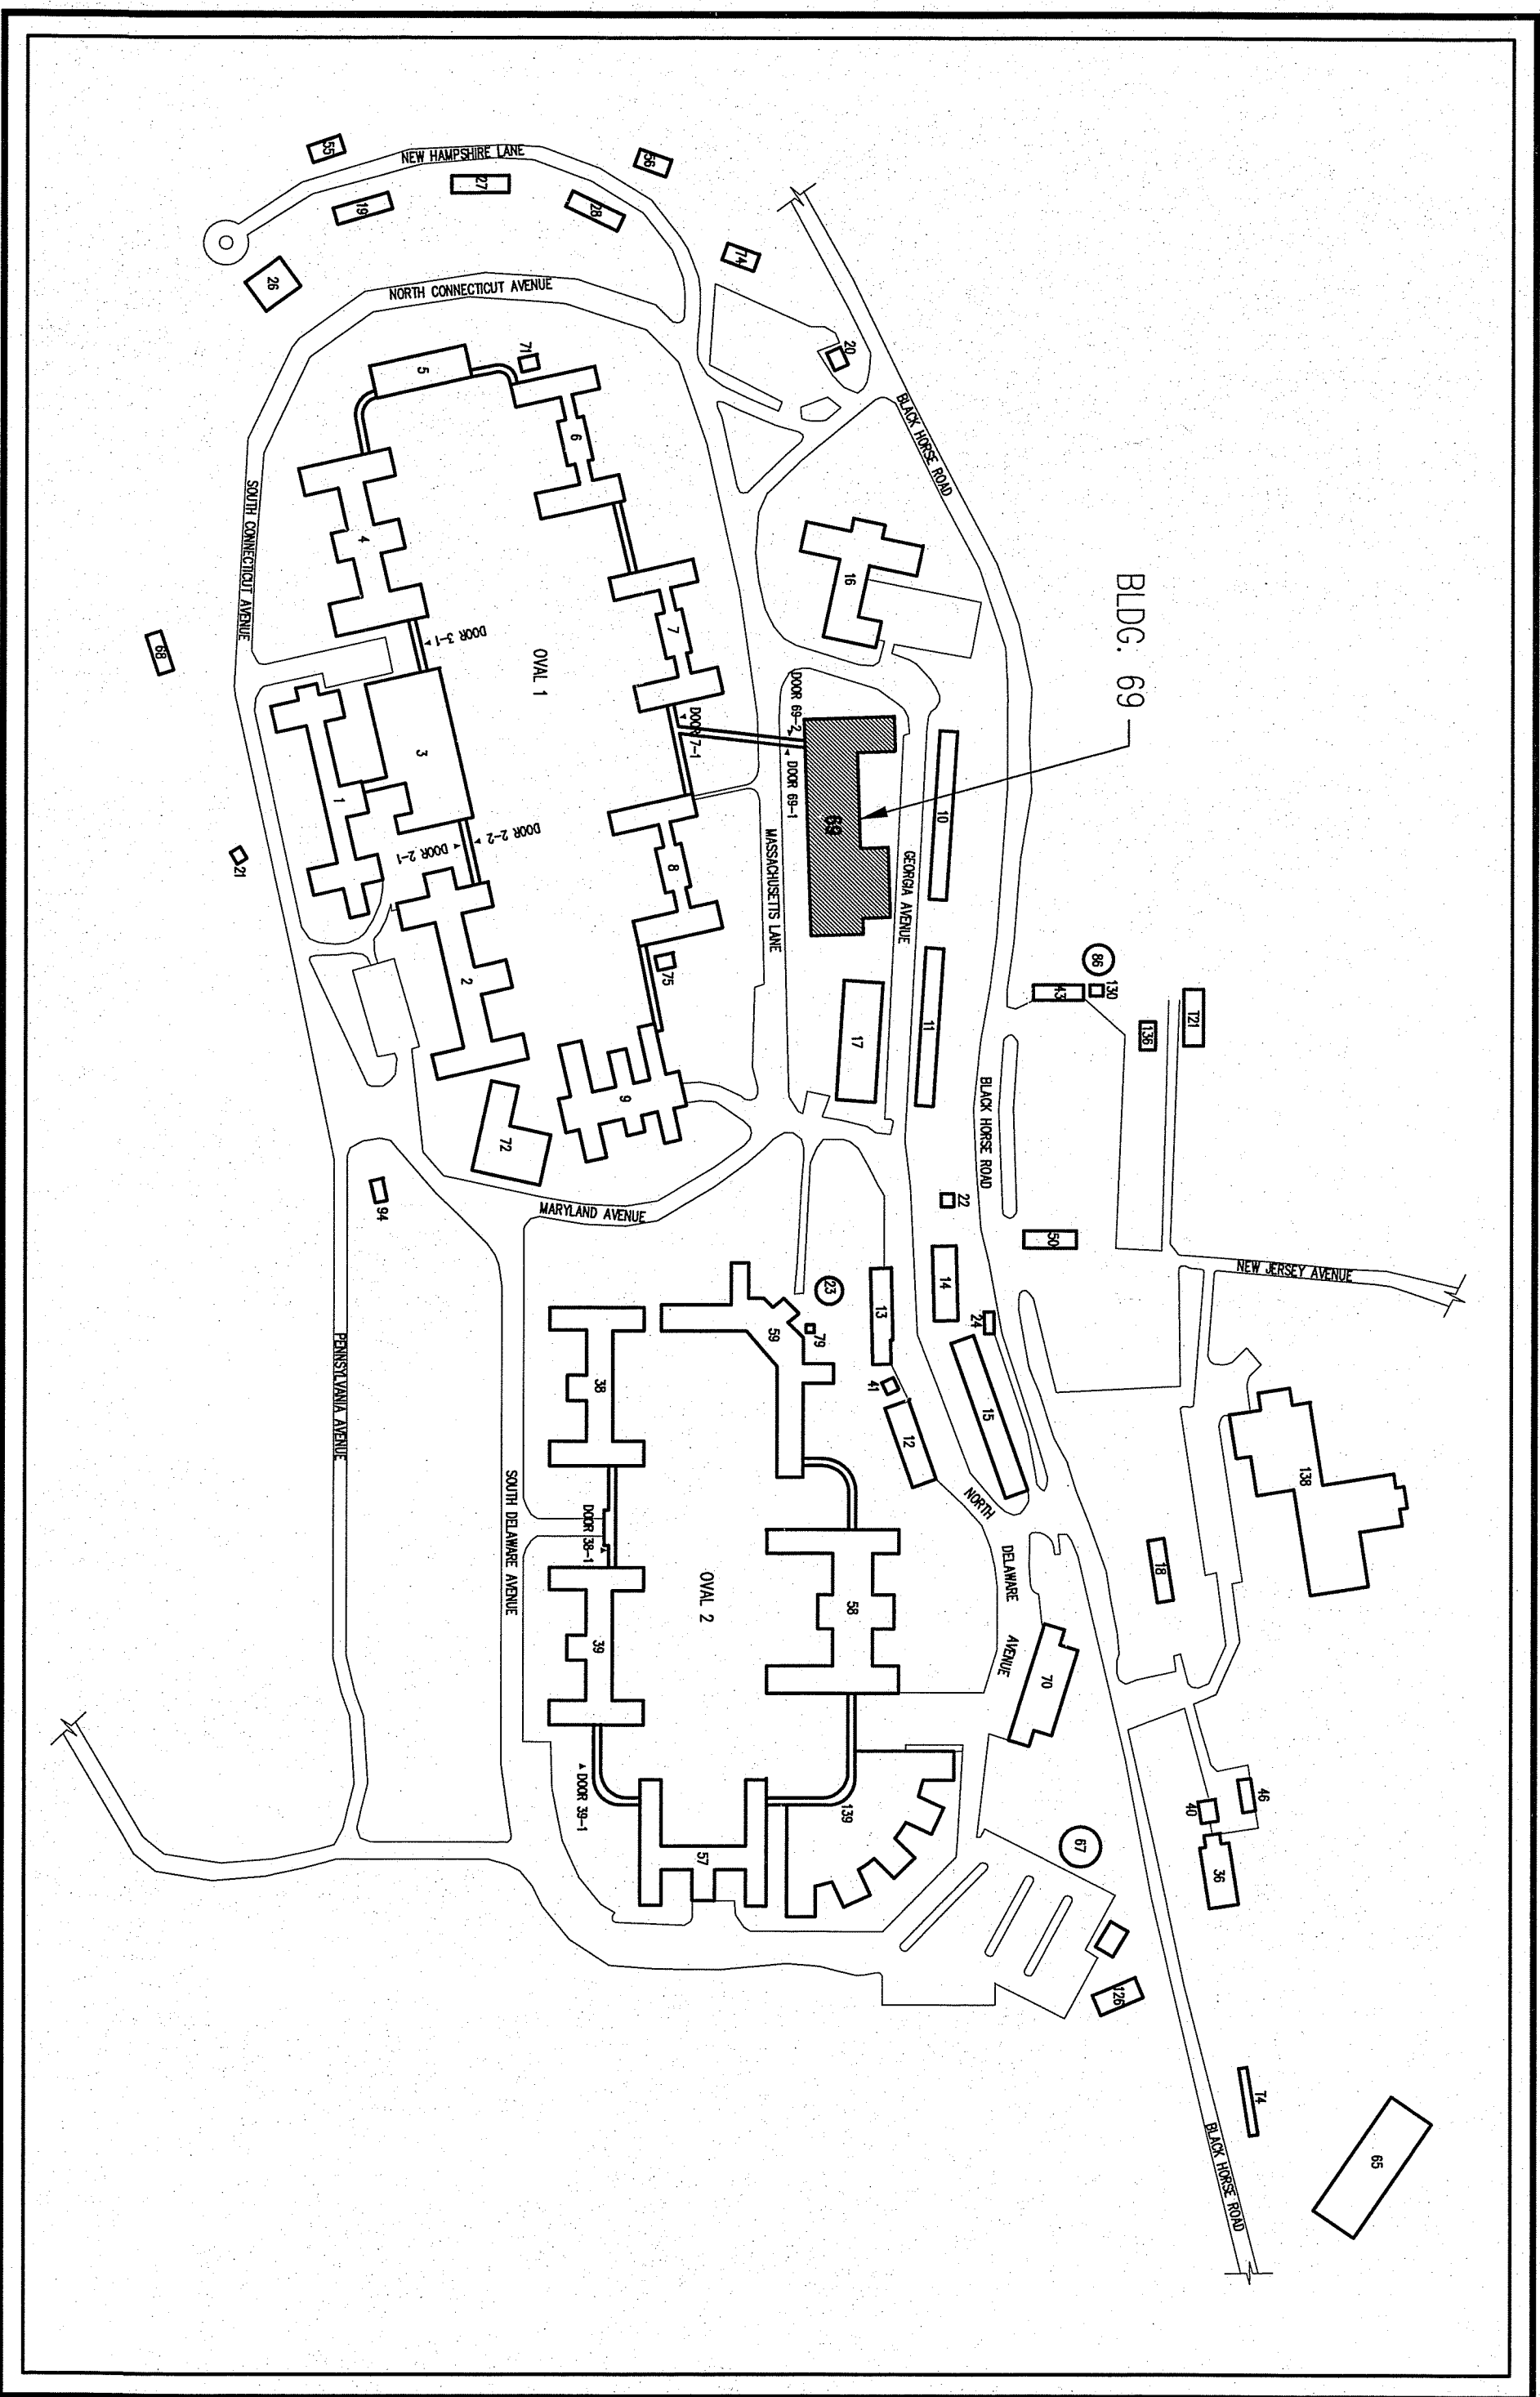

SITE PLAN
N.T.S.

BID ITEMS

BASE BID:
BASE BID SHALL INCLUDE ALL WORK INDICATED ON THE
CONSTRUCTION DRAWINGS AND AS DESCRIBED IN THE
CONSTRUCTION SPECIFICATIONS.

INDEX OF DRAWINGS

DWG. NO.	DWG. NAME
X1	COVER SHEET
69-C1	DEMOLITION PLAN
69-C2	WATER LINE PLAN AND PROFILE
69-A1	MAIN FLOOR PLAN
69-HA21	HAZARDOUS MATERIALS ABATEMENT PLAN
69-H1	MECHANICAL LEGEND, ABBREVIATIONS, SCHEDULES, AND GENERAL NOTES
69-H2	MAIN FLOOR PLAN - HVAC DUCTWORK - DEMOLITION
69-H3	MAIN FLOOR PLAN - HVAC PIPING - DEMOLITION
69-H4	BASEMENT FLOOR PLAN - HVAC PIPING - DEMOLITION
69-H5	MAIN FLOOR PLAN - HVAC DUCTWORK - NEW WORK
69-H6	MAIN FLOOR PLAN - HVAC PIPING - NEW WORK
69-H7	BASEMENT FLOOR PLAN - HVAC PIPING - NEW WORK
69-H8	BUILDING 17 (CHILLER PLANT) - FIRST FLOOR PLAN - HVAC PIPING - NEW WORK
69-H9	MECHANICAL DETAILS
69-H10	MECHANICAL DETAILS
69-H11	MECHANICAL CONTROL SEQUENCES
69-H12	FLOW DIAGRAMS
69-E1	ELECTRICAL LEGEND, ABBREVIATIONS, AND SCHEDULES
69-E2	BASEMENT FLOOR PLAN - ELECTRICAL - DEMOLITION
69-E3	MAIN FLOOR PLAN - ELECTRICAL - DEMOLITION
69-E4	BASEMENT FLOOR PLAN - POWER - NEW WORK
69-E5	MAIN FLOOR PLAN - POWER - NEW WORK

