

**REQUEST FOR INFORMATION (RFI)**  
**36C250-18-B-0081**

PROJECT NUMBER:	610-15-100	<b>Please ensure that before submitting questions or requests for clarification that you thoroughly read the solicitation, specifications, drawings and other pertinent documents. When submitting questions on this project the Government requires contractors to specifically identify the specification and/or solicitation section(s) or drawing number(s) in reference to the question or request for clarification submitted. No question or request for clarification will be answered by the Government unless the above requirements are met. Failure to comply may prevent the Government from responding in a timely manner.</b>
PROJECT TITLE:	Demolish Bldgs. 7,10,11,18,24,60 and Connecting Corridors	
PROJECT LOCATION:	Department of Veterans Affairs VA Northern Indiana HCS 1700 E. 38 <sup>th</sup> Street Marion, IN 46953	

SUBMITTED BY:	Shambaugh & Son, L.P.	CITY/STATE:	Marion, IN
PHONE:	260-224-5007		

**TO:**

Felecia Beamen, Contracting Officer  
Department of Veterans Affairs  
Network 10 Contracting Office  
8888 Keystone Crossing, Suite 1100  
Indianapolis, IN 46240  
[Felecia.Beamen@va.gov](mailto:Felecia.Beamen@va.gov)

RFI NO.: #E10	DATE:	SPEC/DWG. REFERENCE(s):
		ET-103 – Coded Note #2
REPLY NEEDED BY: 1-2-2018		

**INFORMATION NEEDED:**

How many & what size conduits are used for the communication ductbanks?


**REPLY:**

**RFI's will be answered by amendment(s) posted to fbo.gov.**

See attached.

REPLY FROM: VA Marion Station Facilities	DATE: 12-21-17
ATTACHMENTS: 1	COPY TO:


A  
B  
C  
D  
E  
F

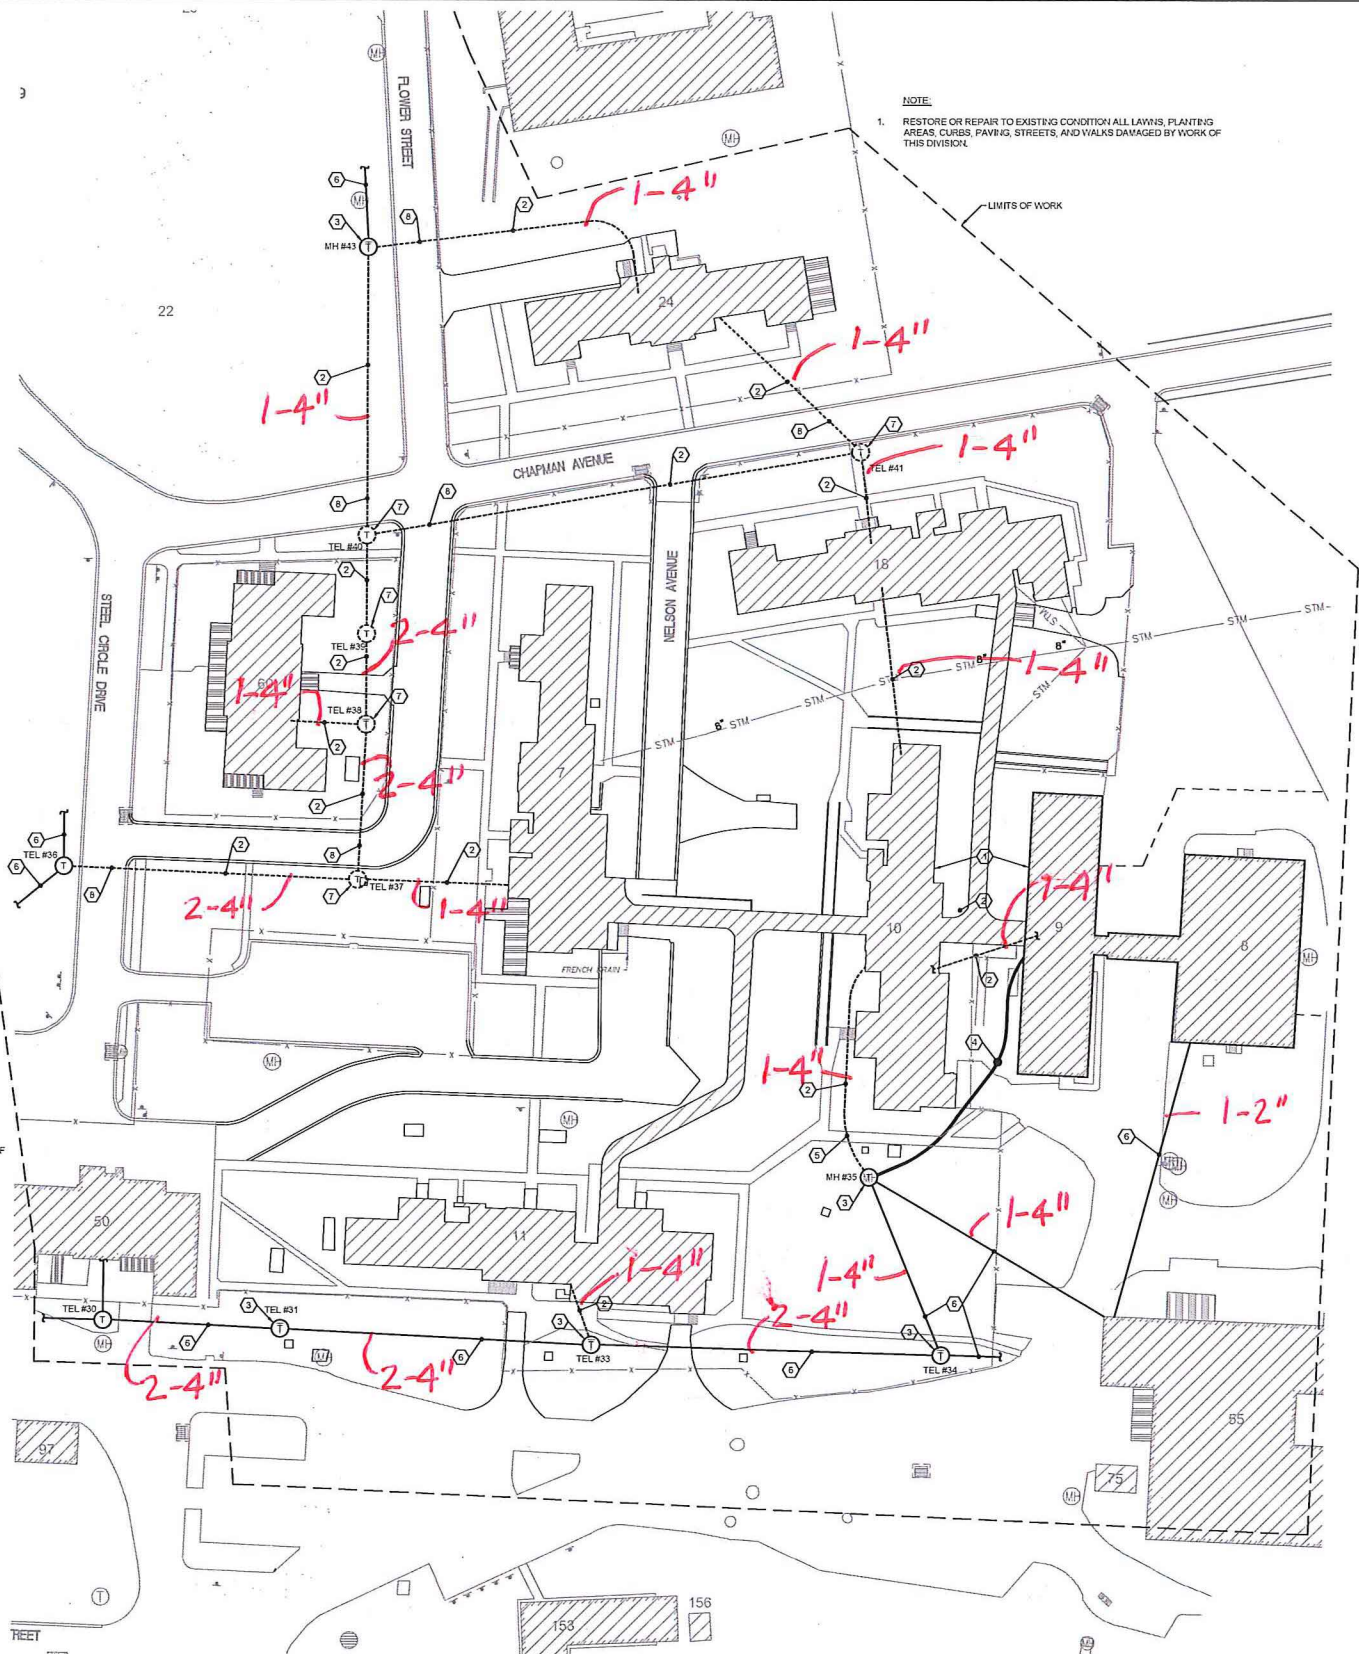

- CODED NOTES
1. RELOCATE IT EQUIPMENT IN BASEMENT OF BUILDING 10 TO BUILDING 9
  2. REMOVE CONDUIT AND CABLEING.
  3. EXISTING MANHOLE TO REMAIN.
  4. PROVIDE 1-4" CONDUIT DUCTBANK INTO BUILDING.
  5. PULL BACK FO CABLEING TO MAN HOLE AND PULL THRU NEW DUCTBANK AND RE-TERMINATE IN BUILDING. TEST CABLE BEFORE REMOVAL, AND RE-TEST AFTER INSTALLATION. PULL OUT COPPER UTP CABLE.
  6. EXISTING DUCTBANK AND CABLEING TO REMAIN.
  7. REMOVE MANHOLE.
  8. ABANDON CONDUIT UNDER ROAD.

- LEGEND
- ① TELECOM MANHOLE
  - CONDUIT / CABLEING
  - - - CONDUIT / CABLEING TO BE REMOVED

 A SITE PLAN  
ELECTRICAL DEMOLITION / NEW WORK



610-15-100  
RFI 10  
12-21-17  
Elkins

100% CONSTRUCTION DOCUMENT SUBMISSION	ENGINEERS OF RECORD	ARCHITECT OF RECORD	STAMP	Drawing Title	Phase	Project Title	Project Number
	<b>KORDA</b> KORDA ENGINEERING 1650 WATERMARK DR. SUITE 200 COLUMBUS, OH 43215 614-487-1650	<b>HR</b> A/E: HDR ARCHITECTURE, INC 600 HENNEPIN AVENUE, SUITE 260 MINNEAPOLIS, MN 55403 612-524-6000	Office of Construction and Facilities Management  VA U.S. Department of Veterans Affairs	ELECTRICAL DEMOLITION AND NEW WORK - TECHNOLOGY	100% CD	DEMOLISH BUILDINGS 7, 10, 11, 18, 24, 60 & CONNECTING CORRIDORS	610-15-100
Mark:	Date:			Approved:		Location	Building Number
						MARION, IN	7,10,11,18,24,60
						Issue Date	Drawing Number
						6/15/2017	ET-103
						Checked	Drawn
						SJK	DJR