


# VA ILLIANA HEALTH CARE SYSTEM

## EMERGENCY REPAIR TO WATER TOWER #94 (SOUTH)


1900 EAST MAIN STREET  
DANVILLE, ILLINOIS 61832

CONSTRUCTION DOCUMENTS  
AUGUST 13, 2017

DRAWING INDEX		
SHEET No.	DWG No.	SHEET TITLE
1	G-001	COVER SHEET
2	G-002	SITE STAGING PLAN
3	G-003	SCOPE OF WORK

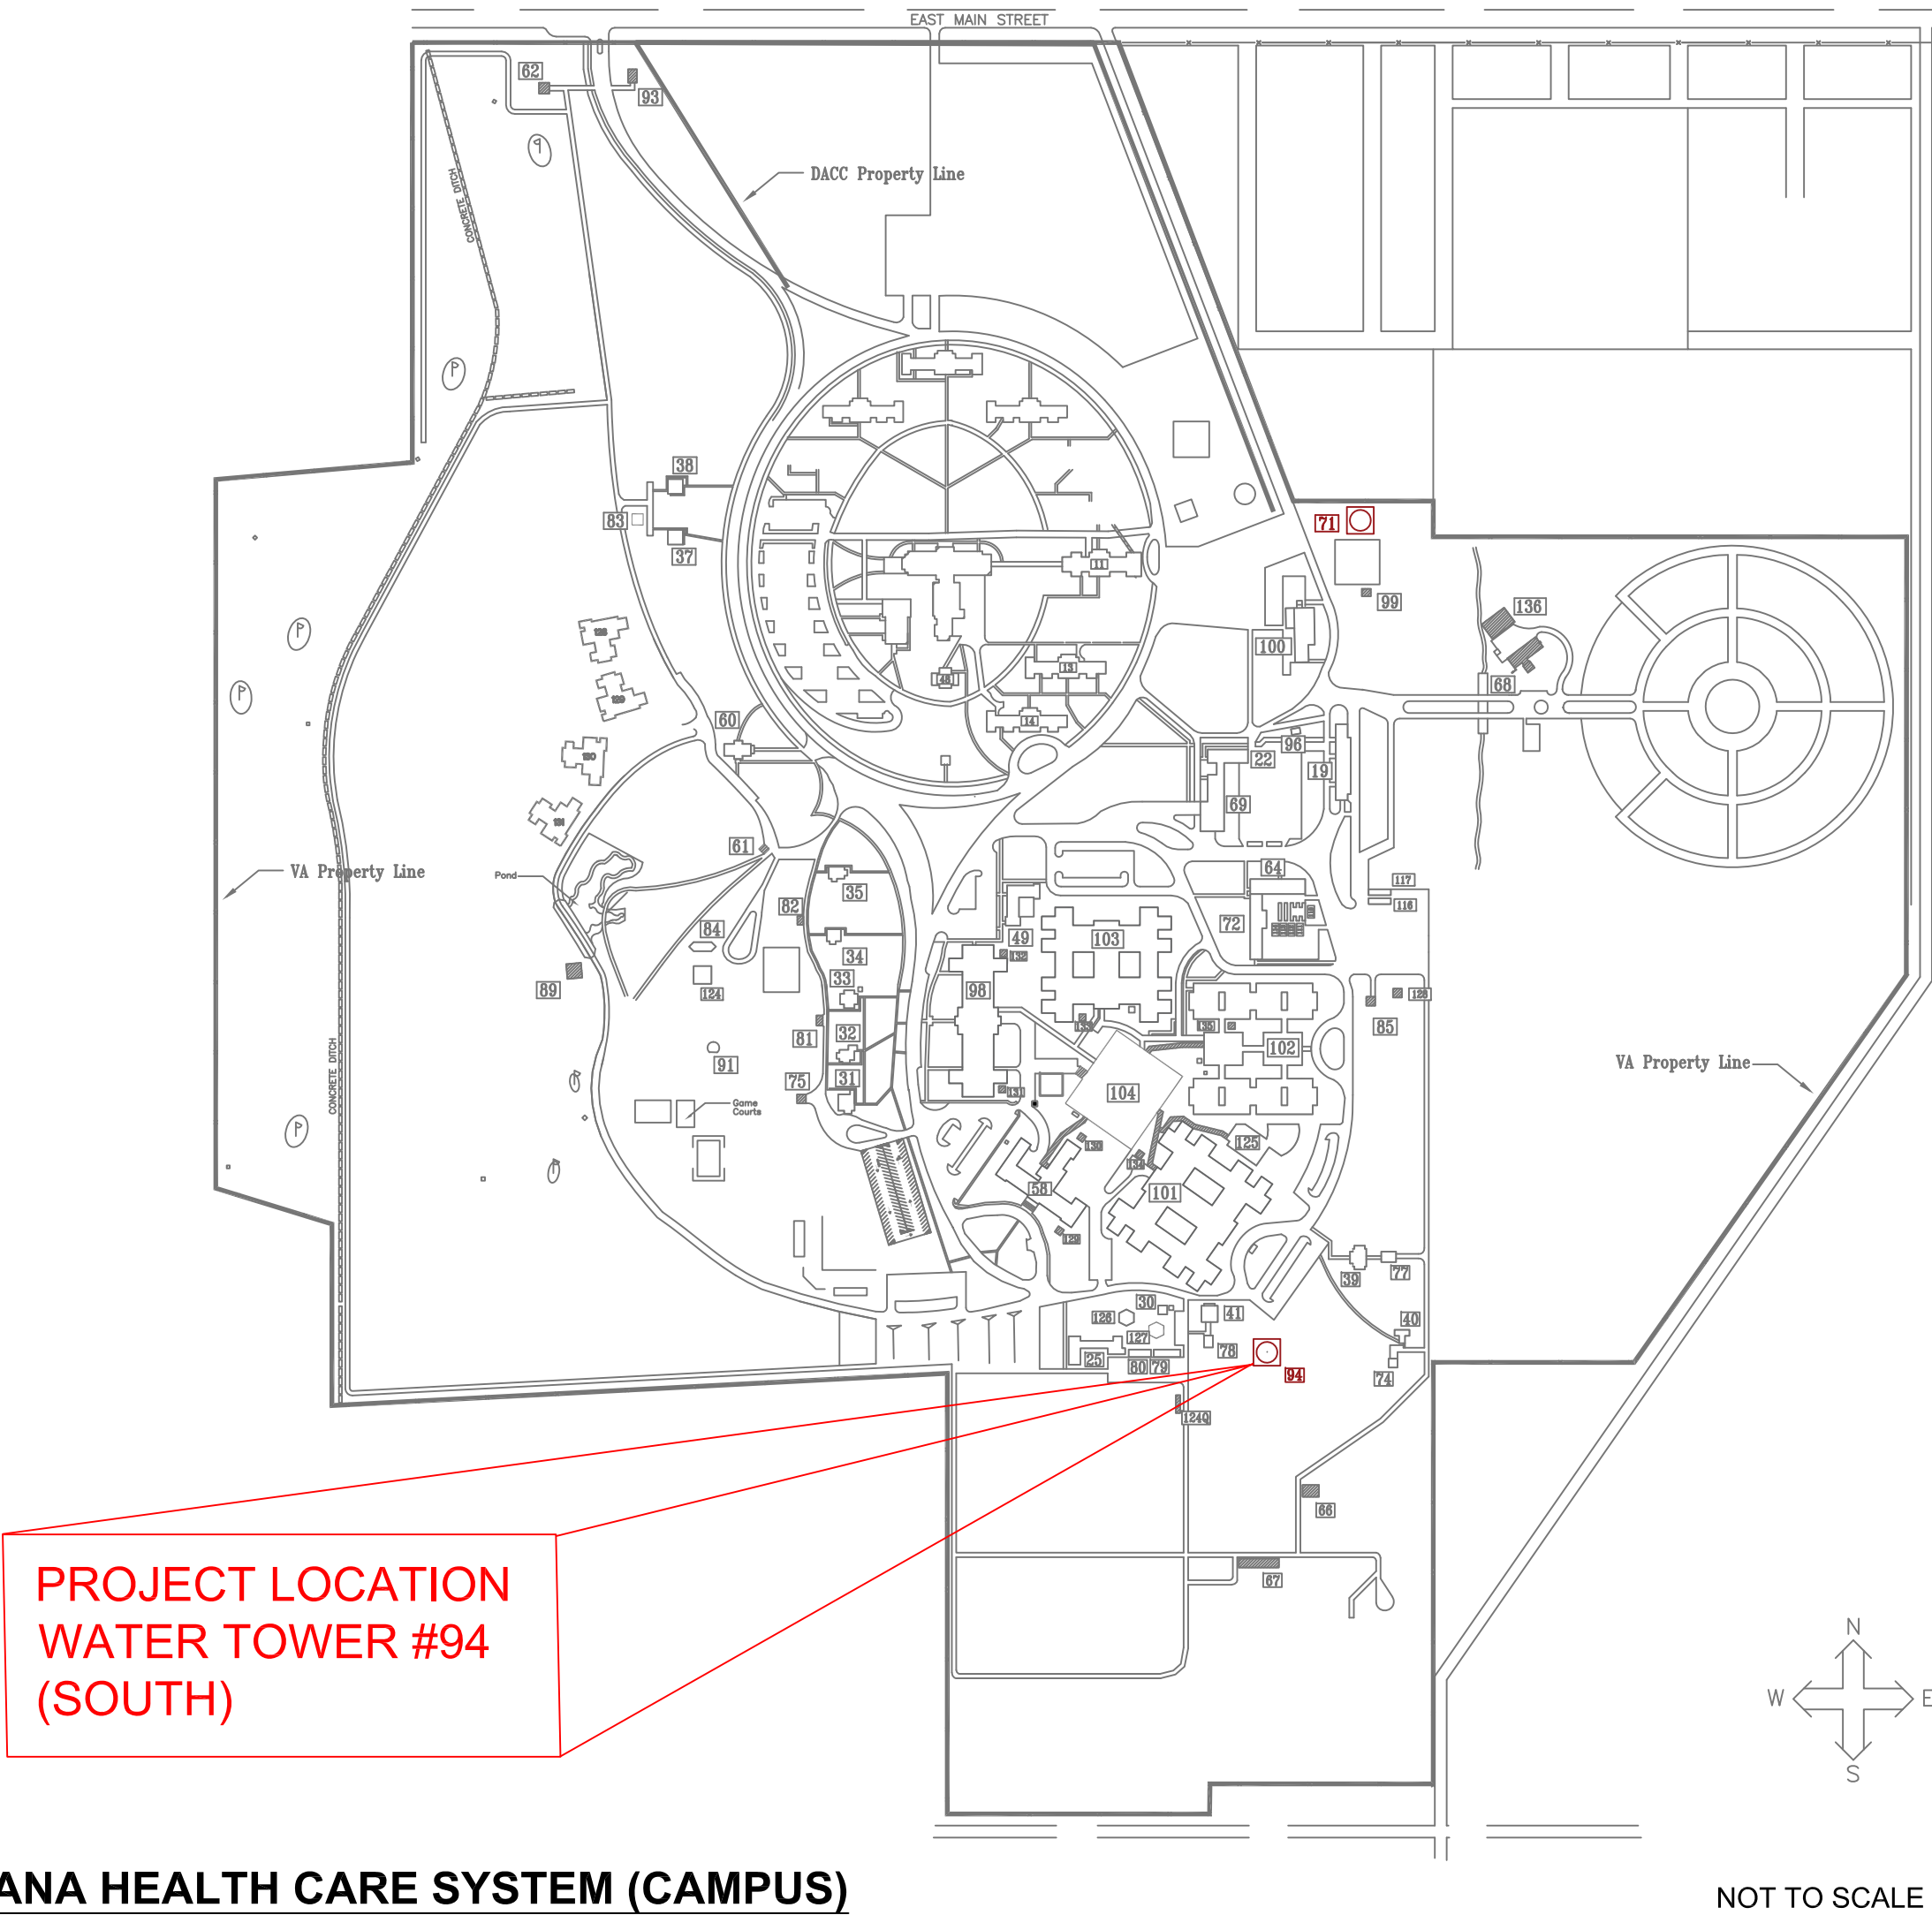

		CONSULTANTS:		ARCHITECT/ENGINEERS:		Drawing Title:		Project Title:		Project Number:		<div>Facility Management Service (FMS) VAIHCS</div> <div> Department of Veterans Affairs</div>	
				VA ILLIANA Health Care System		COVER SHEET		Emergency Repair to Water Tower #94 (South)		550-18-101			
						Approved (Chief, FMS): Troy Martinson, PE, DBIA		Location: VA Illiana HCS, Danville, IL		Building Number:			
				Engineer: Troy Martinson, PE, DBIA Designer:		Approved (Superintendent/Projects Chief): Carl Wise/Mark Shoviak		Date: 8-13-2017		Checked: CW			
Revisions:		Date											

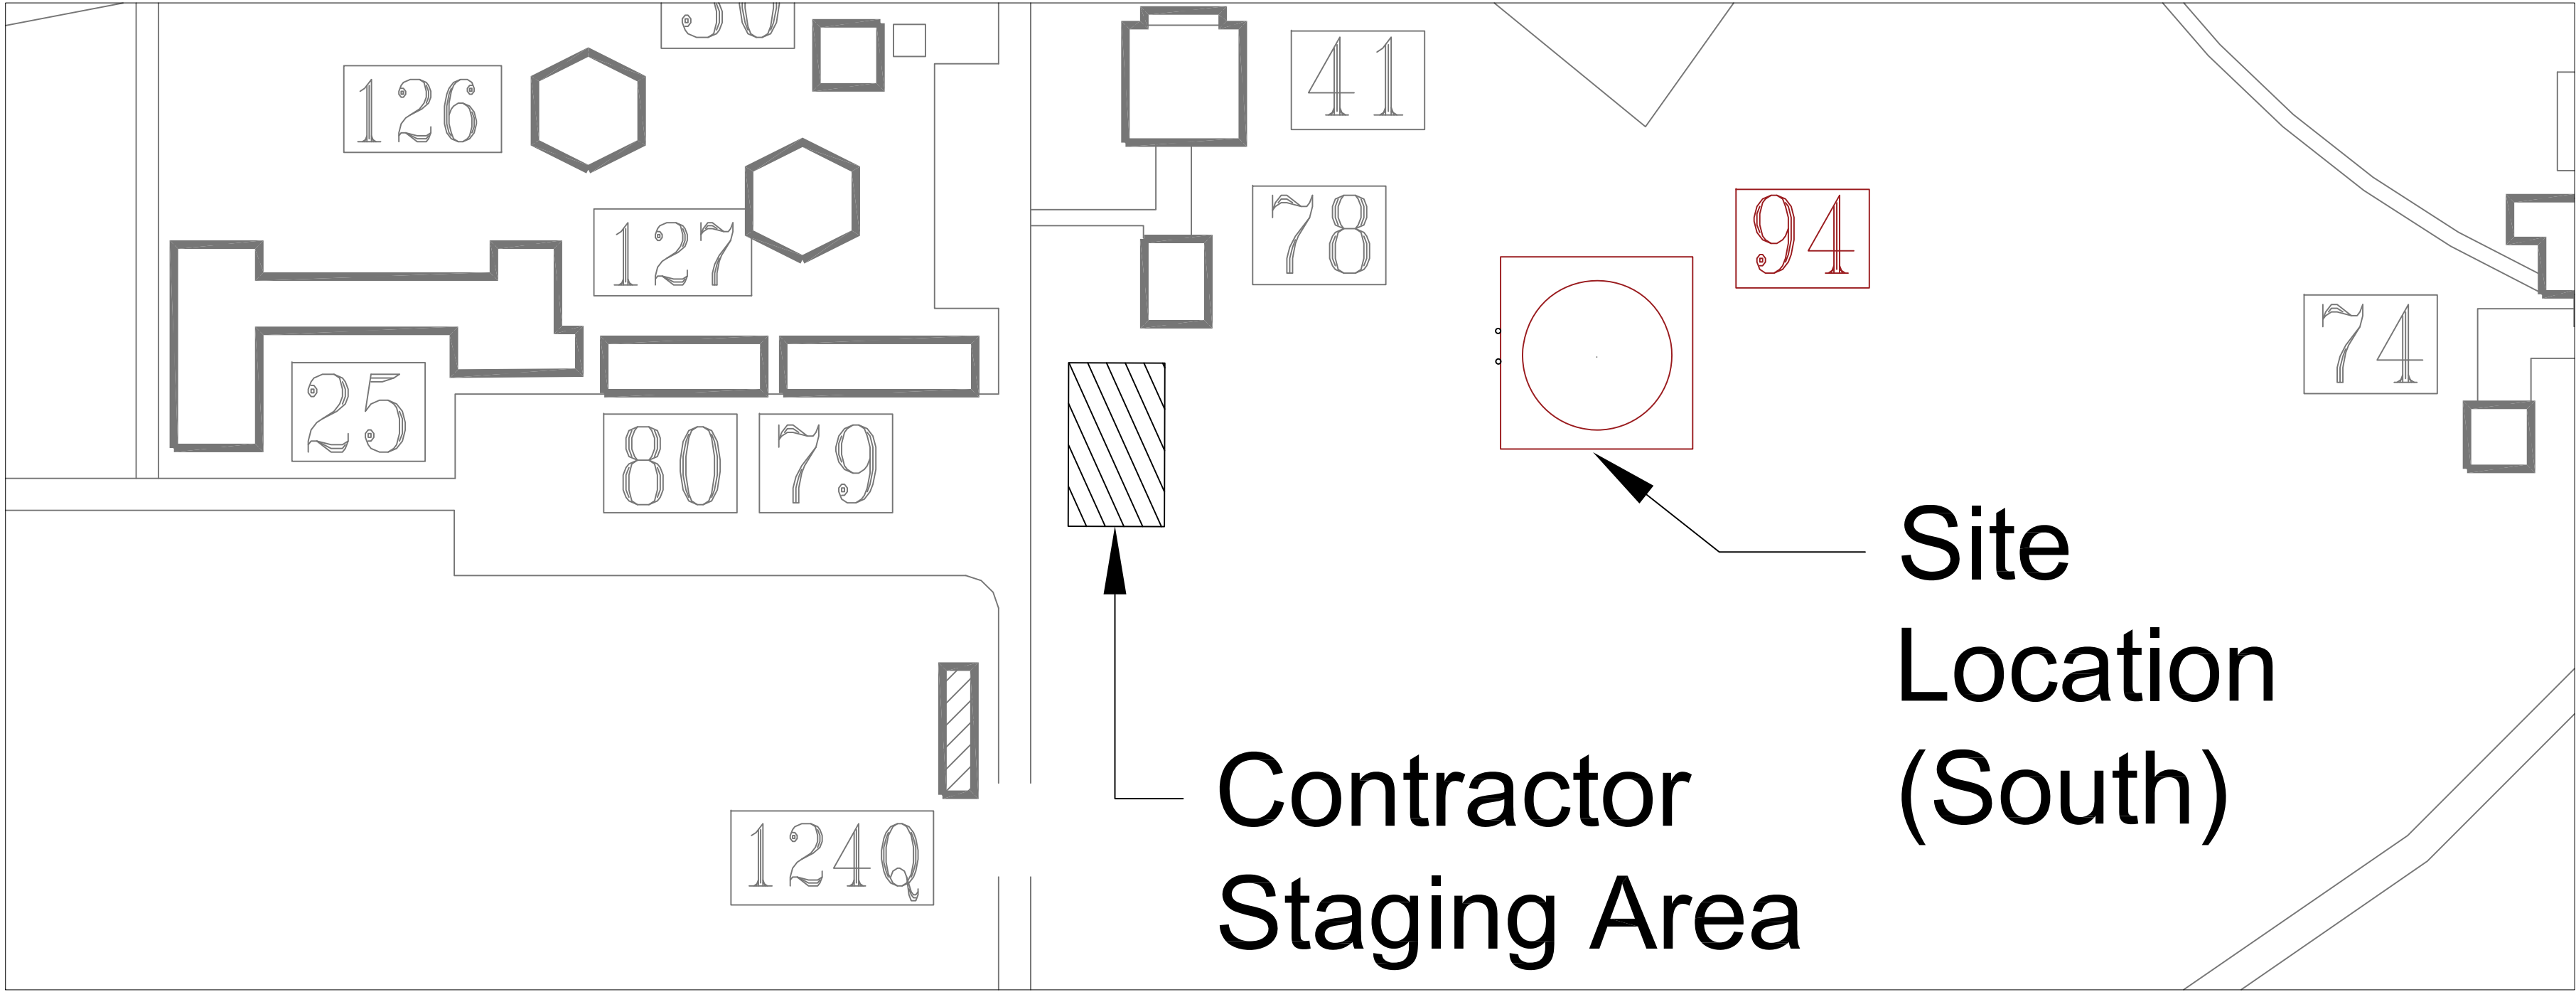

1 Site Plan (Tank Facility #94)  
Scale: 1/32" = 1'-0"

NOTES

1. THE CONTRACTOR SHALL MOBILIZE AND STAGE EQUIPMENT AS INDICATED.

WATER STORAGE TANK INFORMATION

1. WATER STORAGE TANK AND RESERVOIR #94

ORIGINAL MANUFACTURER:	Chicago Bridge & Iron Co.
YEAR BUILT:	1957
TANK TYPE:	Multi-Column Elevated, Toro Ellipsoidal
CAPACITY:	200,000 Gallon
DATE OF LAST INSPECTION:	March 2017
TYPE:	Portable / Fire
HIGH WATER LEVEL:	150'-0"
LOW WATER LEVEL:	118'-9"
DIAMETER:	36'-0"
HEAD RANGE:	31'-3"
TYPE CONSTRUCTION:	Welded

C:\All Projects\2018\550-18-101 Emergency Repairs to Water Tower #94 (South)\02-Design\04-Drawings\550-18-101 Drawings 0002 (2).dwg 8-13-17 08:36:15 PM VHADANMort11

Revisions:	Date

CONSULTANTS:


ARCHITECT/ENGINEERS:
VA ILLIANA Health Care System
Engineer: Troy Martinson, PE, DBIA
Designer:

Drawing Title:
SITE STAGING PLAN
Approved (Chief, FMS):
Troy Martinson, PE, DBIA
Approved (Superintendent/Projects Chief):
Carl Wise/Mark Shoviak

Project Title:
Emergency Repair to Water Tower #94 (South)
Location:
VA Illiana HCS, Danville, IL
Date:
8-13-2017
Checked:
CW
Drawn:
TJM

Project Number:
550-18-101
Building Number:
Drawing Number:
G-002
Dwg. 2 of 3

Facility Management Service (FMS) VAIHCS

Department of Veterans Affairs