


V.A. MEDICAL CENTER
CANANDAIGUA, NY 14424
CONSTRUCTION DOCUMENTS

- GENERAL DRAWINGS:
10-GI-001 COVER SHEET
- MECHANICAL DRAWINGS:
10-MH-601 AHU DIAGRAMS
10-MH-801 AHU-1 PROCESS FLOW DIAGRAM

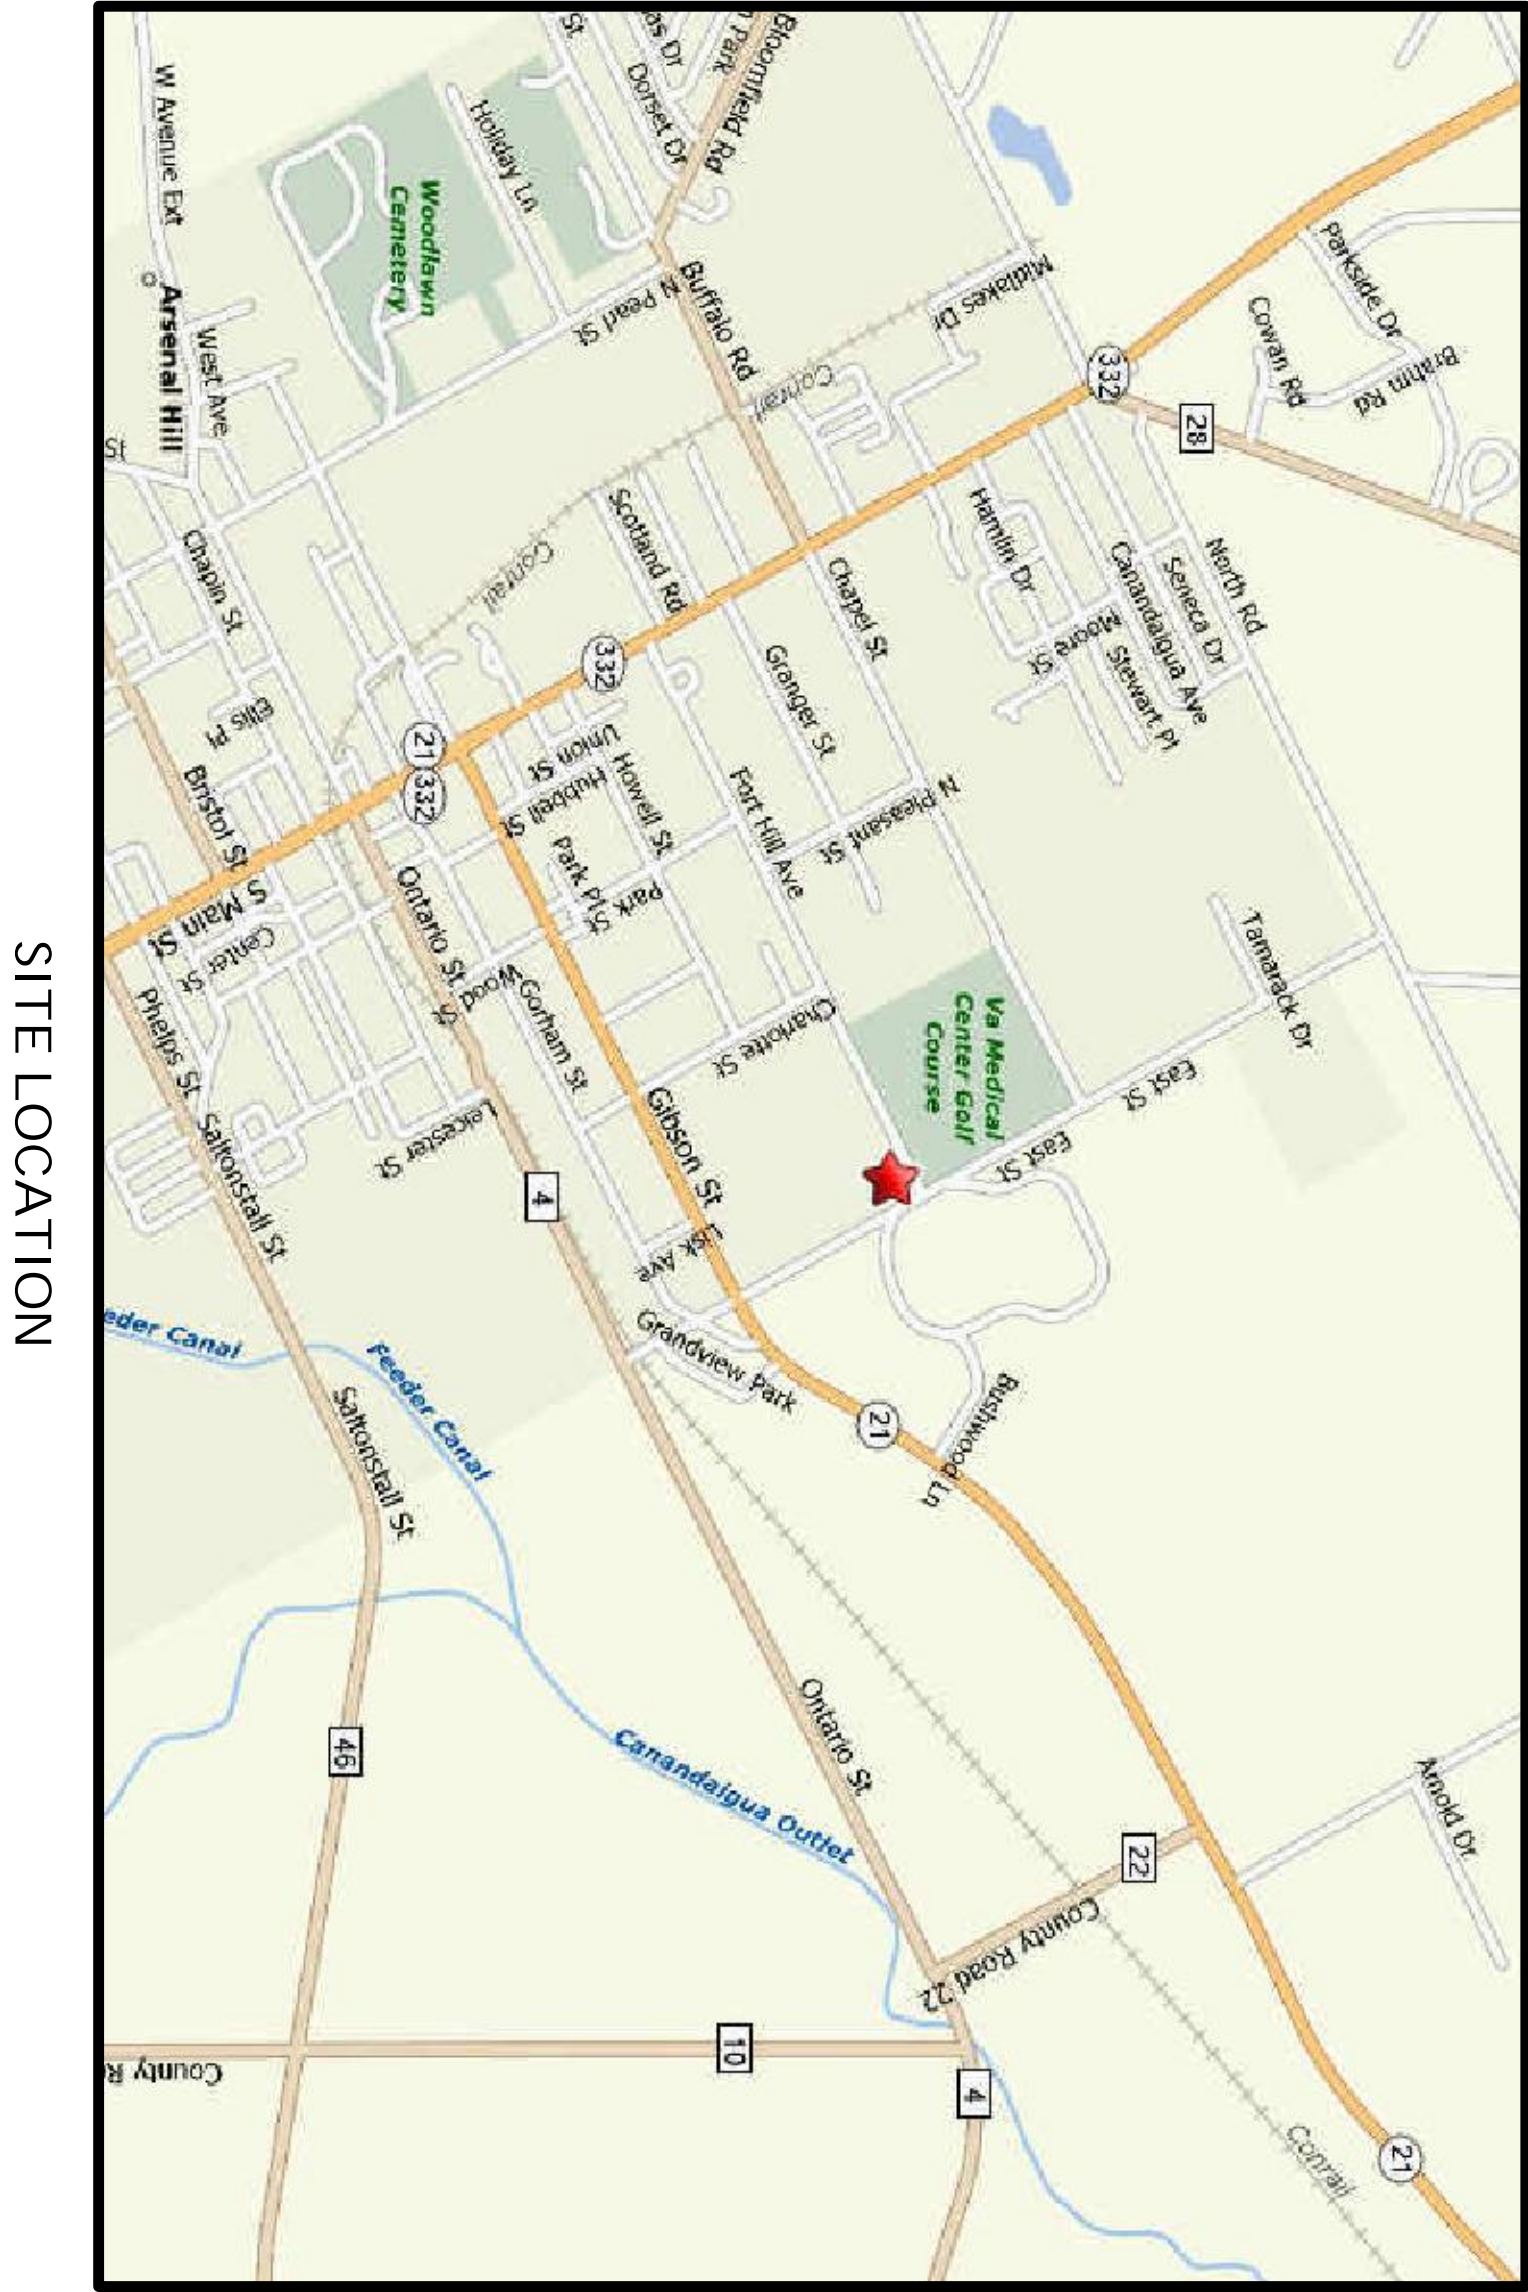

SITE LOCATION

NO.		DATE	DESCRIPTION
REVISIONS			


SHEET TITLE	
COVER SHEET	

BIDS NO.	PROJECT TITLE
10	STEAM COIL REPLACEMENT FOR B-10 LAUNDRY

DRAWN	TDA	CHECKED	TDA	DATE	02/07/12
APPROVED		CHIEF ENGINEERING SERVICE		DRAWING NUMBER	
				10-GI-001	
APPROVED		DIRECTOR, VMHC, CANANDAIGUA		PROJECT NUMBER	
				VA-528-09-RP-0100	

V.A. MEDICAL CENTER
LOCATION
CANANDAIGUA, NY 14424

ERDMAN
ANTHONY

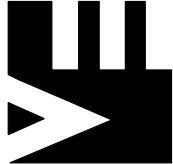

2105 Brighton Highway, Suite 100
Canandaigua, NY 14424
Telephone 585.427.8888
Fax 585.427.8888
www.erdmananthony.com