

DEPARTMENT OF VETERANS AFFAIRS
MEDICAL CENTER
ELEVATOR REPLACEMENT
BUILDING NO. 26
PROJECT: 76-106
KANSAS CITY, MISSOURI

PROJECT

VA MEDICAL CENTER
ELEVATOR REPLACEMENT
4801 LINWOOD BLVD.
KANSAS CITY, MO.

OWNER

VA MEDICAL CENTER
FACILITIES PROGRAM
4801 LINWOOD BLVD.
KANSAS CITY, MO. 64128-2295
CONTACT PERSON: BRETT TWADDLE
TEL. (816) 861-4700 EXT. 7005
FAX (816) 922-3355

ARCHITECT

MARTINEZ & ASSOCIATES
ARCHITECTURE & CONSTRUCTION, INC.
12603 HEMLOCK STREET, SUITE C
OVERLAND PARK, KANSAS 66213-1455
TEL. (913) 851-4788 (913) 851-4703

GENERAL CONTRACTOR

MARTINEZ & ASSOCIATES
ARCHITECTURE & CONSTRUCTION, INC.
12603 HEMLOCK STREET, SUITE C
OVERLAND PARK, KANSAS 66213-1455
CONTACT PERSON: BILL BOWDEN
TEL. (913) 851-4788 (913) 851-4703

STRUCTURAL ENGINEER

THE BLUMH COMPANY, P.A
CONSULTING ENGINEERS
12651 HEMLOCK STREET, SUITE 205
OVERLAND PARK, KANSAS 66213-1455
CONTACT PERSON: ROBERT A. COOK
TEL. (913) 685-8884 FAX (913) 685-0885

MECH./ELECT.

JAY CONSULTING ENGINEERS, INC.
1828 WALNUT STREET, SUITE 814
KANSAS CITY, MISSOURI 64108
CONTACT PERSON: JAY AGGARWAL
TEL. (816) 391-1818 FAX (816) 471-5066

VERTICAL TRANSPORTATION

MONTGOMERY ELEVATOR
VERTICAL TRANSPORTATION
430 W. 7TH STREET
KANSAS CITY, MISSOURI 64105
CONTACT PERSON: STEPHEN GIPPLE
TEL. (816) 842-3788X (816) 842-9365

NOTE


INFORMATION CONTAINED HEREIN IS BASED ON DRAWINGS
PROVIDED TO US BY V.A. MEDICAL CENTER STAFF. ENGINEERING
DEPARTMENT. WE DO NOT GUARANTEE THE ACCURACY OF THE
INFORMATION PROVIDED. NOR WILL WE BE RESPONSIBLE FOR
CHANGES IN WORK RELATED TO INACCURATE AS BUILT DRAWINGS.






SHEET INDEX

CS	COVER SHEET
SP1	SITE INFORMATION, ARCHITECTURAL LEGEND,
D	DEMO. BLDG. SECTION, PROPOSED BLDG.
	SECTIONS / KEY PLAN
A0	BASEMENT - DEMO. FLOOR AND PROPOSED
	FLOOR PLANS, PART. ELEVATIONS
A1	FIRST FLOOR-DEMO. AND PROPOSED
	FLOOR PLANS, PART. ELEVATIONS
A2	SECOND FLOOR-DEMO. AND PROPOSED
	FLOOR PLANS, PART. ELEVATIONS
A3	THIRD FLOOR-DEMO. AND PROPOSED
	FLOOR PLANS, PART. ELEVATIONS
A4	FOURTH FLOOR-DEMO. AND PROPOSED
	FLOOR PLANS
A5	FIFTH FLOOR-DEMO. AND PROPOSED
	FLOOR PLANS
A6	PROPOSED ROOF PLAN, DOOR, ROOM
A7	SCHEDULES AND JAMB DETAILS
A8	EXTERIOR /INTERIOR ELEVATIONS
A9	WALL SECTIONS, DETAILS
A10	DETAILS
S1	STAIR SECTIONS, DETAILS
S2	GENERAL NOTES, SCHEDULES, SPECIFICATIONS
	AND TYPICAL DETAILS
S3	FOURTH FLOOR-EXISTING/ PROPOSED PLANS
	DETAILS
S4	FIFTH FLOOR-EXISTING/PROPOSED PLANS
	DETAILS
S5	ROOF FRAMING/PENTHOUSE FRAMING
	AND DETAILS
S6	BUILDING SECTIONS
S7	STRUCTURAL DETAILS
M1	STRUCTURAL CONNECTIONS, DETAILS
M2	MECHANICAL PLAN , NOTES & DETAILS
E1	ELECT. FLOOR PLAN - LIGHTING/POWER
	REFLECTED CLG. PLAN
E2	ELECT. FLOOR PLAN - LIGHTING/POWER
	REFLECTED CLG. PLAN

REMODELING AND REHABILITATION
LIABILITY DISCLAIMER



IN AS MUCH AS THE REMODELING AND/OR REHABILITATION OF AN
EXISTING BUILDING REQUIRES THAT CERTAIN ASSUMPTIONS BE MADE
REGARDING EXISTING CONDITIONS, AND BECAUSE SOME OF THESE
ASSUMPTIONS MAY NOT BE VERIFIABLE WITHOUT EXPENDING ADDITIONAL
SUMS OF MONEY, OR DESTROYING OTHERWISE SERVICEABLE
PORTIONS OF THE BUILDING, THE OWNER AGREES THAT , EXCEPT FOR
NEGIGENCE ON PART OF MARTINEZ & ASSOCIATES, THE OWNER
WILL HOLD HARMLESS , AND INDEMNIFY MARTINEZ & ASSOCIATES FROM
AND AGAINST ANY AND ALL CLAIMS ARISING OUT OF THE PROFESSIONAL
SERVICES PROVIDED UNDER THIS AGREEMENT.

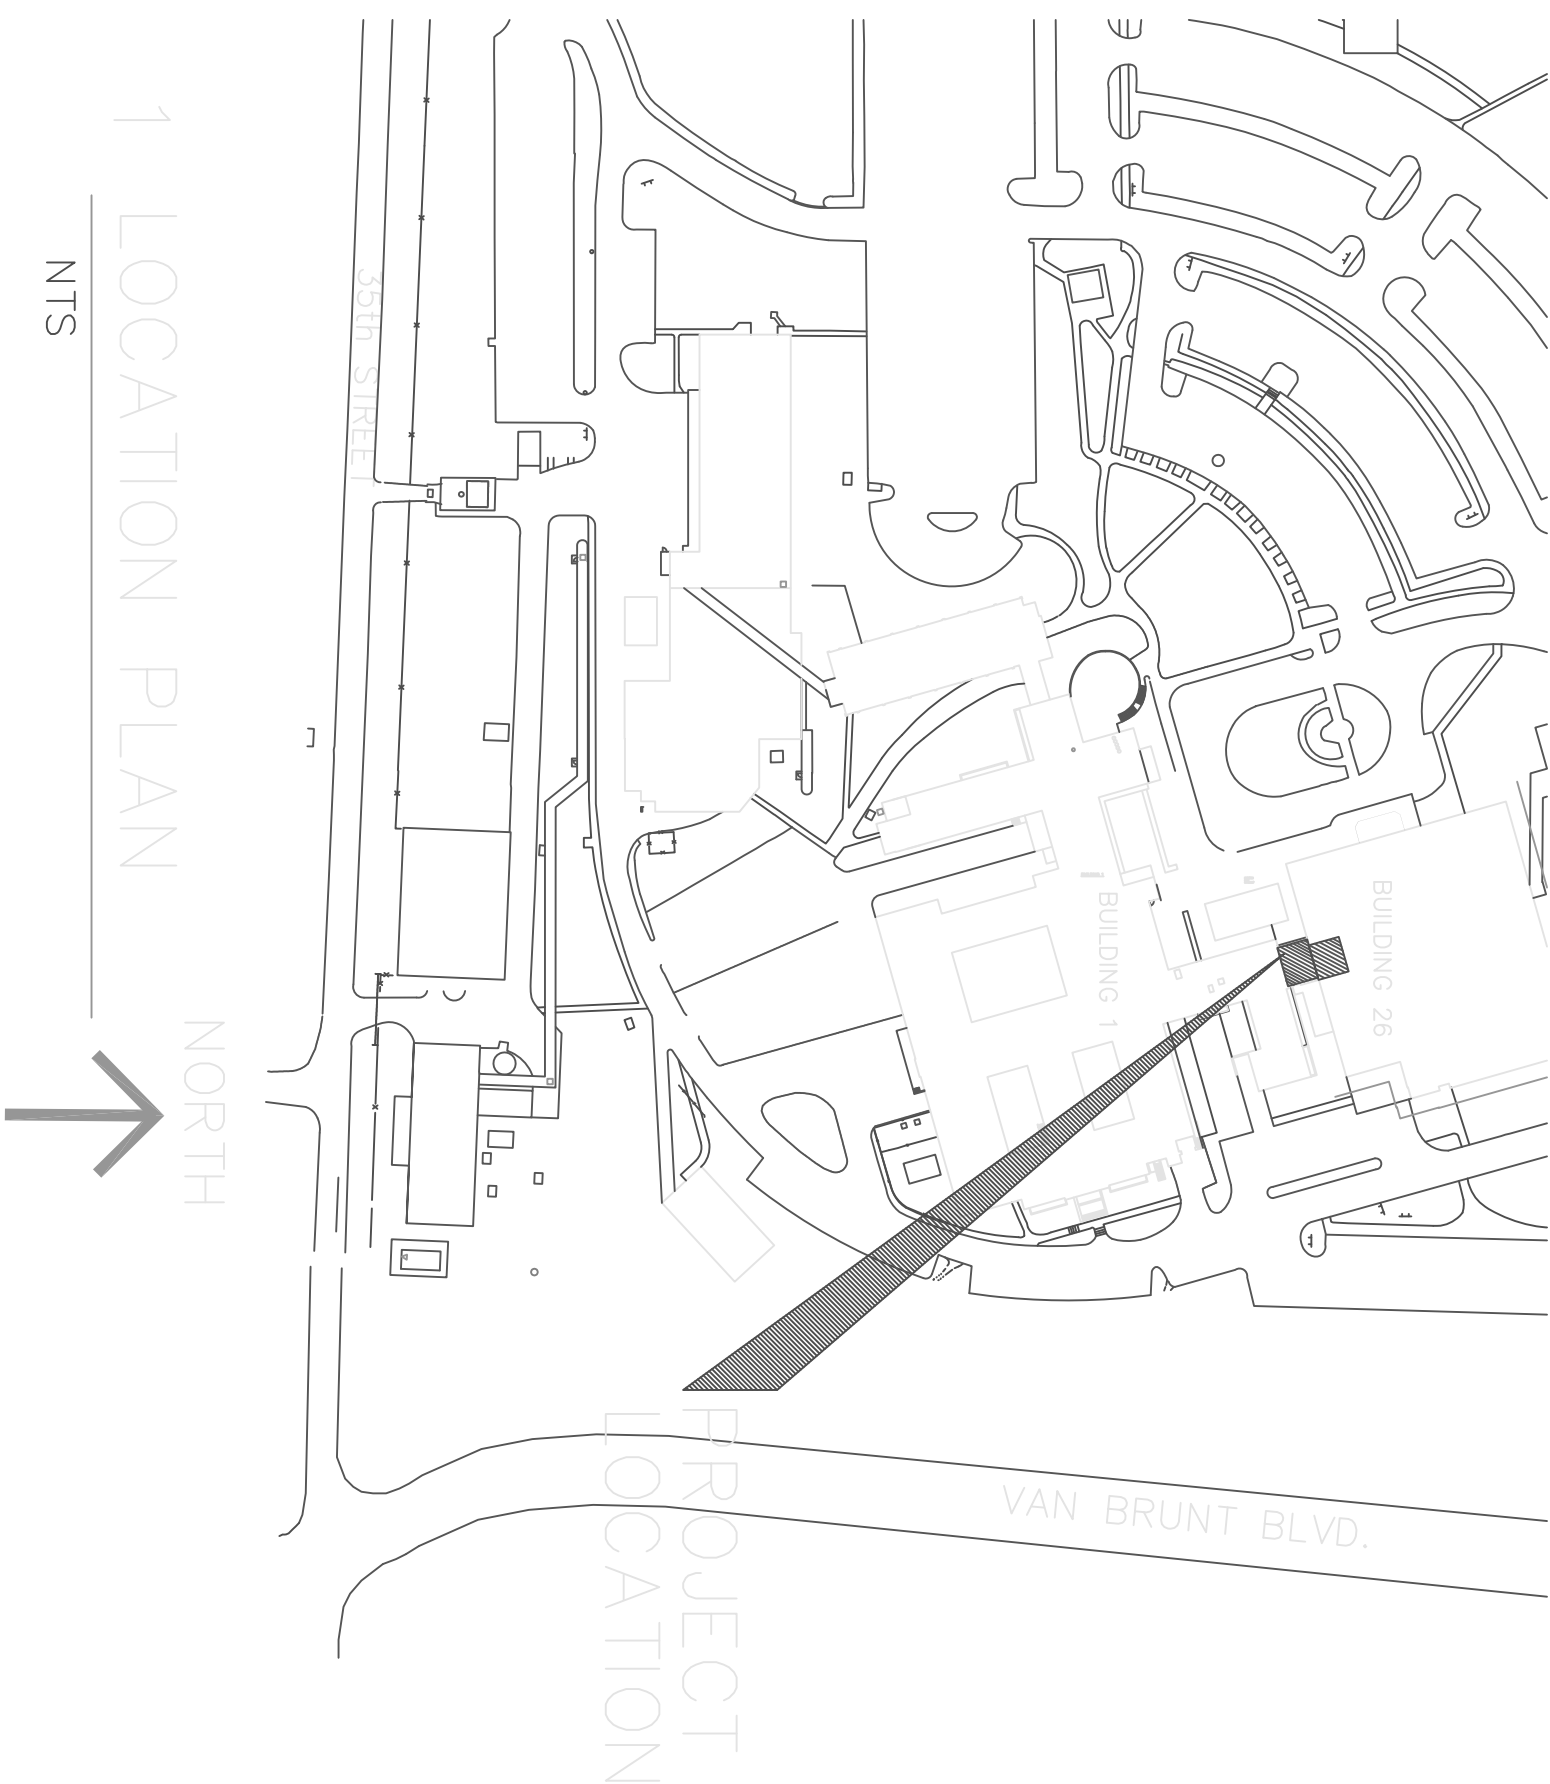

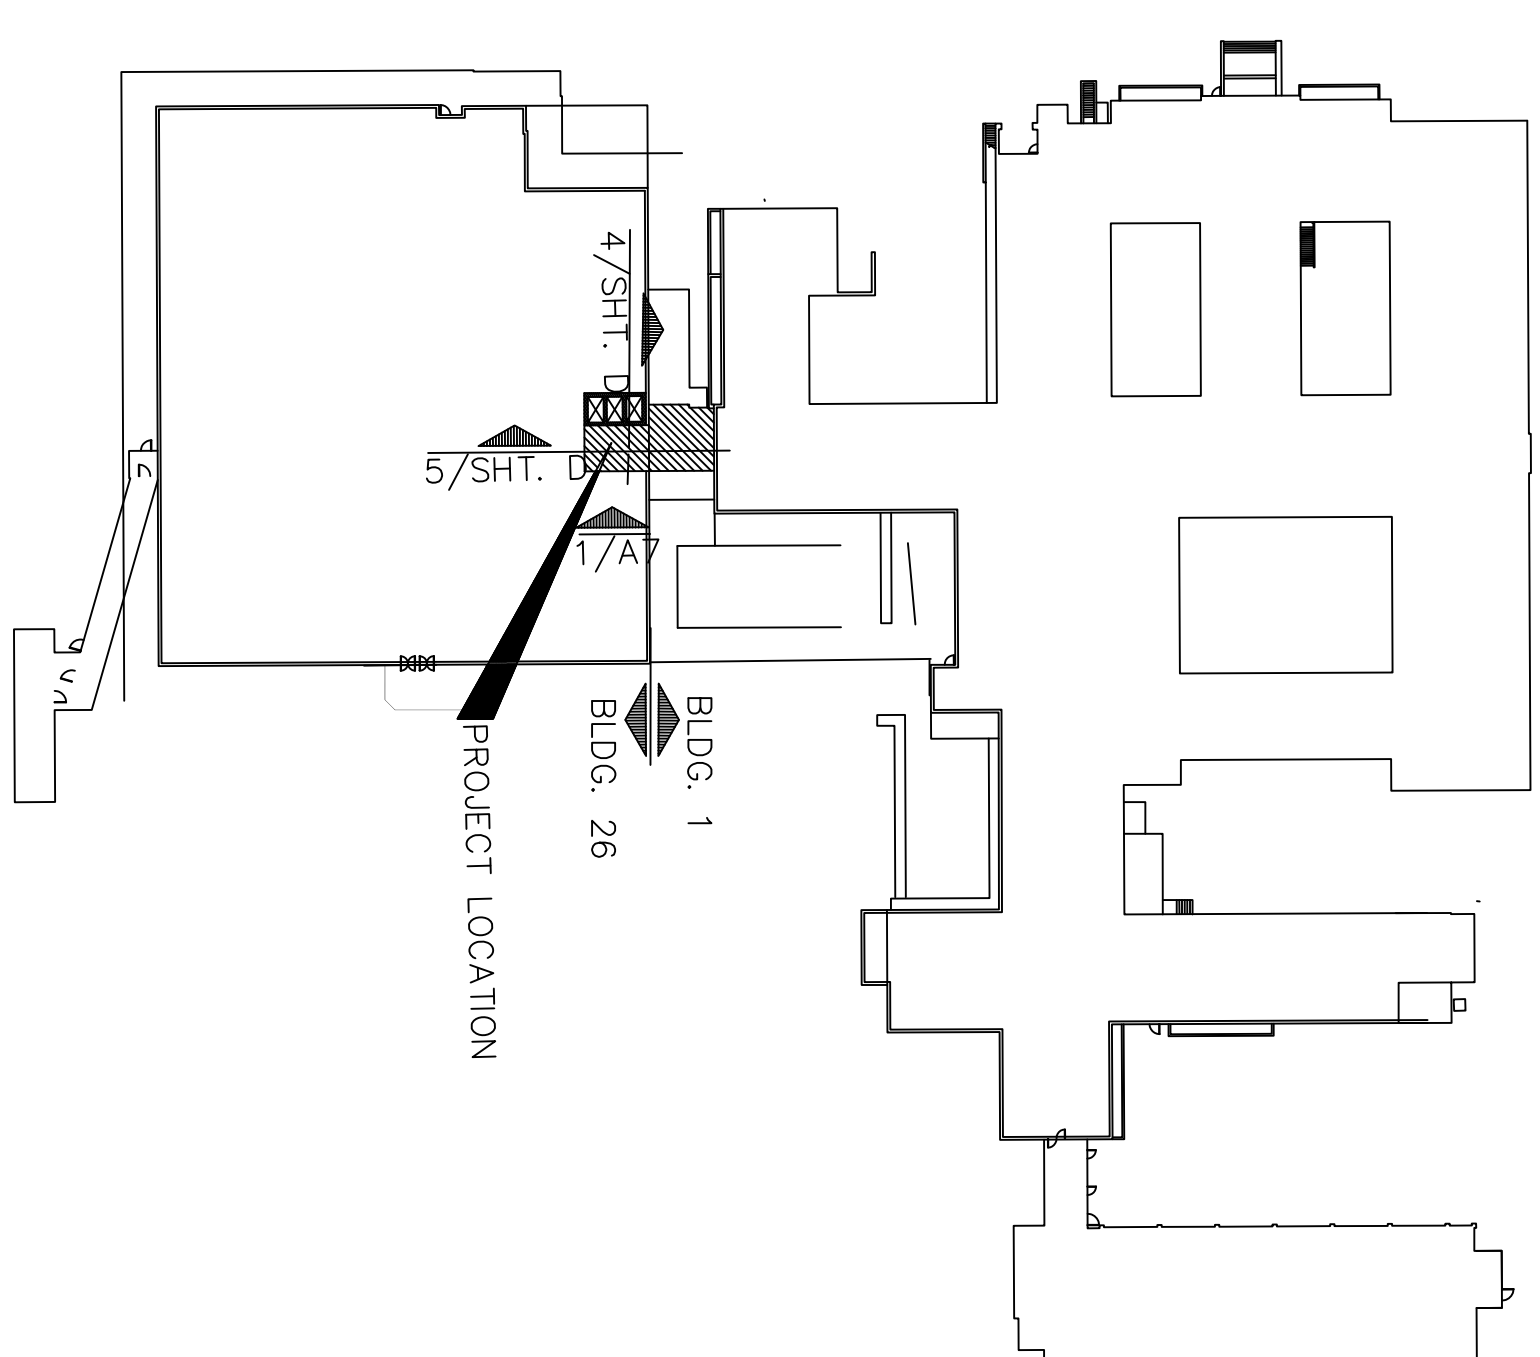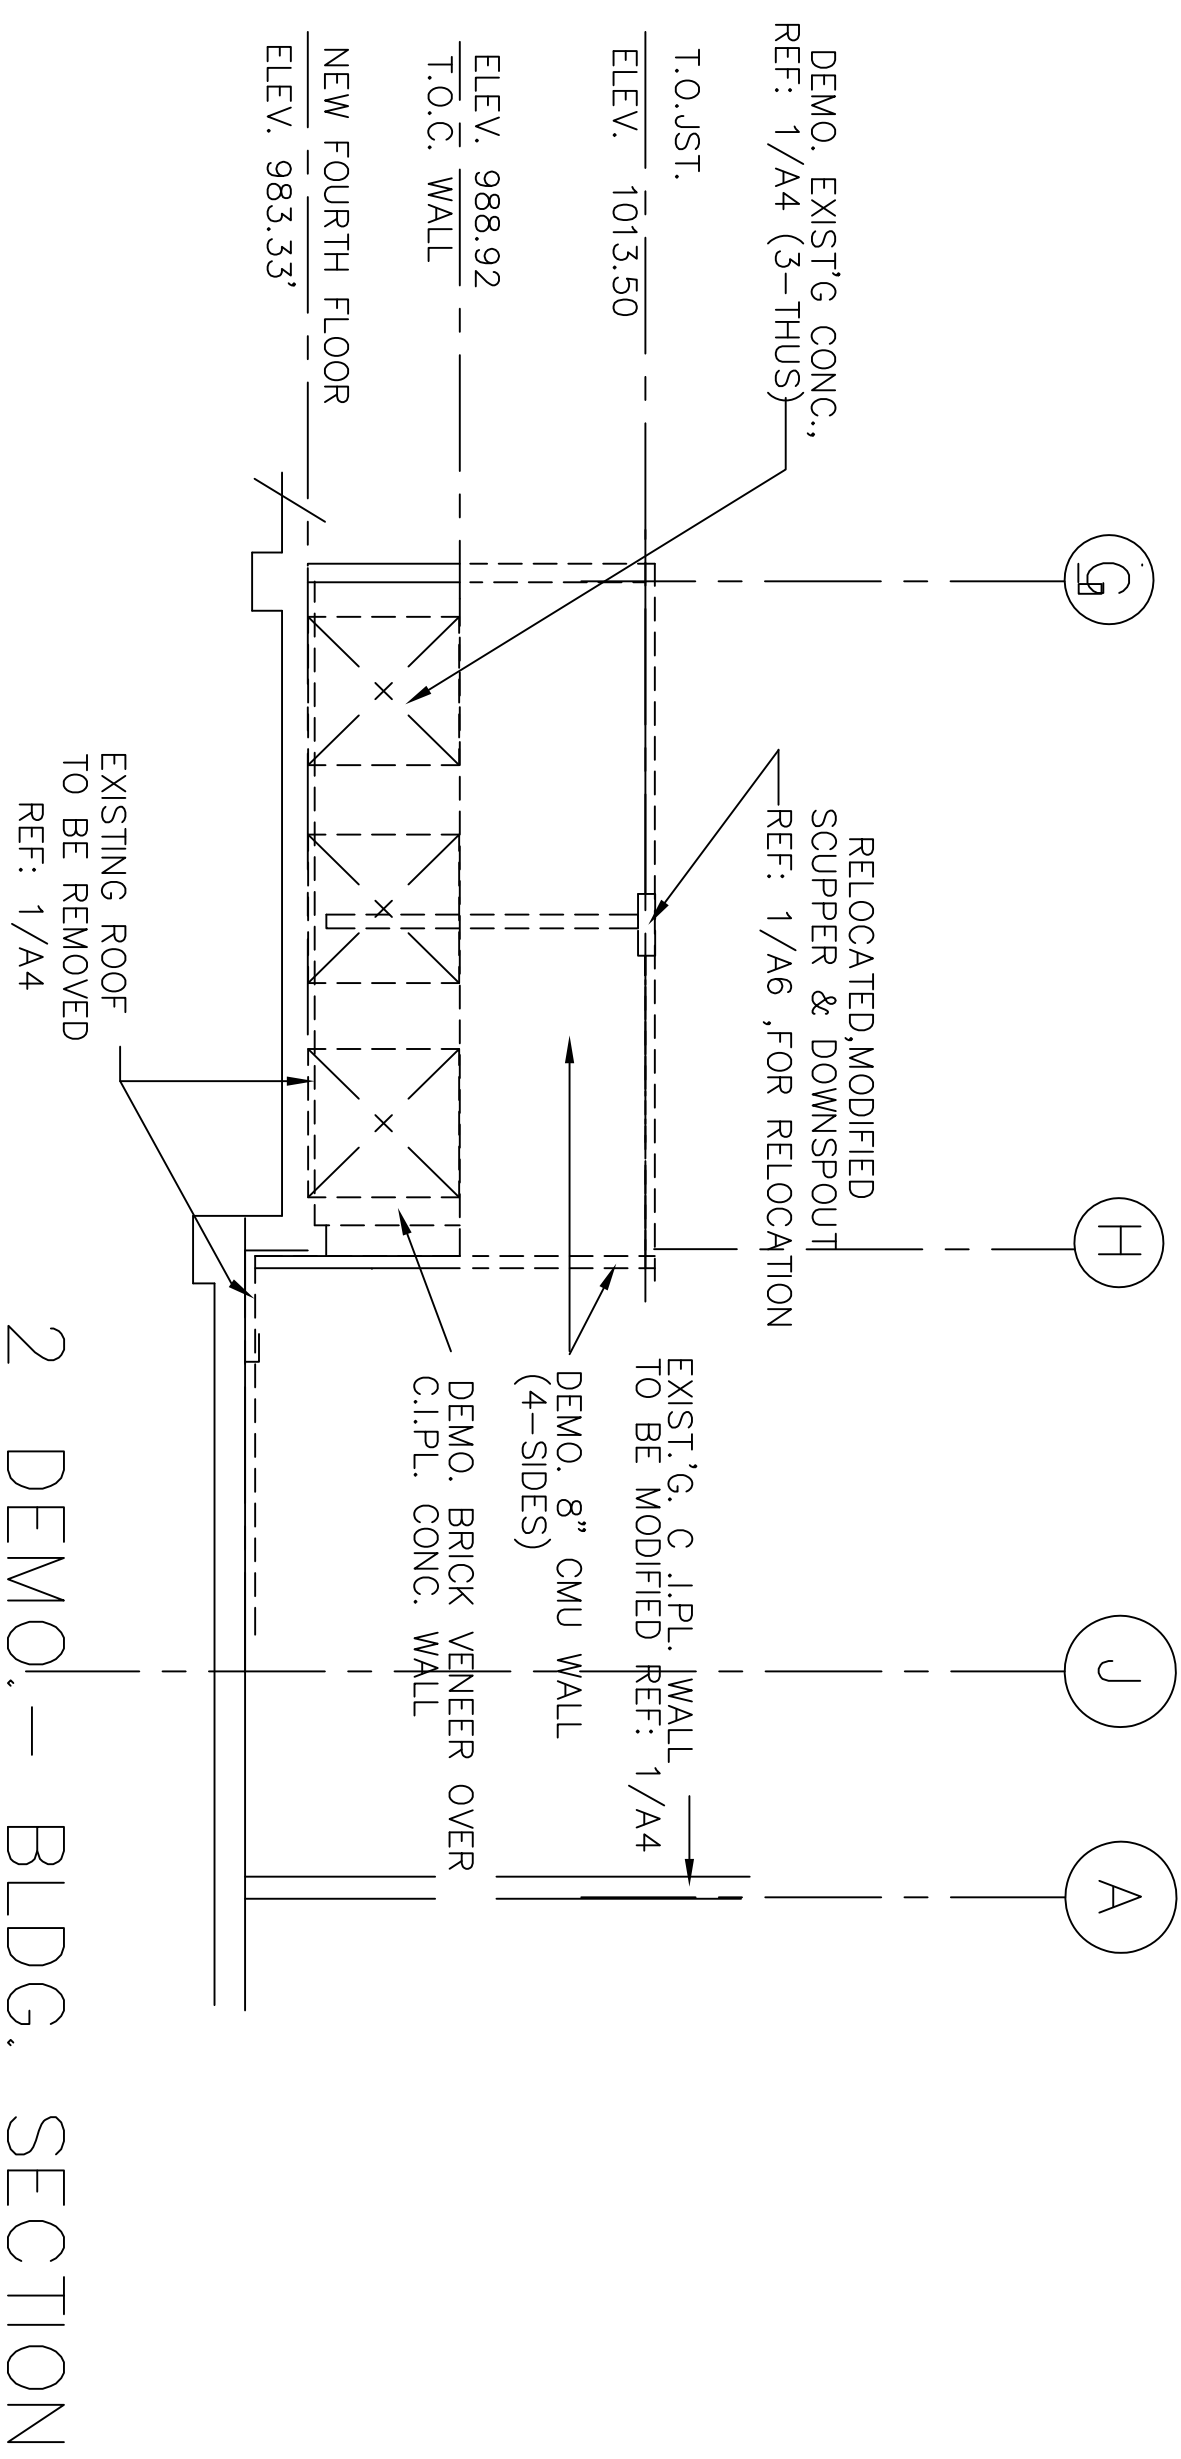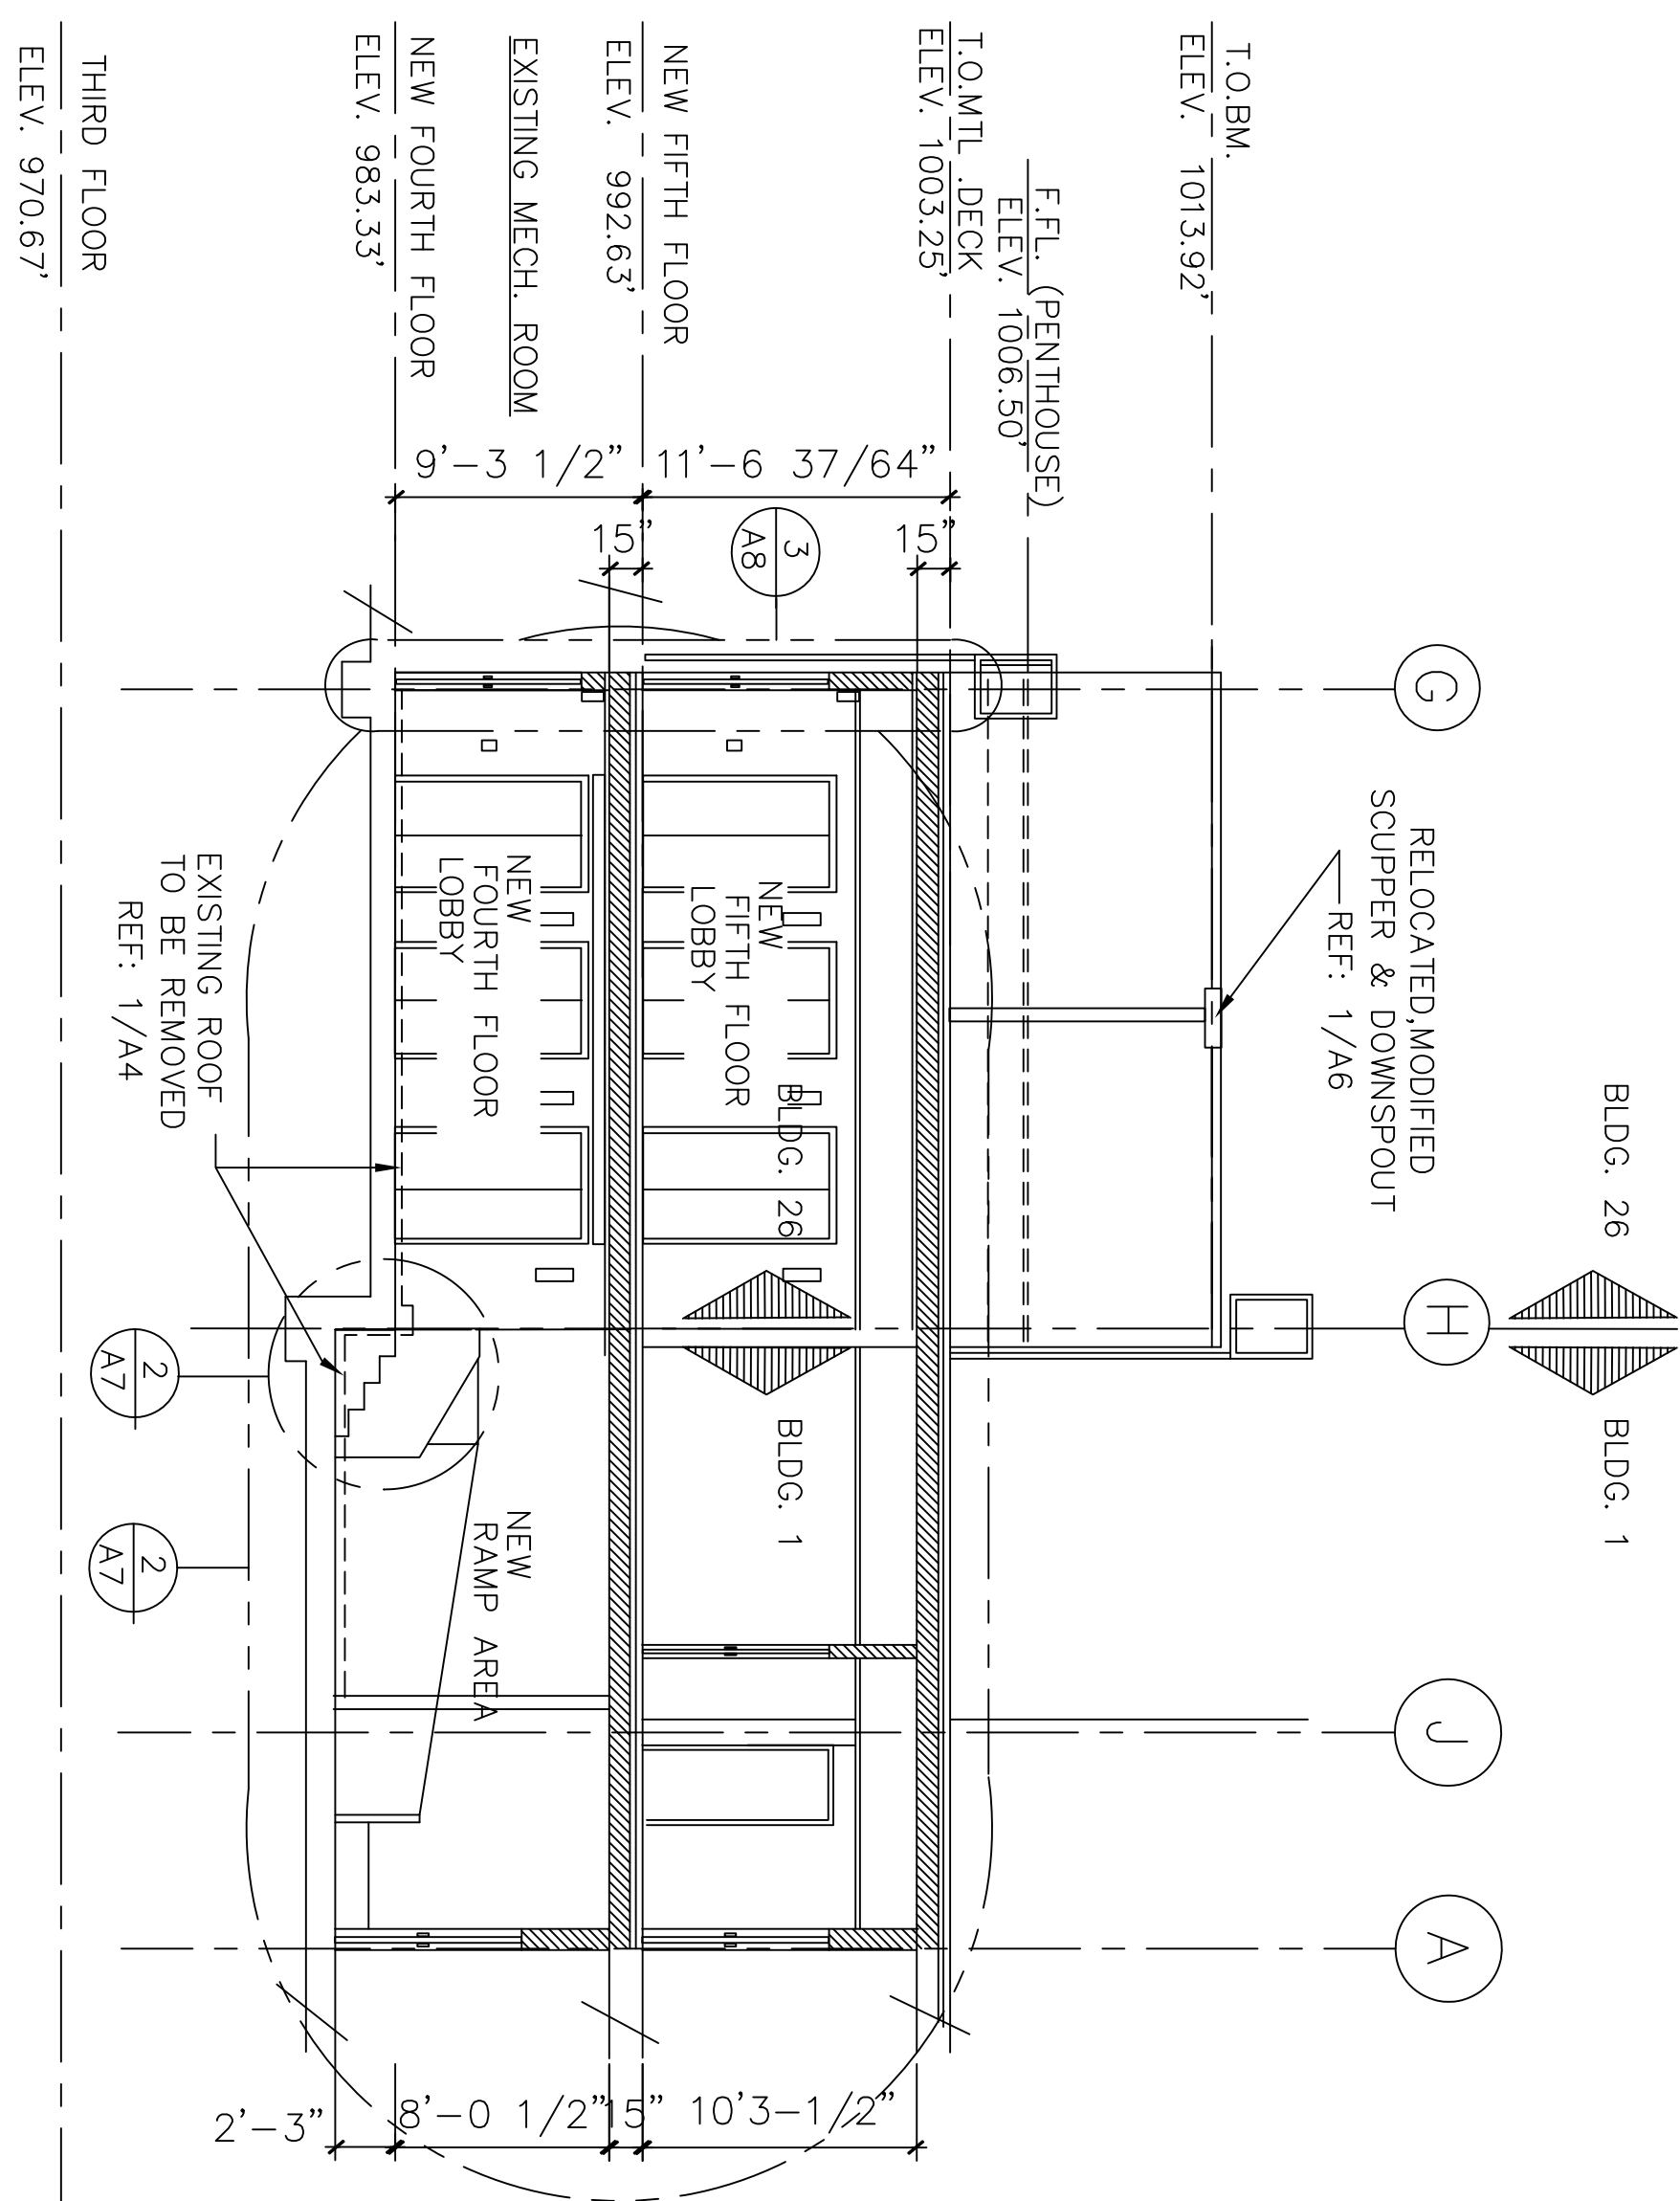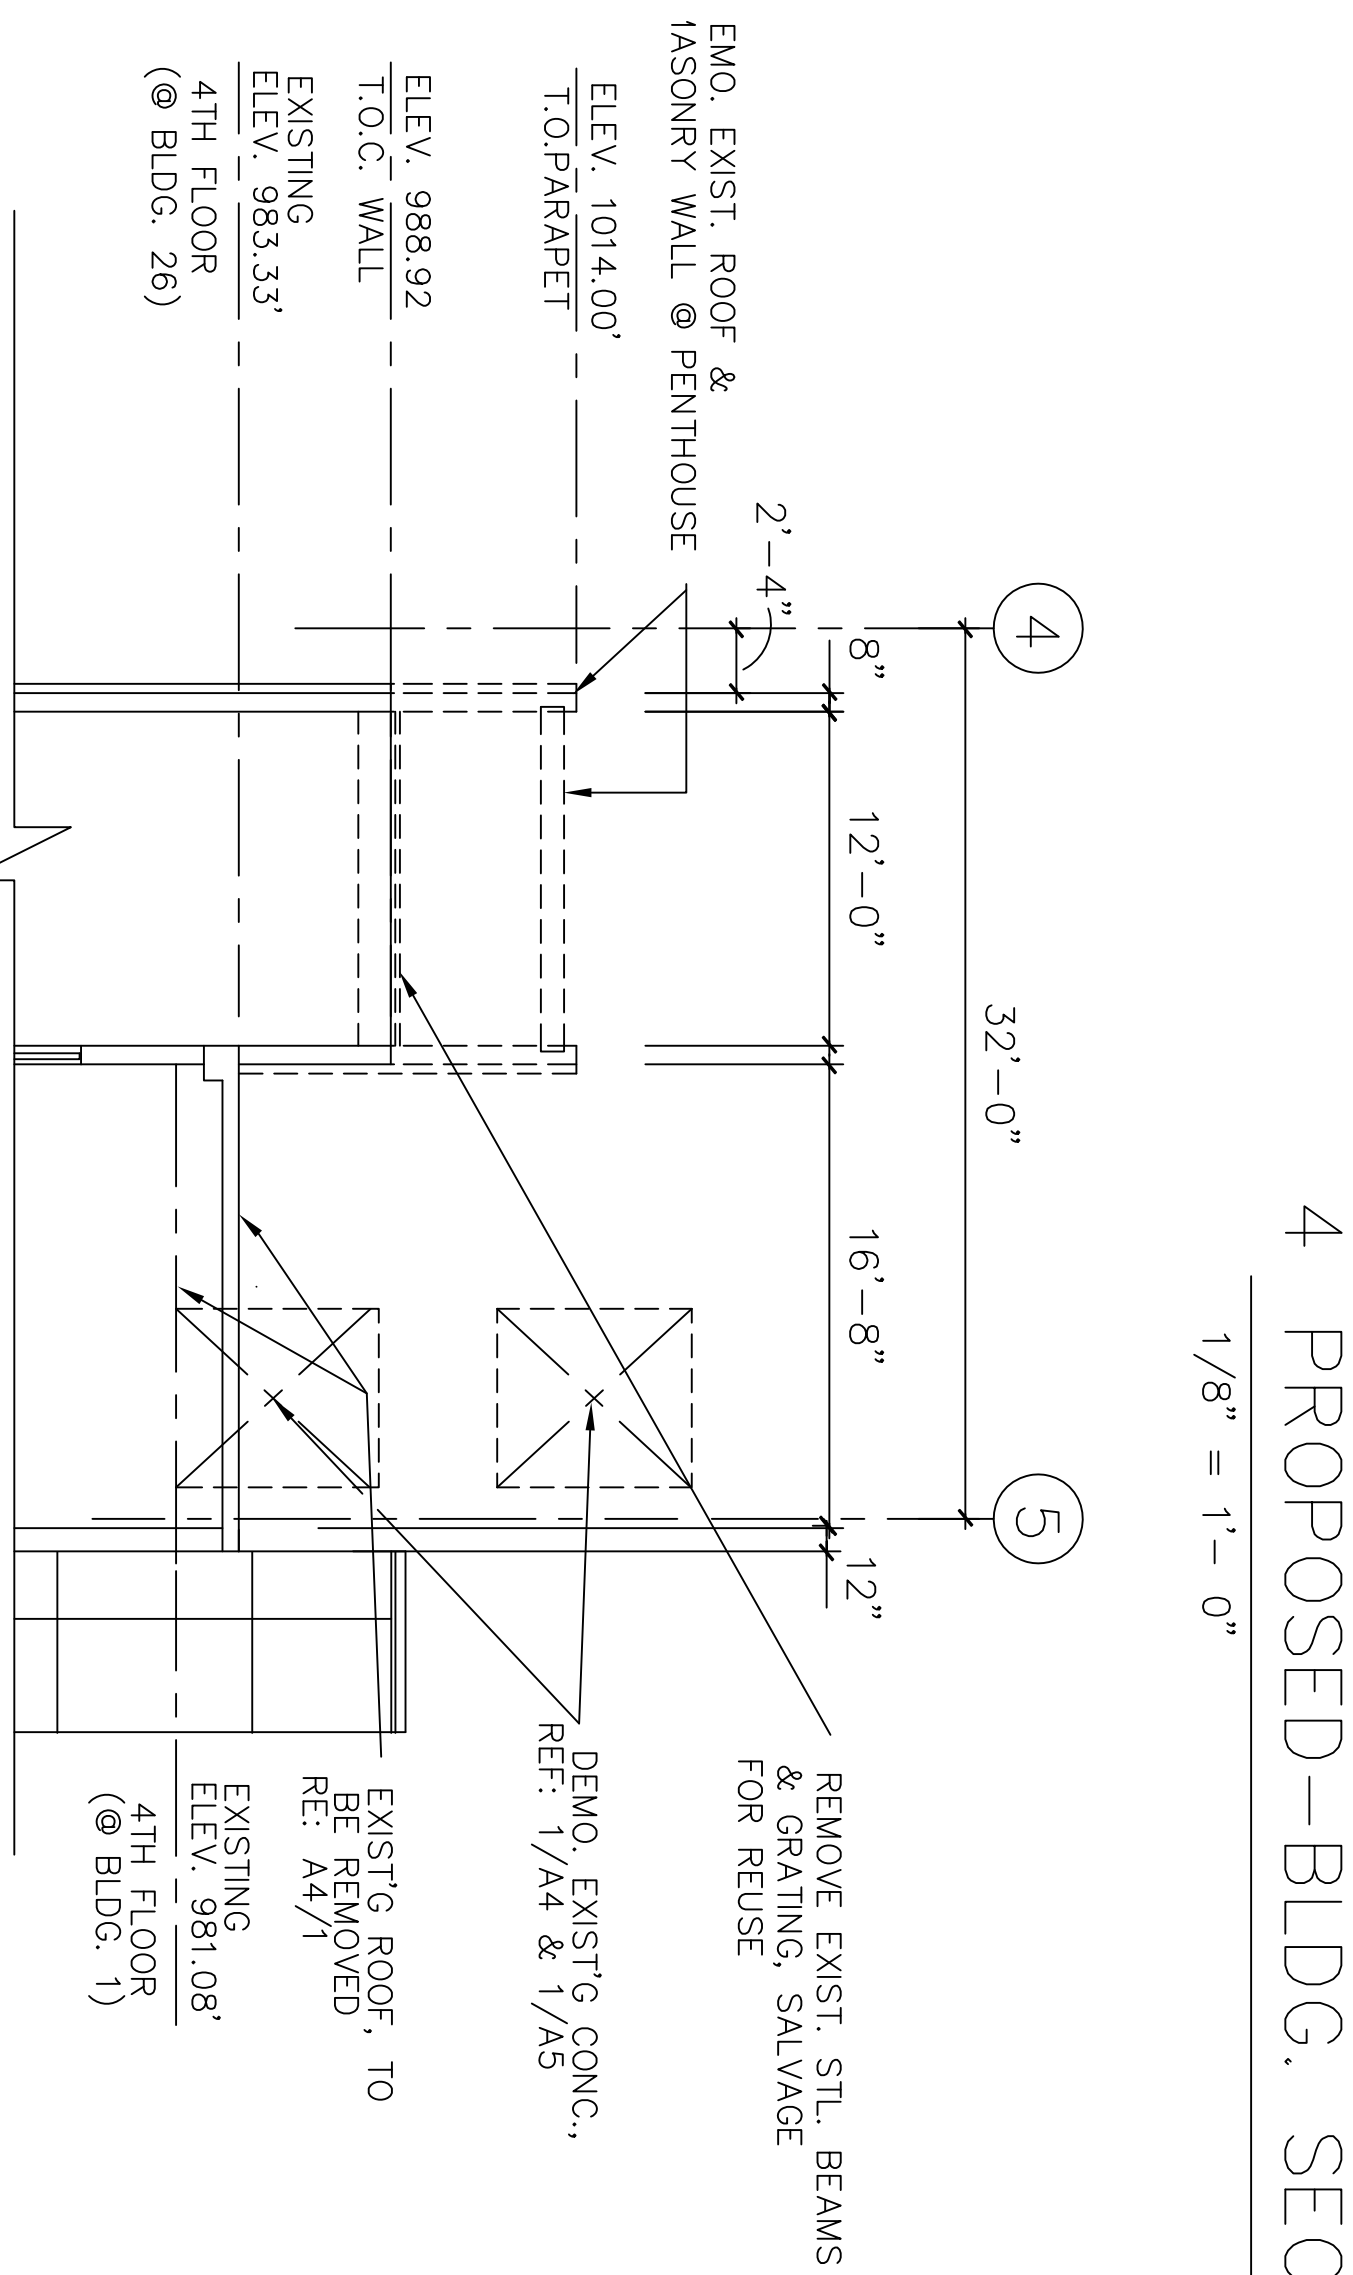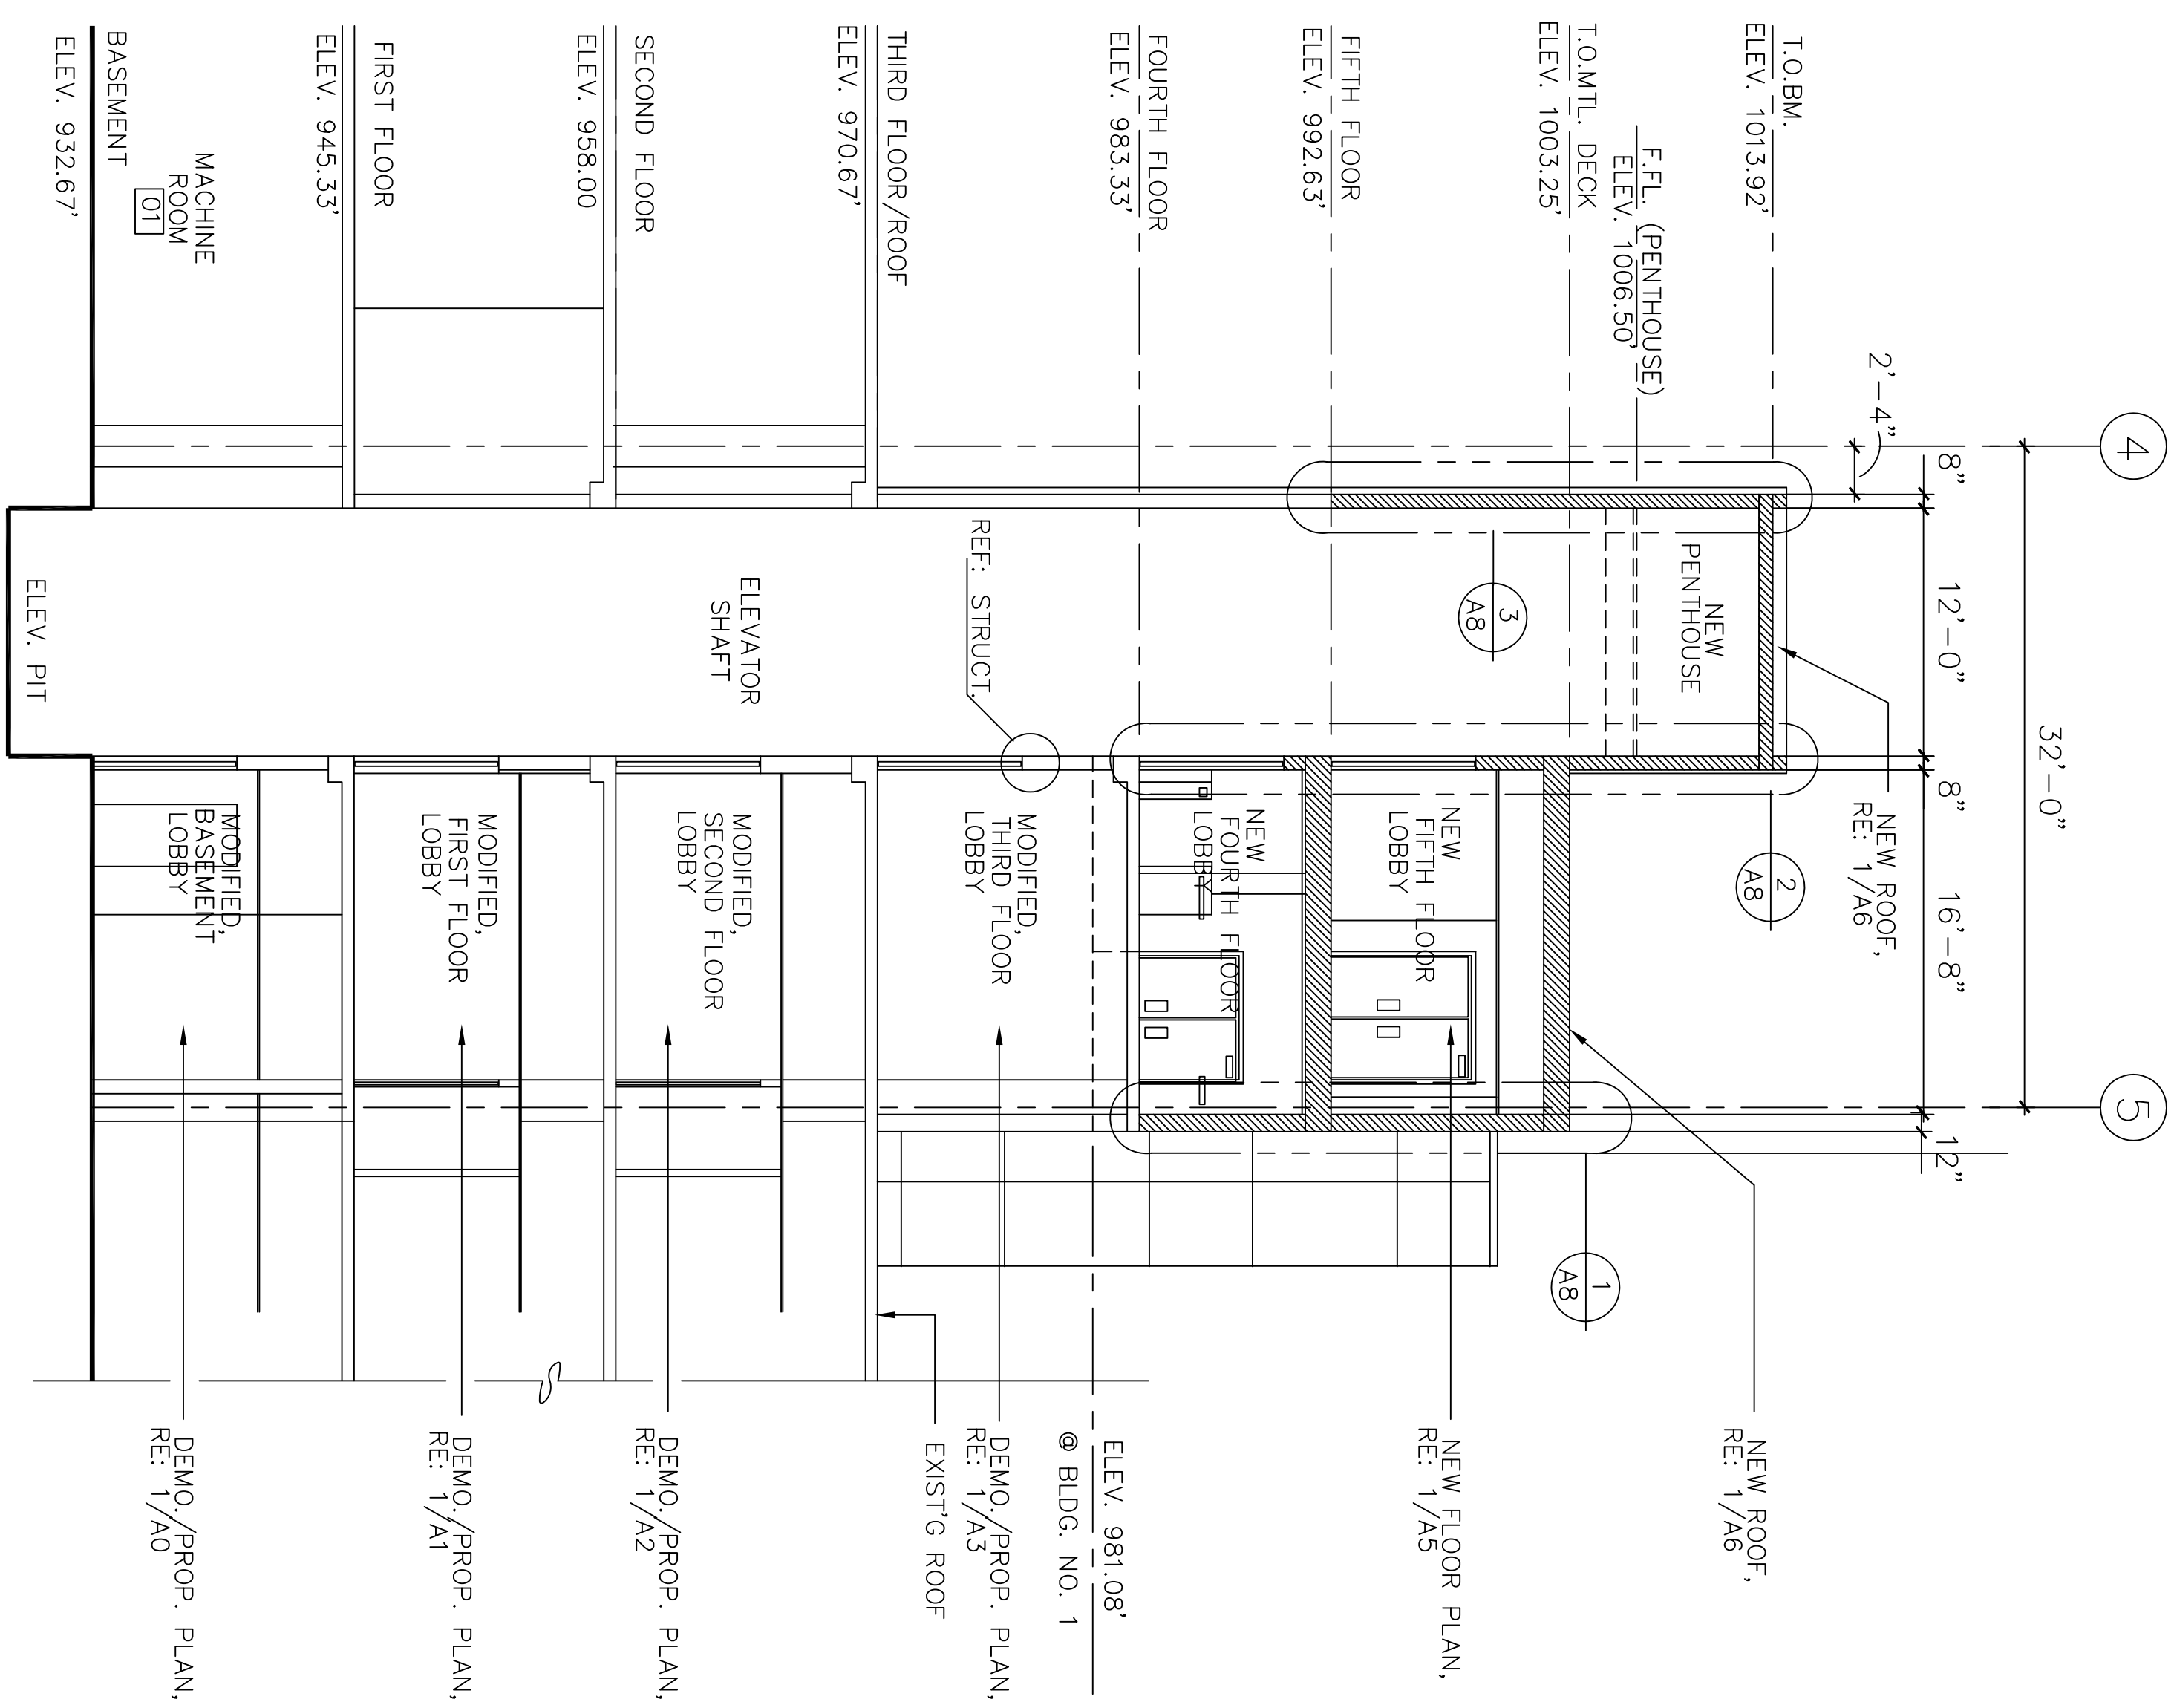

			Drawing Title	Project Title	Date
			DEMO./PROPOSED BUILDING SECTIONS / KEY PLAN	V.A. ELEVATOR REPLACEMENT	12-31-97
			Approved: Division Chief	Drawn	Project No. 76-106
			Approved: Service Director	Checked	DRAWING NO.
				Location 4801 LINWOOD BLVD., KC. MO. 64128	Dwg. Of
Revisions	Date				

[illegible]

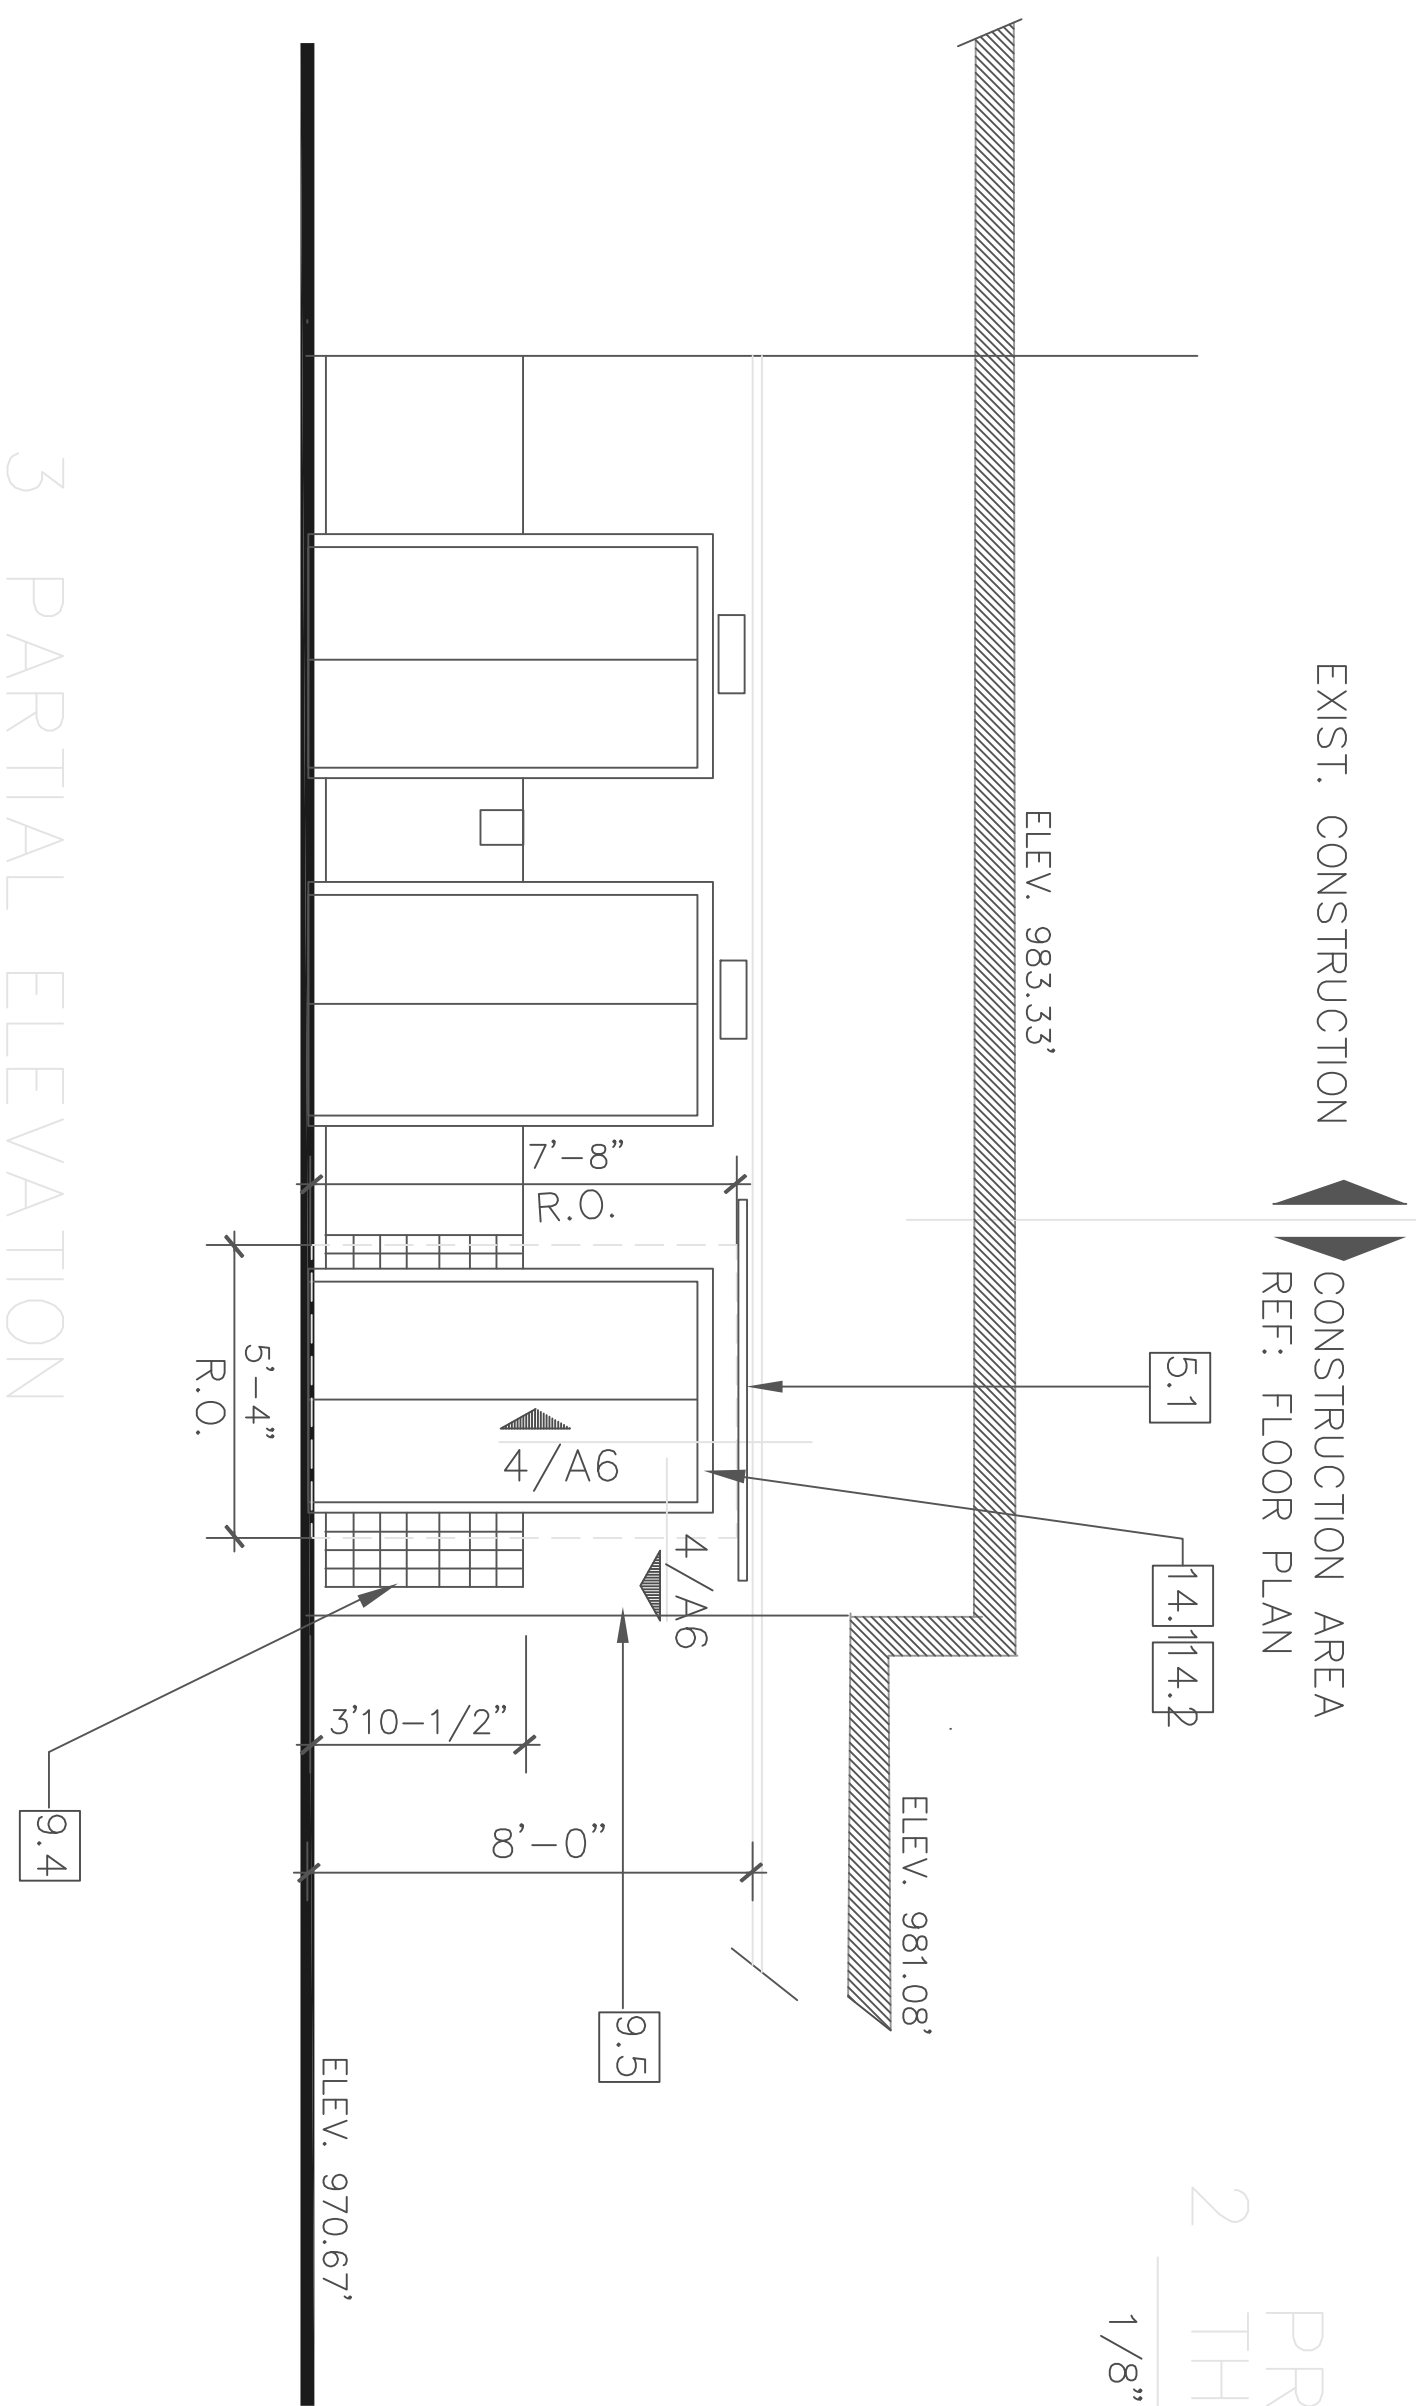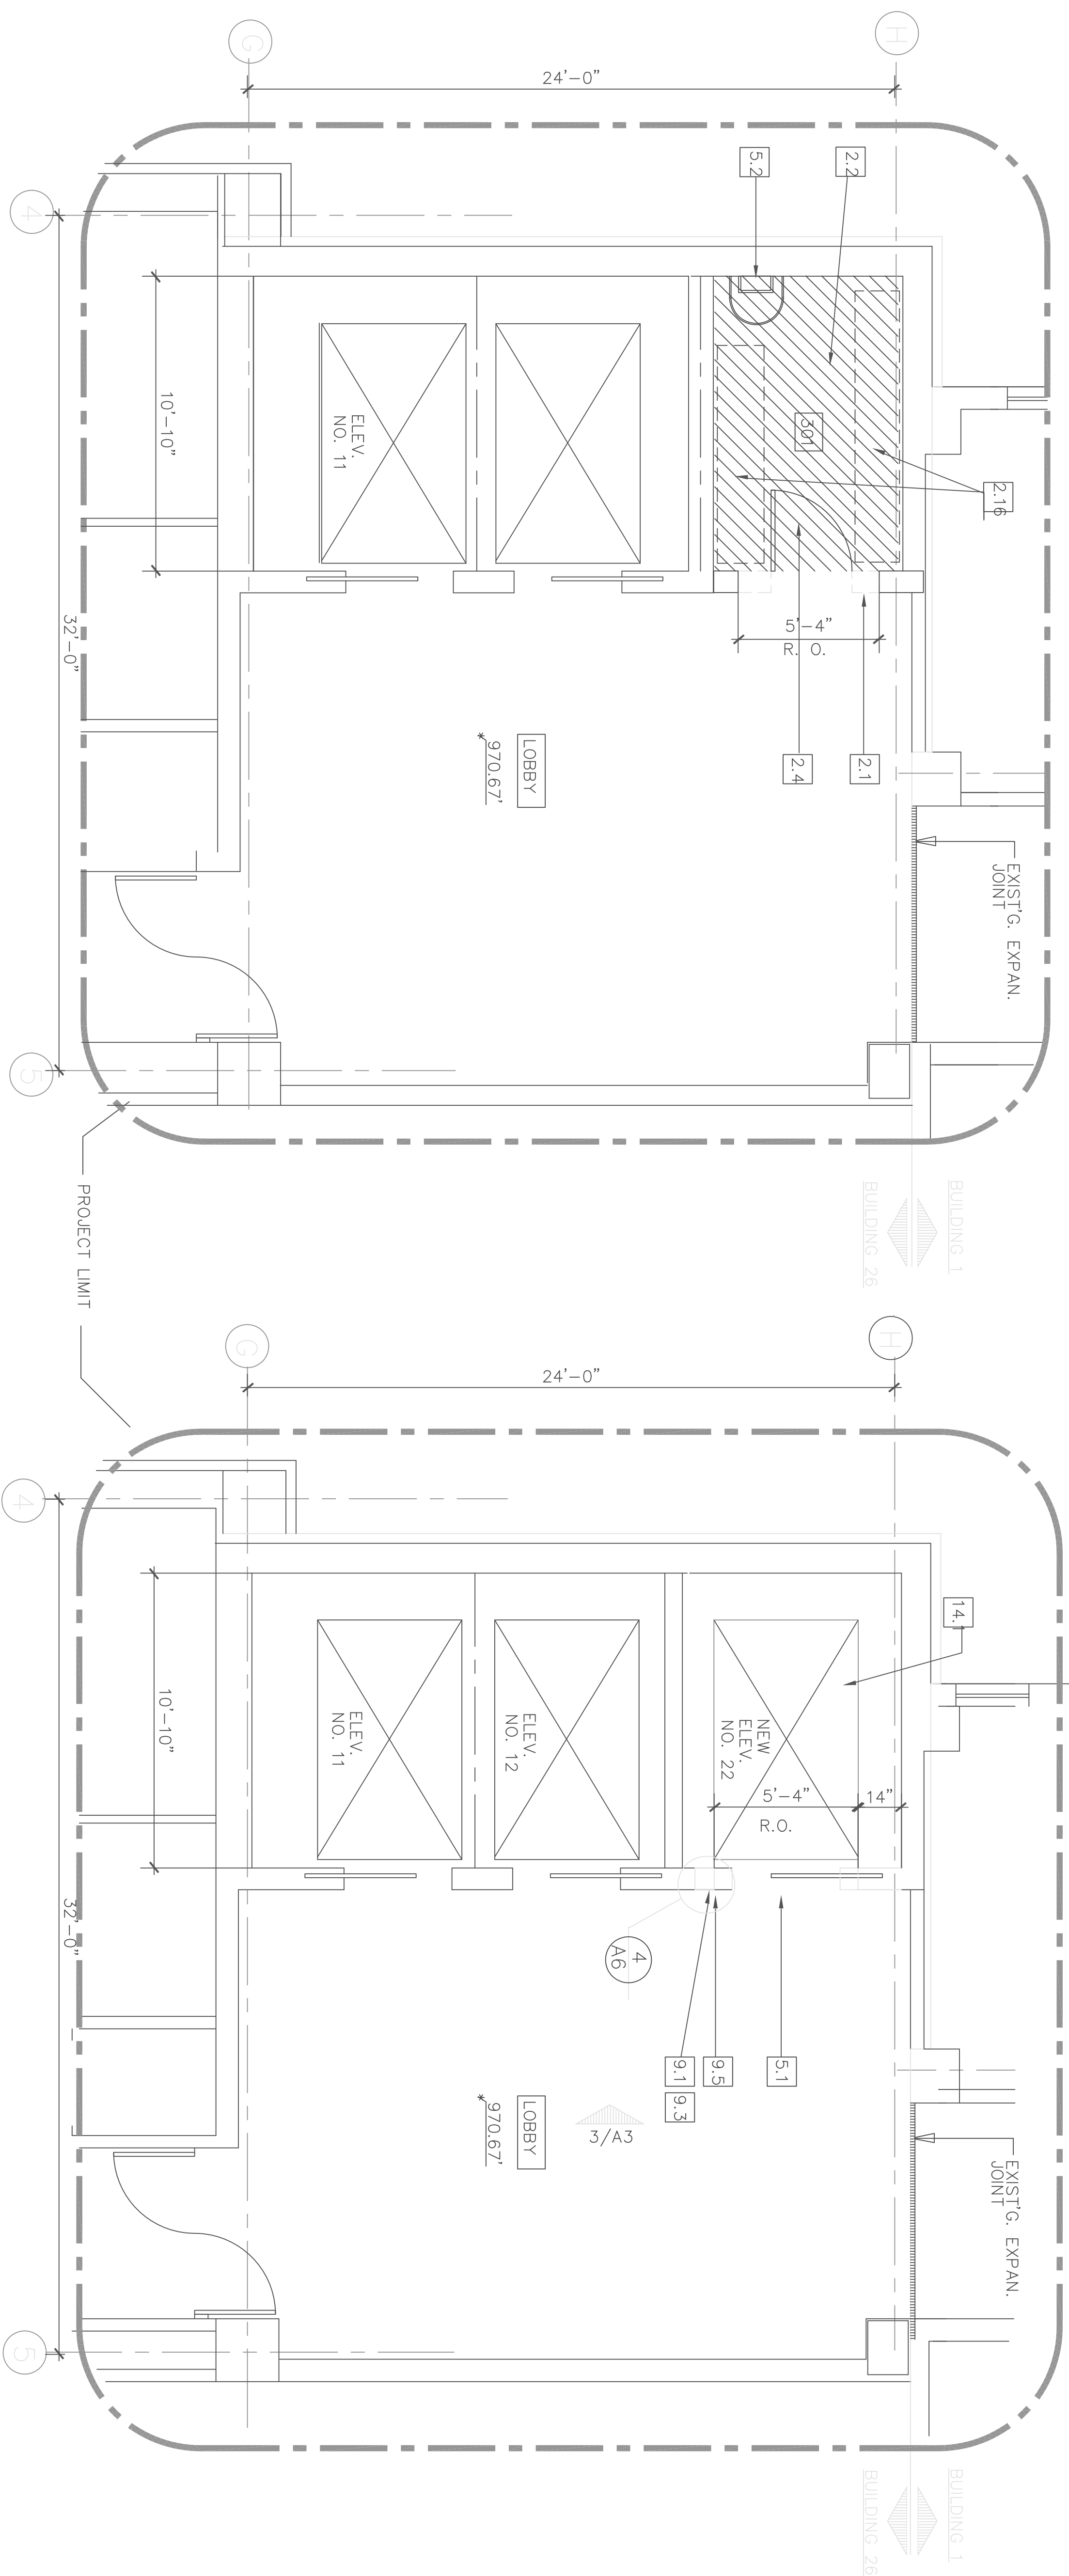
[illegible]

3 PARTIAL

1/8" = 1' - 0"

Drawing Title	Project Title
THIRD FLOOR DEMO / PROPOSED FLOOR PLAN PARTIAL ELEVATION	V.A. ELEVATOR REPLACEMENT
Approved: Division Chief	Building No.
Approved: Service Director	Location
Checked	4801 LINWOOD BLVD. KC. MO. 64128

REFERENCE		REMARKS
DESCRIPTION		
1. REFERENCE SHEET A-02 FOR GENERAL NOTES		
2.	REMOVE EXISTING WALL AS SHOWN (REQUIRED)	REF. SCHEDURING NOTES
3.	REMOVE EXISTING BRICKWORK SHEET	SWALLOW, REF. GEN. NOTES
4.	REMOVE EXISTING GIP AND FRAME	
5.	REMOVE EXISTING ROOF S/S TO CONC. SUBGRADE	
6.	REMOVE EXISTING ROOF S/S TO CONC. SUBGRADE	
7.	REMOVE EXISTING HANGAR, SALVAGE FOR OWNER	
8.	REMOVE EXISTING WALL, DOCKET	
9.	REMOVE EXISTING WALL, DOCKET	
10.	REMOVE EXISTING WALL, DOCKET	
428.	REMOVE EXISTING WALL, DOCKET	
429.		

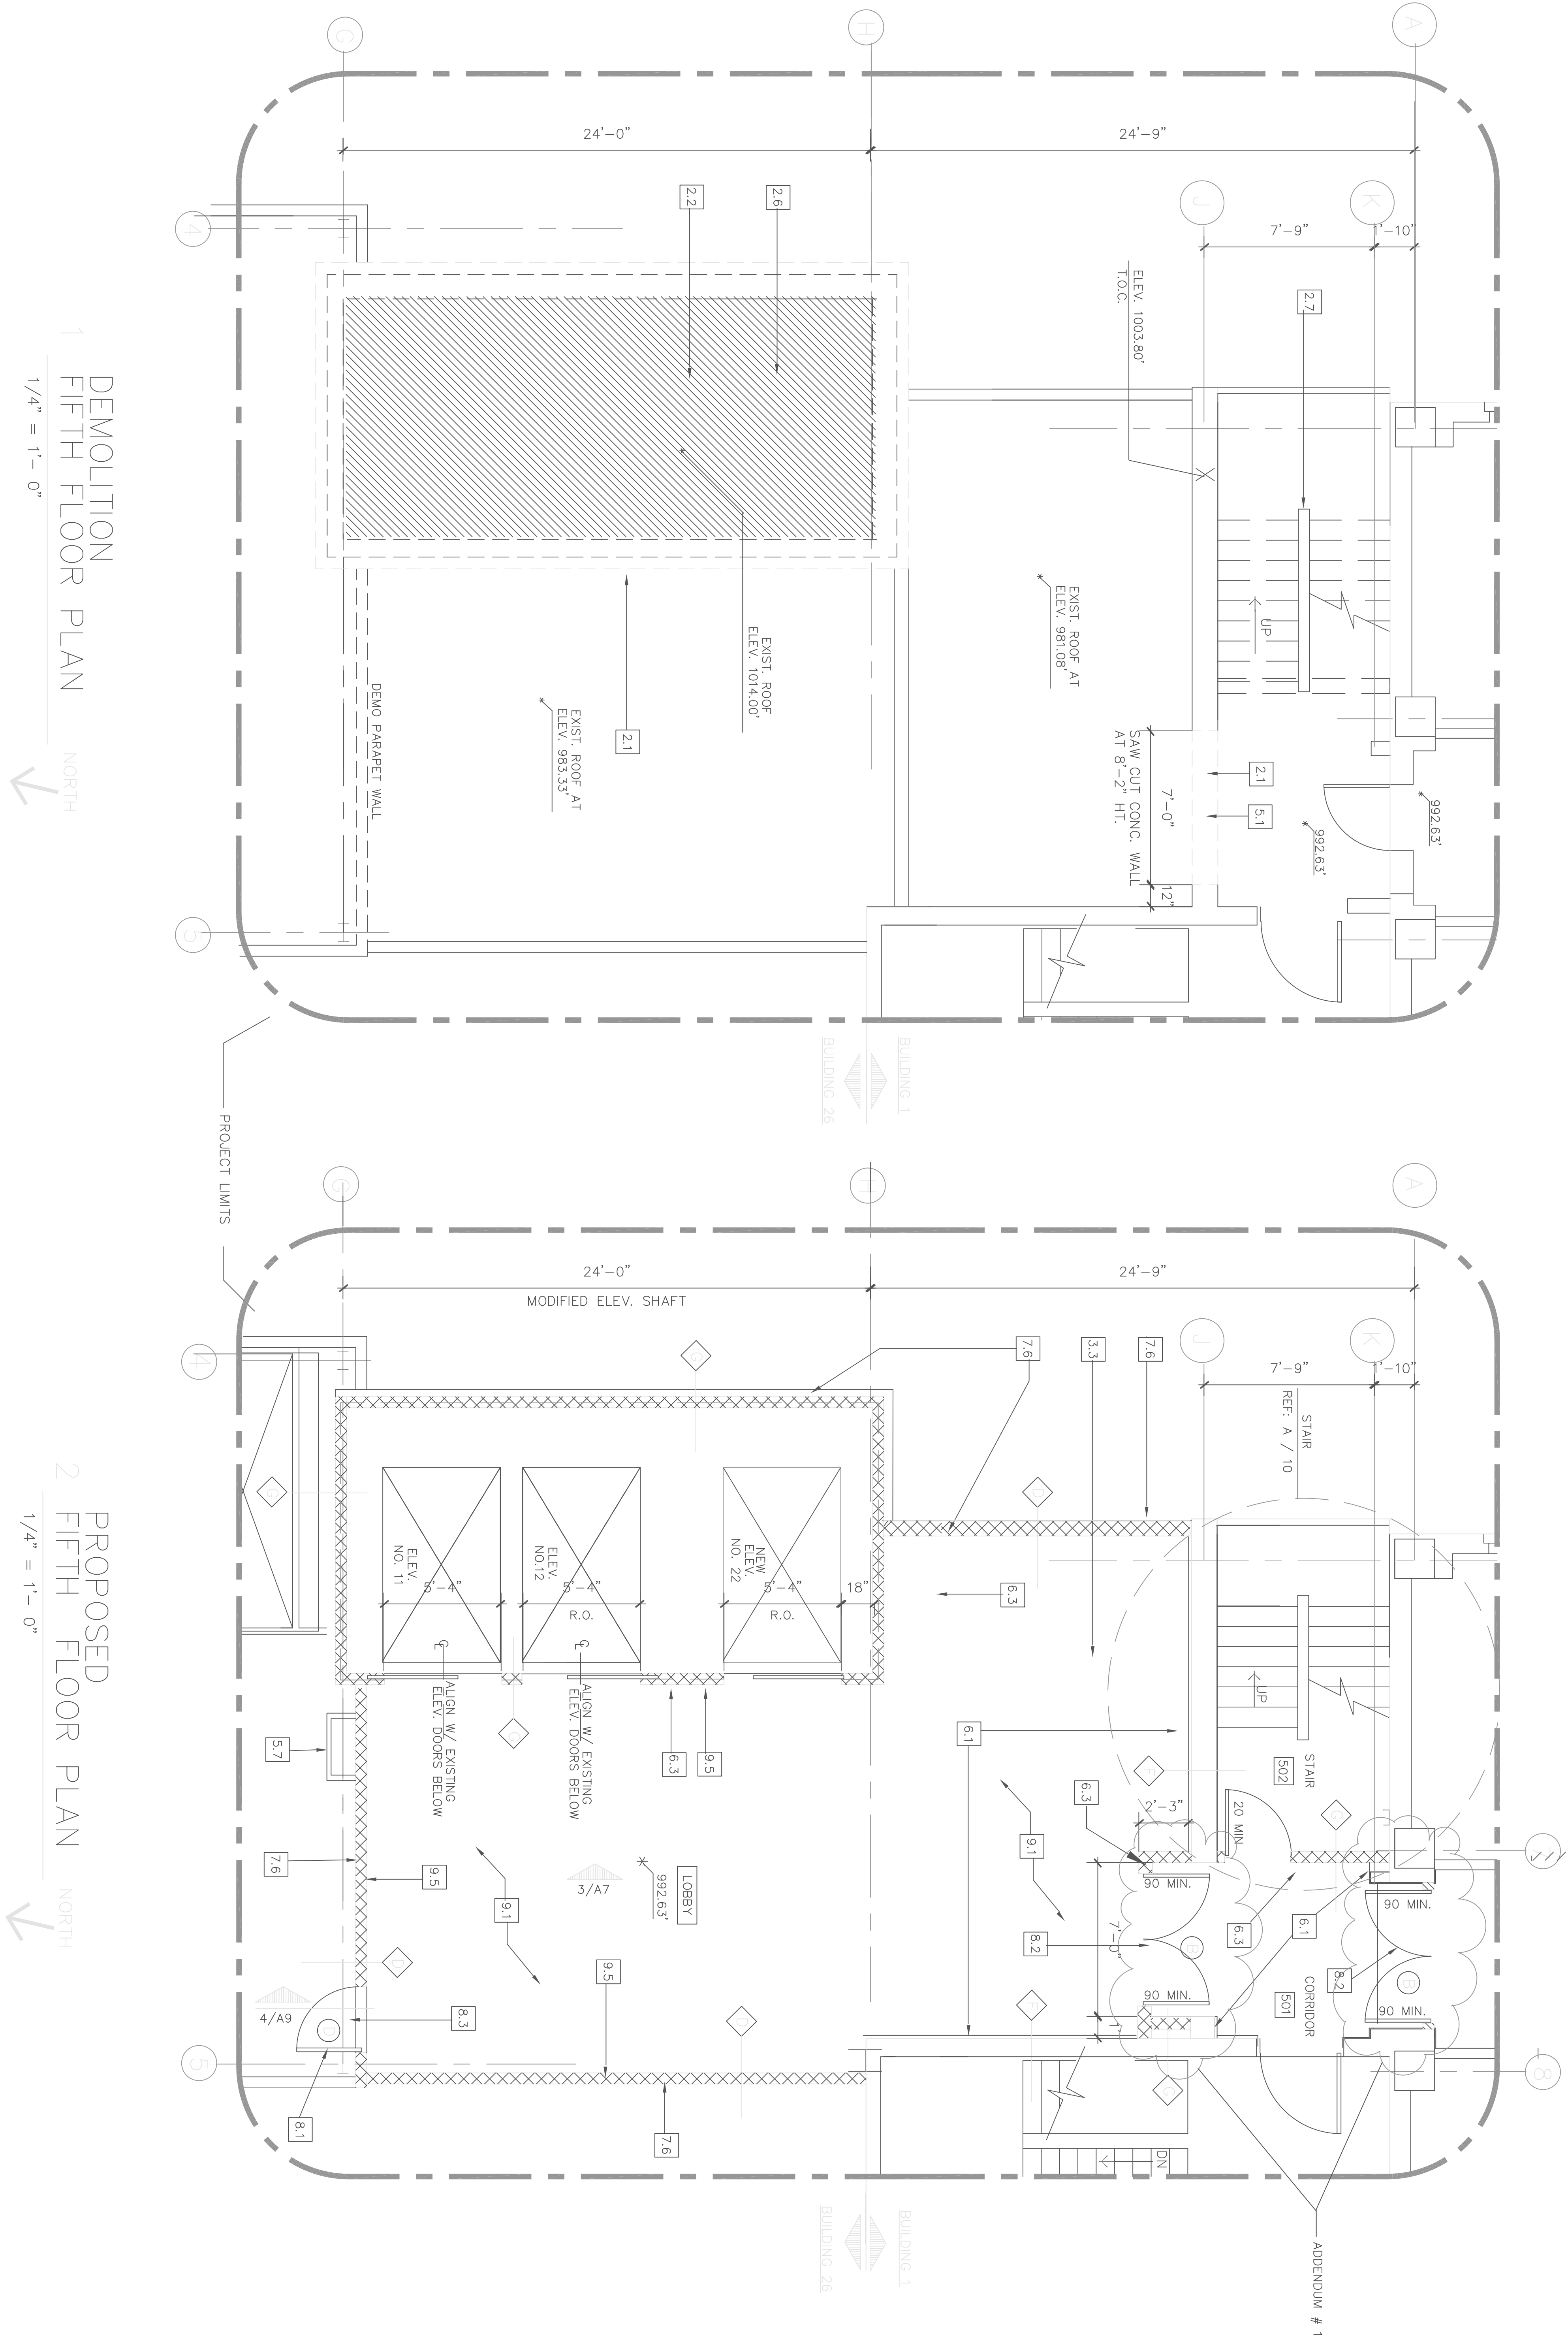

DEMOLITION
FIFTH FLOOR PLAN

1/4" = 1' - 0"


NORTH

PROPOSED
FIFTH FLOOR PLAN

1/4" = 1'-0"


Drawing Title	Project Title	
FIFTH FLOOR DEMO / PROPOSED FLOOR PLAN	V.A. ELEVATOR REPLACEMENT	
Approved: Division Chief	Drawn	Building No.
Approved: Service Director	Checked	BLDG. 1 & BLDG. 26
	Location	4801 LINWOOD BLVD., KC., MO. 64128


REFERENCE		REFUGES
DATE	DESCRIPTION	
1.	REFERENCE SHEET #02 FOR GENERAL NOTES	
2.	REFUGES	
3.	REFUGES	
4.	REFUGES	
100.	REFUGES	

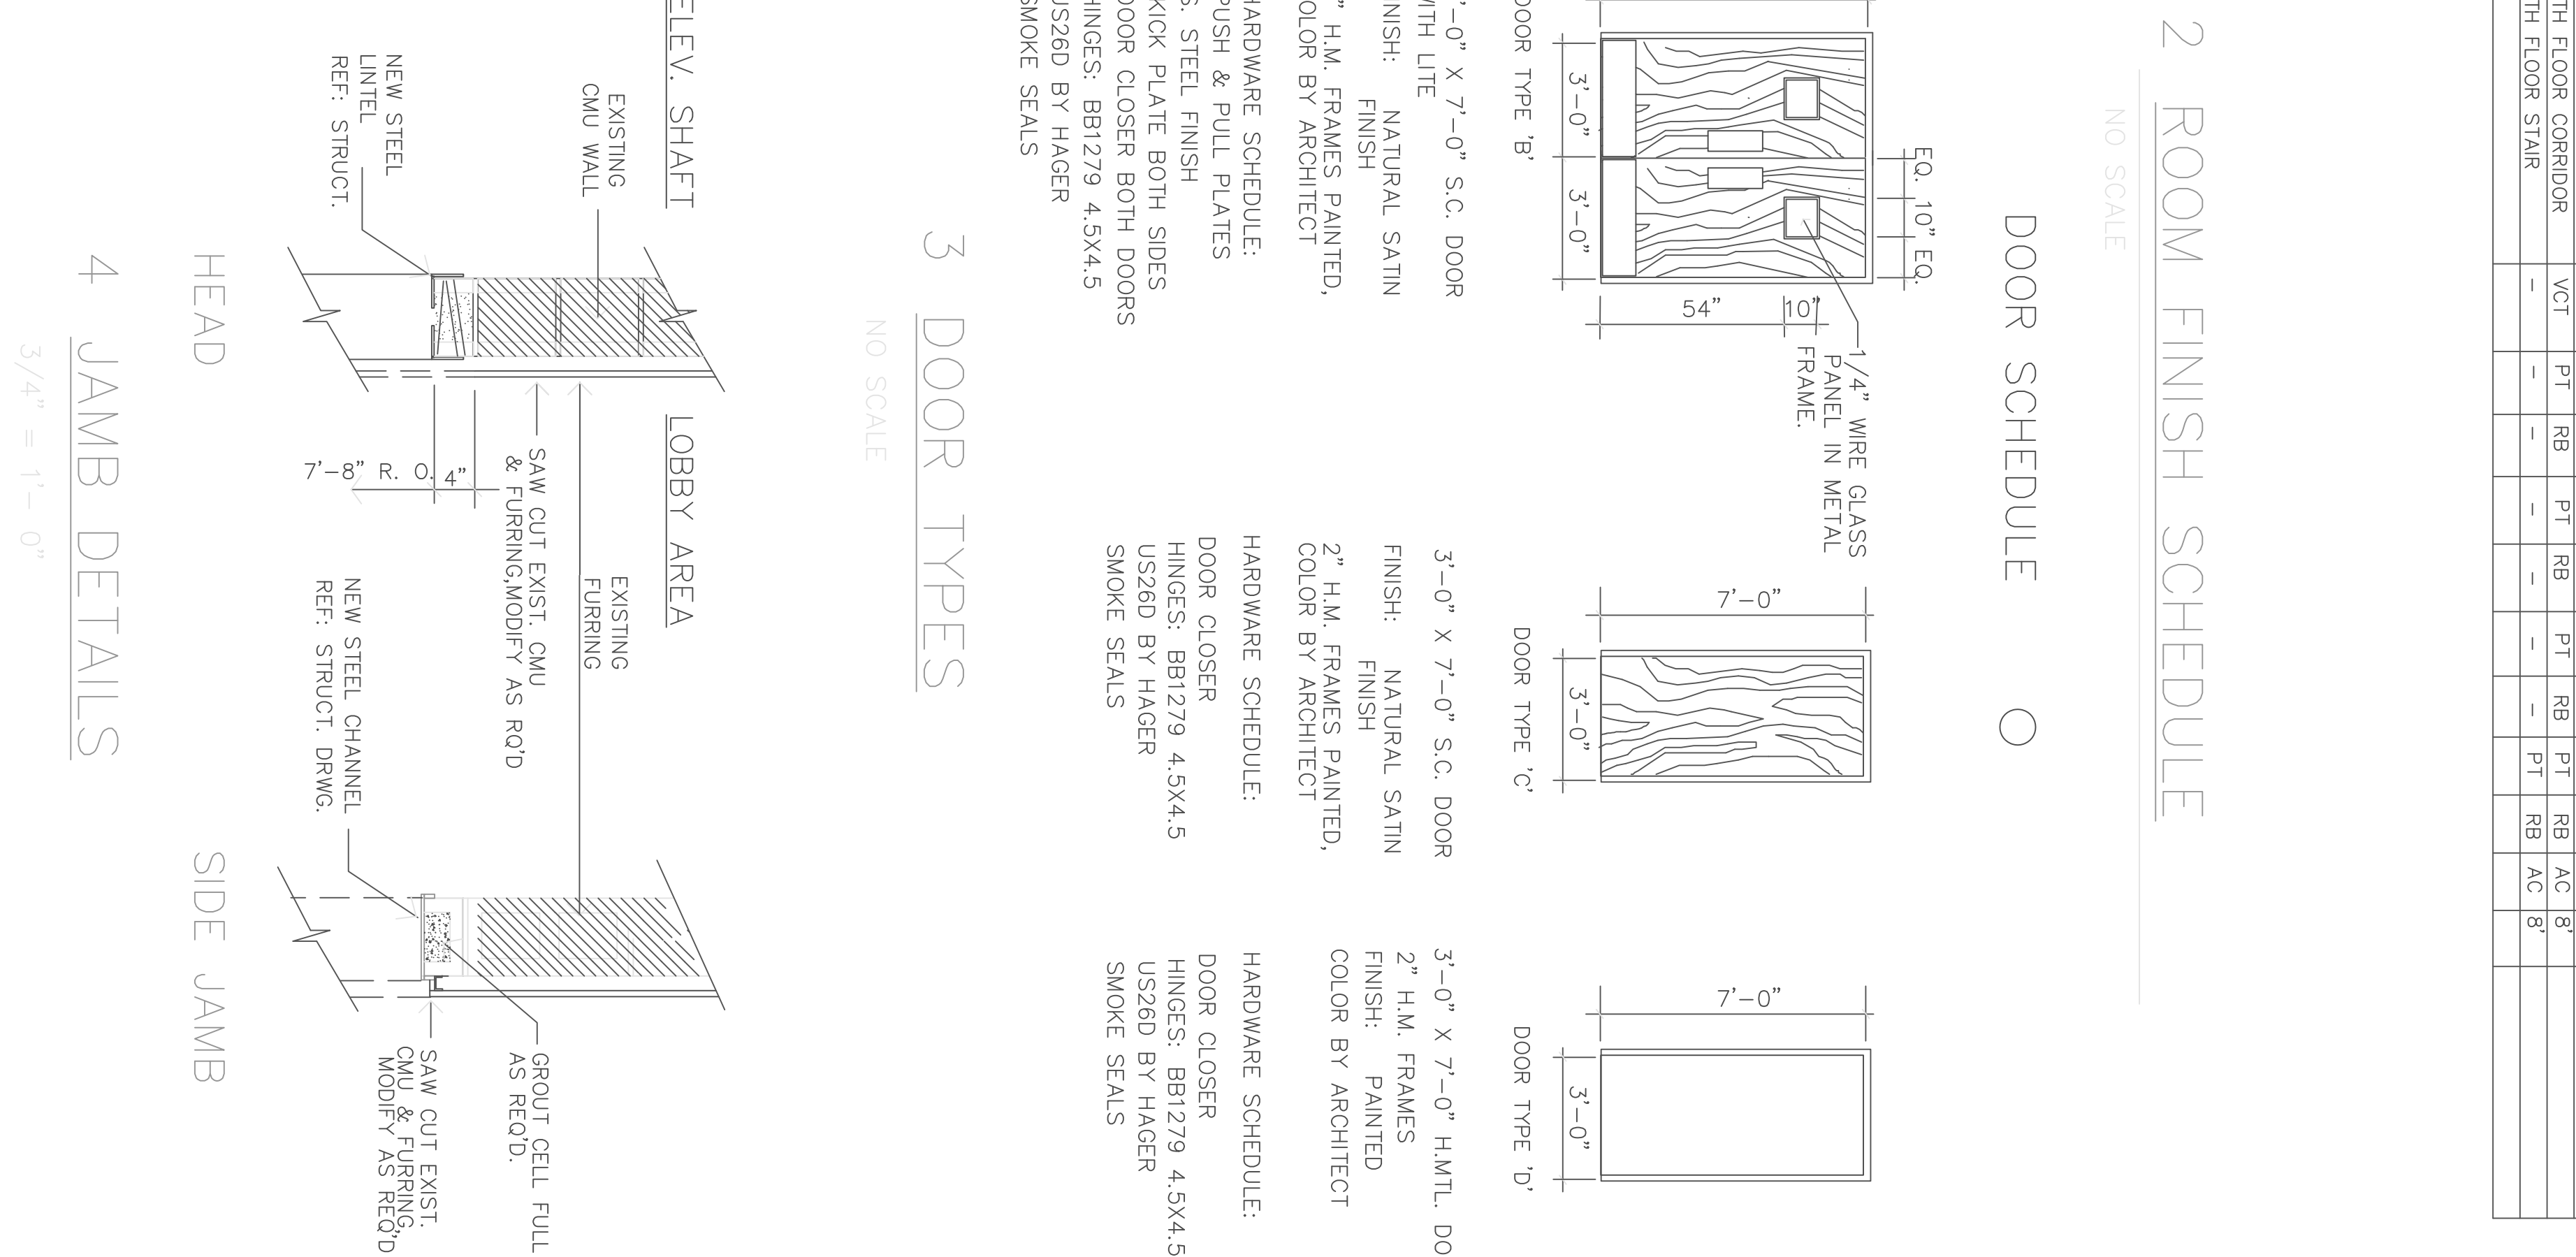

4.1	NOT USED
4.2	
5.0	STEEL LINEL RE. STRUCT. DIMS.
5.1	REMOVE EXISTING M/L LADDER, SALVAGE FOR REUSE
5.2	REMOVE EXISTING M/L LADDER
5.3	REMOVE EXISTING M/L LADDER
5.4	EXISTING METAL GRADE TO REMAIN
5.5	EXISTING STEEL BEAM TO REMAIN


61	NEW 3/4" OPN BRD OVER 7/8" NAT CHMS, ATTACHED		
62	REPAIR EXISTING RECOATED DOOR FRAME		
63	REPAIR EXISTING RECOATED DOOR FRAME		
64	REPAIR EXISTING RECOATED DOOR FRAME		
65	REPAIR EXISTING RECOATED DOOR FRAME		
66	REPAIR EXISTING RECOATED DOOR FRAME		
67	REPAIR EXISTING RECOATED DOOR FRAME		
68	REPAIR EXISTING RECOATED DOOR FRAME		
69	REPAIR EXISTING RECOATED DOOR FRAME		
70	REPAIR EXISTING RECOATED DOOR FRAME		
71	NEW 3/4" OPN BRD OVER 7/8" NAT CHMS, ATTACHED		
72	REPAIR EXISTING RECOATED DOOR FRAME		
73	REPAIR EXISTING RECOATED DOOR FRAME		
74	REPAIR EXISTING RECOATED DOOR FRAME		
75	REPAIR EXISTING RECOATED DOOR FRAME		
76	REPAIR EXISTING RECOATED DOOR FRAME		
77	REPAIR EXISTING RECOATED DOOR FRAME		
78	REPAIR EXISTING RECOATED DOOR FRAME		
79	REPAIR EXISTING RECOATED DOOR FRAME		
80	REPAIR EXISTING RECOATED DOOR FRAME		
81	REPAIR EXISTING RECOATED DOOR FRAME		
82	REPAIR EXISTING RECOATED DOOR FRAME		
83	REPAIR EXISTING RECOATED DOOR FRAME		
84	REPAIR EXISTING RECOATED DOOR FRAME		
85	REPAIR EXISTING RECOATED DOOR FRAME		
86	REPAIR EXISTING RECOATED DOOR FRAME		
87	REPAIR EXISTING RECOATED DOOR FRAME		
88	REPAIR EXISTING RECOATED DOOR FRAME		
89	REPAIR EXISTING RECOATED DOOR FRAME		
90	REPAIR EXISTING RECOATED DOOR FRAME		
91	REPAIR EXISTING RECOATED DOOR FRAME		
92	REPAIR EXISTING RECOATED DOOR FRAME		
93	REPAIR EXISTING RECOATED DOOR FRAME		
94	REPAIR EXISTING RECOATED DOOR FRAME		
95	REPAIR EXISTING RECOATED DOOR FRAME		
96	REPAIR EXISTING RECOATED DOOR FRAME		
97	REPAIR EXISTING RECOATED DOOR FRAME		
98	REPAIR EXISTING RECOATED DOOR FRAME		
99	REPAIR EXISTING RECOATED DOOR FRAME		
100	REPAIR EXISTING RECOATED DOOR FRAME		

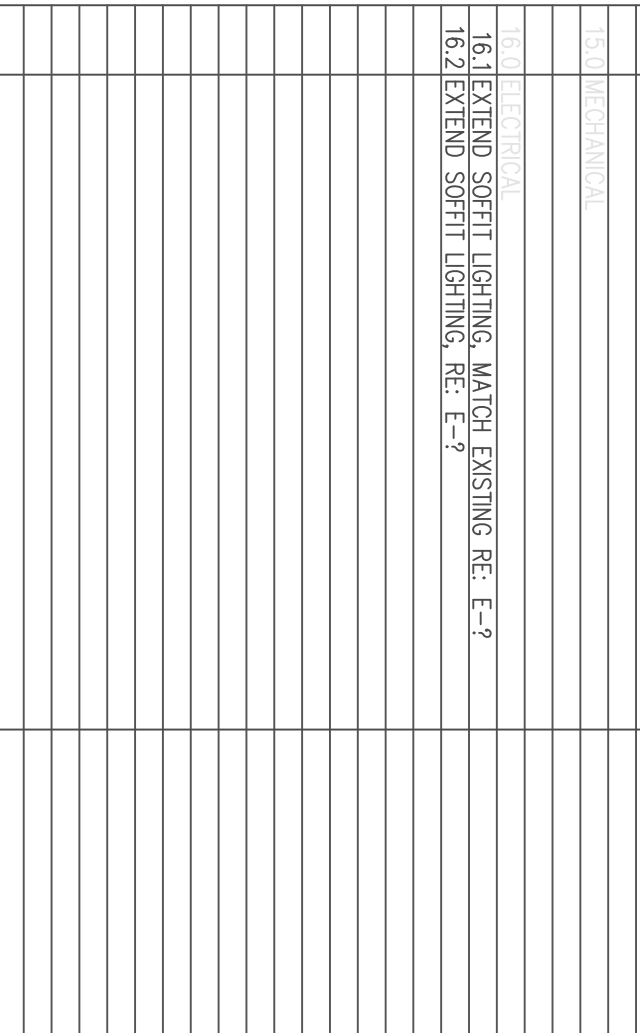

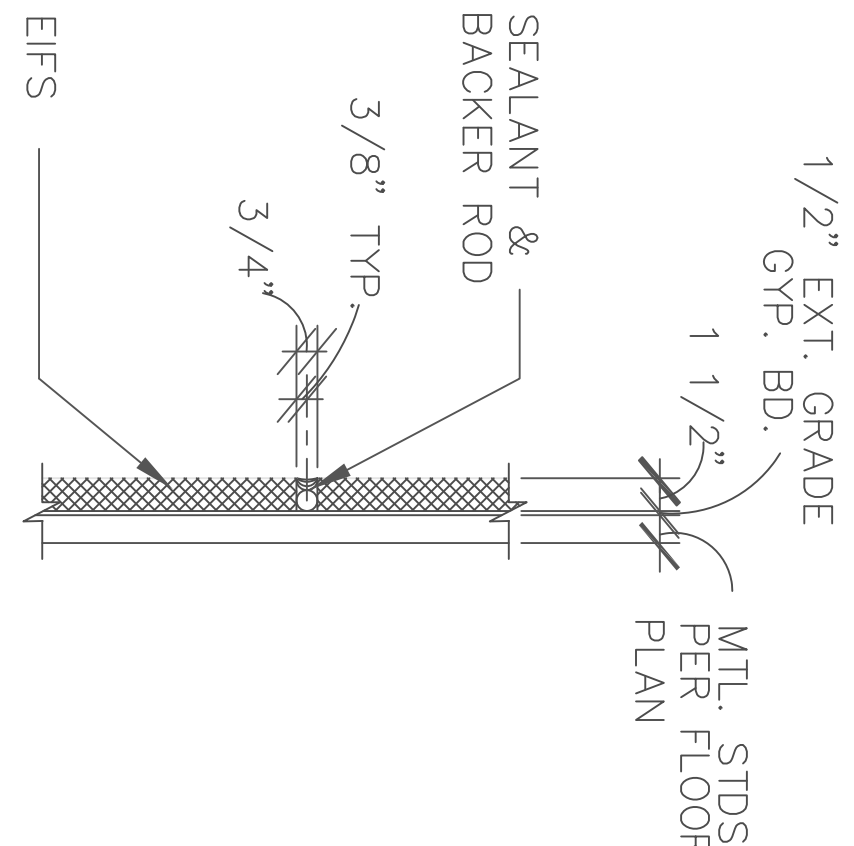


6 EXPAN. JOINTS-EIFS.

1 1/2" = 1'-0"

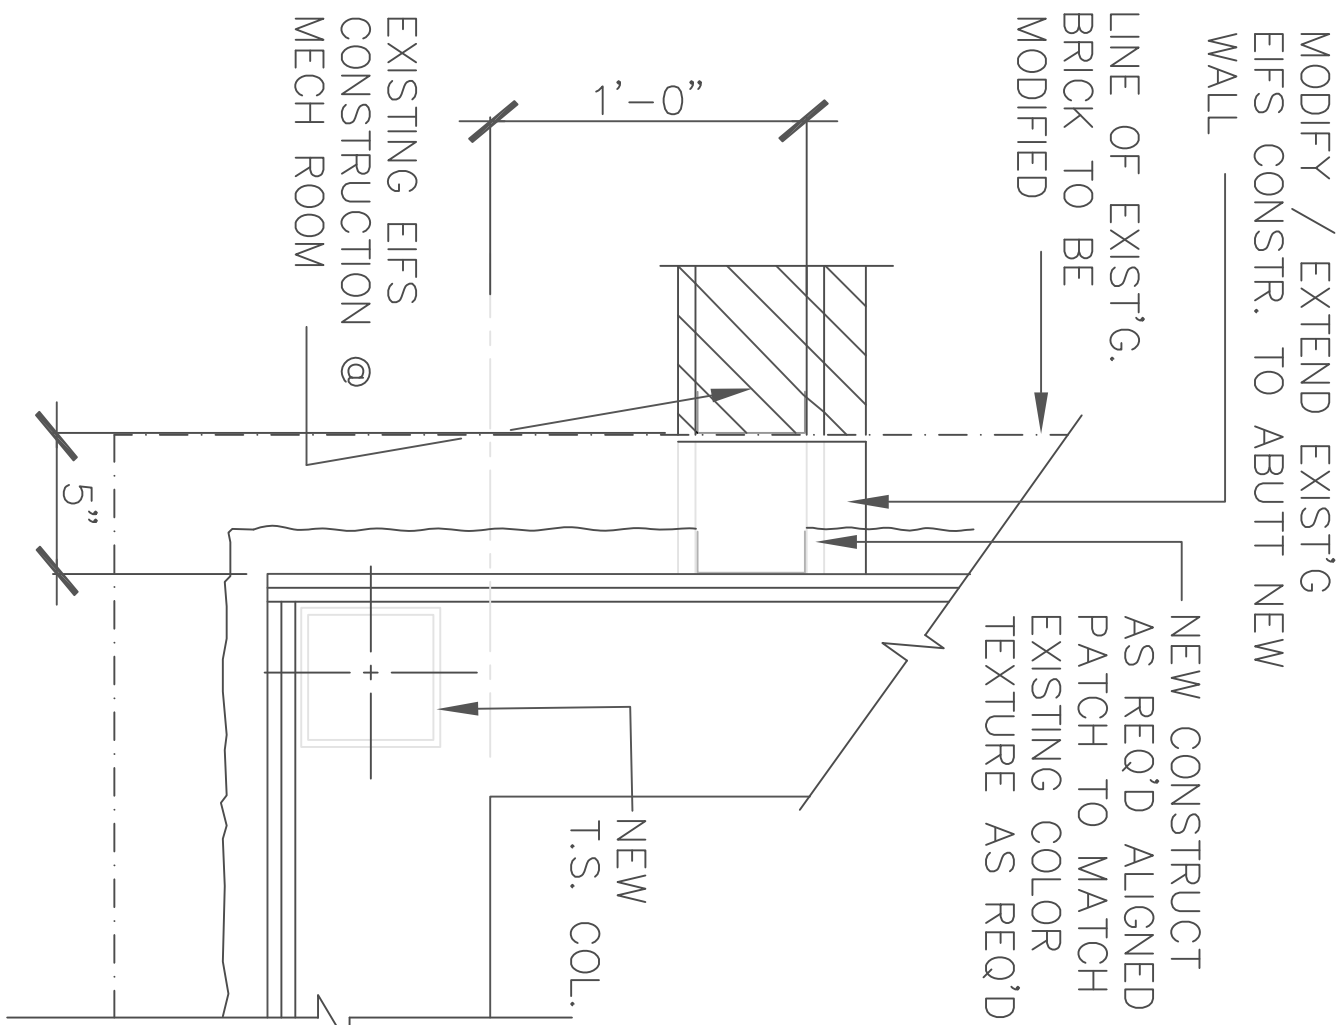

5 PLAN DETAIL

1-1/2" = 1'-0"

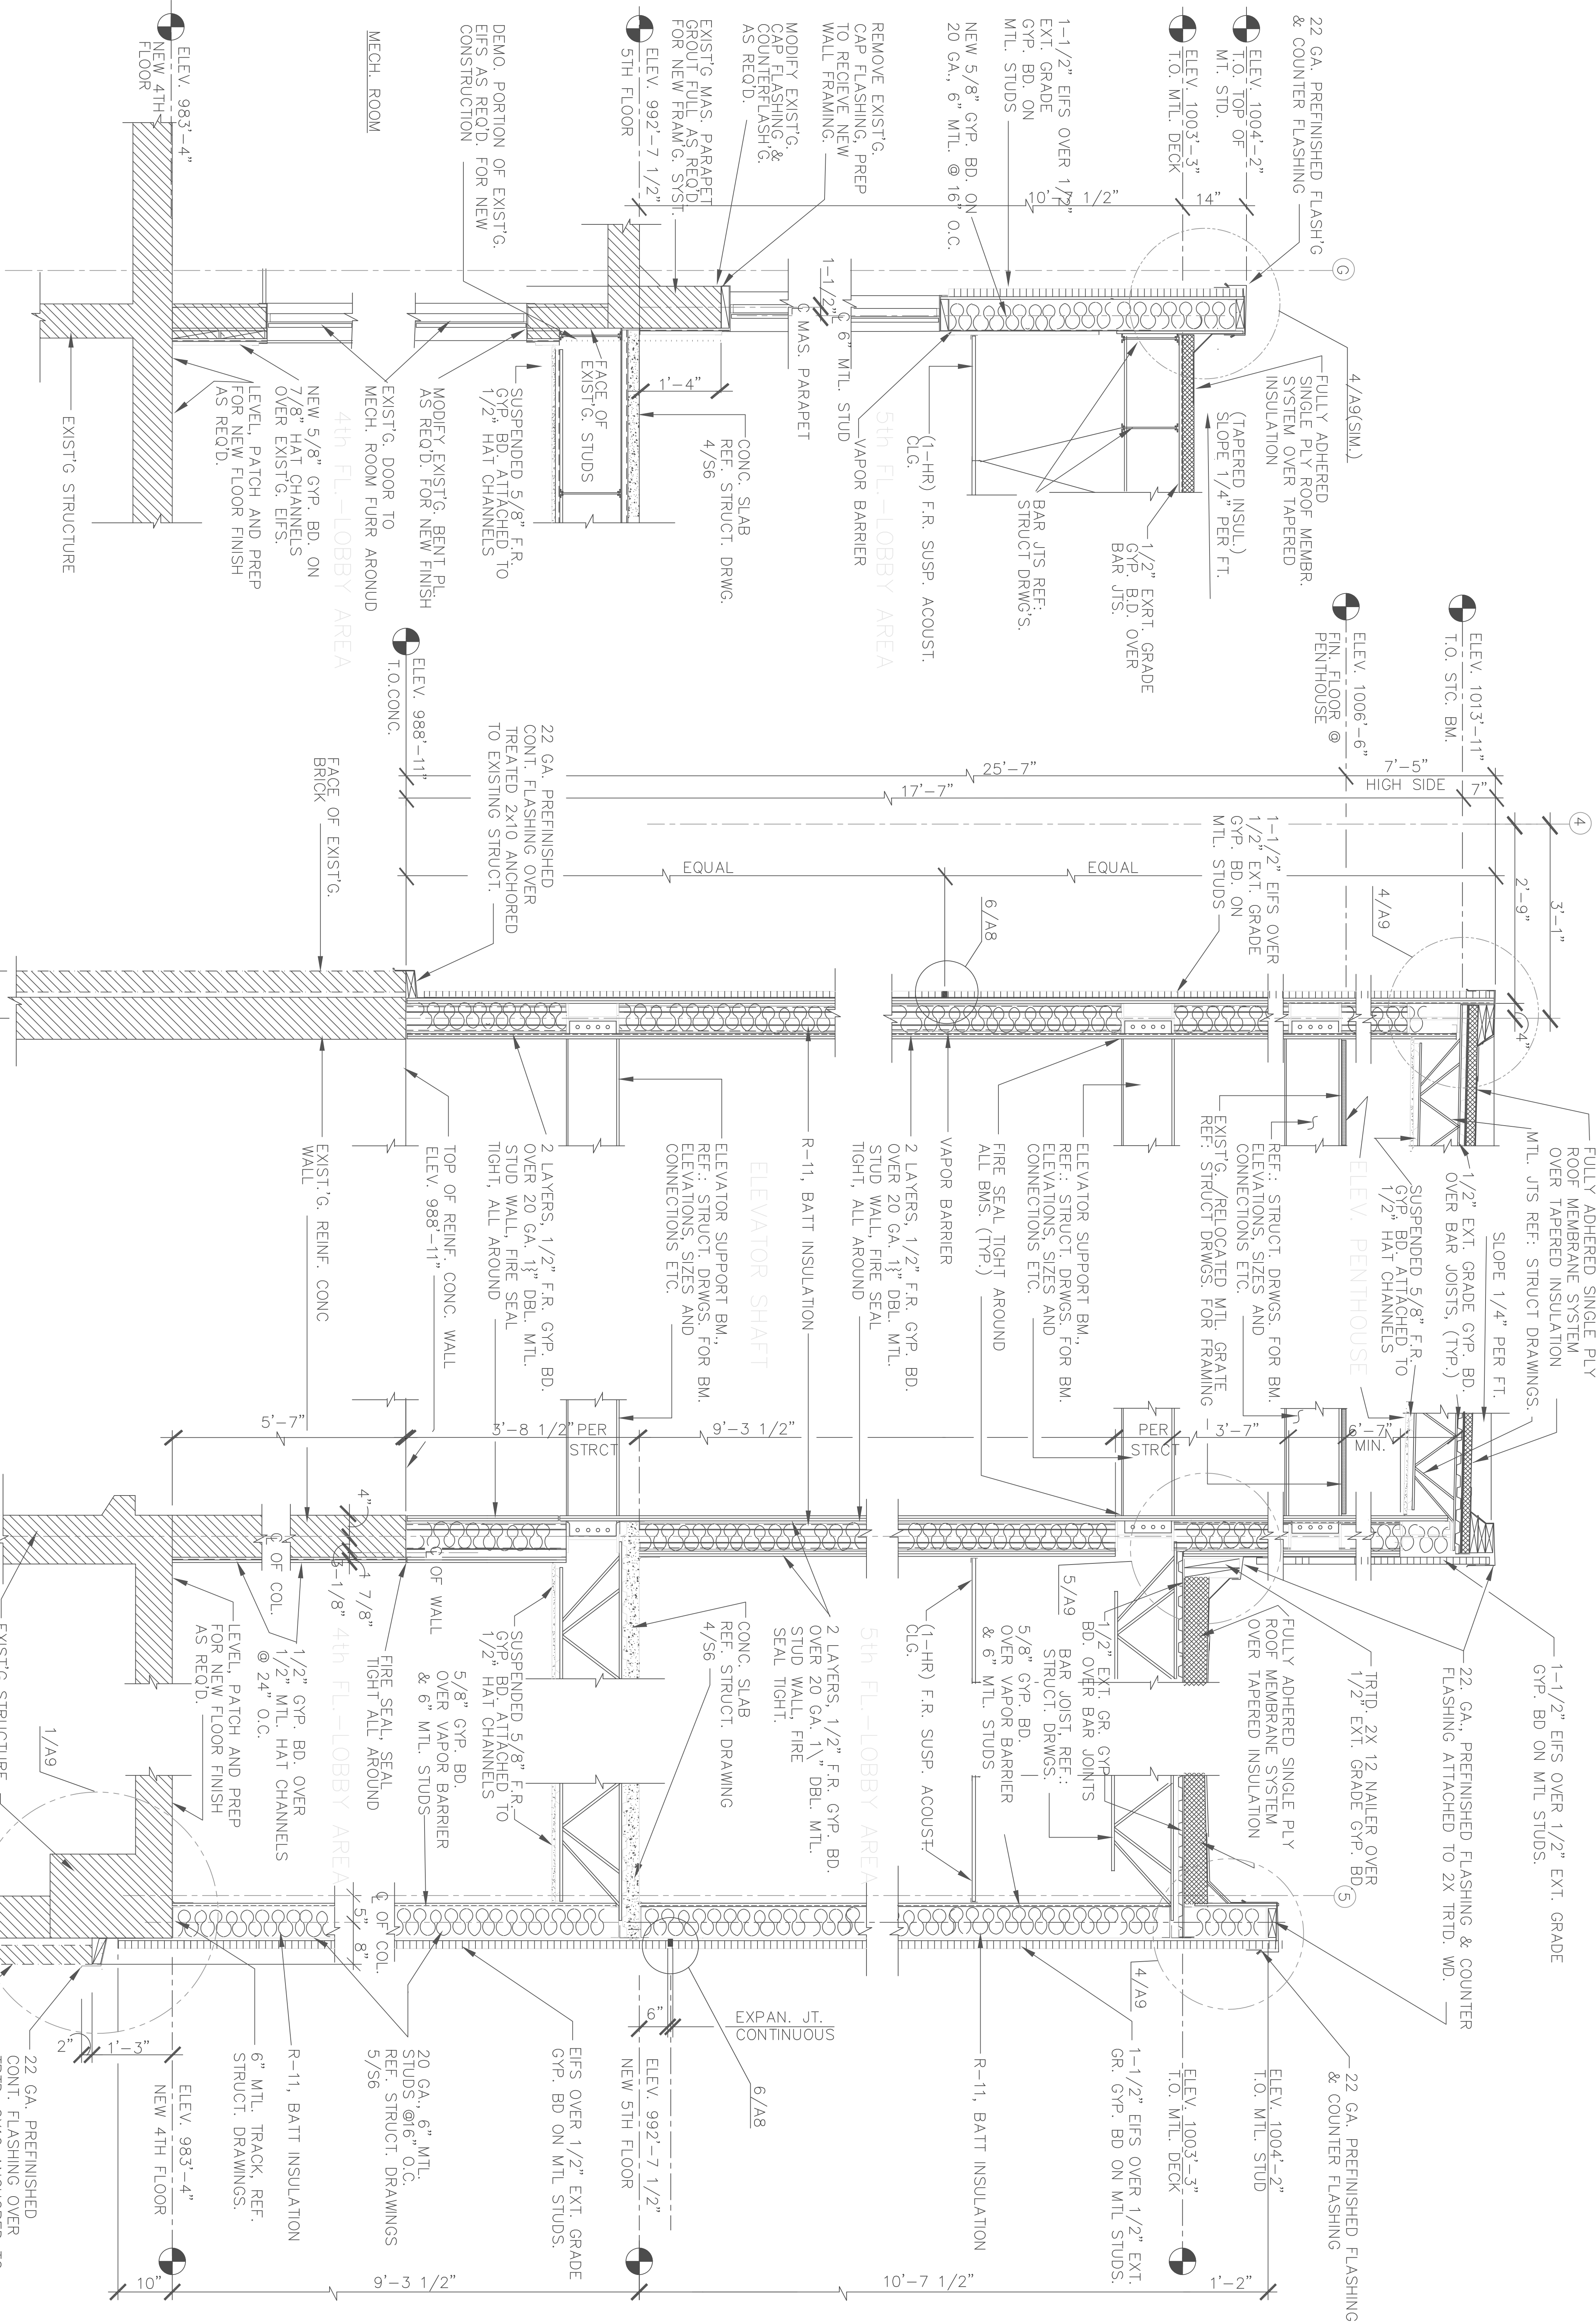

4 SECTION

3/4" = 1'-0"

3 SECTION

3/4" = 1'-0"

2 SECTION

3/4" = 1'-0"



1 SECTION

3/4" = 1'-0"


WALL SECTION, DETAILS

V.A. ELEVATOR REPLACEMENT


Drawing Title		Project Title		Date	
Approved: Division Chief	Drawn	Building No.	BLDG. 1 & BLDG. 26	Project No.	XX-XX-XX
Approved: Service Director	Checked	Location	4801 LINCOLN BLDG. KC. MO. 64128	Drawing No.	76-106
				Drawn By	A8

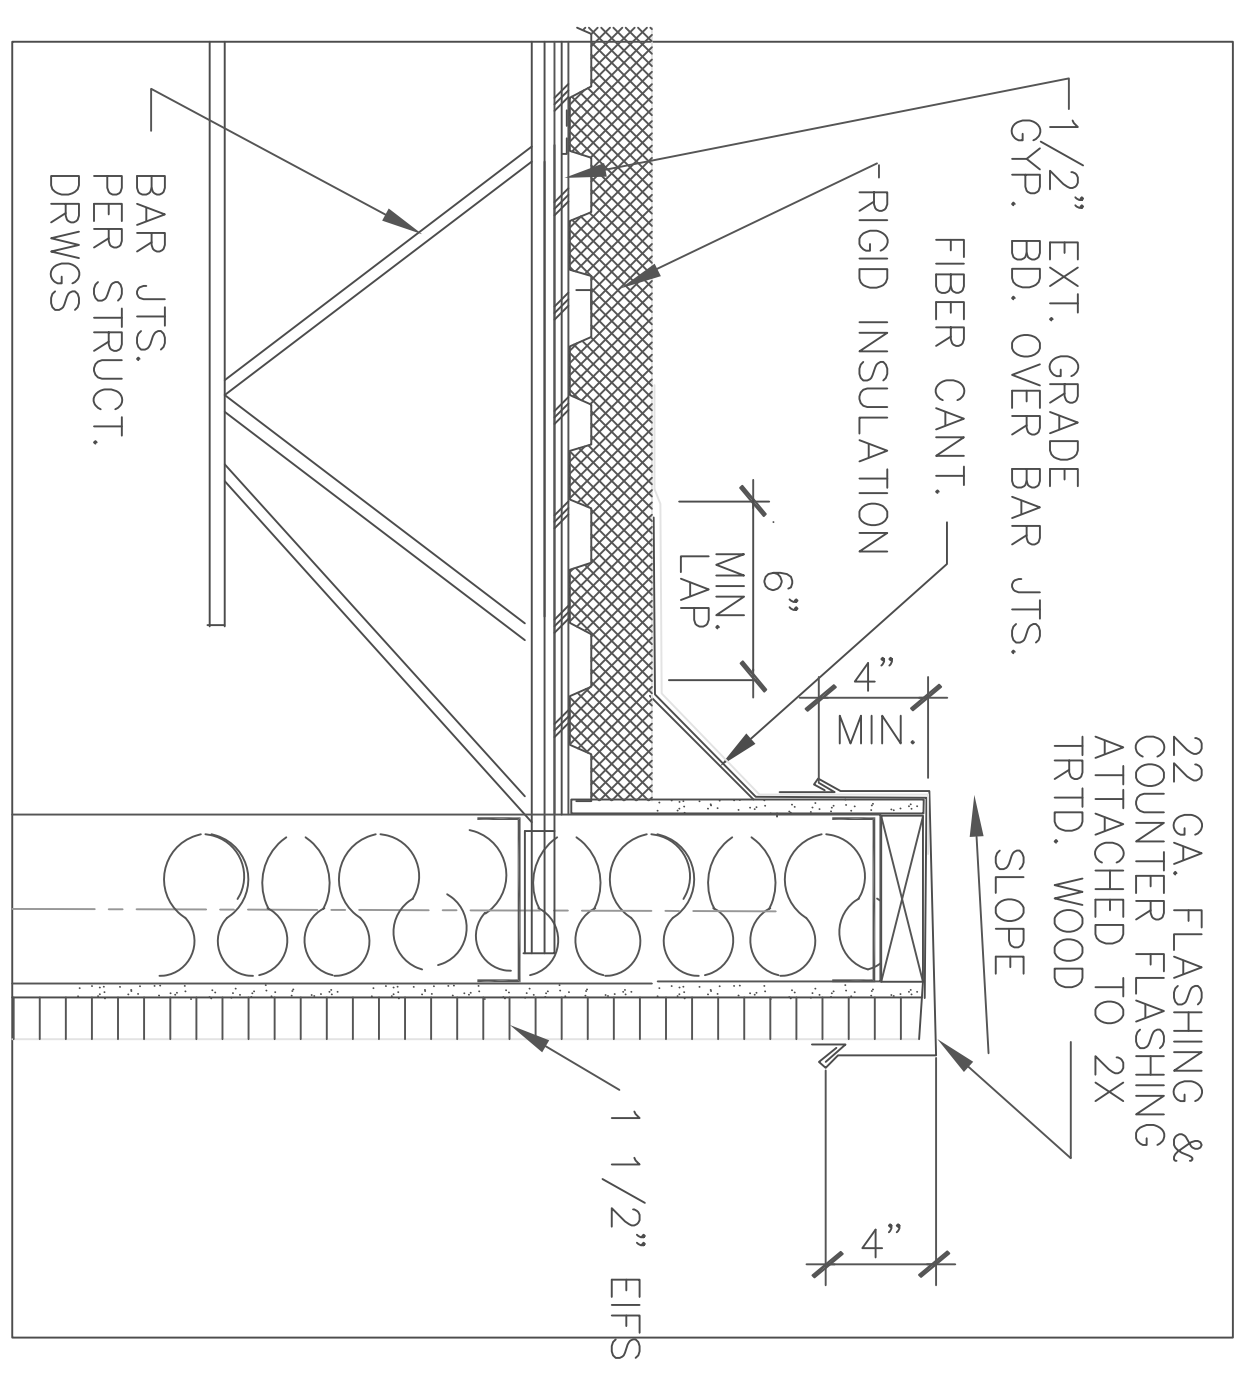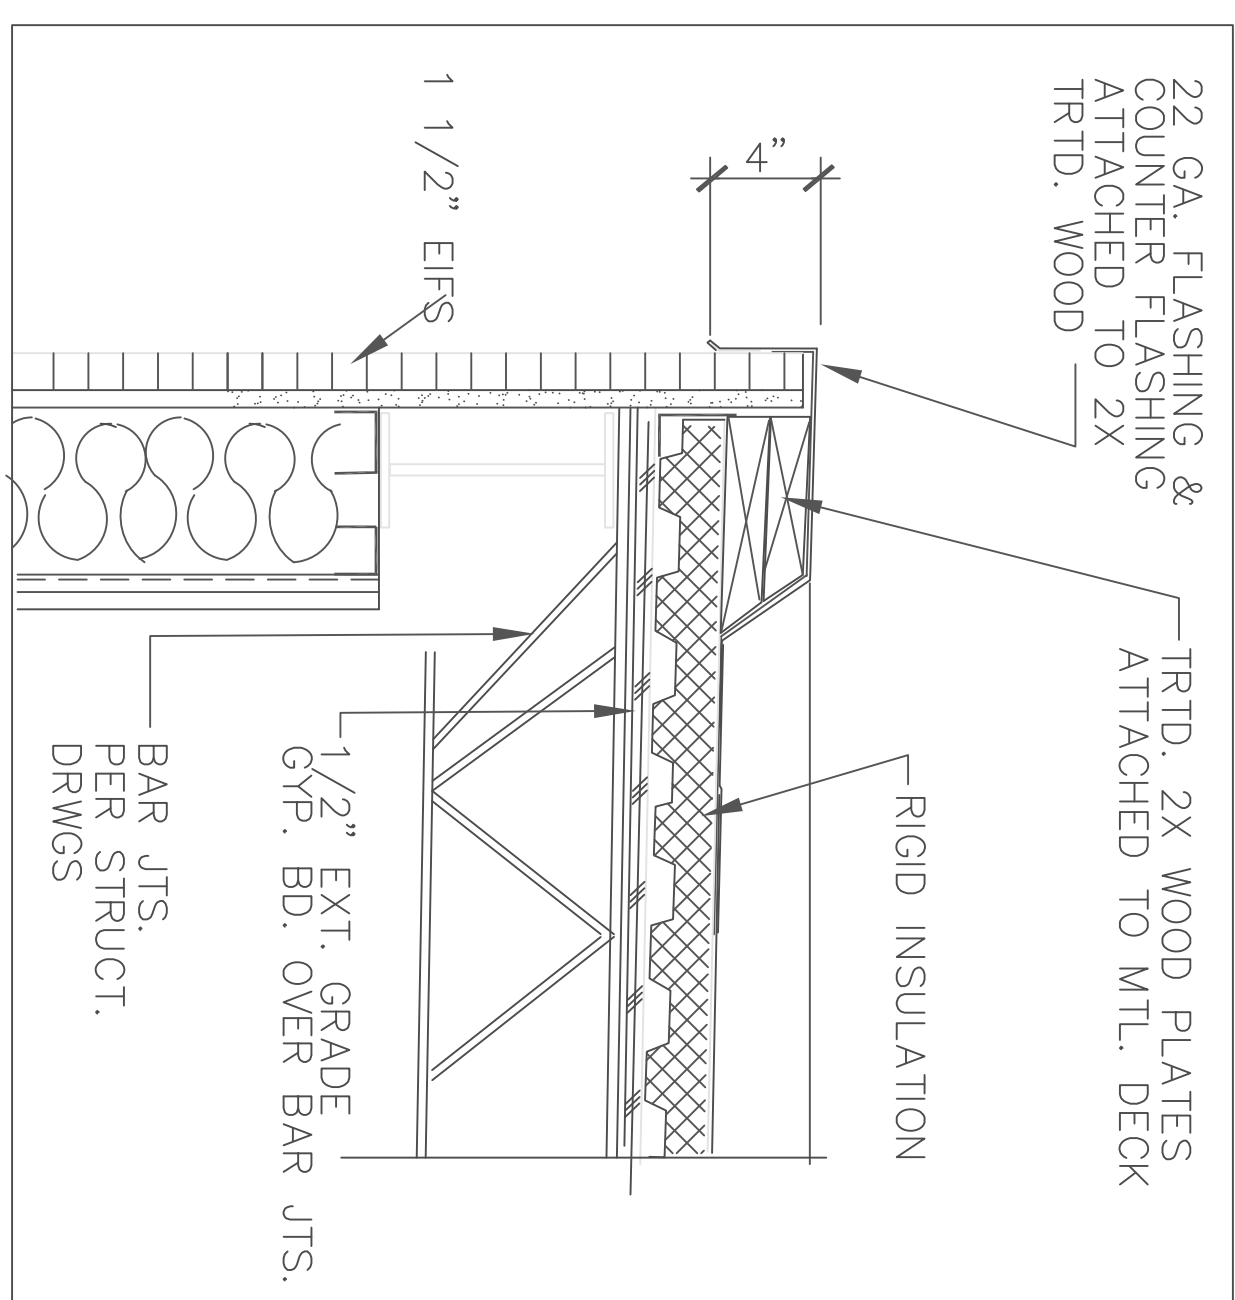


4 DETAIL

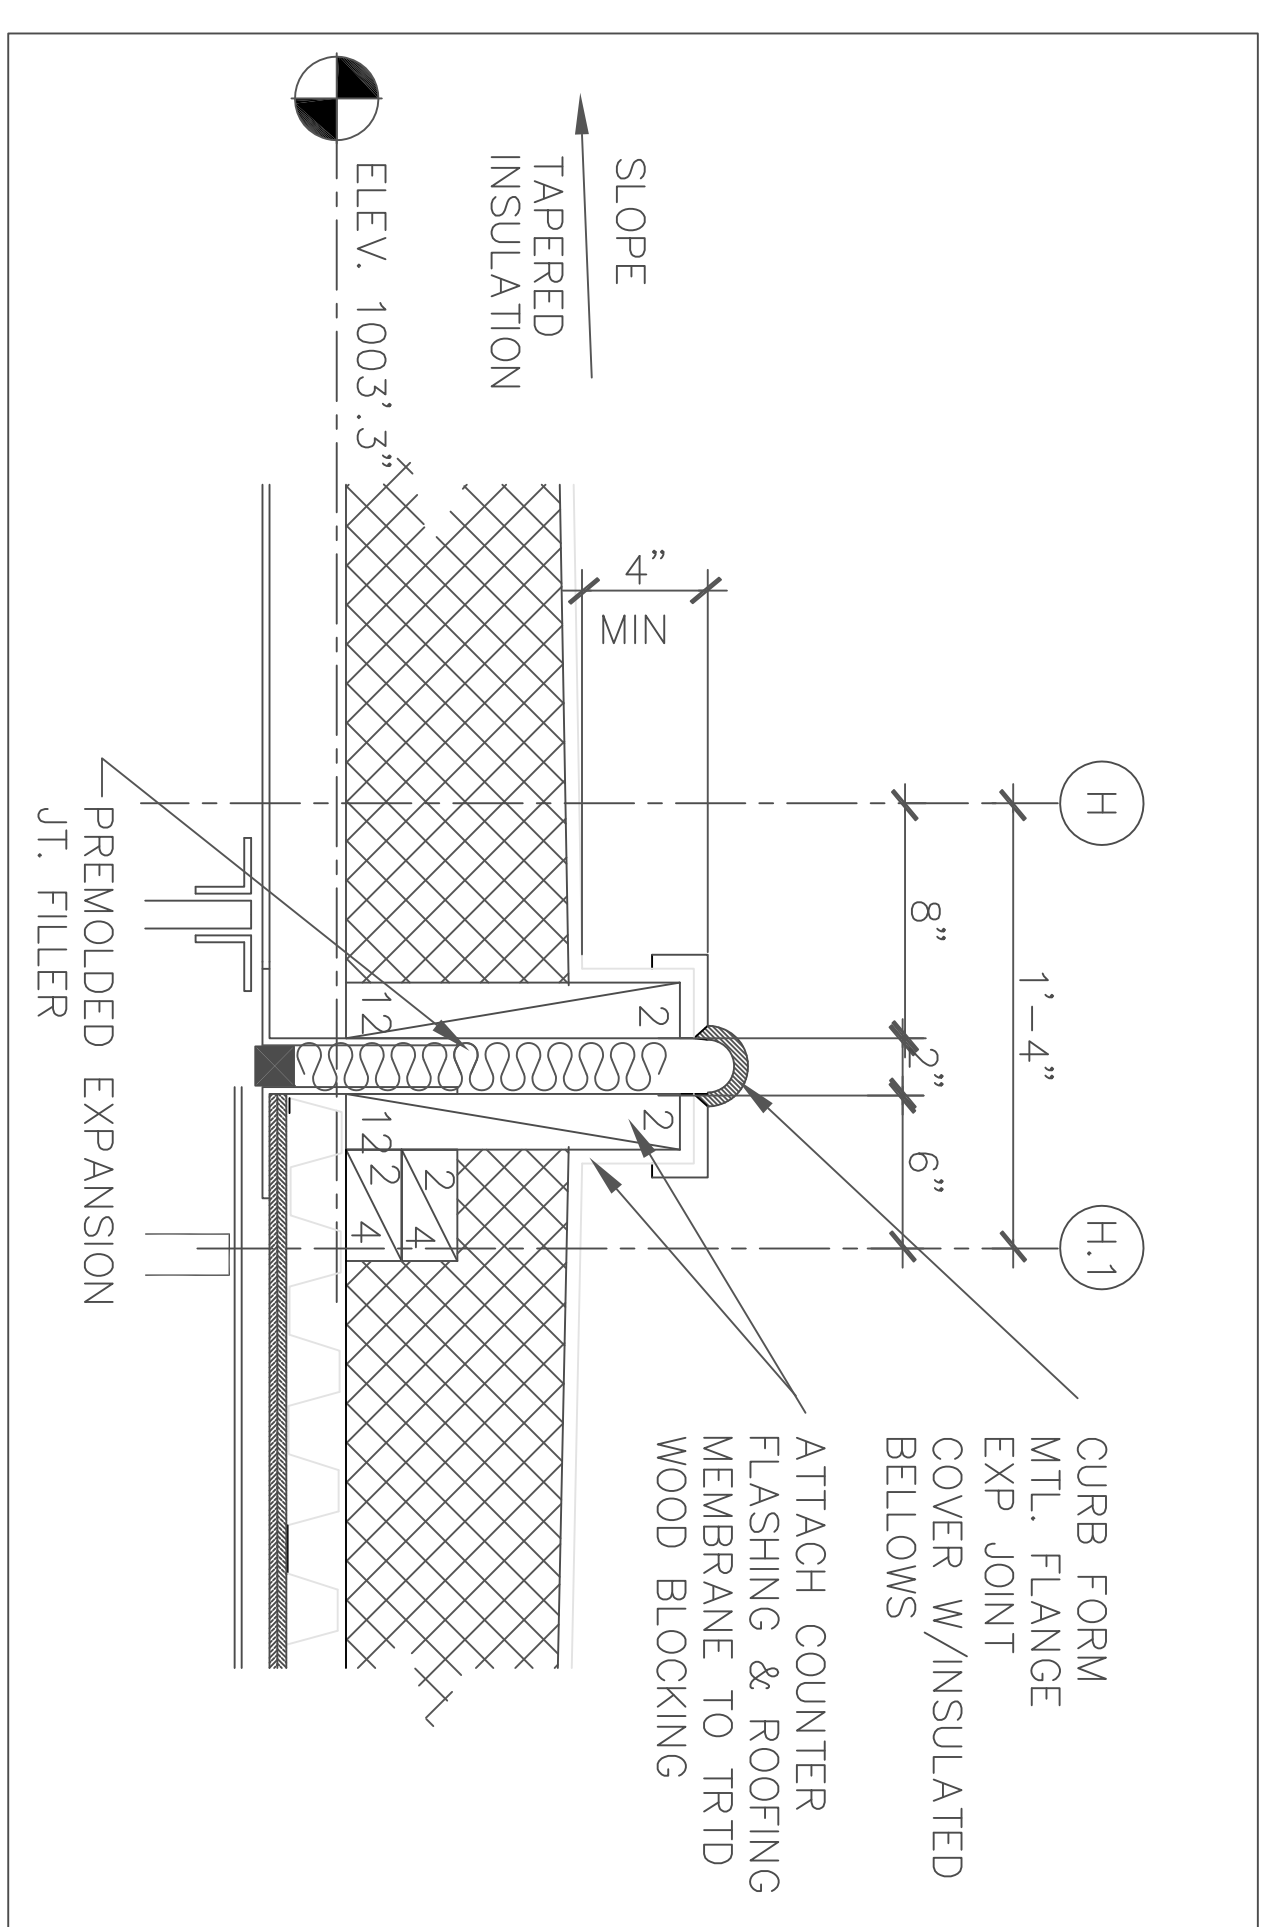


8 ROOF EXPANSION JOINT

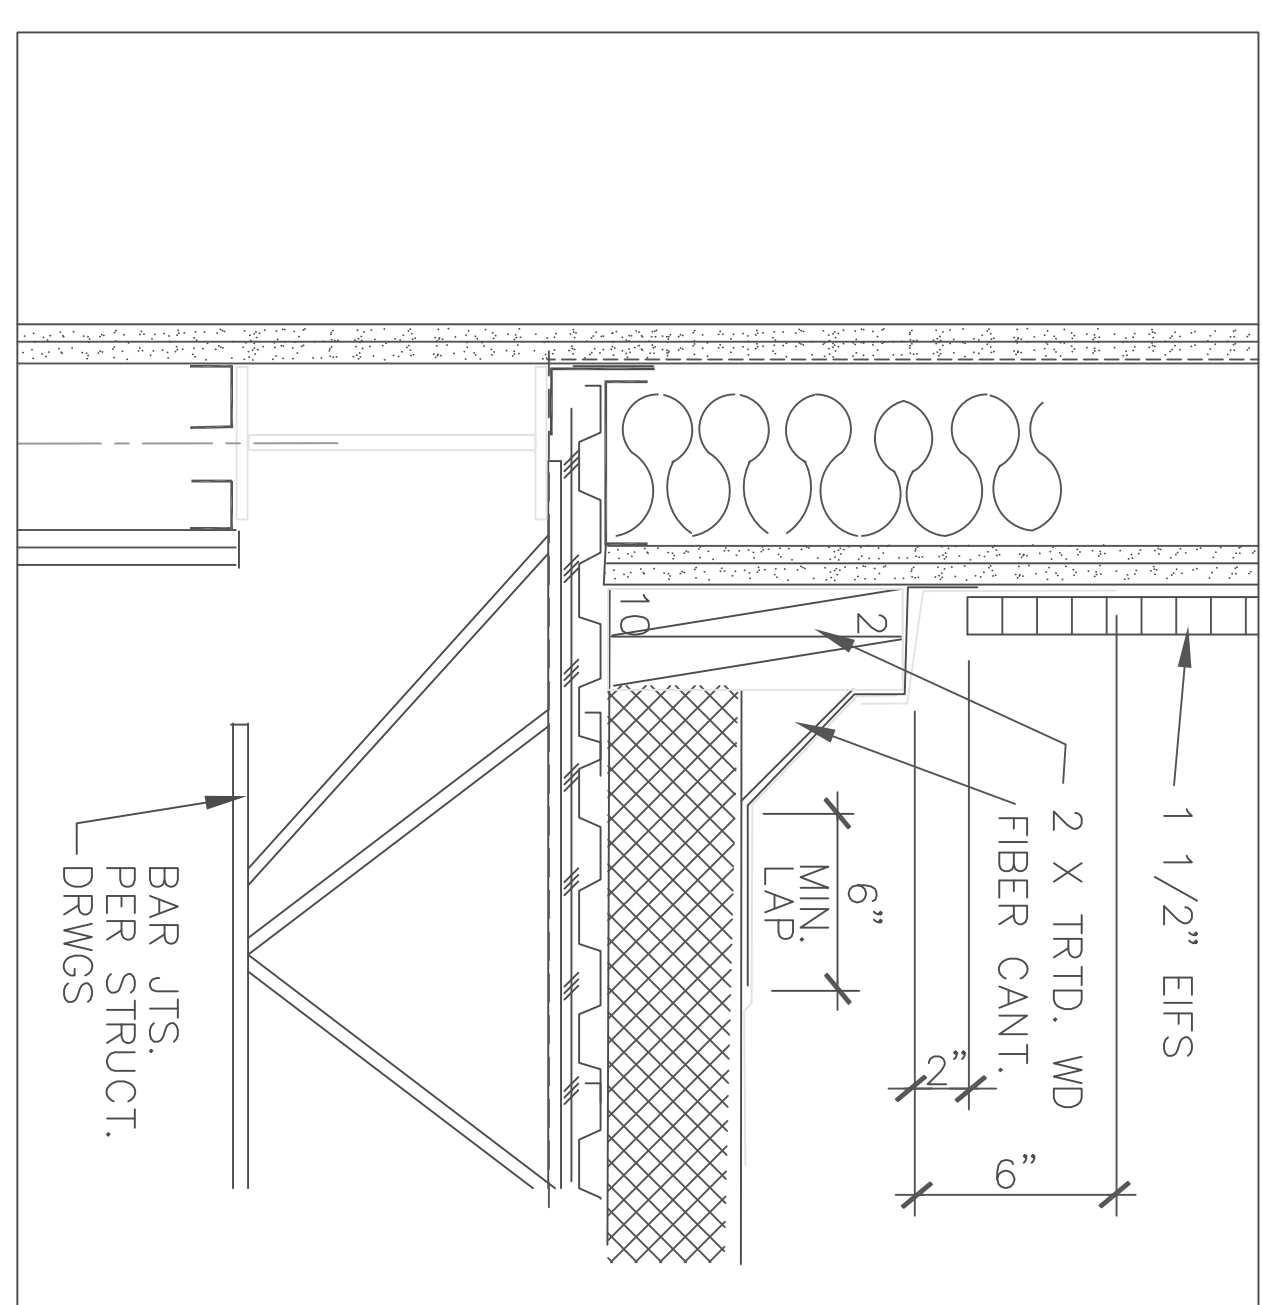


5 DETAIL

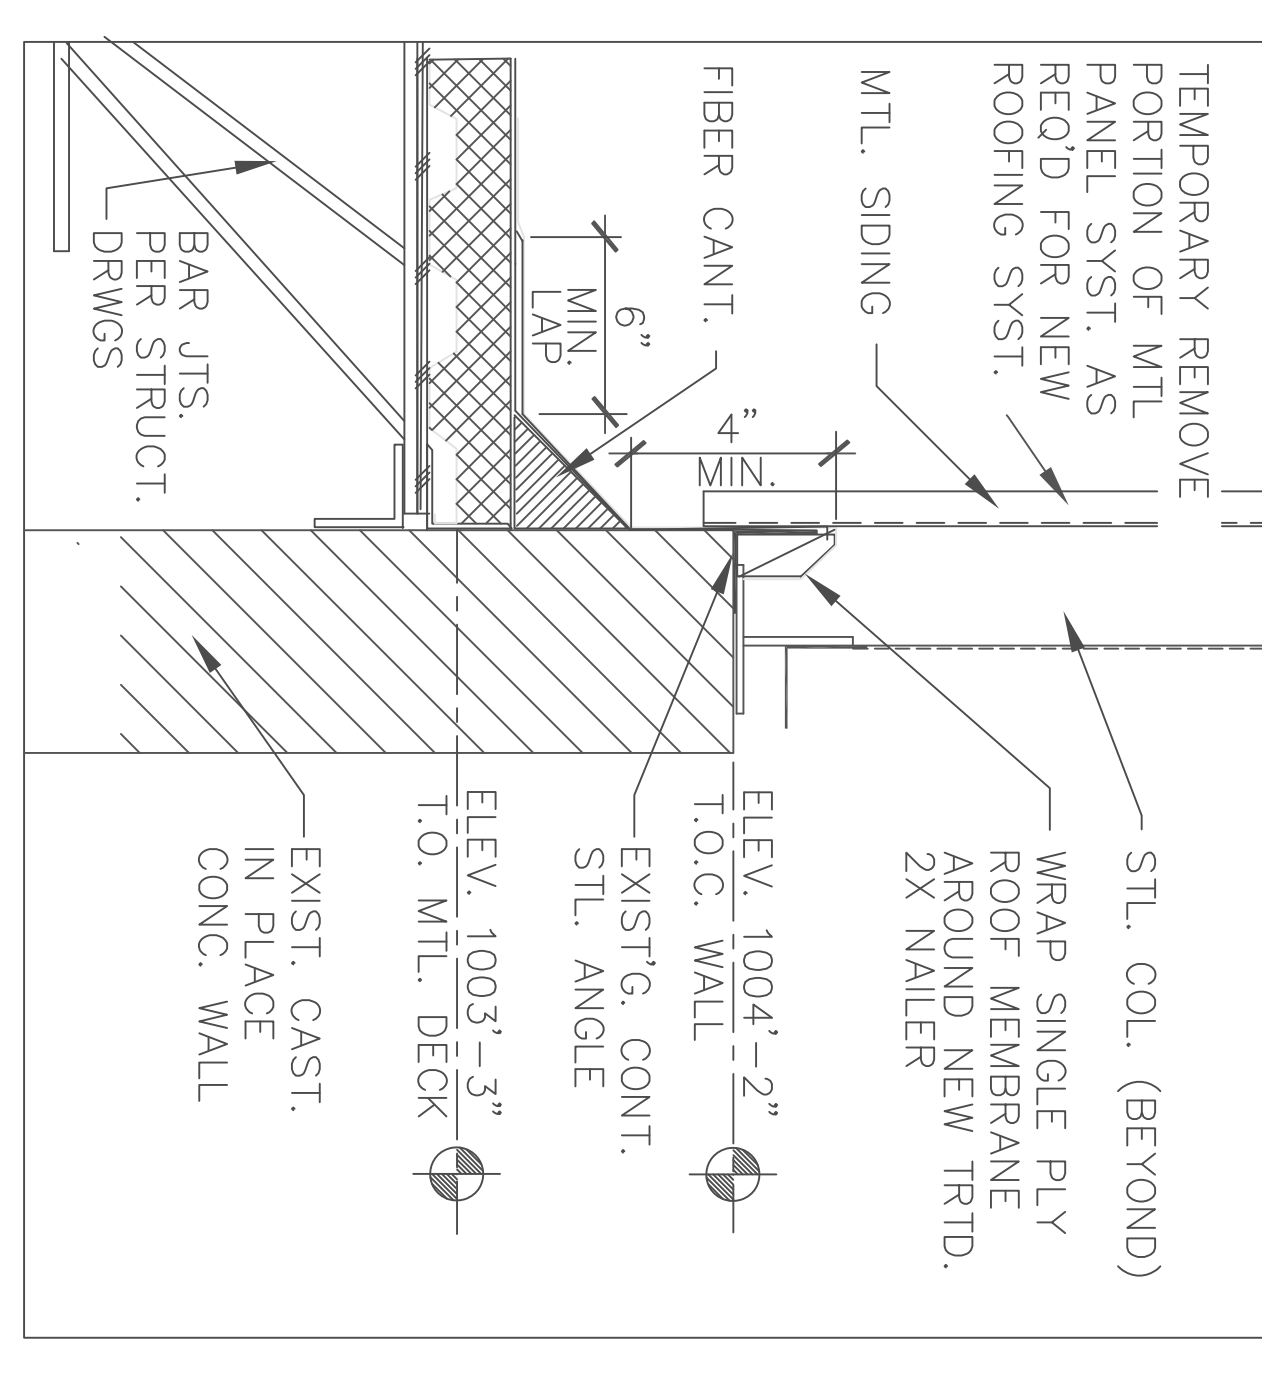


2 DETAIL

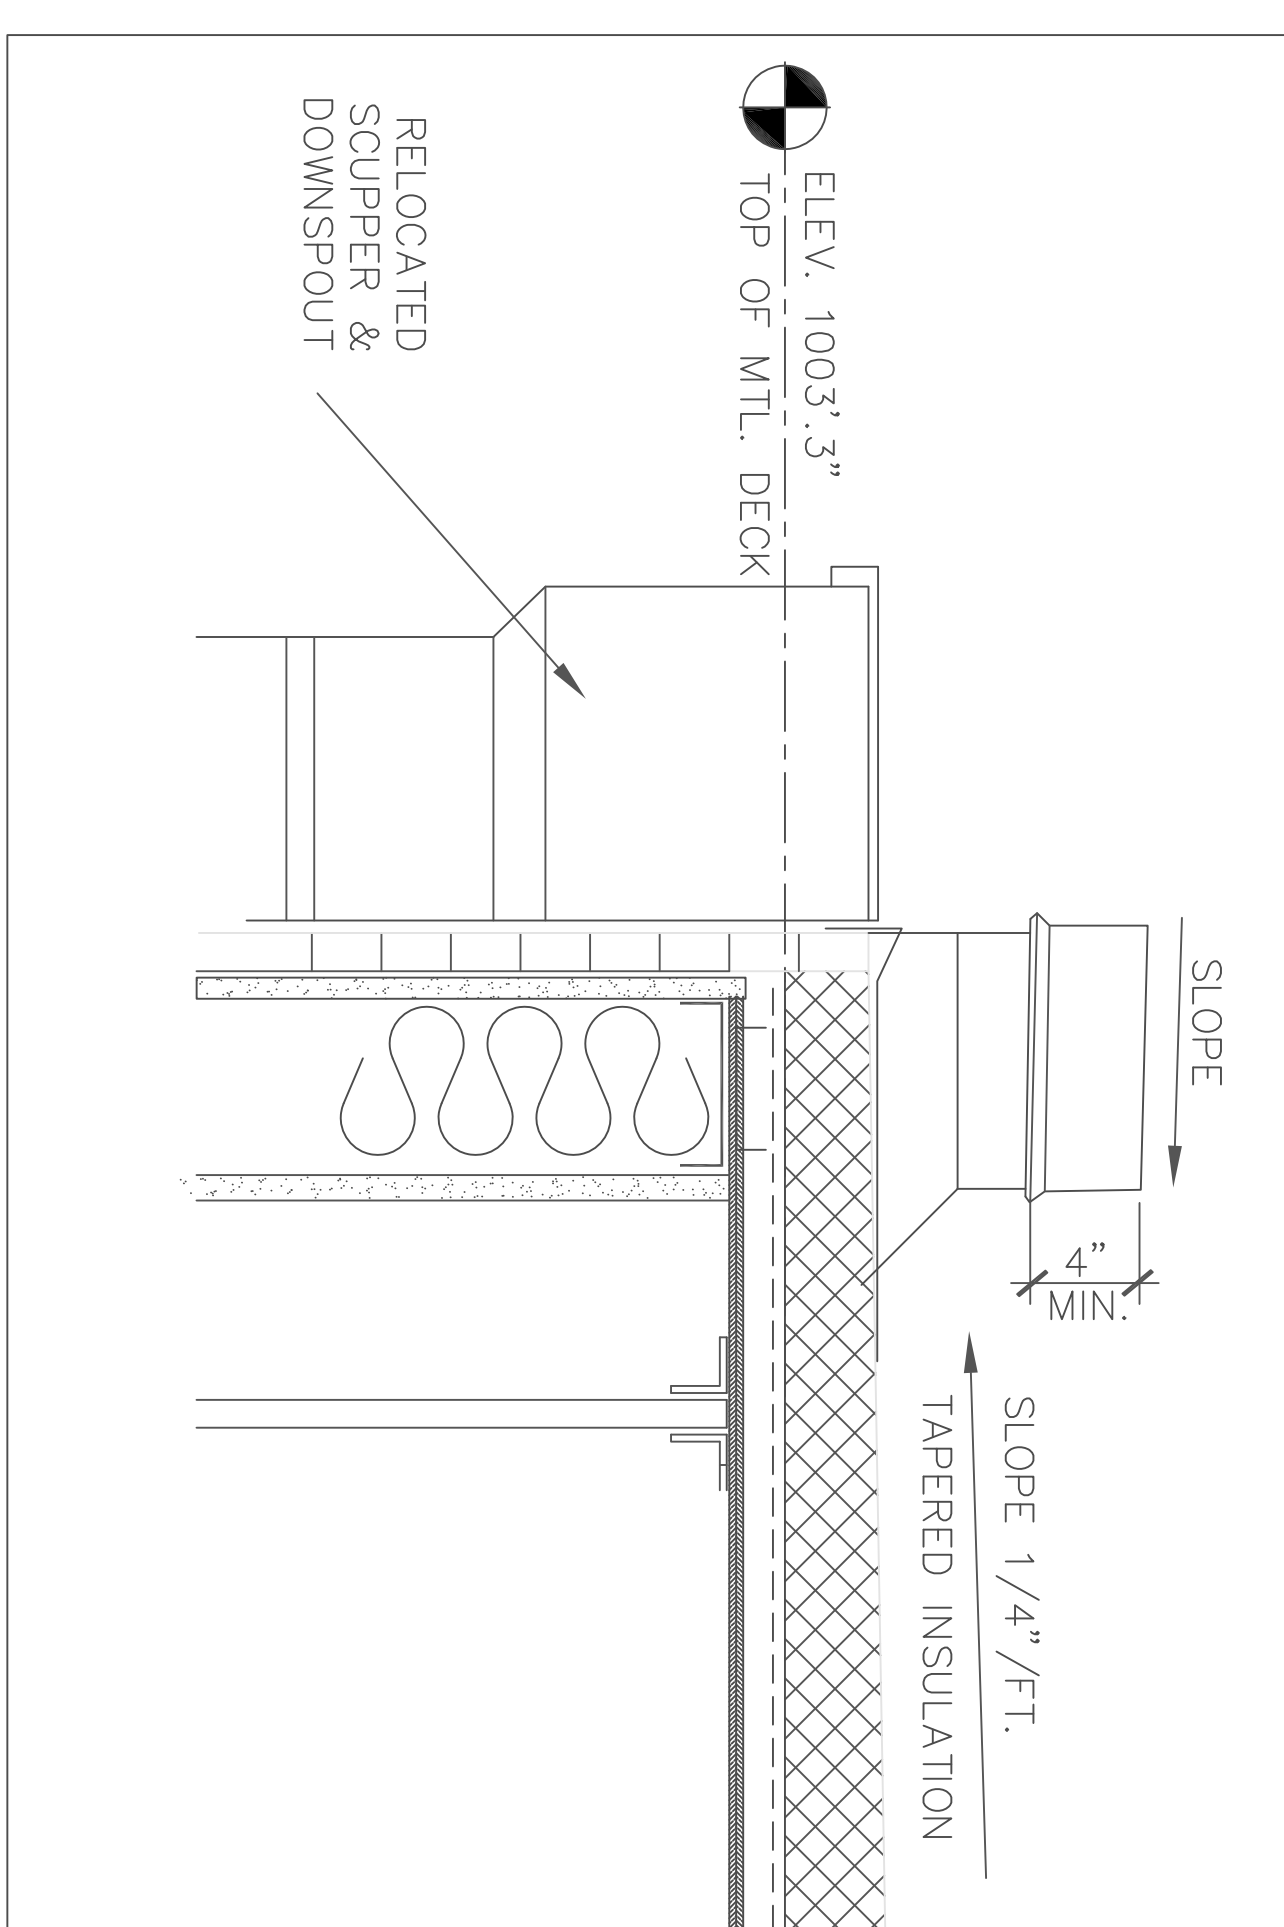

7 SECTION @ SCUPPER

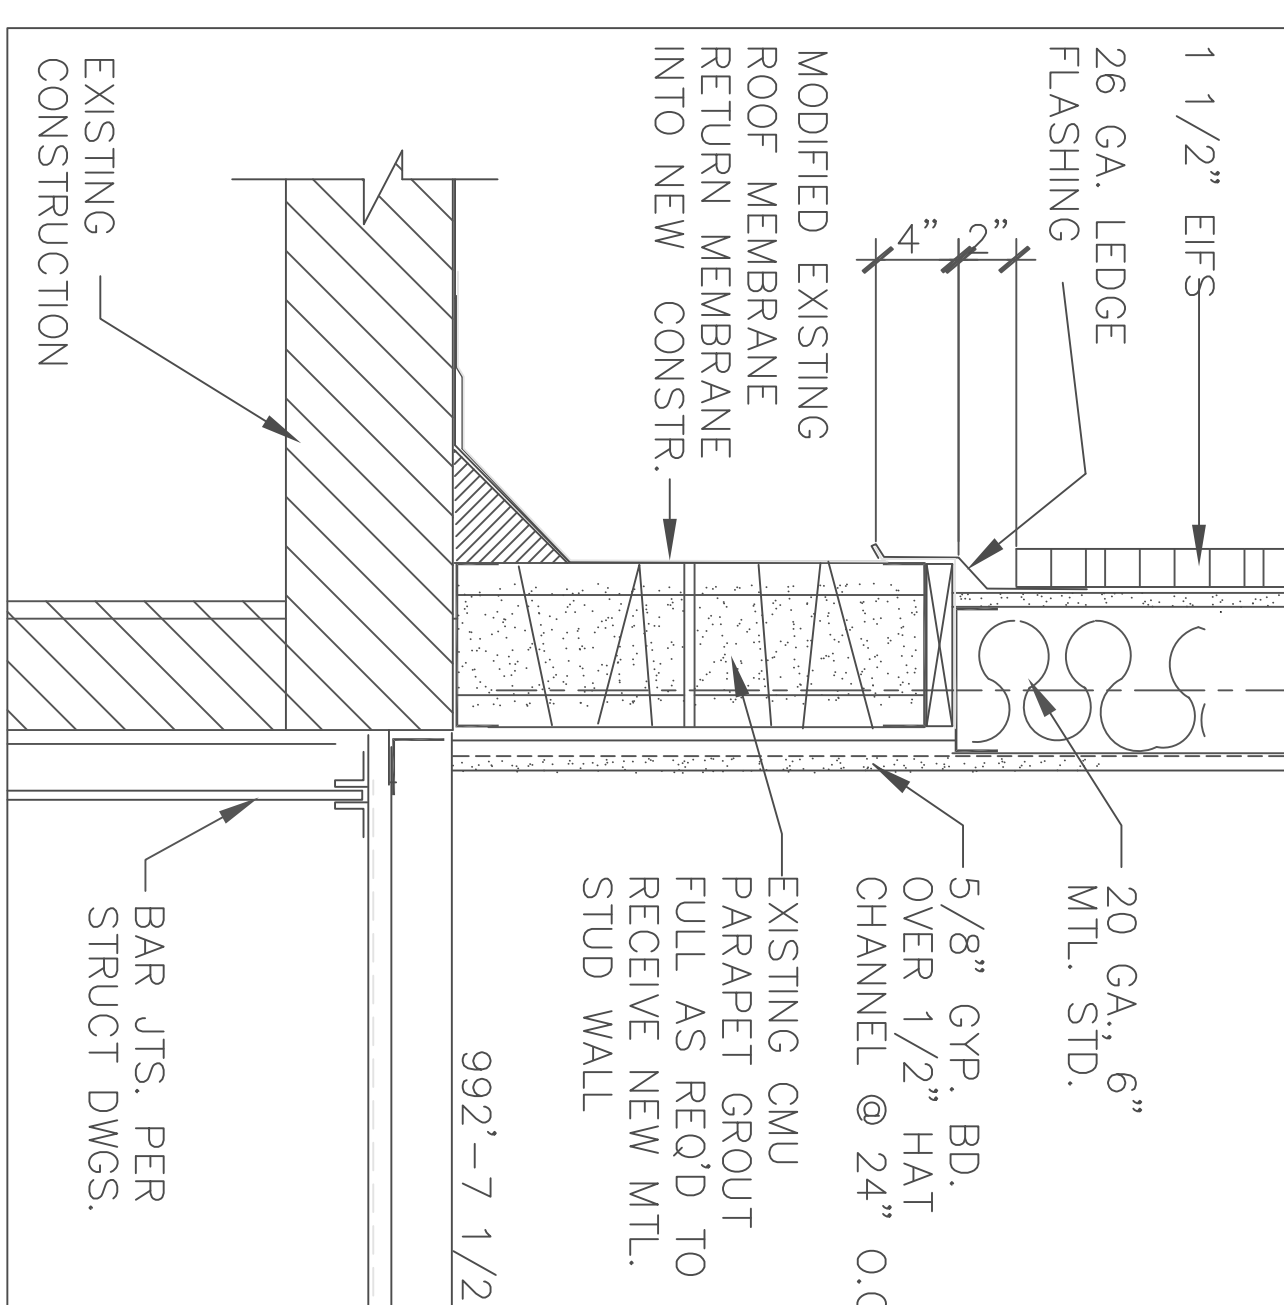


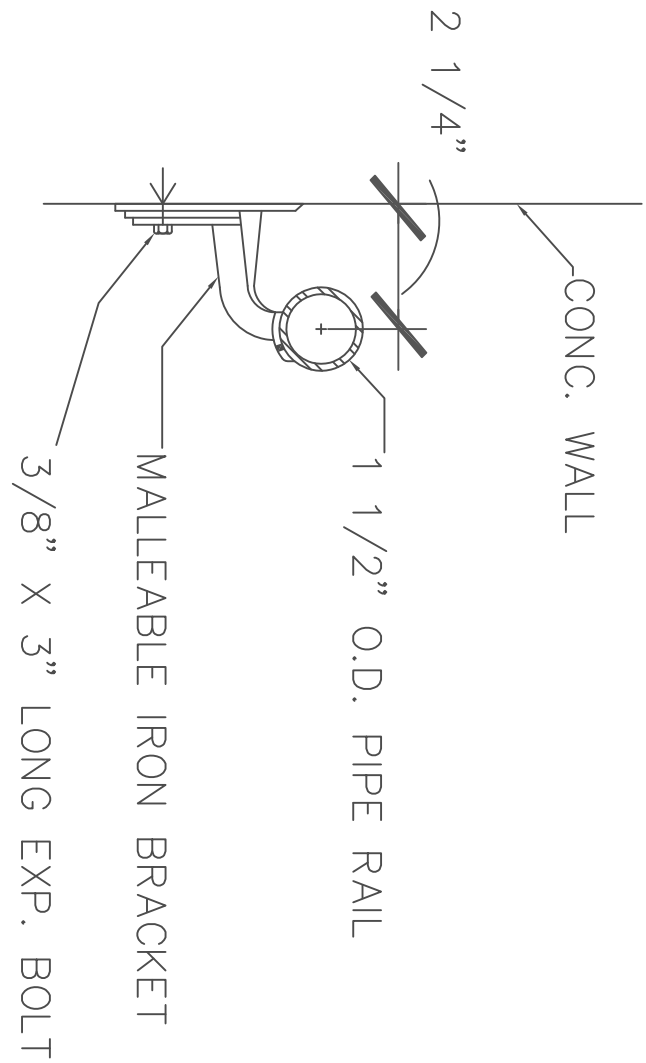
6 DETAIL

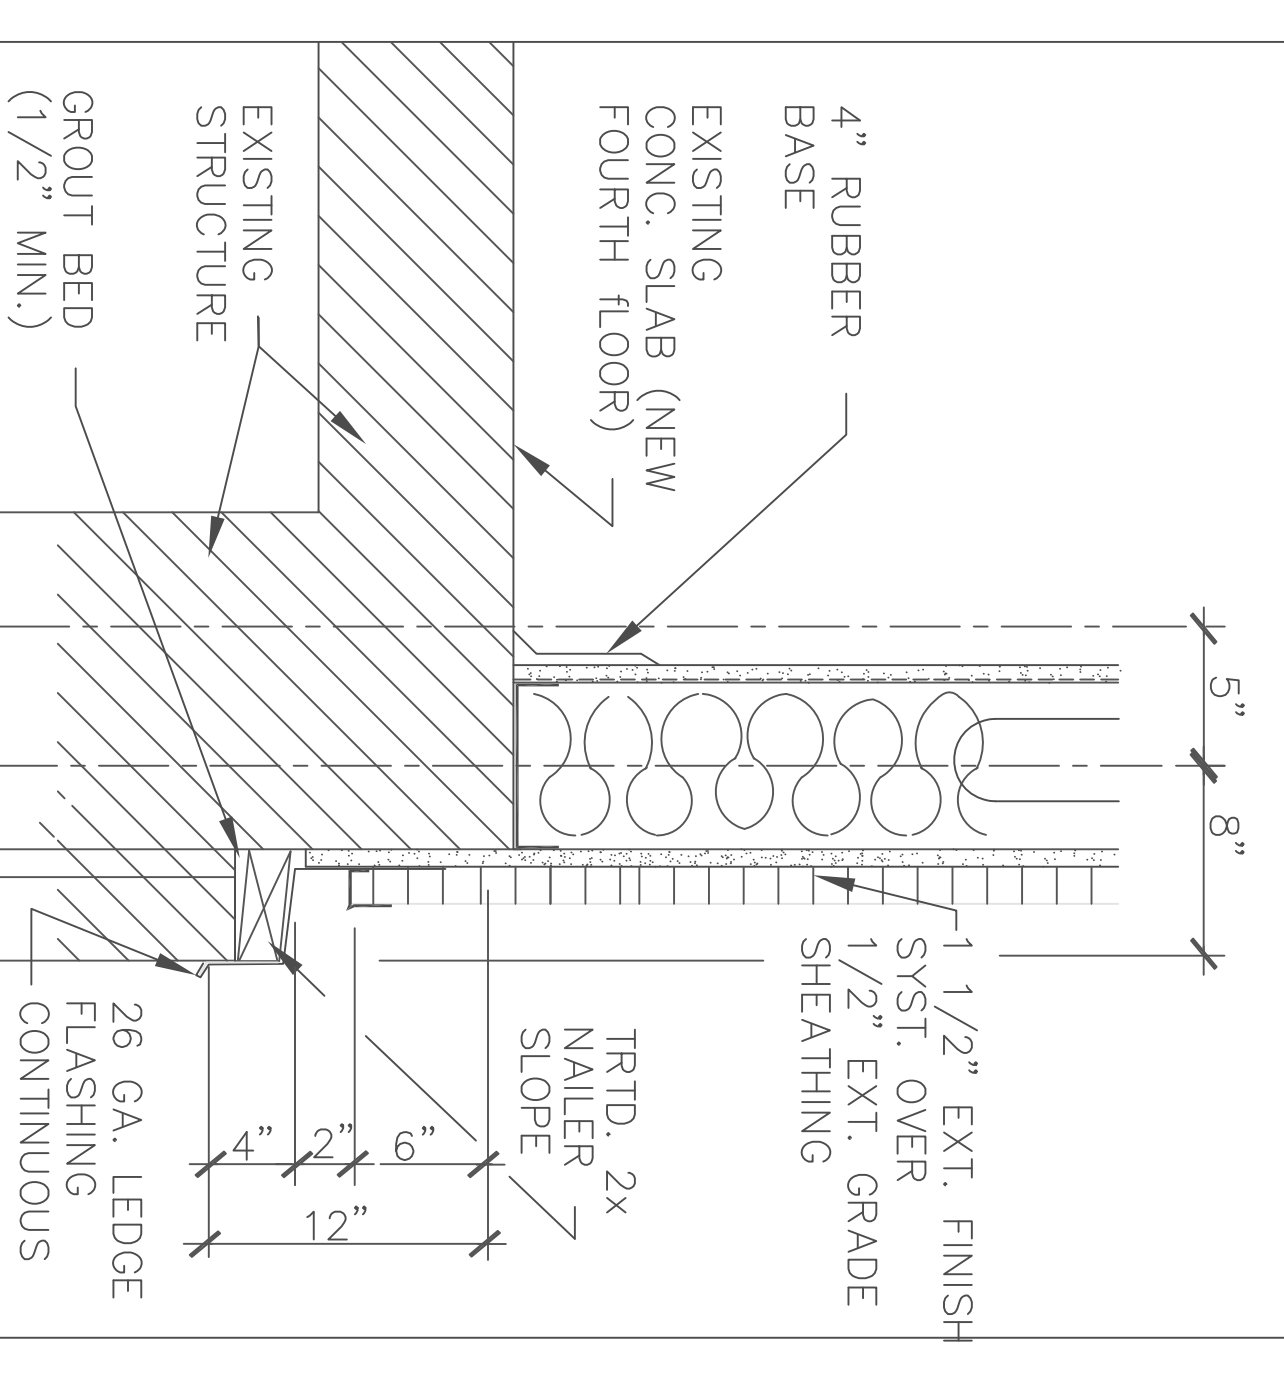


1 DETAILED

Drawing Title		Project Title		Date	
DETAILS		V.A. ELEVATOR REPLACEMENT		12-31-97	
Approved: Division Chief		Drawn		Project No.	
Approved: Service Director		Checked		76-106	
		Building No.		DRAWING NO.	
		BLDG. 1 & BLDG. 26		A9	
		Location		Dwg. Of	
		4801 LINWOOD BLVD. MC. MO. 64128			



 Department of
Veterans Affairs




8 DETAIL
3" = 1'-0"

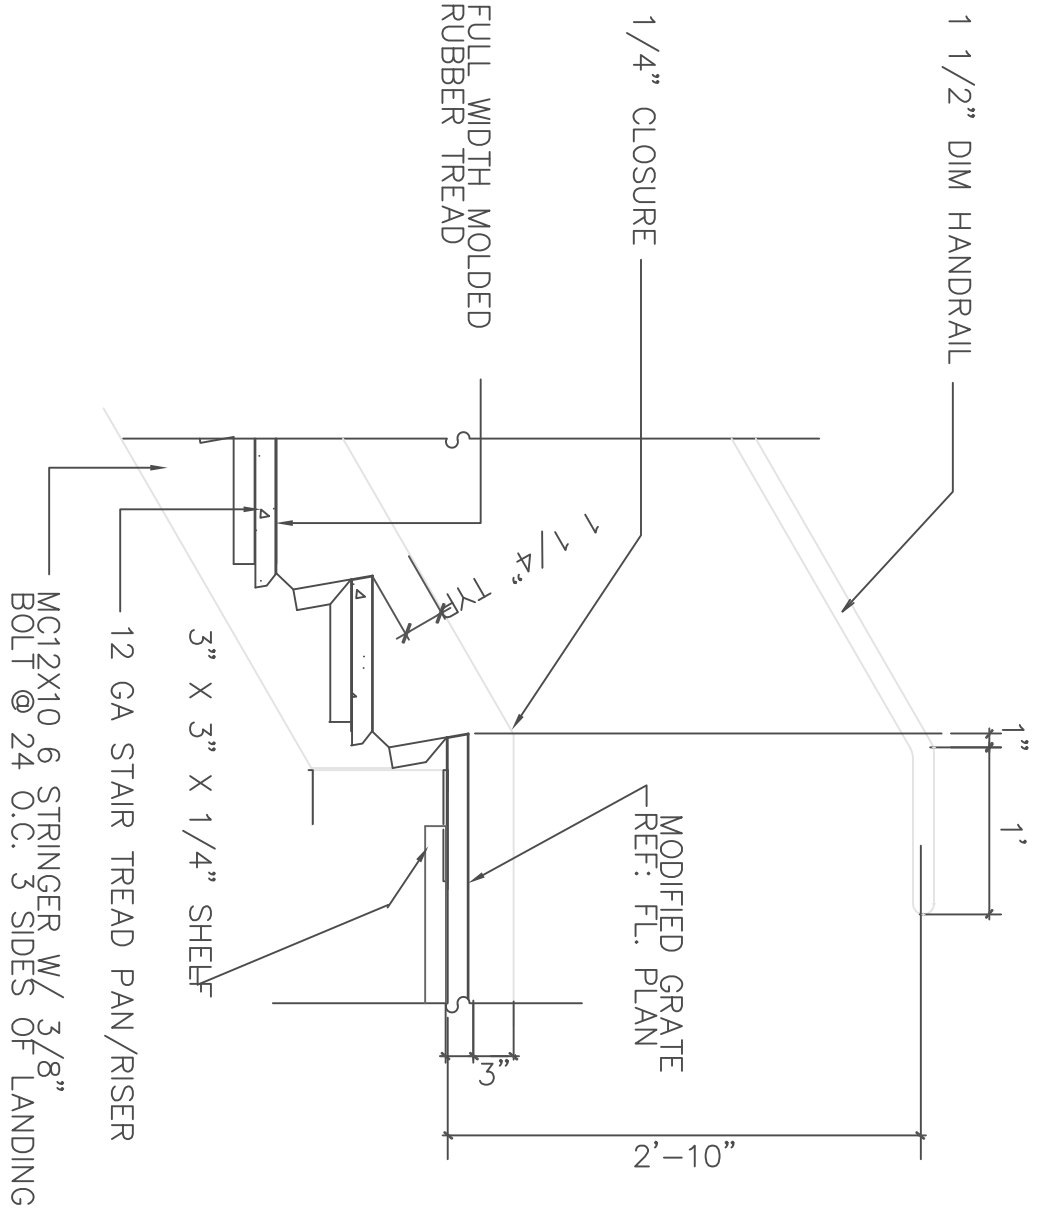


5 DETAIL
3/4" = 1'-0"

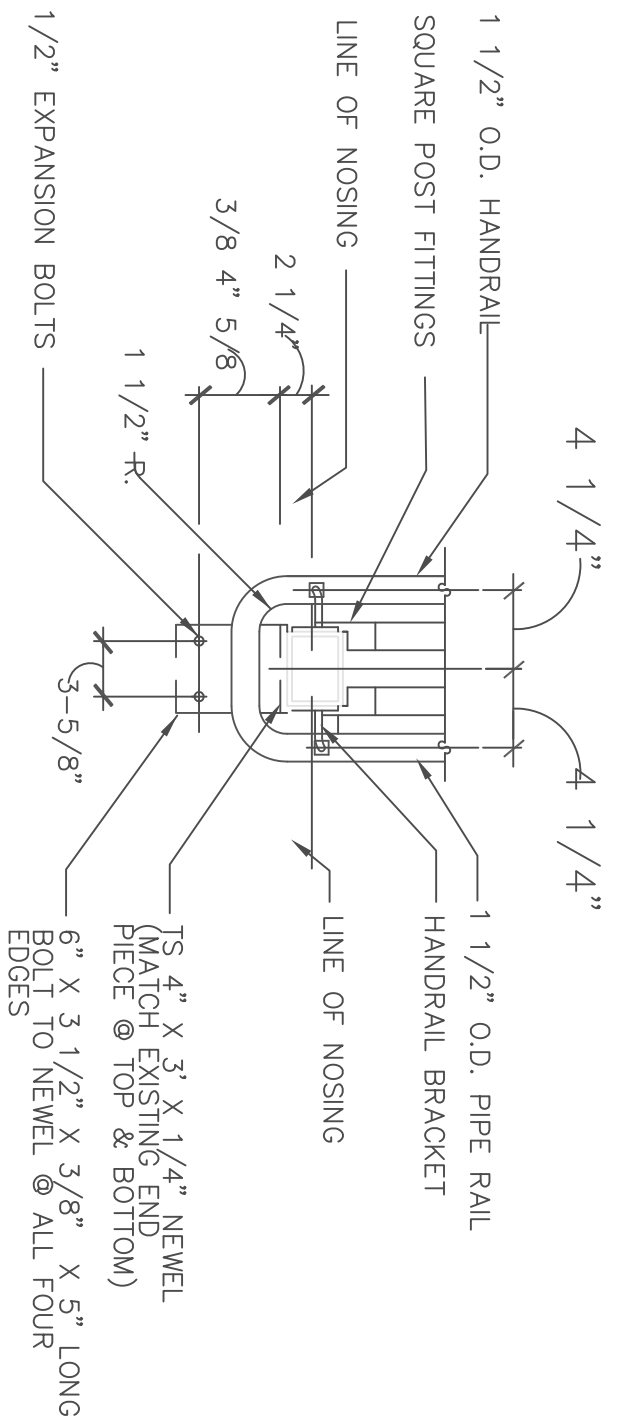


7 PLAN @ NEWEL
1" = 1'-0"

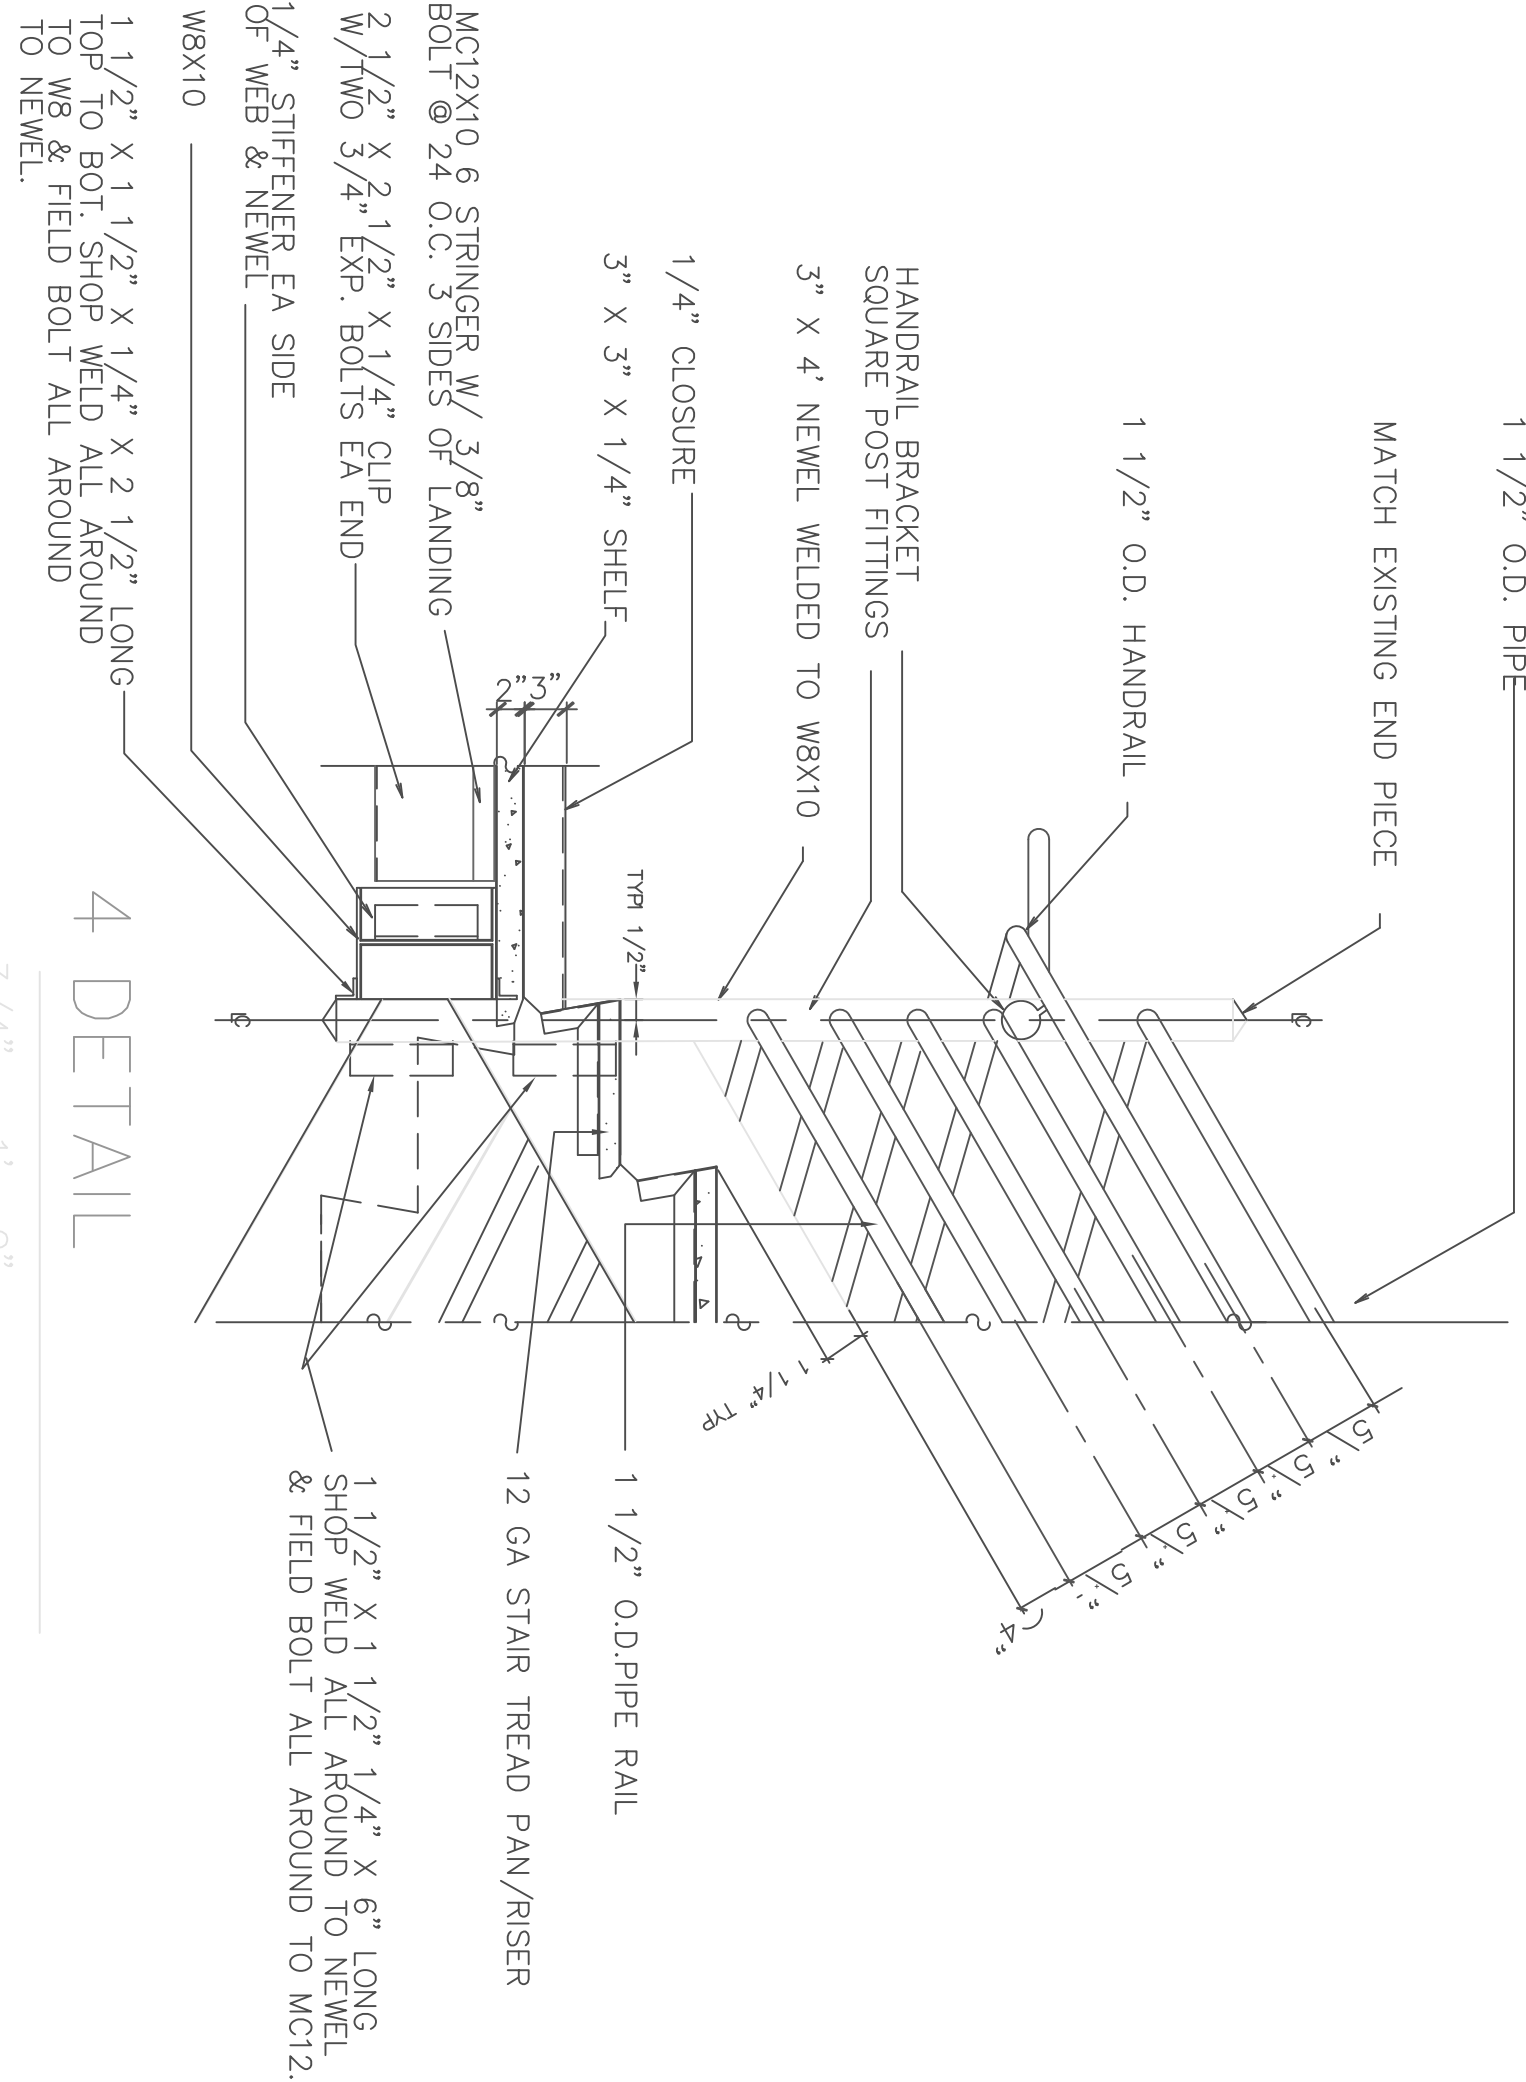


4 DETAIL
3/4" = 1'-0"

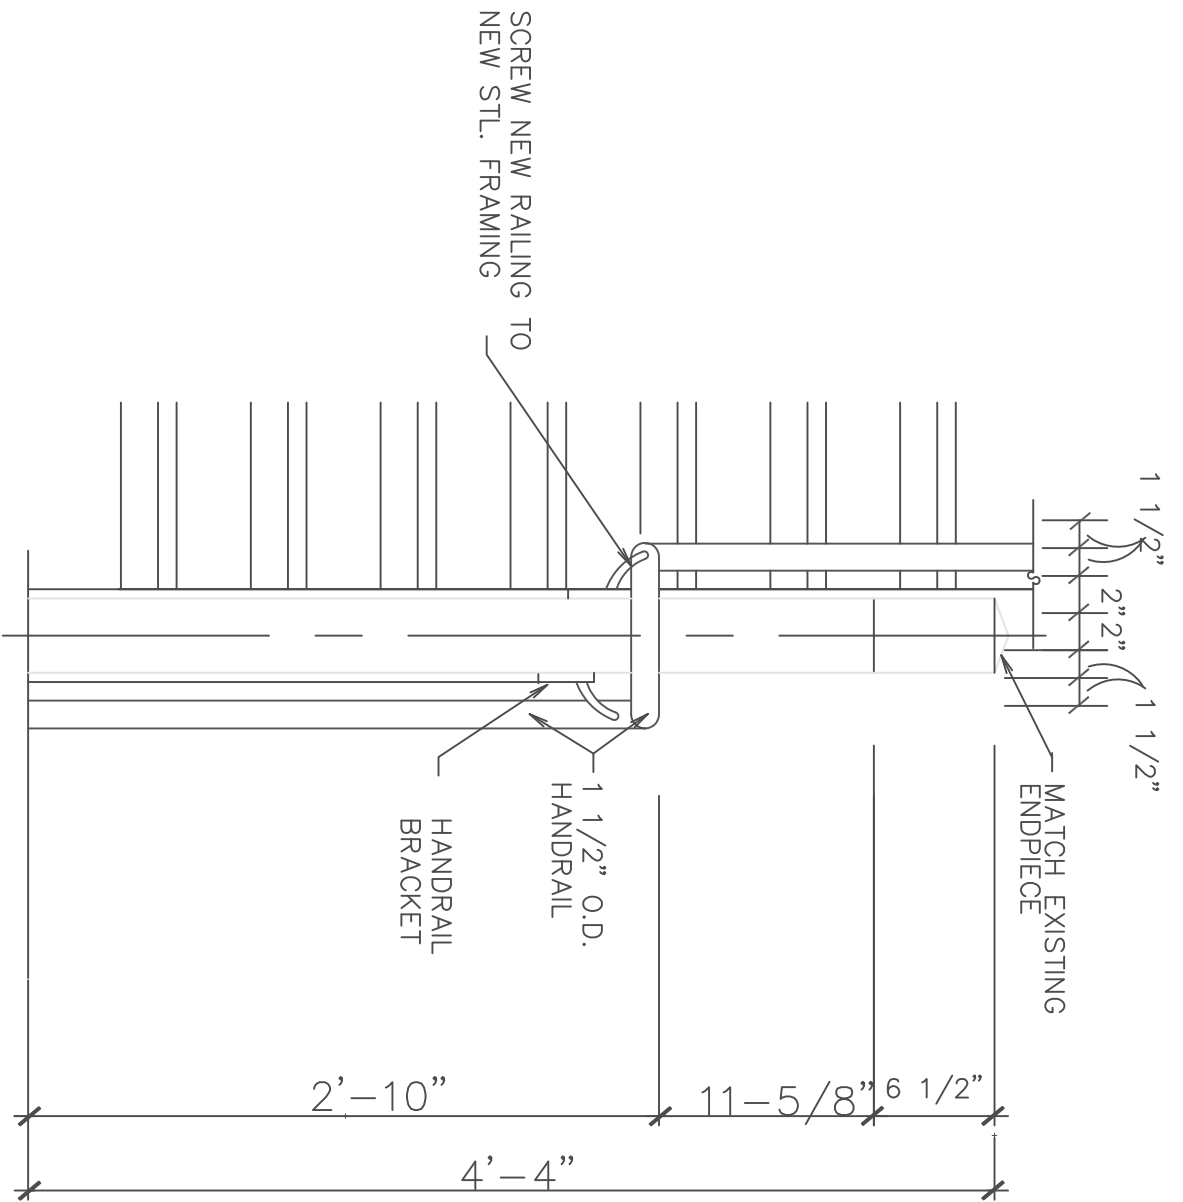


6 PART. ELEV.
1" = 1'-0"

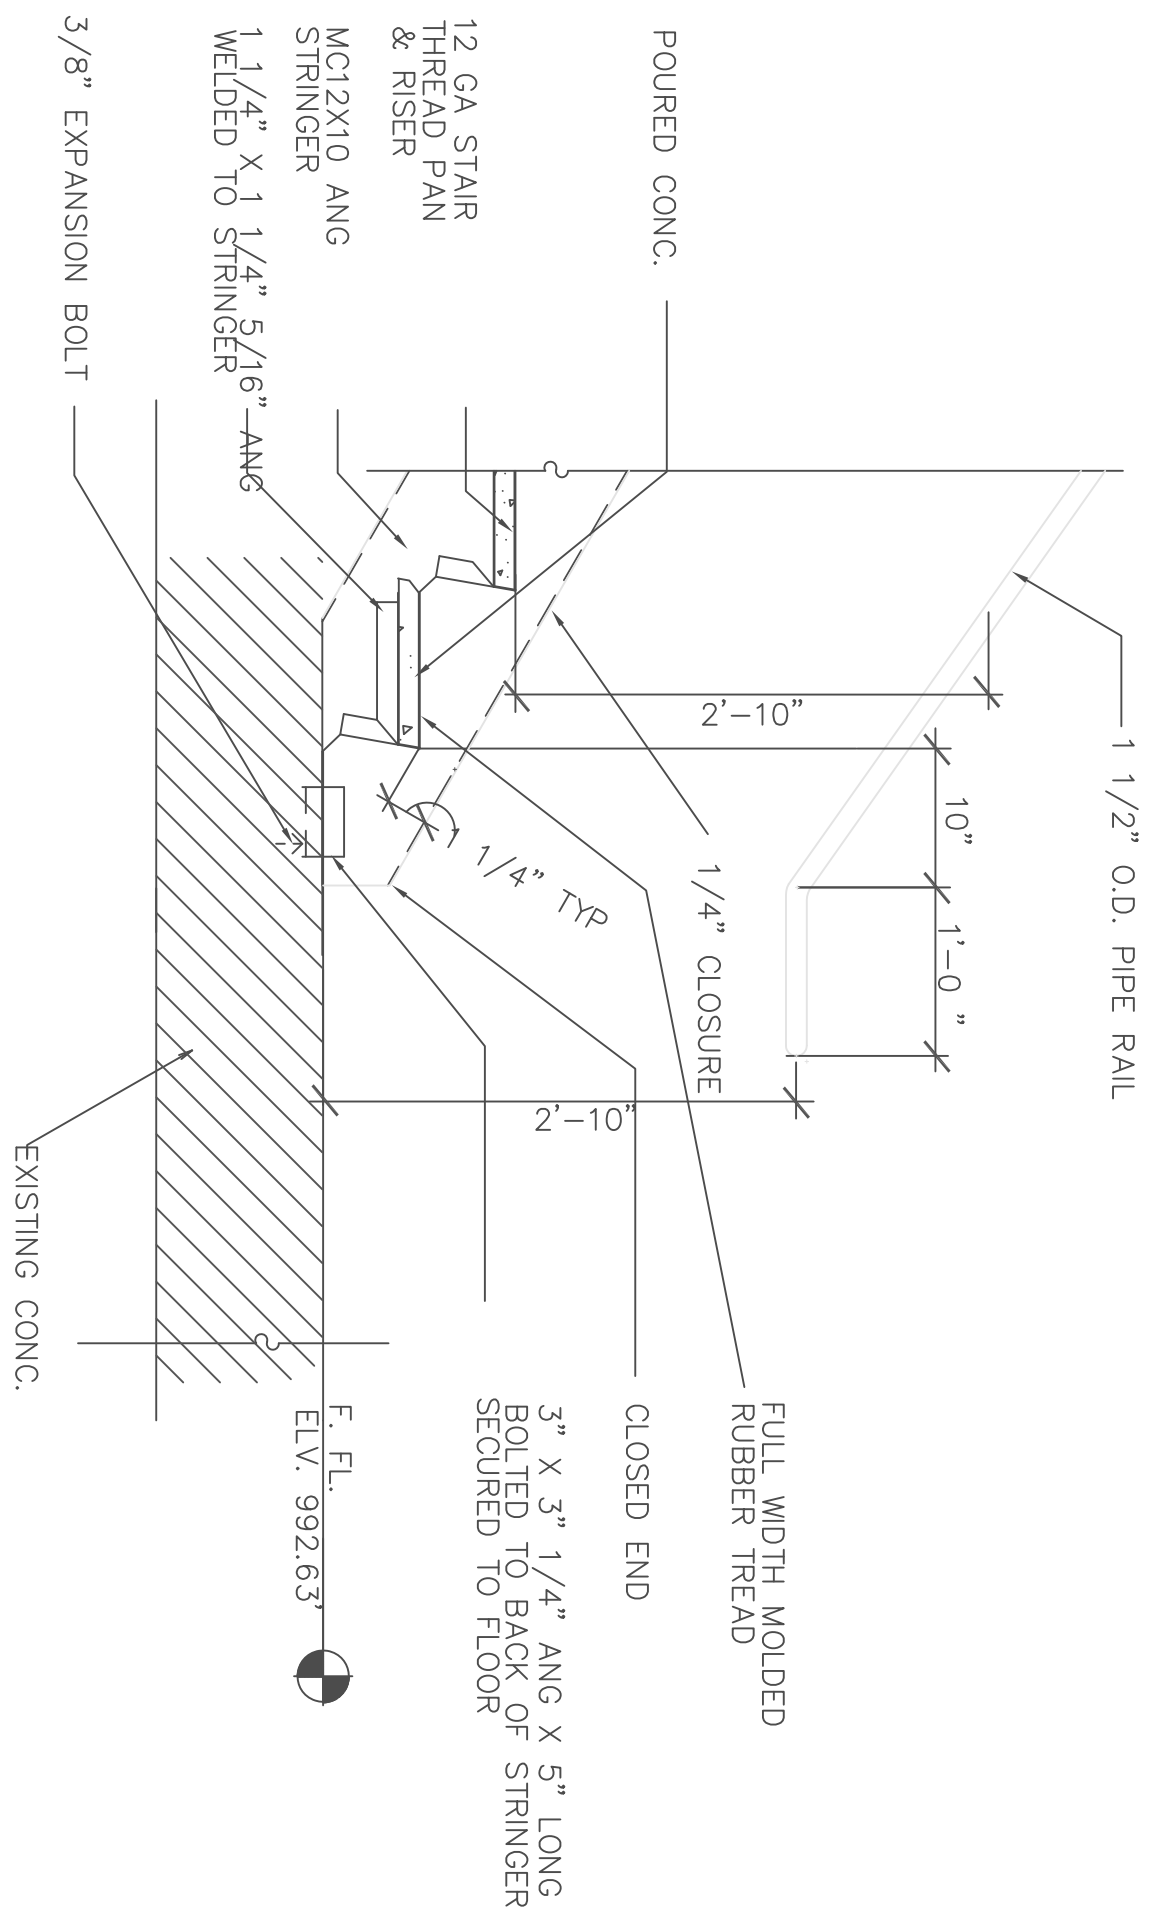

3 DETAIL
3/4" = 1'-0"

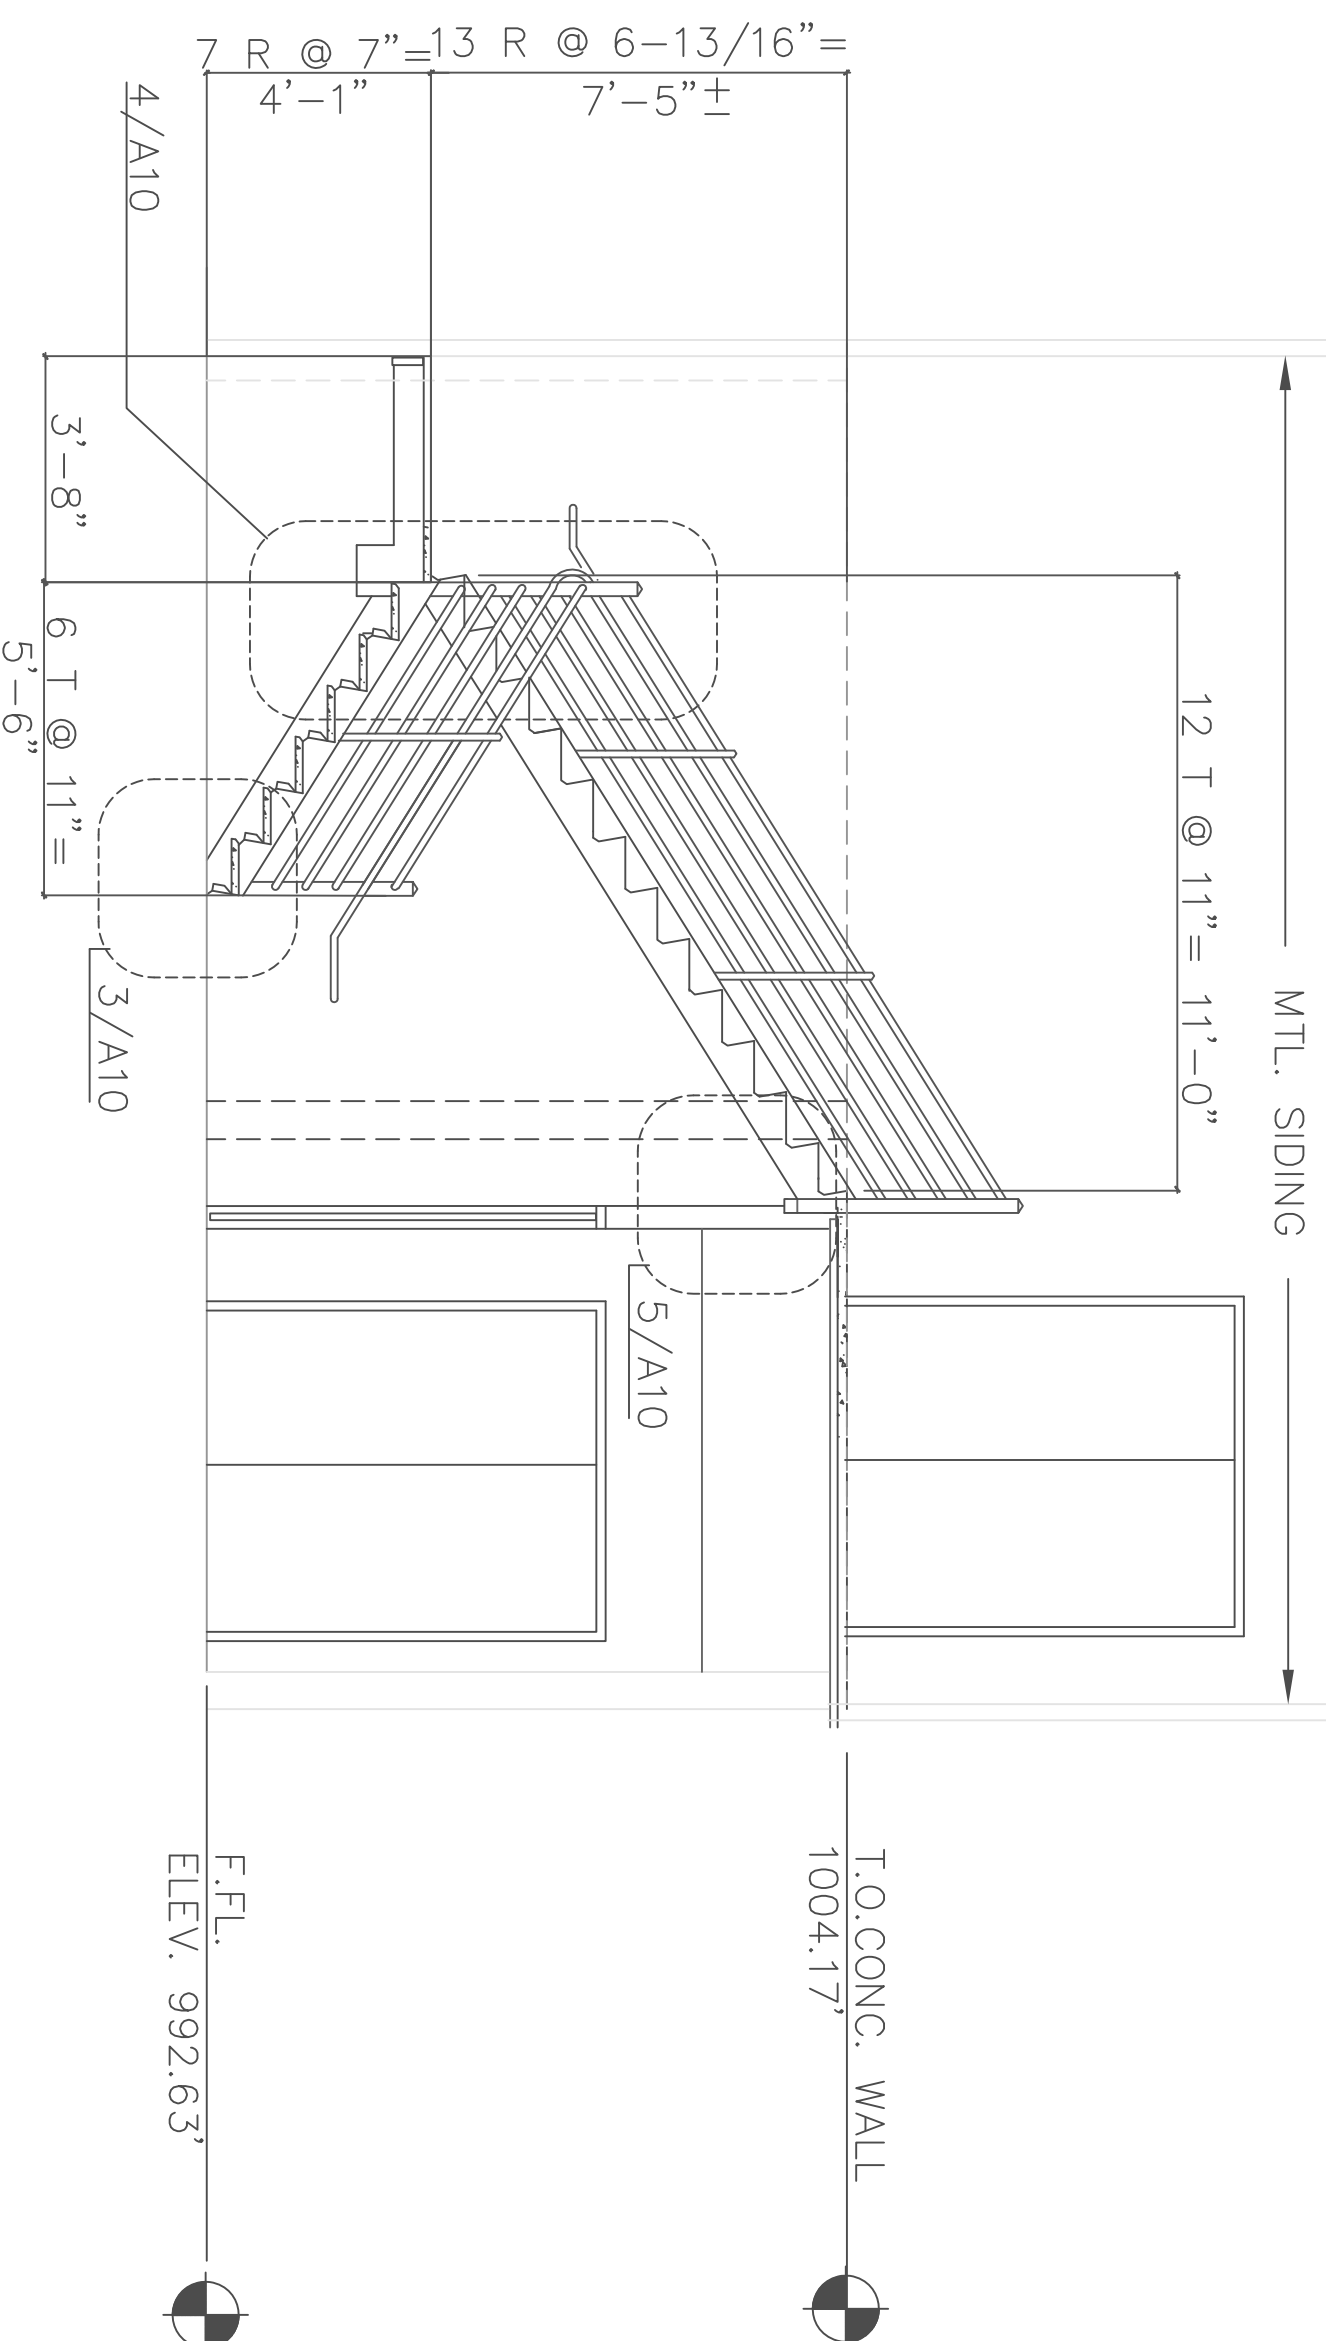

2 STAIR-SECTION
1/4" = 1'-0"

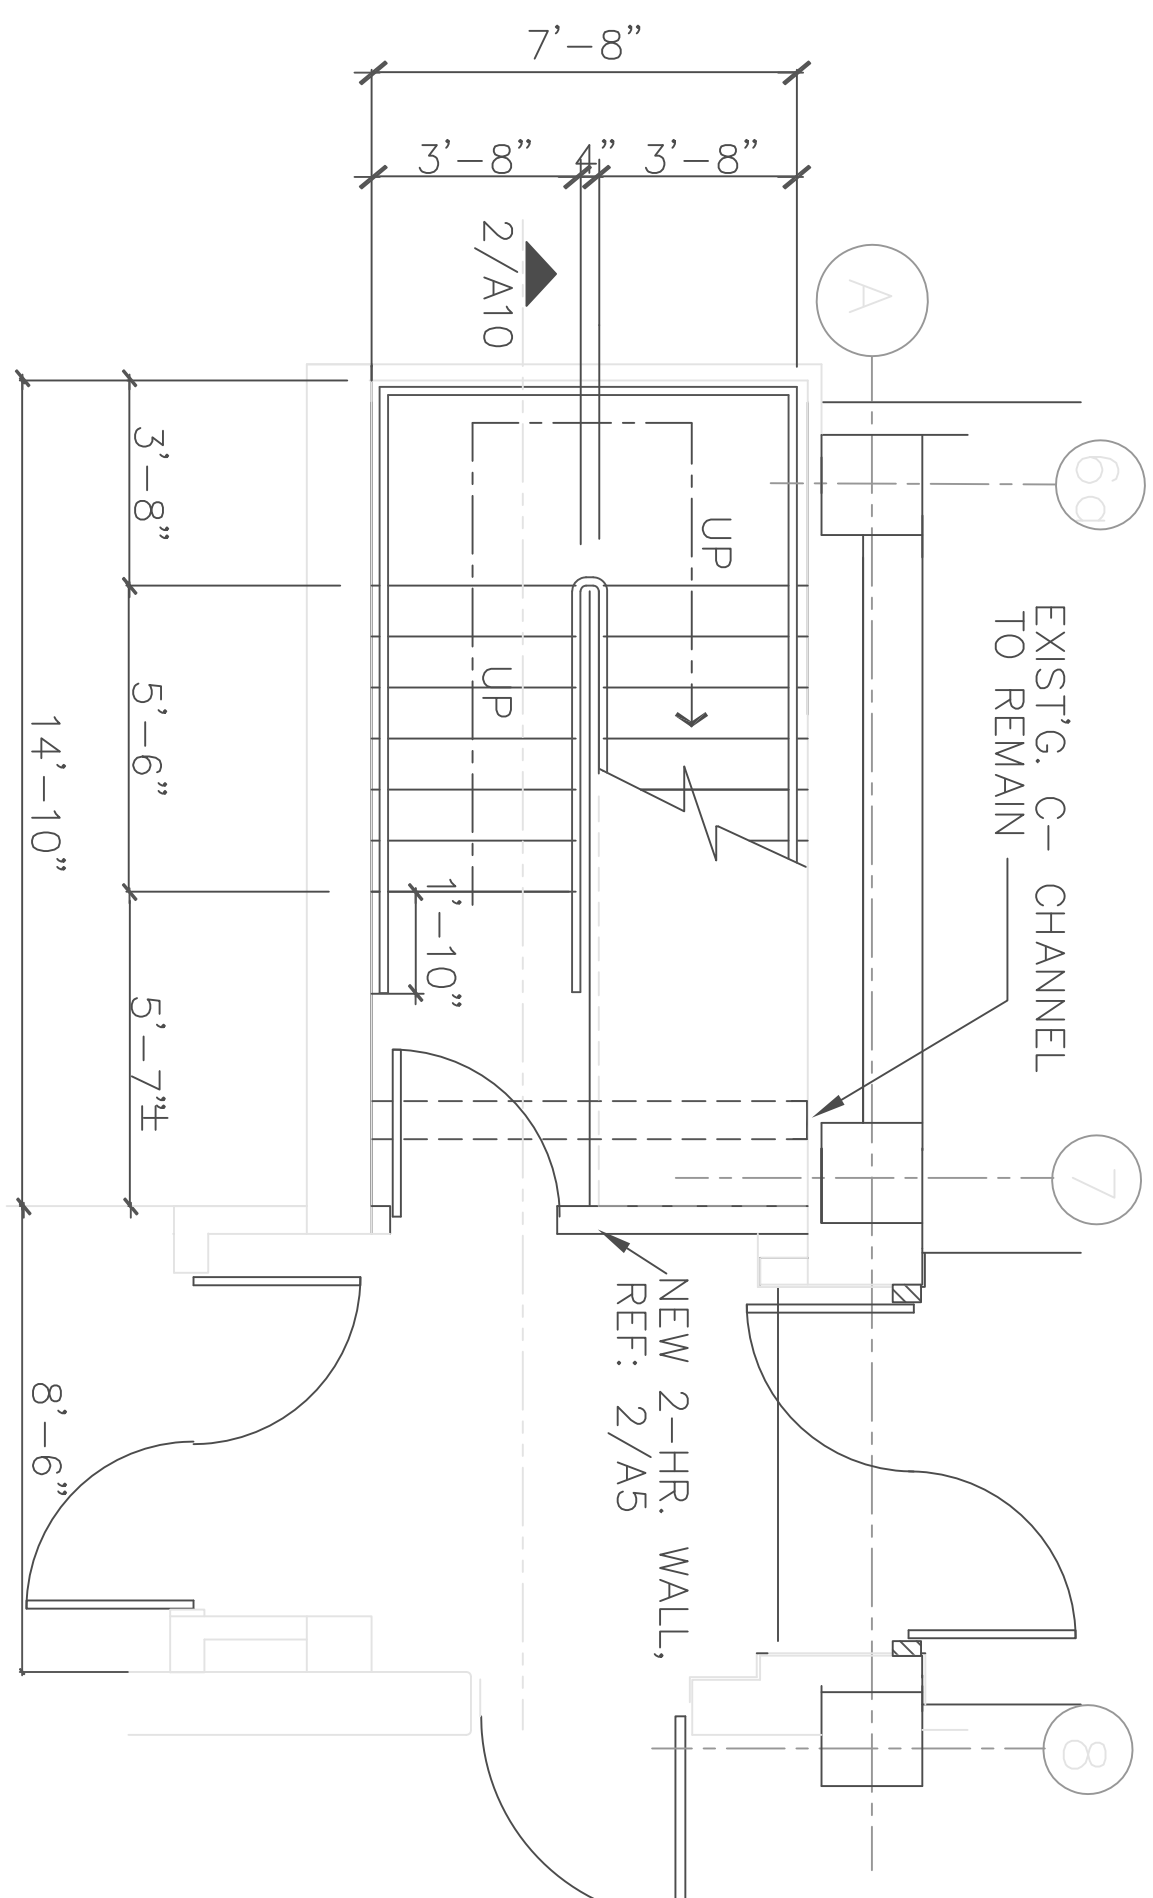

1 STAIR PLAN
1/4" = 1'-0"

REVISIONS		DATE	
<div>Project Title: STAIR PLAN, SECTIONS, DETAILS</div> <div>Project No: 76-106</div> <div>Building No: BLDG. 1 & BLDG. 26</div> <div>Location: 4801 LINKWOOD BLVD. KC, MO. 64128</div> <div>Drawn: A10</div> <div>Checked: </div> <div>Approved: Service Director</div>			
Drawing Title: STAIR PLAN, SECTIONS, DETAILS		Project Title: V.A. ELEVATOR REPLACEMENT	
Approved: Division Chief		Building No: BLDG. 1 & BLDG. 26	
Approved: Service Director		Location: 4801 LINKWOOD BLVD. KC, MO. 64128	
Date: 12-31-97		Date: 12-19-97	
Project No: 76-106		Project No: 76-106	
Drawing No: A10		Drawing No: A10	
Issue Date: 12-03-97		Issue Date: 12-03-97	
100% REVIEW		100% REVIEW	
Department of Veterans Affairs			