


BUILDING ISOMETRIC

GENERAL NOTES


- 1. A

ENLARGED PLAN NOTES


- 1. 6" STEEL PIPE BOLLARD. SEE DETAIL 3/AP-101.
- 2. 10" STEEL PIPE BOLLARD. SEE DETAIL 4/AP-101.

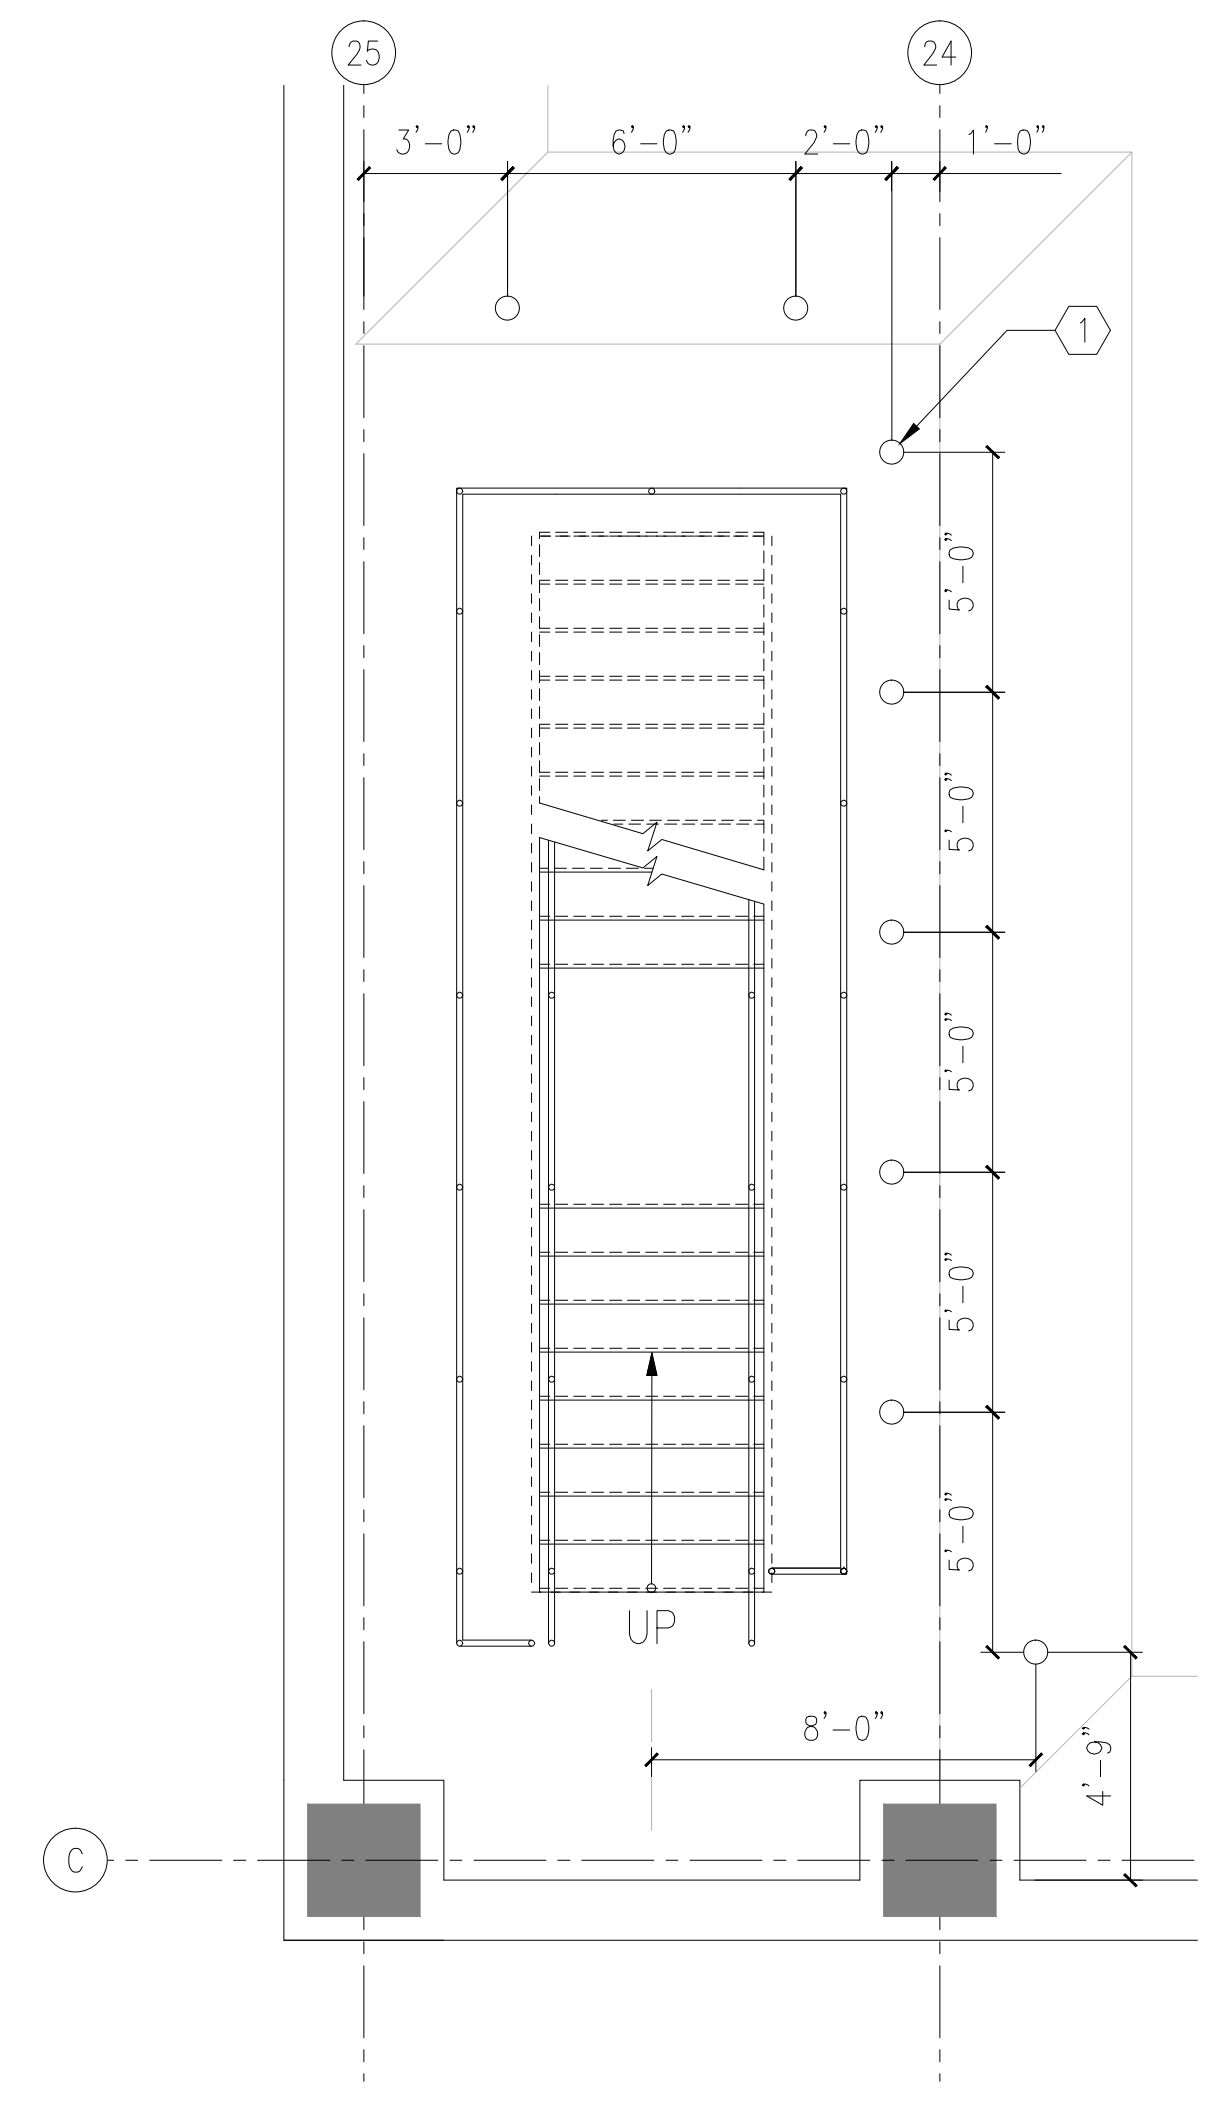


1 ENLARGED STAIR 4 PLAN-LEVEL AA
1/4"=1'-0"

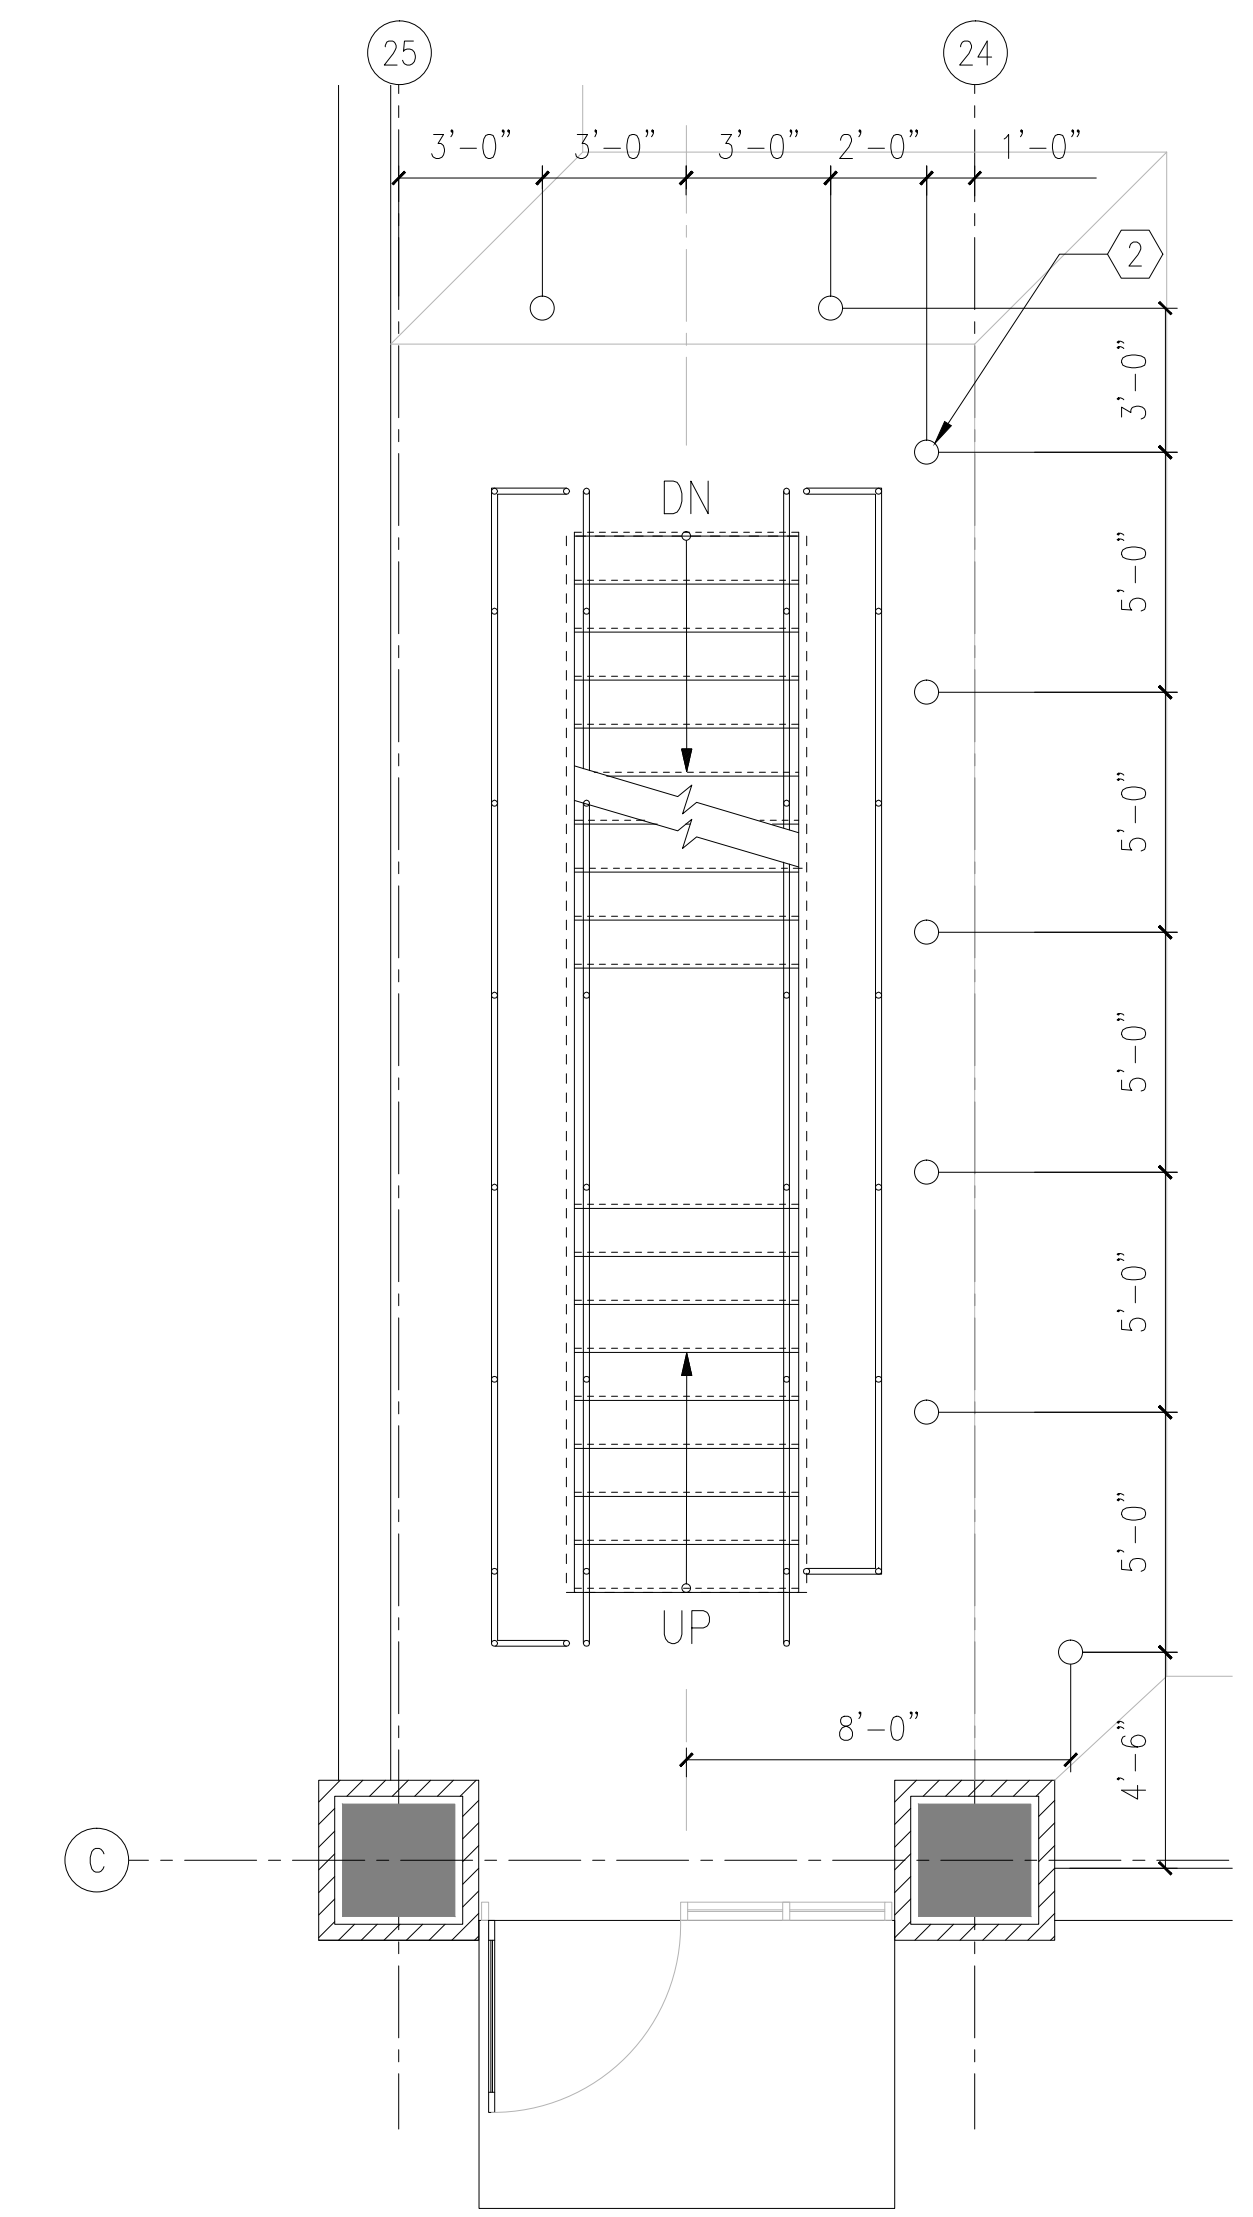


2 ENLARGED STAIR 4 PLAN-LEVEL BB
1/4"=1'-0"

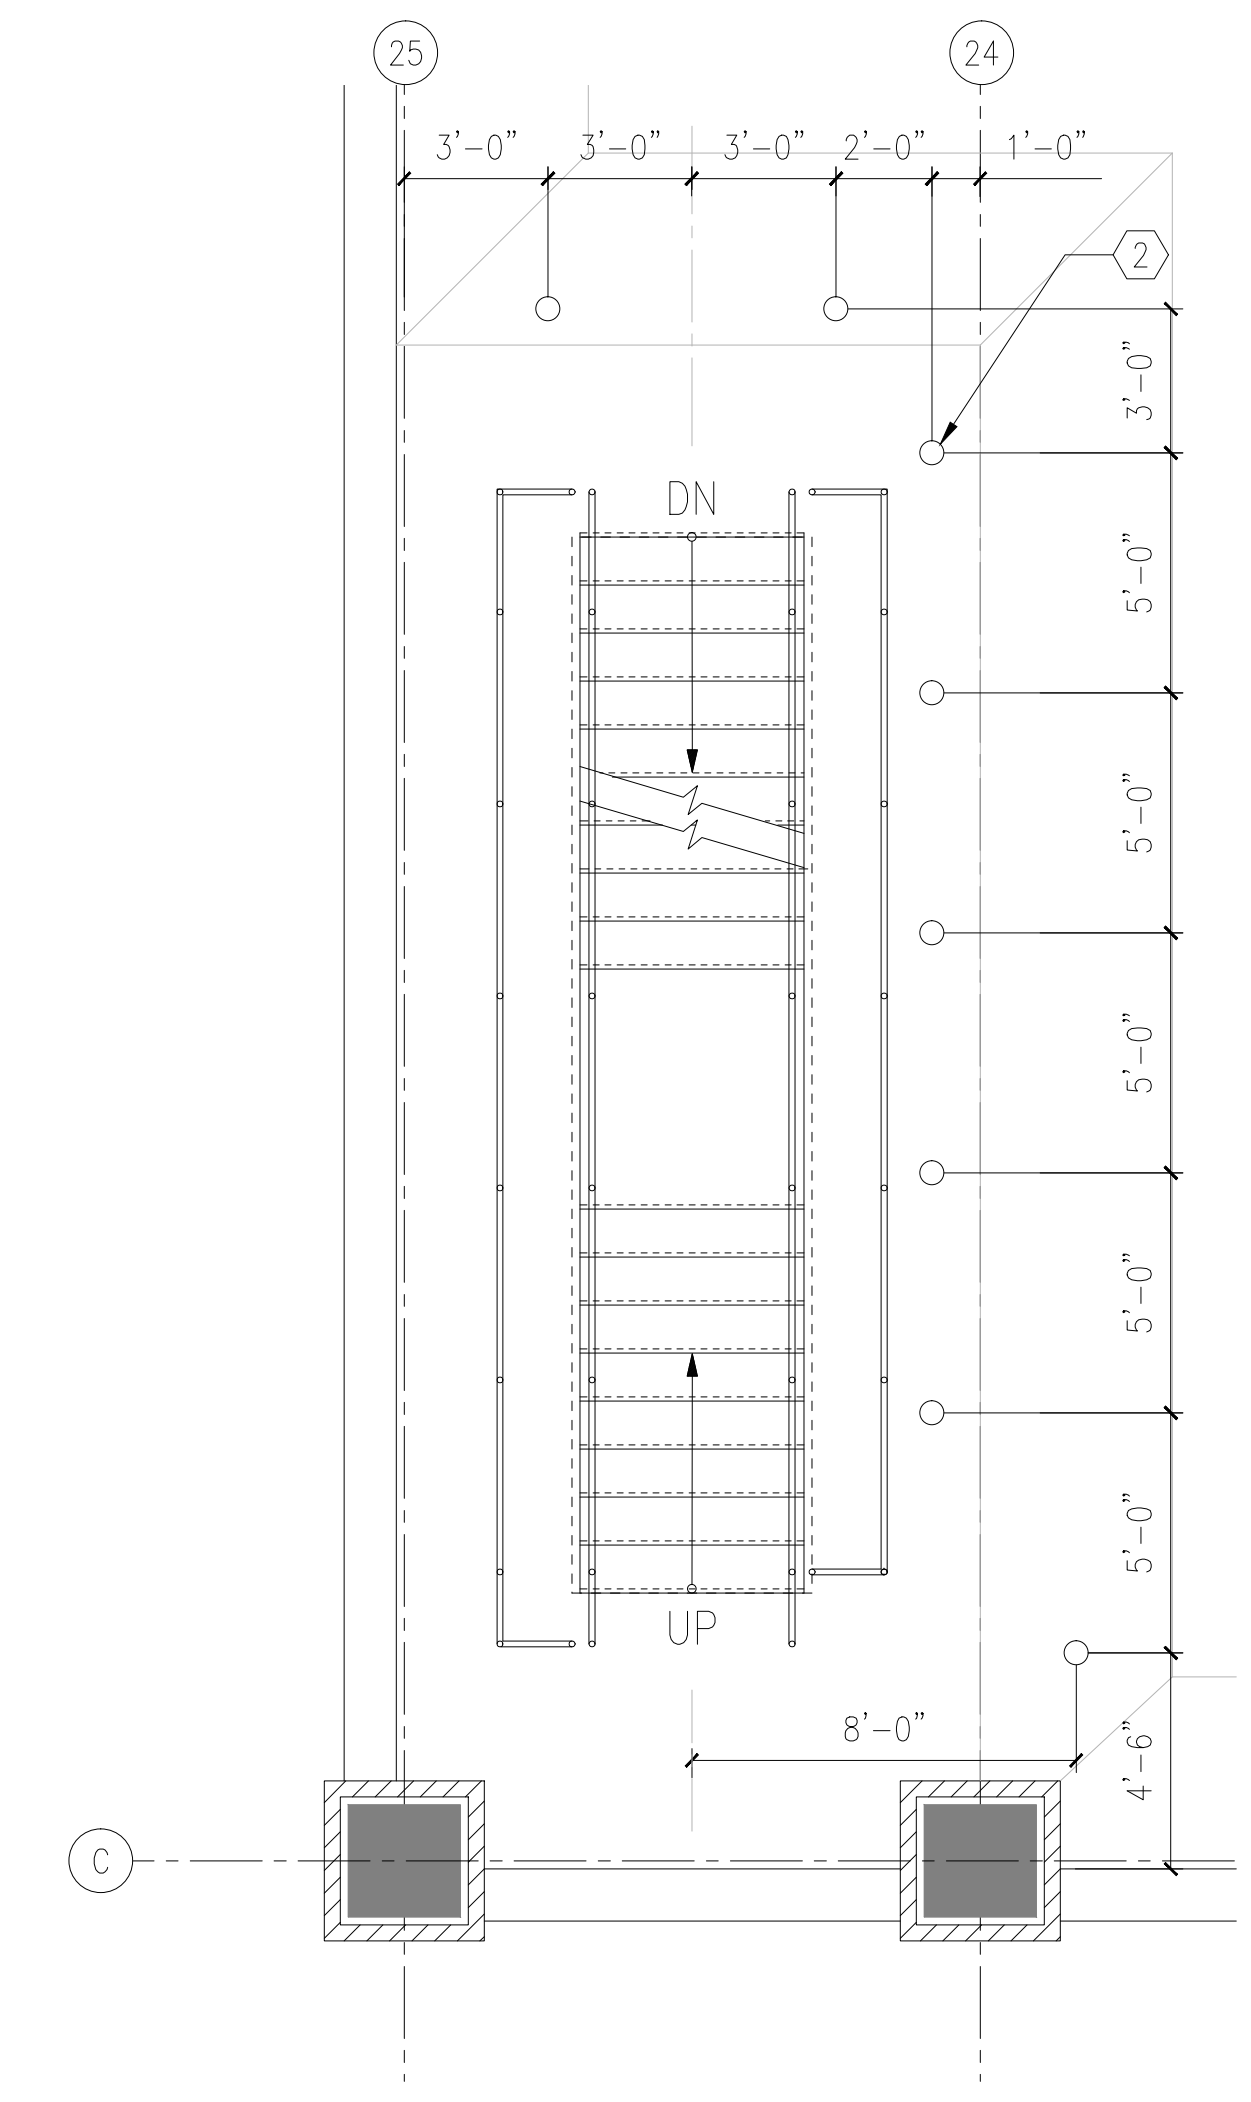


3 ENLARGED STAIR 4 PLAN-LEVEL CC
1/4"=1'-0"

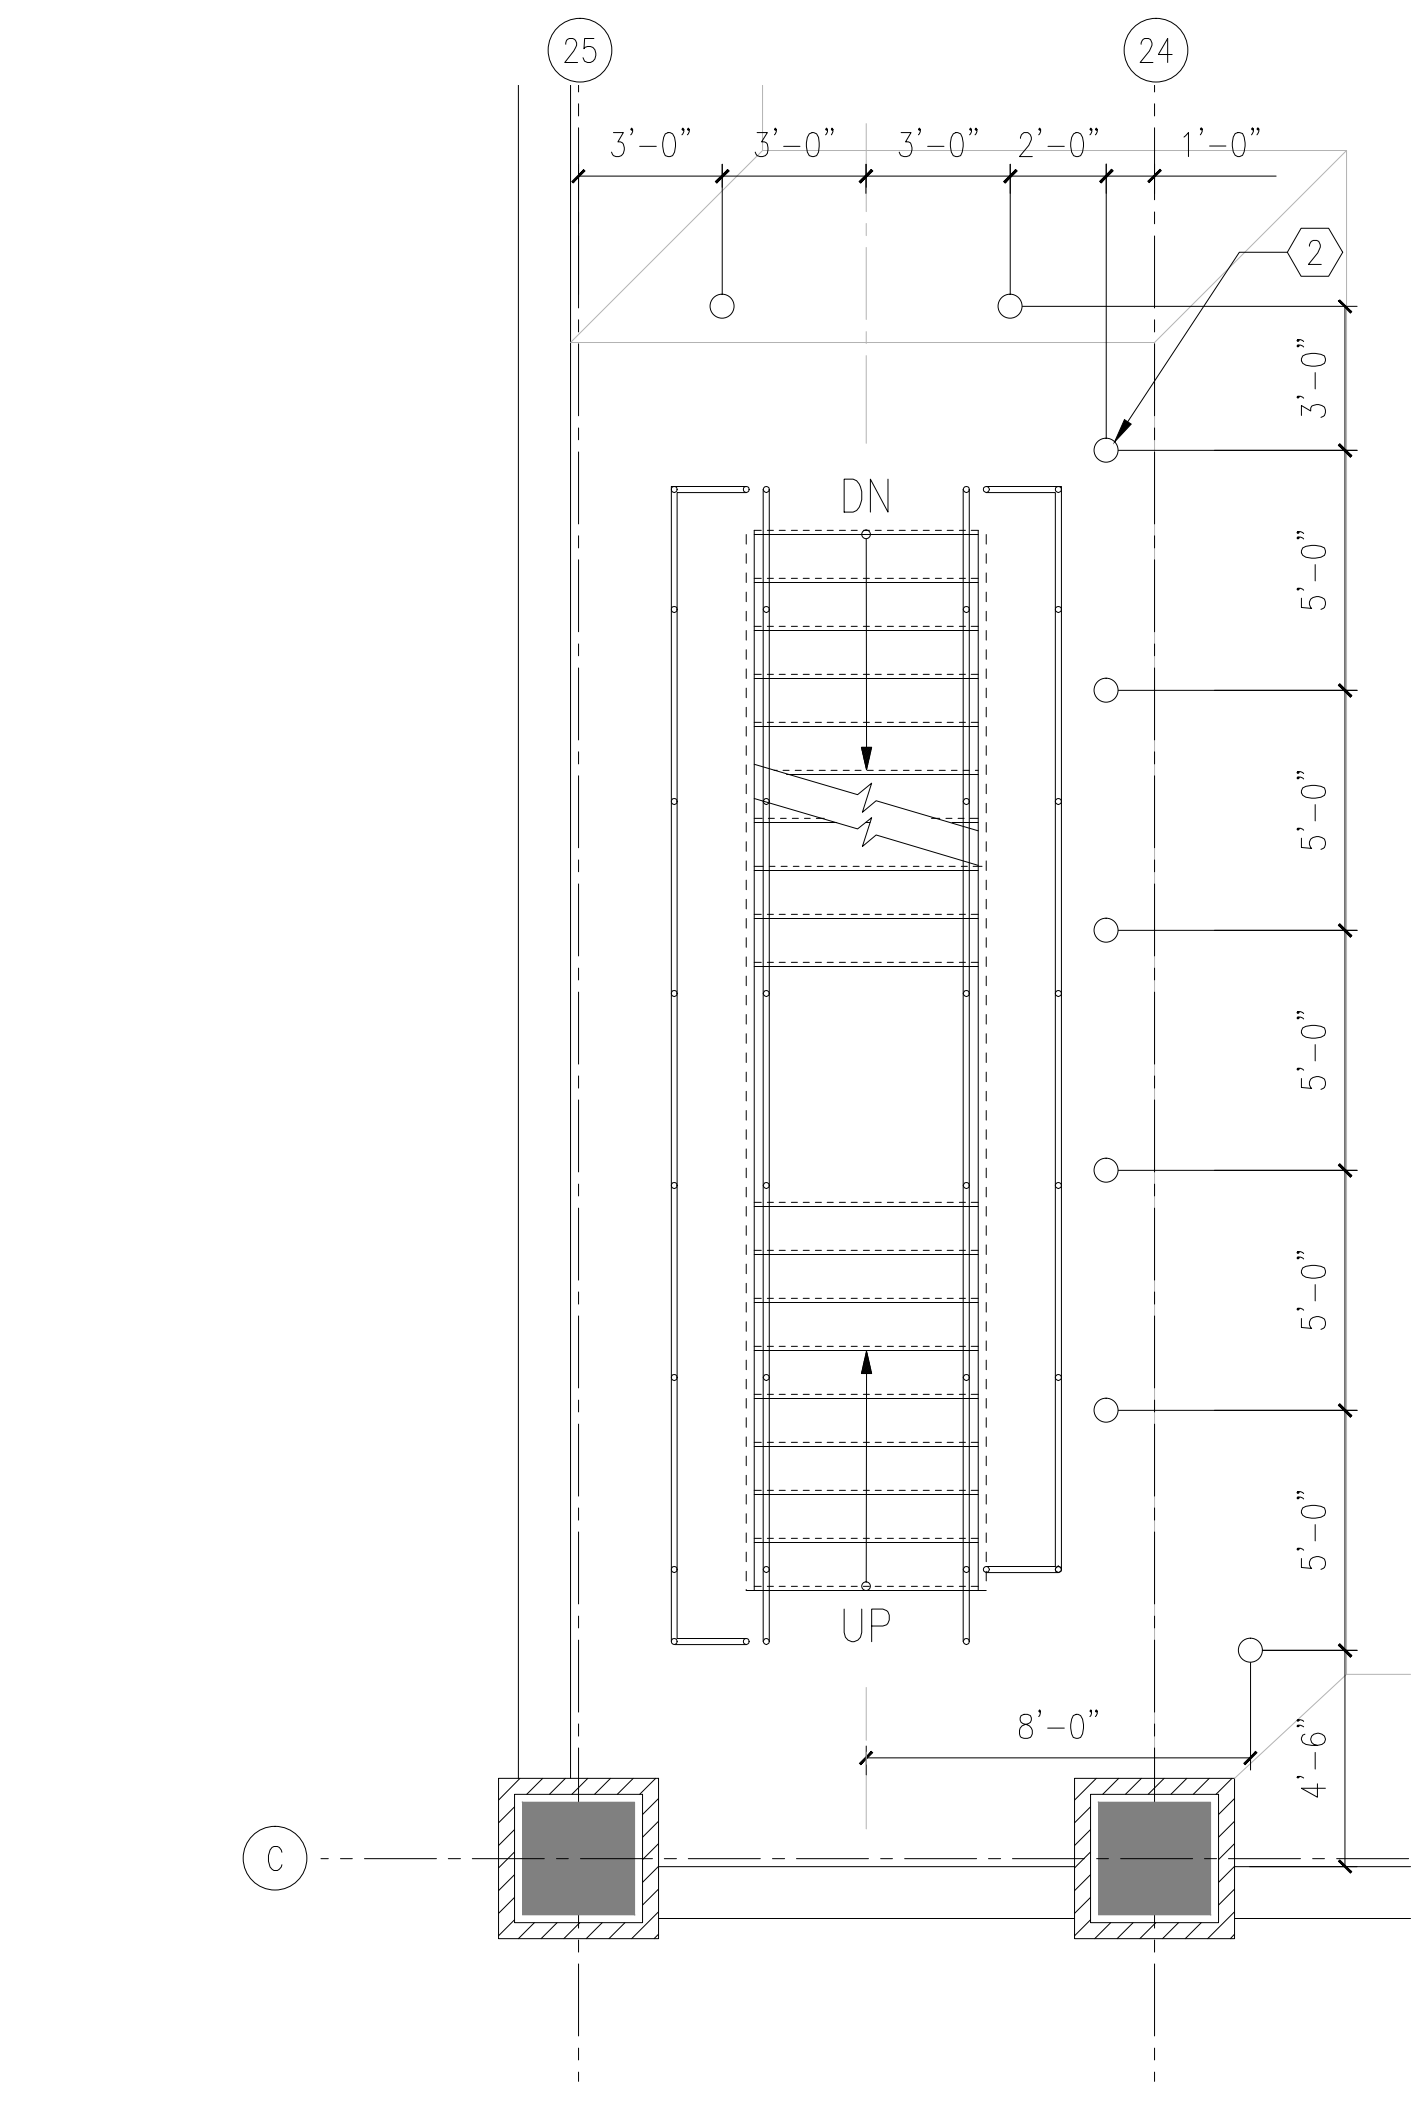


4 ENLARGED STAIR 4 PLAN-LEVEL DD
1/4"=1'-0"

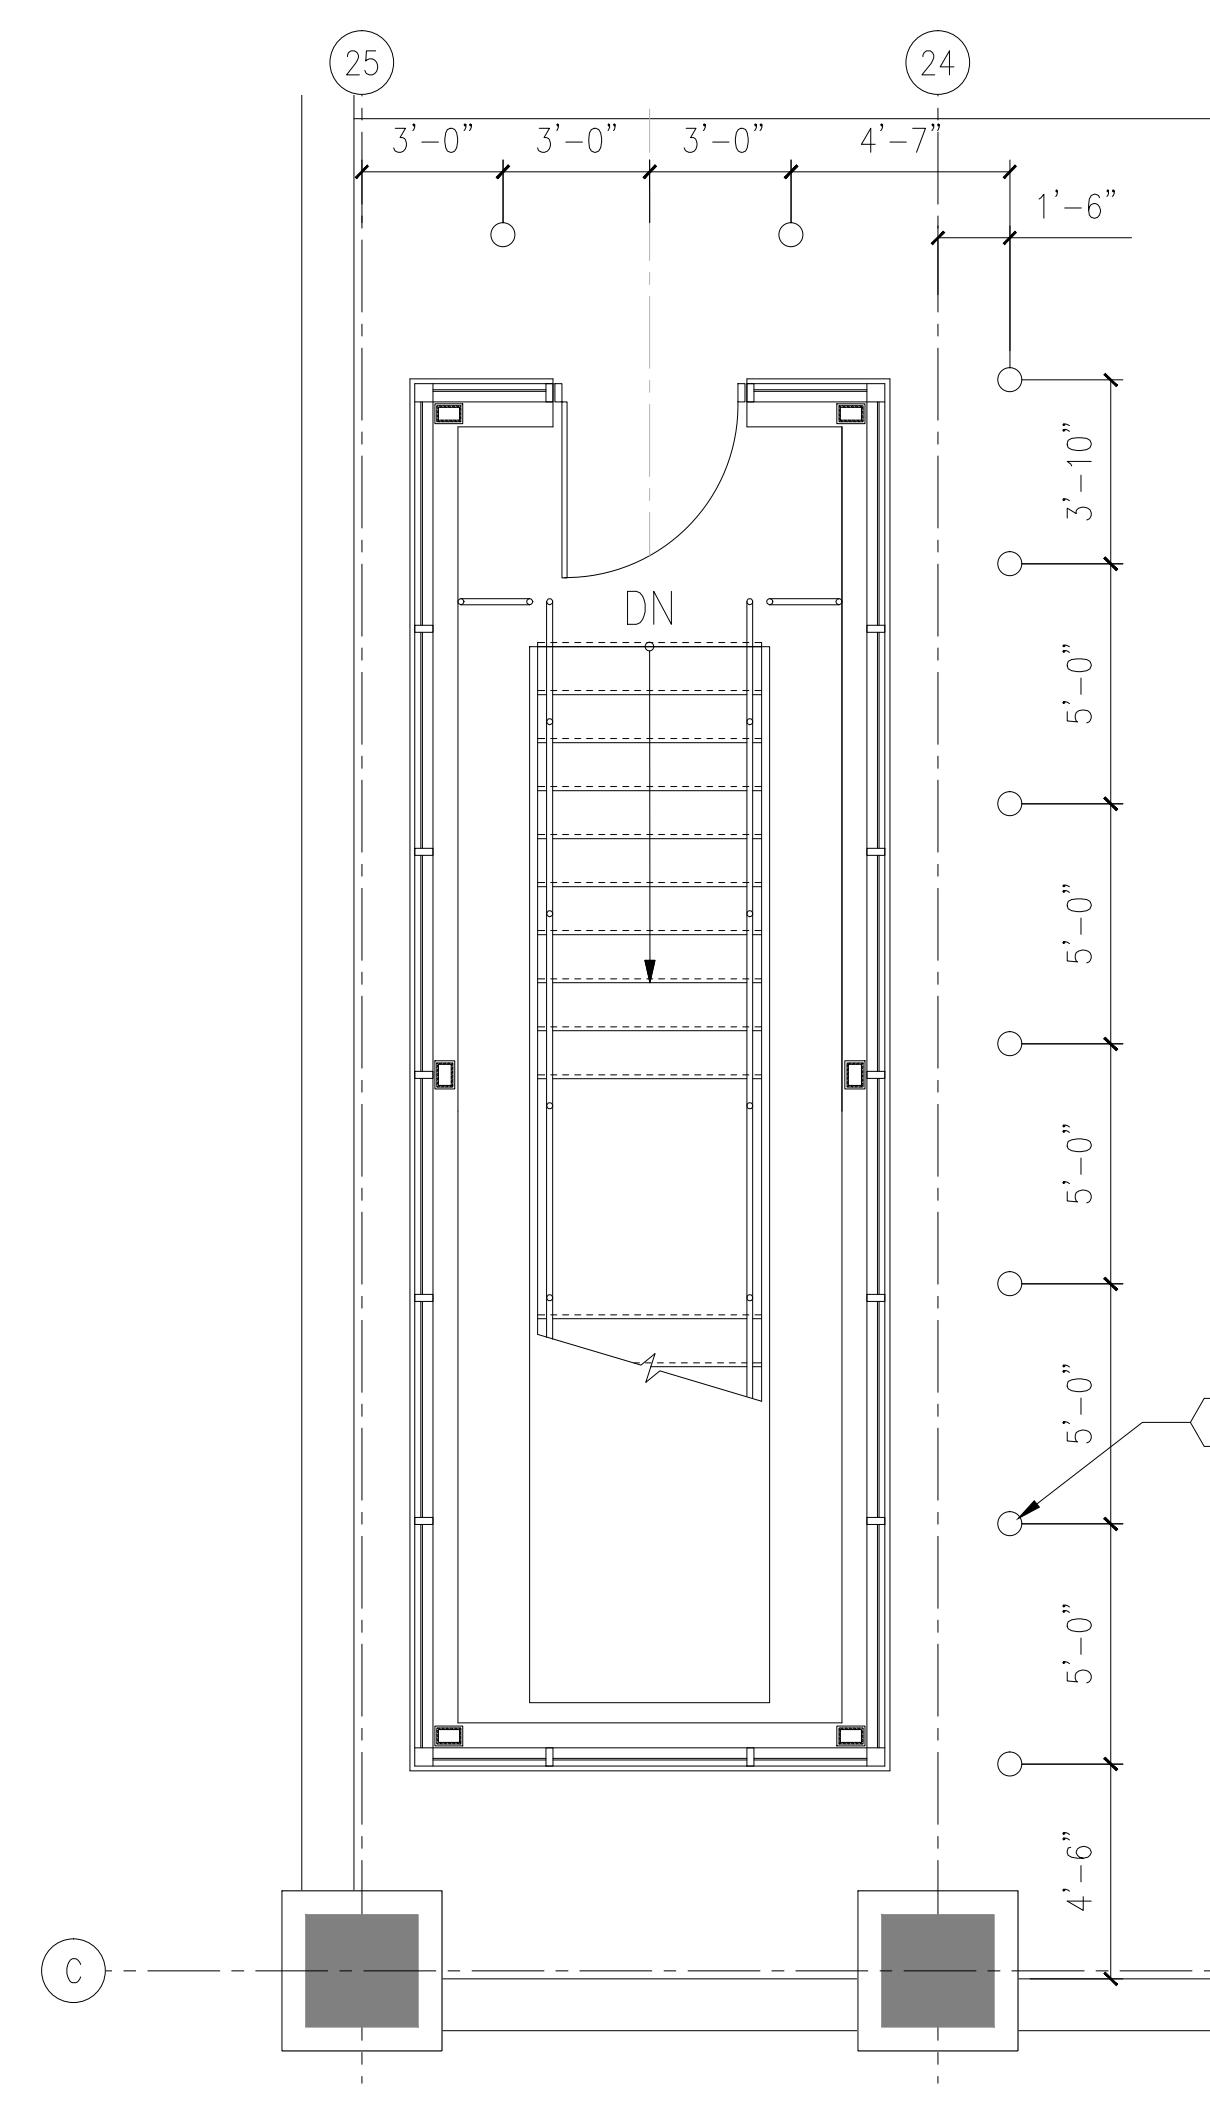


5 ENLARGED STAIR 4 PLAN-LEVEL EE
1/4"=1'-0"

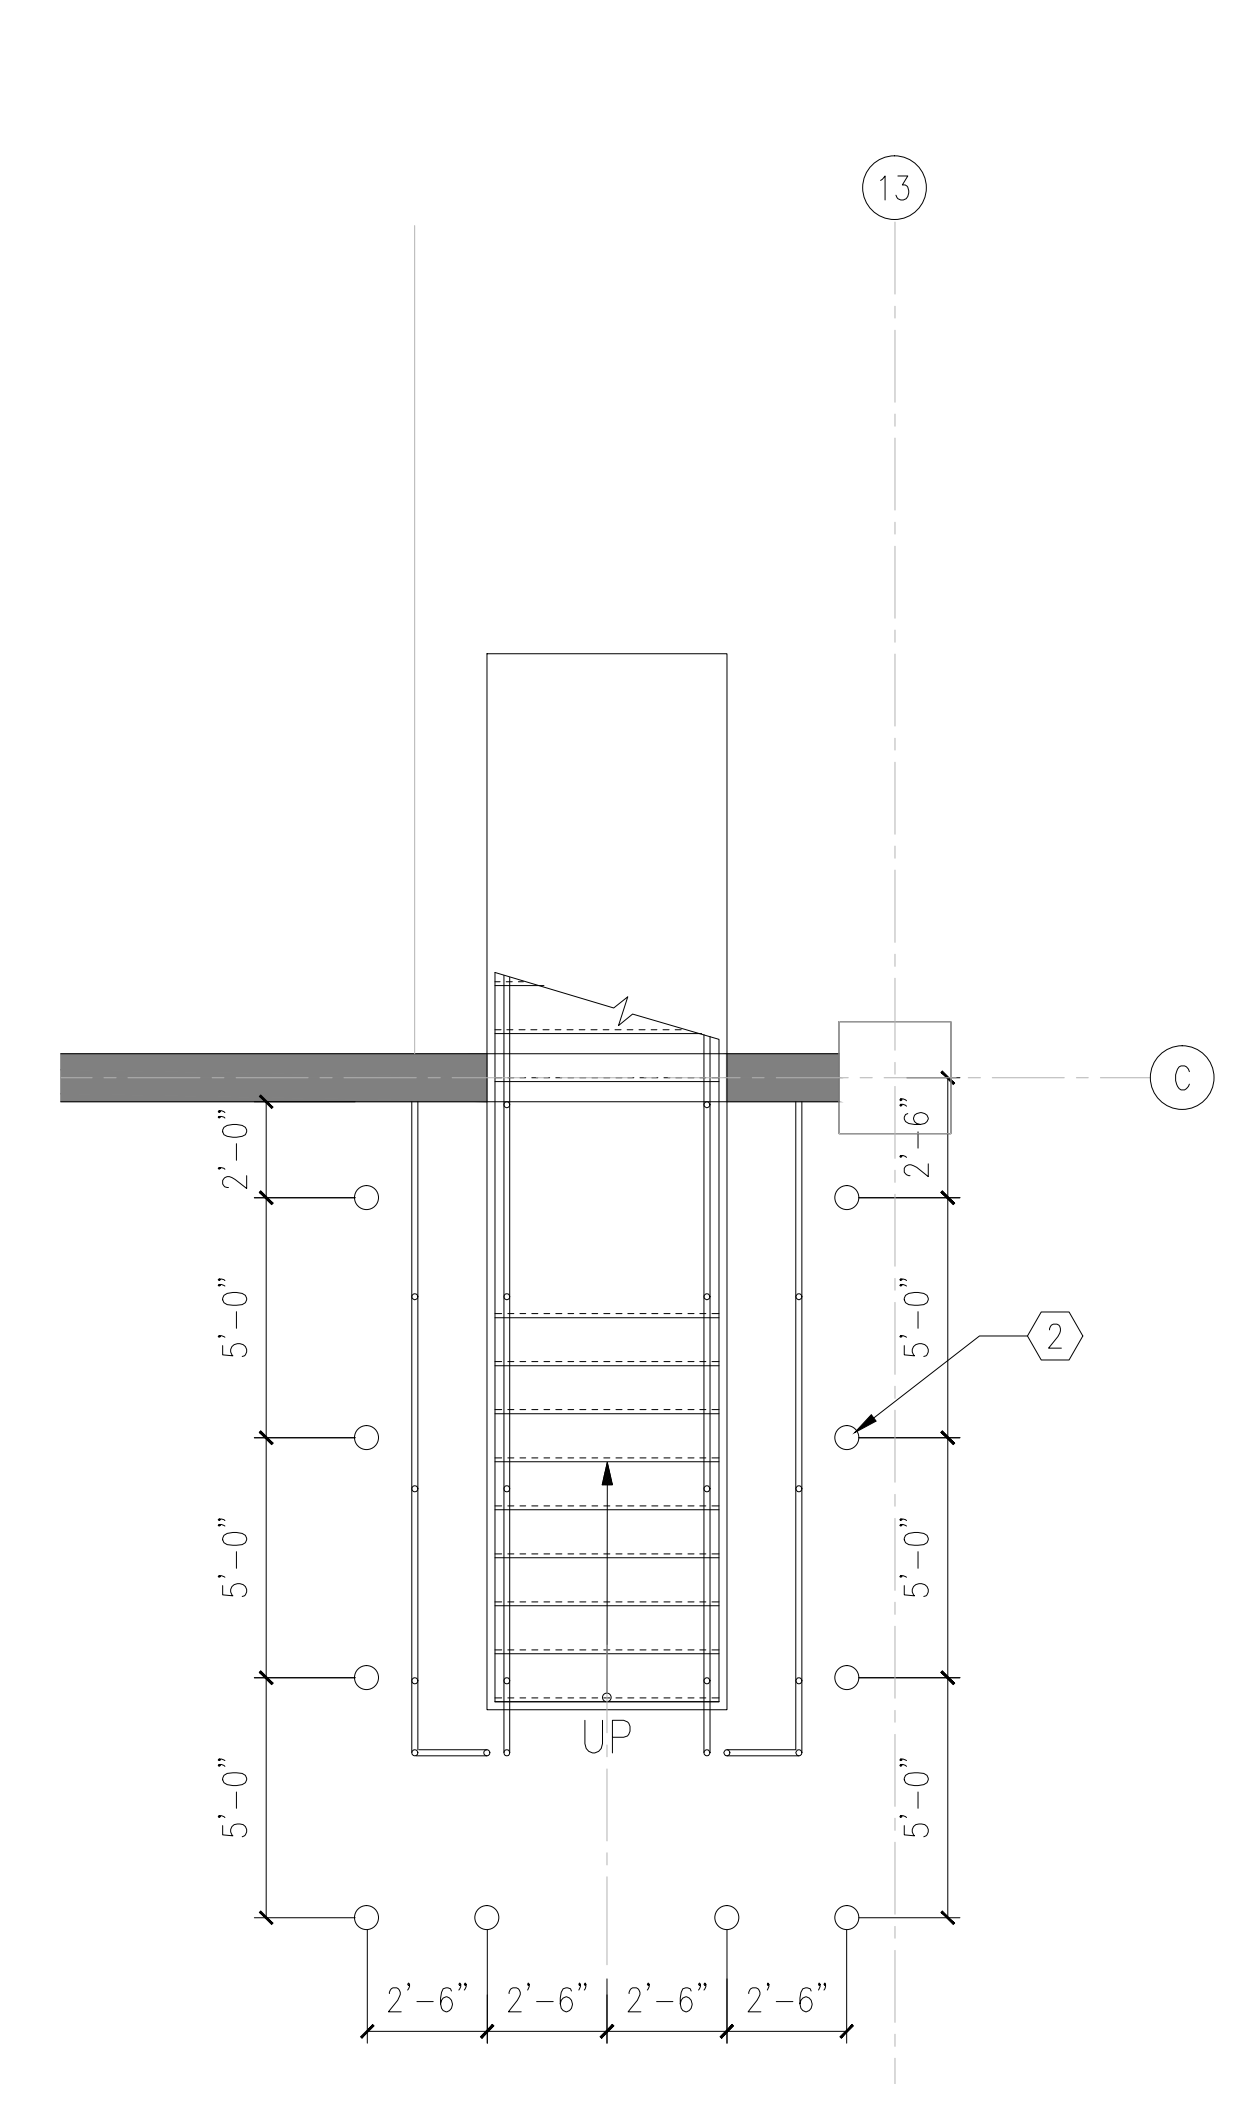


6 ENLARGED STAIR 5 PLAN-LEVEL D
1/4"=1'-0"

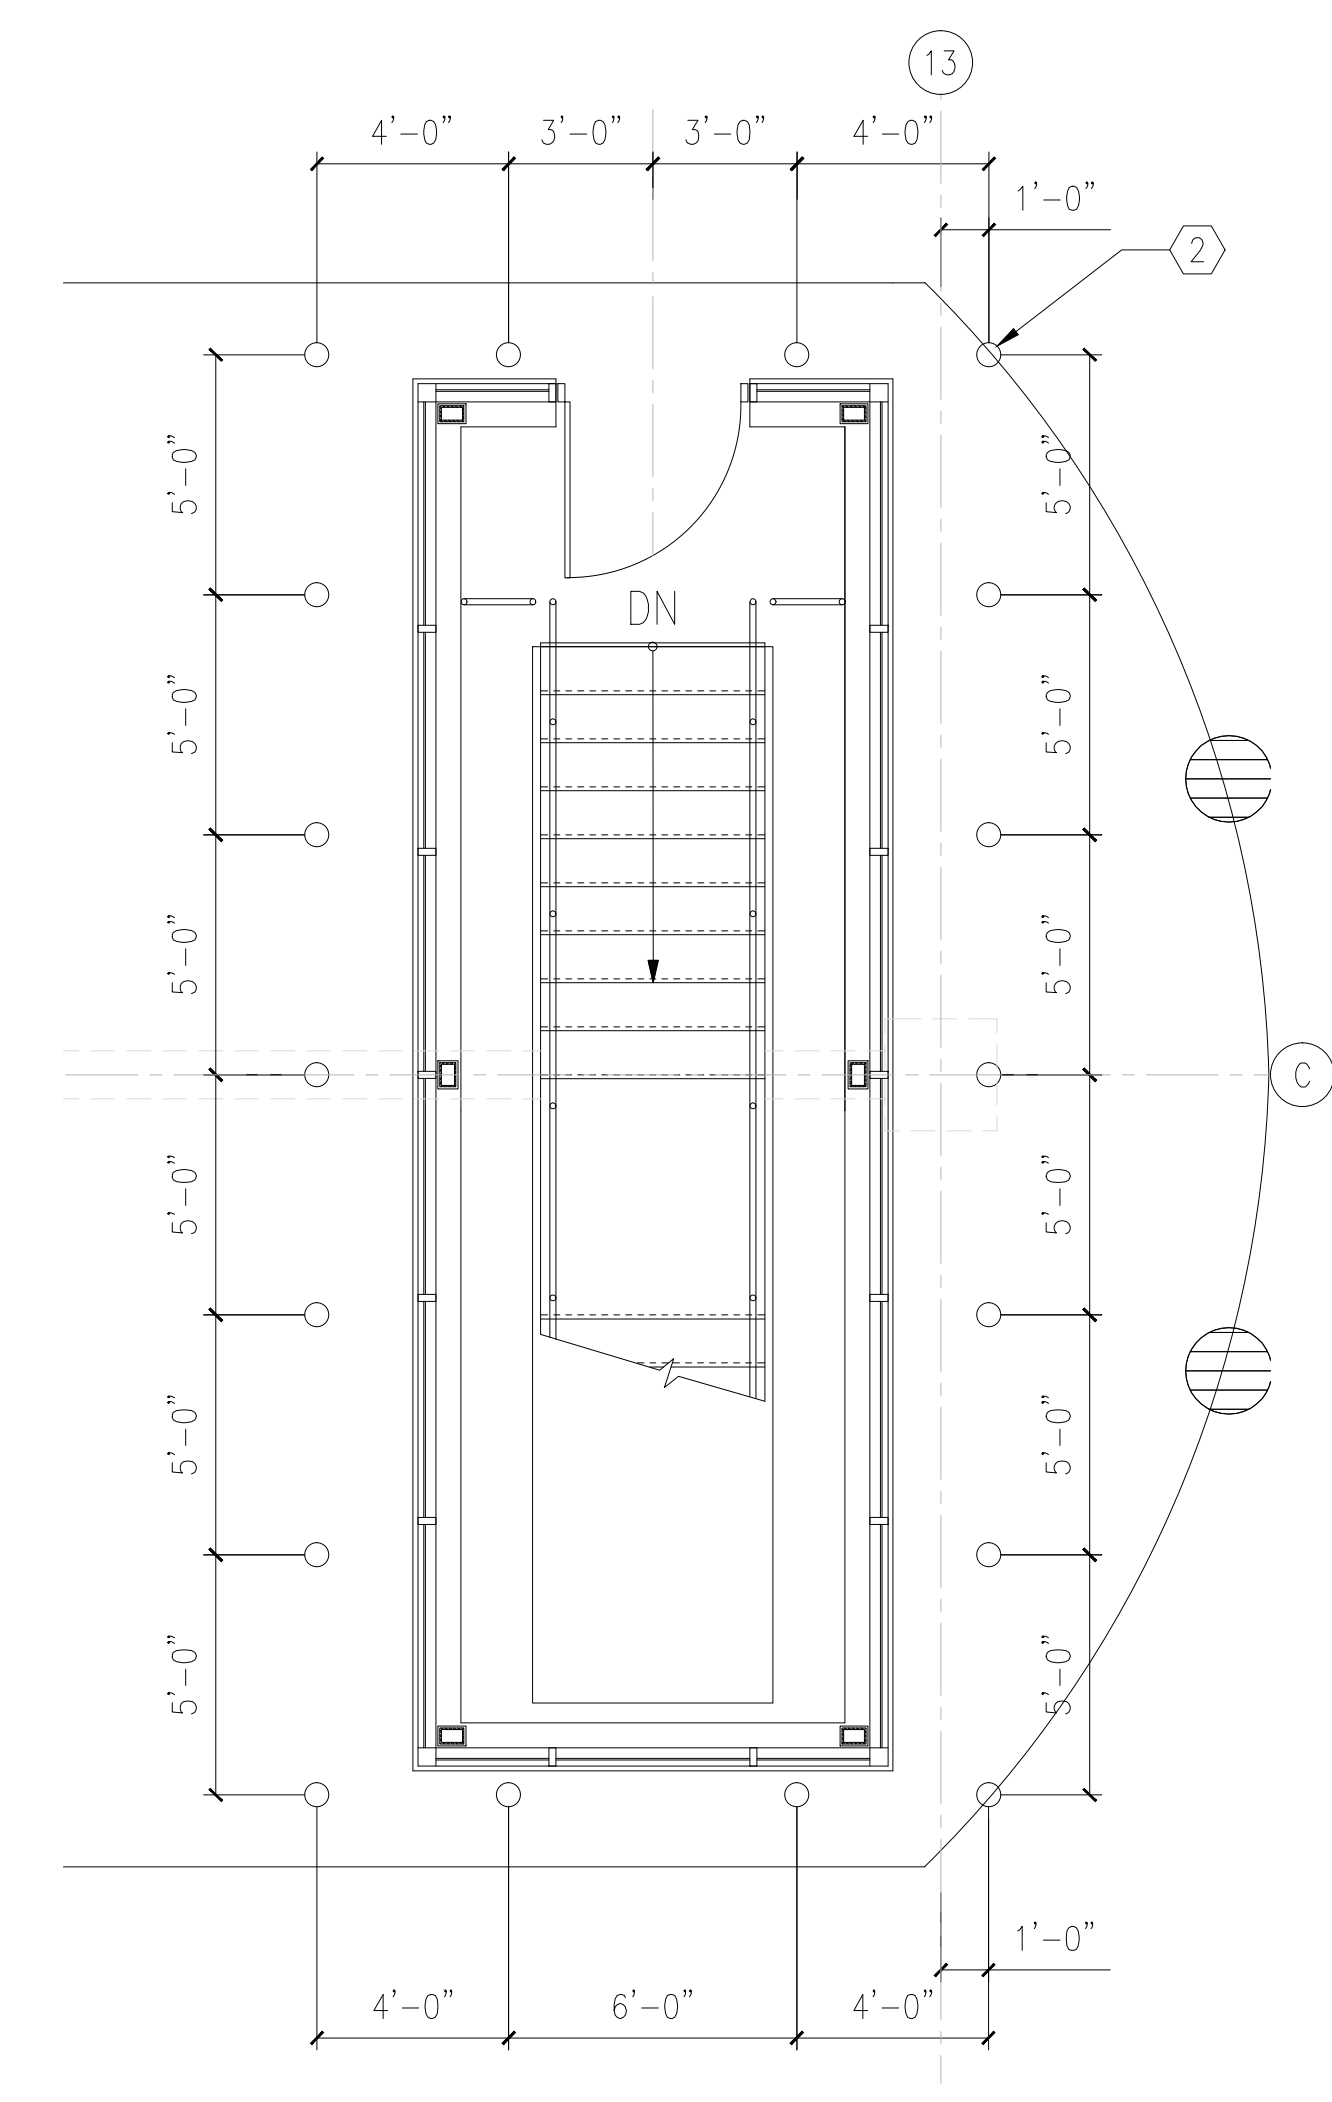

7 ENLARGED STAIR 5 PLAN-LEVEL E
1/4"=1'-0"

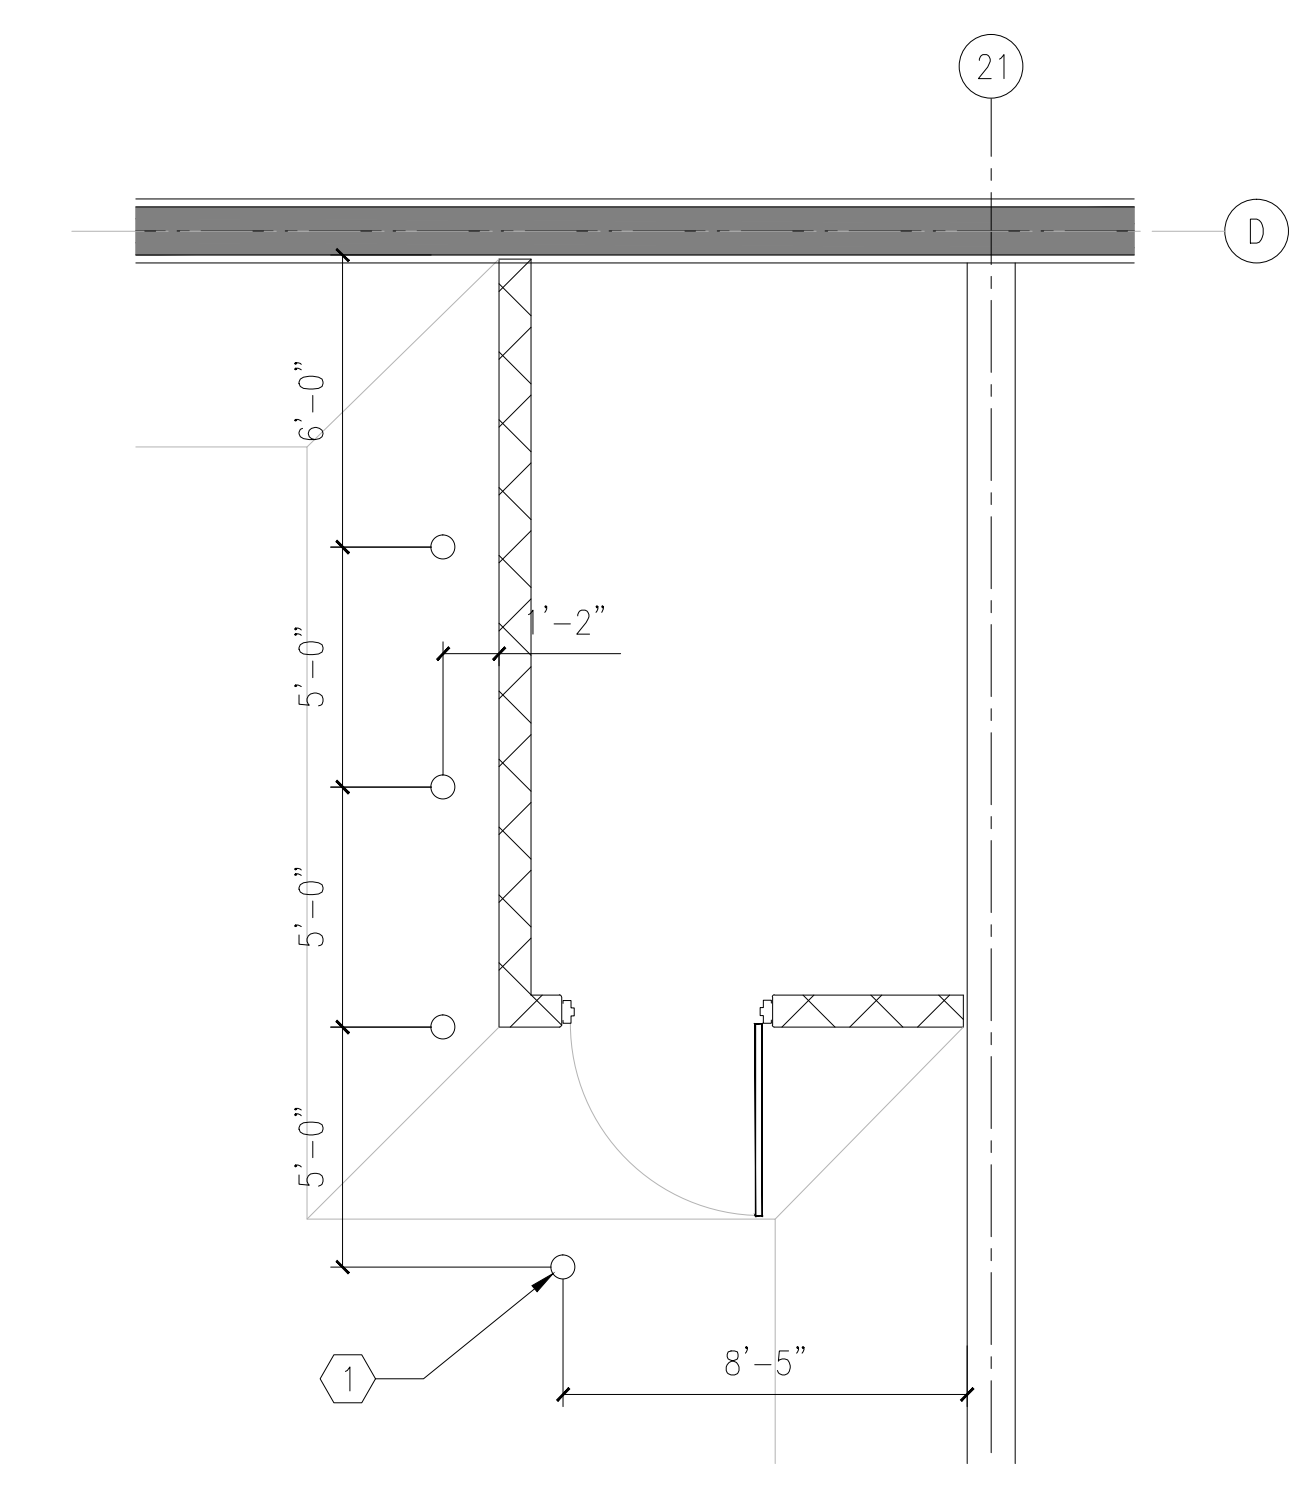

8 ENLARGED ELECTRICAL PLAN-LEVEL AA
1/4"=1'-0"

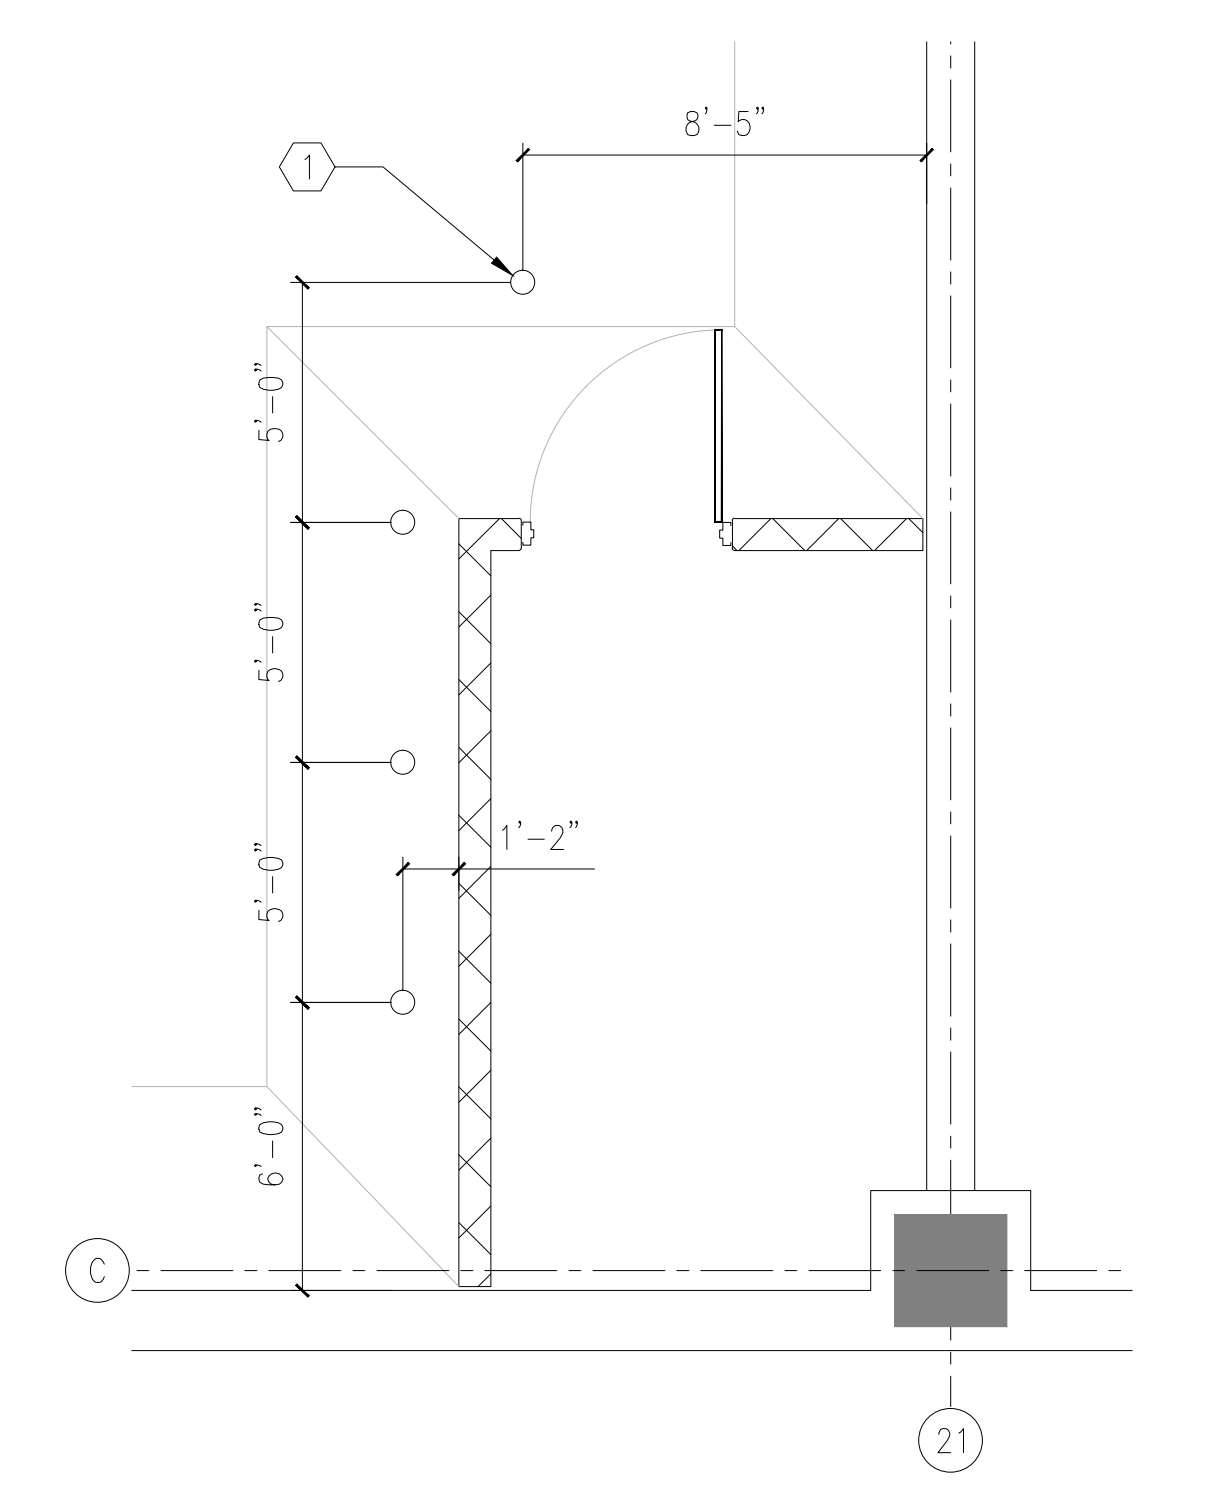

9 ENLARGED STORAGE PLAN-LEVEL AA
1/4"=1'-0"

CONSULTANTS: WALKER PARKING CONSULTANTS 225 Andy Drive, Suite 1 Ann Arbor, MI 48108		KEYPLAN		ARCHITECT + ENGINEERS: BANCROFT ARCHITECTS + ENGINEERS 700 Nicholas Blvd., Suite 300 Eli Grove Village, IL 60007 Telephone : 847.952.9342 www.bancroft-ae.com Bancroft-AE Project No. 14-121		Drawing Title ENLARGED DETAIL PLANS - STEEL PIPE BOLLARDS		Project Title CONSTRUCT NORTH PARKING STRUCTURE		Project Number 506-331		Office of Construction and Facilities Management
100% FINAL BID DOCUMENTS 08-18-2017 100% BID DOCUMENTS-NOT FOR CONSTRUCTION 07-24-2017 95% CONSTRUCTION DOCUMENTS SUBMISSION 06-15-2017 65% DESIGN DEVELOPMENT SUBMISSION 04-19-2017 35% SCHEMATIC DESIGN SUBMISSION 03-06-2017 Revisions: Date						Approved Project Director		Location ANN ARBOR, MICHIGAN		Building Number 29		
								Date 08-18-2017		Drawn AQ		