


BUILDING ISOMETRIC

GENERAL NOTES

1. REFER TO SPECIFICATIONS DIVISION 01 GENERAL REQUIREMENTS.
2. REFER TO SPECIFICATIONS DIVISION 26 ELECTRICAL, DIVISION 27 COMMUNICATIONS AND DIVISION 28 ELECTRONIC SAFETY AND SECURITY FOR PROJECT SPECIFICATIONS AND REQUIREMENTS.
3. REFER TO DRAWING G-004 FOR PROJECT CONSTRUCTION PHASING NOTES.
4. REFER TO DRAWING E-001 FOR GENERAL ELECTRICAL NOTES, ELECTRICAL SYMBOLS LIST AND ABBREVIATIONS.
5. REFER TO DRAWINGS ED-101 FOR ELECTRICAL DEMOLITION PLANS.
6. REFER TO DRAWINGS EC-101 THROUGH EC-105 FOR FIRE ALARM SYSTEM AND SECURITY SYSTEM PLANS.
7. CONDUIT ROUTING IS SHOWN DIAGMATICALLY ON FLOOR PLANS. CONTRACTOR WILL PROVIDE SHOP DRAWING INDICATING ROUTING OF ALL CONDUIT SYSTEMS PRIOR TO INSTALLATION. REFER TO DETAIL 1 ON S-515 FOR THE LOCATION AND QUANTITIES OF BLOCKOUTS AT THE PRECAST CONCRETE DOUBLE TEE MEMBERS.

ELECTRICAL PLAN NOTES

1. REFER TO ARCHITECTURAL REFLECTED CEILING PLANS.
2. SUSPENDED LIGHT FIXTURES "F1". IT SHOULD BE CIRCUITED TO NORMAL POWER PANEL 29 L2-03. LIGHTING FIXTURE SCHEDULE ON DRAWING E-701.
3. SUSPENDED LIGHT FIXTURES CONNECTED TO EMERGENCY POWER SYSTEM. IT SHOULD BE CIRCUITED TO EMERGENCY POWER PANEL 29 EL2-04.
4. SURFACE MOUNTED POWER OUTLETS.
5. SUSPENDED EXIT SIGNAGE SYSTEM. IT SHOULD BE CIRCUITED TO PANEL 29 EL2-04.
6. REFER TO DRAWING E-201 FOR PARKING GARAGE LEVEL A AND B OVERALL ELECTRICAL PLAN FOR LOCATION OF EXISTING ELECTRICAL ROOM AND RESPECTIVE NEW CONDUITS AND FEEDER CABLES.
7. REFER TO DETAIL PLAN OF ELECTRIC ROOM ON DRAWING E-401.

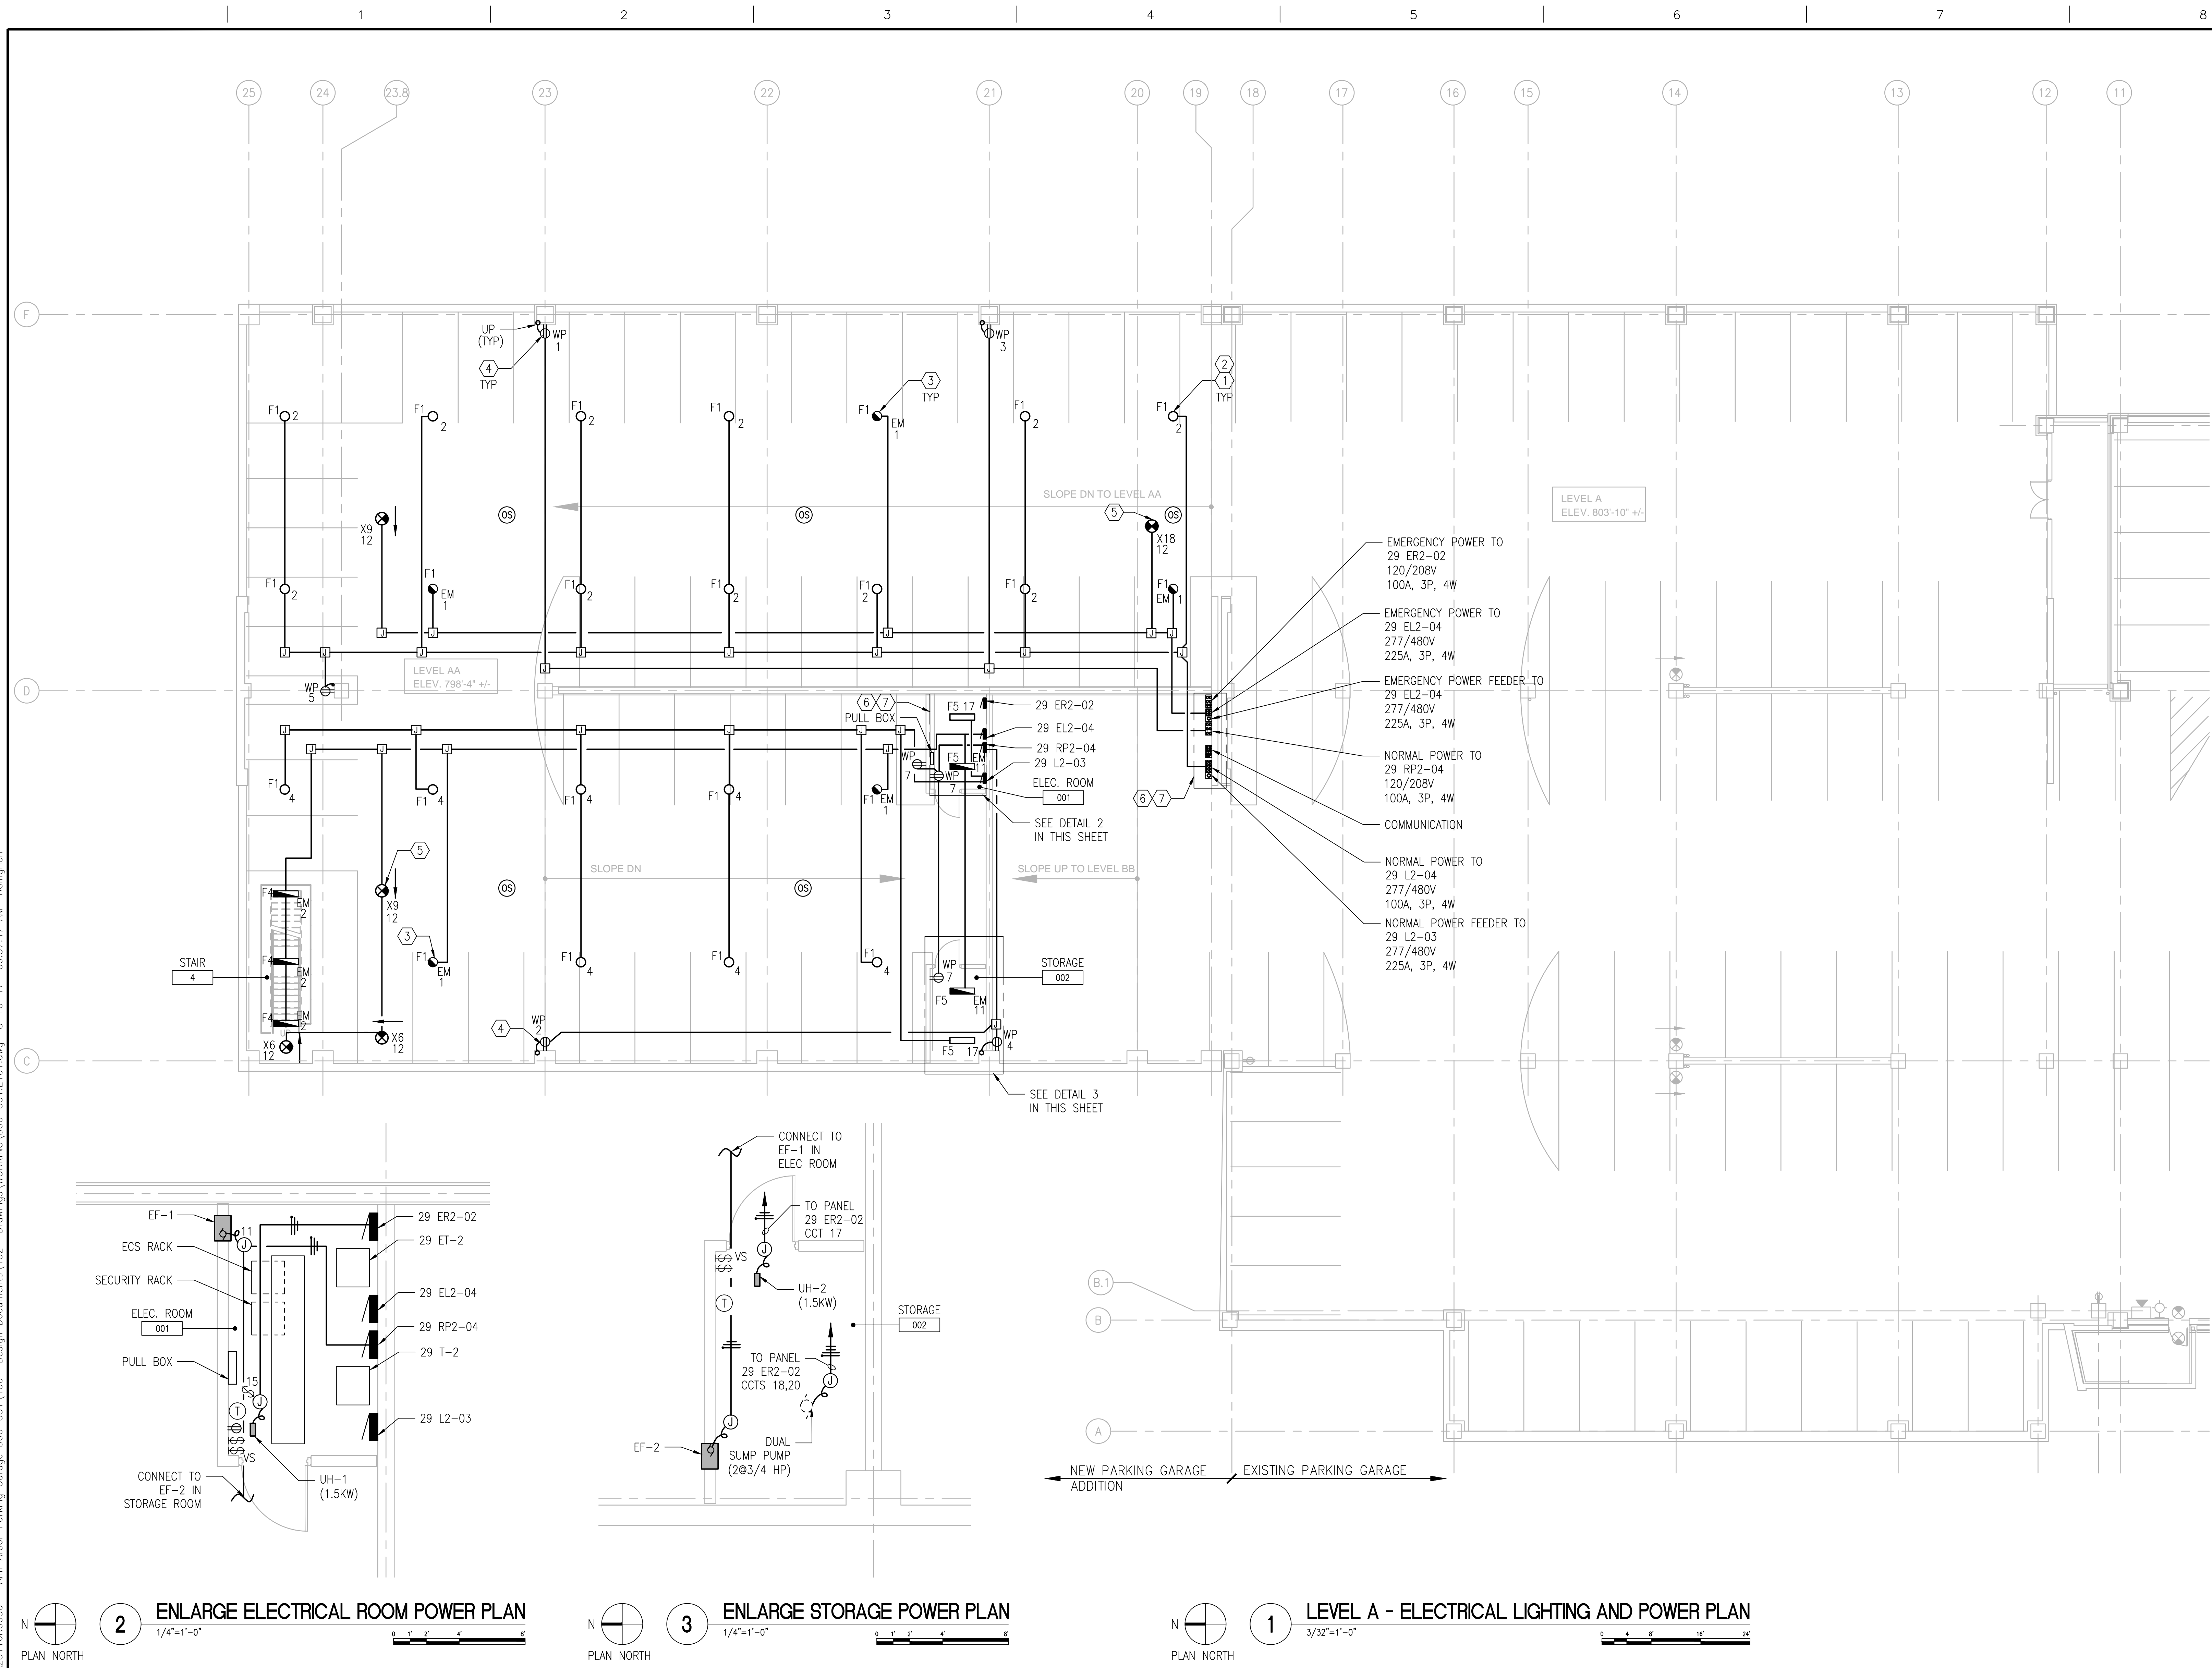

<b>CONSULTANTS:</b>  WALKER PARKING CONSULTANTS 225 Andy Drive, Suite 1 Ann Arbor, MI 48108		<b>MIDWESTERN CONSULTING</b> 3815 Plaza Drive Ann Arbor, Michigan 48108 (734) 995-0200 • www.midwesternconsulting.com Land Development • Land Survey • Institutional • Municipal Wireless Communications • Transportation • Landfill Services		<b>KEYPLAN</b>		<b>ARCHITECT + ENGINEERS:</b>  BANCROFT ARCHITECTS + ENGINEERS 700 Nicholas Blvd., Suite 300 Eli Grove Village, IL 60007 Telephone : 847.952.9342 www.bancroft-ae.com Bancroft-AE Project No. 14-121 VA CONTRACT NO. VA250-17-C-0008		<b>Drawing Title</b> LEVEL A - ELECTRICAL LIGHTING AND POWER PLAN <b>Approved Project Director</b>		<b>Project Title</b> CONSTRUCT NORTH PARKING STRUCTURE <b>Location</b> ANN ARBOR, MICHIGAN <b>Date</b> 08-18-2017 <b>Checked</b> LF <b>Drawn</b> YY AG EM		<b>Project Number</b> 506-331 <b>Building Number</b> 29 <b>Drawing Number</b> E-101		<b>Office of Construction and Facilities Management</b> 	
---------------------------------------------------------------------------------------------------------	--	-----------------------------------------------------------------------------------------------------------------------------------------------------------------------------------------------------------------------------------------------------------	--	----------------	--	--------------------------------------------------------------------------------------------------------------------------------------------------------------------------------------------------------------------------------------------------------------	--	----------------------------------------------------------------------------------------------------------	--	--------------------------------------------------------------------------------------------------------------------------------------------------------------------------------------	--	----------------------------------------------------------------------------------------------------	--	-------------------------------------------------------------	--