

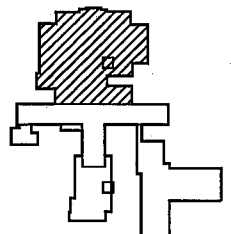
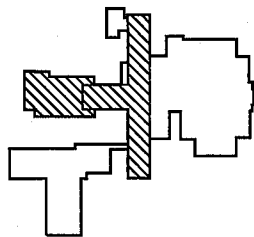
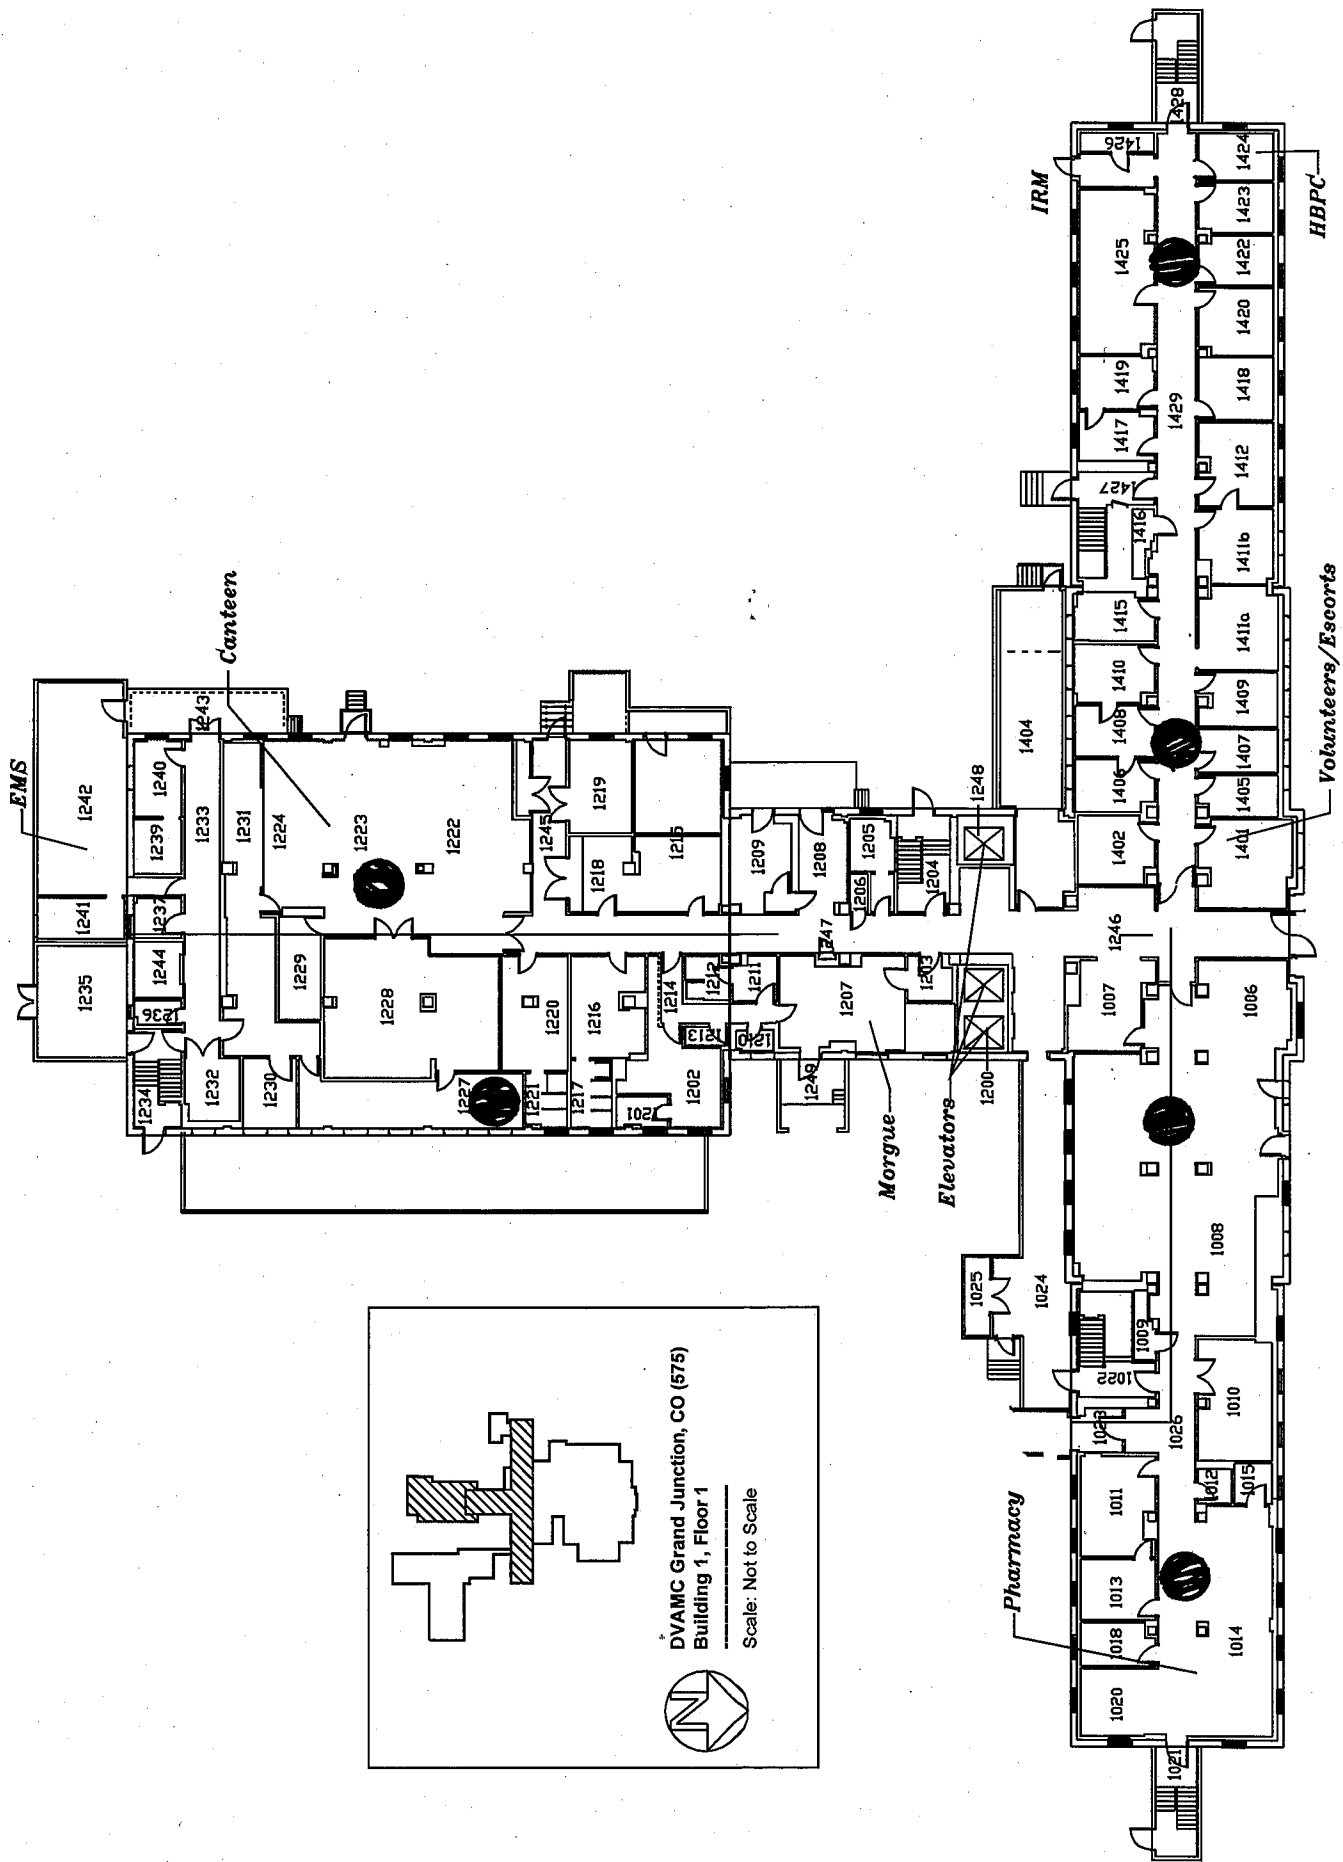
[illegible]








DVAMC Grand Junction, CO (575)
 Building 1, Floor 1, OPA
 Scale: Not to Scale

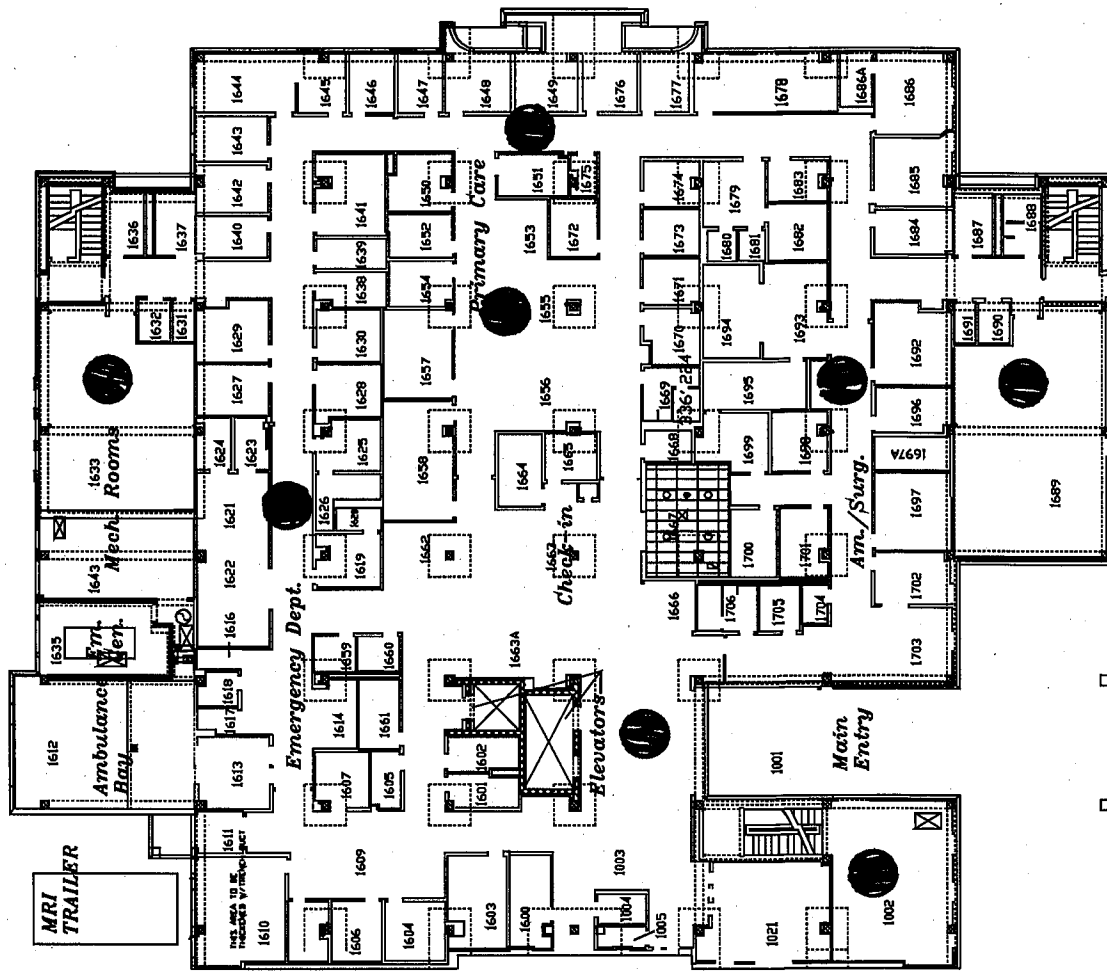


DVAMC Grand Junction, CO (575)
Building 1, Floor 1


Scale: Not to Scale



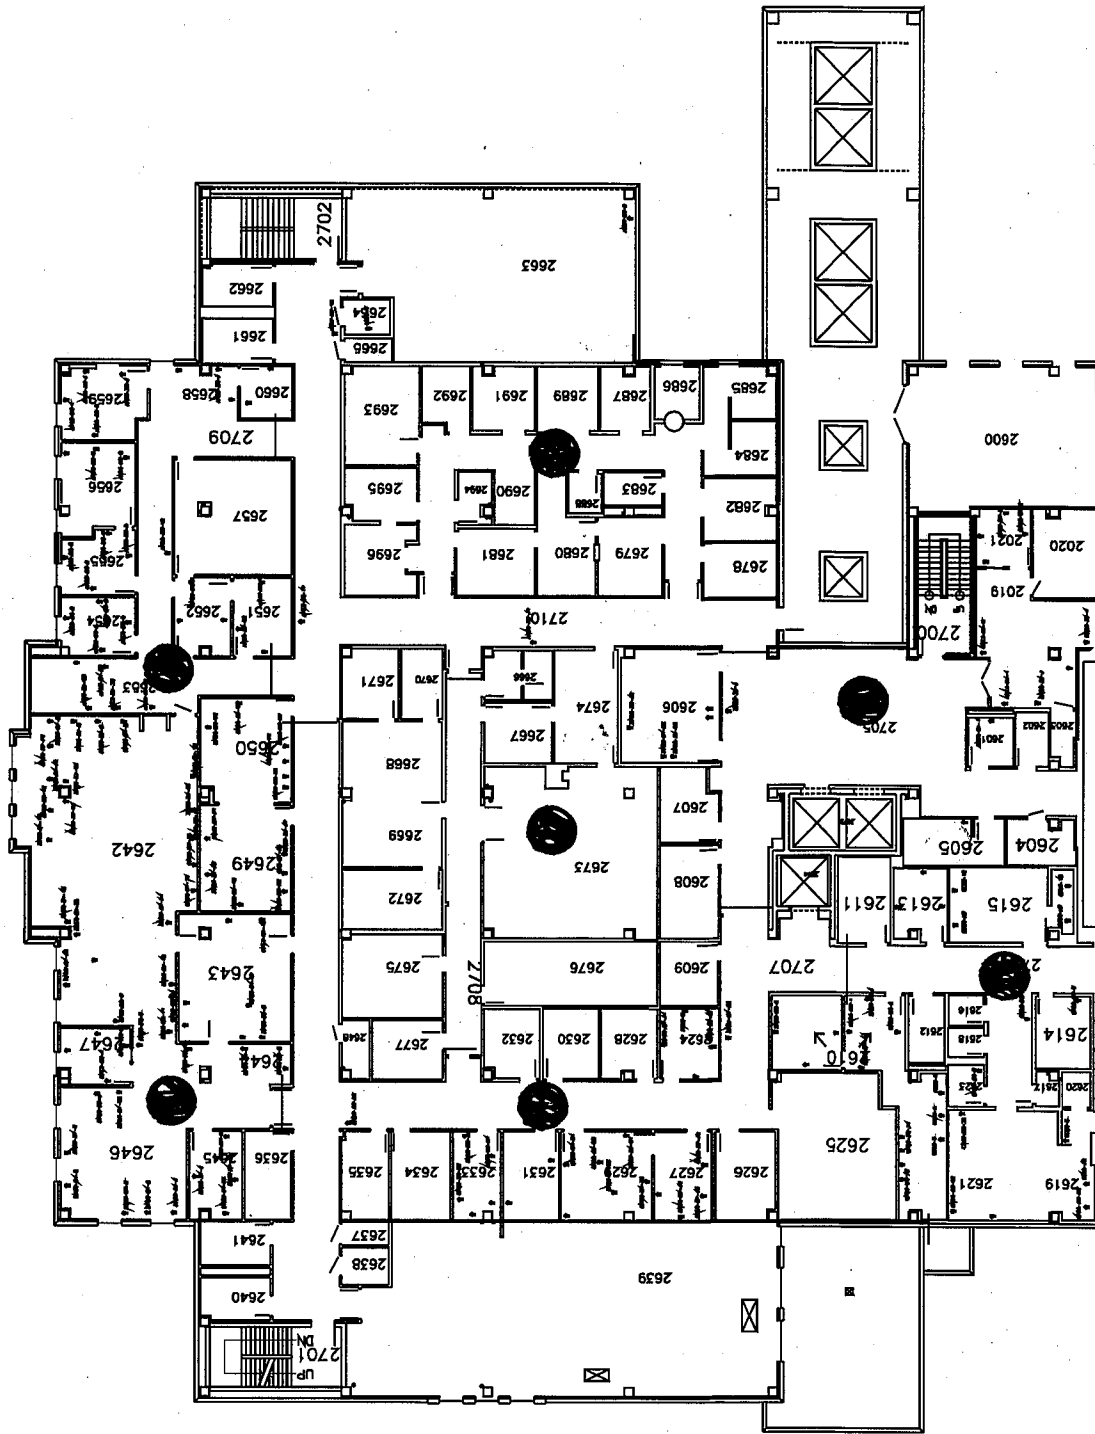


2nd Floor, OPA, B1

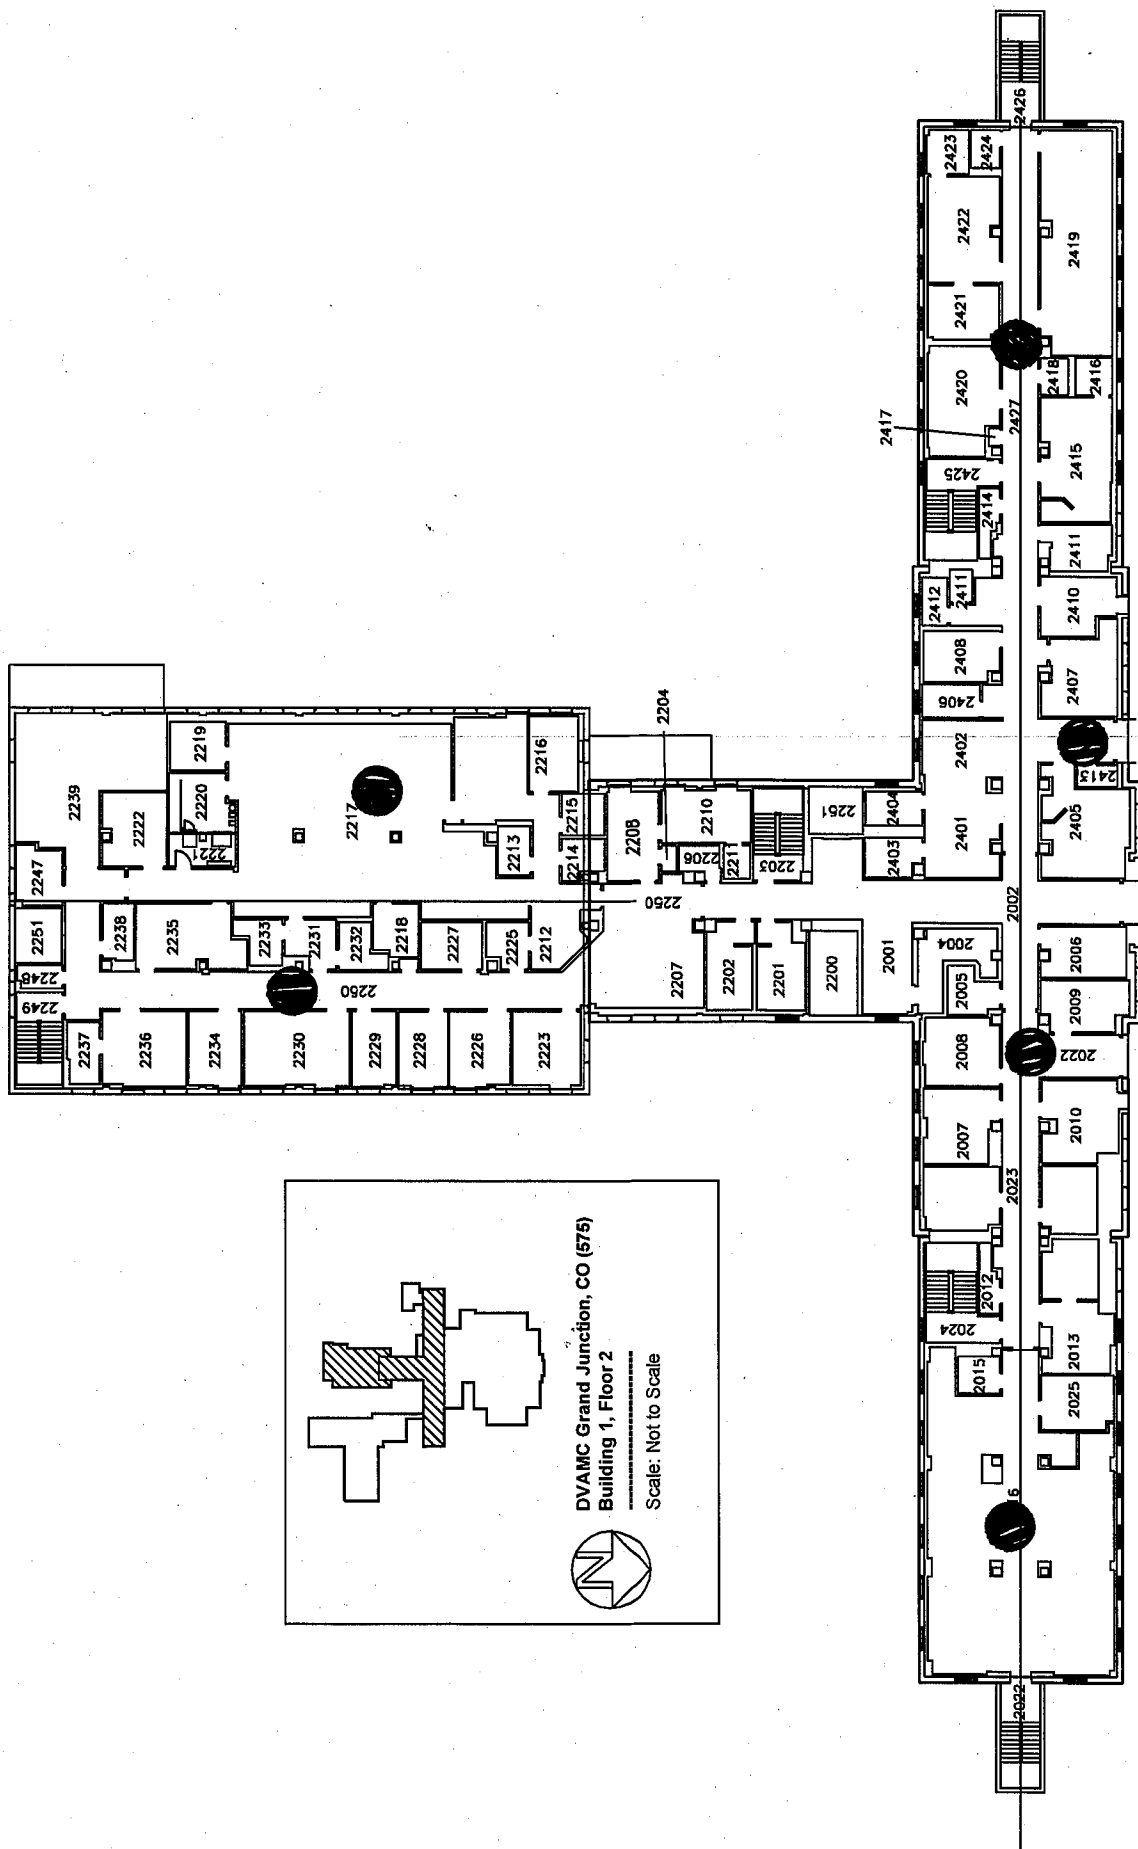


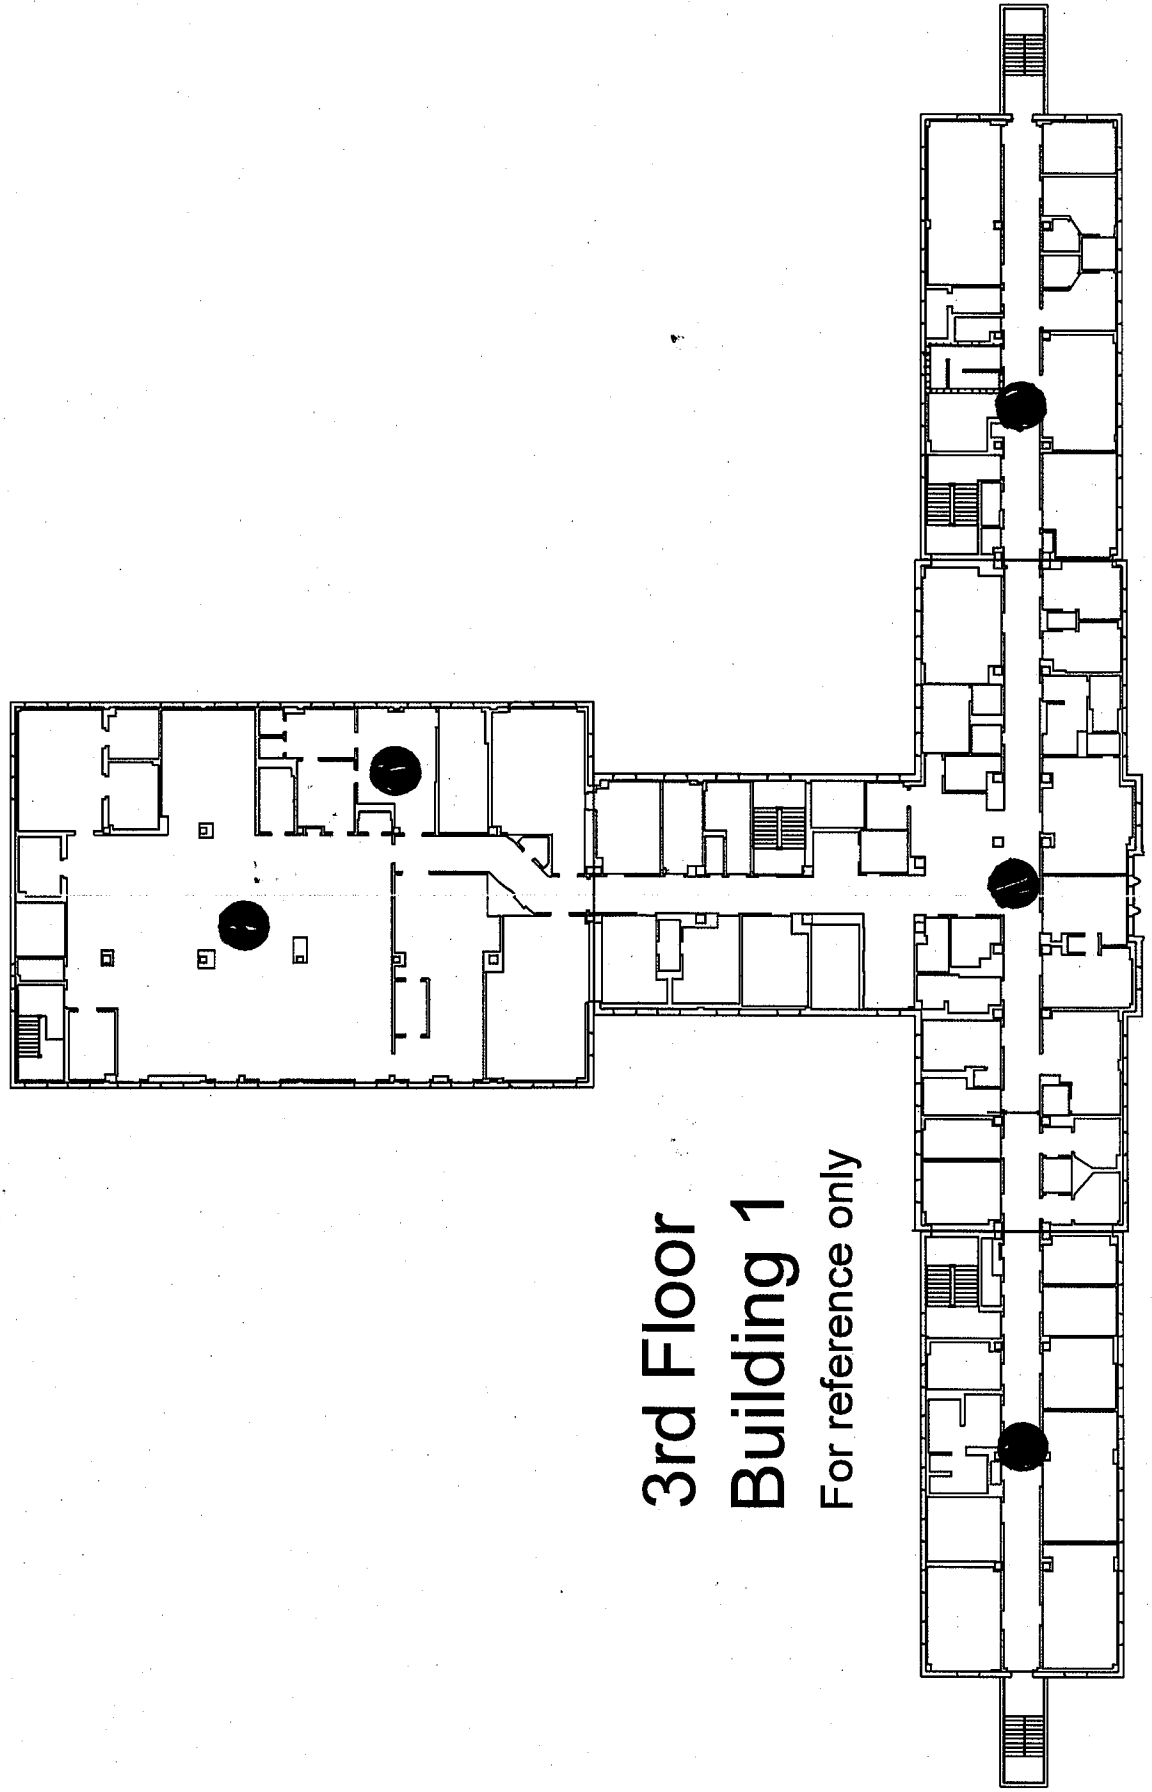


3rd Floor
Building 1
For reference only

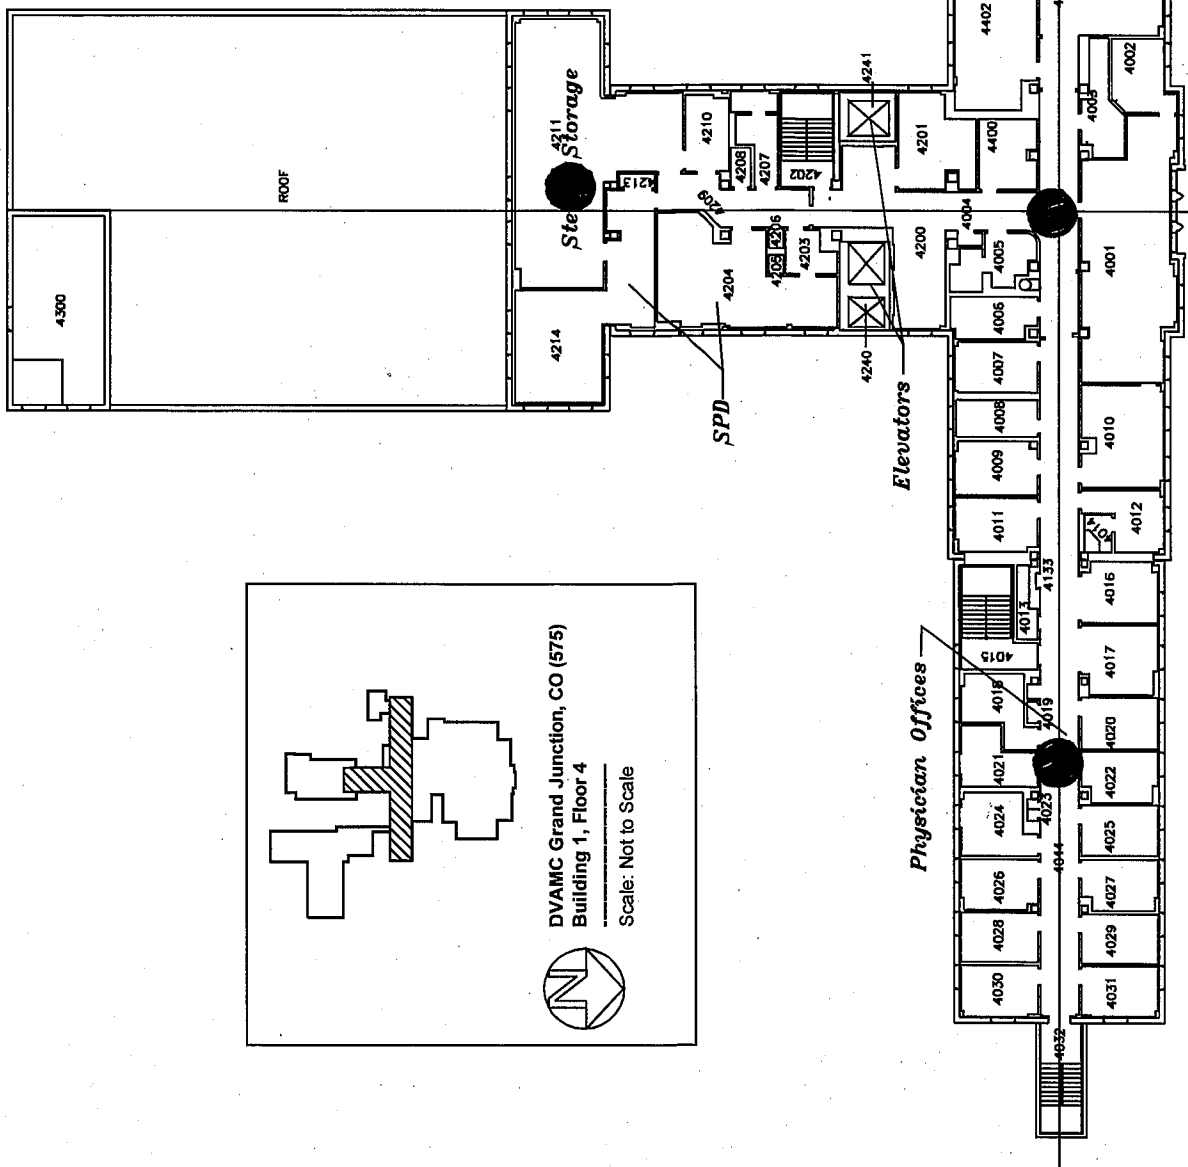


DVAMC Grand Junction, CO (575)
 Building 1, Floor 5
 Scale: Not to Scale

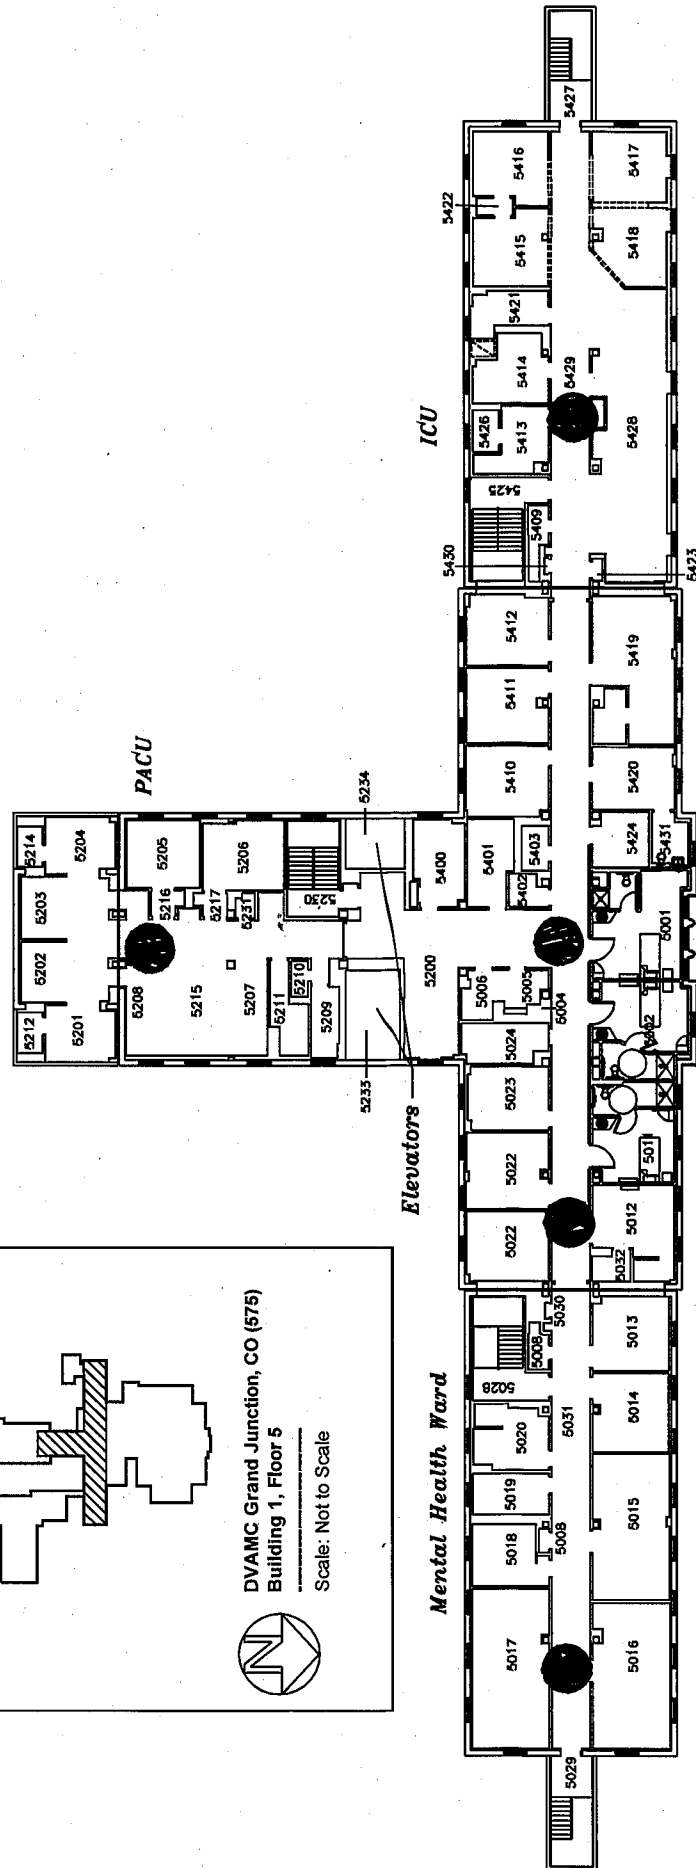


PENTHOUSE ROOM 7000-1
BUILDING 1

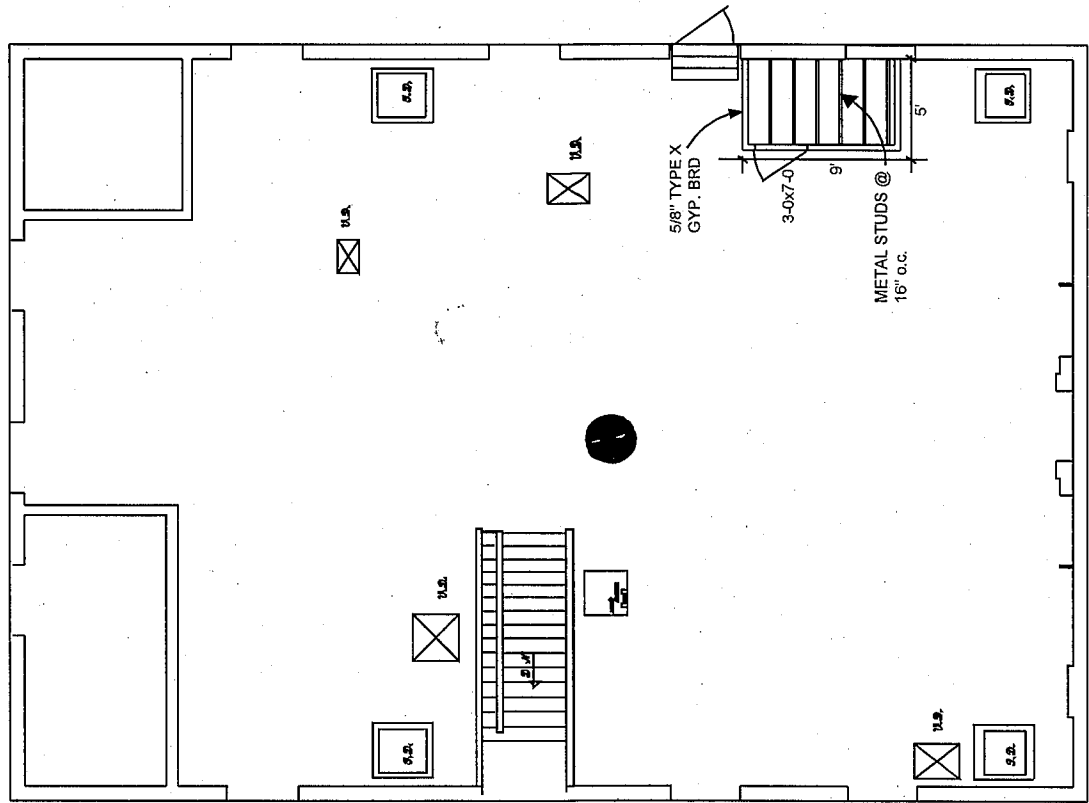


FOUNDATION

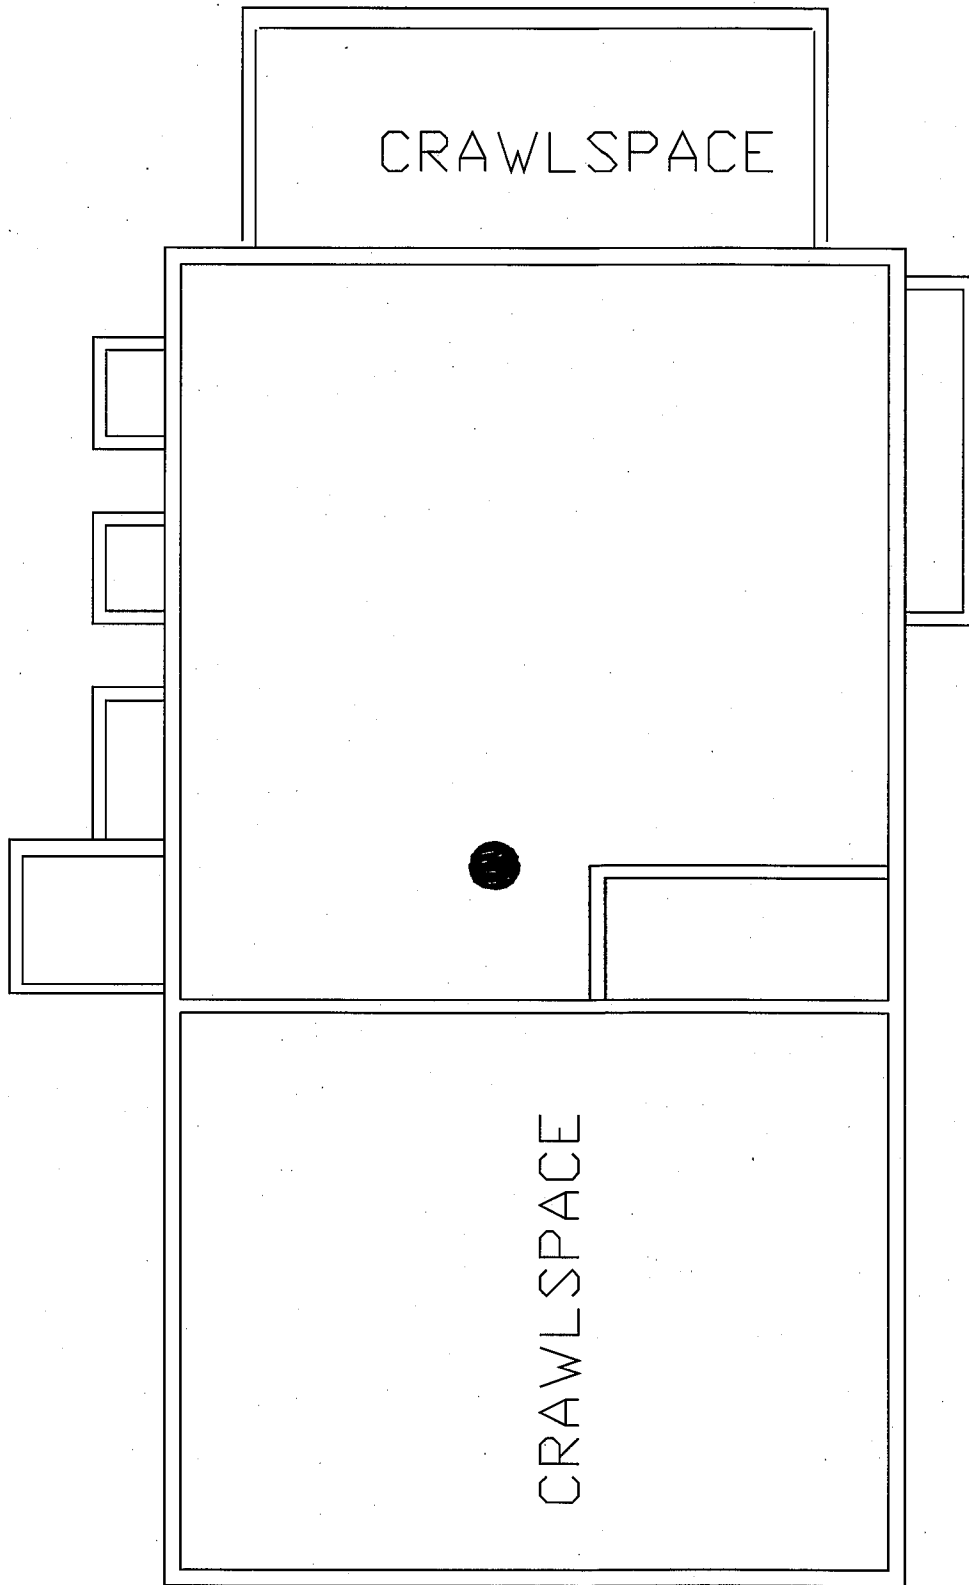

BLDG 5 BASEMENT

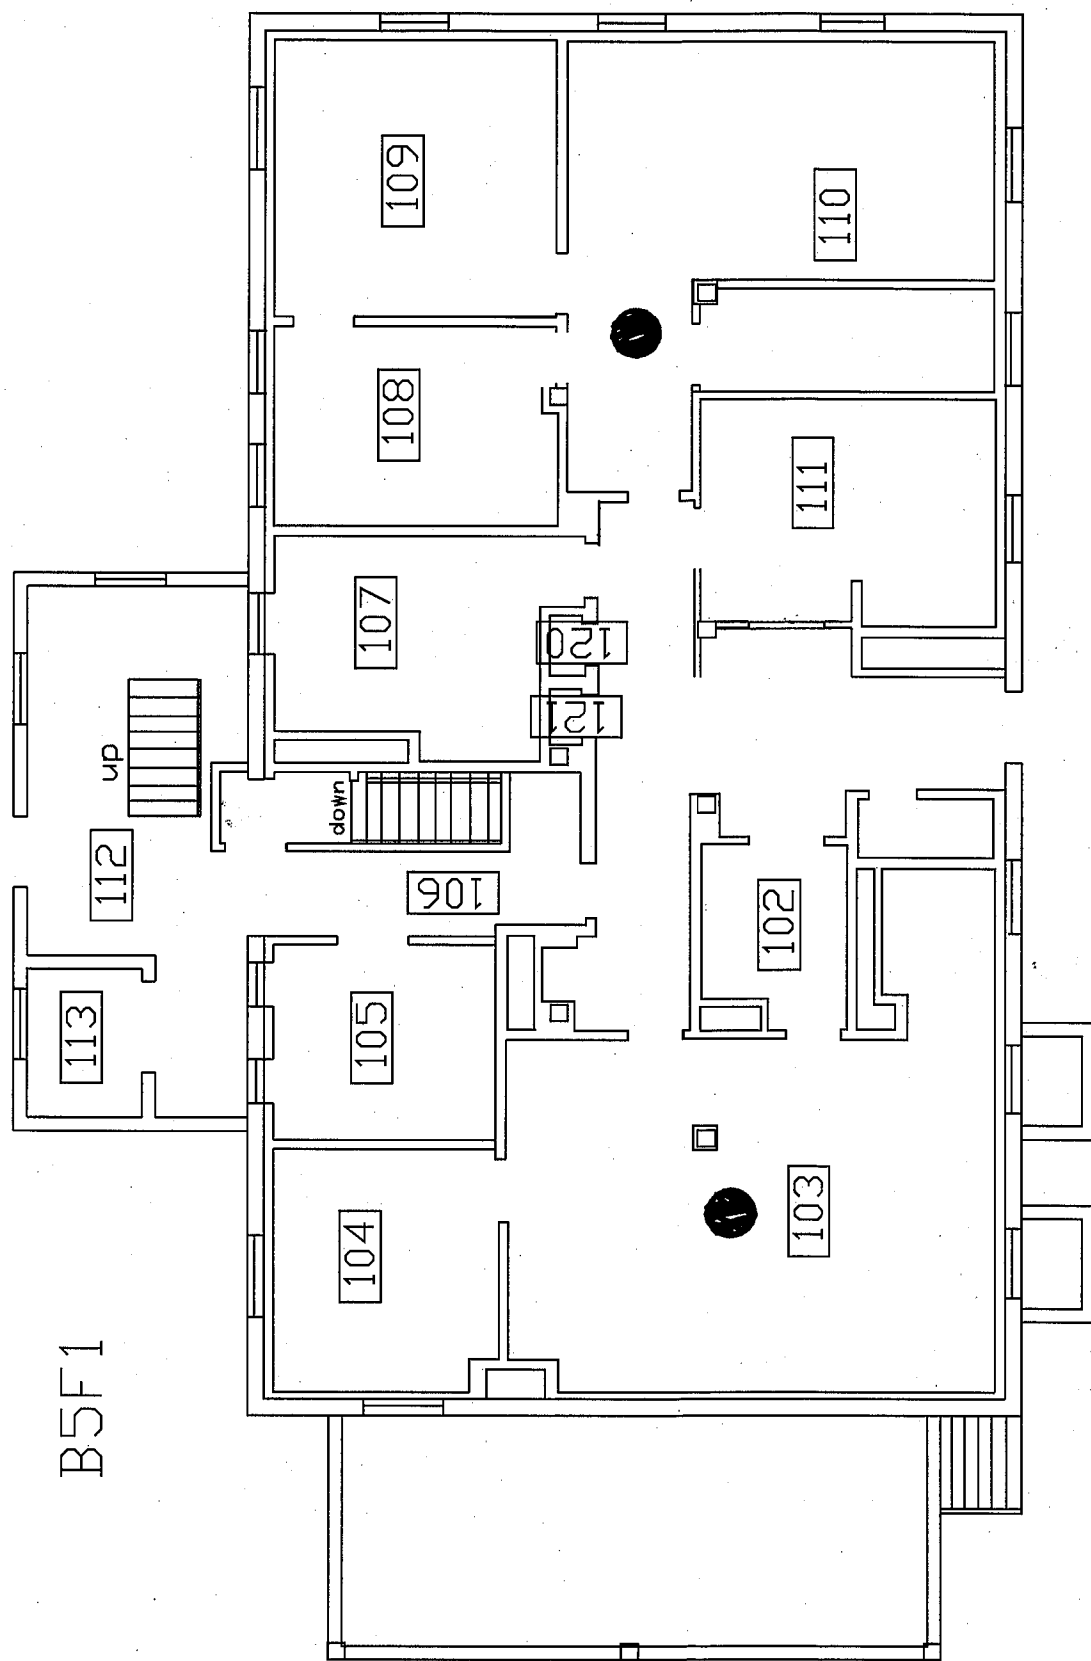



1St Floor, B-5

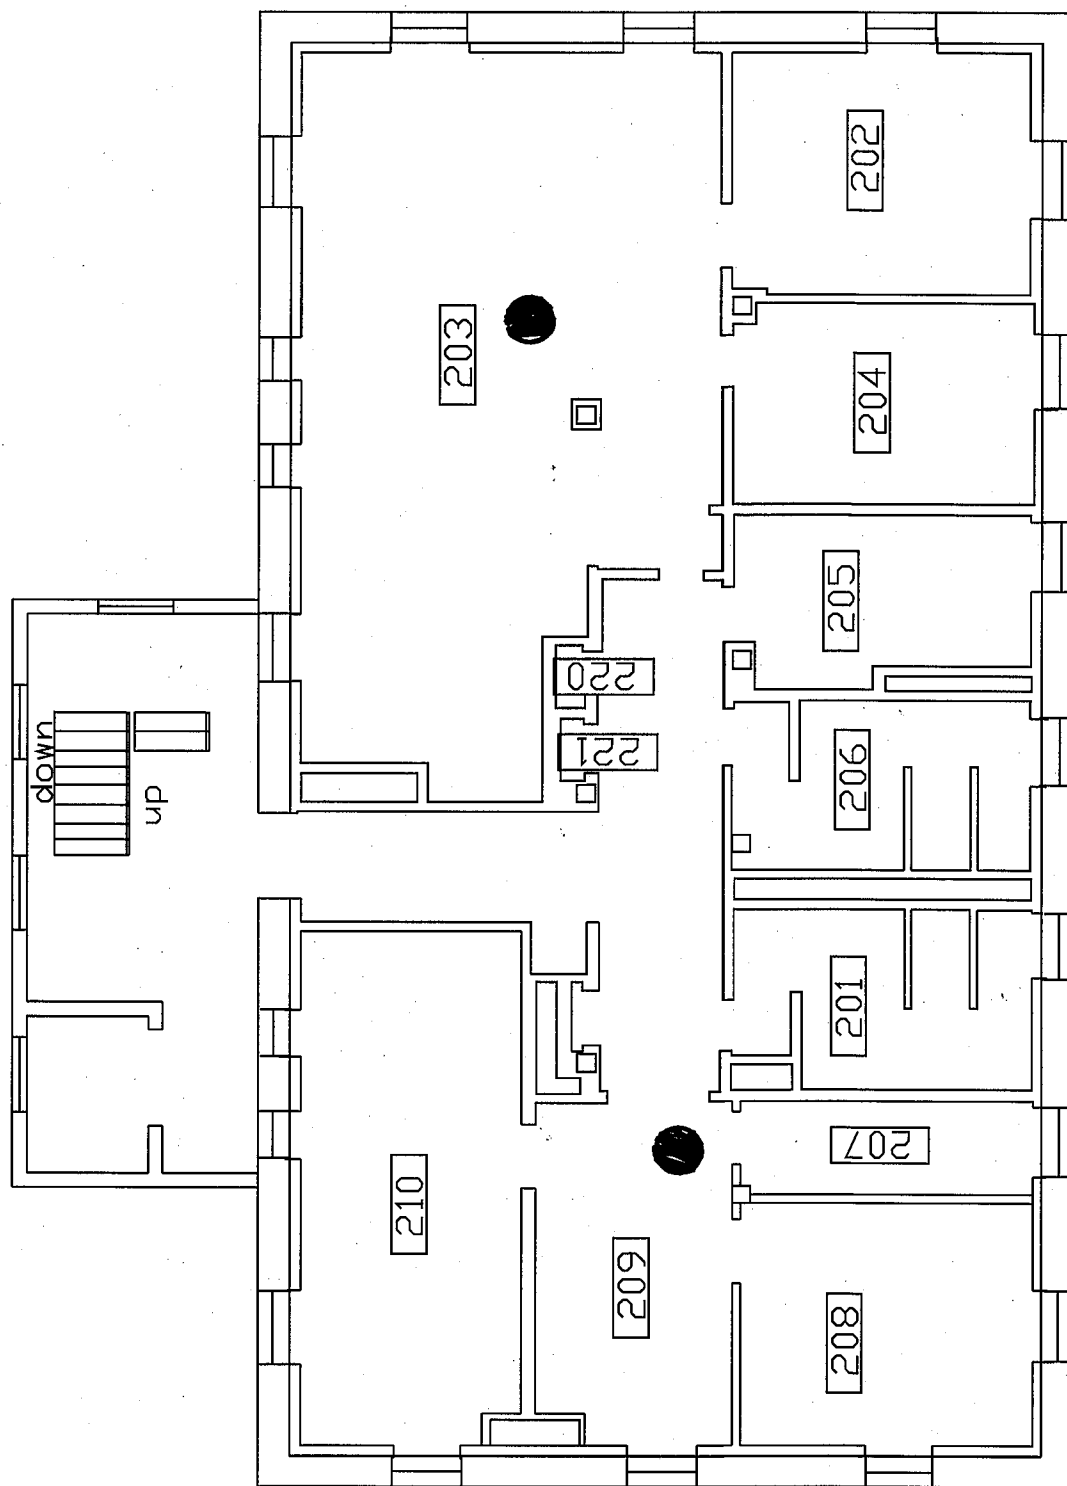

2nd Floor, B5


BUILDING 6

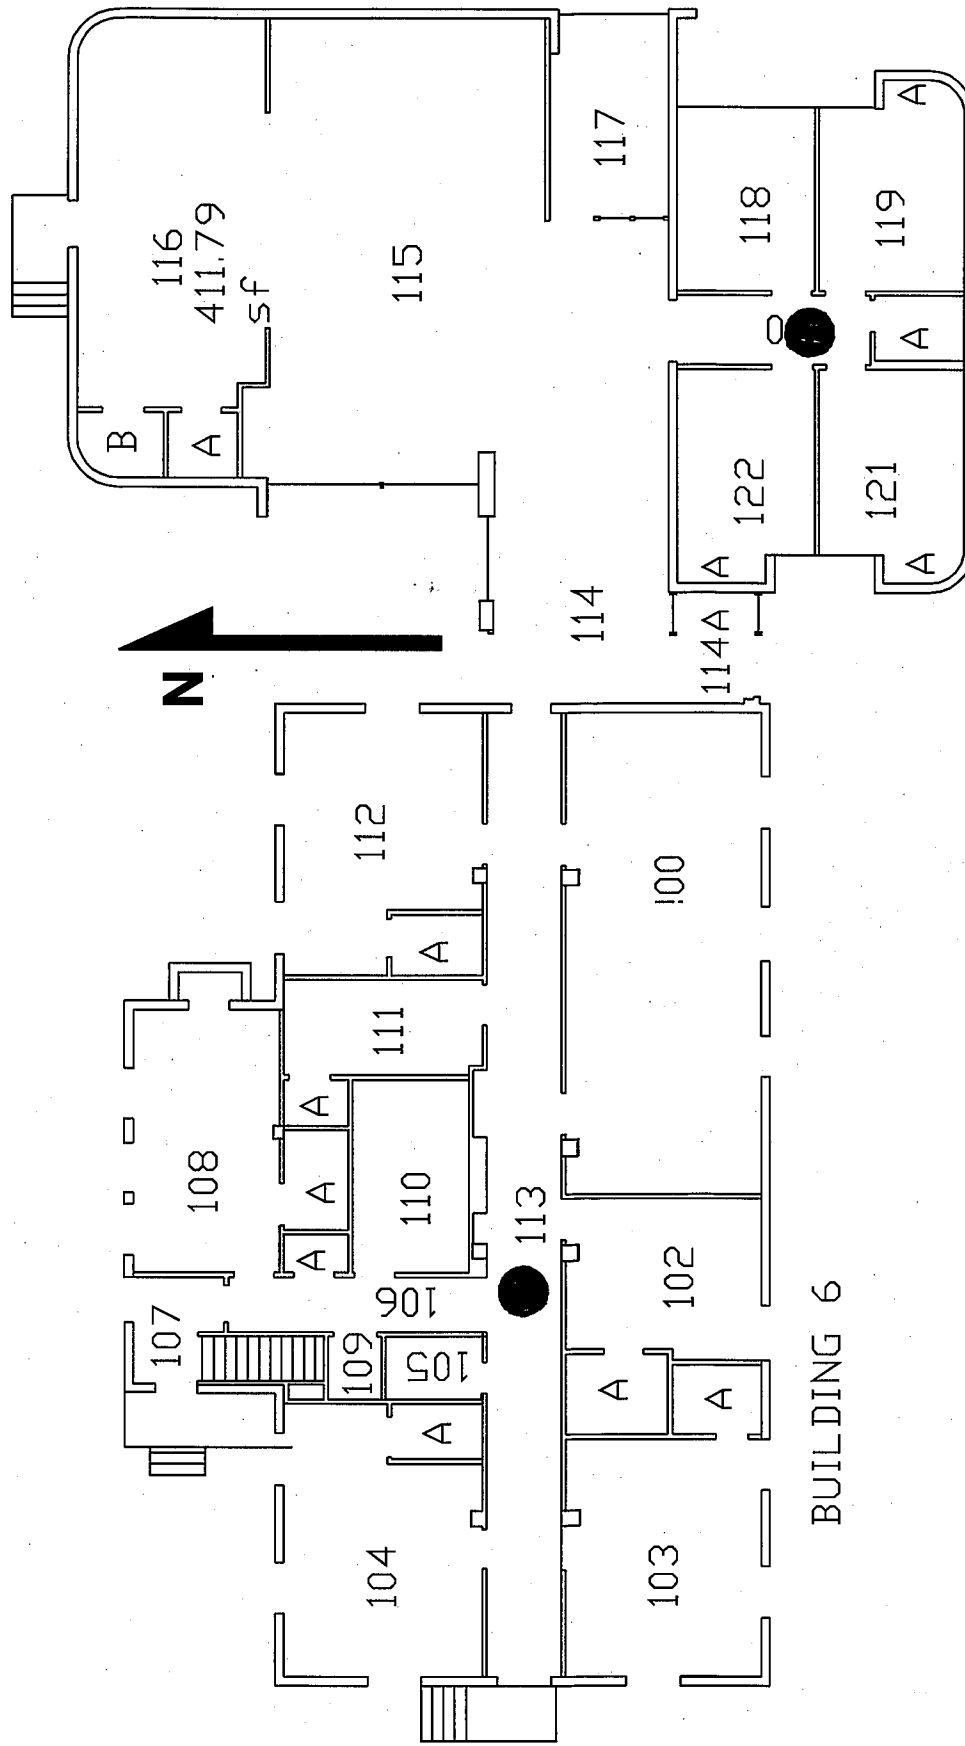

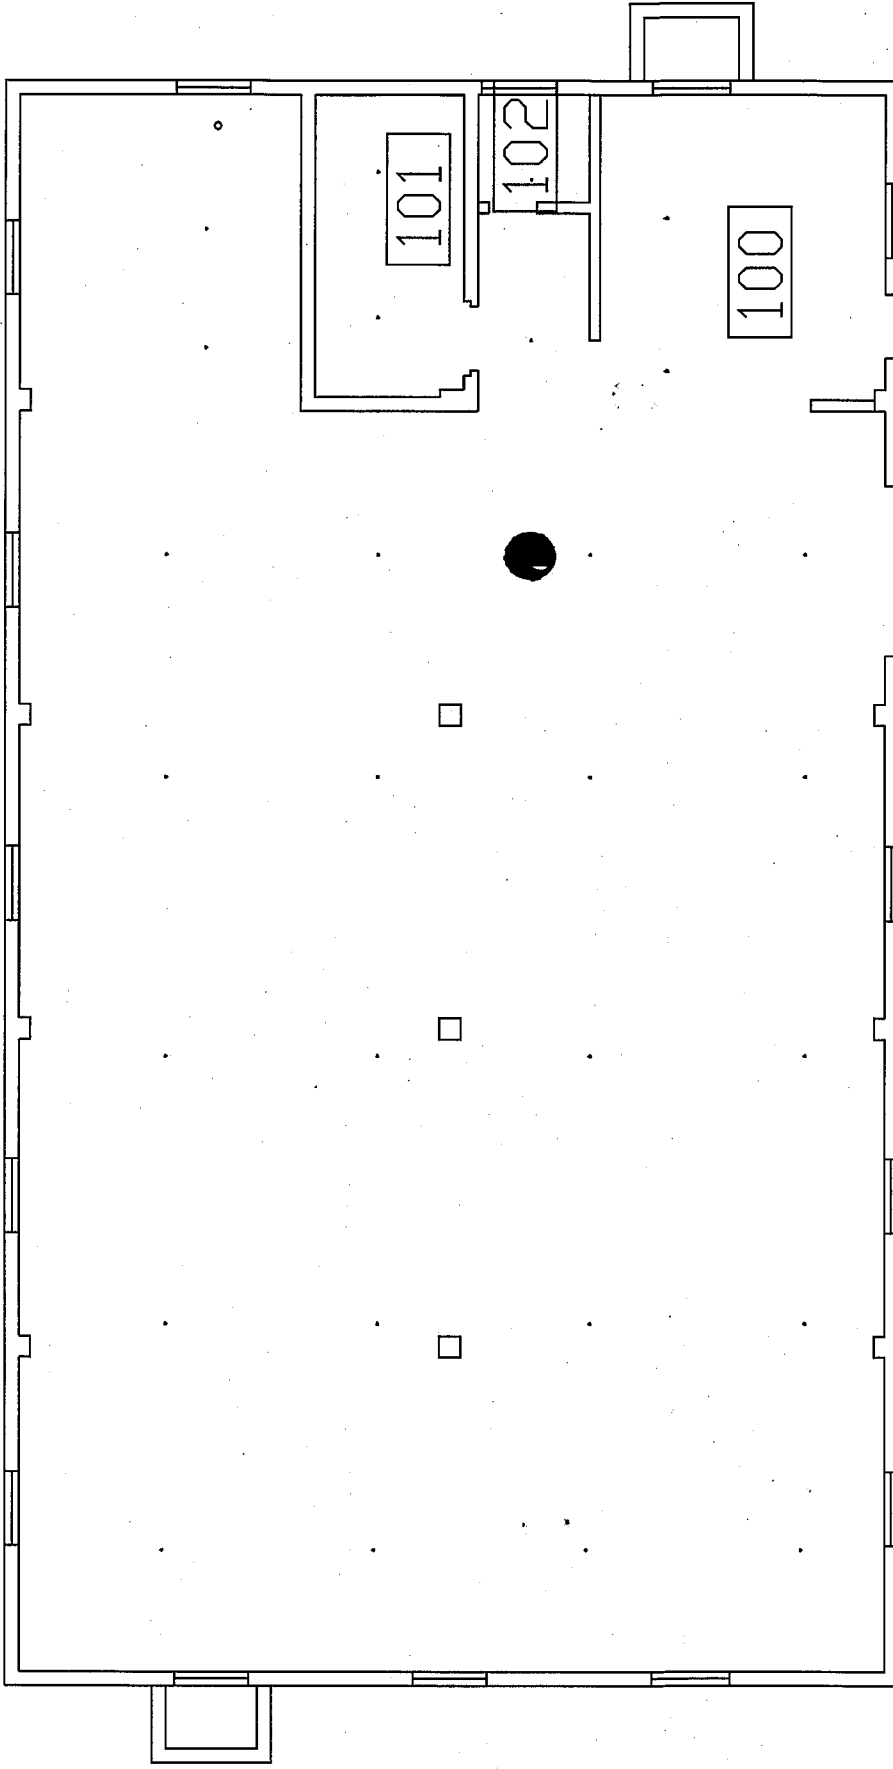


1st Floor, B7


B-8

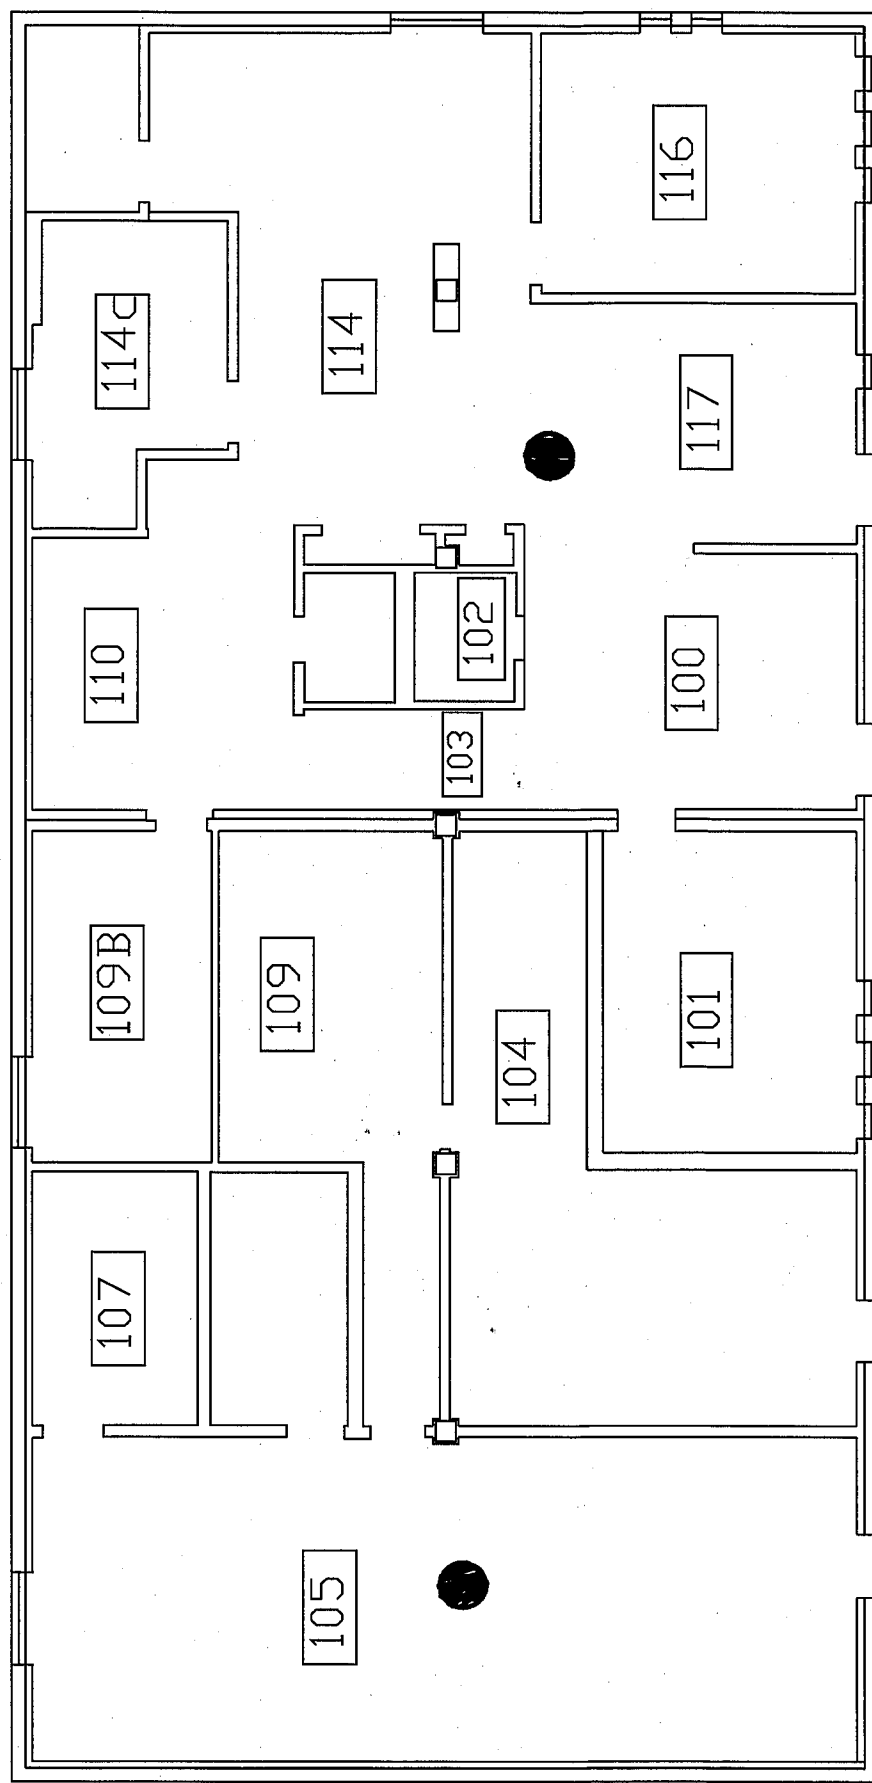

1st Floor, B8

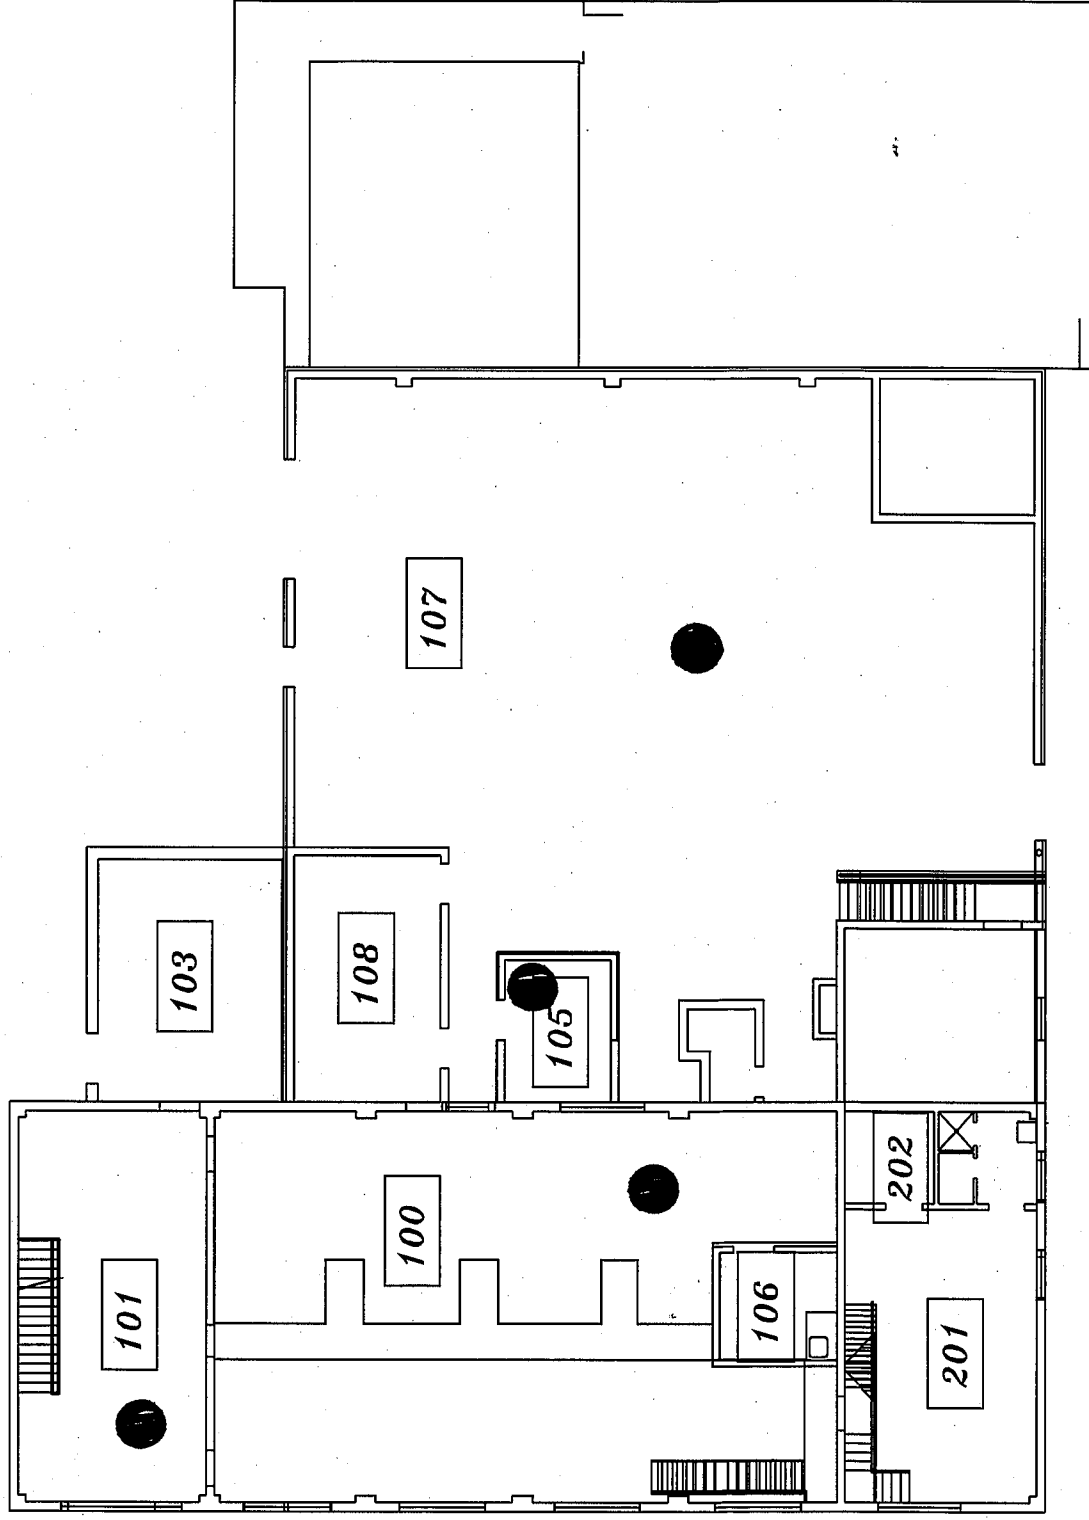


Main Floor, B9

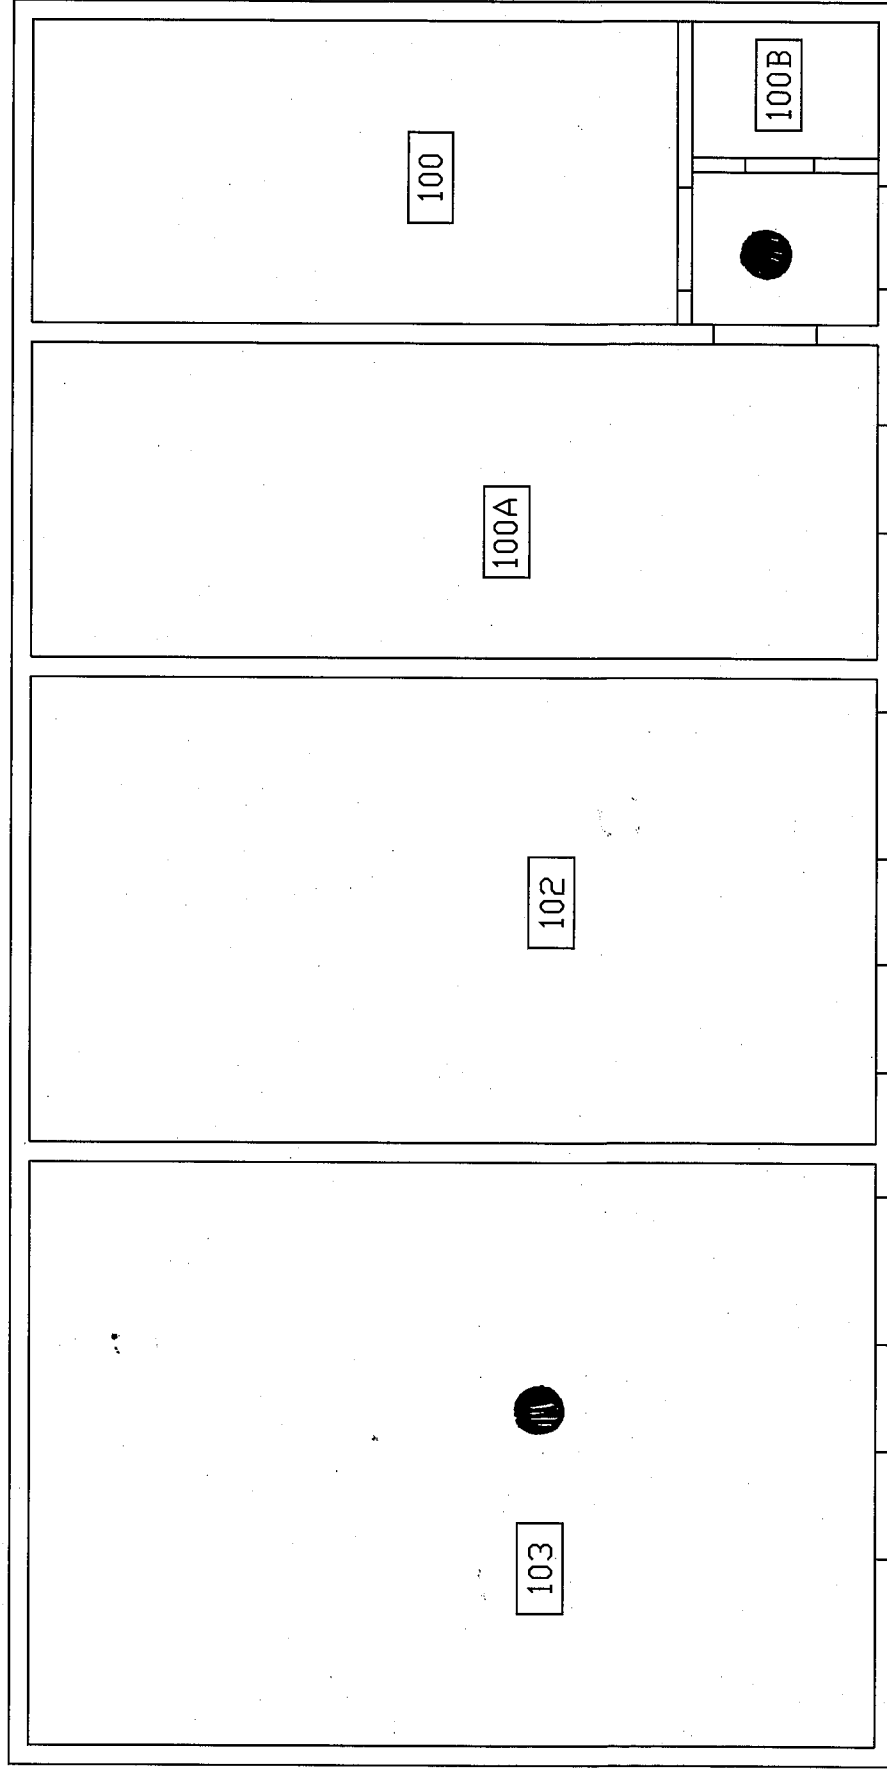

1st Floor, B12

Laundry.....4440 gsf

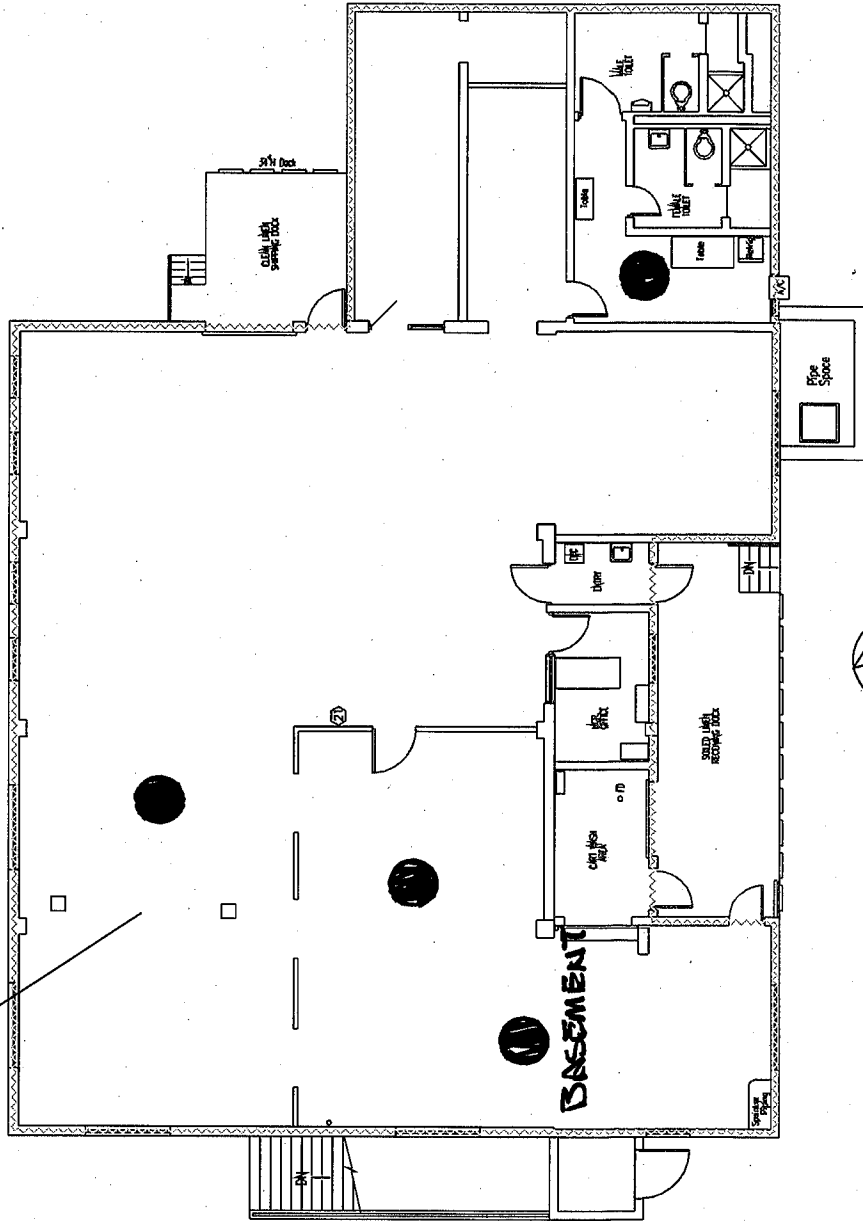

Building 13


DVAMC GrandJunction, CO (575)

Buildings 13 & 14


Scale 1/16" = 1' 0"




FIRST FLOOR MECHANICAL PLAN

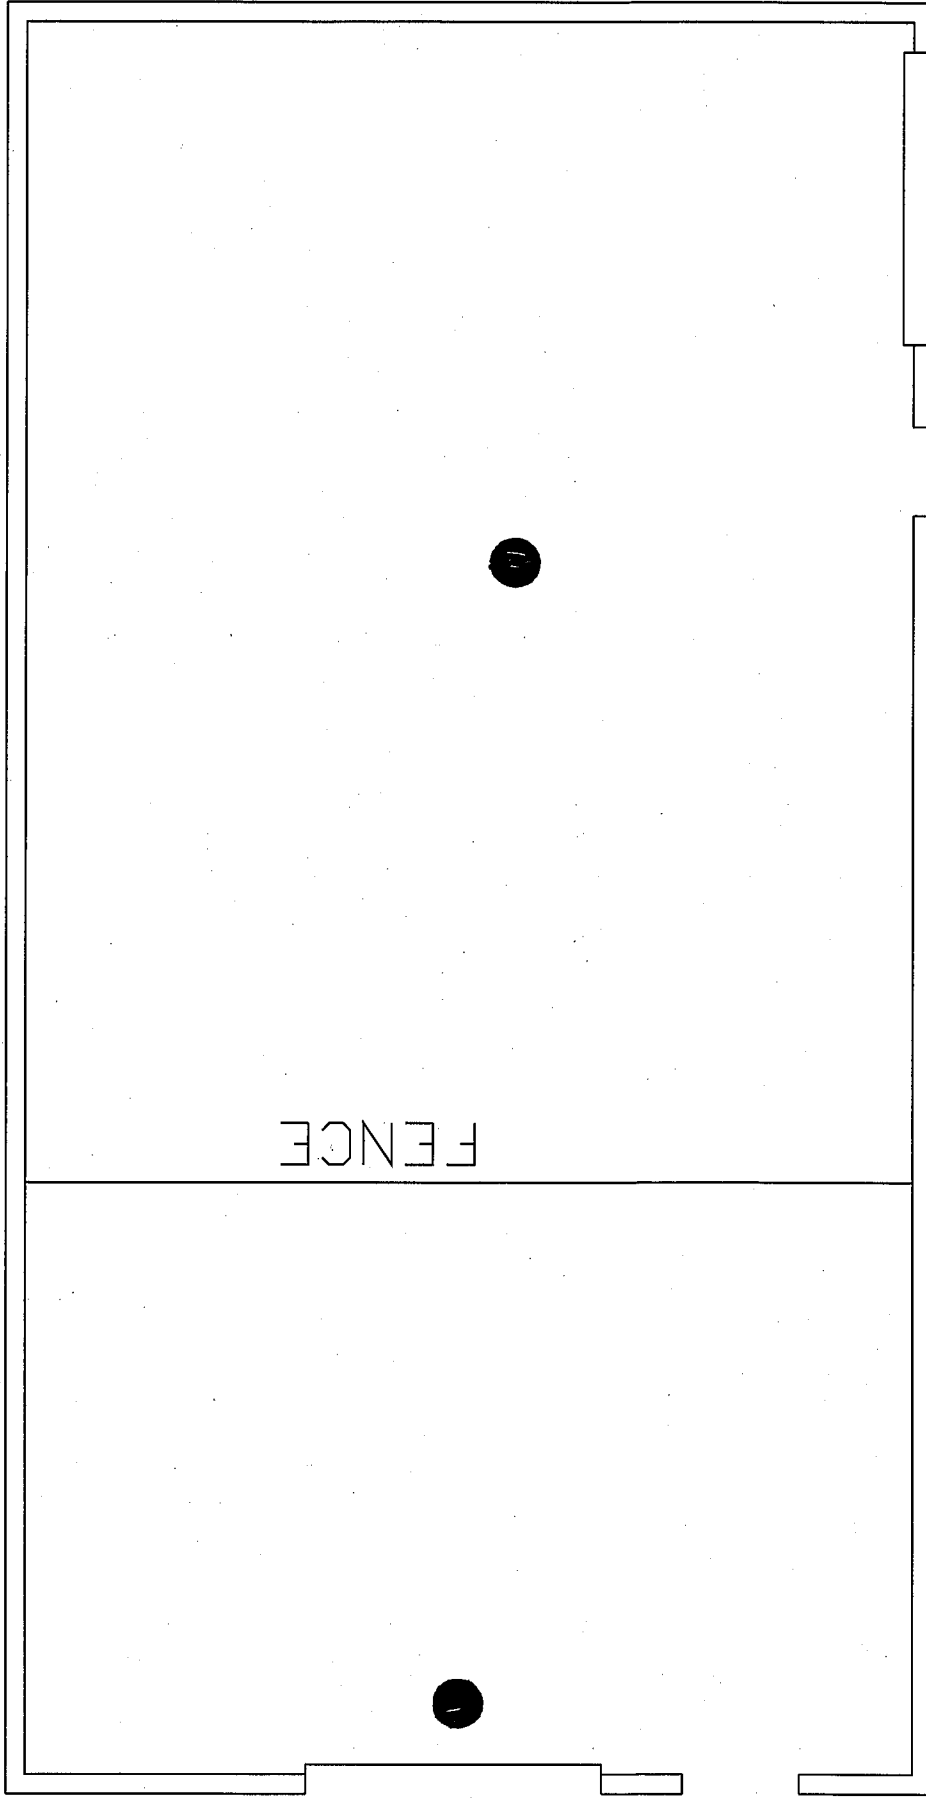


1st Floor, B22

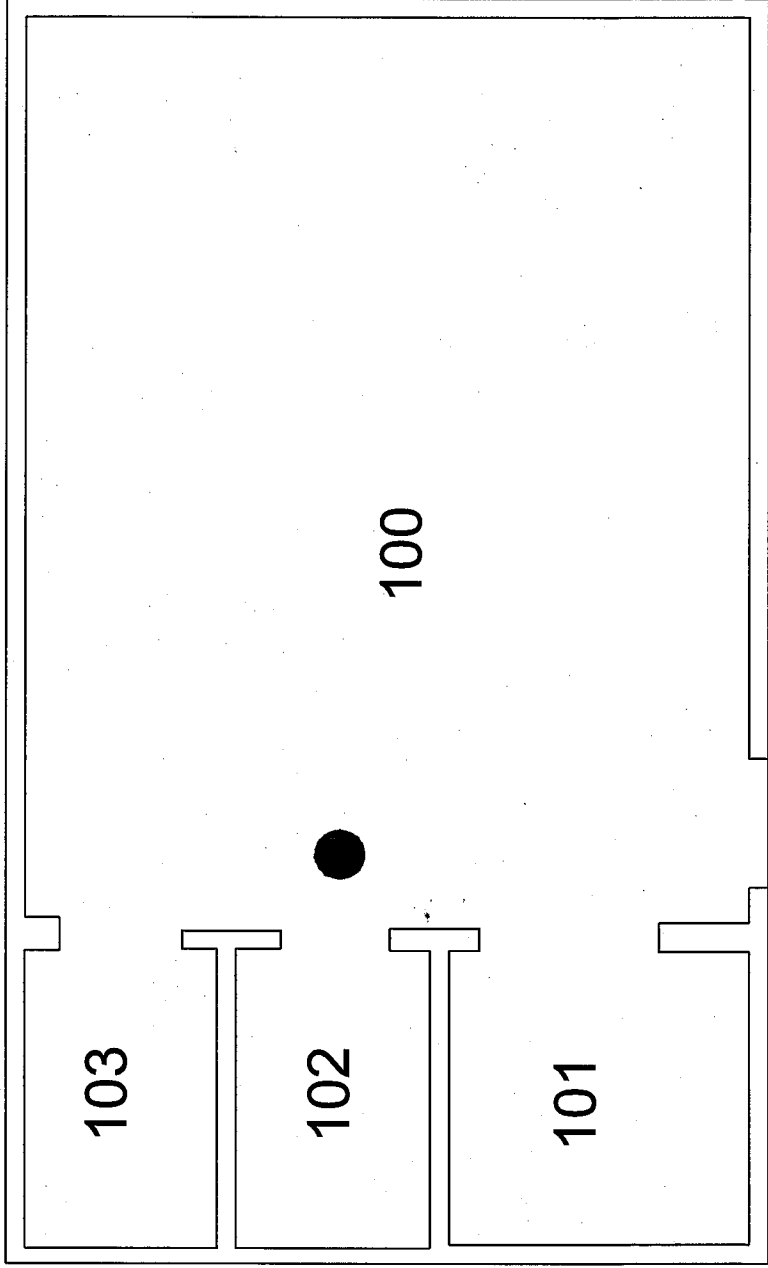


1st Floor, B33

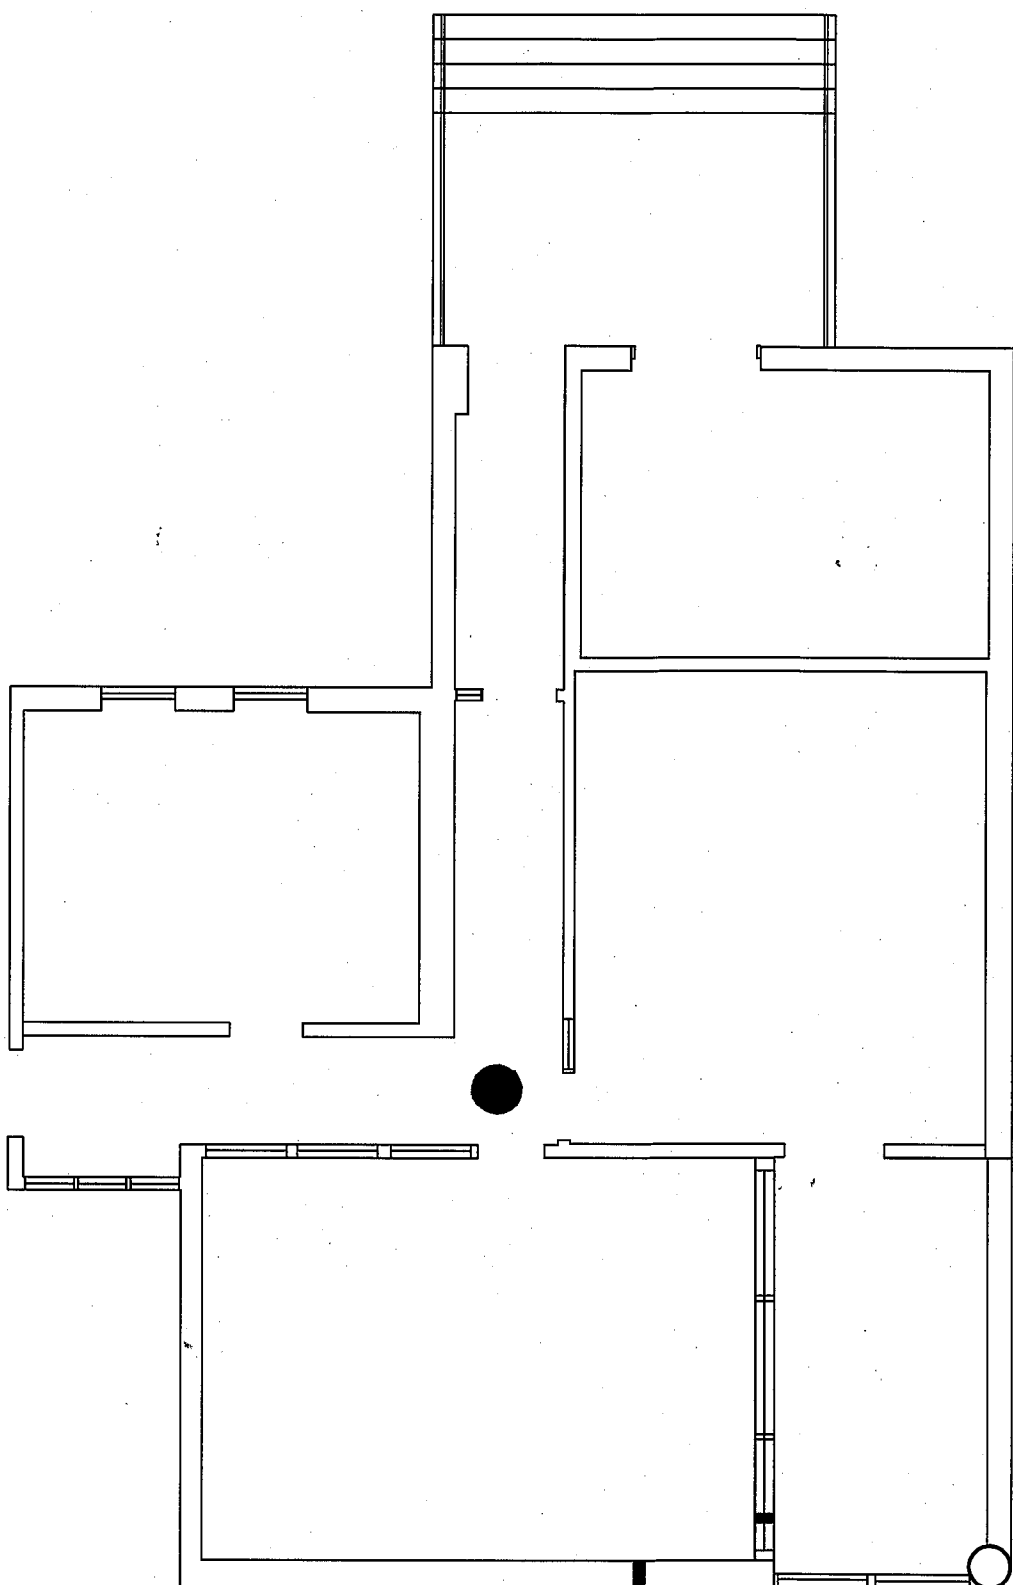

1st Floor, B34

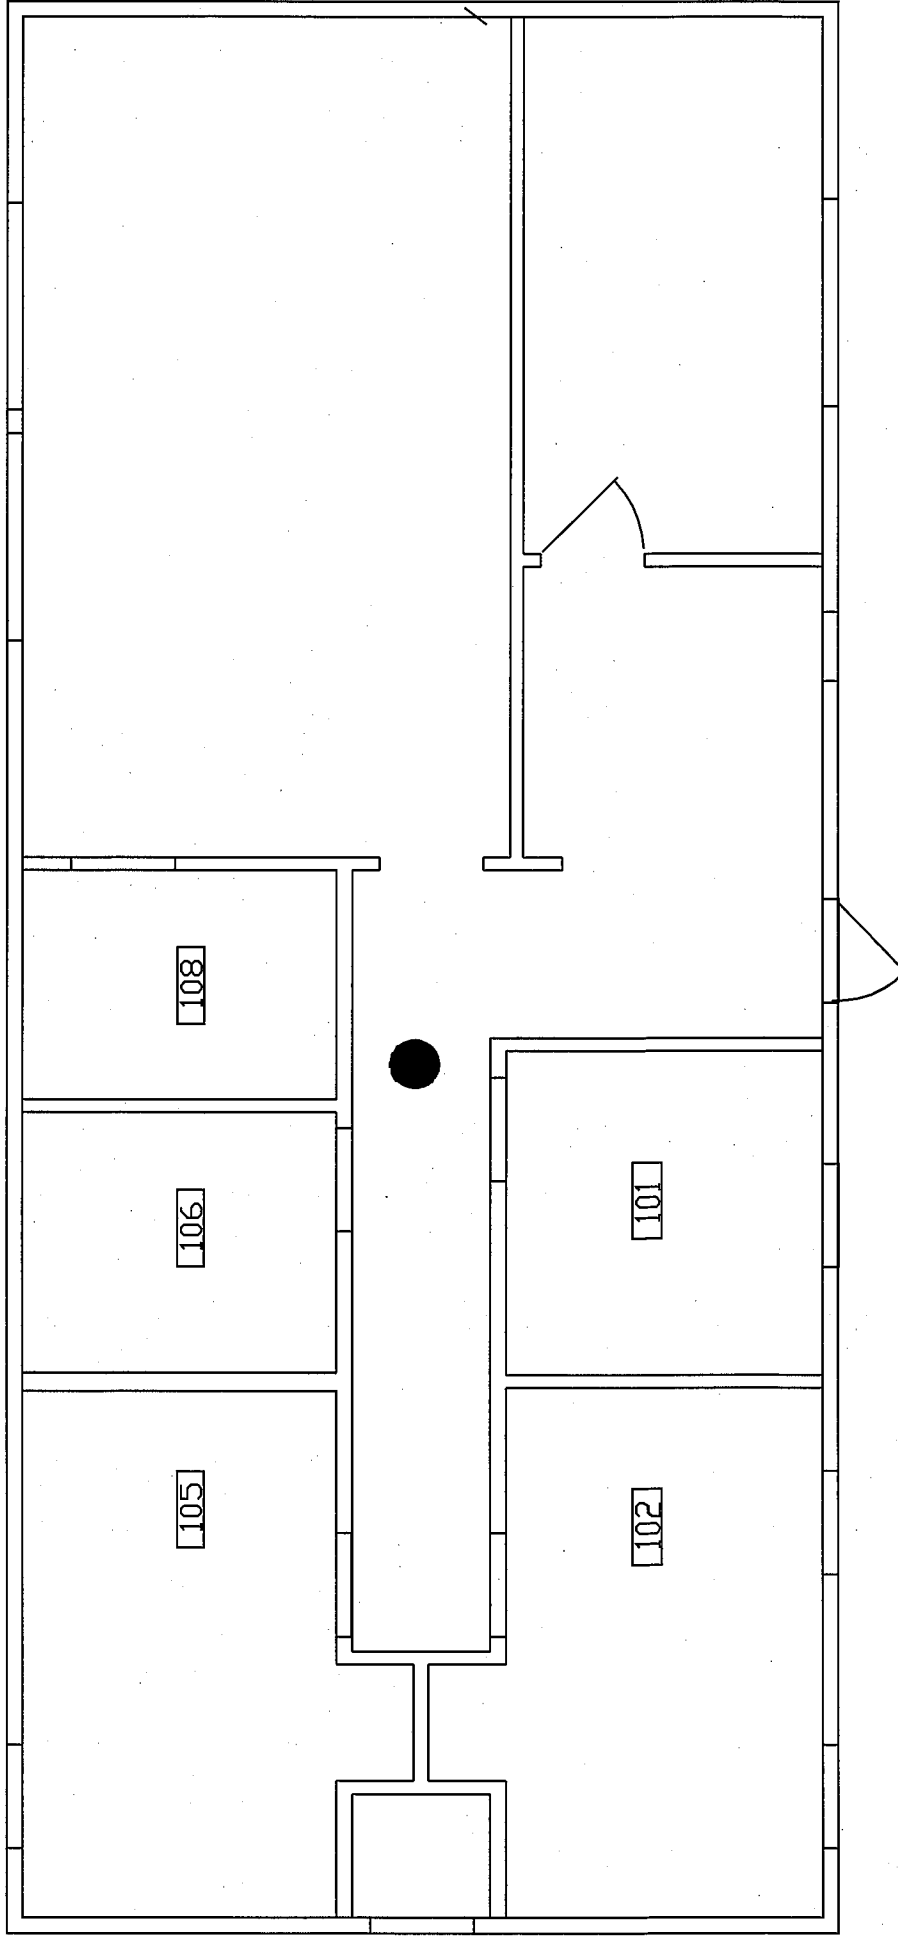


1st Floor, B35

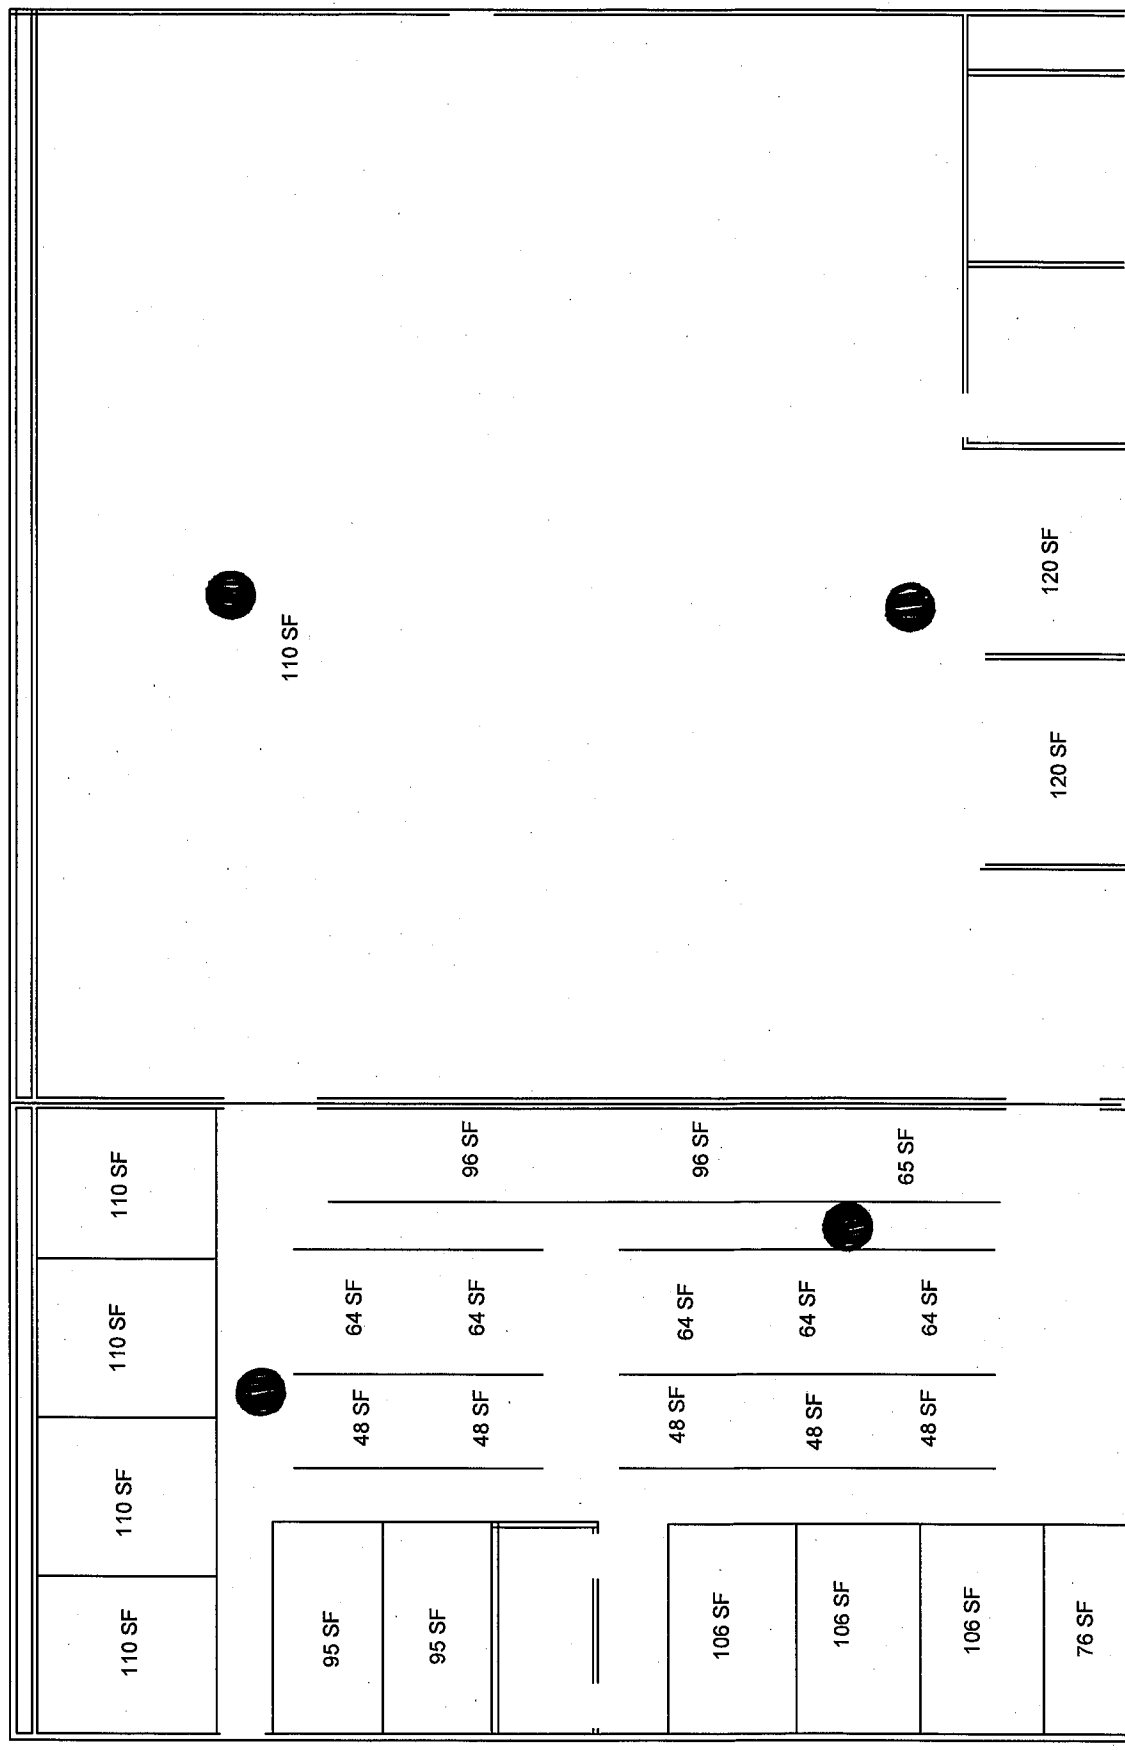

1st Floor, B36

SURGERY & RECREATION BUILDING 575-09-815 8 APRIL 2009

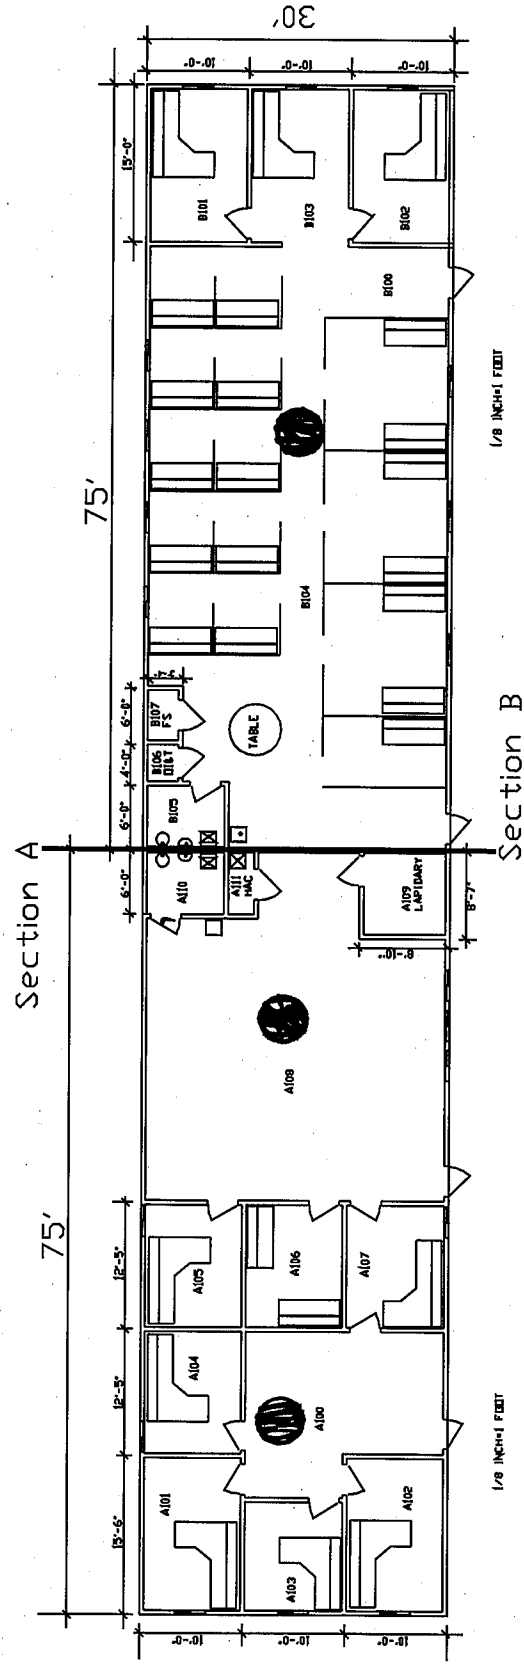

1st Floor, B37