


SITE PLAN KEYNOTES

1. ASPHALT PAVEMENT
2. CONCRETE CURB AND GUTTER
3. CONCRETE SIDEWALK
4. REPLACE TREE PER SCHEDULE BELOW
5. EXCAVATION LIMITS
6. ADA RAMP WITH TRUNCATED DOMES, SEE DETAIL SHEET CS501
7. PROVIDE TWO MECHANICAL DUCT PLUGS FOR EXISTING 4-INCH BURIED CONDUITS IN AN EXISTING MANHOLE. ONE CONDUIT IS EMPTY AND WILL REQUIRE A SOLID MECHANICAL PLUG. THE CONDUIT HAS FOUR EXISTING COMMUNICATIONS CABLES WHICH WILL NEED TO BE INCORPORATED INTO THE DESIGN OF THE SECOND MECHANICAL PLUG WHEN ORDERING BOTH PRODUCTS. INCLUDE LABOR, MATERIAL, AND EQUIPMENT COST IN THE BID TO PHYSICALLY SURVEY THE MANHOLE CONTAINING THESE TWO CONDUITS, WHICH IS REQUIRED TO OBTAIN EXACT OUTSIDE DIAMETER OF EACH CABLE AND THE EXACT INSIDE DIAMETER OF THE CONDUITS. PROVIDE SUBMITTAL FOR SELECTED PRODUCT IN ACCORDANCE WITH 01 33 23 SHOP DRAWINGS.

TREE REPLACEMENT SCHEDULE

| ID# | Mitigation DBH (inches) | Species |
|-----|-------------------------|--------------|
| 4A | 6" | WHITE ASH |
| 4B | 4" | BLACK OAK |
| 4C | 6" | WHITE OAK |
| 4D | 6" | WHITE SPRUCE |
| 4E | 6" | WHITE SPRUCE |

CONTRACTOR TO PROTECT EXISTING UTILITIES (TYP)

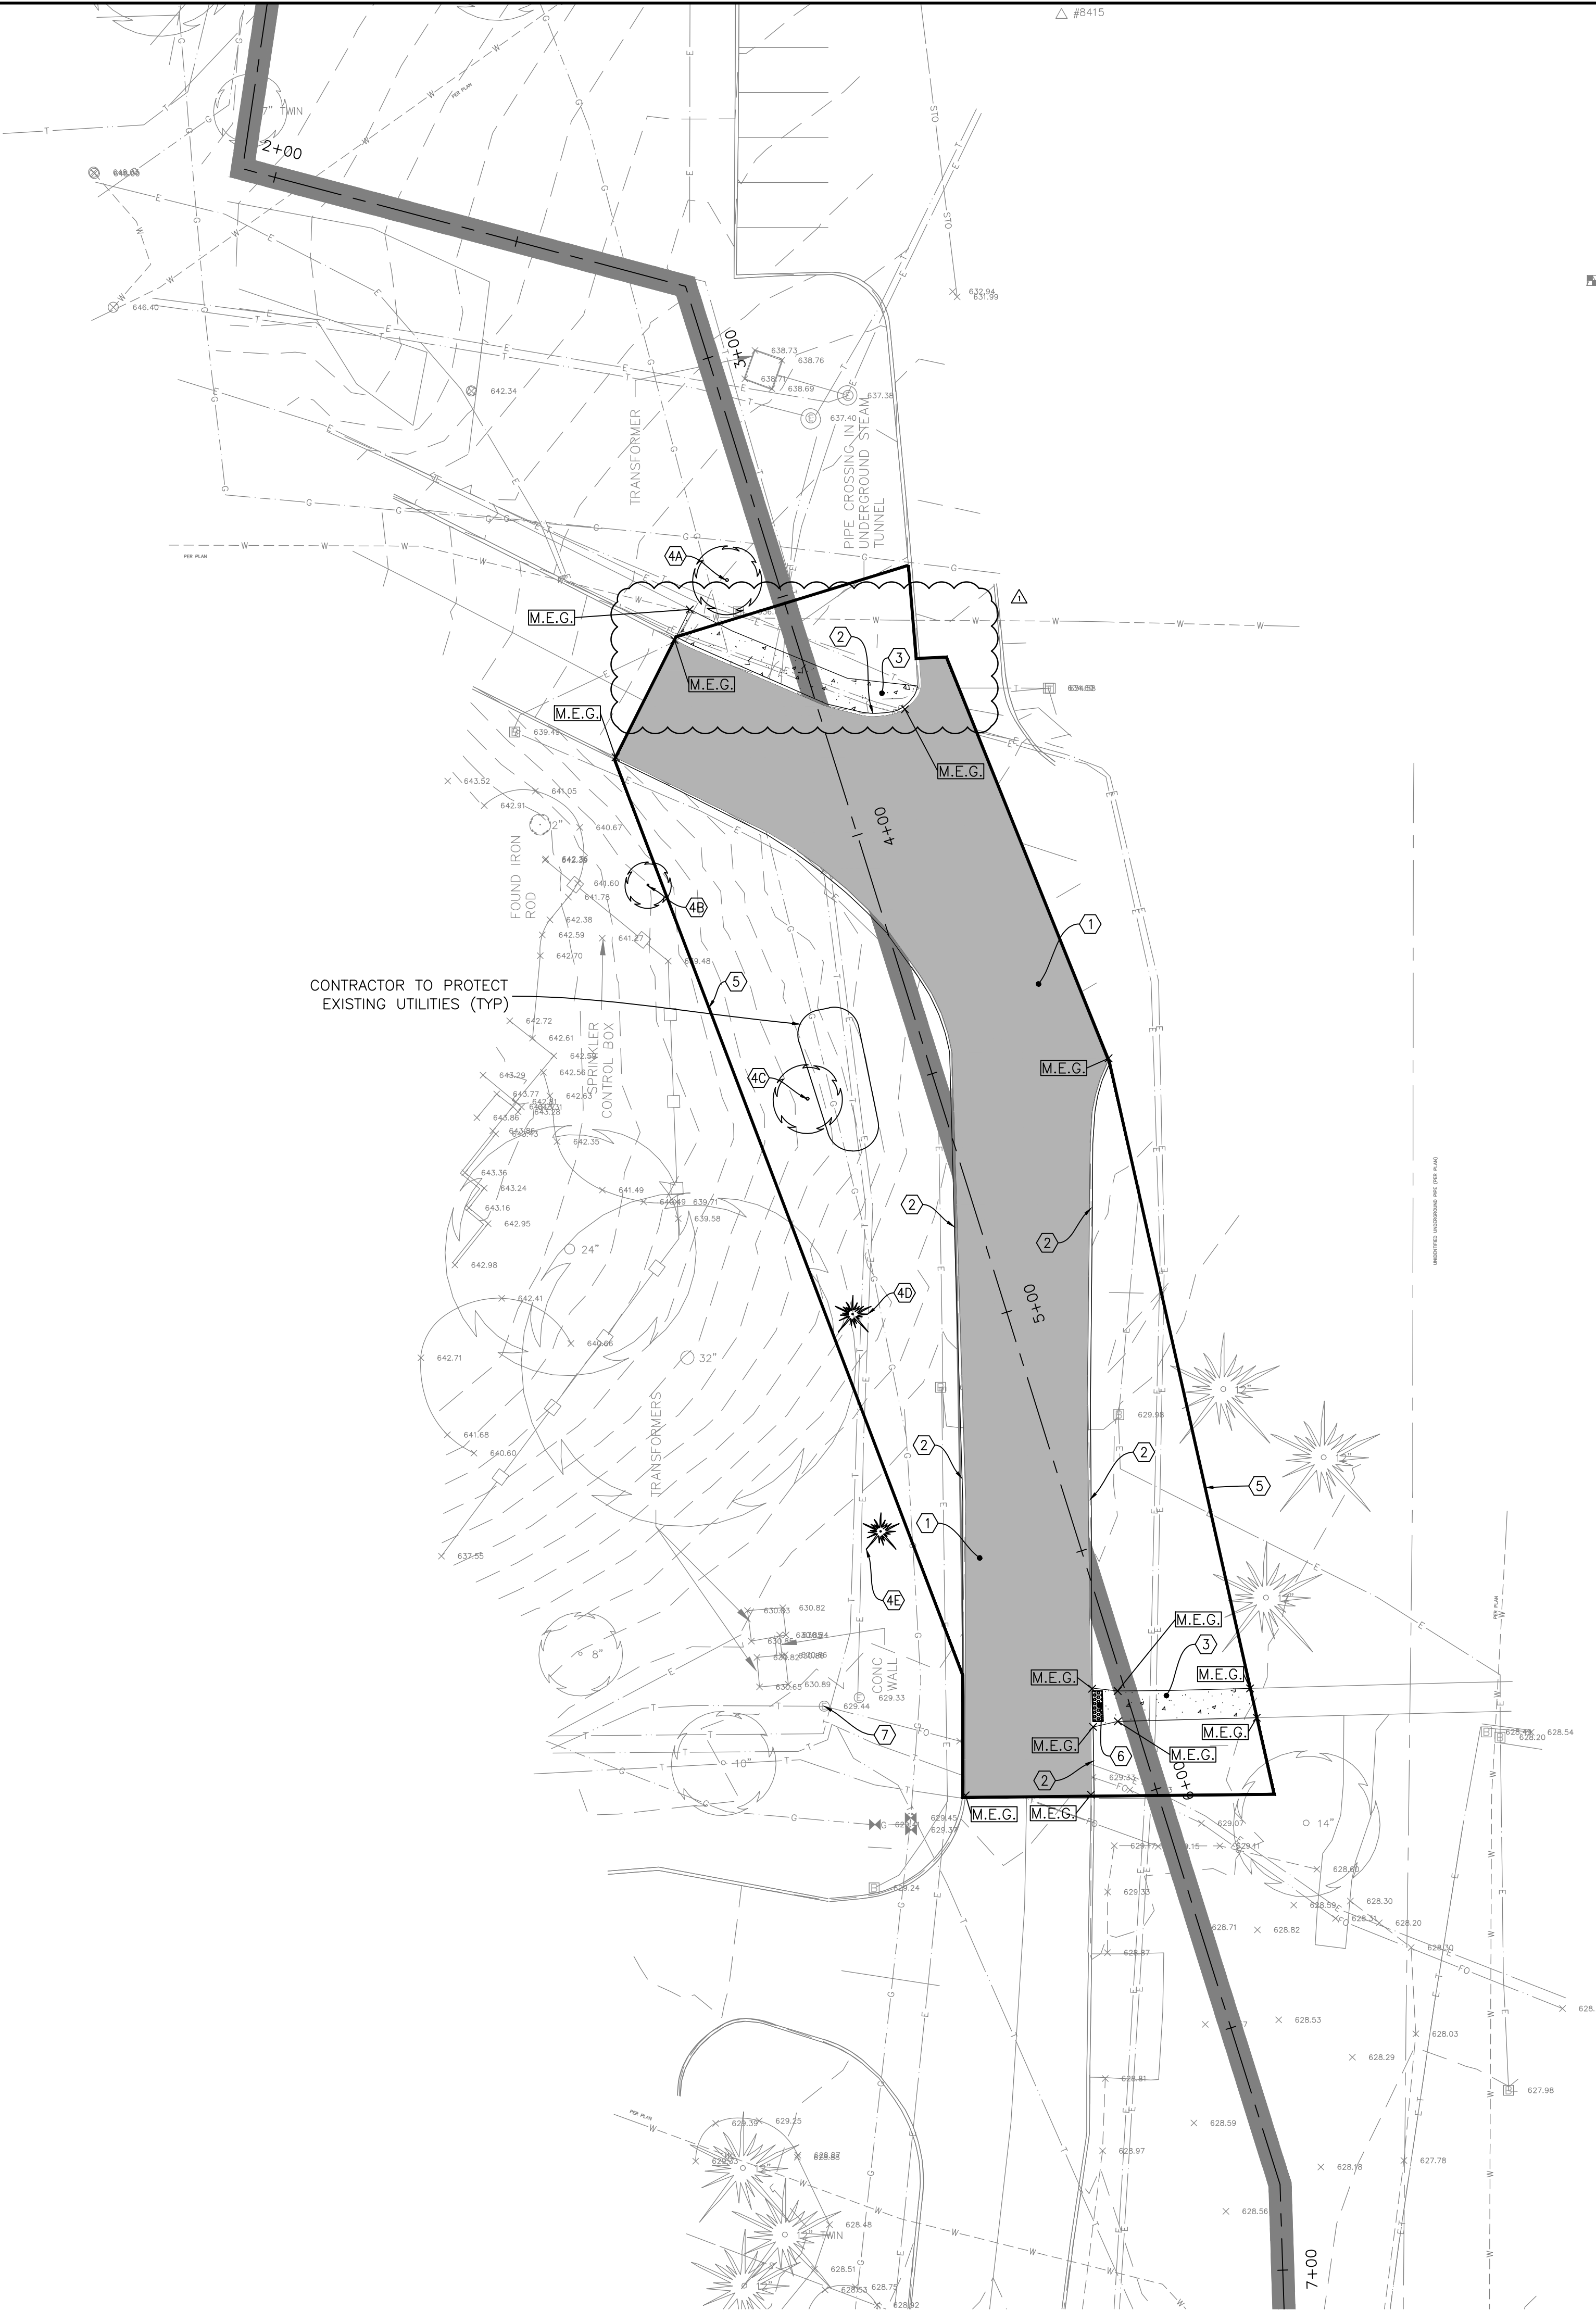

A
B
C
D
E
F

A
B
C
D
E
F

| | | | | | | | | | | | | |
|--|---|--|--------------|--|--|--|--|---|--|--|--|--|
| | <p>CONSULTANT</p> <p>Consultant: RING & DuCHATEAU LLP 17400 W. CAPITOL DRIVE BROOKFIELD, WI 53045 (414) 778-1700</p> | <p>ARCHITECT/ENGINEER OF RECORD</p> <p>A/E: PROJECT LEAD Architect, Structural Engineer, Civil Engineer</p> <p>GUIDON DESIGN</p> <p>905 N. CAPITOL AVE., SUITE 100 INDIANAPOLIS, IN 46204 317.800.6388 WWW.GUIDONDESIGN.COM SUSTAINABLE ARCHITECTURE + ENGINEERING</p> | <p>STAMP</p> | <p>Office of Construction and Facilities Management</p> <p>VA U.S. Department of Veterans Affairs</p> | <p>Drawing Title SITE PLAN</p> <p>Approved: JIM BEIER, COR, VAMC</p> | <p>Phase 100% BID SET</p> <p>NON-SPRINKLERED</p> | <p>Project Title REPAIR CAMPUS STEAM TUNNEL AND STRUCTURAL SUPPORTS</p> <p>Location MILWAUKEE VAMC</p> | <p>Project Number 695-17-119</p> <p>Building Number BLDG 112</p> <p>Drawing Number CS101</p> | | | | |
| <p>Revisions:</p> <table border="1" style="width: 100%; border-collapse: collapse;"> <tr> <td style="width: 80%;">Amendment 5</td> <td style="width: 20%;">1/29/2018</td> </tr> <tr> <td> </td> <td>Date: </td> </tr> </table> | Amendment 5 | 1/29/2018 | | Date: | | | | | | | | |
| Amendment 5 | 1/29/2018 | | | | | | | | | | | |
| | Date: | | | | | | | | | | | |