



C:\Users\VFABANWIGHTS\appdata\local\temp\AcPublish\_4080\B78 Water Monitoring.dwg 1-08-18 12:36:12 PM VFABANWIGHTS

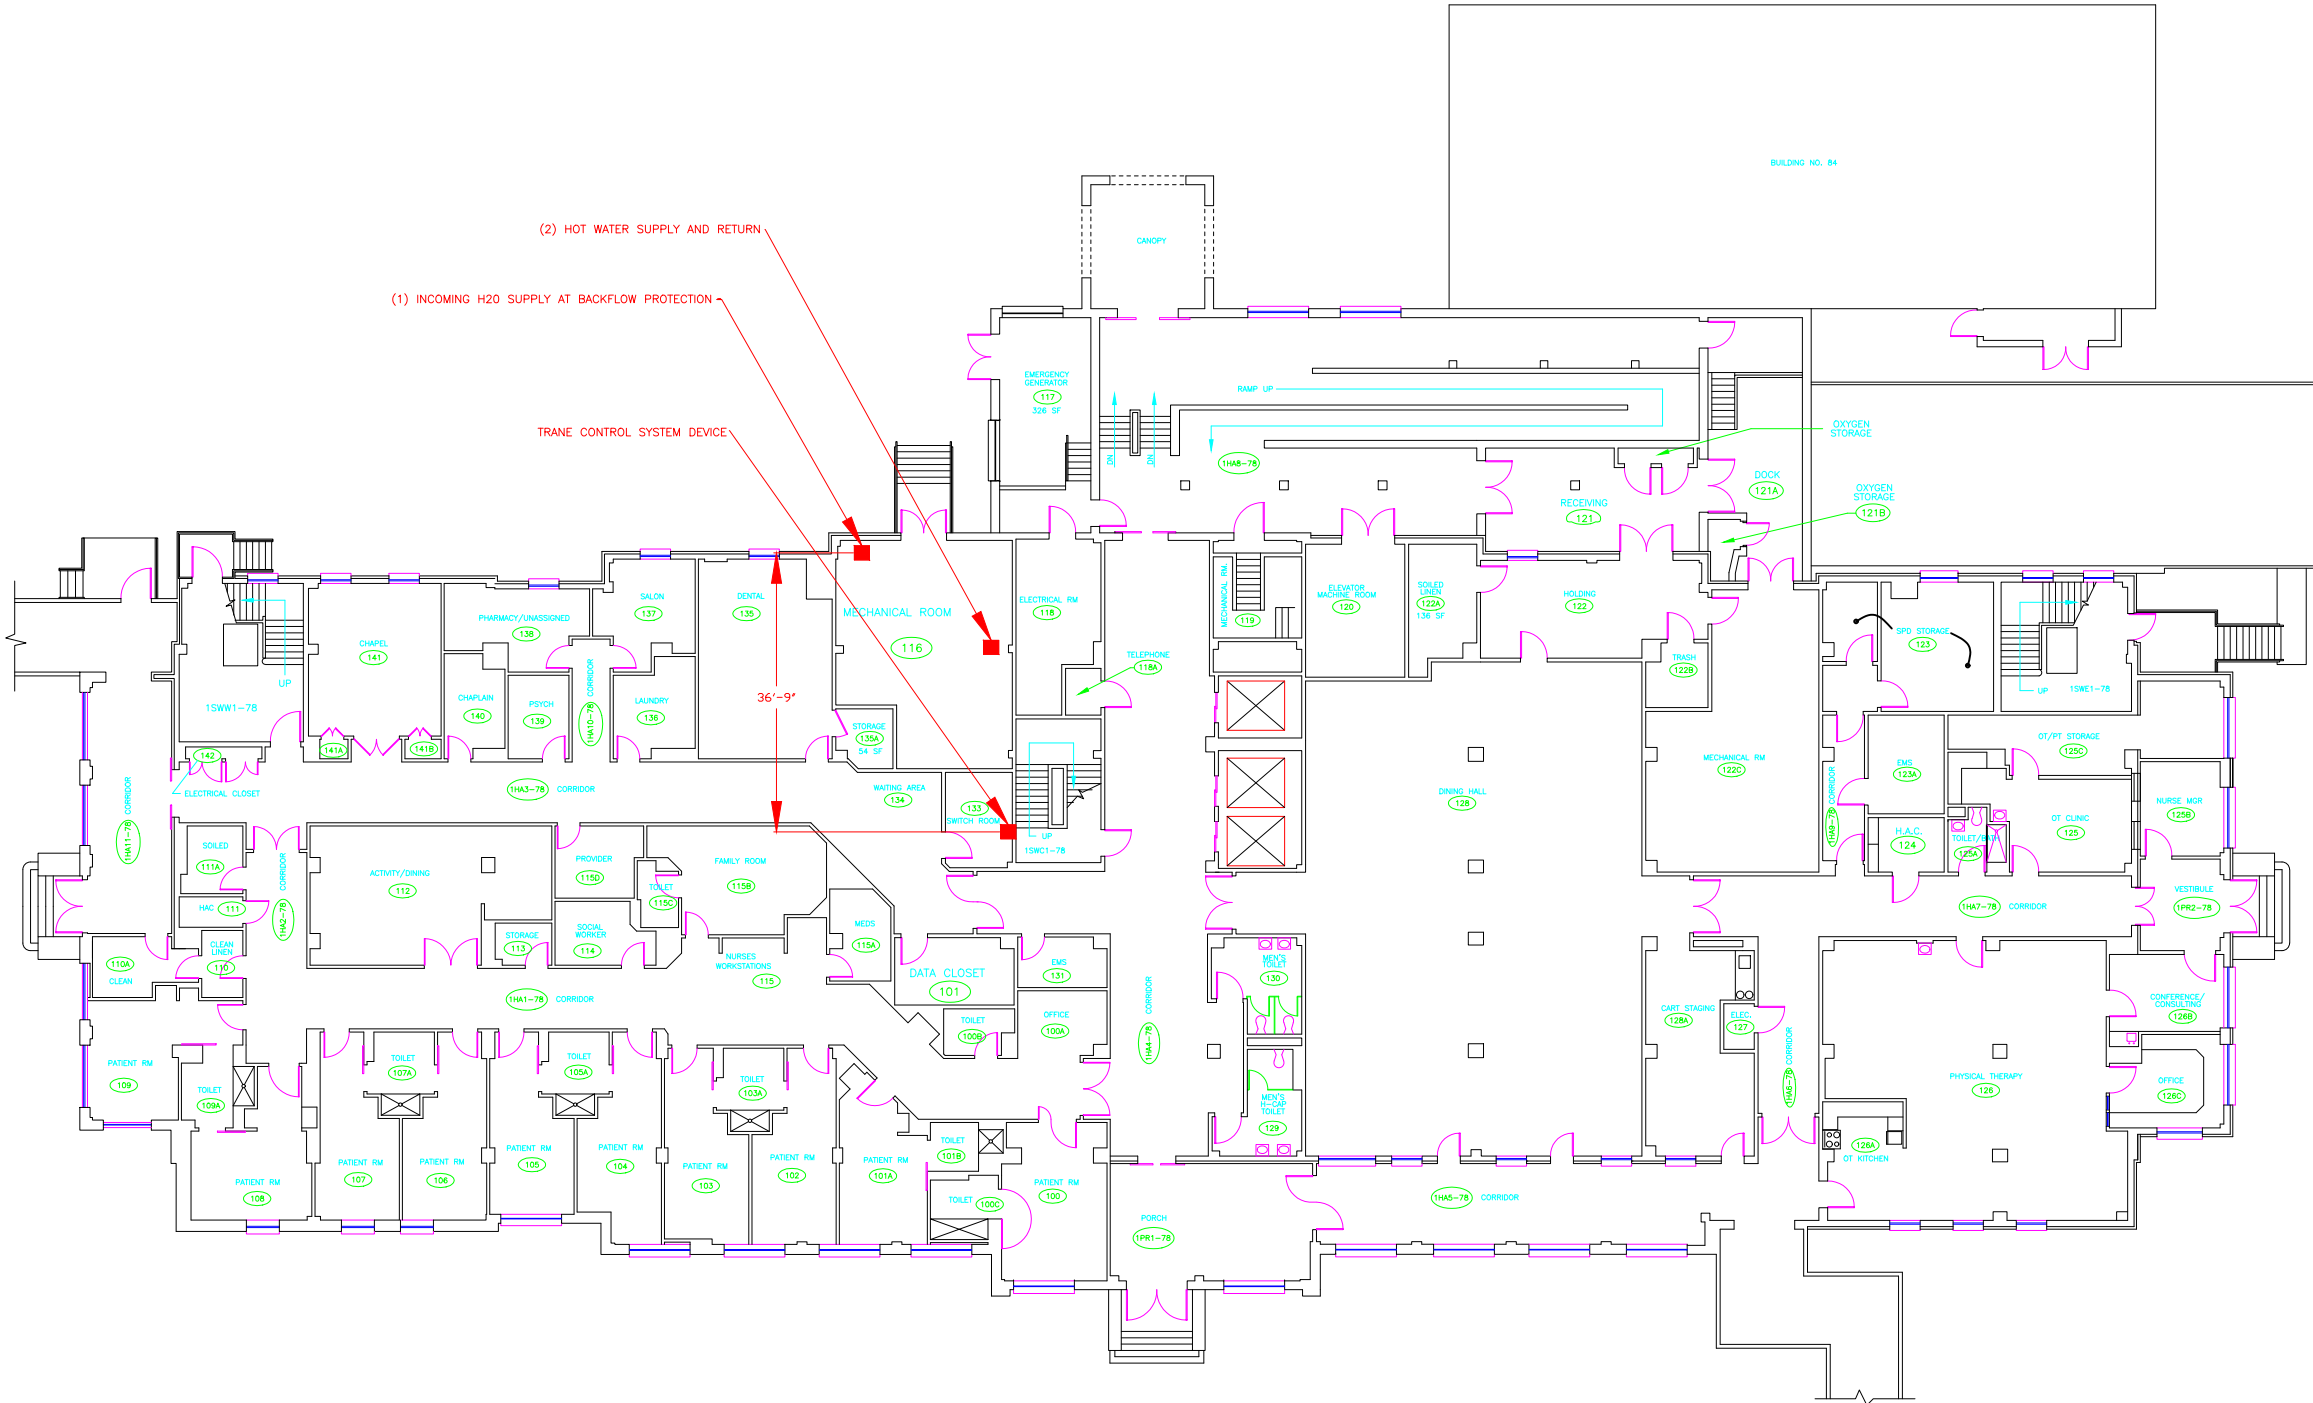

Scale:  
None

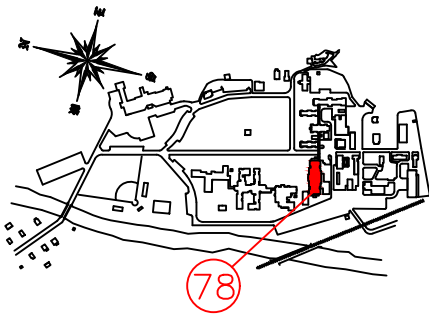

Office of  
Construction  
and Facilities  
Management



U.S. Department  
of Veterans Affairs

Drawing Title

1st Floor Plan

**NOTE:**

USERS OF THESE DRAWINGS ARE RESPONSIBLE FOR VERIFYING  
EXISTING DIMENSIONS AND CONDITIONS IN THE FIELD

Project Title

Water Safety Requirements  
(Continuous Monitoring)

Location

Bath, NY

Issue Date

1/8/18

Checked

Mike H.

Drawn

Steve W.

Project Number

528A6-18-615

Building Number

78

Drawing Number

Revisions:  
Date: