
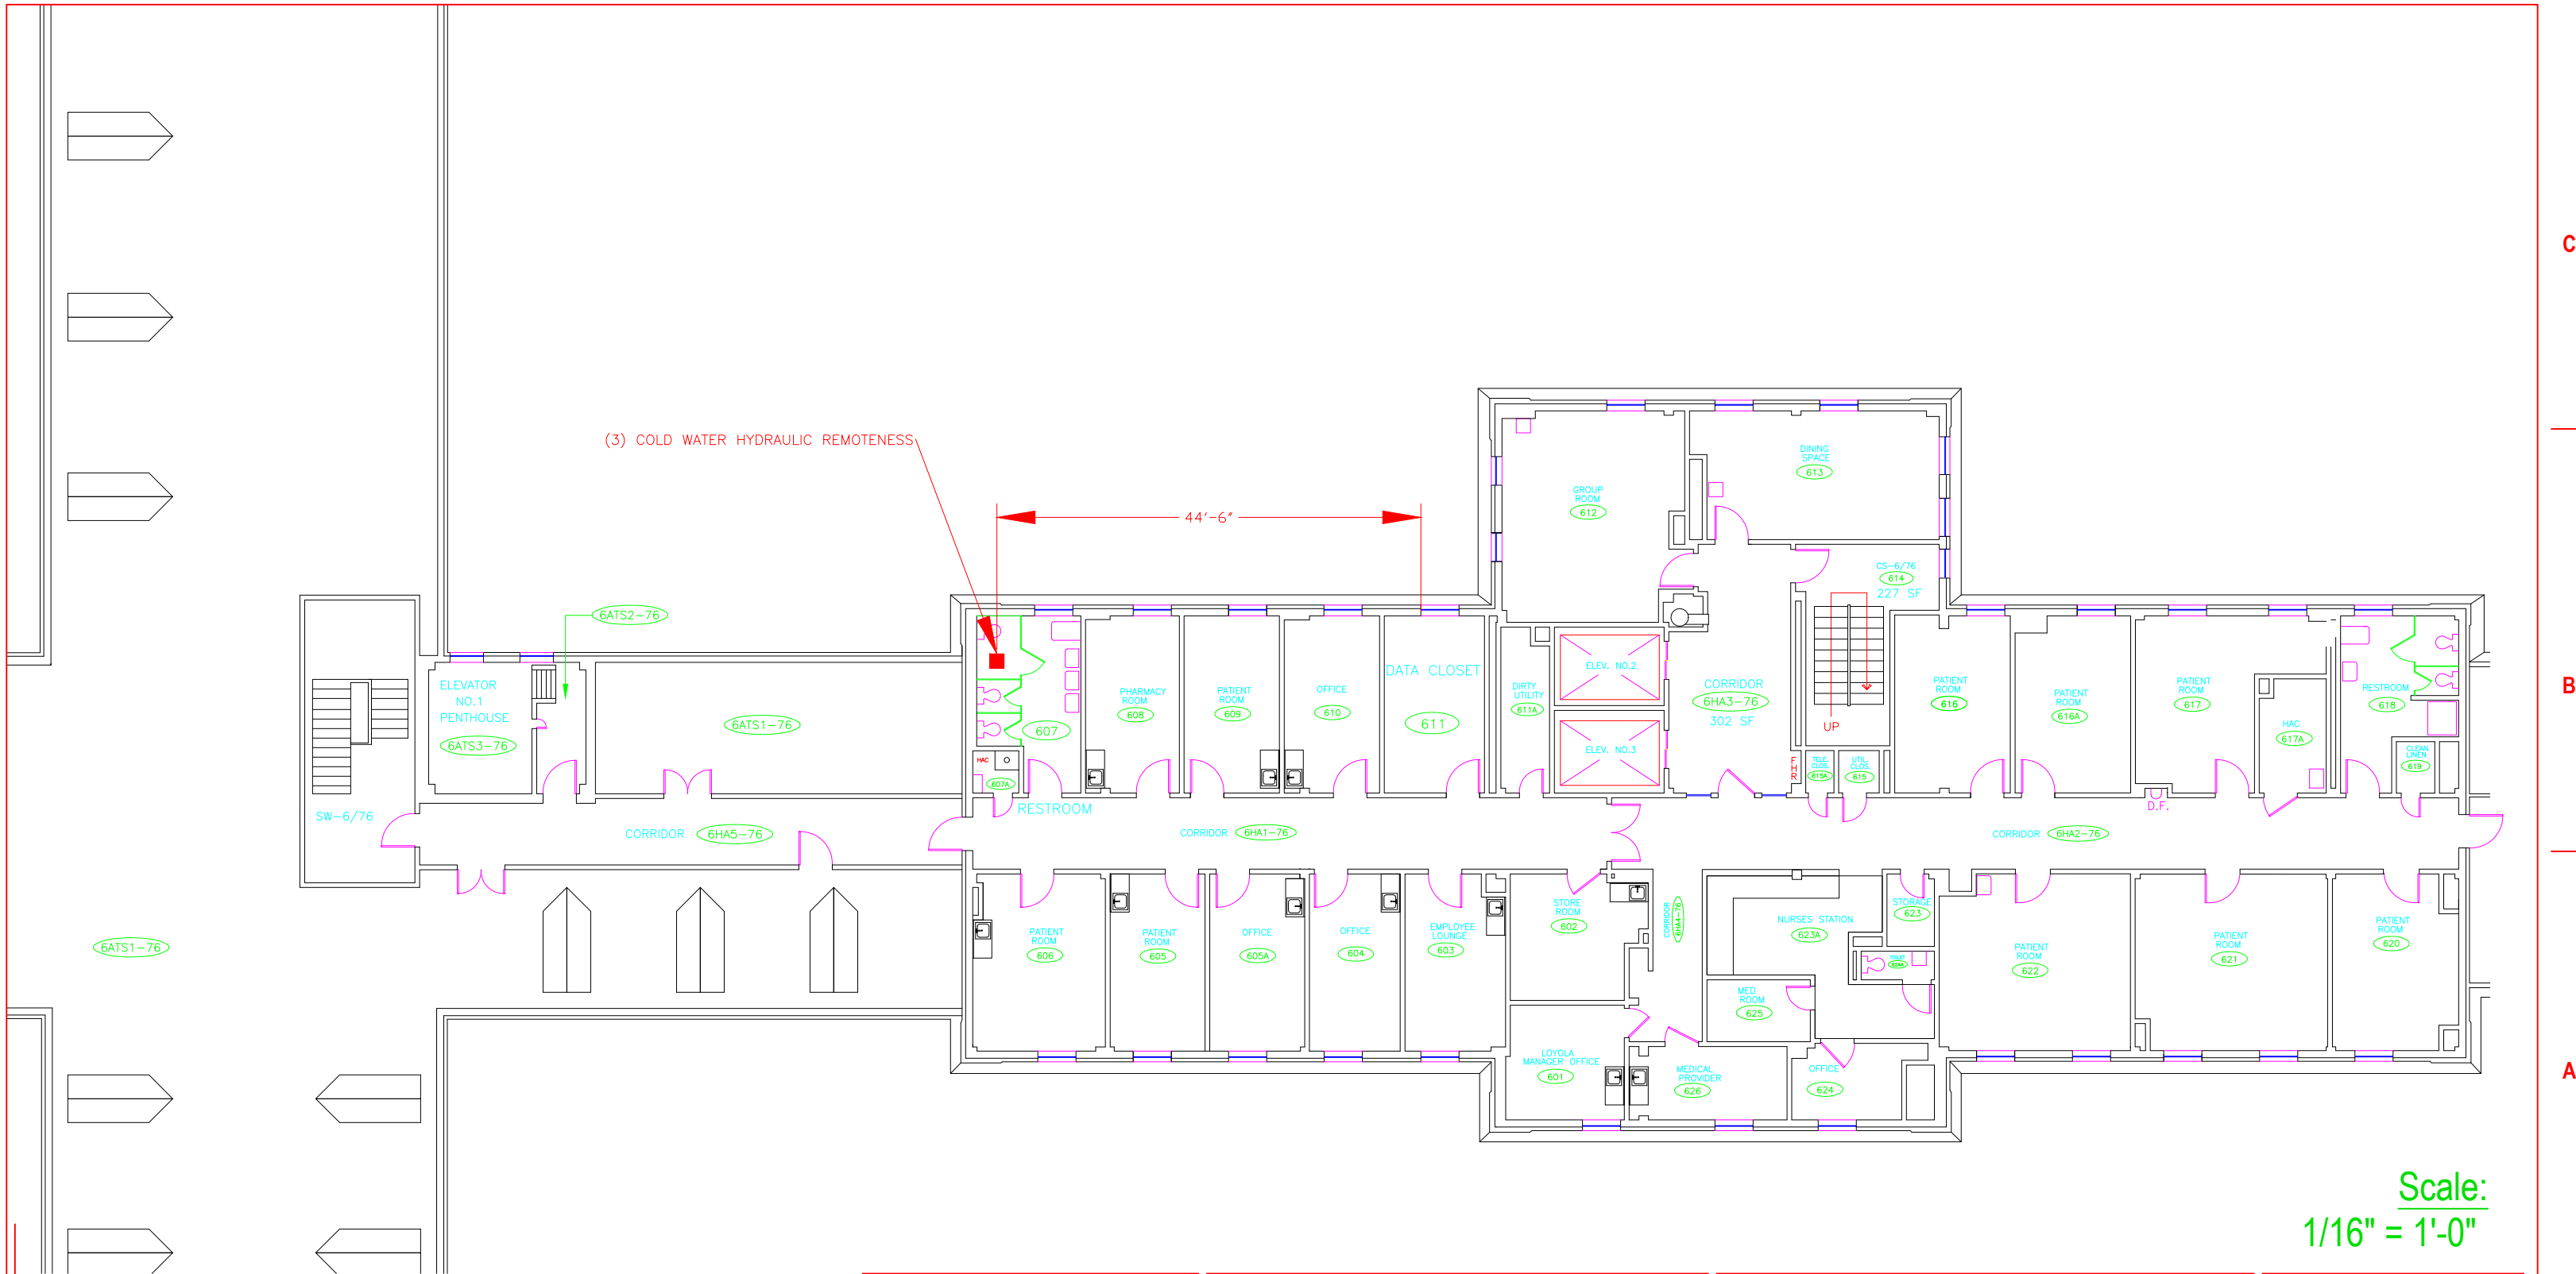


C:\Users\VHABANWIGHTS\appdata\local\temp\AcPublish\_4080\B-76 6th Floor North Water Monitoring.dwg 1-08-18 11:31:23 AM VHABANWIGHTS

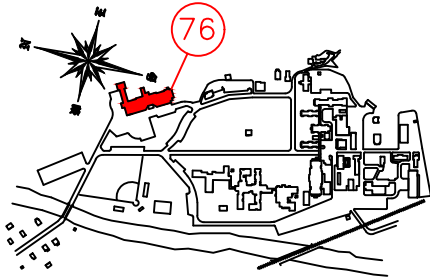

Scale:  
1/16" = 1'-0"

Revisions:	Date:		<b>Office of Construction and Facilities Management</b>  <b>VA</b> U.S. Department of Veterans Affairs	<b>Drawing Title</b> Floor Plan - 6th Floor		<b>Project Title</b> Water Safety Requirements (Continuous Monitoring)		<b>Project Number</b> 528A6-18-615	
						<b>Location</b> Bath, NY		<b>Building Number</b> 76	
				<b>NOTE:</b> USERS OF THESE DRAWINGS ARE RESPONSIBLE FOR VERIFYING EXISTING DIMENSIONS AND CONDITIONS IN THE FIELD		<b>Issue Date</b> 1/8/18		<b>Checked</b> Mike H.	<b>Drawn</b> Steve W.
								<b>Drawing Number</b>	