



C:\Users\VHABANWIGHTS\appdata\local\temp\AcPublish\_4080\B-31 Water Monitoring.dwg 1-08-18 10:39:21 AM VHABANWIGHTS

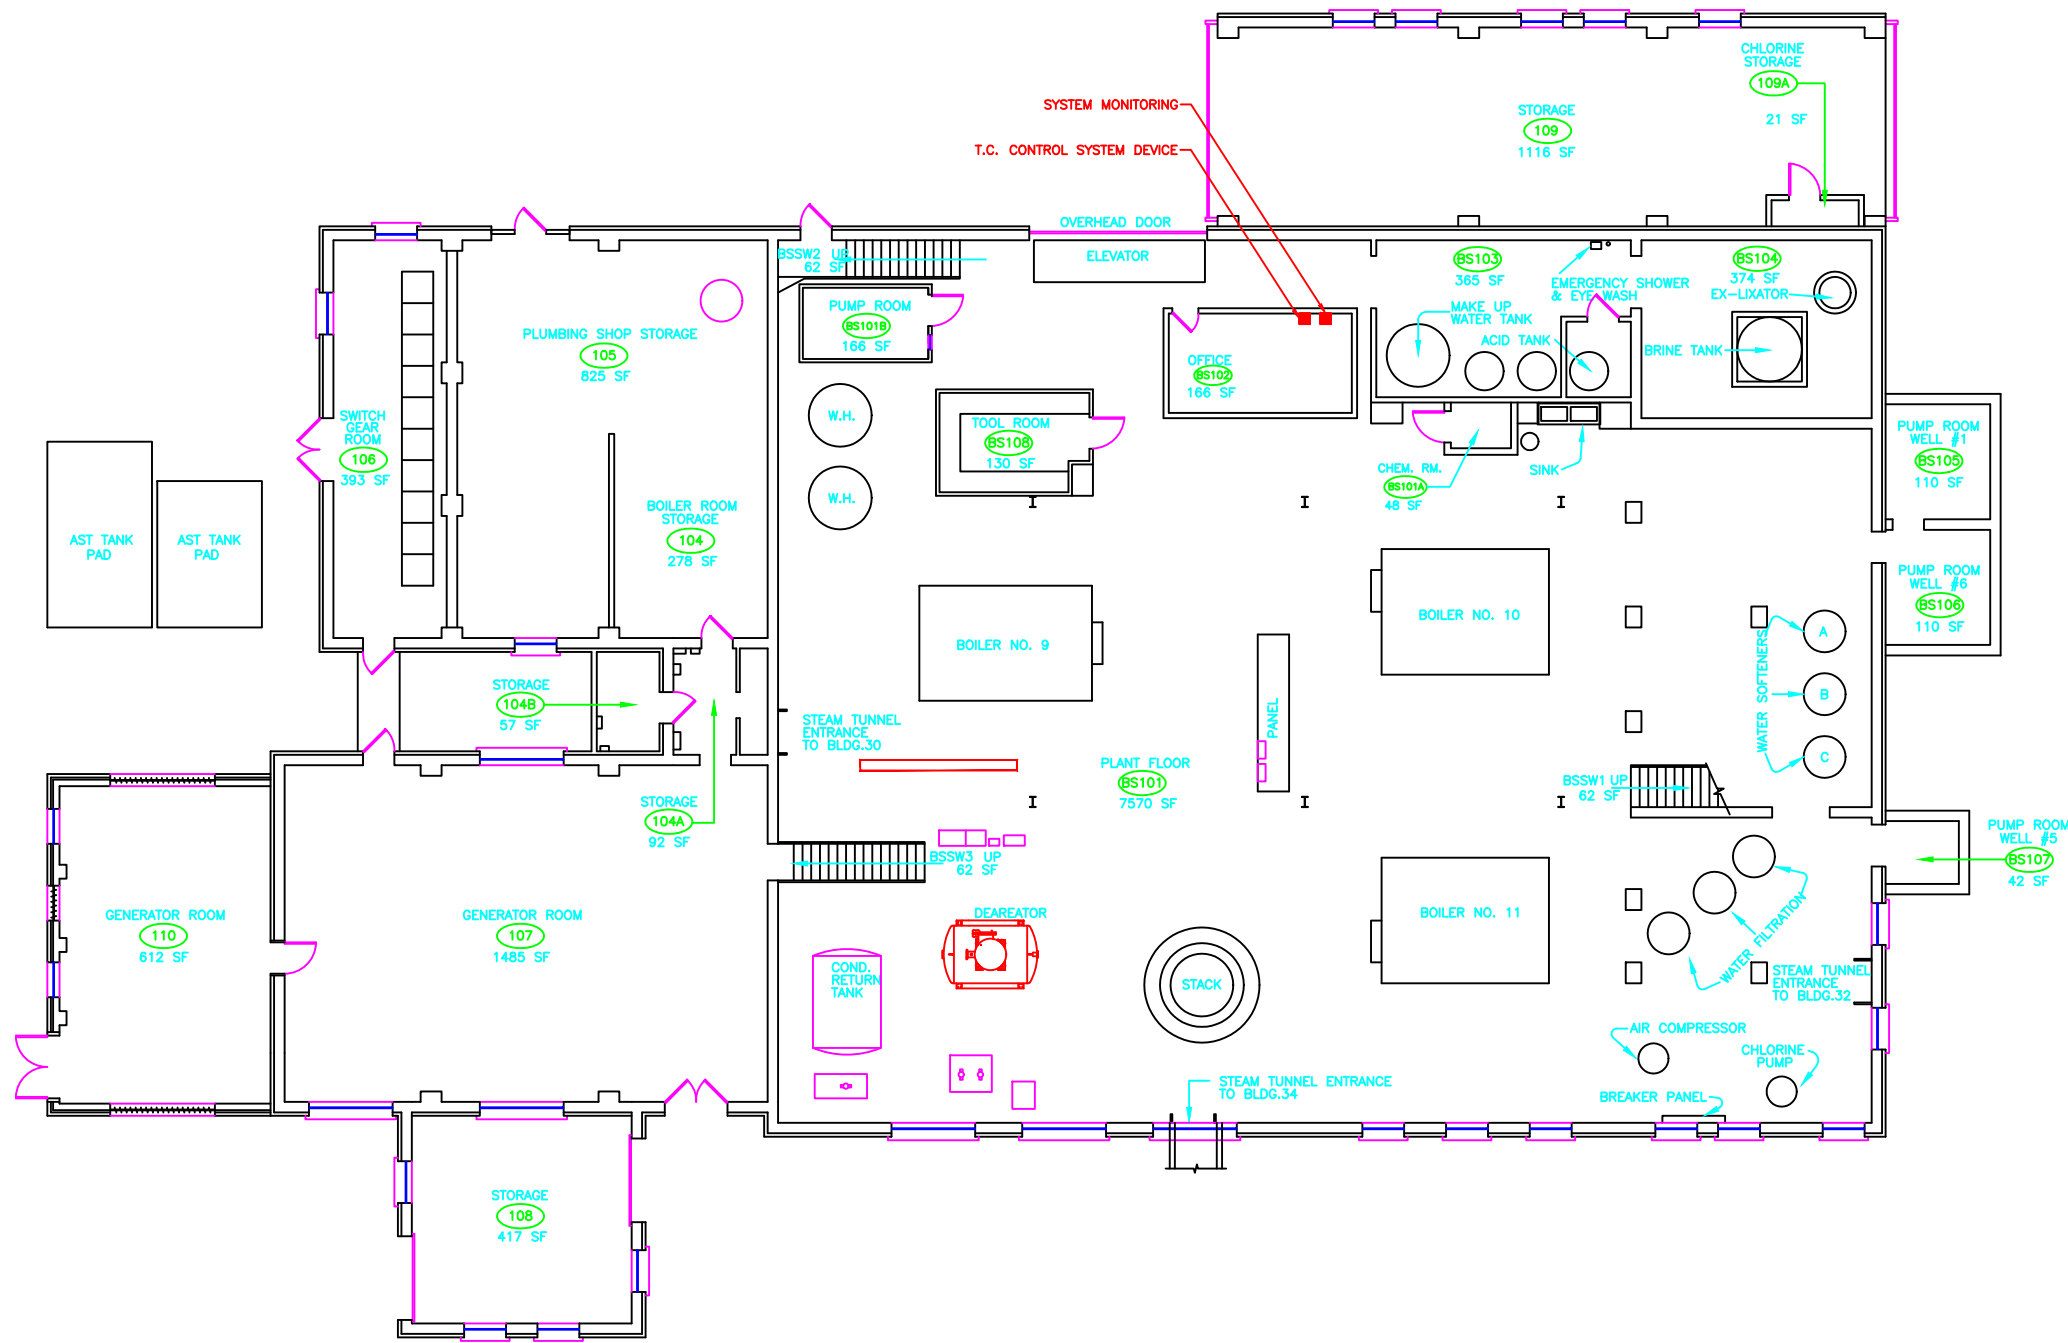


OPERATING FLOOR PLAN

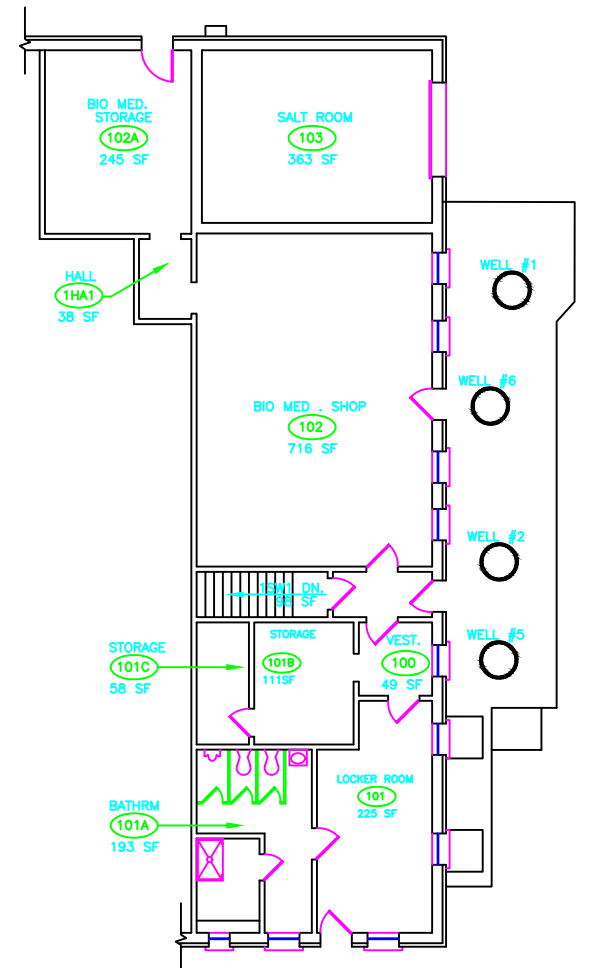

FIRST FLOOR PLAN

Scale:  
None

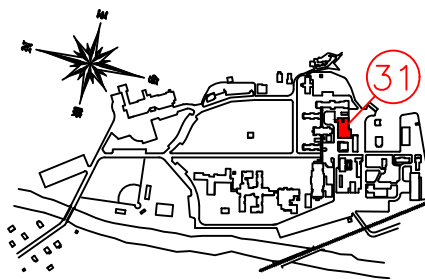

Office of  
Construction  
and Facilities  
Management



U.S. Department  
of Veterans Affairs

Drawing Title  
B-31 Floor Plan

**NOTE:**

USERS OF THESE DRAWINGS ARE RESPONSIBLE FOR VERIFYING  
EXISTING DIMENSIONS AND CONDITIONS IN THE FIELD

Project Title  
Water Safety Requirements  
(Continuous Monitoring)

Location  
Bath, NY

Issue Date  
1/8/18

Checked  
Mike H.

Drawn  
Steve W.

Project Number  
528A6-18-615

Building Number  
31

Drawing Number

Revisions:

Date: