



C:\Users\VAHANWIGHTS\appdata\local\temp\AcPublish\_4080\B-76 GROUND FLOOR NORTH.dwg 1-08-18 11:19:49 AM VAHANWIGHTS

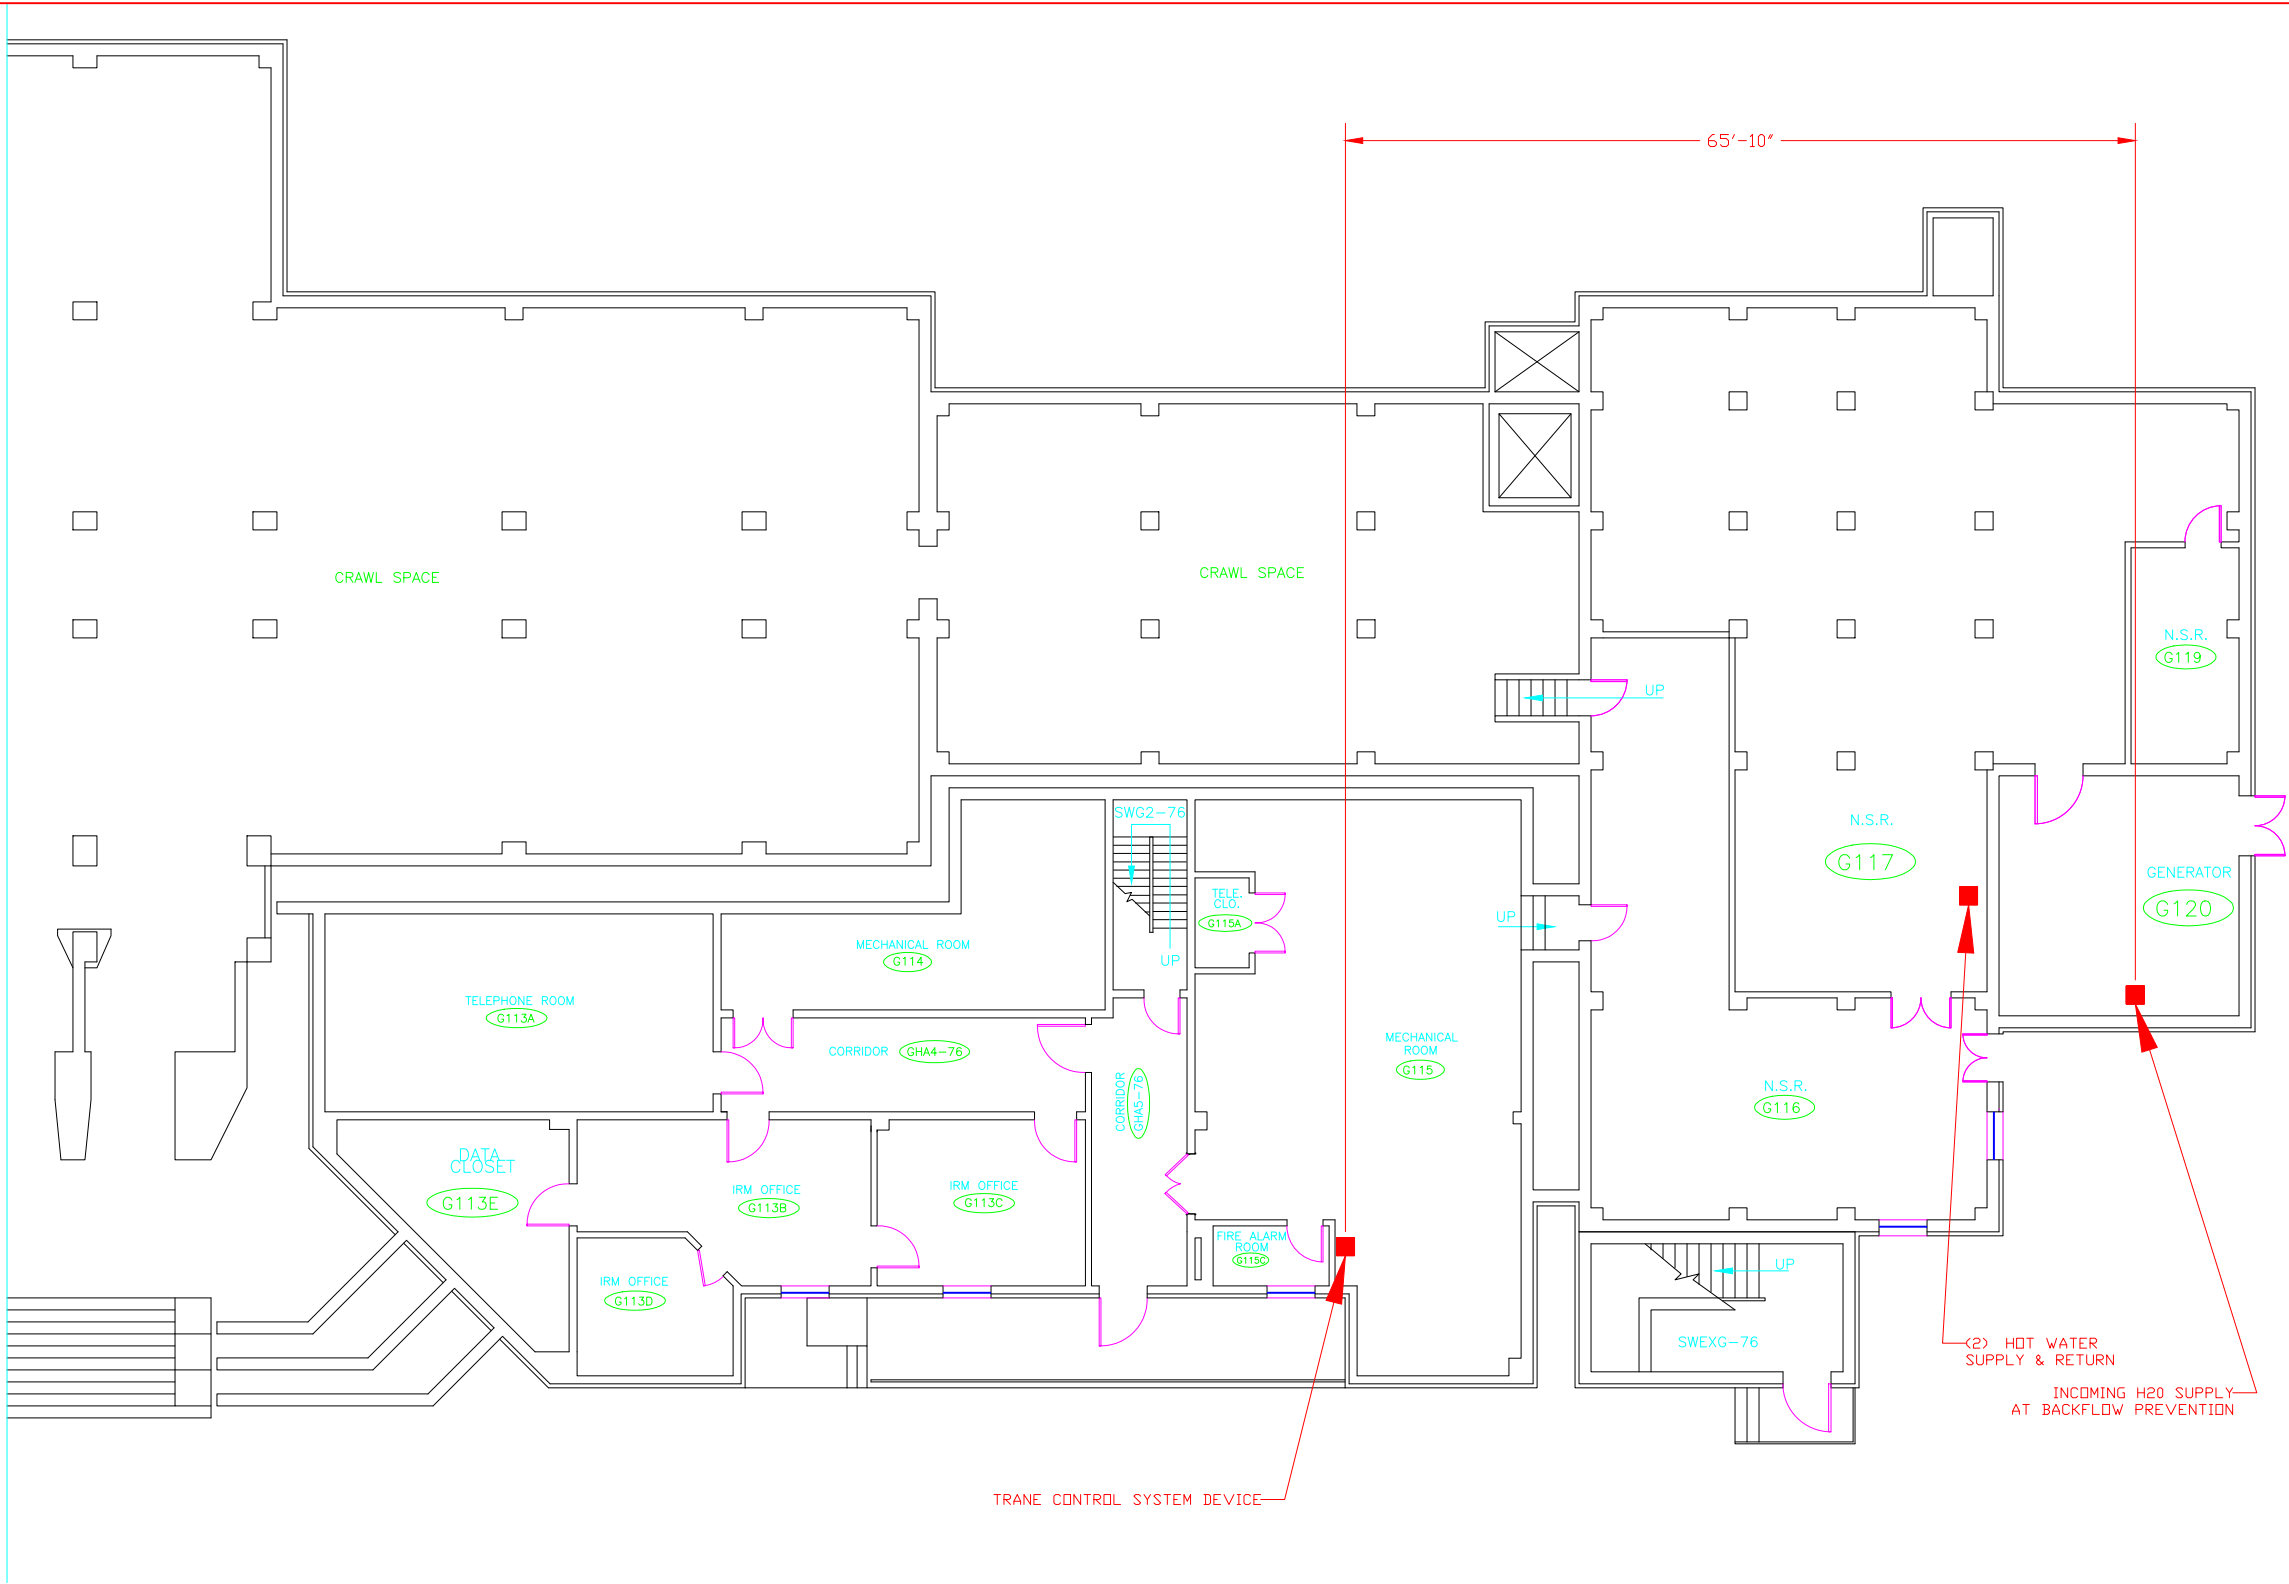

Scale:  
1/16" = 1'-0"

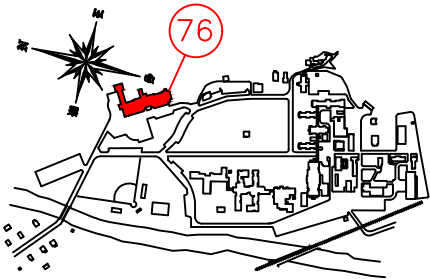

Office of  
Construction  
and Facilities  
Management

**VA** U.S. Department  
of Veterans Affairs

Drawing Title  
Floor Plan - Ground Floor  
North

**NOTE:**  
USERS OF THESE DRAWINGS ARE RESPONSIBLE FOR VERIFYING  
EXISTING DIMENSIONS AND CONDITIONS IN THE FIELD

Project Title  
Water Safety Requirements  
(Continuous Monitoring)

Location  
Bath, NY

Issue Date  
1/8/18

Checked  
Mike H.

Drawn  
Steve W.

Project Number  
528A6-18-615

Building Number  
76

Drawing Number

Revisions:	Date:
------------	-------