




Mixing Valve/Room Schedule		
Room No.	Sinks	Mixing Valves
BA-117A	1	1
BC-102	2	2
BC-108I	1	1
		Stops
		2
		4
		2

* - See Drawing PL-108 for Installation Diagram

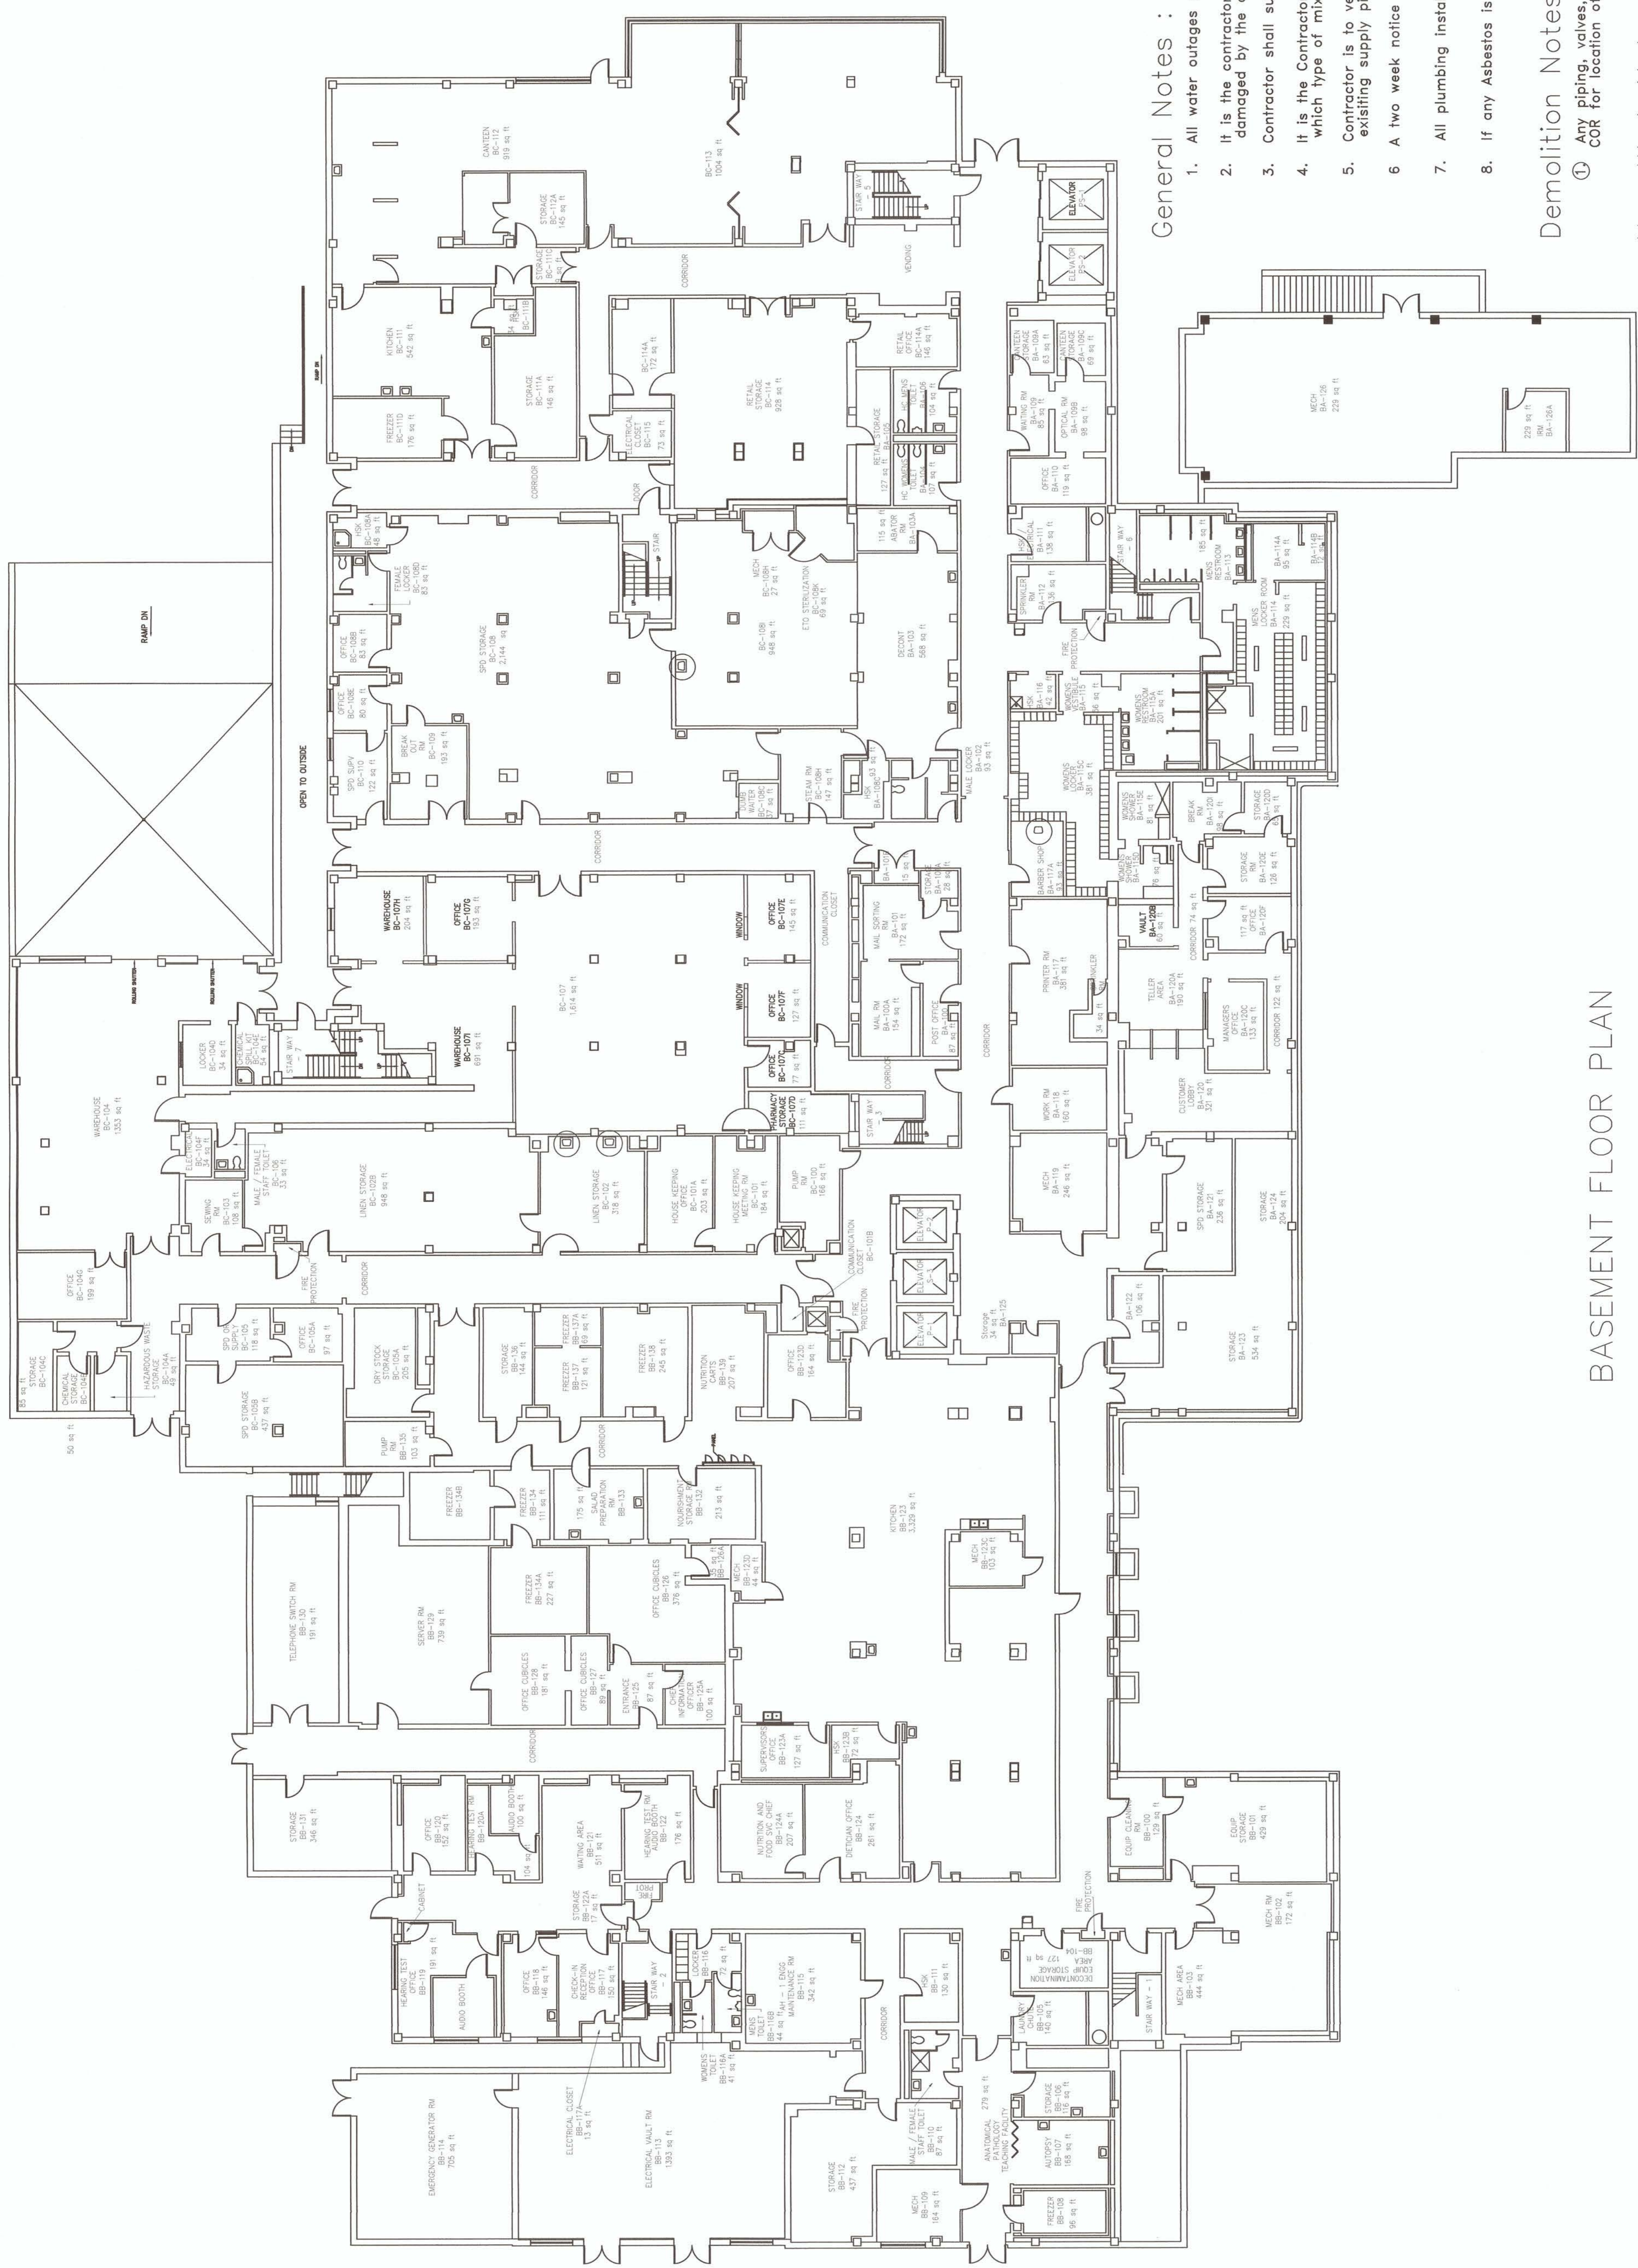

BASEMENT FLOOR PLAN
Building 1

General Notes :

- All water outages must be scheduled in advance with COR.
- It is the contractor's responsibility to repair or replace any property damaged by the contractor during construction.
- Contractor shall supply VA with a schedule.
- It is the Contractor's responsibility to verify all Faucet types to be determined which type of mixing valve is required.
- Contractor is to verify and supply under this contract type of adapter needed to connect stop to existing supply pipe.
- A two week notice is required for any water shut down.
- All plumbing installation is to be done by licensed certified plumbers.
- If any Asbestos is found, the contractor is to stop work and notify the COR immediately.

Demolition Notes :


- Any piping, valves, etc. deemed shall be recycled in a VA provided container. See COR for location of recycling container.

New Work Notes :

- Contractor to repair any damage to finishes after valves have been installed. Finishes to match existing.
- Contractor to clean room and advise COR before proceeding to next room.
- Contractor to install 1 mixing valve and 2 stops to all sinks indicated in mixing valve/room schedule on this sheet.

Legend:

- Sink with new mixing valve and 2 - stops.

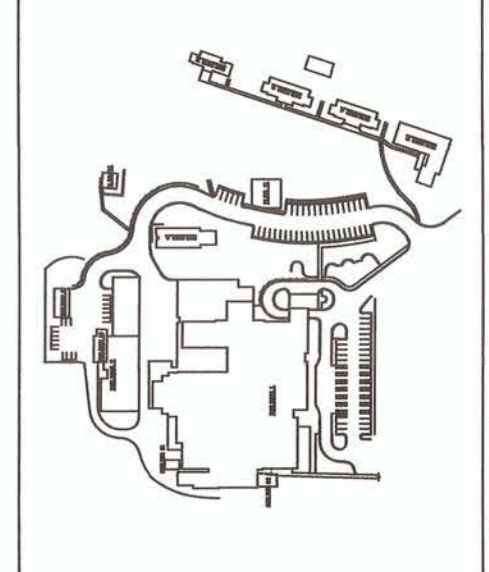

APPROVED: SAFETY MANAGER
JUSTIN GREENE
APPROVED: INFECTION CONTROL

APPROVED: CHIEF, FACILITIES MANAGEMENT SERVICE LINE
JOHN MONTGOMERY
APPROVED: ASSOCIATE DIRECTOR for PATIENT CARE SERVICES/EXECUTIVE NURSE
DEBRA LEGG, RN, MSN
APPROVED: SERVICE LINE CHIEF

APPROVED: MEDICAL CENTER DIRECTOR
STACY J VASQUEZ
APPROVED: ASSOCIATE DIRECTOR
JOHN D. STOUT
APPROVED: CHIEF OF STAFF

DRAWING TITLE:
Basement - Mixing Valve Installation Locations

PROJECT TITLE:
Correct Water System for Legionella Phase 2

DATE
8/16/2017

REV.
NTS

SCALE
NTS

CHECKED BY:
KB, JH

NOT TO SCALE

PUTTING
VERTIKANS
FIRST

Medical Center Av
200 Veterans Av
Beckley, WV. 25801