

100% CONSTRUCTION DRAWING SUBMITTAL


V.A. ROSEBURG HEALTHCARE SYSTEM

SEISMIC REPLACEMENT BUILDING 2


PHASE 1 MINOR / PROJECT NO. 653-322

ACUTE PSYCHIATRIC WARD

VICINITY MAP

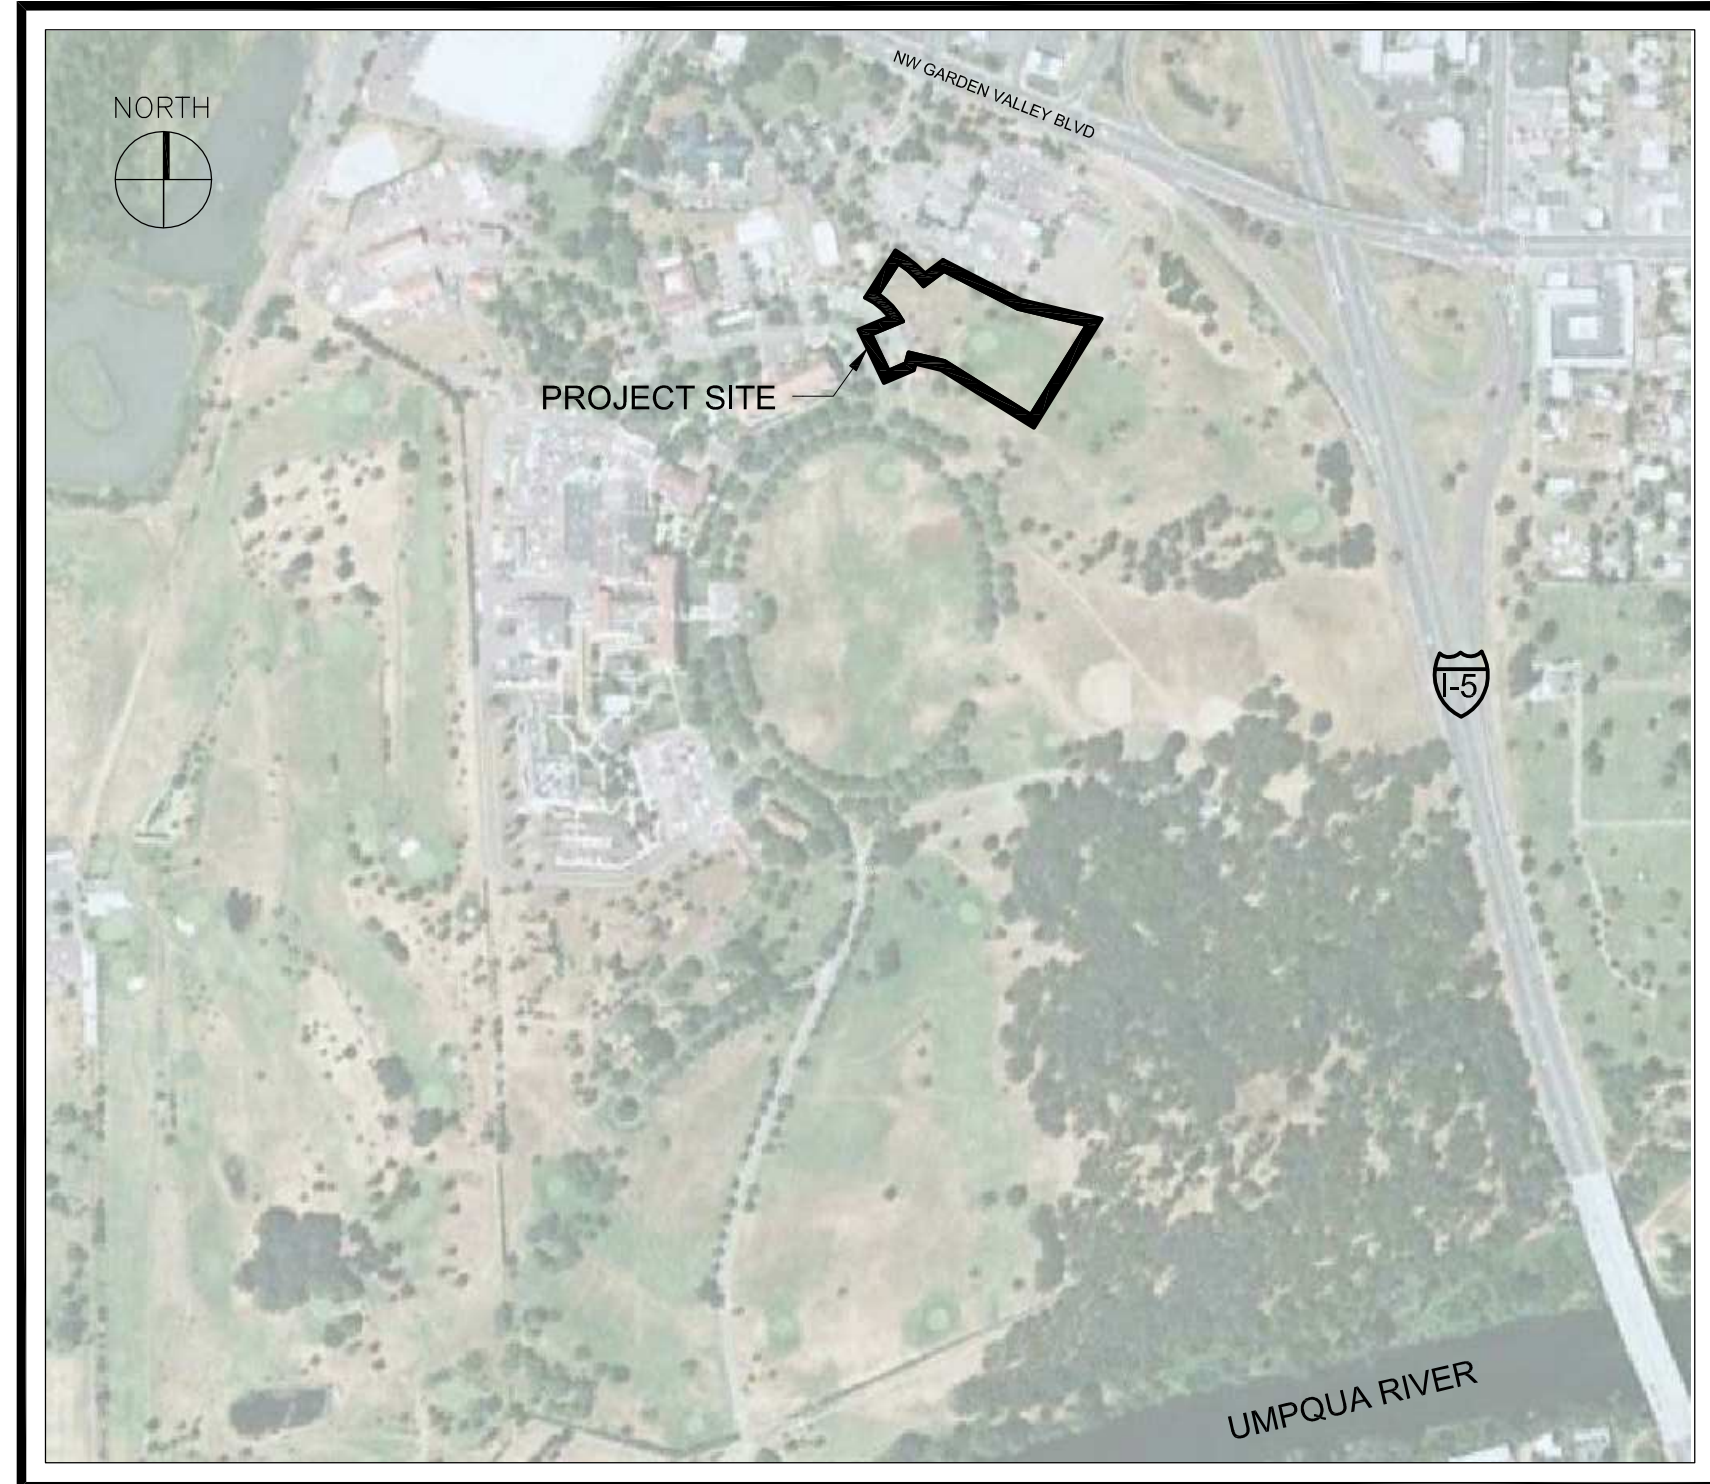

LOCATION MAP

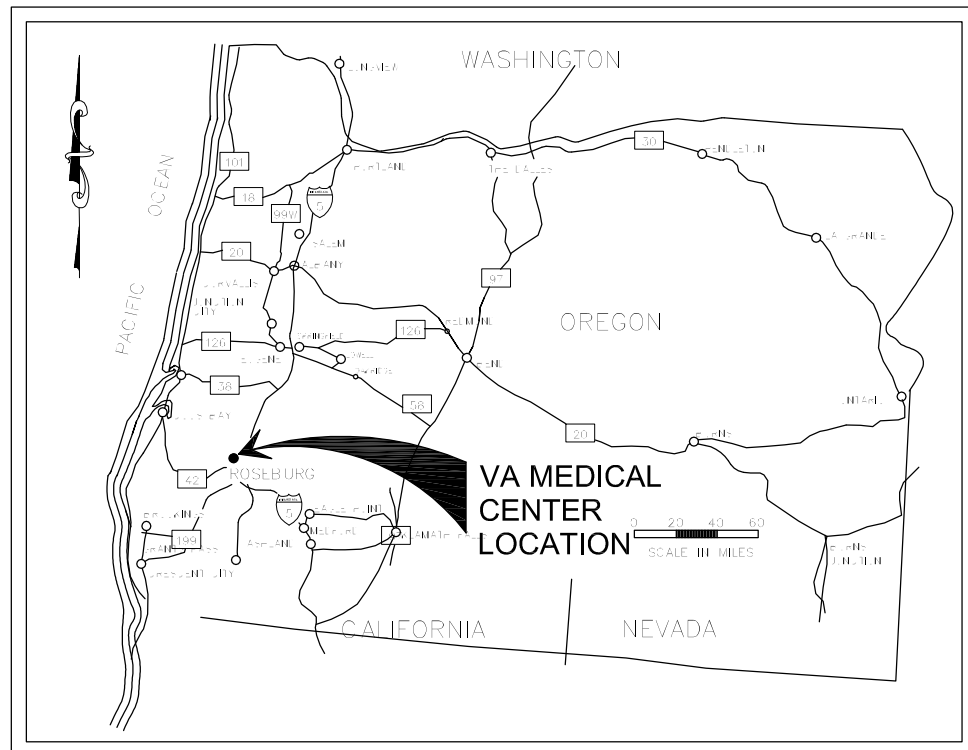

CONTACT LIST

OWNER DEPARTMENT OF VETERAN AFFAIRS 913 NW GARDEN VALLEY BLVD. ROSEBURG, OR 97471 CONTACT: STEVEN BOYER TEL: (541) 440-1371 FAX: (541) 440-1219	STRUCTURAL ENGINEER DEGENKOLB ENGINEERS 1000 SW BROADWAY, SUITE 1800 PORTLAND, OR 97205 CONTACT: KENT YU, SE, PhD EMAIL: kyu@degenkolb.com TEL: (503) 223-9932 FAX: (503) 242-1780
ARCHITECT OF RECORD TINA ELY ARCHITECT 2915 WINGATE STREET EUGENE, OR 97408 CONTACT: TINA ELY, AIA, LEED AP EMAIL: tina.ely@comcast.net TEL: (541) 521-2477 FAX: (541) 345-9604	MECHANICAL ENGINEER BALZHISER & HUBBARD ENGINEERS, INC. 100 WEST 13TH AVENUE EUGENE, OR 97401 ENGINEER: TIMOTHY S. ELY, PE, LEED AP CONTACT: STEPHEN SMITH, PE, LEED AP EMAIL: ssmith@bhengineers.com TEL: (541) 686-8478 FAX: (541) 345-5303
FIRE PROTECTION ENGINEER CREIGHTON ENGINEERING, INC. 210 UNIVERSITY ROAD, SUITE 100 SPOKANE VALLEY, WA 99206 CONTACT: SCOTT R. CREIGHTON (F)PE EMAIL: src@creightoneg.com TEL: (509) 921-9755 FAX: (509) 921-9806	ELECTRICAL ENGINEER BALZHISER & HUBBARD ENGINEERS, INC. 100 WEST 13TH AVENUE EUGENE, OR 97401 ENGINEER: K. MICHAEL WARE, PE, LEED AP CONTACT: JOSE GUERRERO EMAIL: jguerrero@bhengineers.com TEL: (541) 686-8478 FAX: (541) 345-5303
CIVIL ENGINEER BALZHISER & HUBBARD ENGINEERS, INC. 100 WEST 13TH AVENUE EUGENE, OR 97401 ENGINEER: TINA GUARD, P.E., LEED AP CONTACT: JOHN HORNBERGER, PE EMAIL: jhornberger@bhengineers.com TEL: (541) 686-8478 FAX: (541) 345-5303	LOW VOLTAGE, SECURITY & ACOUSTICS ENGINEER CONVERGENT TECHNOLOGIES DESIGN GROUP, INC 2132 EAST VILLA COURT TEMPE, AZ 85282 CONTACT: BRIAN WHITLOCK, CTS-D EMAIL: bwhitlock@ctcdginc.com TEL: (480)345-9951 FAX: (480) 345-9952
LANDSCAPE ARCHITECT MACDONALD ENVIRONMENTAL PLANNING, PC 1022 SW SALMON STREET, STE 470 PORTLAND, OR 97205 CONTACT: LAUREL MACDONALD, ASLA EMAIL: lmacdonald@mep-pc.com TEL: (503) 224-1225 FAX: (503) 295-6906	CONSULTING ARCHITECT Oh planning + design architecture 115 NW FIRST AVE., SUITE 300 PORTLAND, OR 97225
INTERIOR DESIGNER PELLITIER & PELLITIER INTERIOR DESIGN P.O. BOX 5512 EUGENE, OR 97405 CONTACT: MICHELLE PELLITIER EMAIL: michelle@pellitier.com TEL: (541) 484-2045 FAX: (541) 484-0518	COST ESTIMATOR RIDER LEVETT BUCHNALL 1120 NW COUCH STREET, SUITE 730 PORTLAND, OR 97209 CONTACT: GRAHAM ROY, FRICS EMAIL: graham.roy@ua.r16.com TEL: (502) 226-2730 FAX: (503) 226-1267

SHEET INDEX - VOLUME 1

- GENERAL -	
GI-101	COVER SHEET, PROJECT DATA, SHEET INDEX
GI-102	FIRE LIFE SAFETY PLAN
GI-103	FIRE LIFE SAFETY DESIGN NARRATIVE
- CIVIL -	
V1	TOPOGRAPHIC SURVEY
V2	TOPOGRAPHIC SURVEY
CG-101	GRADING PLAN
CP-101	PAVING PLAN
CS-101	EROSION AND SEDIMENT CONTROL PLAN
CS-102	SITE DIMENSIONING PLAN
CS-501	EROSION AND SEDIMENT CONTROL NOTES
CS-502	CIVIL AND SURVEY LEGENDS, NOTES, AND DETAILS
CS-503	CIVIL DETAILS
CS-504	CIVIL DETAILS
CS-505	CIVIL DETAILS
CU-101	STORM DRAIN PLAN
CU-102	SANITARY SEWER, WATER, AND NATURAL GAS DISTRIBUTION PLAN
CU-103	SANITARY SEWER, WATER, AND NATURAL GAS DISTRIBUTION DETAILS
GD-100	SITE DEMOLITION PLAN
GS-100	SITE PLAN
- LANDSCAPE -	
LS-100	TREE PROTECTION PLAN
LS-101	LANDSCAPE LAYOUT PLANS
LS-102	LANDSCAPE DIMENSIONING PLANS
LS-501	LANDSCAPE SITE FEATURE DETAILS
LS-502	LANDSCAPE WATER FEATURES DETAILS
LI-101	IRRIGATION PLAN
LI-501	IRRIGATION DETAILS
LP-101	LANDSCAPE PLANTING PLAN
LP-102	ECOROOF PLAN AND DETAILS
LP-501	LANDSCAPE PLANT LEGEND AND DETAILS
- ARCHITECTURAL -	
AS-001	ABBREVIATIONS, LEGENDS AND NOTES
AS-002	PARTITION TYPES AND DETAILS
AS-101	OVERALL FLOOR PLAN
AS-101.1	ENLARGED FLOOR PLAN - SOUTHWEST WING
AS-101.2	ENLARGED FLOOR PLAN - NORTH WING
AS-101.3	ENLARGED FLOOR PLAN - EAST WING
AS-101.4	ENLARGED FLOOR PLAN - CANOPY PLAN AND MECHANICAL STAIRS
AS-102.0	OVERALL REFLECTED CEILING PLAN
AS-102.1	ENLARGED REFLECTED CEILING PLAN - SOUTHWEST WING
AS-102.2	ENLARGED REFLECTED CEILING PLAN - NORTH WING
AS-102.3	ENLARGED REFLECTED CEILING PLAN - EAST WING
AS-103	ROOF PLAN
AS-201	EXTERIOR ELEVATIONS
AS-211	INTERIOR ELEVATIONS
AS-212	INTERIOR ELEVATIONS
AS-213	INTERIOR ELEVATIONS
AS-214	INTERIOR ELEVATIONS
AS-215	INTERIOR ELEVATIONS
AS-216	INTERIOR ELEVATIONS
AS-217	INTERIOR ELEVATIONS
AS-311	EXTERIOR WALL SECTIONS
AS-312	EXTERIOR WALL SECTIONS
AS-313	EXTERIOR WALL SECTIONS
AS-501	EXTERIOR DETAILS
AS-502	EXTERIOR DETAILS
AS-503	EXTERIOR DETAILS
AS-511	INTERIOR DETAILS - CEILING
AS-512	INTERIOR DETAILS - CASEWORK
AS-521	ROOF DETAILS
AS-601	EXTERIOR WINDOW SCHEDULE
AS-602	EXTERIOR WINDOW DETAILS
AS-603	EXTERIOR WINDOW DETAILS
AS-604	EXTERIOR WINDOW DETAILS
AS-605	CURTAIN WALL DETAILS
AS-611	INTERIOR WINDOW SCHEDULE
- FINISHES -	
FS-101	FINISH FLOOR PLAN
- STRUCTURAL -	
SF-001	GENERAL NOTES
SF-002	SYMBOLS, ABBREVIATIONS, AND SHEET LIST
SF-031	TYPICAL CONCRETE DETAILS
SF-032	TYPICAL CONCRETE DETAILS
SF-041	TYPICAL MASONRY DETAILS
SF-051	TYPICAL STEEL DETAILS
SF-052	TYPICAL STEEL DETAILS
SF-053	TYPICAL METAL DECK DETAILS
SB-101	OVERALL FOUNDATION PLAN
SB-102	FOUNDATION PLAN
SB-103	FOUNDATION PLANS
SF-111	OVERALL ROOF FRAMING PLAN
SF-112	ROOF FRAMING PLAN
SF-113	ROOF FRAMING PLANS
SF-121	OVERALL CLERESTORY FRAMING PLAN
SF-122	CLERESTORY FRAMING PLANS
SF-201	BRACED FRAME ELEVATIONS
SF-202	BRACED FRAME ELEVATIONS
SF-203	BRACED FRAME ELEVATIONS
SB-501	FOUNDATION DETAILS
SB-501	FOUNDATION DETAILS
SF-511	STEEL DETAILS
SF-512	STEEL DETAILS
SF-513	STEEL DETAILS
SF-514	STEEL DETAILS
SF-515	STEEL DETAILS
SF-516	STEEL DETAILS

SHEET INDEX - VOLUME 2

- GENERAL -	
GI-101	COVER SHEET, PROJECT DATA, SHEET INDEX
- MECHANICAL -	
MH-001	MECHANICAL & PLUMBING SYMBOLS LIST & SHEET INDEX
MH-002	MECHANICAL SCHEDULES
MH-101.1	FLOOR PLAN WEST - HVAC
MH-101.2	FLOOR PLAN NORTH - HVAC
MH-101.3	FLOOR PLAN EAST - HVAC
MH-102.1	FLOOR PLAN WEST - HVAC PIPING
MH-102.2	FLOOR PLAN NORTH - HVAC PIPING
MH-102.3	FLOOR PLAN EAST - HVAC PIPING
MH-201	ROOF PLAN - MECHANICAL & PLUMBING
MH-300	MECHANICAL ROOM PLAN
MH-501	MECHANICAL DETAILS
MH-502	MECHANICAL DETAILS
MH-503	MECHANICAL CONTROLS
- PLUMBING -	
PL-001	PLUMBING SCHEDULES
PL-100	FOUNDATION PLAN - PLUMBING
PL-101.1	FLOOR PLAN WEST - PLUMBING
PL-101.2	FLOOR PLAN NORTH - PLUMBING
PL-101.3	FLOOR PLAN EAST - PLUMBING
PL-500	PLUMBING DETAILS
- ELECTRICAL -	
ES-000	SYMBOLS LIST & SHEET INDEX
ES-001	SITE PLAN - ELECTRICAL
ES-101.1	FLOOR PLAN SOUTHWEST WING - POWER
ES-101.2	FLOOR PLAN NORTH WING - POWER
ES-101.3	FLOOR PLAN EAST WING - POWER
ES-101.4	ENLARGED LOADING DOCK PLAN - POWER
ES-102.1	FLOOR PLAN SOUTHWEST WING - LIGHTING
ES-102.2	FLOOR PLAN NORTH WING - LIGHTING
ES-102.3	FLOOR PLAN EAST WING - LIGHTING
ES-102.4	ENLARGED LOADING DOCK PLAN - LIGHTING
ES-103	ROOF PLAN
ES-104.1	LUMINAIRE SCHEDULE
ES-104.2	PANEL SCHEDULES
ES-105	ELECTRICAL DETAILS
ES-105.1	ELECTRICAL DETAILS
ES-106	ONE LINE DIAGRAM
- LOW VOLTAGE -	
TA-001	LOW VOLTAGE SYSTEMS TITLE SHEET
TA-010	TELECOMMUNICATIONS OUTSIDE PLANT
TA-011	TELECOMMUNICATIONS SYSTEMS RISER
TA-012	TELECOMMUNICATIONS ROOM 3D CONCEPT SKETCH
TA-013	TELECOMMUNICATIONS ROOM PLAN DETAILS
TA-014	TELECOMMUNICATIONS ROOM EQUIP RACK DETAIL MDF
TA-015	TELECOMMUNICATIONS ROOM EQUIPMENT RACK DETAIL IDF
TA-020	TELECOMMUNICATIONS CABLING SYSTEM DETAILS
TA-021	TELECOMMUNICATIONS AND AV INFRASTRUCTURE WALLBOX AND FLOORBOX DETAILS
TA-022	LOW VOLTAGE SYSTEMS INFRASTRUCTURE DETAILS
TA-023	NURSE CALL AND CCTV DETAILS
TA-024	ACCESS CONTROL DOOR DETAILS (1 OF 2)
TA-025	ACCESS CONTROL DOOR DETAILS (2 OF 2)
TA-101	LOW VOLTAGE SYSTEMS FIRST FLOOR PLAN
TA-102	LOW VOLTAGE SYSTEMS FIRST FLOOR RCP
TA-103	TWO-WAY COMMUNICATIONS IMAGING SYSTEM ZONING PLAN
TA-410	CCTV SIGNAL FLOW DIAGRAM
TA-500	STAFF CONFERENCE ROOM AV SIGNAL FLOW
TA-501	STAFF CONFERENCE ROOM AV CONTROL FLOW
TA-502	STAFF CONFERENCE ROOM AV PLATE AND RACK DETAIL
TA-510	DAY DINING, PATIENT GROUP EDUCATION, PATIENT LOUNGE AV SIGNAL AND CONTROL FLOW
TA-511	DAY DINING, PATIENT GROUP EDUCATION, PATIENT LOUNGE AV PLATE AND RACK ELEVATION
TA-600	TWO-WAY COMMUNICATIONS / PAGING / INTERCOM SIGNAL FLOW DIAGRAM
TA-601	TWO-WAY COMMUNICATIONS / PAGING / INTERCOM SIGNAL FLOW DIAGRAM
TA-602	TWO-WAY COMMUNICATIONS / PAGING / INTERCOM CONTROL FLOW DIAGRAM
TA-700	NURSE CALL SIGNAL FLOW DIAGRAM

Revisions	Date	CONSULTANT	STAMP	ARCHITECT	Drawing Title	Project Title	VA Project Number	OFFICE OF CONSTRUCTION AND FACILITIES MANAGEMENT
					COVER SHEET, PROJECT DATA, SHEET INDEX	SEISMIC REPLACEMENT BLDG 2 PHASE 1 MINOR ACUTE PSYCHIATRIC WARD	653-322	
					Approved: Project Director	Location ROSEBURG, OREGON	Building Number 086	
						Date 30 APR 2012	Sheet Number GI-001	
						Checked TME	Drawn	

REGISTERED ARCHITECT
4447
TINA M. ELY
EUGENE, OREGON

Tina Ely architect
2915 Wingate Street / Eugene, OR 97408
541.521.2477 / Tina.Ely@comcast.net

Department of Veterans Affairs