


THE ELECTRICAL DUCTBANK ON THIS PAGE HAS BEEN MODIFIED. PLEASE REFER TO THE COORDINATED SITE ELECTRICAL DRAWING FOR DETAILS.

AS-BUILT INFORMATION SHOWN IN ITALIC TEXT WAS PROVIDED BY CONTRACTOR ON 04-11-2013 (RFI 01353)

SEE RFI 4099.1: MOVE DRAIN LINE AND STRUCTURE NORTH TO LINE UP WITH DRAIN LINE COMING OUT OF D&T


RFI:01308 - Pipe Elevation Changes

* = REOD 10" DUCTILE IRON WATER OFFSET
** = REOD DEPRESSED ELECTRICAL DUCTBANK
2 FULL BUSINESS DAYS BEFORE DIGGING
DIAL: **811**
OR **800-272-3020**
Louisiana One Call

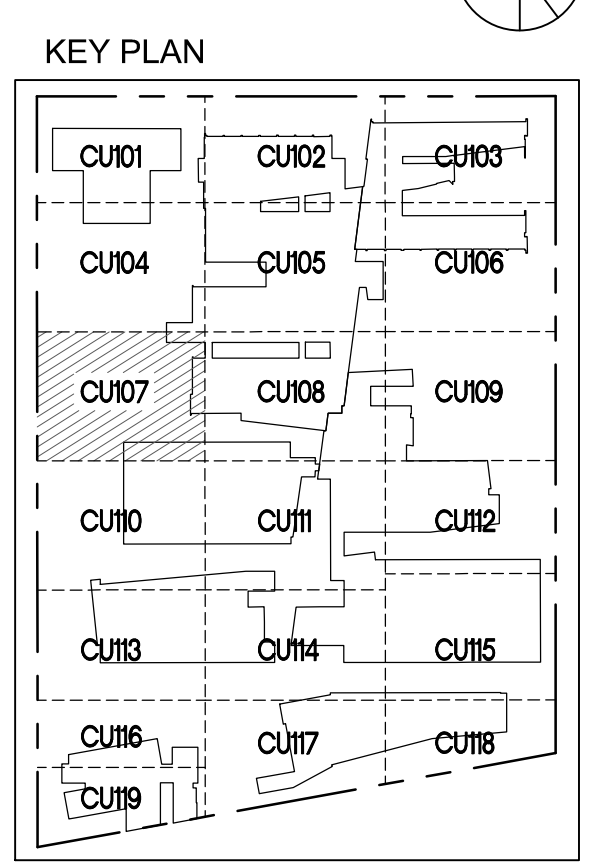

20 - BULLETIN 104	09/27/2013
10 - BULLETIN 013	04/19/2013
3 - ADDENDUM 3 - POST BID	01/23/2013
REVISIONS:	DATE

CONSULTANTS:
DESMAN ASSOCIATES / PARKING
CODE CONSULTANTS, INC. / CODE CONSULTANT
THE SEXTANT GROUP / AV & ACOUSTICAL
HAMMER DESIGN ASSOCIATES / FOOD SERVICE
PYBURN & ODOM / ABATEMENT
TATA & HOWARD / TANK CONSULTANT

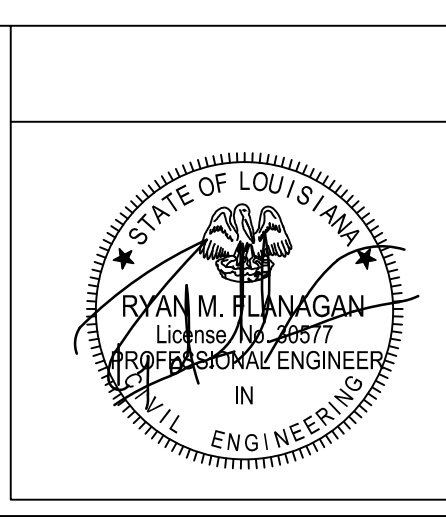

ARCHITECT/ENGINEERS:
studio **NOVA**
SCHRENK & PETERSON CONSULTING ENGINEERS / CIVIL
KORDA/NEMETH ENGINEERING / STRUCTURAL
BR+A CONSULTING ENGINEERS / MECH, ELECT, PLUMBING, LOW VOLTAGE
ARCHITECTURAL ENGINEERING / PLUMBING
SCALES ASSOCIATES / FIRE PROTECTION

DRAWING TITLE
OVERALL UTILITY PLAN
SCALE:
1" = 10'
APPROVED: PROJECT DIRECTOR

PROJECT TITLE
SLVHCS
REPLACEMENT MEDICAL CENTER
PROJECT
LOCATION
NEW ORLEANS, LOUISIANA
DATE
02/29/2012
CHECKED
CMJ
DRAWN
ML

PROJECT NUMBER
629-HS2-401
BUILDING NUMBER
DOCUMENT SET PACKAGE
WP_08
DRAWING NUMBER
CU107

OFFICE OF
CONSTRUCTION
AND FACILITIES
MANAGEMENT
Department of
Veterans Affairs