




one eighth inch = one foot
one quarter inch = one foot
three eighths inch = one foot
one half inch = one foot
three quarters inch = one foot
one inch = one foot
one and one half inch = one foot
two inch = one foot
three inch = one foot

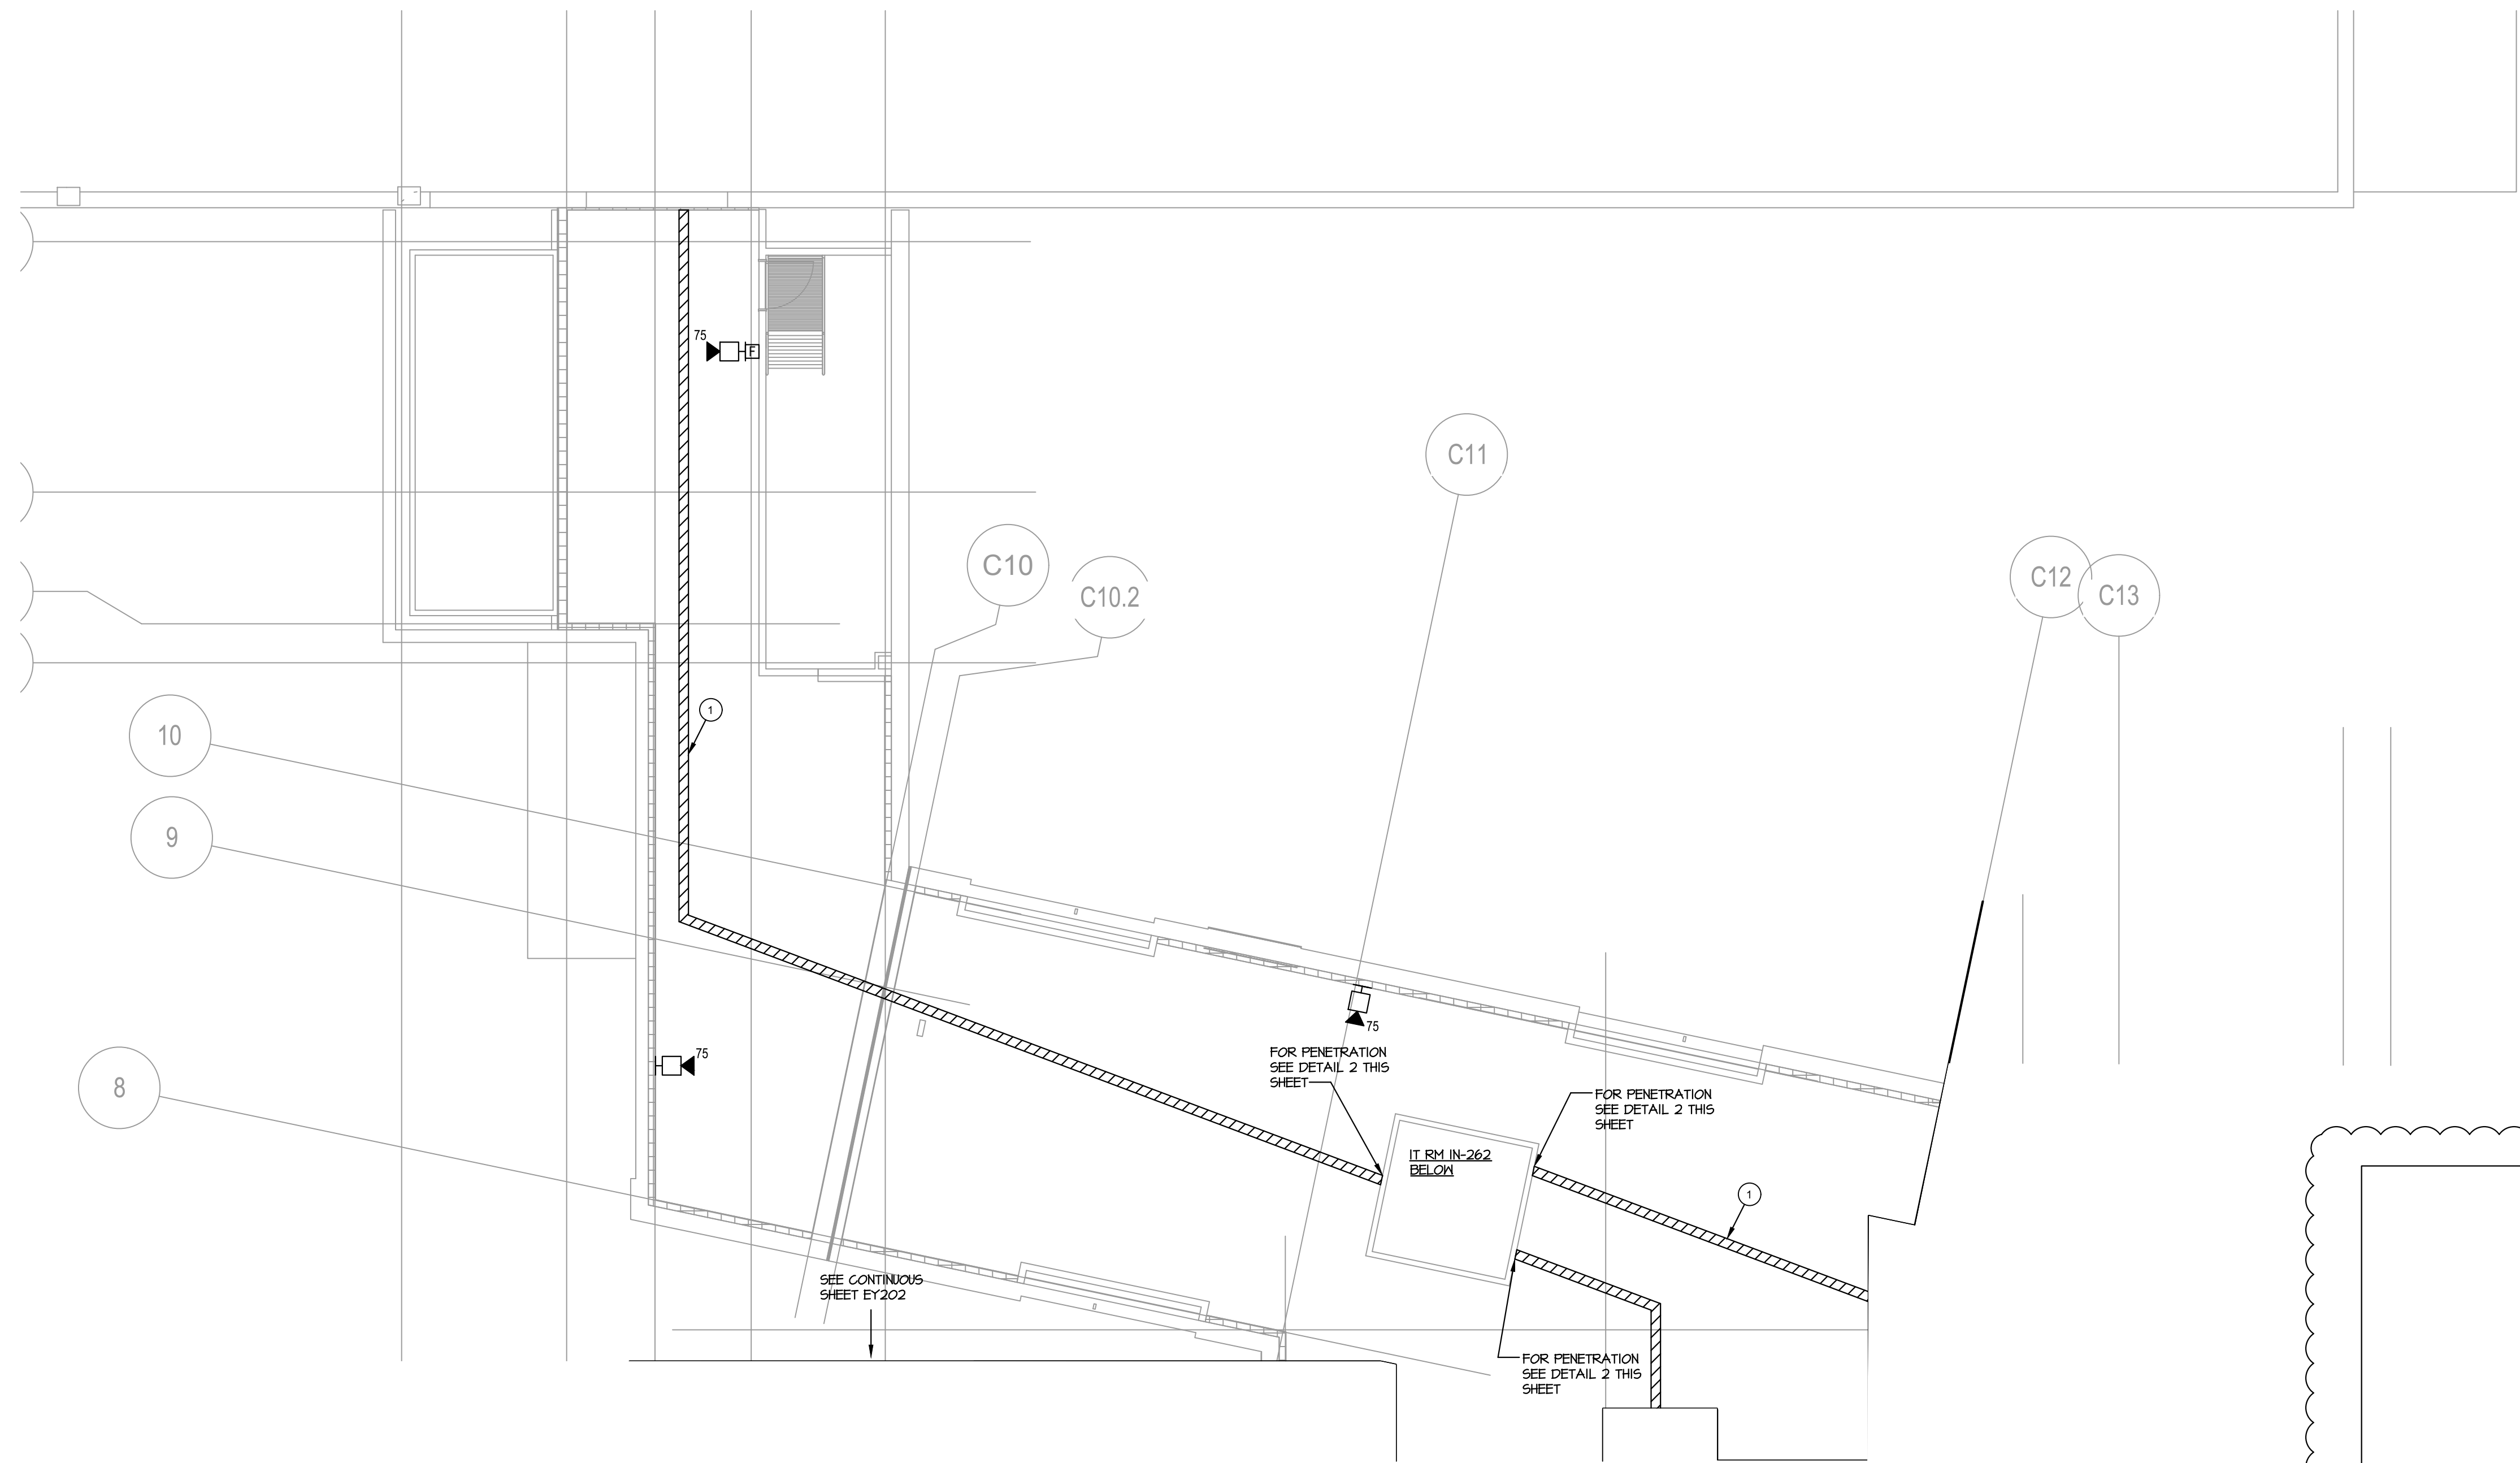

- PLAN NOTES:**
- 1 PROVIDE 2" x 12" BASKET-TYPE CABLE TRAY IN INTERSTITIAL SPACE THE COMMUNICATION WIRES SEE DETAIL 2/EY202.
 - 2 RUN TWO (2) SETS OF CAT6 WIRING THE ENTIRE LENGTH OF THE CABLE TRAY FOR WIRELESS ACCESS POINTS. ONE SET TO BE GREEN AND ONE SET TO BE ORANGE.

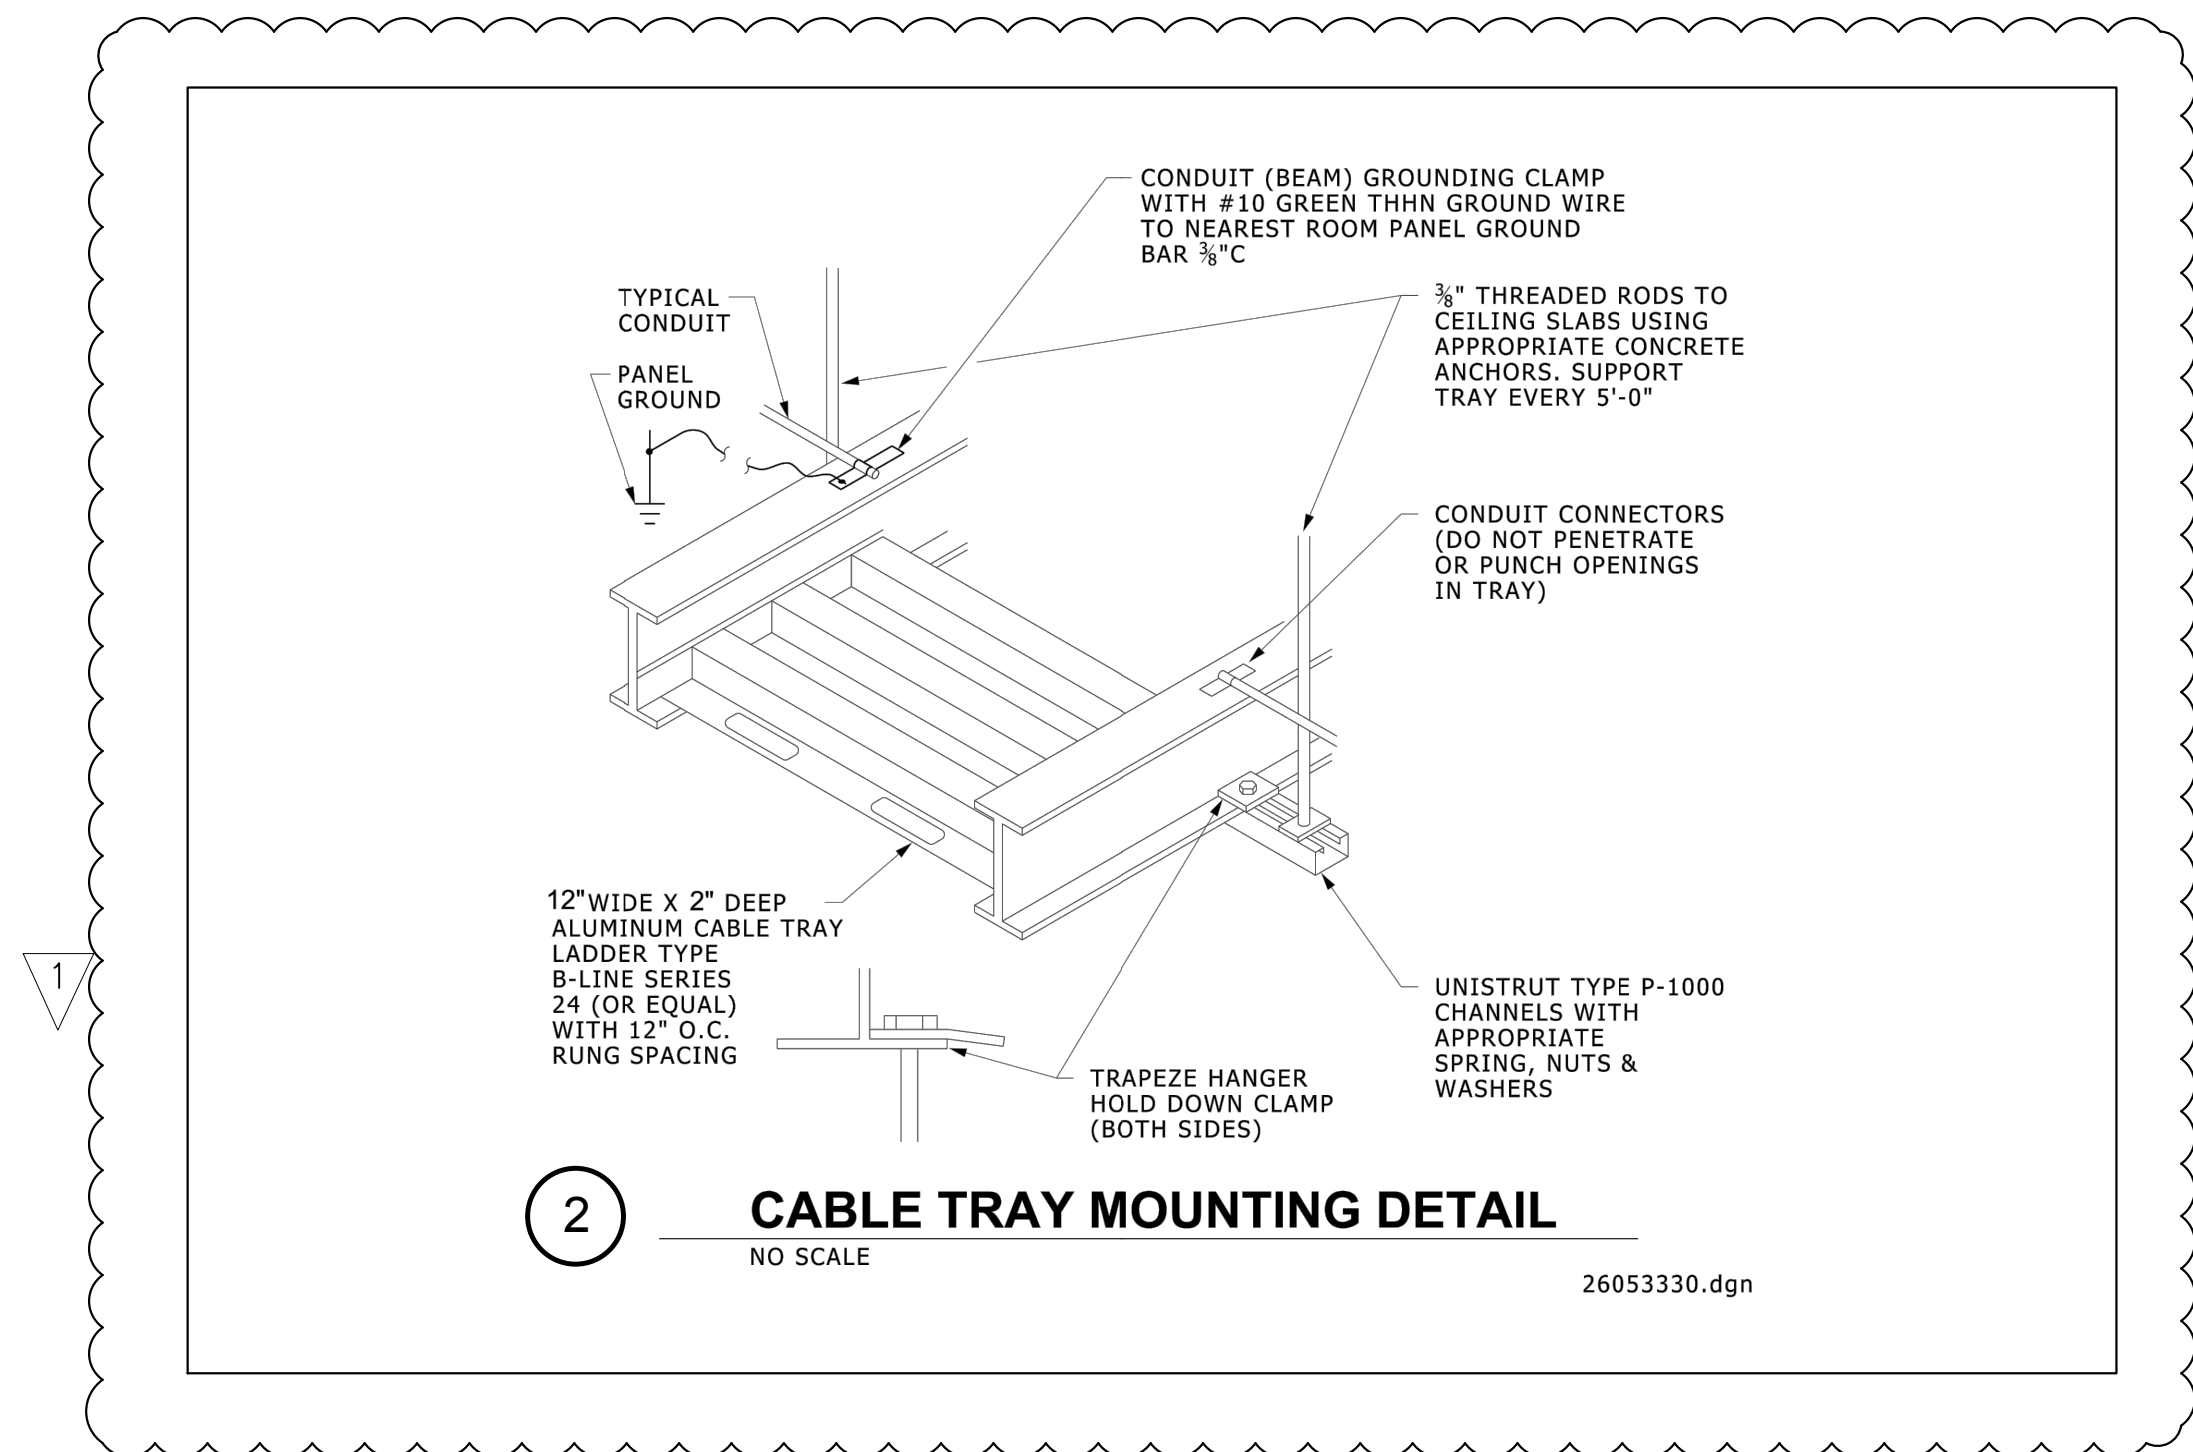

1 INTERSTITIAL LOW VOLTAGE PLAN - KNUCKLE
1/8" = 1'-0"

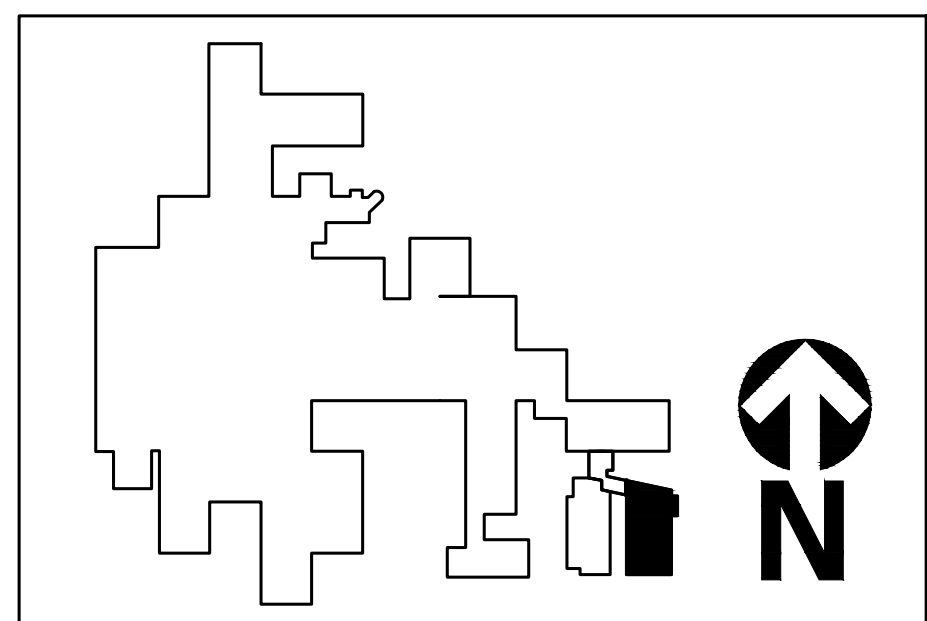

<div></div> <div>02-22-2018</div> <div>ADDENDUM #1</div>	CONSULTANTS:		STAMP	ARCHITECTS/ENGINEERS:		<div>Drawing Title: INTERSTITIAL LOW VOLTAGE PLAN - KNUCKLE</div>	<div>Project Title: COMMUNITY LIVING CENTER EXPANSION AND RENOVATION</div>	<div>Project Number: VA 246 14R 0013</div>	<div>Office of Construction and Facilities Management</div> <div> Department of Veterans Affairs</div>
	<div>1451 Dolley Madison Blvd. Suite 220 McLean VA 22101-3812 703-827-9552 www.ehlert-bryan.com</div> <div> ENGINEERING ■ PLANNING ■ LANDSCAPE ■ ARCHITECT ■ SURVEYING ■ DESIGN ■ LASER ■ SCANNING VIFA MARYLAND LLC 20201 CENTURY BOULEVARD, SUITE 400 ■ GERMANTOWN, MARYLAND 20874 (301) 916-4100 ■ FAX: (301) 916-2262 WWW.VIFA.COM</div>	<div> </div>	<div> HUELAT DAVIS HEALING DESIGN  DESIGN-AIRE ENGINEERING, INC.</div> <div>Virginia 635 S. Fairfax Street Alexandria, VA 22314 703.838.8414 www.healingdesign.com 220 North College Avenue Indianapolis, Indiana 46202 464.9090 ■ www.daengineering.com</div>	<div>Approved: Project Director</div>	<div>Location: 1201 Broad Rock Blvd. Richmond, VA 23249</div>	<div>Drawing Number: EY201</div>			
					<div>Date: APRIL 14, 2017</div>	<div>Checked: EWB</div>	<div>Drawn: DAE</div>	<div>DWG.155 OF 158</div>	