


\\va\apps\va\proj\14-8101\050\Drawings\417-AS-101.dwg, Wed May 30 13:46:51 2012

three inches = one foot
one and one half inches = one foot
one inch = one foot
three quarters inch = one foot
one half inch = one foot
three eighths inch = one foot
one quarter inch = one foot
one eighth inch = one foot
one sixteenth inch = one foot

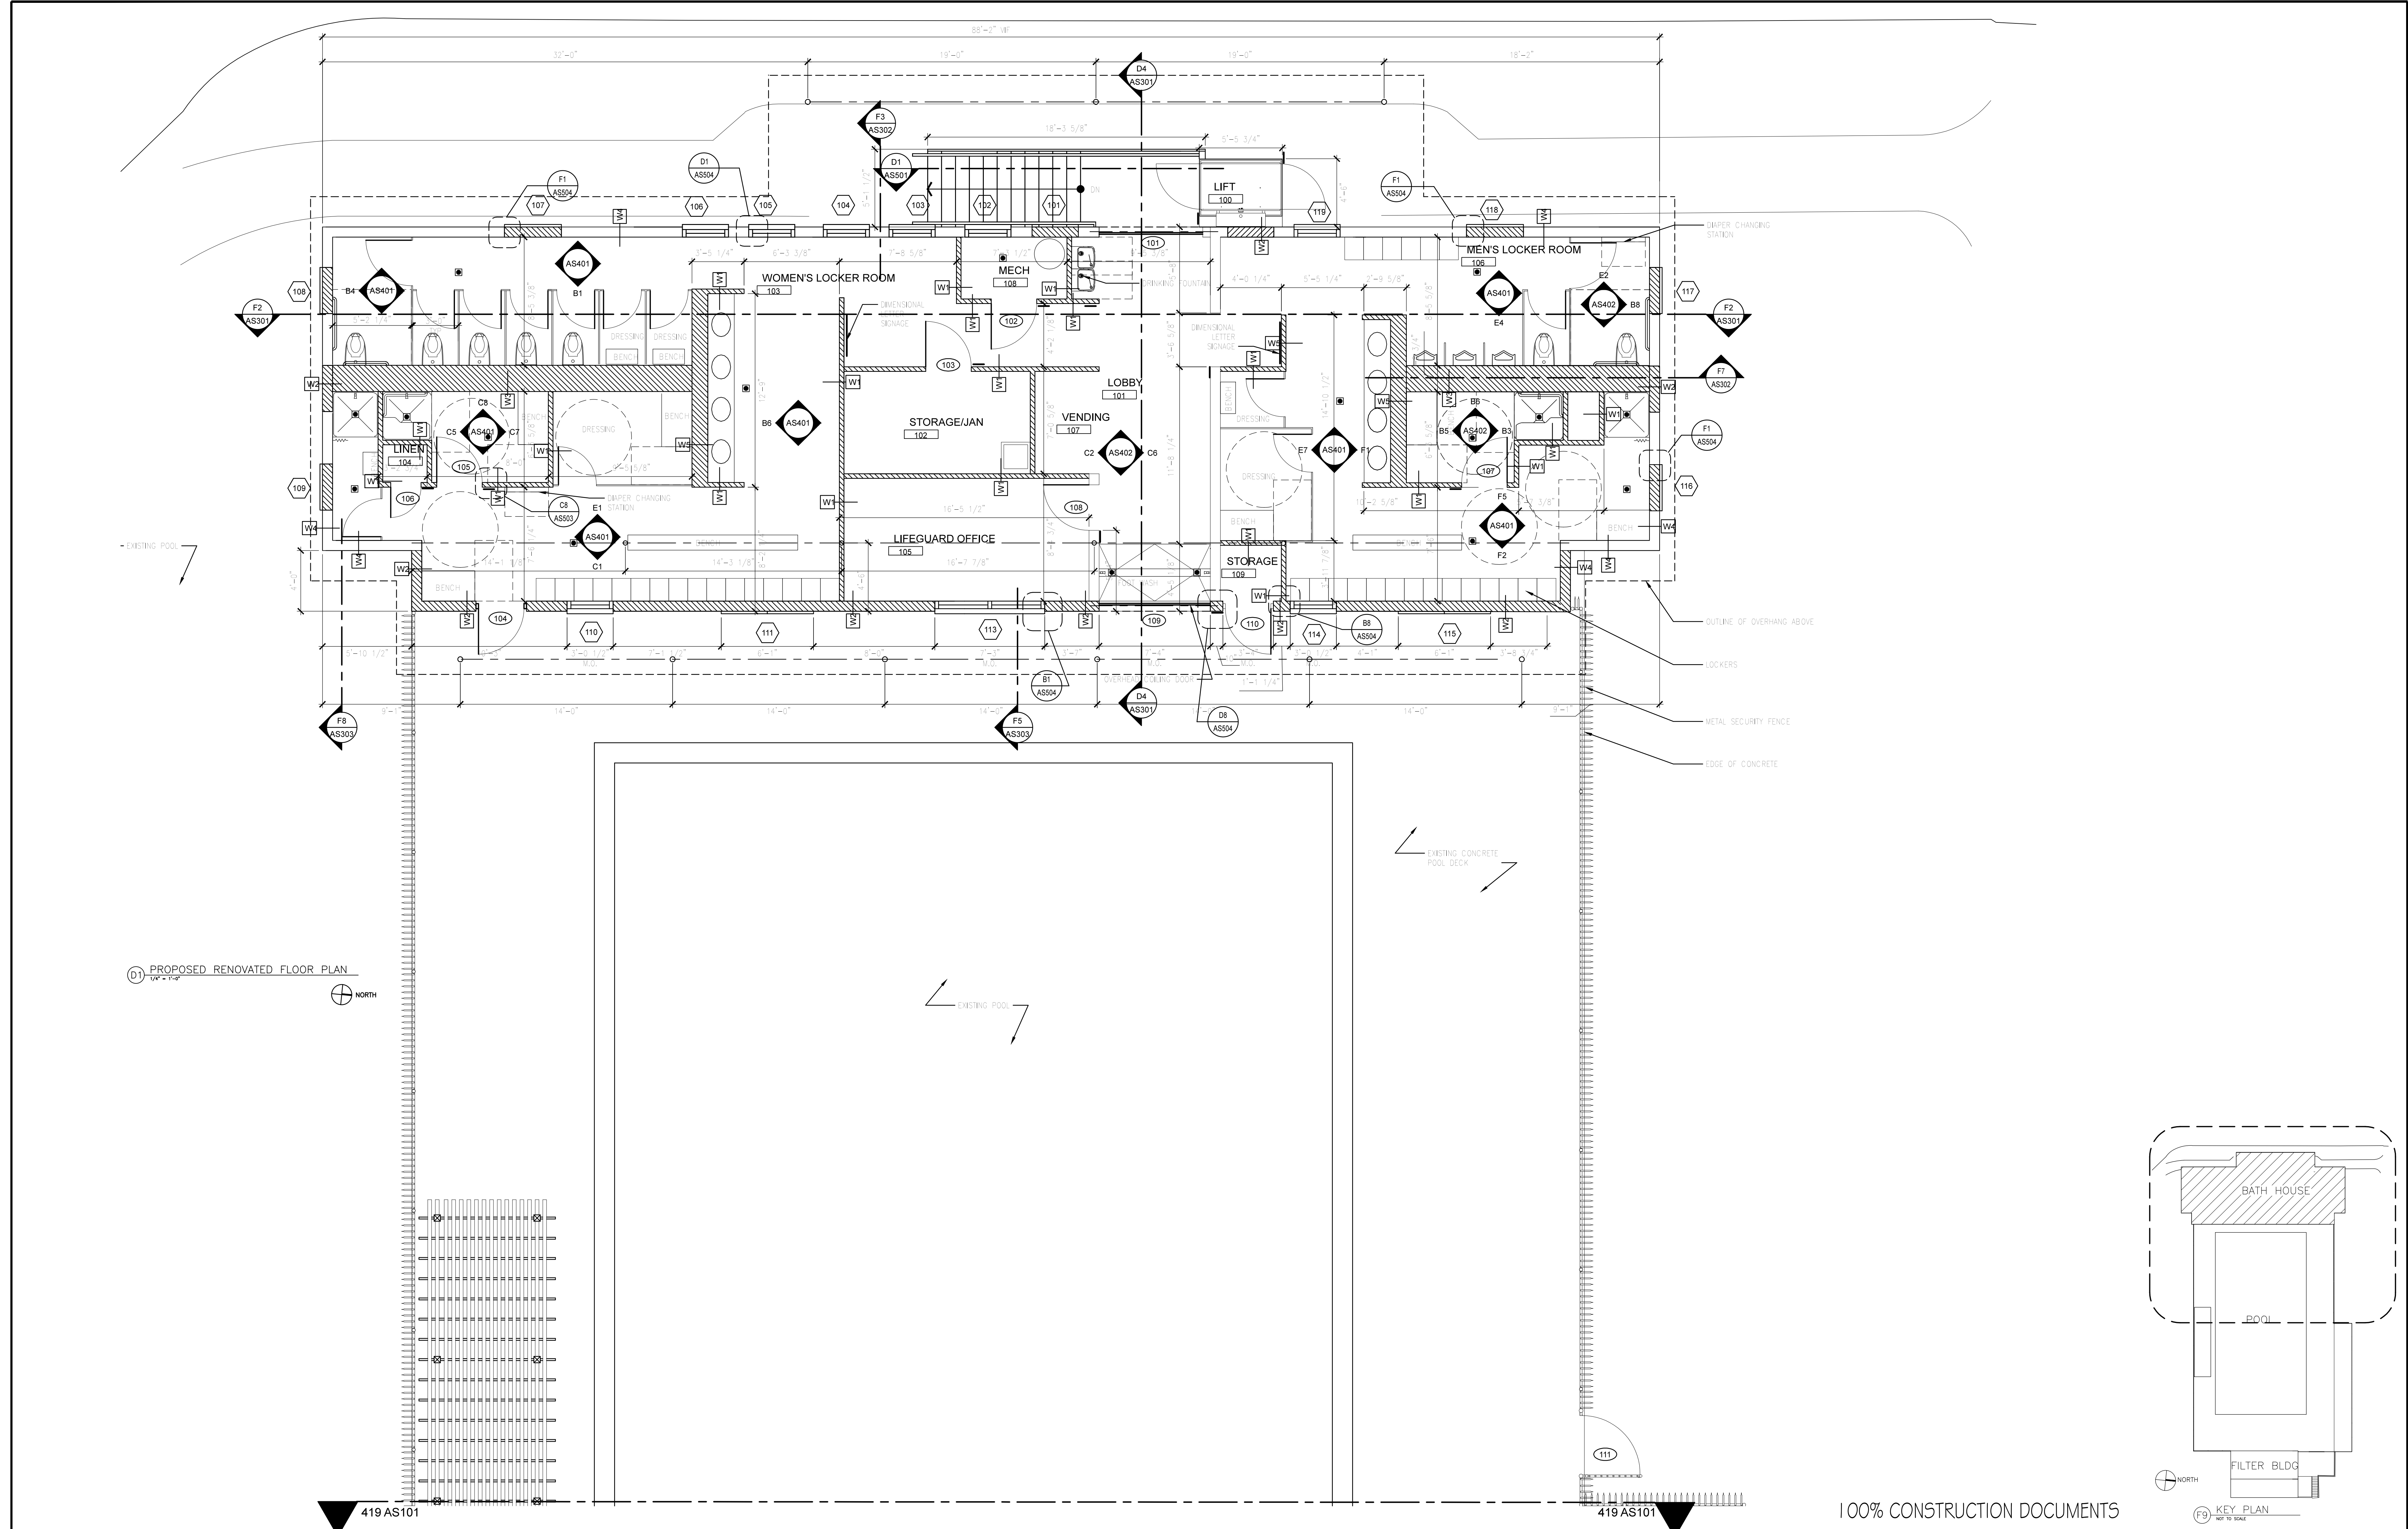

CONSULTANTS:			ARCHITECT/ENGINEERS: SAA architects 600 North Hartley Street, Suite 150 T 717.843.3200 F 717.699.0205 York, PA 17404 www.saaarchitects.com	Drawing Title FLOOR PLANS Approved: Project Director	Project Title RECREATIONAL POOL FACILITY RENOVATIONS BATH HOUSE Location VAMC, MARTINSBURG, WV Date 05-14-12 Checked DRSD Drawn CAP	Project Number 613-11-140 Building Number 417 Drawing Number 417-AS-101 Dwg. 6 of 24	Office of Construction and Facilities Management Department of Veterans Affairs
Revisions:	Date						