

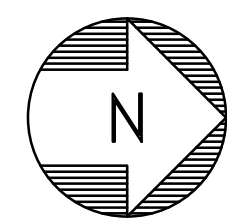
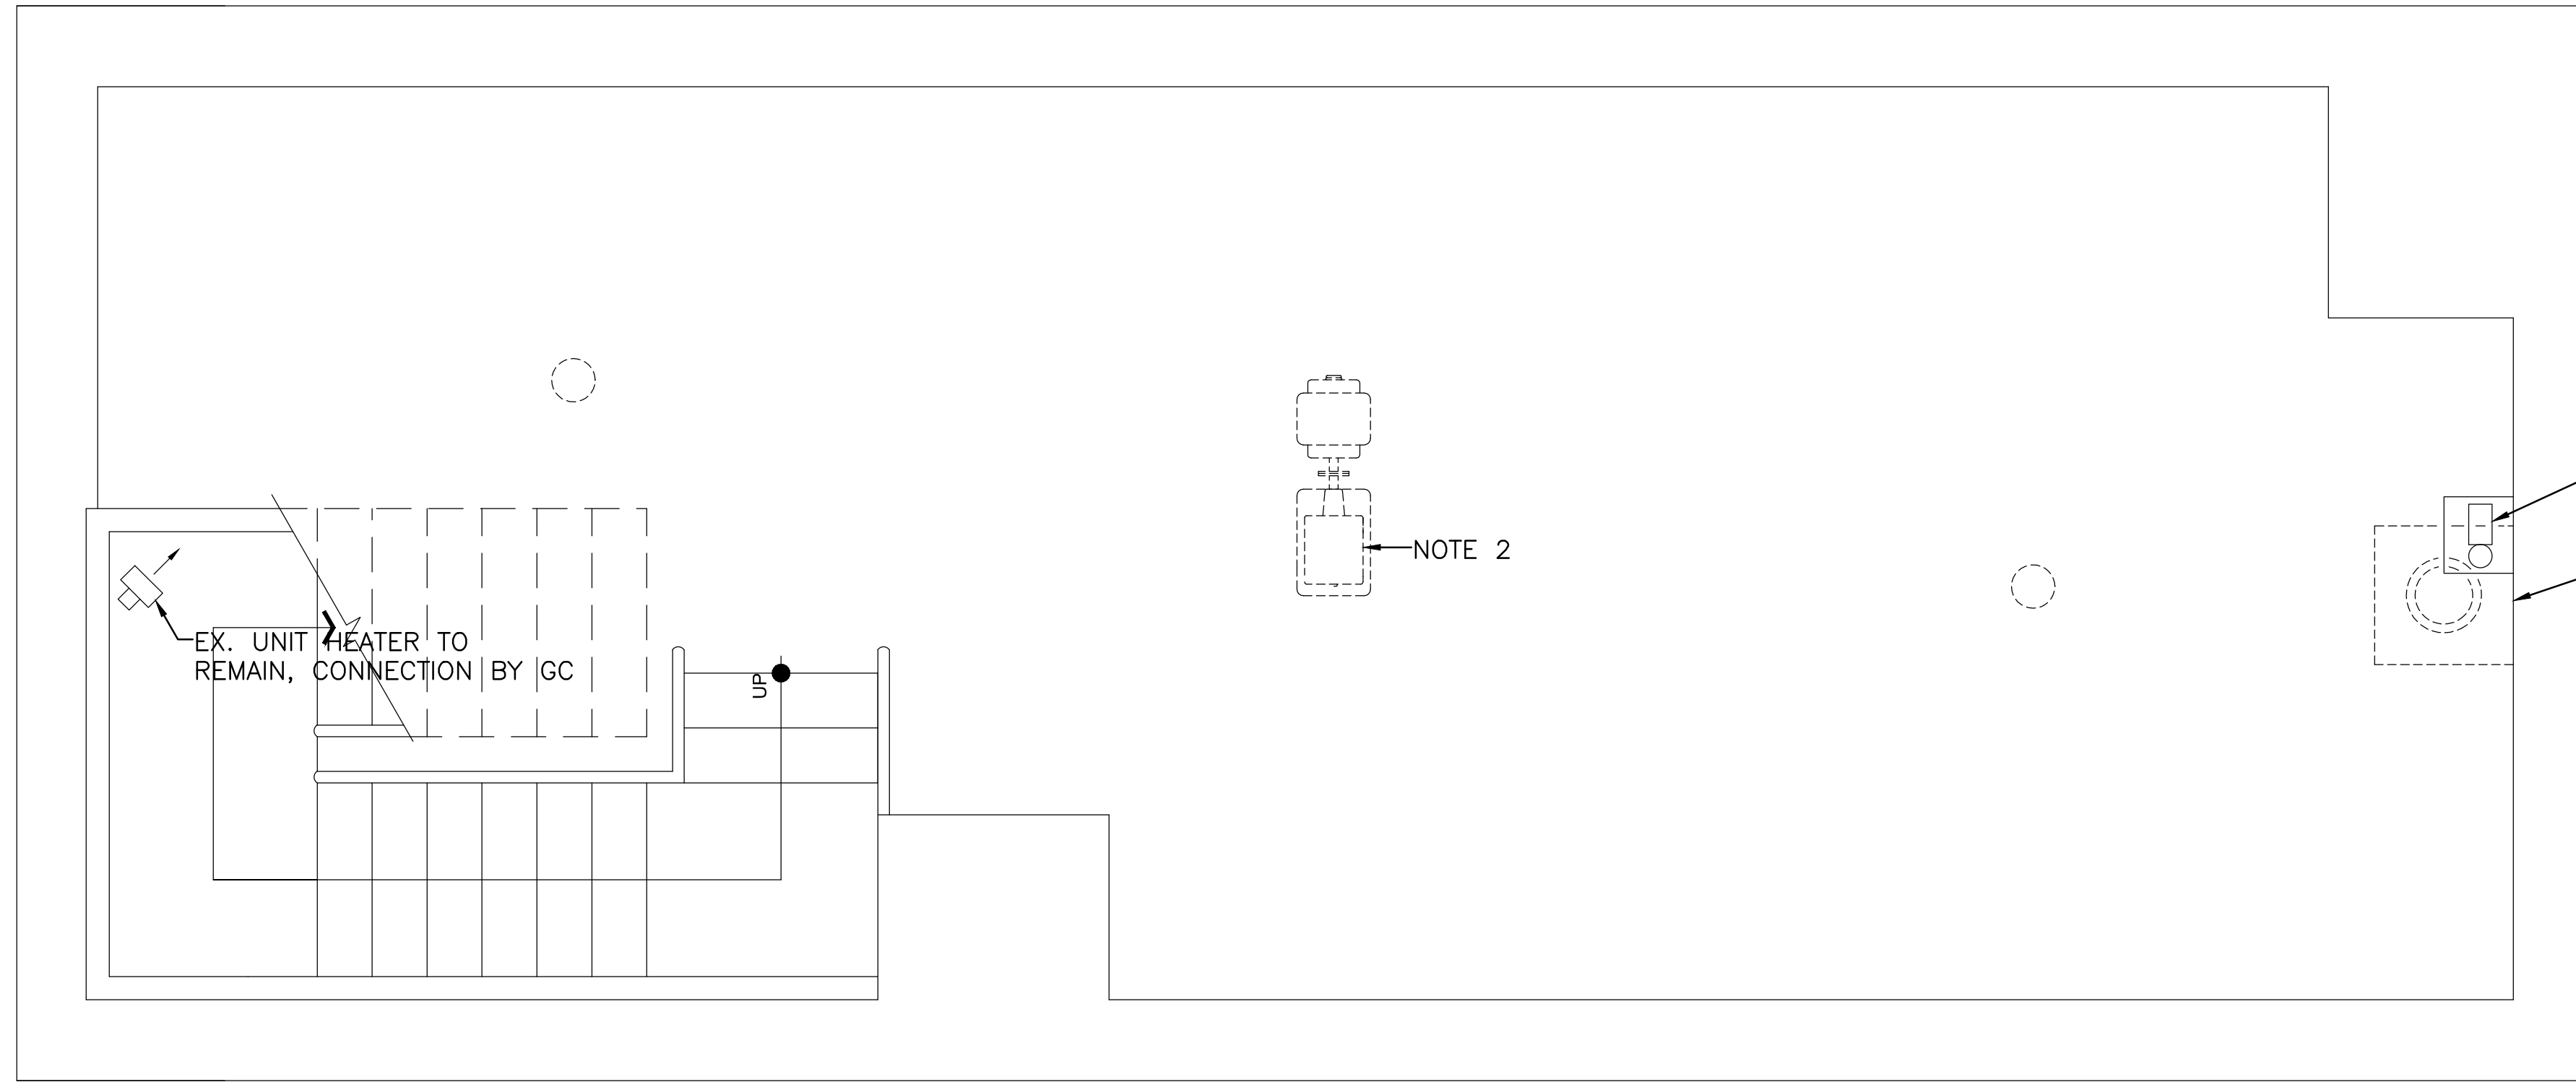


0:\2011\20-00\WSS\451822\419\ED101.dwg, 5/20/2012 7:20:41 AM Tim P. Miller  
one eighth inch = one foot  
one quarter inch = one foot  
three eighths inch = one foot  
one half inch = one foot  
three quarters inch = one foot  
one inch = one foot  
one and one half inches = one foot  
two inches = one foot  
three inches = one foot  
four inches = one foot  
six inches = one foot  
one foot = one foot

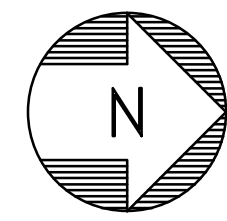

**BUILDING 419 - LOWER LEVEL FLOOR PLAN - DEMOLITION - ELECTRICAL**  
SCALE: 1/2"=1'-0"

NOTE 1

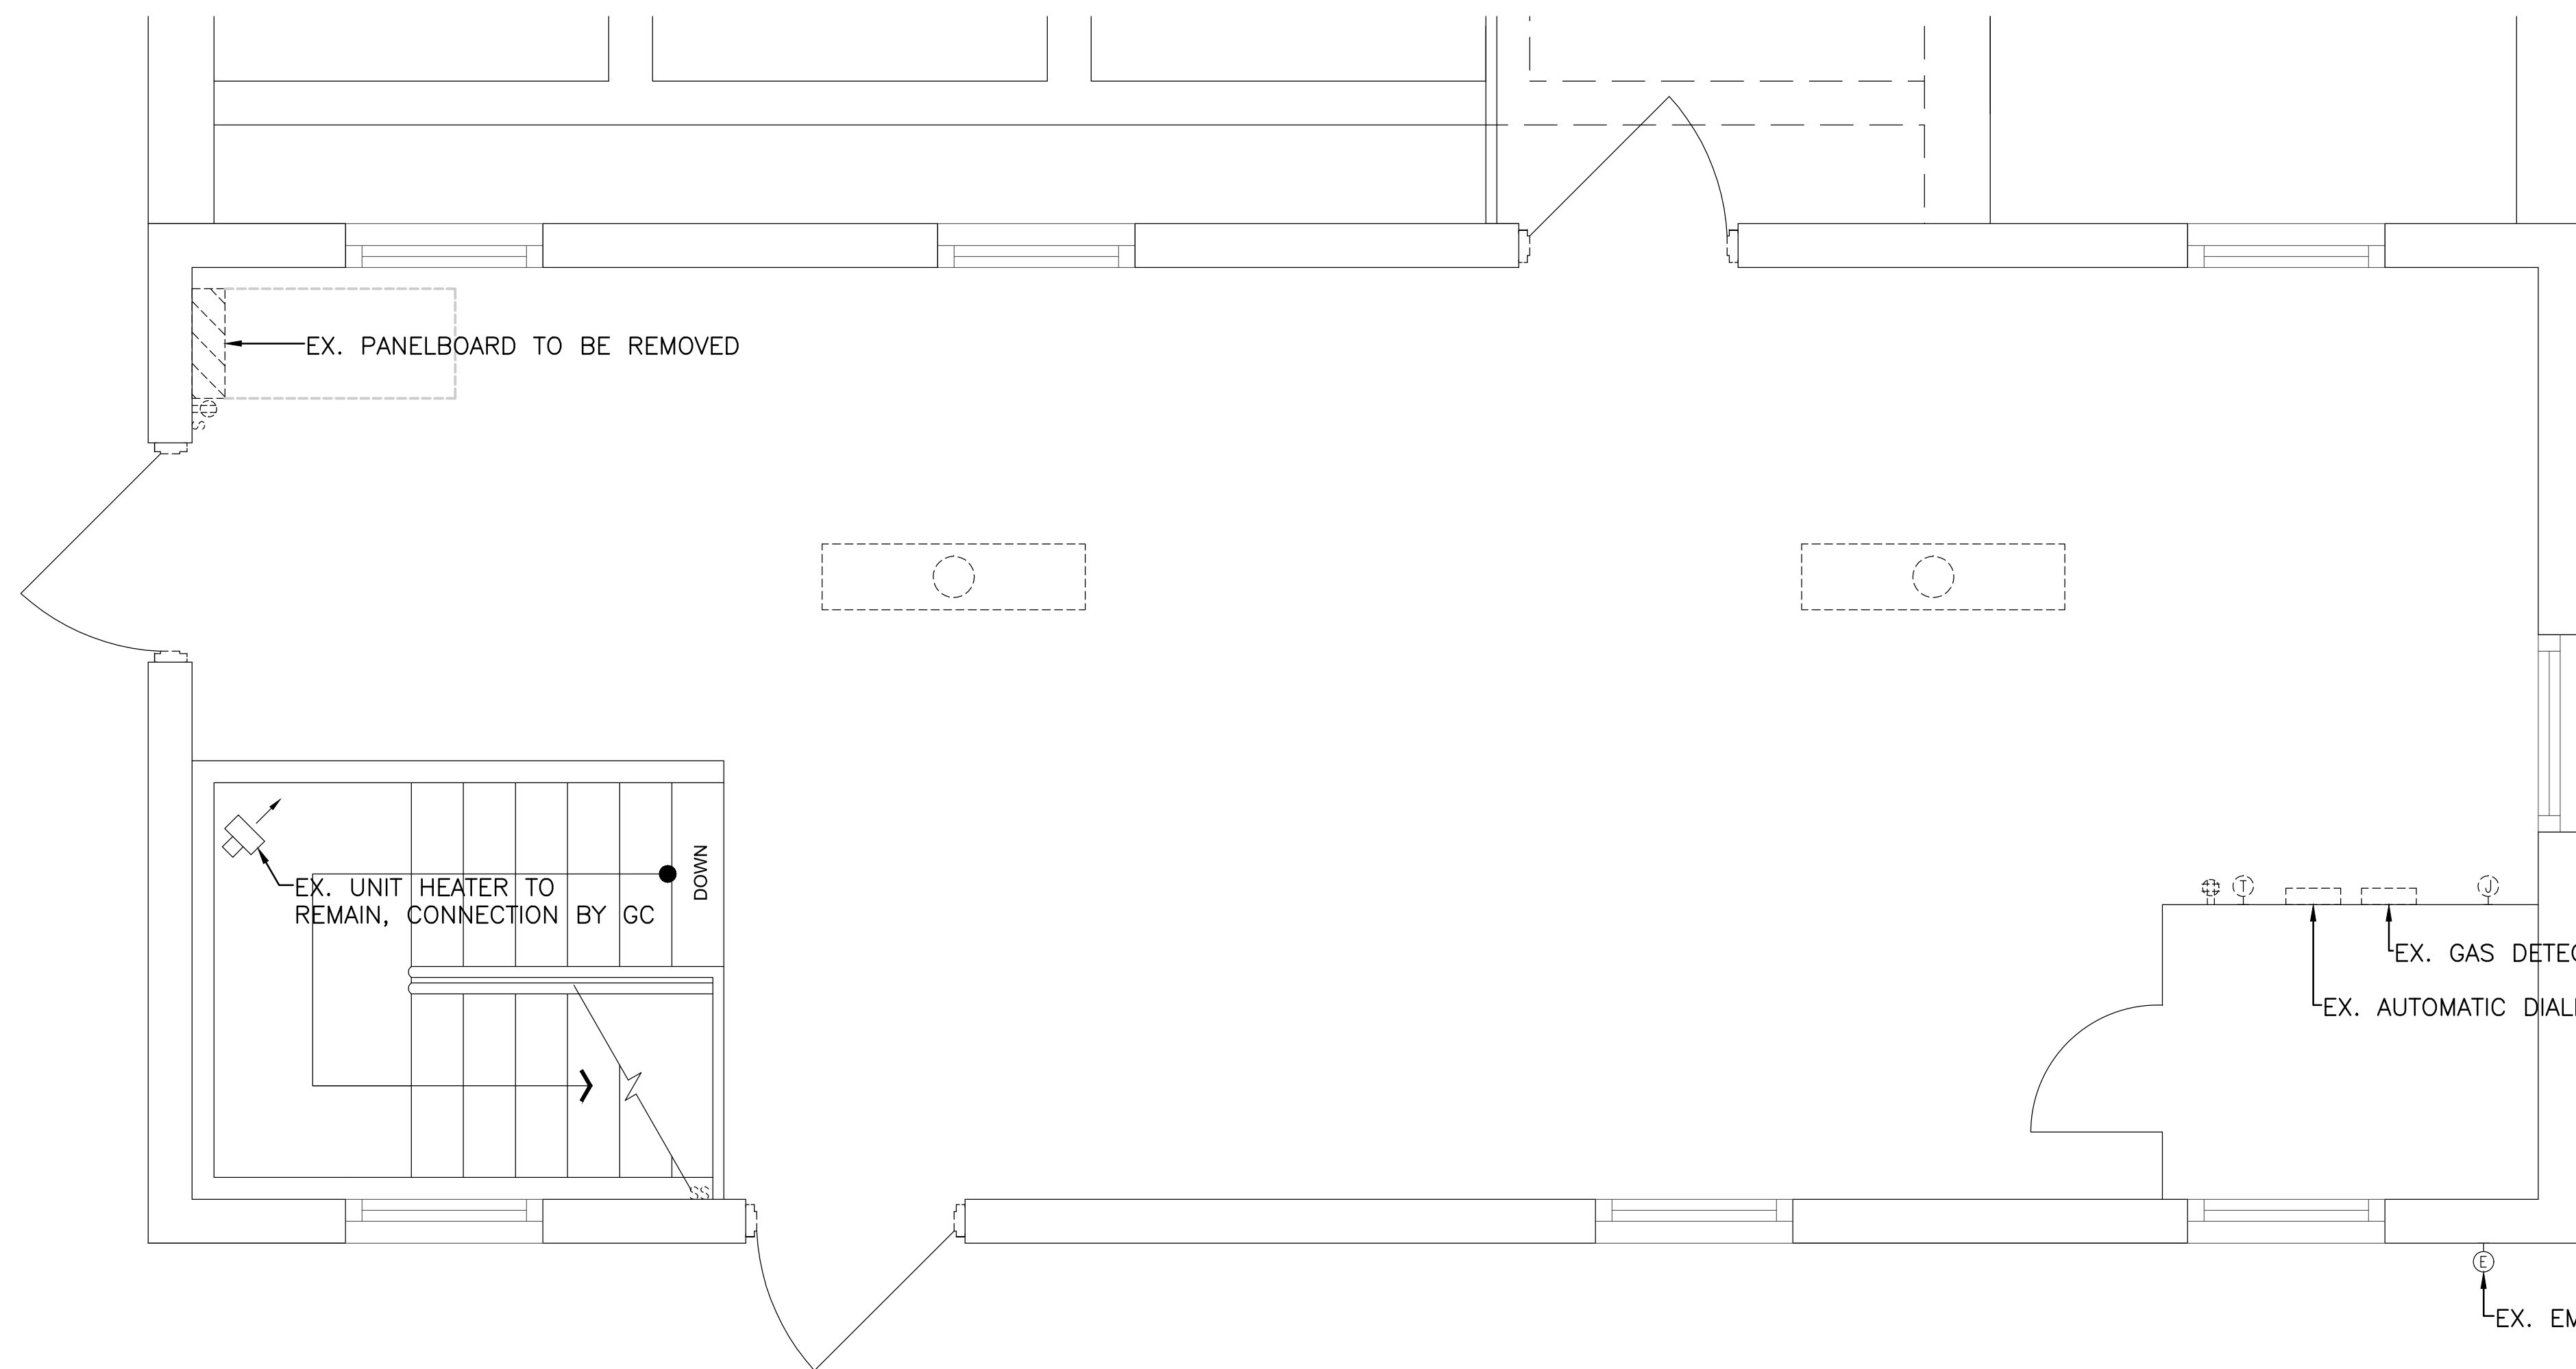


**BUILDING 419 - UPPER LEVEL FLOOR PLAN - DEMOLITION - ELECTRICAL**  
SCALE: 1/2"=1'-0"

NOTE 1

**NOTES:**

1. ALL EXISTING ELECTRICAL ITEMS TO BE REMOVED, UNLESS NOTED OTHERWISE.
2. EXISTING POOL PUMP TO BE REMOVED BY PLUMBING CONTRACTOR, DISCONNECT AND REMOVE ALL ASSOCIATED LINE VOLTAGE CONTROLS, WIRING, AND CONDUIT AS REQUIRED.
3. EXISTING SUMP PUMP TO BE REMOVED BY PLUMBING CONTRACTOR, DISCONNECT AND REMOVE ALL ASSOCIATED LINE VOLTAGE CONTROLS, WIRING, AND CONDUIT AS REQUIRED.

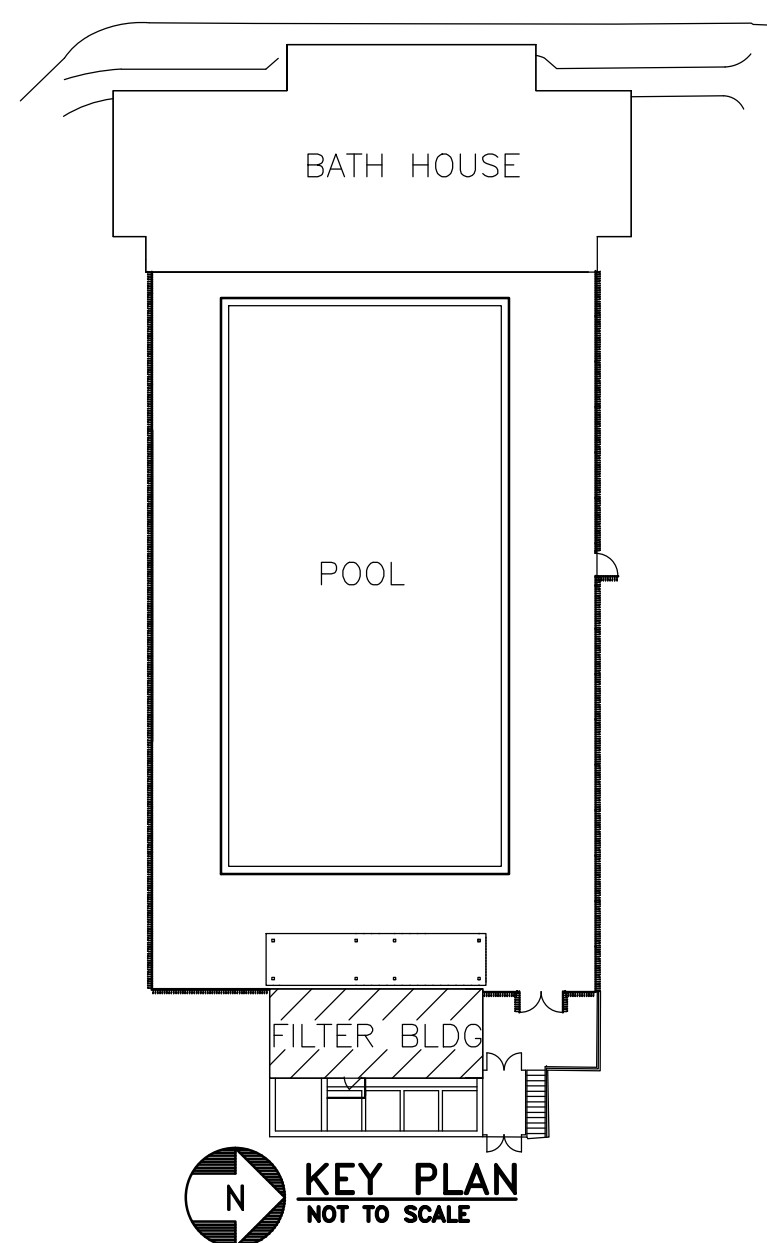

**KEY PLAN**  
NOT TO SCALE

100% CONSTRUCTION DOCUMENTS

<b>CONSULTANTS:</b> <b>Barton Associates</b> Consulting Engineers Beverly Hills, California 90212 221 West Philadelphia Street York, PA 17404 Tel: (717) 945-1054 Web: www.barton-associates.com We Make Buildings Work. PROJECT No. 2011129.00 DATE 05-04-12 CHECKED BY WLS DESIGNED BY BCB Copyright © 2012 Barton Associates, Inc.		<b>ARCHITECT/ENGINEERS:</b> <b>SAA architects</b> 600 North Hartley Street, Suite 150 York, PA 17404 T 717.843.3200 F 717.699.0205 www.saaarchitects.com		<b>Drawing Title</b> BUILDING 419 - DEMOLITION - ELECTRICAL <b>Approved Project Director</b>		<b>Project Title</b> RECREATIONAL POOL FACILITY RENOVATIONS FILTER BUILDING <b>Location</b> VAMC, MARTINSBURG, WV <b>Date</b> 05-04-12 <b>Checked</b> - <b>Drawn</b> -		<b>Project Number</b> 613-11-140 <b>Building Number</b> 419 <b>Drawing Number</b> 419-ED101 Dwg. of -		<b>Office of Construction and Facilities Management</b> <b>Department of Veterans Affairs</b>	
--	--	---	--	--	--	--	--	---	--	--	--