





 **ROOF AND PENTHOUSE ELECTRICAL POWER PLAN**
SCALE: 1/4"=1'-0"

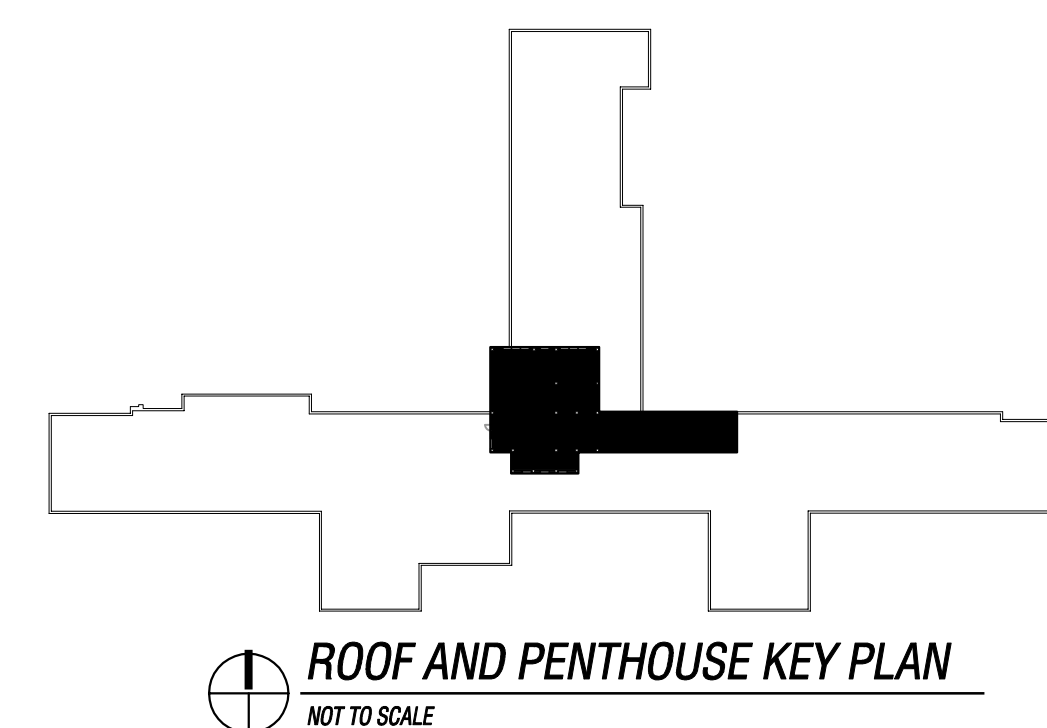

		CONSULTANTS:				ARCHITECT/ENGINEERS:  PRIMARY ENGINEERING, INC. Fort Wayne 2626 Lake Ave. Fort Wayne, Indiana 46805 260.424.0444 ph 260.424.1444 fax info@primary-eng.com www.primary-eng.com PRIMARY JOB # 09252		Drawing Title ROOF LEVEL ELECTRICAL PLAN		Project Title VA MORGUE VENTILATION		Project Number 610A4-01-104		Office of Construction and Facilities Management  Department of Veterans Affairs	
						Approved: Project Director		Location FORT WAYNE INDIANA		Building Number 1		Drawing Number E202 Dwg-SHT10of 10			
Revisions:		Date						Date 02/08/2012		Checked CUB		Drawn CUB			