


H:\BMA Projects\VA Medical Center Bldg 01 - White River JCT\Sheets\CD\A-203.dwg, 7/27/2012 1:55:08 PM, 30x42, 1:1



Revisions		Date	ARCHITECT: BMA ARCHITECTS ■ PLANNERS 103 Wales Street, Rutland VT 05701 Ph: 802.773.8245 Fx: 802.773.8235 210 South Street, Bennington VT 05201 Ph: 802.445.7170 Fx: 802.445.7175 Toll Free: 800.754.9056 www.bma-architects.com				Professional Seal		Drawing Title NORTH ELEVATION AND DETAILS	Project Title WRJ VAMC BLDG. 1 WINDOW REPLACEMENT		Date MAY 02, 2011
Approved: Project Manager		Approved: Service Chief		Building Number 1		Checked	Drawn	Location VAMC, WHITE RIVER JUNCTION V.T.		Project No. 405-09-114		Drawing No. A-203

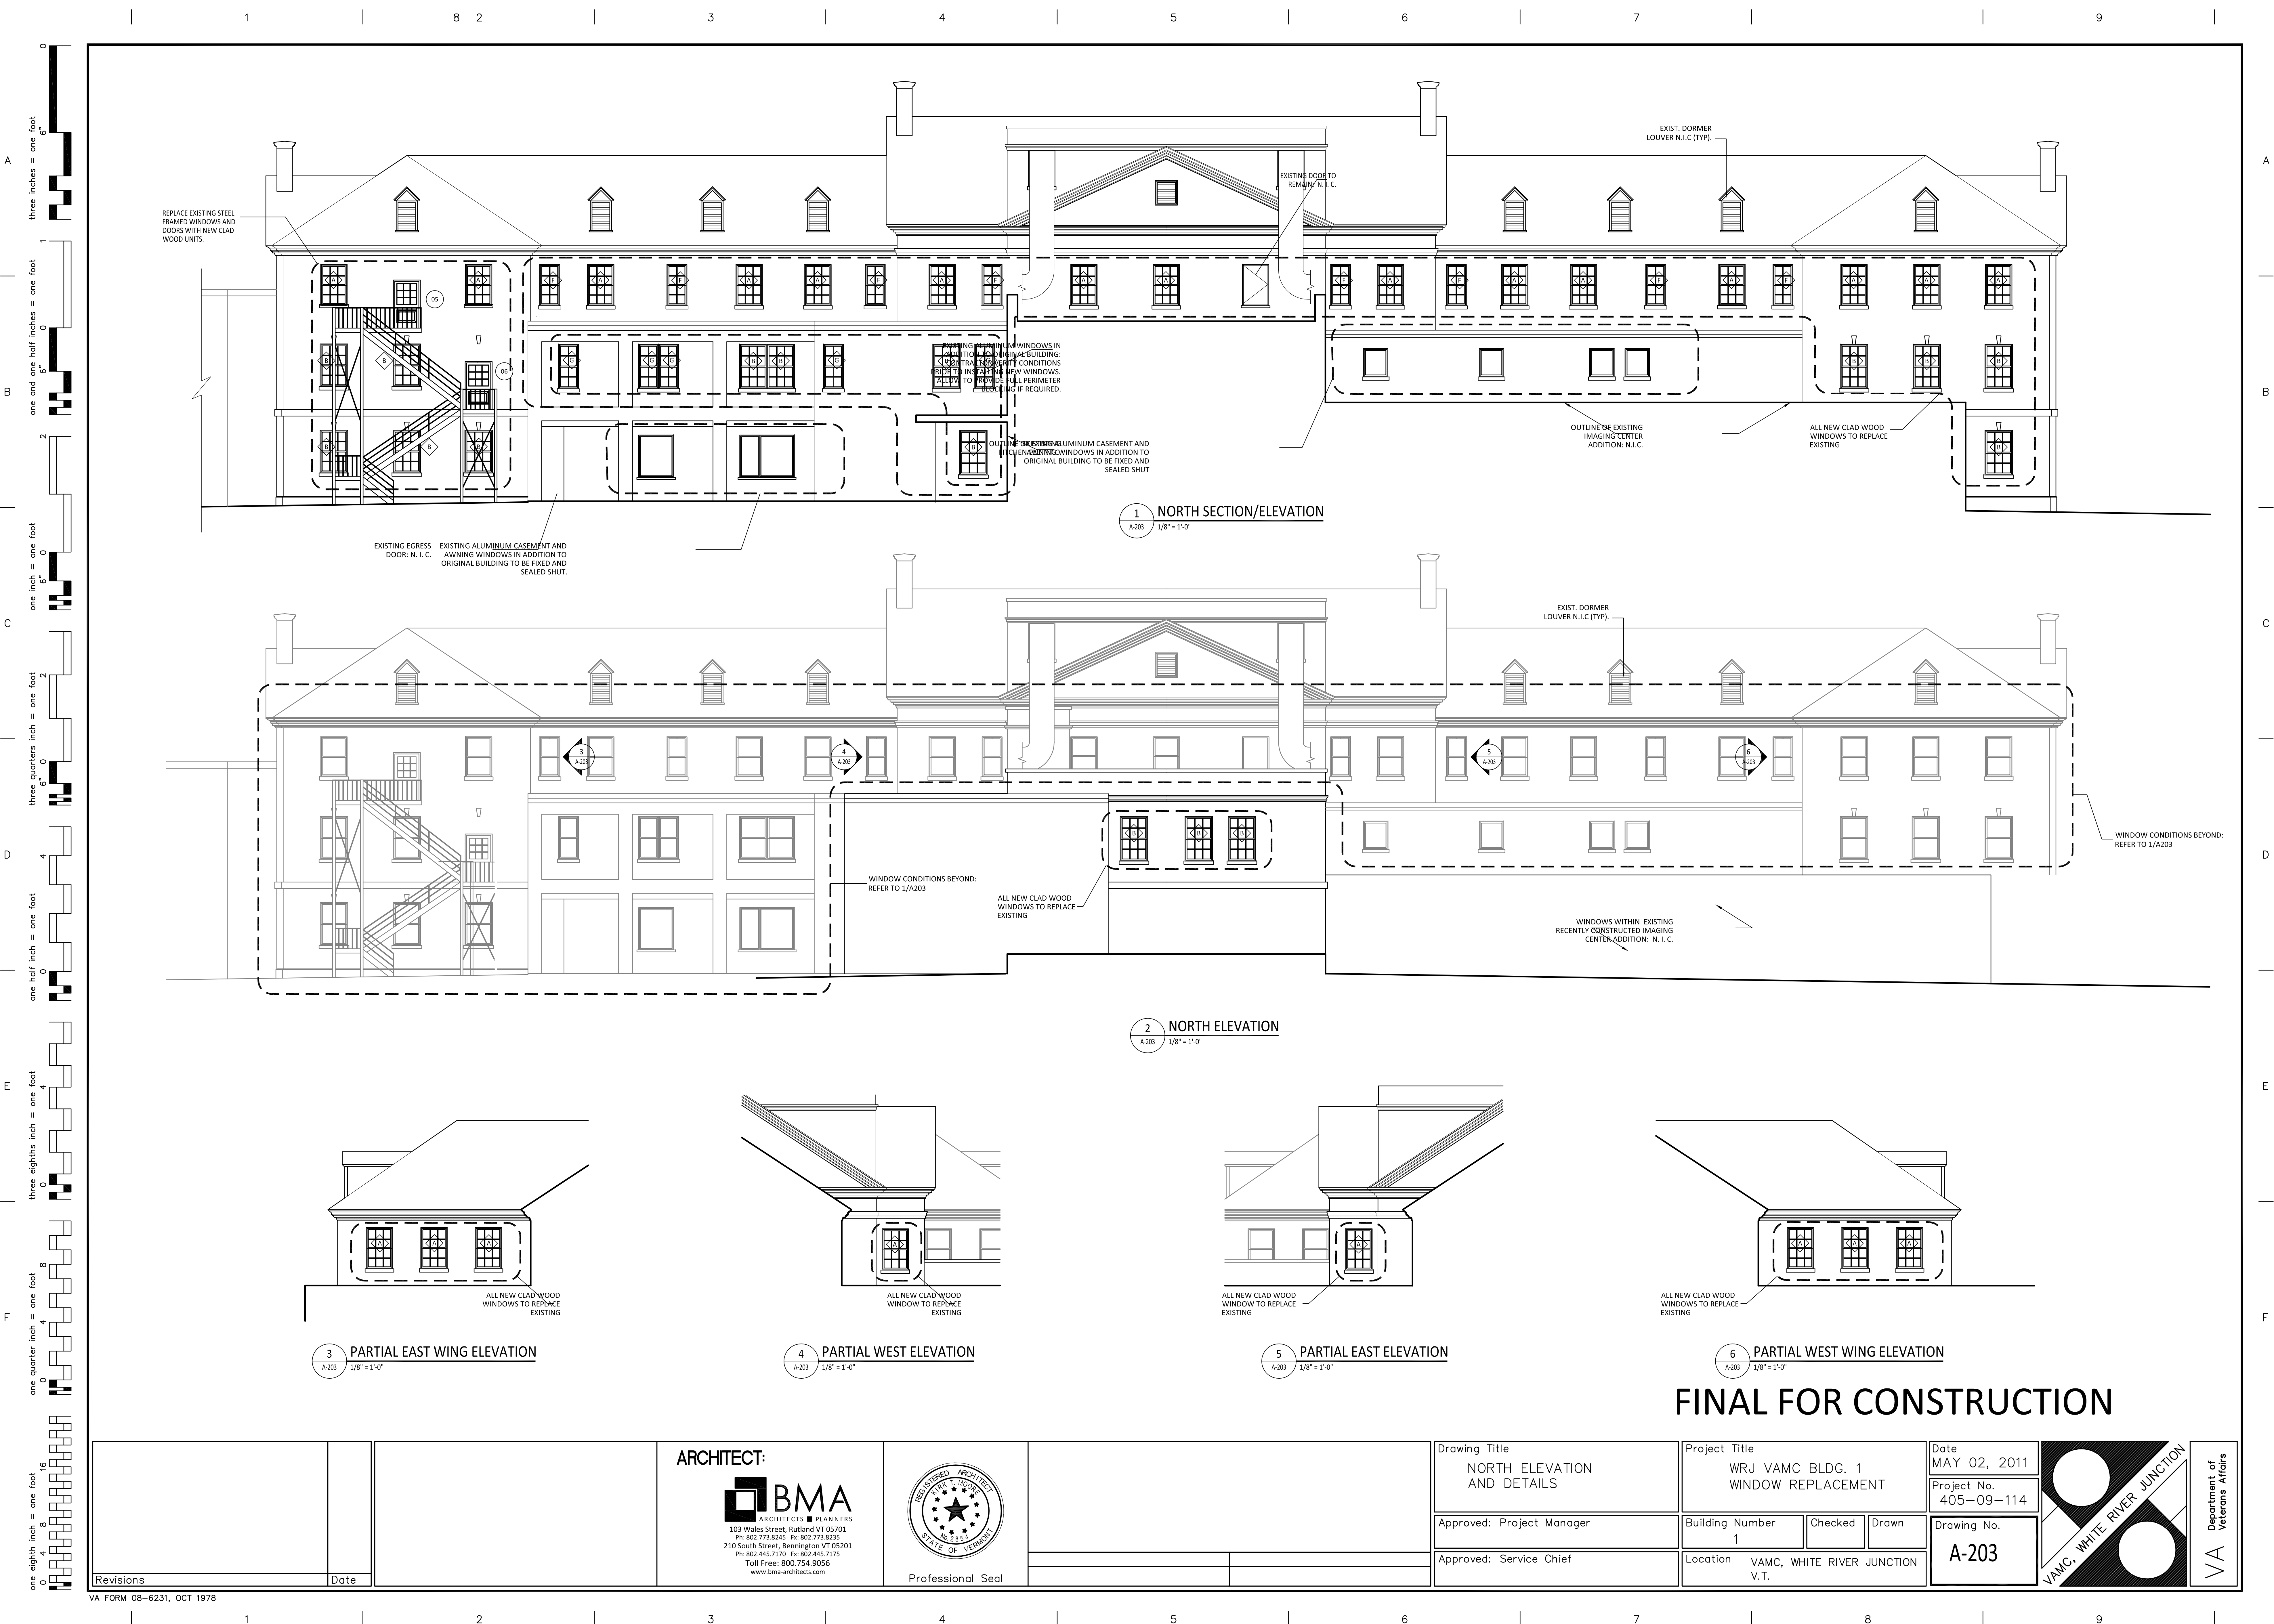