

A

B

C

D

E

F

A

B

C

D


E


F

three inches = one foot  
one and one half inches = one foot  
one inch = one foot  
three quarters inch = one foot  
one half inch = one foot  
three eighths inch = one foot  
one quarter inch = one foot  
one eighth inch = one foot

AC 11-1 located on this roof

LEGEND	
SYMBOLS / LINE TYPES	DESCRIPTION
⊙	EXHAUST FAN
↻	RETURN AIR
⊙	RETURN DIFFUSER
⊙	SUPPLY DIFFUSER
—	WALL CLEAN OUT
⊙	SUPPLY DIFFUSER
⊙	EXHAUST DIFFUSER
⊙	GRILLE
⊙	ROOM CONTROL THERMOSTAT
⊙	RETURN DIFFUSER
⊙	RISEN
⊙	MOTOR OPERATED DAMPER
⊙	GATE VALVE
⊙	HEAT EXCHANGER
⊙	FLEXIBLE CONNECTION
⊙	FLOW
⊙	FLOAT & THERMOSTATIC TRAP SET
⊙	DIFFERENTIAL PRESSURE VALVE
⊙	UNIT HEATER
⊙	FIRE DAMPER
⊙	END CAP
⊙	RETURN AIR FLOW DIRECTION
⊙	DRAIN VALVE
⊙	CHILLED WATER SUPPLY
⊙	CHILLED WATER RETURN
⊙	MEDIUM PRESSURE STEAM RETURN
⊙	MEDIUM PRESSURE STEAM SUPPLY
⊙	CHILLED WATER SUPPLY
⊙	CHILLED WATER RETURN
⊙	HOT WATER RETURN
⊙	HOT WATER SUPPLY
⊙	CONDENSATE DRAIN LINE

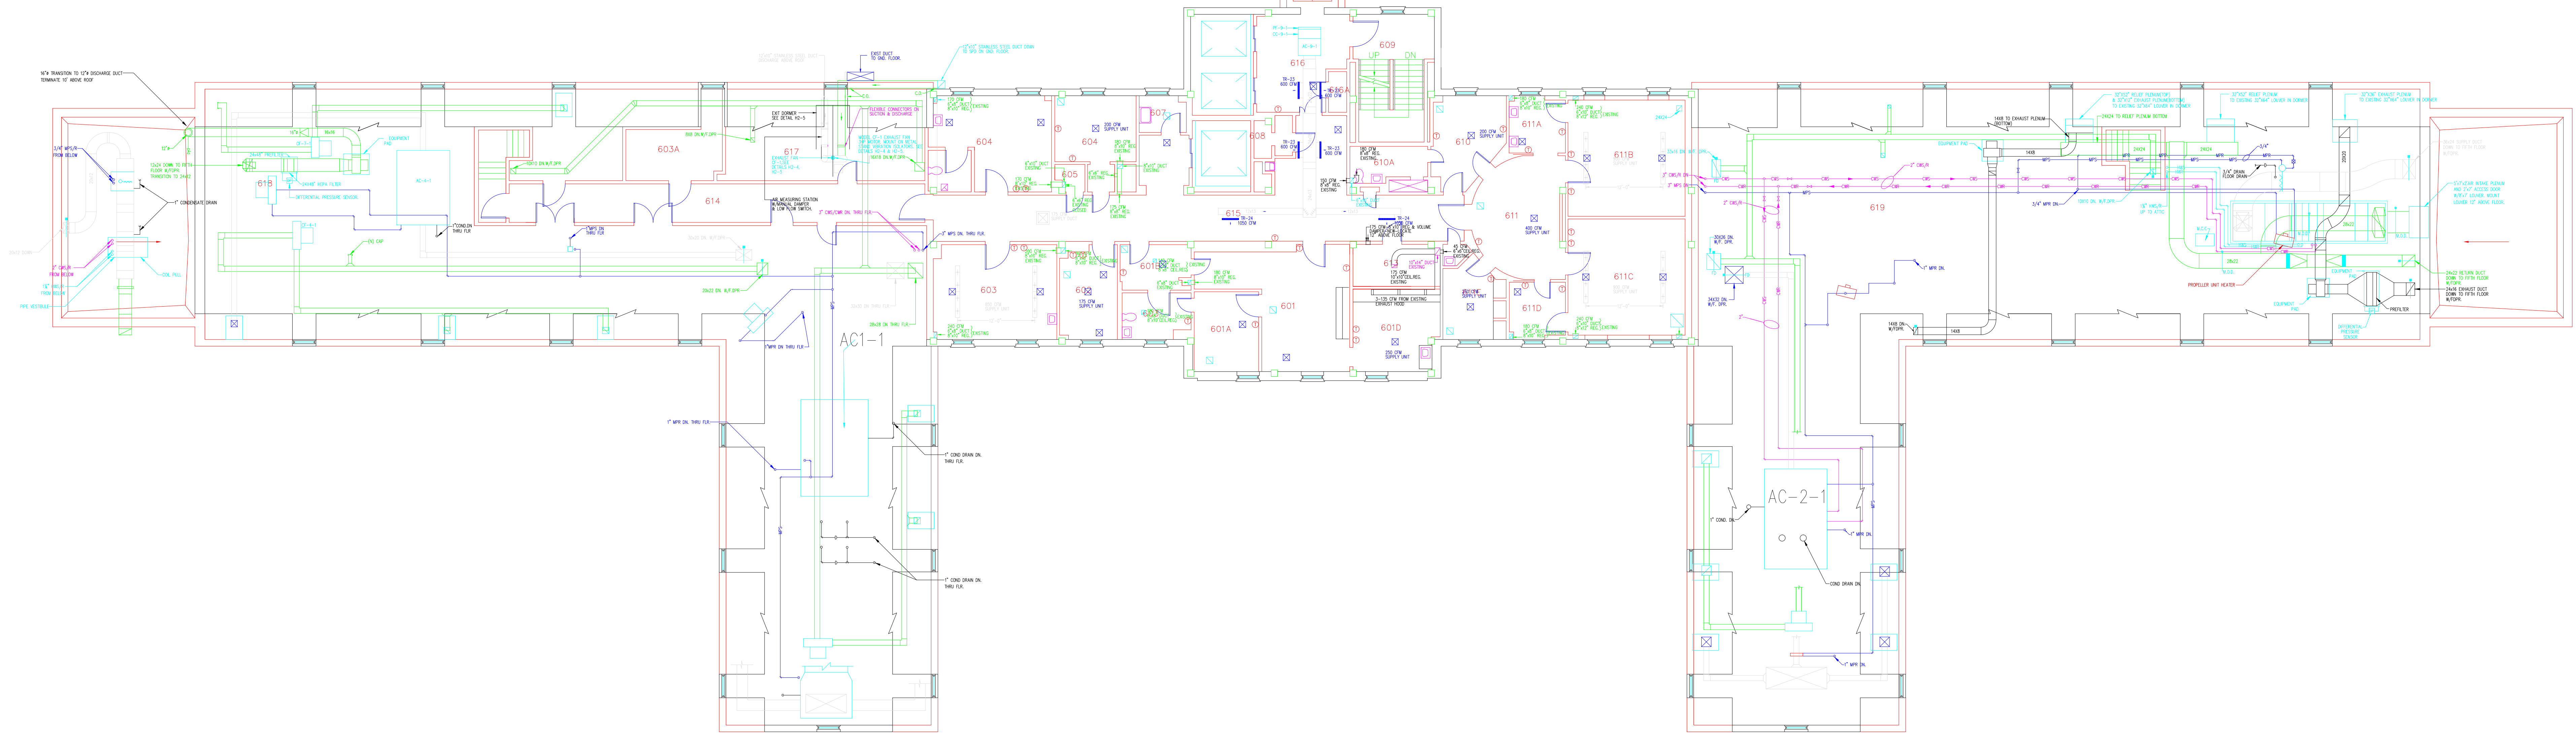

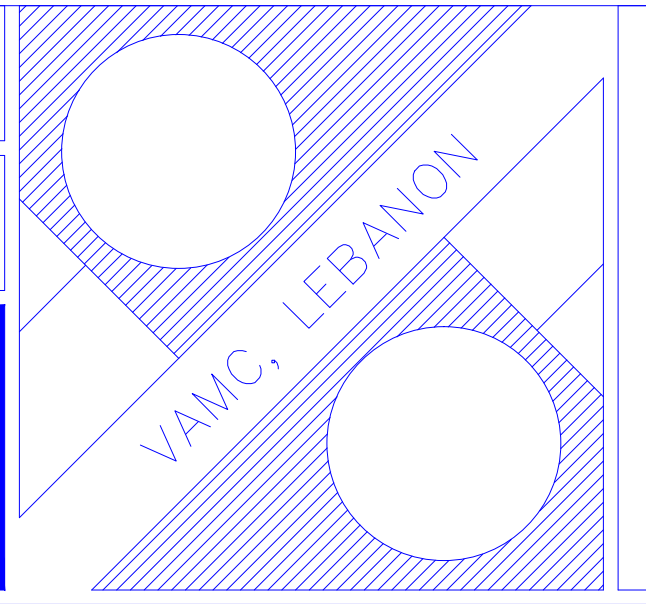Revisions		Date	Professional Seal		Drawing Title SIXTH FLOOR PLAN MECHANICAL	Project Title AS-BUILT Drawings	Date 07-02-2011			VA Department of Veterans Affairs			
Approved:			Approved:			Building Number 01	Checked	Drawn	Project No.				
Approved:			Approved:			Location VAMC LEBANON PA.	Drawing No.						