


Department Of Veterans Affairs

MARION NATIONAL CEMETERY

MARION, INDIANA

ADMINISTRATION BUILDING AND MAINTENANCE BUILDING IMPROVEMENTS

PROJECT NUMBER 817-18-106

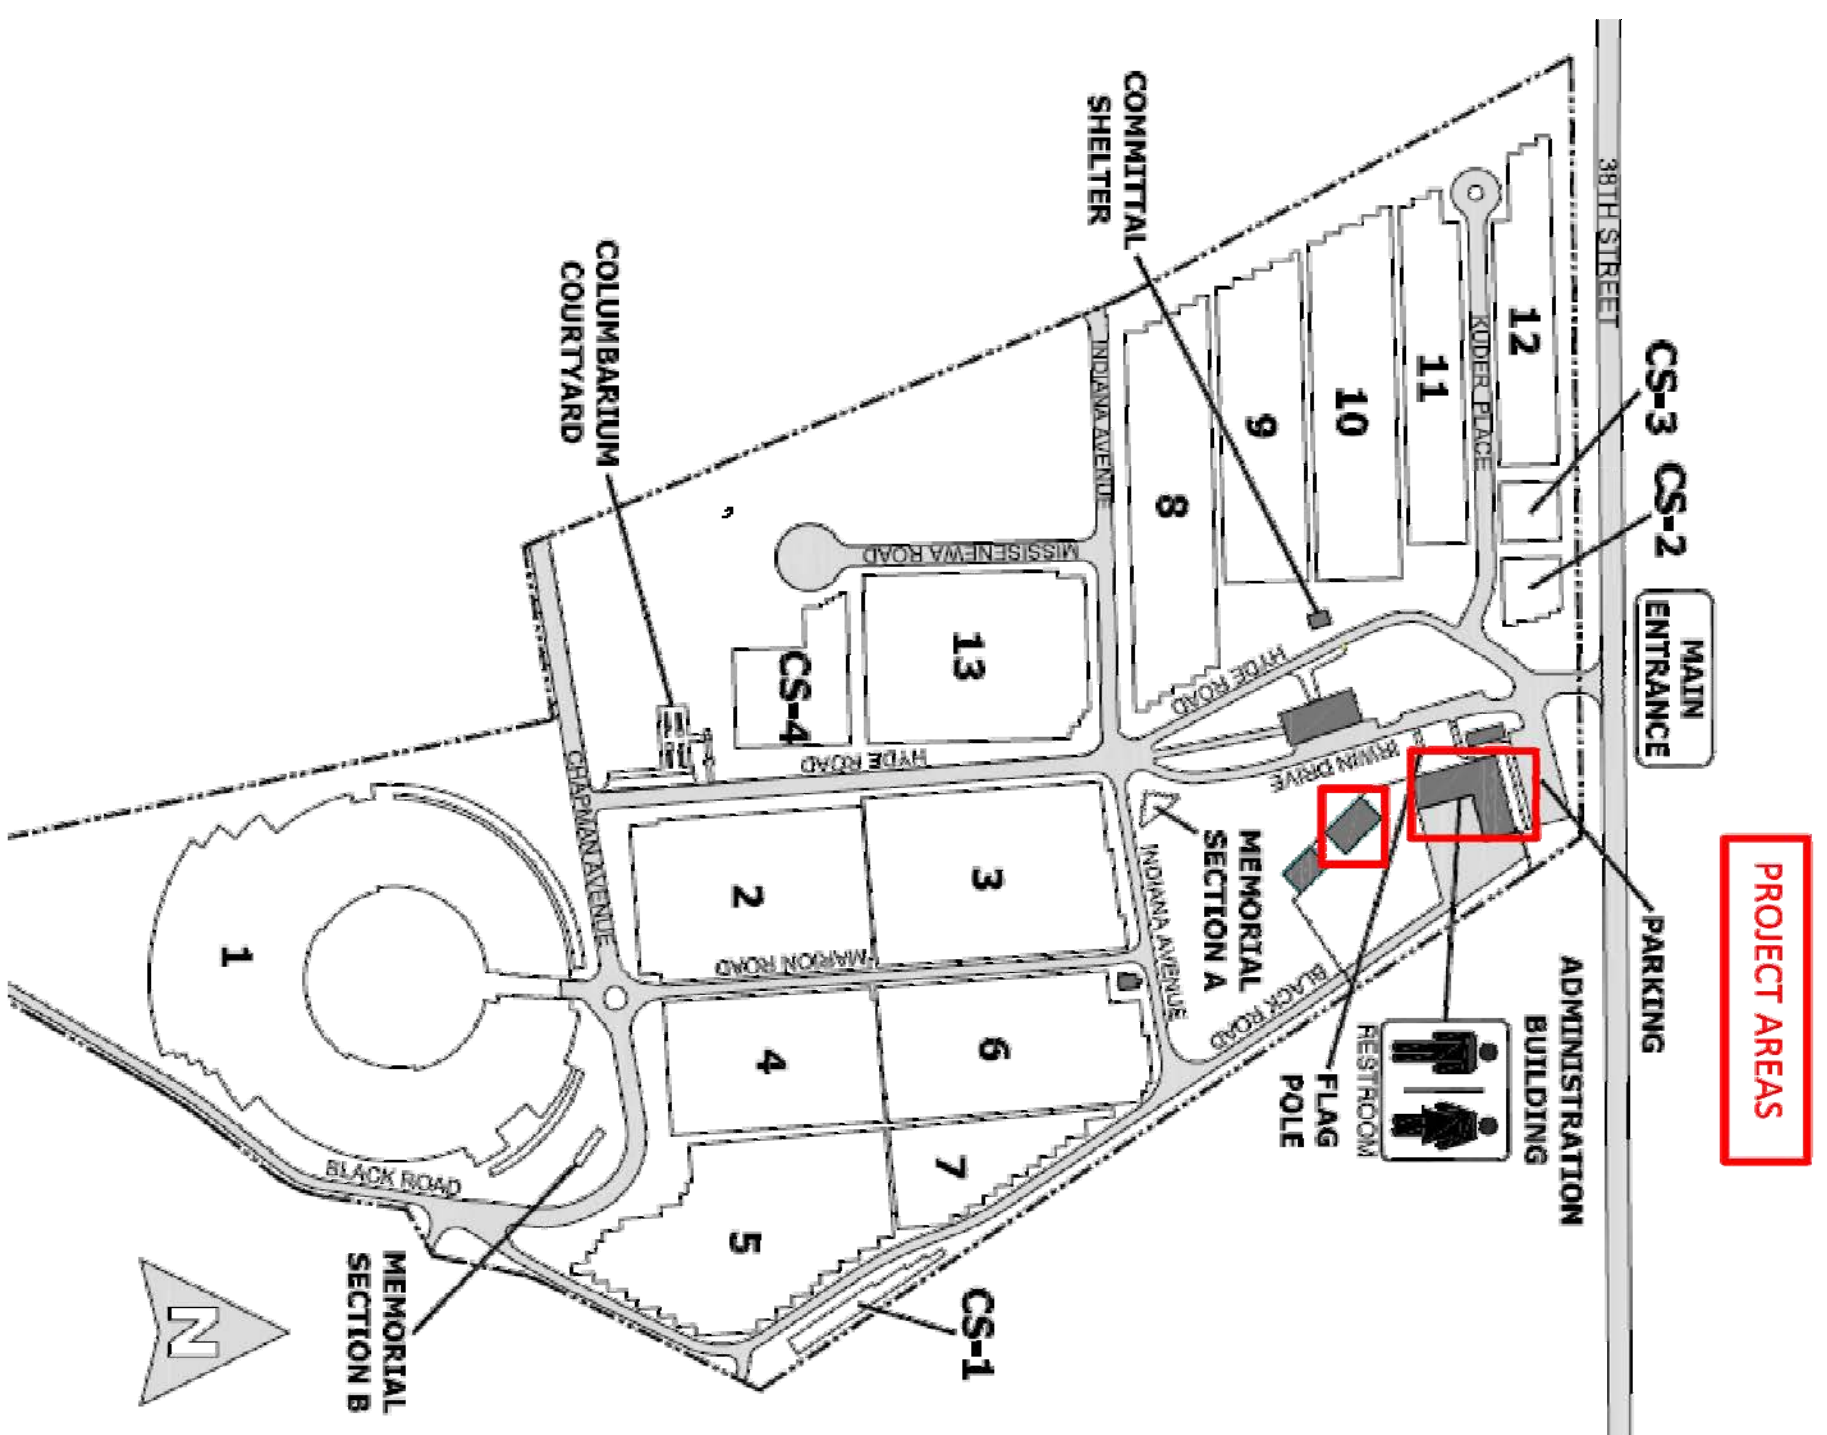

LOCATION MAP - MARION NATIONAL CEMETERY

SCALE: NOT TO SCALE

- GENERAL NOTES:
1. ALL CONSTRUCTION WITHIN MARION NATIONAL CEMETERY SHALL BE CONDUCTED WITH THE EMPHASIS ON PROPER CEMETERY ETIQUETTE AS THIS IS AN ACTIVE CEMETERY. NO DISRESPECTFUL ACTIVITY WILL BE TOLERATED.
2. COORDINATE ALL CONSTRUCTION ACTIVITIES WITH THE CEMETERY DIRECTOR TO AVOID CONFLICTS. SEQUENCE WORK AS NECESSARY TO ENSURE DAILY CEMETERY OPERATIONS REMAIN UNINTERRUPTED DURING CONSTRUCTION OPERATIONS.
3. CONTRACTOR SHALL PROTECT AND MAINTAIN PROPER SIGNS, BARRICADES, CONES, AND FENCES TO PROPERLY PROTECT THE PUBLIC AND CEMETERY STAFF FROM INJURY. WORK AREAS SHALL BE BARRICADED OFF DURING NON-WORKING HOURS AND WHEN THERE IS NO ACTIVE CONSTRUCTION AT THE SITE.
4. ANY DAMAGE INCURRED TO THE EXISTING FACILITIES DUE TO CONTRACT OPERATIONS BY THE CONTRACTOR SHALL BE REPAIRED OR REPLACED BY THE CONTRACTOR AT NO ADDITIONAL COST TO THE GOVERNMENT.
5. AREAS OUTSIDE OF THE CONSTRUCTION LIMITS IMPACTED BY OPERATIONS OF THE CONTRACTOR SHALL BE RETURNED TO THE STATE IT WAS FOUND PRIOR TO NEW CONSTRUCTION.
6. ALL DEBRIS, CONCRETE, ETC. SHALL BE REMOVED OFF CEMETERY PROPERTY AND PROPERLY DISPOSED OF AT AN APPROVED WASTE DISPOSAL SITE.
7. THOROUGHLY CLEAN UP THE WORK AREA AT THE END OF EACH DAYS WORK AND AT COMPLETION OF THE PROJECT. LEAVE PREMISES CLEAN AND FREE OF WASTE, SCRAP, USED EQUIPMENT, OR OTHER MATERIAL, INTENTIONALLY OR UNINTENTIONALLY DELIVERED TO THE SITE BY CONTRACTOR OR CONTRACTORS PERSONNEL.
8. A PRE-AD VISIT BY THE BIDDER IS REQUIRED TO GET AN ACCURATE MEASUREMENT AND UNDERSTANDING OF THE WORK.
9. ALL WORK SHALL BE PERFORMED BY A FULL TIME PROFESSIONAL WITH TWO OR MORE YEARS OF EXPERIENCE IN THE RESPECTIVE TRADE. ALL WORK MUST BE IN ACCORDANCE WITH APPLICABLE STATE AND LOCAL CODES AND REGULATIONS. THE WORK SHALL INCLUDE SITE RESTORATION TO ORIGINAL CONDITION, INCLUDING REPAIRS TO EXISTING PAVING, AND REPAIRS TO EXISTING CURBS AND SIDEWALKS. FINISHING OF ANY MATERIALS, ALL WORK SHALL BE PERFORMED IN A PROFESSIONAL WORKMANSHIP LIKE MANNER.


SHEET INDEX:

X -1	TITLE SHEET
L-1	ADMIN BLDG - MAINTENANCE OFFICE IMPROVEMENT PLAN
L-2	MAINT BLDG AS-BUILT - ARCHITECTURAL PLAN
L-3	MAINT BLDG AS-BUILT - MECHANICAL PLAN
L-4	MAINT BLDG-IMPROVEMENT PLAN
L-5	MAINT BLDG-PHOTOS

FINAL FOR CONSTRUCTION

MARCH 22, 2018

Revisions	Date

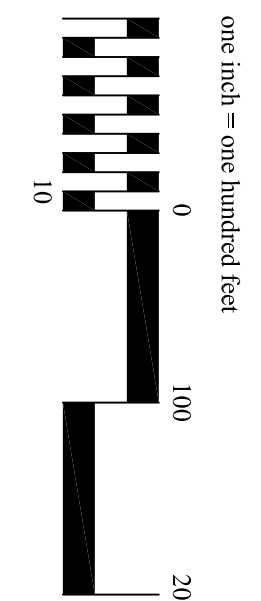

NATIONAL
CEMETERY
ADMINISTRATION

Drawing Title	Project Title			Date
COVER SHEET & SHEET INDEX	ADMIN & MAINT BLDG IMPROVEMENTS			3/22/2018
Approved: Division Chief	Building Number	Checked	Drawn	Project No.
	*****		RME	817-18-106
Approved: Service Director	Location	DRAWING NO.		
	MARION NATIONAL CEMETERY	X-1		
		Dwg. 1 Of 6		