

three inches = one foot
one and one half inches = one foot
one inch = one foot
three quarters inch = one foot
one half inch = one foot
three eighths inch = one foot
one quarter inch = one foot
one eighth inch = one foot



REFLECTED CEILING PLAN GENERAL NOTES

- ALL CEILING GRID SHALL BE CENTERED IN THE ROOM OR CORRIDOR IN WHICH IT OCCURS, UNLESS SHOWN OTHERWISE.
- SEE FIRE RATING (LIFE SAFETY) PLANS FOR LOCATION OF FIRE RATED WALLS.


REFLECTED CEILING PLAN LEGEND

(APPLIES TO ALL REFLECTED CEILING PLAN SHEETS)

- ACOUSTICAL CEILING (AT)
- GYPSUM WALL BOARD
- HVAC GRILLES AND DIFFUSERS - SEE MECHANICAL
- LIGHT FIXTURES AND EQUIPMENT - SEE ELECTRICAL
- ACCESS DOOR
- CEILING ACCESS PANEL

REFLECTED CEILING PLAN KEYNOTES

- 01 REINSTALL EXISTING CEILING GRID. PROVIDE AT1.
- 02 METAL PANEL SOFFIT
- 03 REINSTALL EXISTING CEILING GRID AND REWORK AT NEW WALL LOCATION.
- 04 PROVIDE NEW CEILING GRID AND AT1.
- 05 REINSTALL HVAC DIFFUSER AND LIGHTS

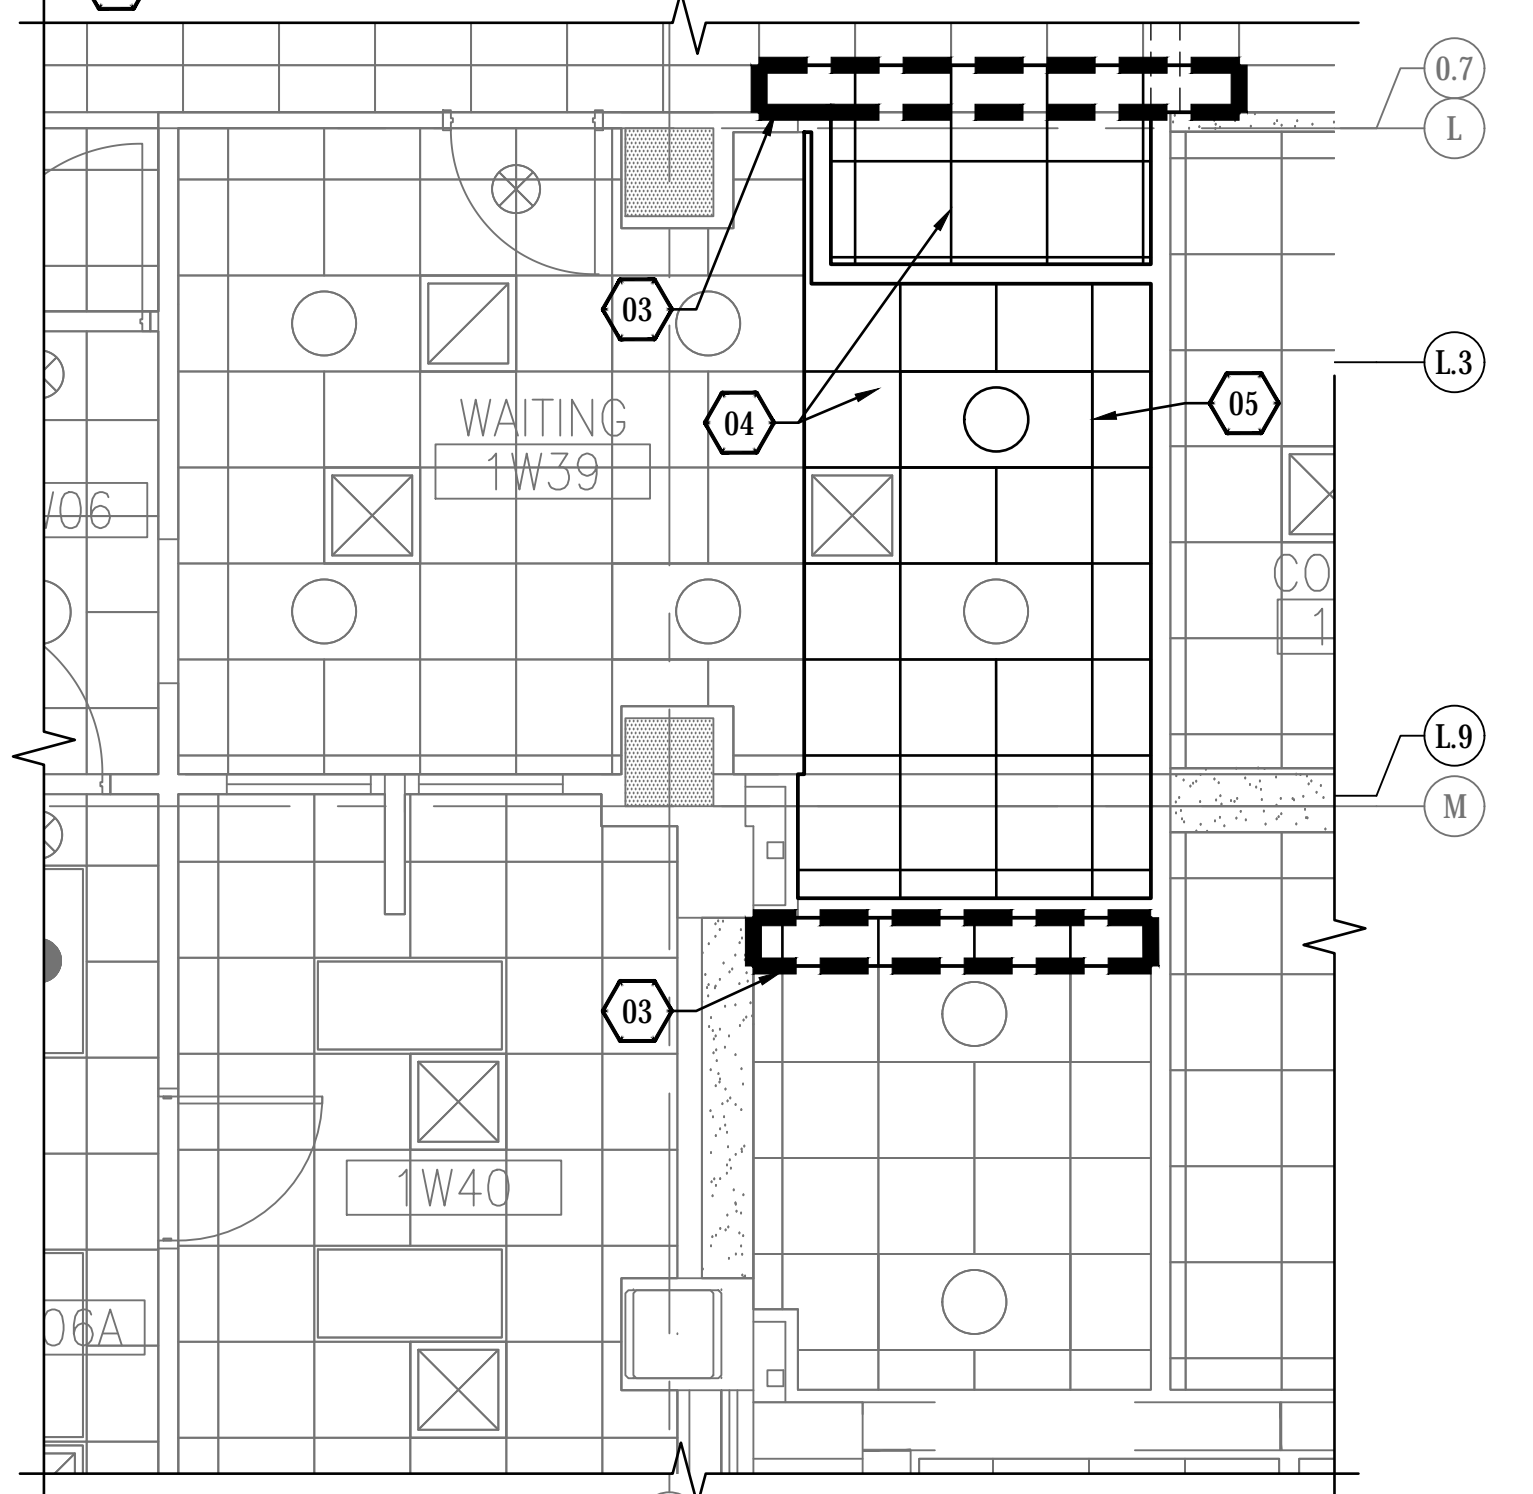

2 INTERIM FIRST FLOOR REFLECTED CEILING PLAN
SCALE: 1/4" = 1'-0"

100% BID DOCUMENTS - FULLY SPRINKLERED

Scale: 1/8" = 1'-0"

CONSULTANTS:

ARCHITECT/ENGINEERS:

KHA
Kenneth Hahn
Architects

1343 South 75th Street | Omaha, NE 68124-1610 | 402.391.2111 | www.kharch.com

AE Project #
171-005

Drawing Title
FIRST FLOOR
REFLECTED CEILING PLAN

Approved Project Director
-
VAPAHCS PLANNING AND ENGINEERING

Project Title
CORRECT LIFE
SAFETY DEFICIENCIES

Location
IOWA CITY VA HEALTH CARE SYSTEM
Date
19 SEPTEMBER 2017

Project Number
636A8-16-006

Building Number
01

Drawing Number
A14-01W
Volume 1 of 2
Dwg. 54 of 103

Office of
Construction
and Facilities
Management

VA U.S. Department
of Veterans Affairs

1 - ADDENDUM 00002
Revisions
Date

6 APR 2018

VA FORM 08-6231