


VA MEDICAL CENTER

WTS SNOW AND ICE REMOVAL SPECIAL REQUIRMENT

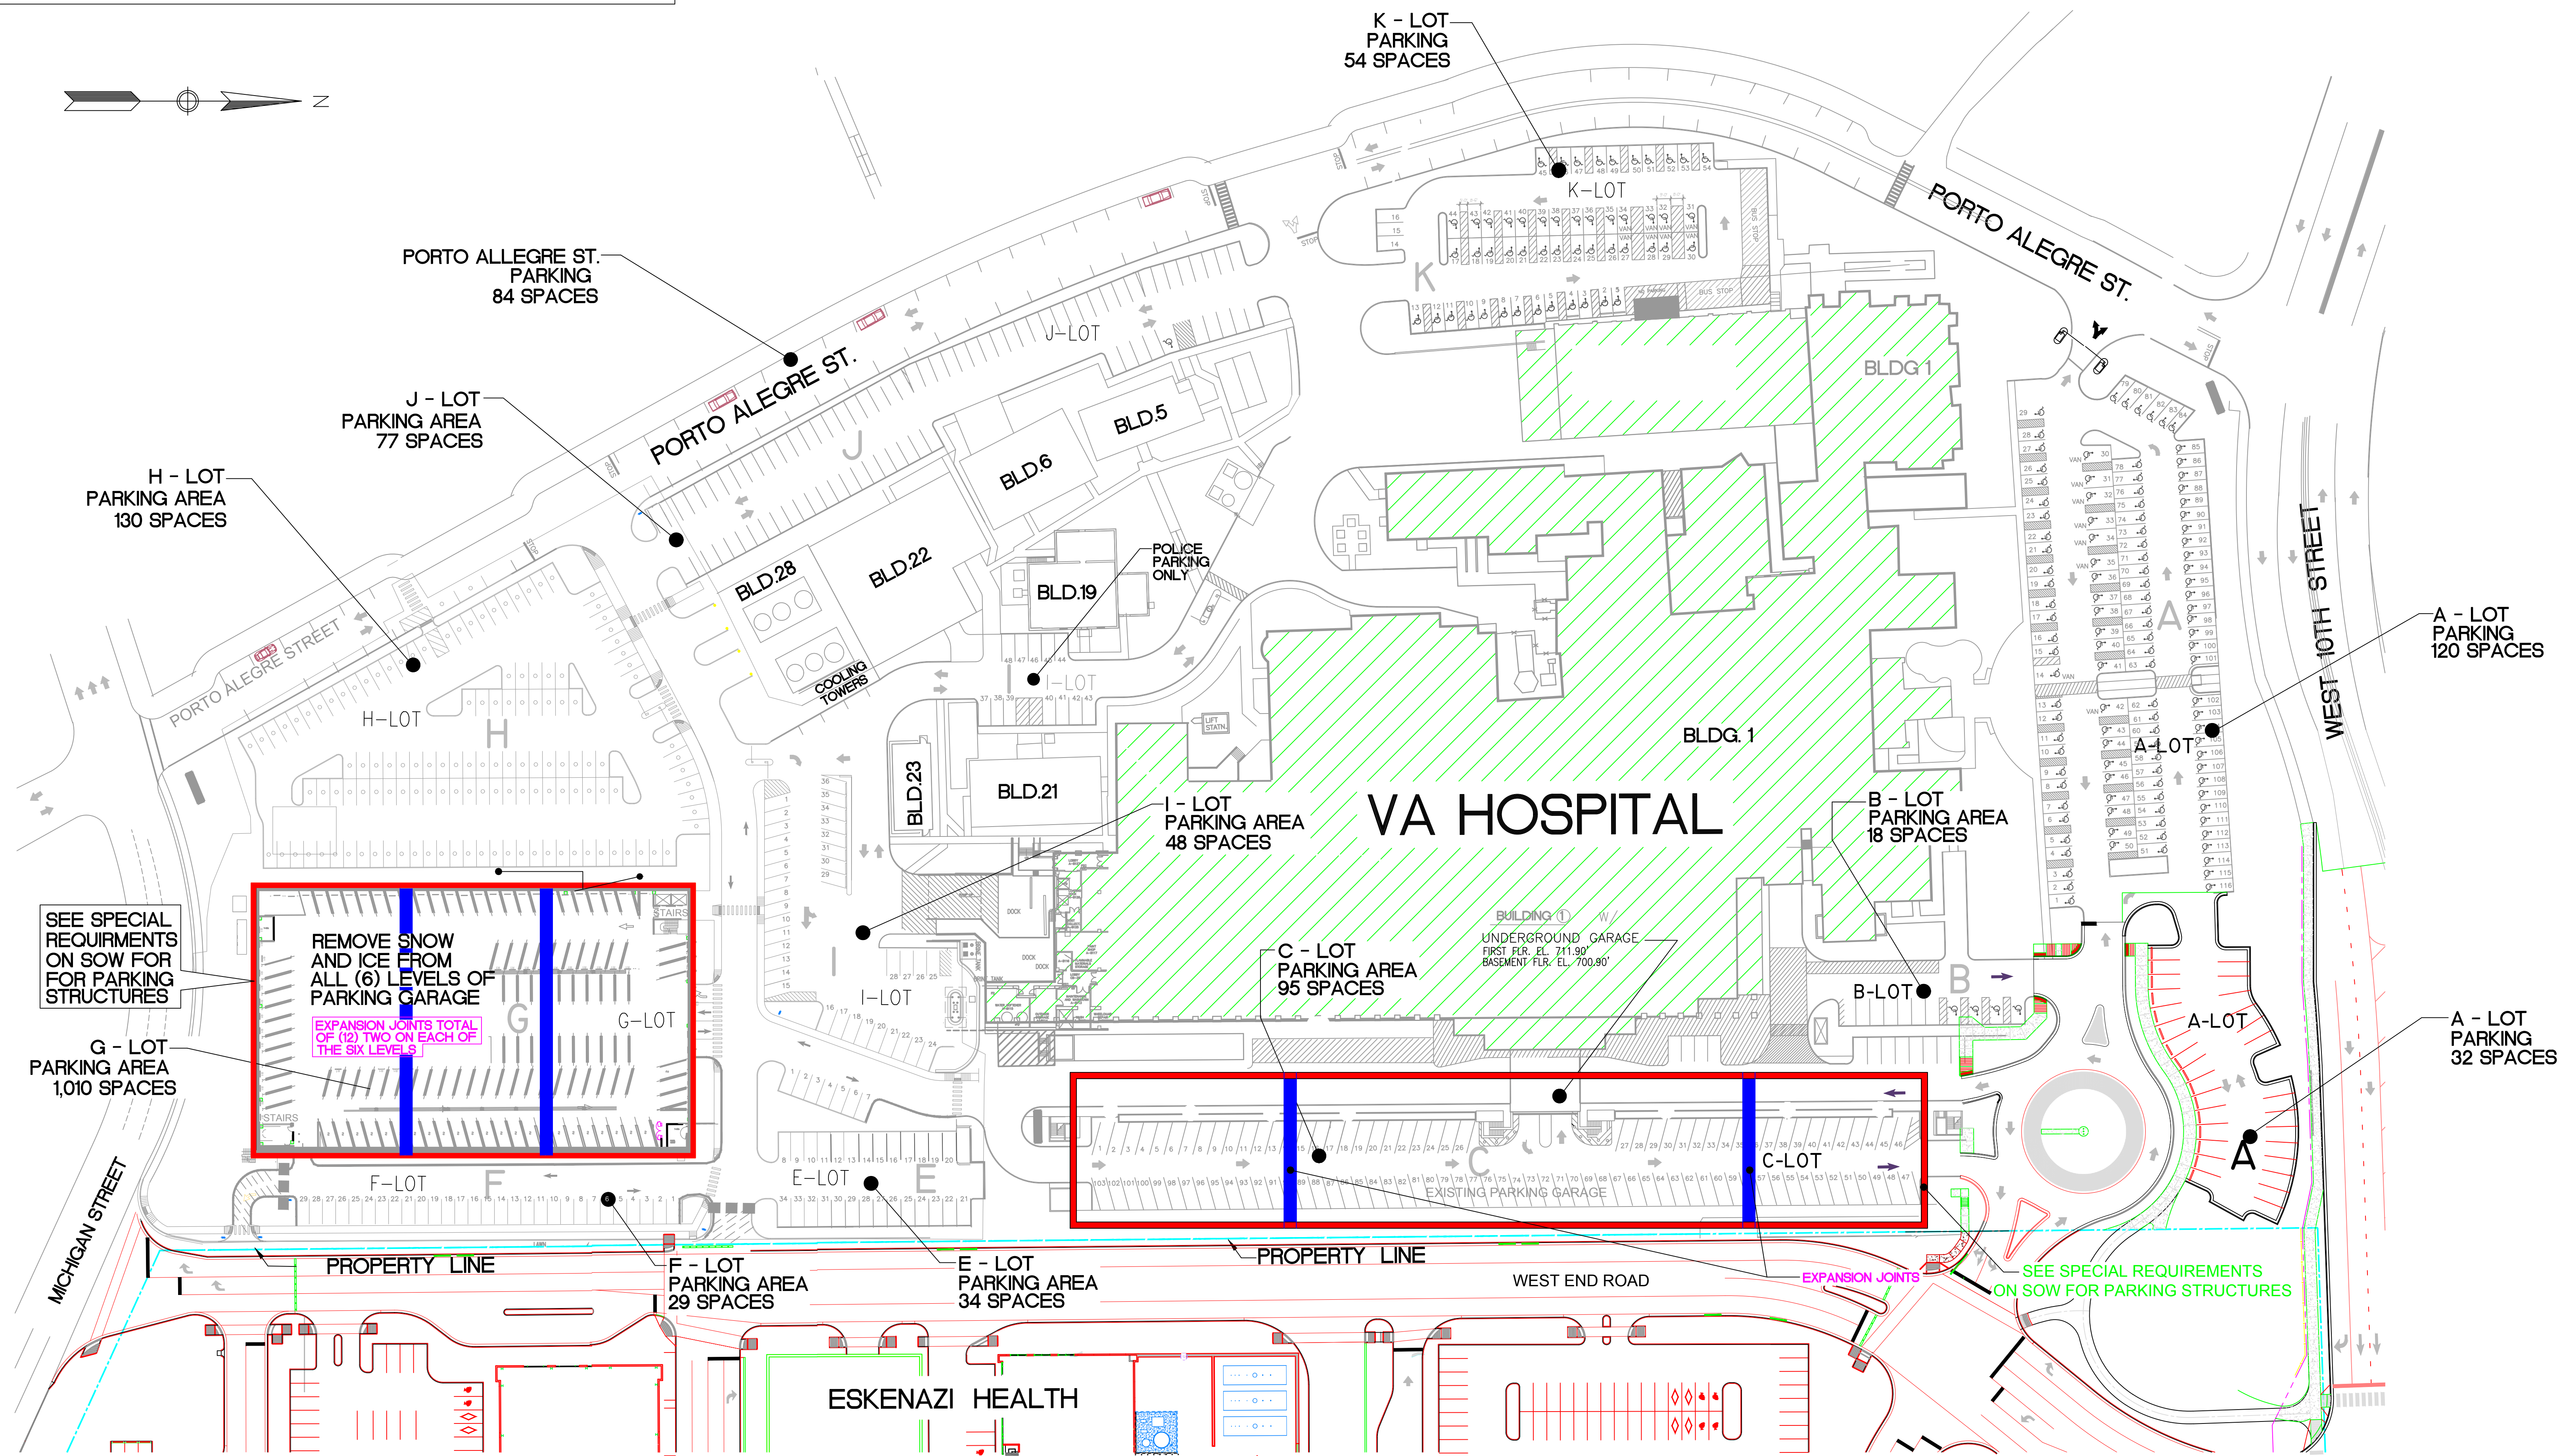

WTS - SNOW AND ICE REMOVAL AND SPECIAL REQUIREMENTS
SCALE 1" = 50'

MARCH 2018

Revisions:		Date	ADDRESS:		NORTH REFERENCE	PROJECT ENGINEERS:		Drawing Title		Project Title		Project Number		Engineering and Facilities Management Services				
			Richard L. Roudebush VA Medical Center 1481 W. 10th St. Indianapolis, Indiana 46202					WTS - SNOW AND ICE REMOVAL AND SPECIAL REQUIREMENTS		SNOW REMOVAL SITE PLAN		Building Number						
												Building #1						
												Drawing Number						
								Approved Project Director		Location		Date		Checked	Drawn			
										WEST TENTH STREET		21 MAR 2018			A. FERNANDEZ			
														Dwg. 2 of 3				