

LUMINAIRE SCHEDULE									
Symbol	Label	Qty	Catalog Number	Description	Lamp	Filb	Lumens	LLF	Watts
	A	9	125-28HPS R4 DG	GLASS REFRACTOR, ALUMINUM REFLECTOR, SOCKET POSITION D.S., MOUNTED 30' AFS.	TWO 250-WATT HIGH PRESSURE SODIUM.	AE3800IES	29000	0.72	530
	B	9	125-28HPS R4 DG	GLASS REFRACTOR, ALUMINUM REFLECTOR, SOCKET POSITION D.S., MOUNTED 30' AFS.	ONE 250-WATT HIGH PRESSURE SODIUM.	AE3843IES	29000	0.72	257

STATISTICS					
Description	Symbol	Avg	Max	Min	Max/Min
Calc Zone #1	+	3.2 fc	7.4 fc	1.1 fc	6.7:1
					2.8:1

REVISION NO.	DATE	COMMENTS

T.E.S.
TUCHMAN ENGINEERING SERVICES, Inc.
MECHANICAL, ELECTRICAL, PLUMBING, FIRE ALARM AND SYSTEM INTEGRATORS.
3209 MCKINLEY STREET
HOLLYWOOD, FL. 33021.
TEL: (786) 423-5511
FAX: (954) 805-4902
Email: TuchmanEngineering@gmail.com
Find us on Facebook
CA#127930

MEGAWATTAGE GENERATOR INC



2750 N. 29th Avenue, Suite 209,
Hollywood, FL 33020.
TEL: (786) 247-4077
FAX: (305) 436-3736

PROJECT NAME AND ADDRESS:
V.A.
New Parking Light System.

1455 NW 17th Street,
Miami, Florida, 33125.

DRAWN BY: J.T.
SCALE: AS NOTED
PROJECT NUMBER: 20130426-3
PAGE TITLE: PHOTOMETRIC PLAN.

DATE: 4/26/13
REVISD BY: J.T.

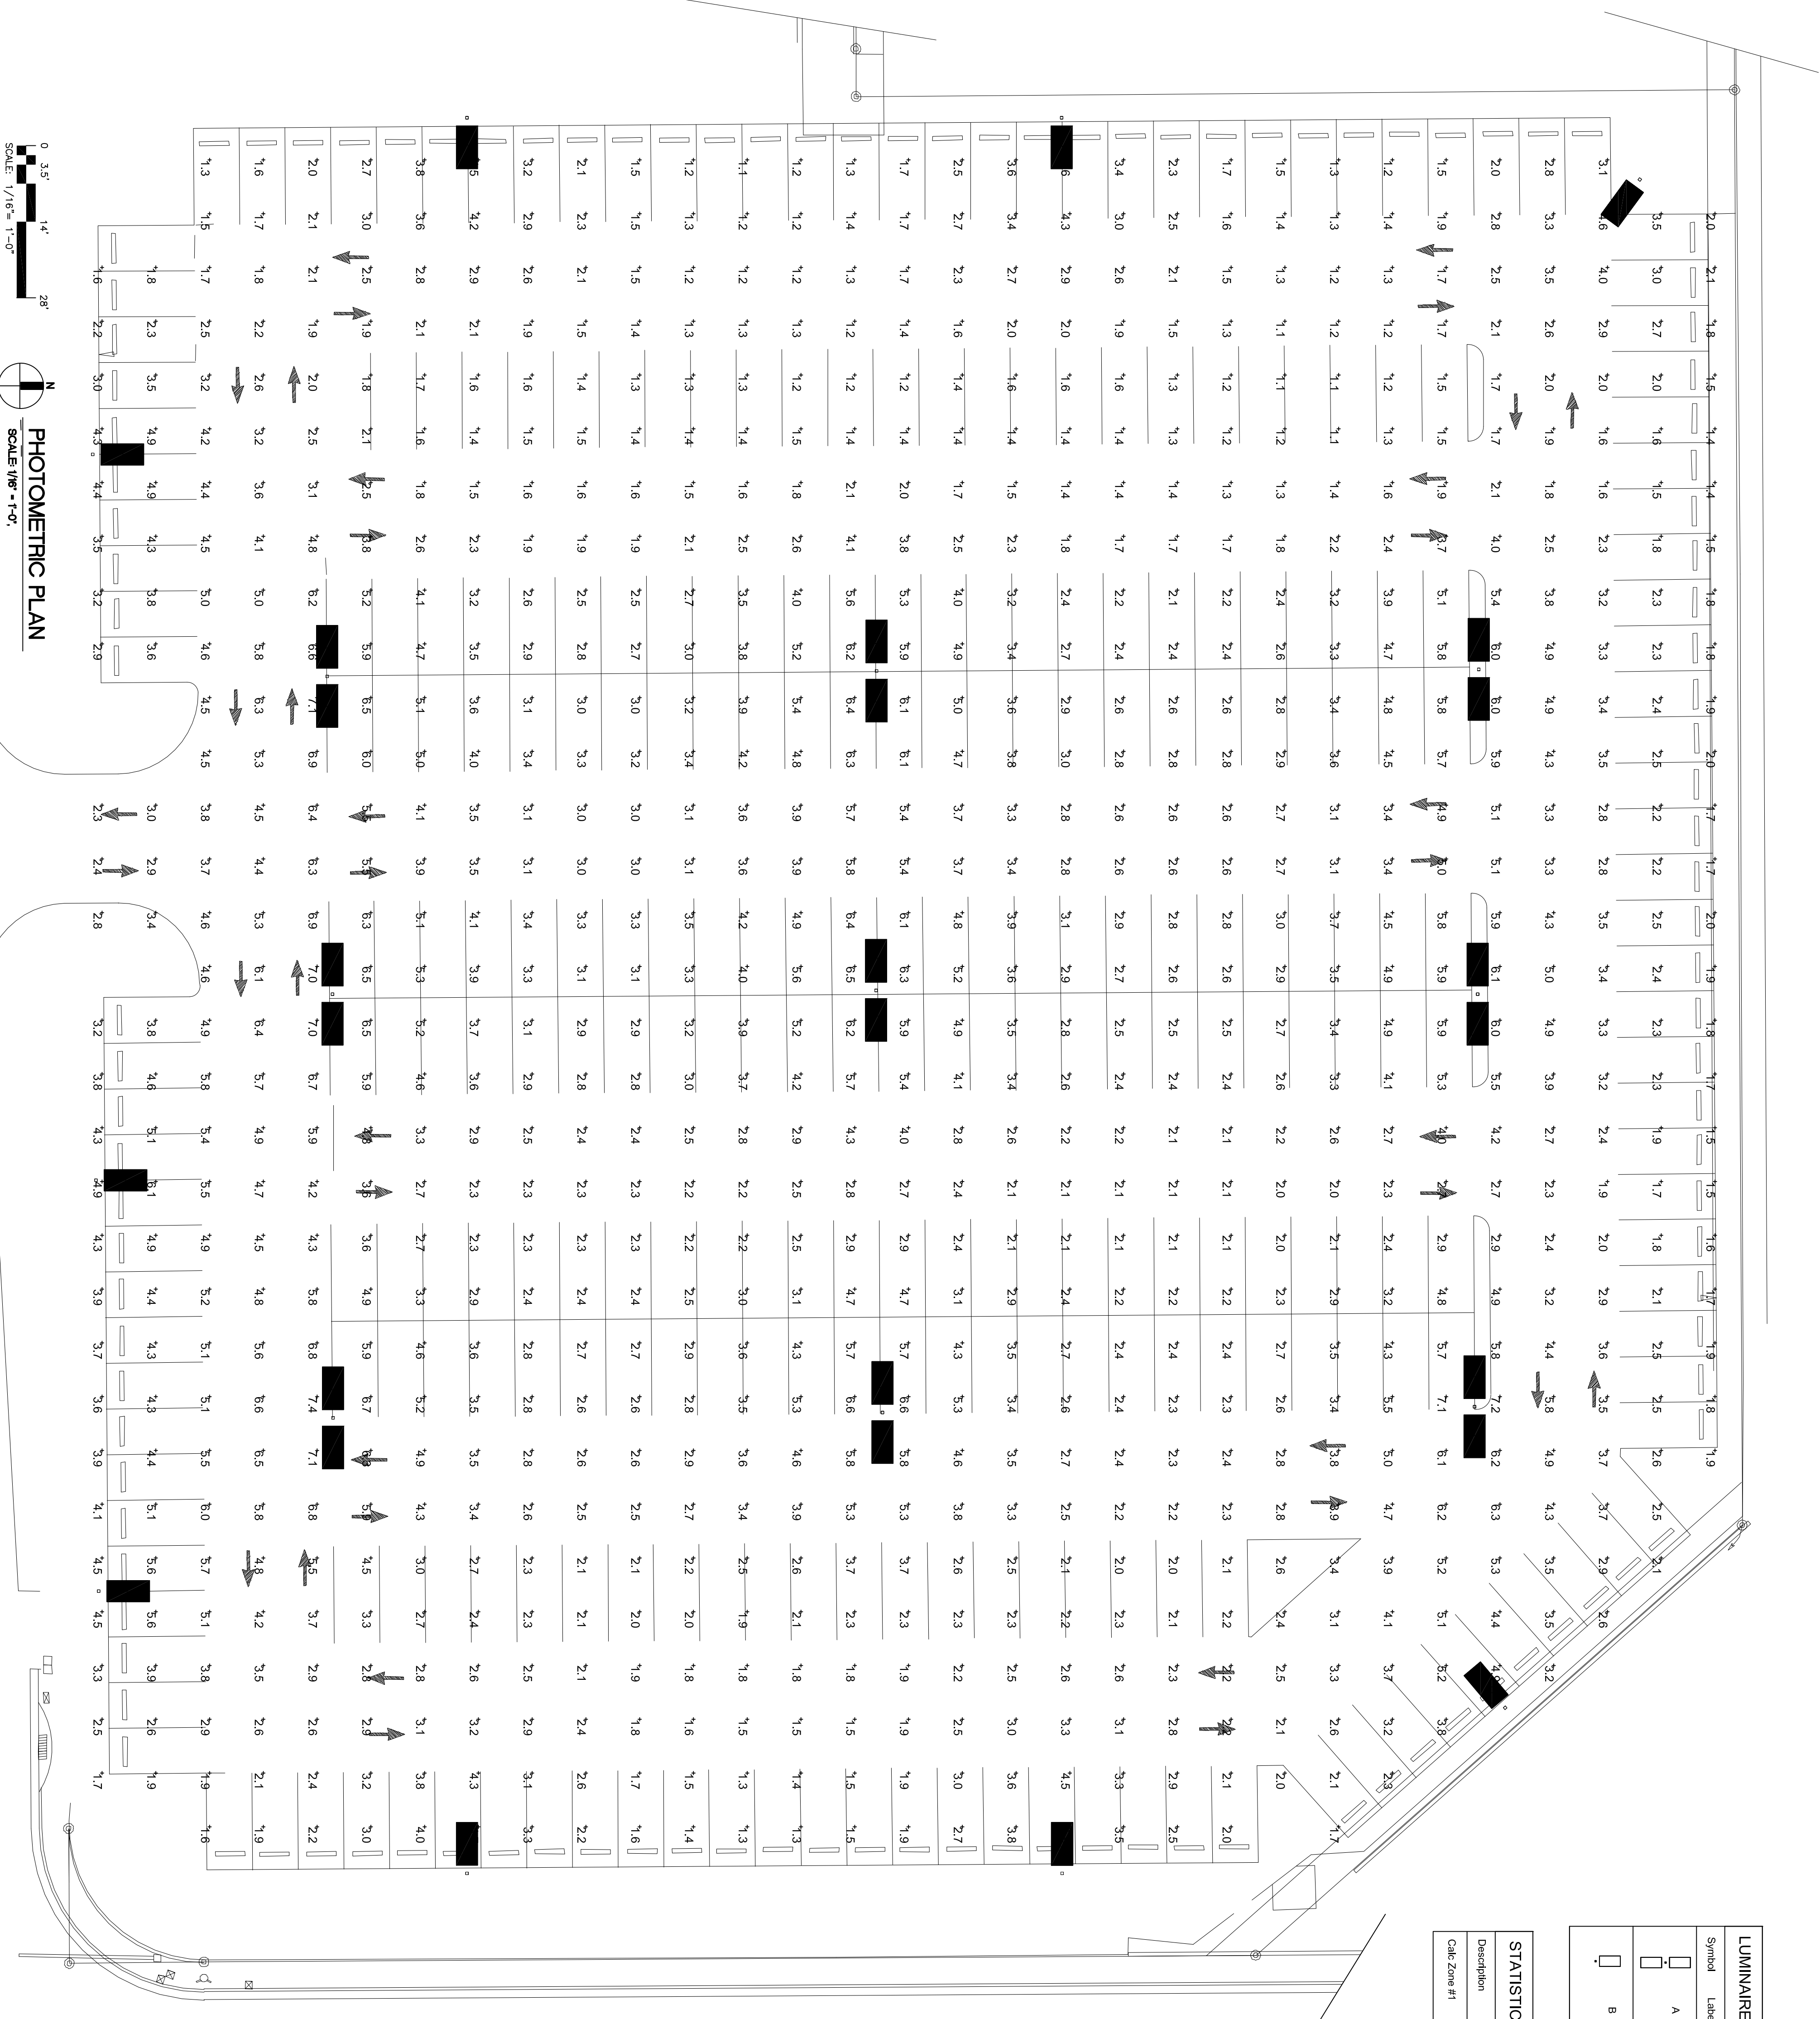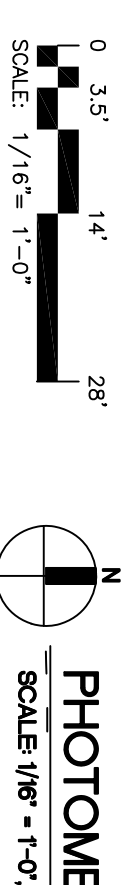

JAVIER TUCHMAN P.E.
DISCIPLINE: ELECTRICAL
ADDRESS: 3209 Mc Kinley St., Hollywood, FL, 33021.

REG: 60285
PHONE: (786) 423-5511

STATE: Florida

ALL DRAWINGS AND WRITTEN MATERIAL APPEARING HEREIN CONSTITUTE THE ORIGINAL AND UNPUBLISHED WORK, AND MAY NOT BE DUPLICATED, USED OR DISCLOSED WITHOUT THE EXPRESS WRITTEN CONSENT OF JAVIER TUCHMAN P.E.
ENGINEER IS NOT RESPONSIBLE IF ANY CHANGES ARE MADE WITHOUT HIS APPROVAL.

PAGE NUMBER:
E-1 OF 3