



DEMO ROOF PLAN – 3RD FLOOR
SCALE: 1/8"=1'-0"

- DEMOLITION NOTES**
- 1 REMOVE EXISTING ROOF DRAIN AND FIRST 2' OF PIPING BELOW.
 - 2 COMPLETELY REMOVE ALL EXISTING ROOFING LAYERS, BALLAST, INSULATION, VAPOR BARRIER, ETC. DOWN TO CONCRETE DECK.
 - 3 REMOVE ALL EXISTING METAL COPING.
 - 4 REMOVE EXISTING CURBING. IN-FILL OPENING IN DECK WITH CONCRETE AND PIN INTO EXISTING CONCRETE WITH #4 REBAR AROUND PERIMETER.
 - 5 EXISTING COATING ON FLASHING HAS TESTED POSITIVE FOR ASBESTOS AND ALL FLASHINGS SHALL BE ABATED PER CODE REQUIREMENTS.
 - 6 EXPANSION JOINTS TO BE REMOVED IN THEIR ENTIRETY.

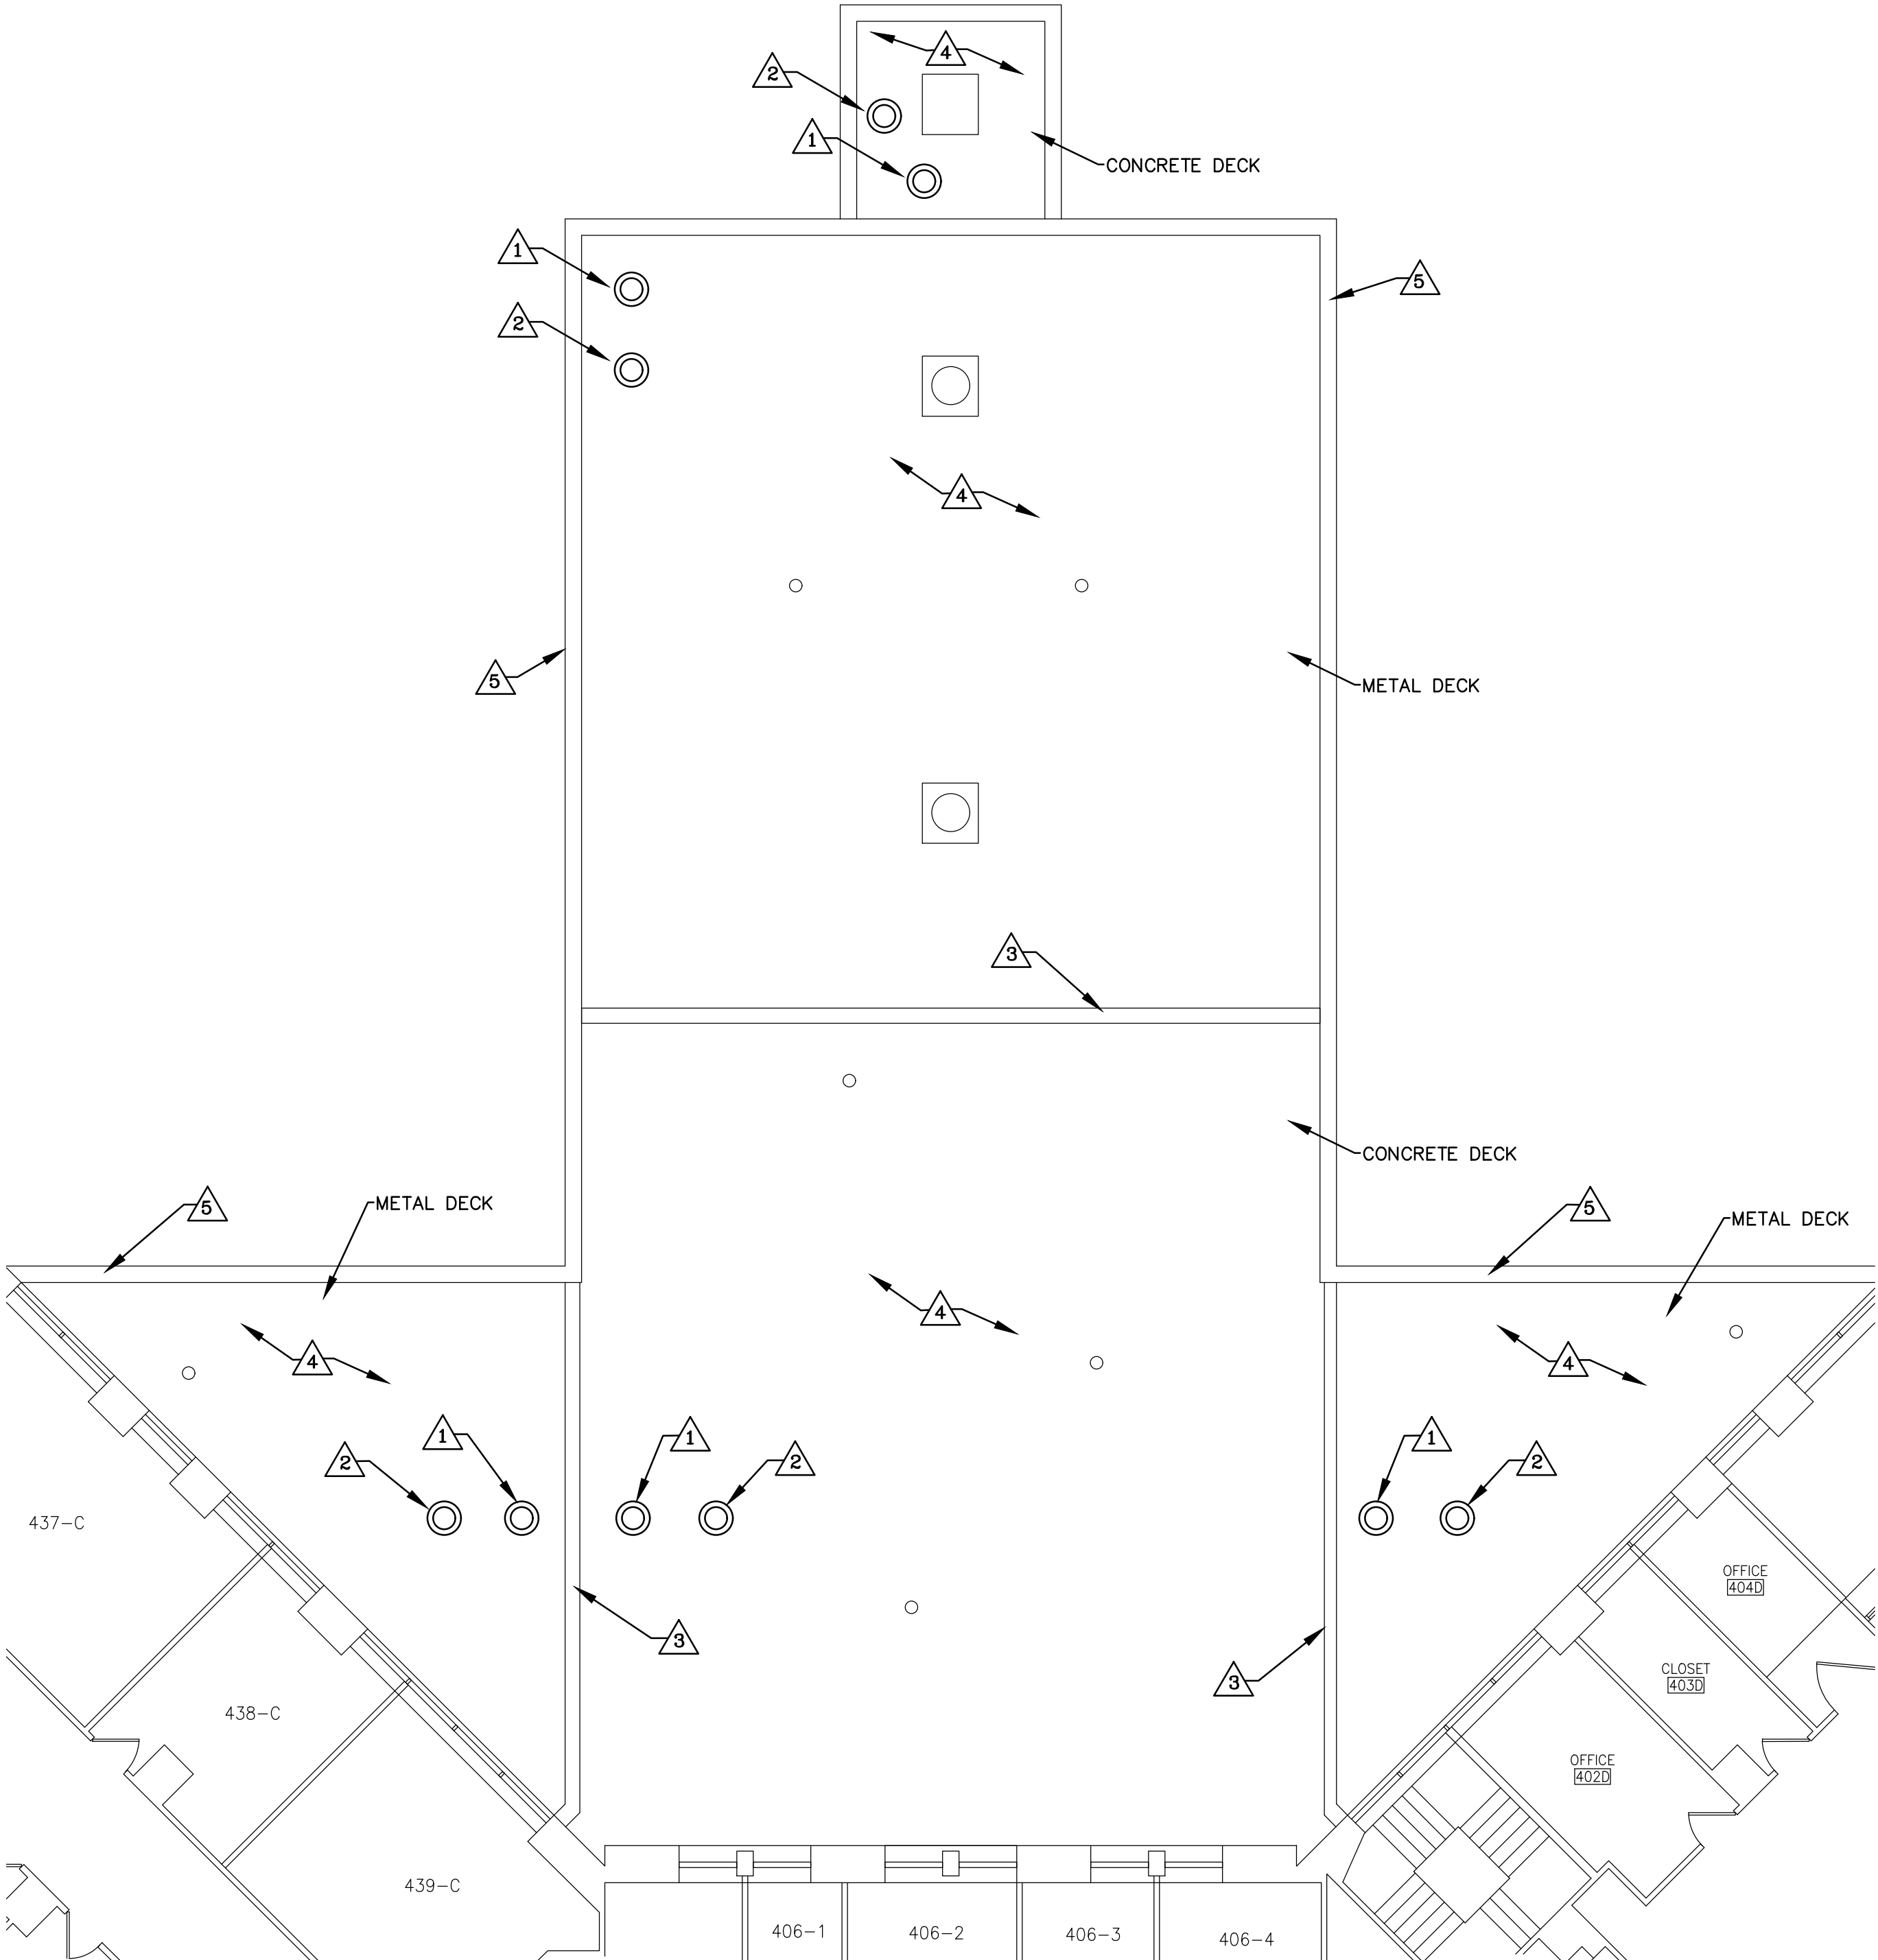

NEW ROOF PLAN
SCALE: 1/8"=1'-0"

- KEY NOTES**
- 1 PROVIDE NEW ROOF DRAIN IN PLACE OF EXISTING AND CONNECT NEW PIPING TO EXISTING IN CEILING BELOW.
 - 2 CUT OPENING IN ROOF DECK AND PROVIDE NEW SECONDARY ROOF DRAIN. CONNECT NEW PIPING TO EXISTING IN CEILING BELOW.
 - 3 PROVIDE NEW EXPANSION JOINTS - REFER TO DETAIL ON DRAWING A-103.
 - 4 PROVIDE NEW ROOF - REFER TO DETAILS ON A-103.
 - 5 PROVIDE .50 ALUMINUM COPING AROUND PERIMETER OF ROOF AND BUILD UP WITH WOOD BLOCKING TO HEIGHT NECESSARY. REFER TO DETAIL ON A-103.

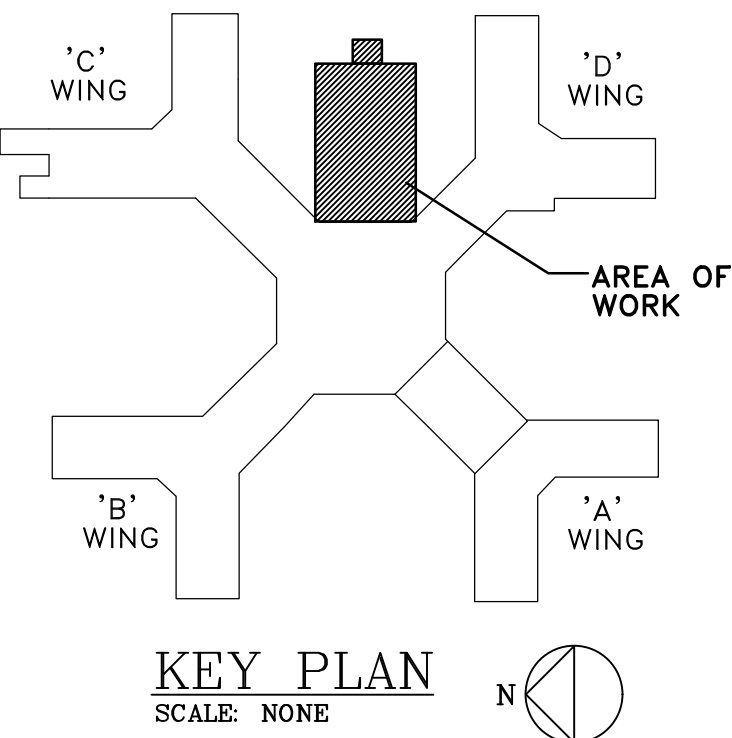

Revisions Date	VA WESTERN NEW YORK HEALTHCARE SYSTEM 3495 BAILEY AVENUE BUFFALO, NEW YORK 14215	CLINICAL ENGINEERING	DATE	ENGINEERING MANAGER	DATE	Drawing Title 3RD FLOOR ROOF PLAN	Project Title 2018 ROOF REPLACEMENTS	Date MARCH 8, 2018	Station No. 528	18-S43-A102	Office of Facilities Department of Veterans Affairs
		INFECTION CONTROL	DATE	CARELINE MANAGER	DATE						
		SAFETY OFFICER	DATE	CHIEF OF STAFF	DATE						
		MEDICAL CENTER DIRECTOR	DATE	ASSOCIATE MEDICAL CENTER DIRECTOR	DATE						
						Building Number 1	Checked RLR	Drawn RLR			
						Location V.A.M.C. BUFFALO, NEW YORK					