




PART AS-BUILT - FIRST FLOOR PLAN
SCALE: 1/8"=1'-0"

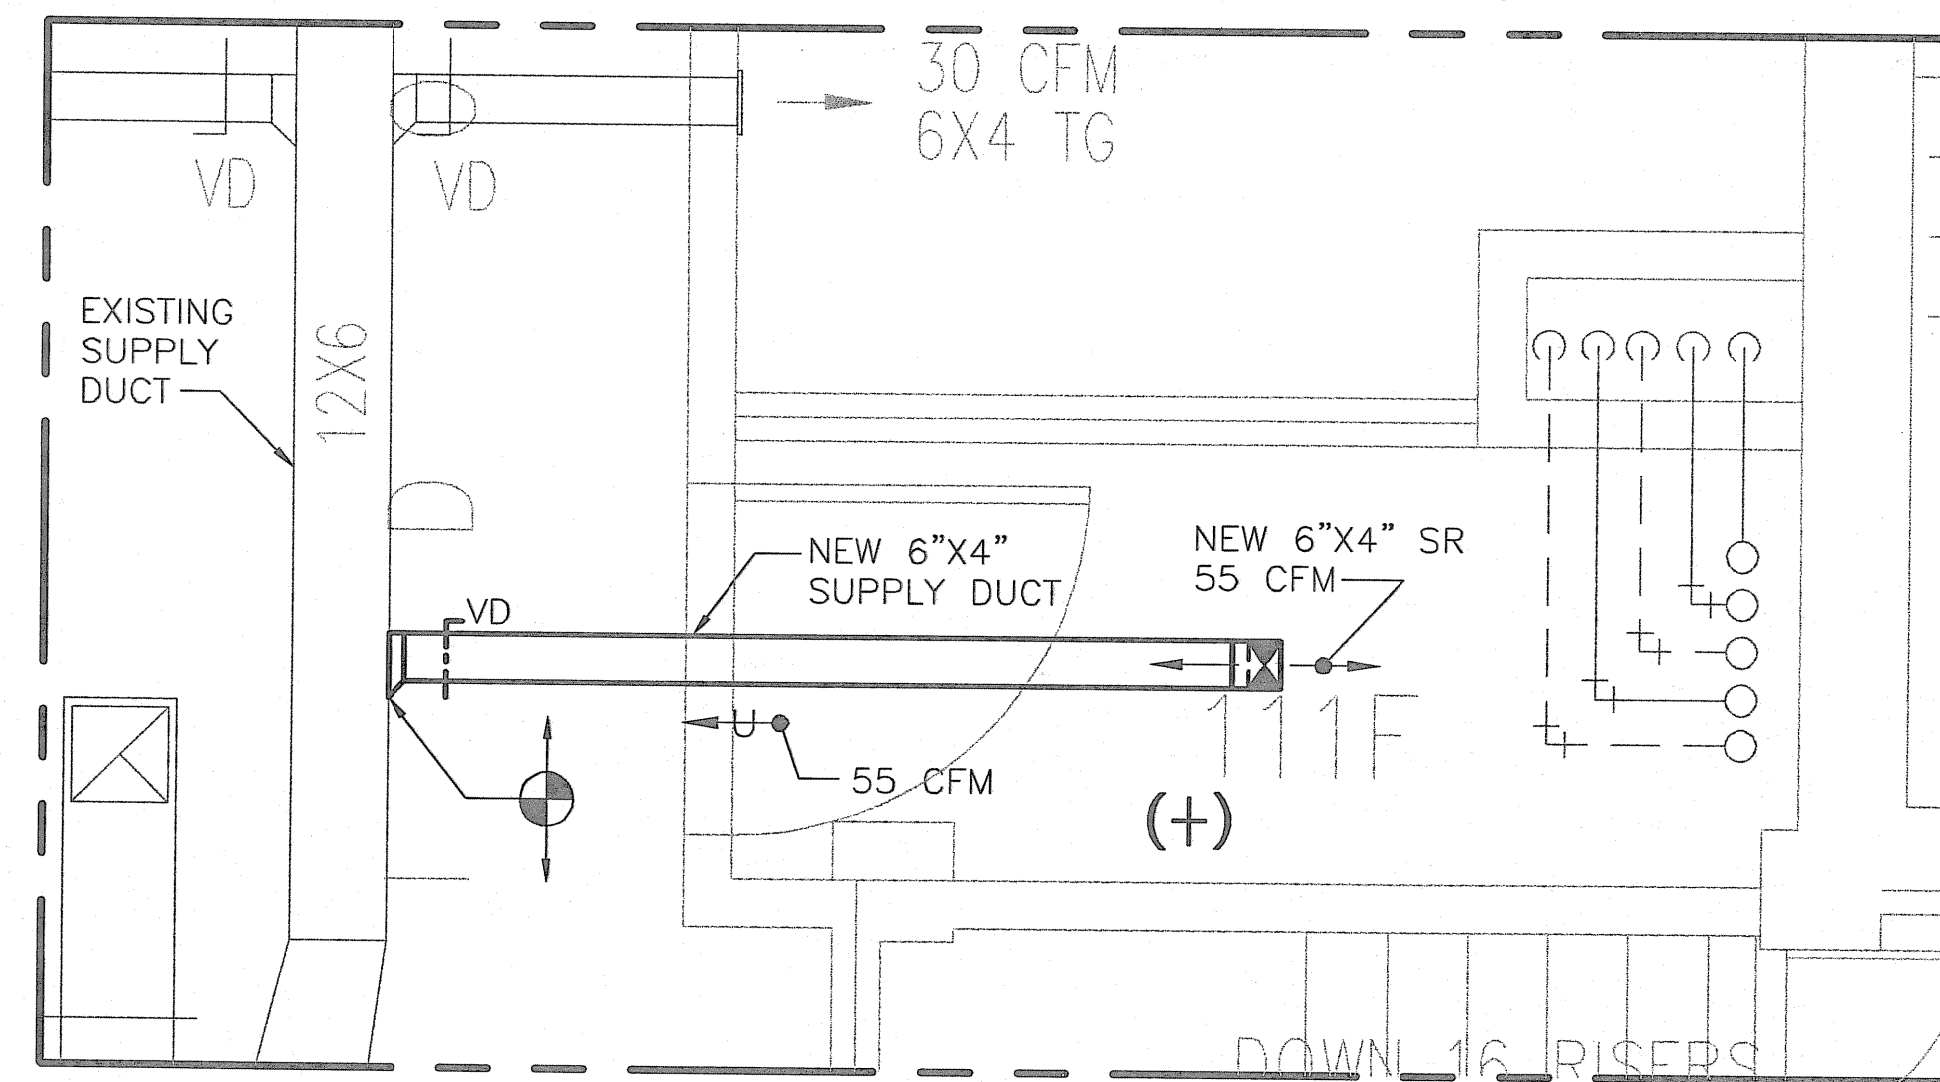


1
NEW WORK - ROOM 111F ENLARGED PLAN - 1
SCALE: 1/2"=1'-0"

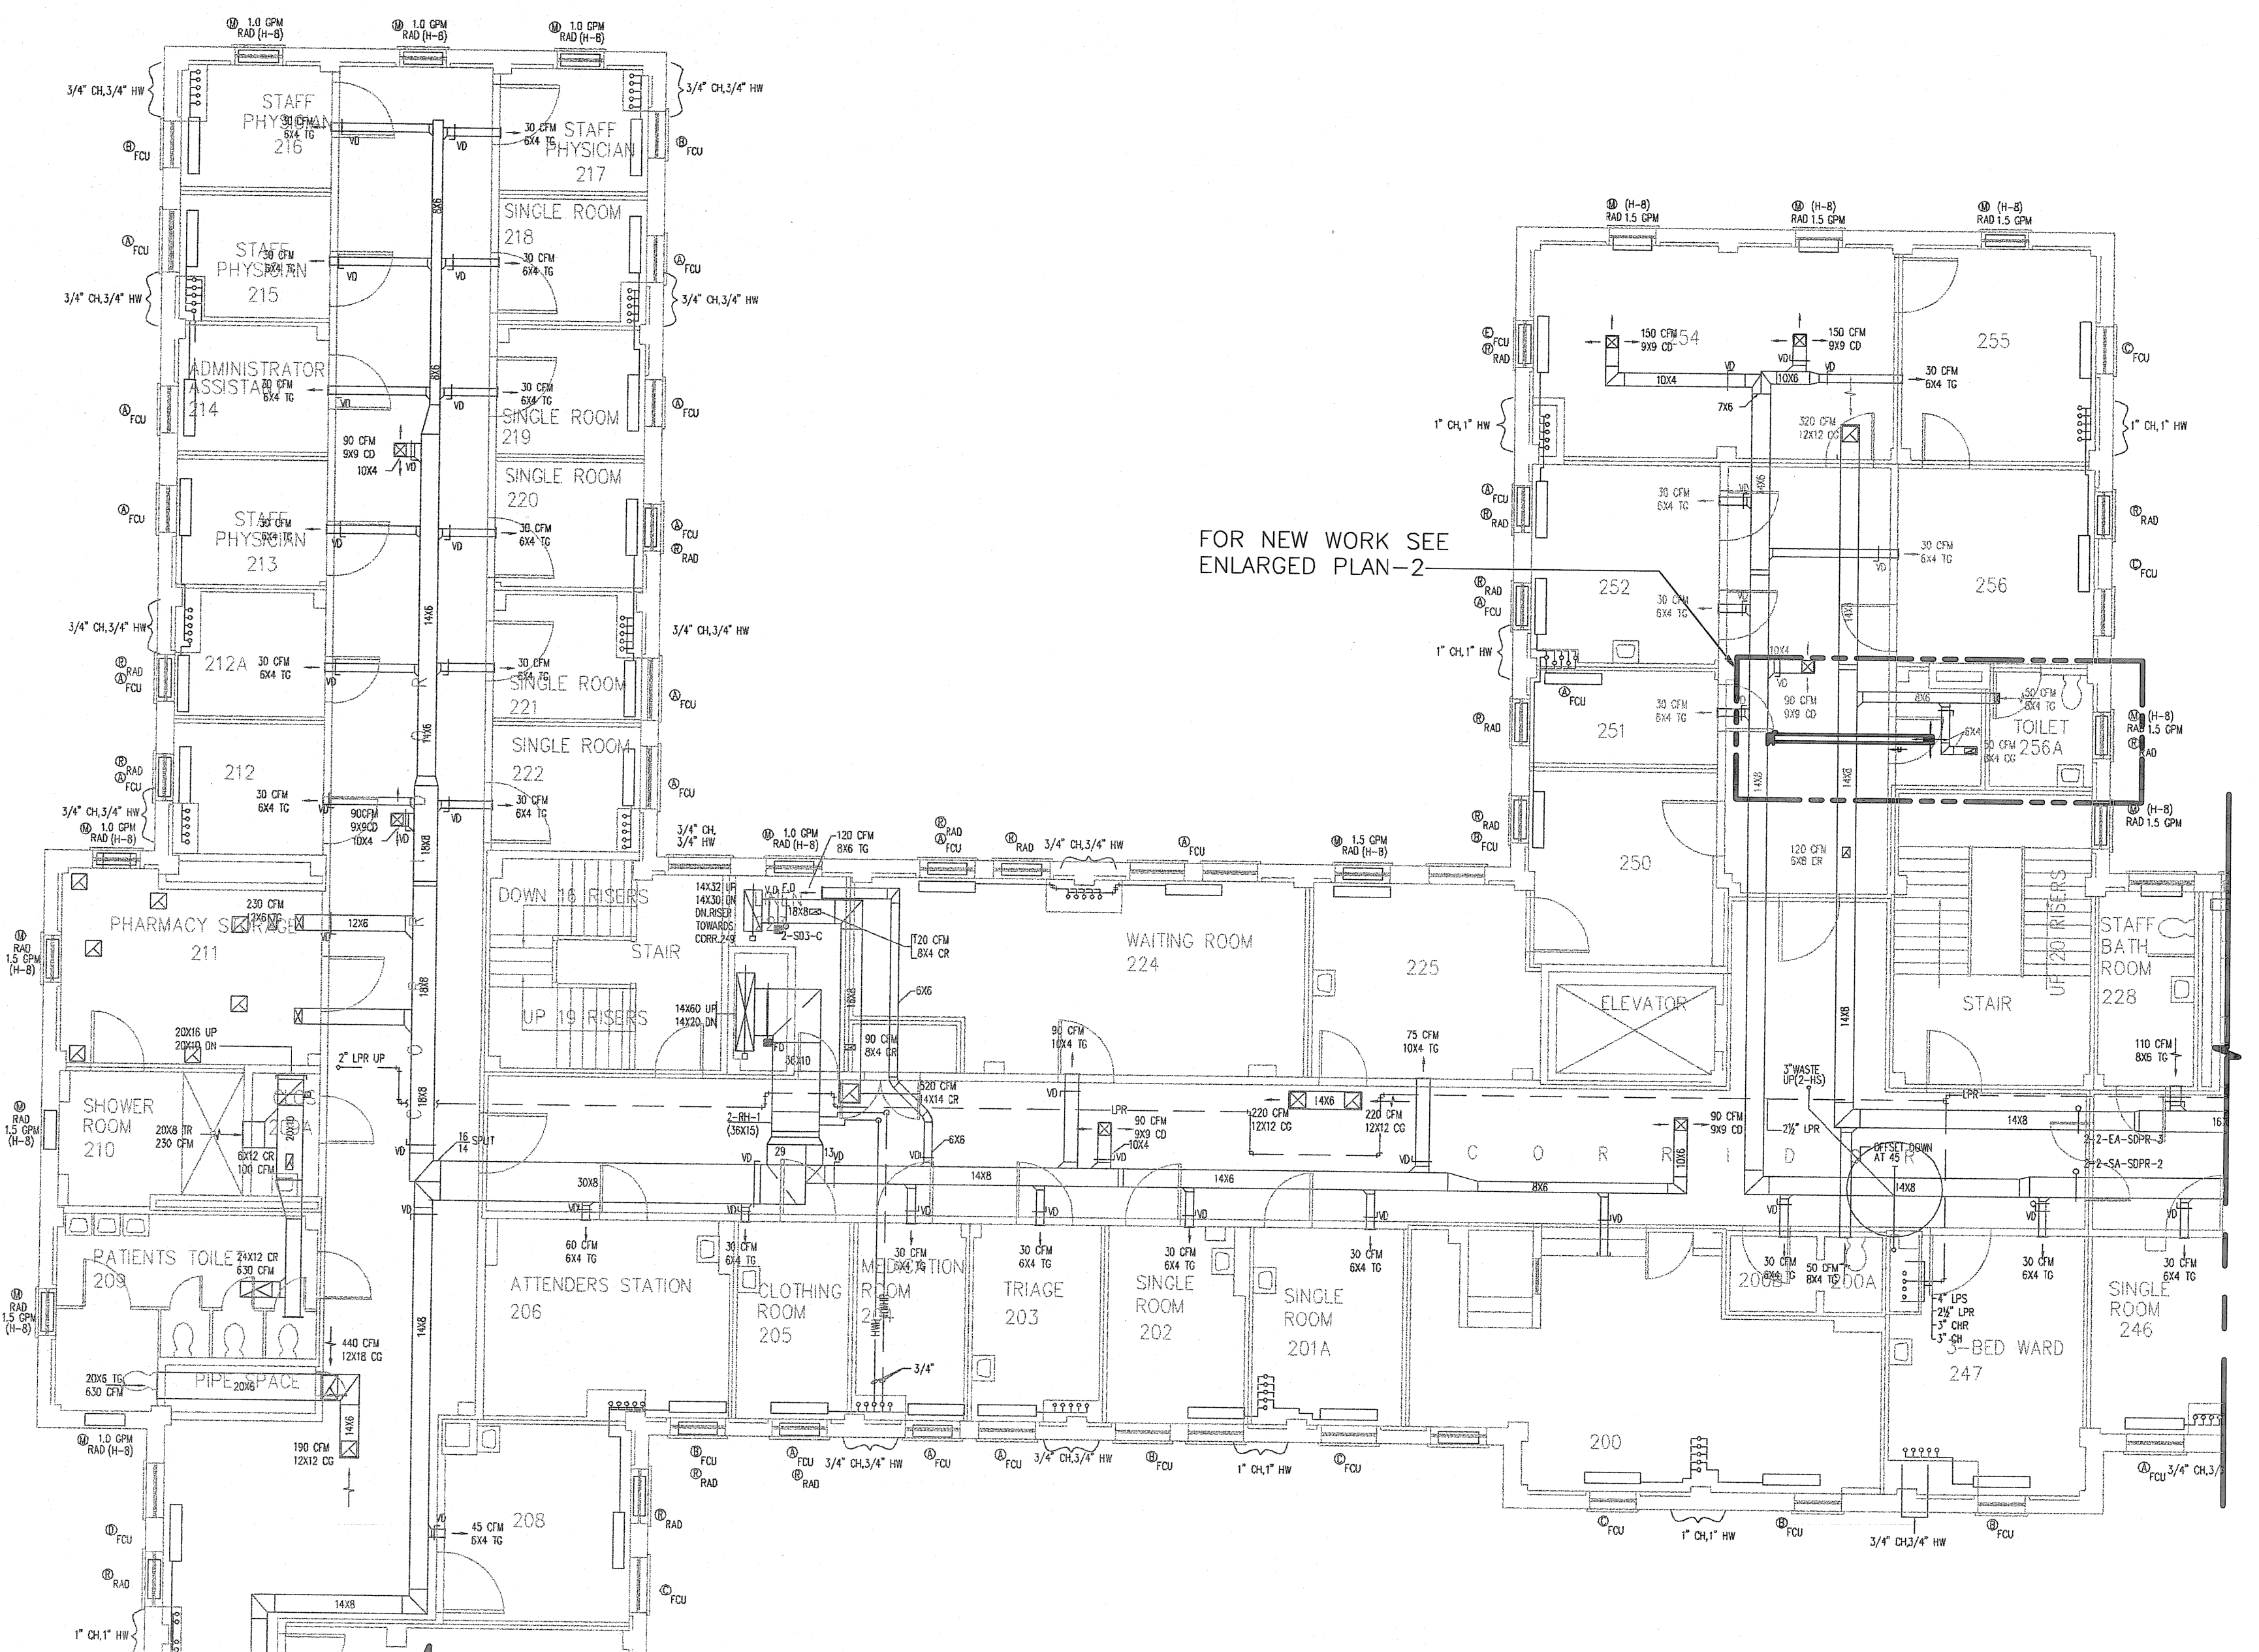

PART AS-BUILT - SECOND FLOOR PLAN
SCALE: 1/8"=1'-0"

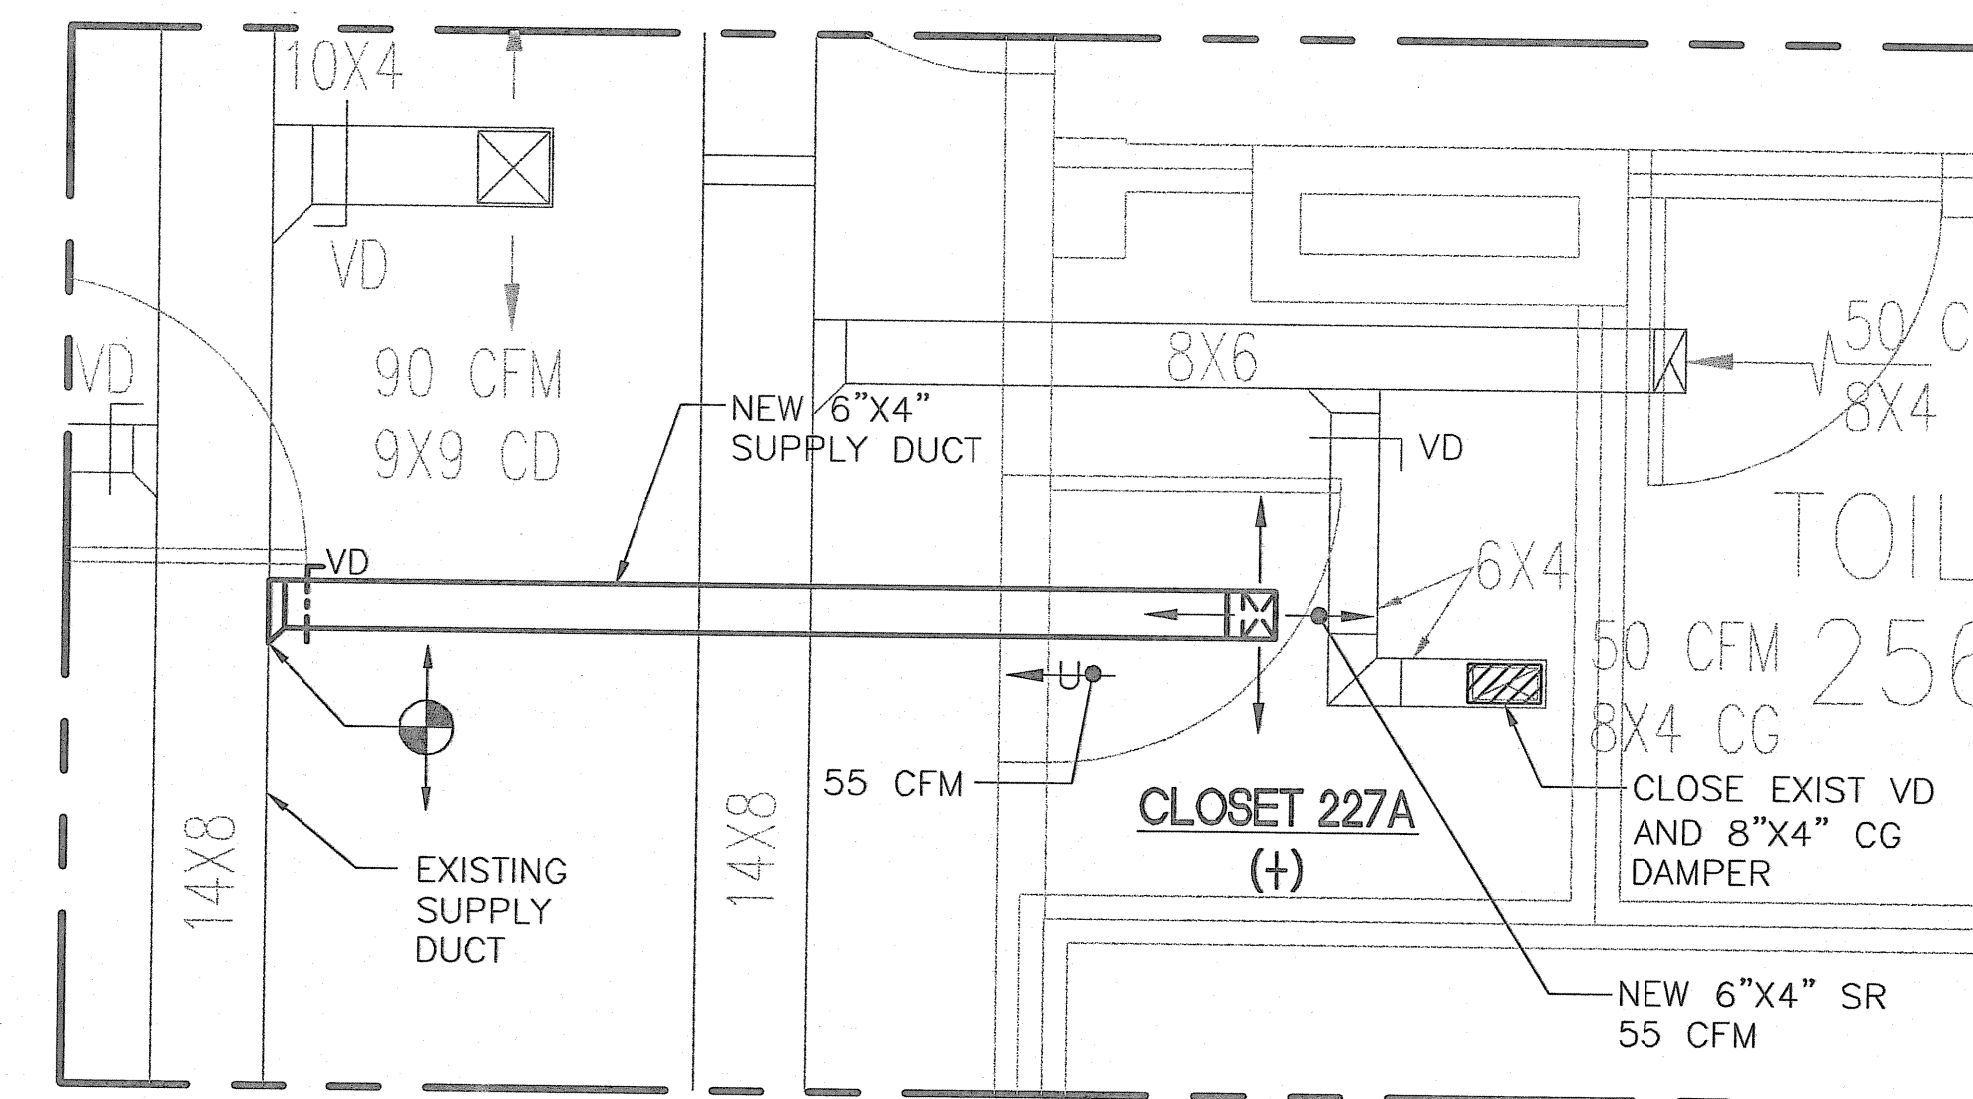

2
NEW WORK - ROOM 227A ENLARGED PLAN - 2
SCALE: 1/2"=1'-0"

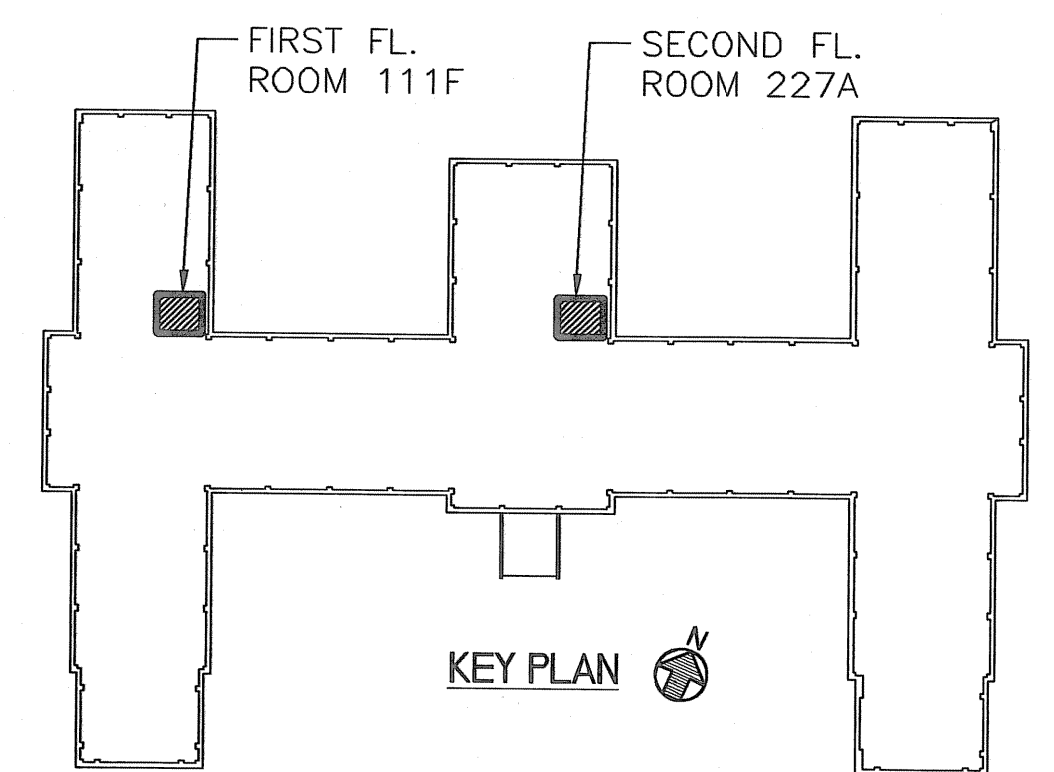


KEY PLAN

Revisions	Date

A/E SEAL

John

A/E ADDRESS

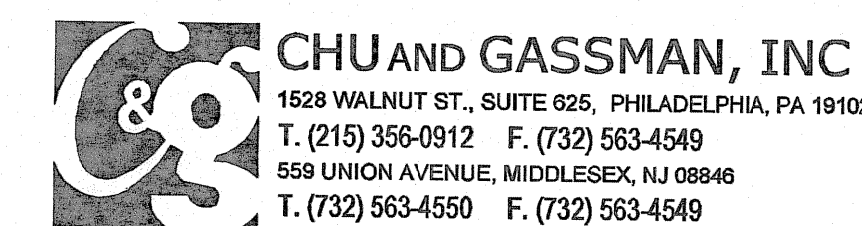

CHU and GASSMAN, INC
1528 WALNUT ST., SUITE 225, PHILADELPHIA, PA 19102
T. (215) 563-0912 F. (732) 563-4549
558 UNION AVENUE, MIDDLESEX, NJ 08948
T. (732) 563-4550 F. (732) 563-4549

Drawing Title

MECHANICAL
NEW WORK
PART FIRST/SECOND FLOOR PLANS

Approved: Chief Engineering Service
Michael Carcanague

Drawn
T. CHU

Approved: Medical Center Director
Gary W. Devansky

Checked
D. GABRIEL

FINAL CONSTRUCTION DOCUMENTS

Project Title

VAMC ENVIRONMENTAL
CONTROLS

Building Number

02

Location

COATESVILLE, PENNSYLVANIA

Date

2/15/2012

Project No.

542-08-114

DRAWING No.

02MH102

Dwg. 7 of 17

VA