


PART AS-BUILT - FIRST FLOOR PLAN
SCALE: 1/8"=1'-0"

PART AS-BUILT - SECOND FLOOR PLAN
SCALE: 1/8"=1'-0"

1 NEW WORK - ROOM 107 ENLARGED PLAN - 1
SCALE: 1/2"=1'-0"

2 NEW WORK - ROOM 202 ENLARGED PLAN - 2
SCALE: 1/2"=1'-0"

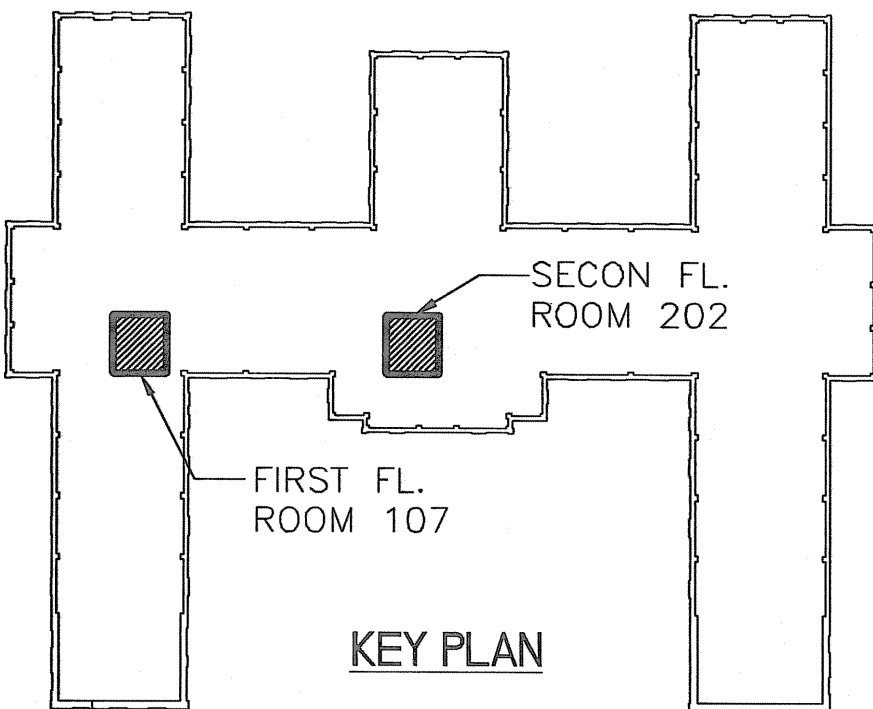

Revisions	Date

A/E SEAL		A/E ADDRESS		Drawing Title		Project Title		Date
		CHU AND GASSMAN, INC 1528 WALNUT ST., SUITE 625, PHILADELPHIA, PA 19102 T. (215) 355-0912 F. (732) 563-4549 559 UNION AVENUE, MIDDLESEX, NJ 08846 T. (732) 563-4550 F. (732) 563-4549		MECHANICAL NEW WORK PART FIRST/SECOND FLOOR PLANS		VAMC ENVIRONMENTAL CONTROLS		2/15/2012
				Approved: Chief Engineering Service Michael Carcanague		Drawn T. CHU		Project No. 542-08-114
Approved: Medical Center Director Gary W. Devansky		Checked D. GABRIEL		Building Number 57		Location COATESVILLE, PENNSYLVANIA		DRAWING No. 57MH101
								Dwg. 13 of 17

V.A.