

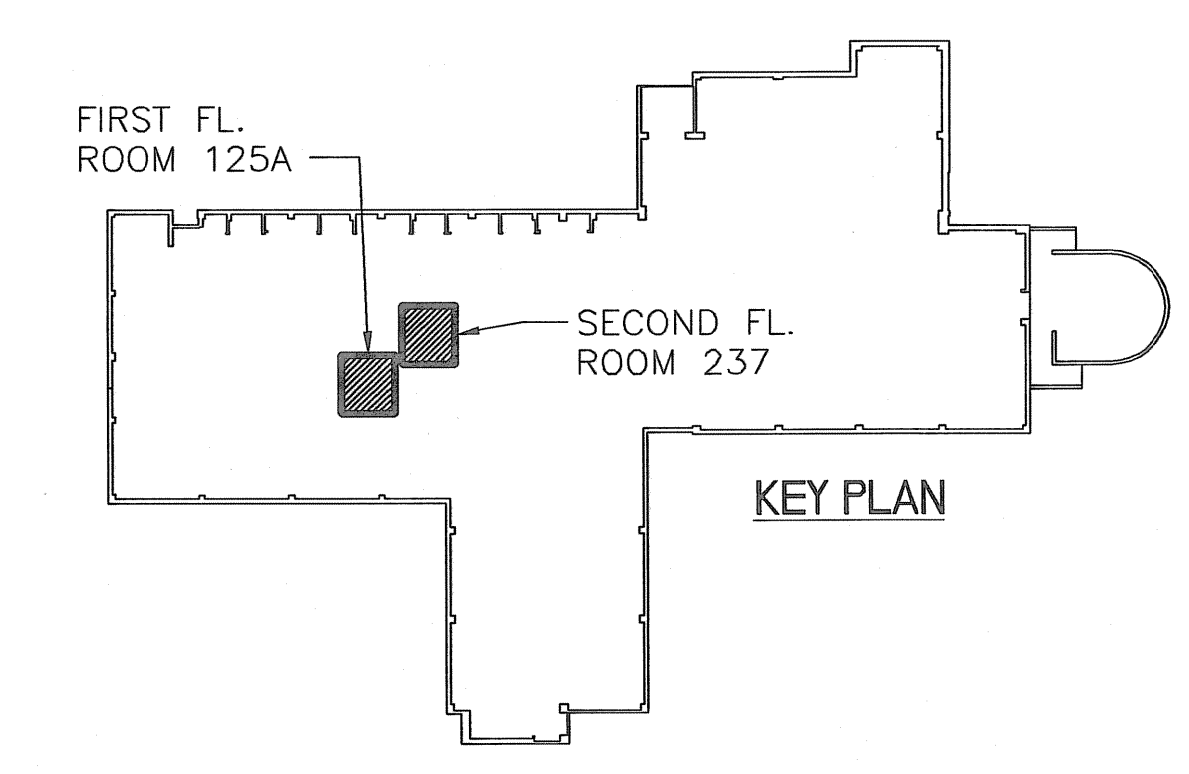
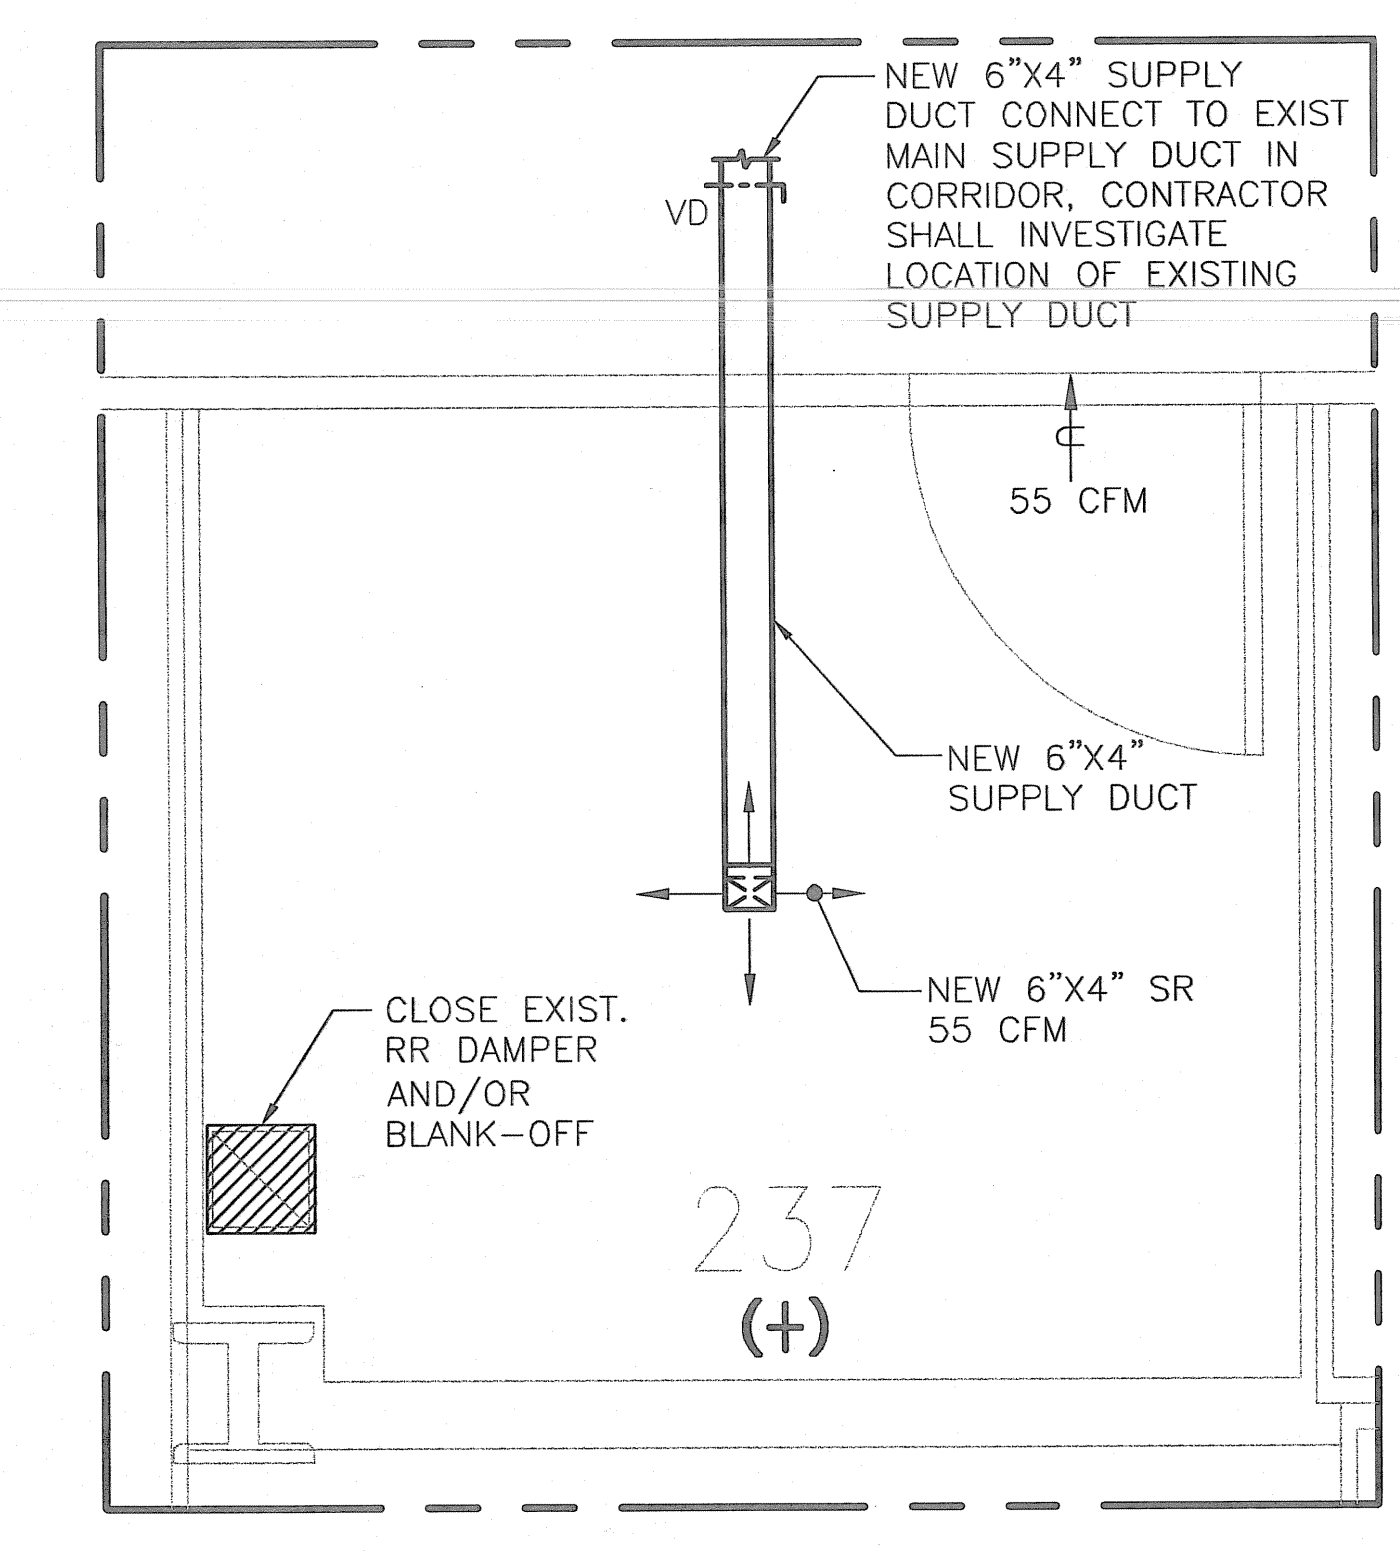
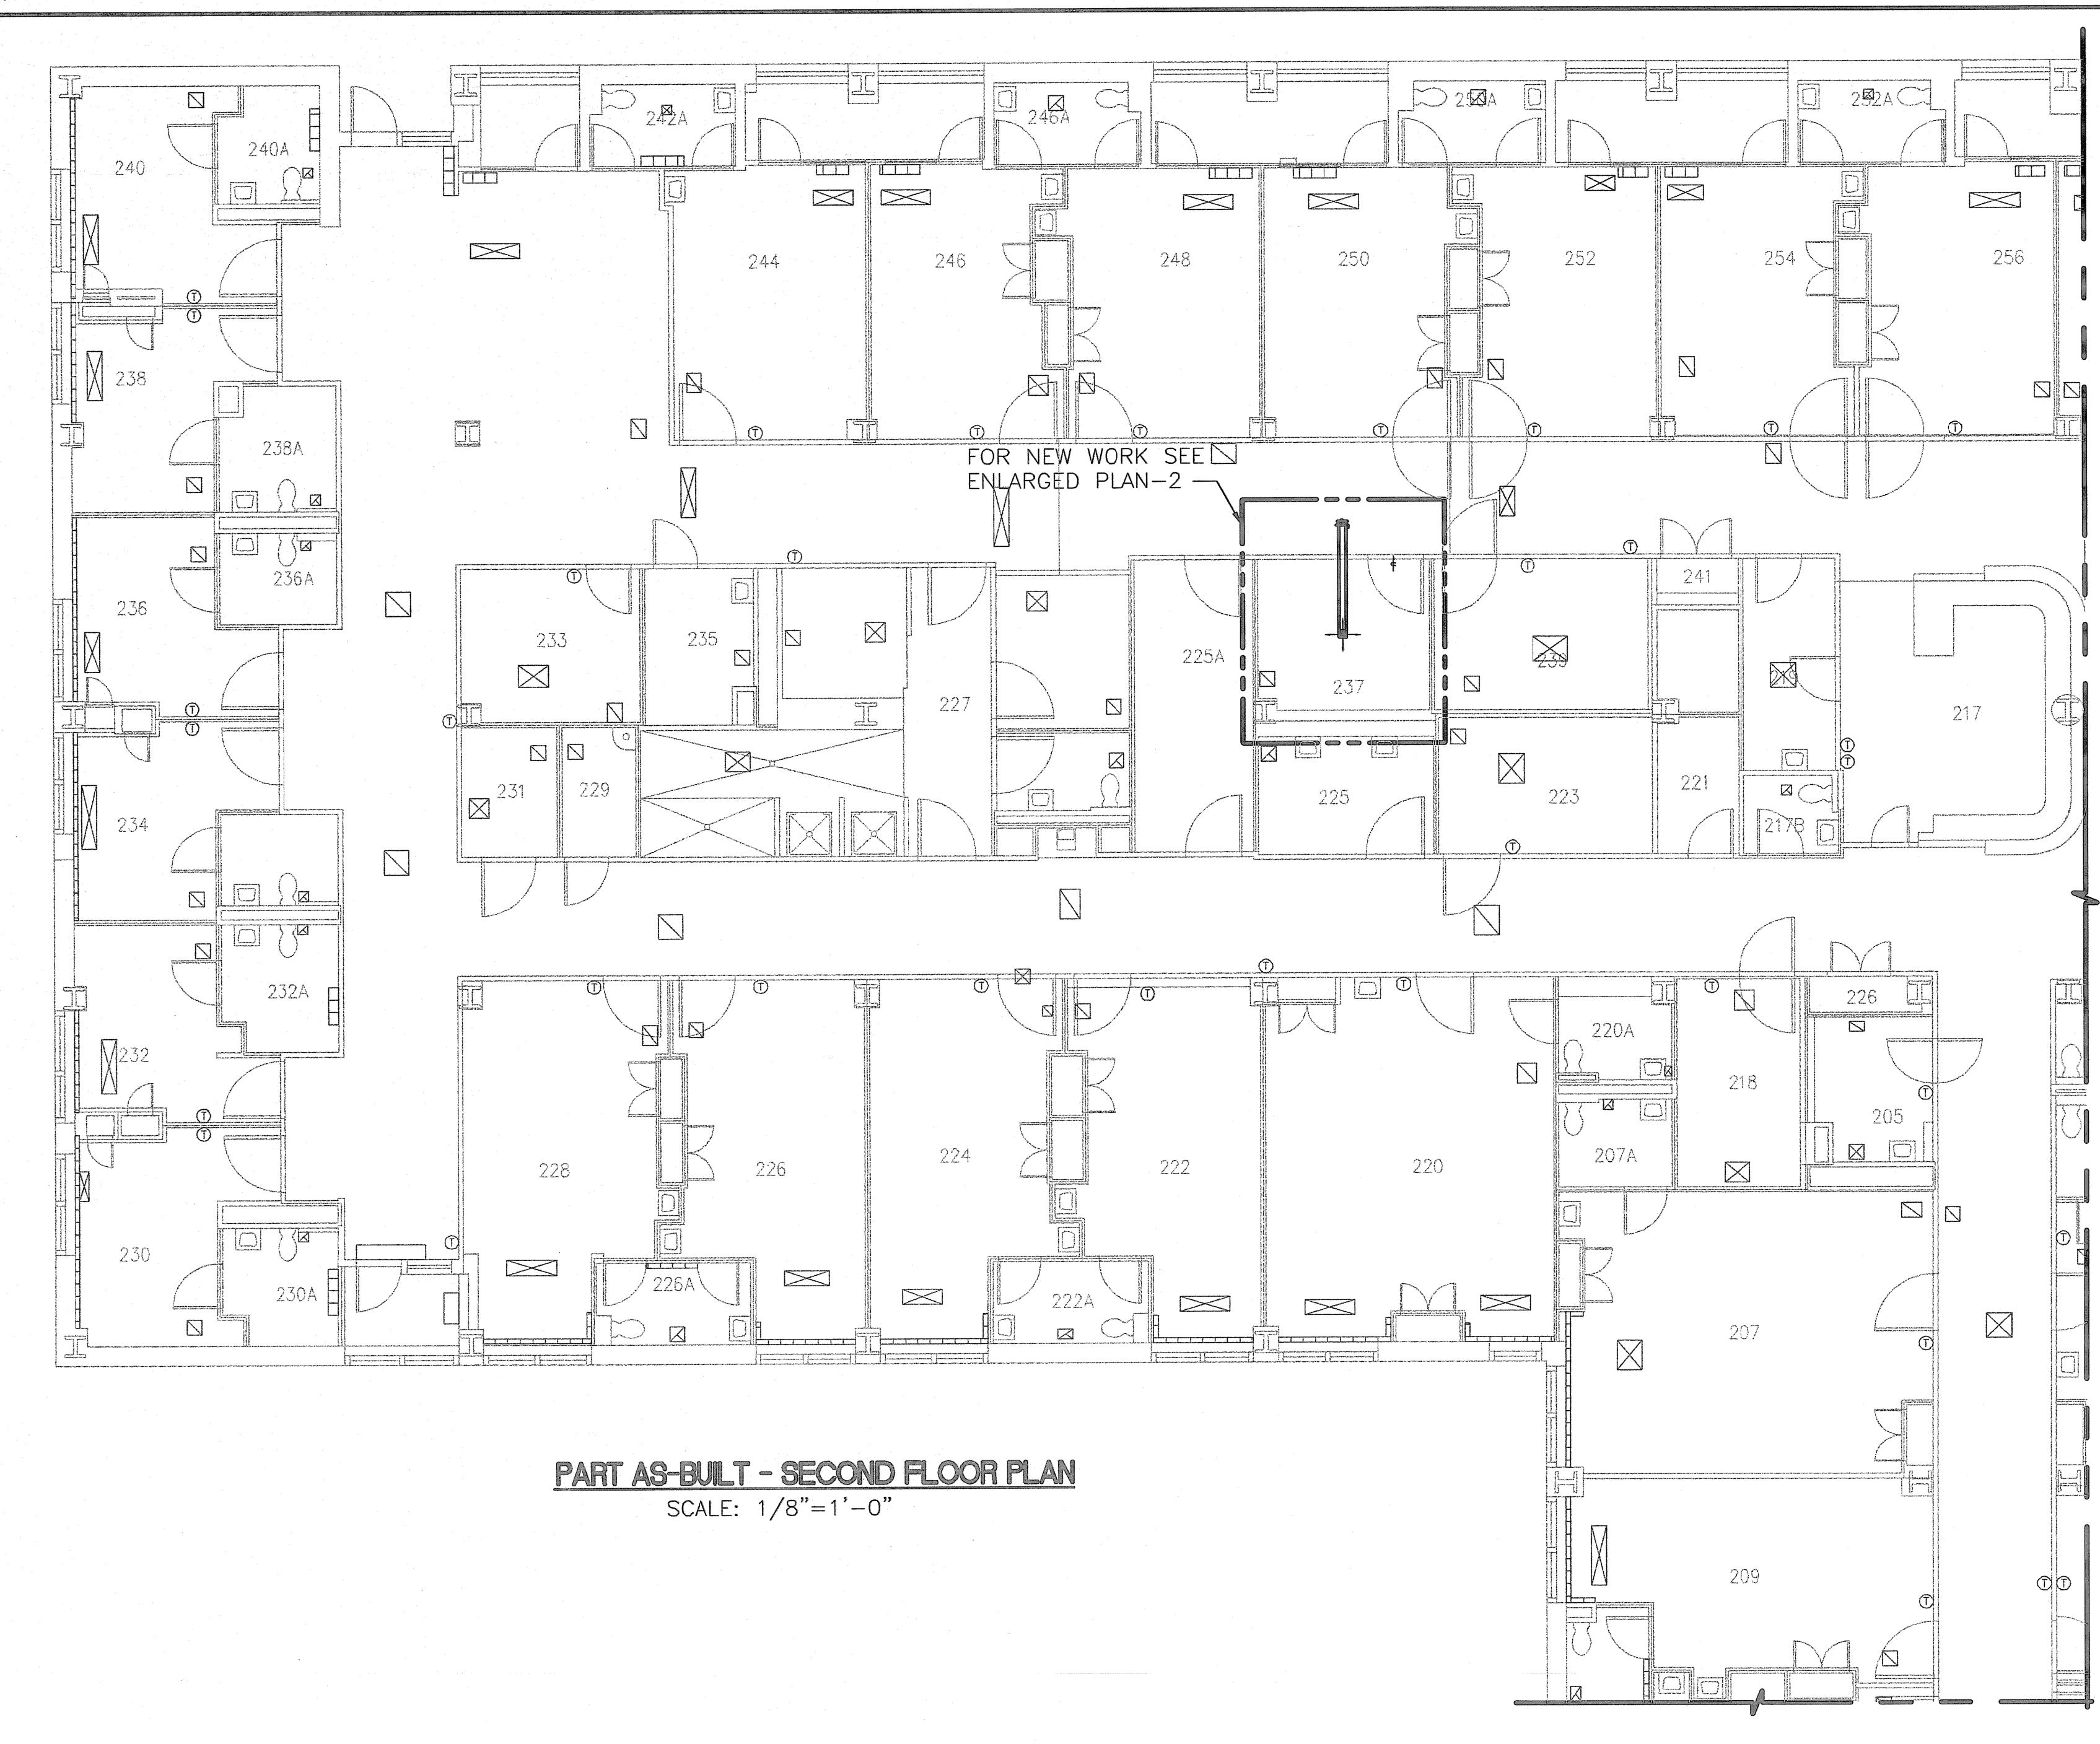


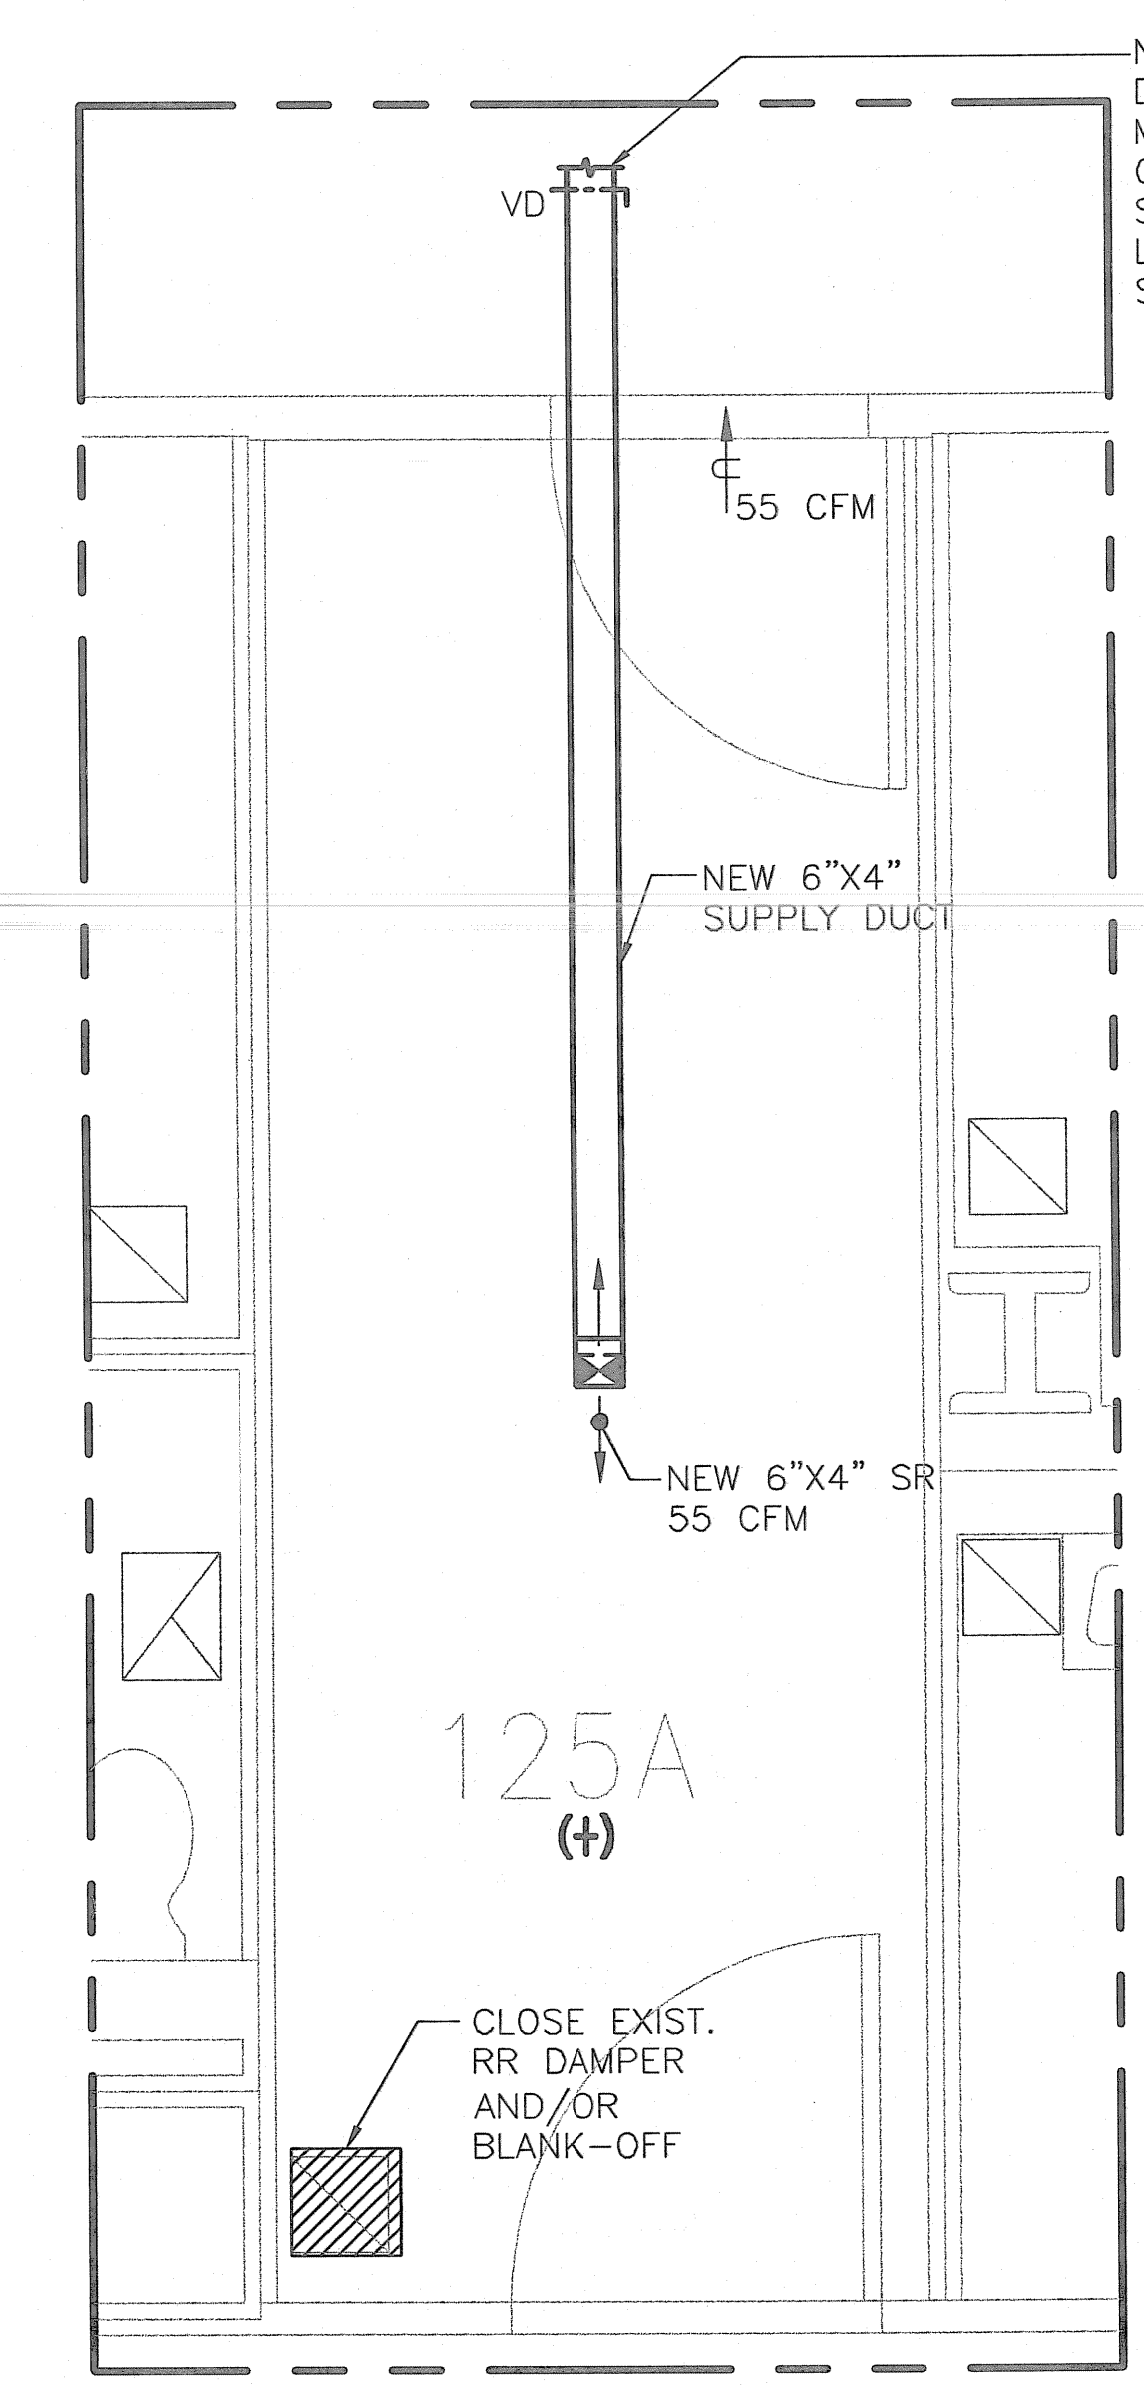

A
 B
 C
 D
 E
 F

three inches = one foot
 one and one half inches = one foot
 one inch = one foot
 three quarters inch = one foot
 one half inch = one foot
 three eighths inch = one foot
 one quarter inch = one foot
 one eighth inch = one foot

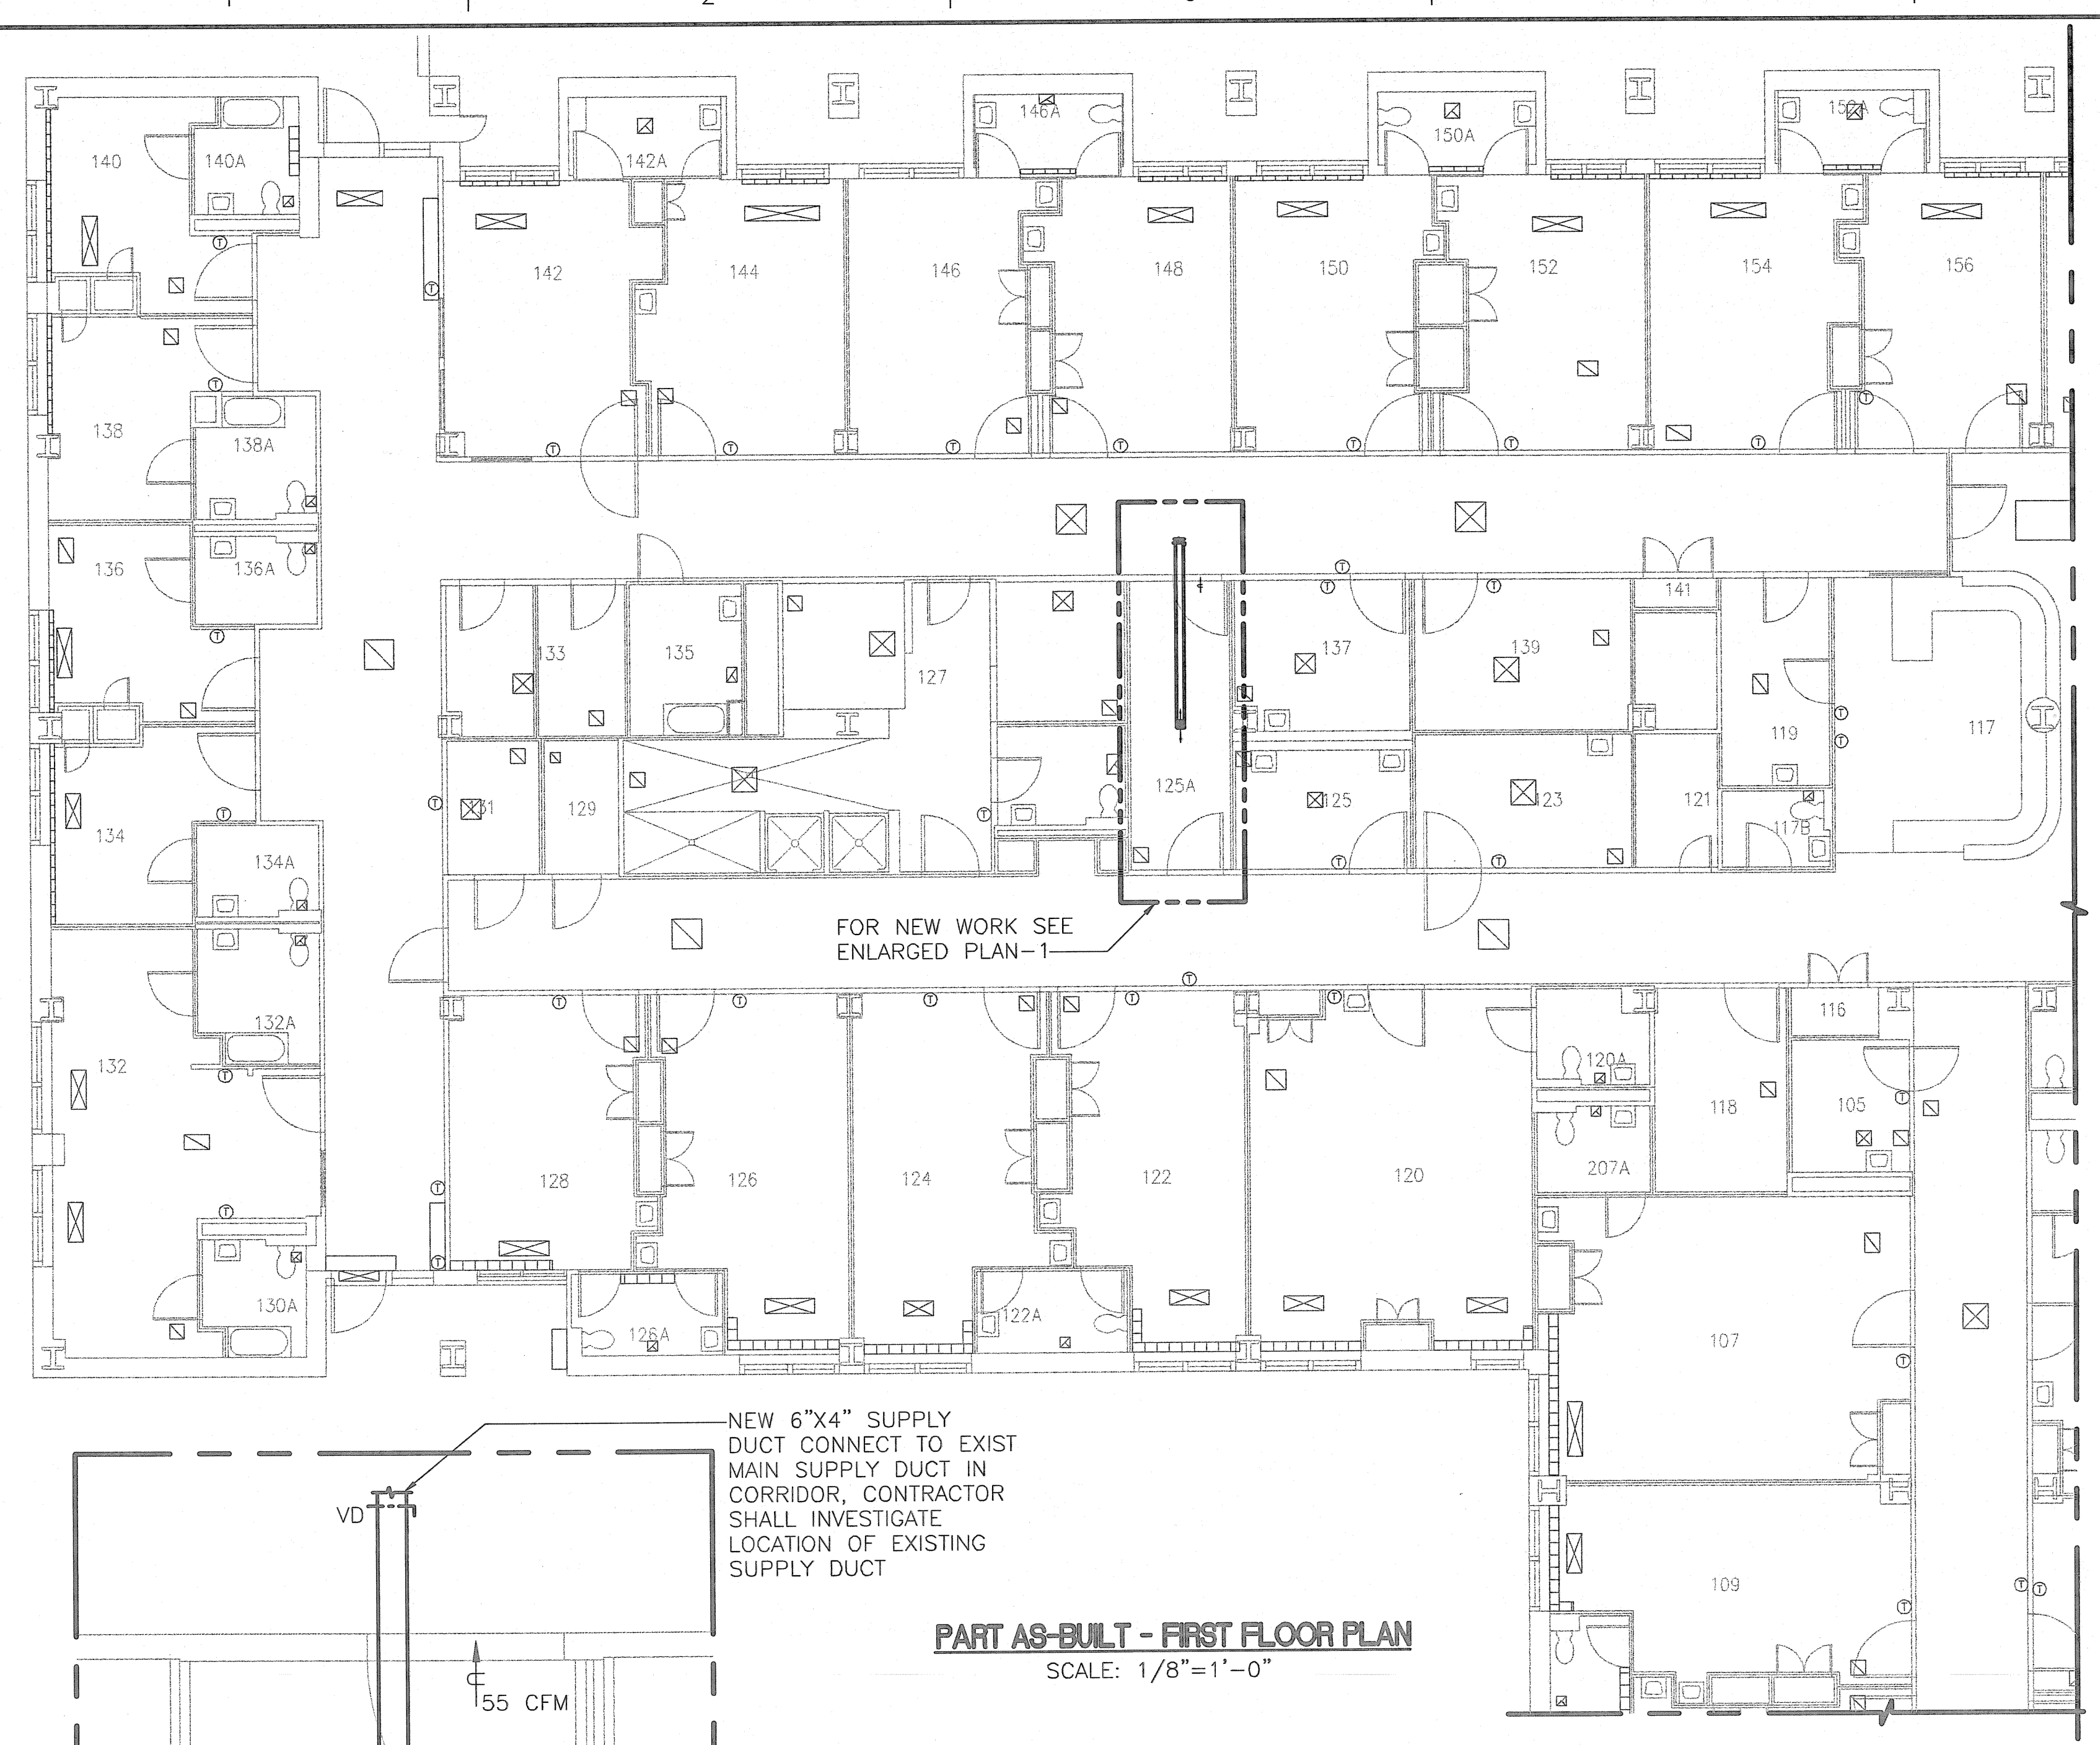

Revisions	Date

<div>A/E SEAL</div> <div></div>	<div>A/E ADDRESS</div> <div><div>CHU AND GASSMAN, INC 1628 WALNUT ST., SUITE 405, PHILADELPHIA, PA 19102 T. (215) 356-0912 F. (732) 563-4549 559 UNION AVENUE, MIDDLESEX, NJ 08849 T. (732) 563-4550 F. (732) 563-4549</div></div>	Drawing Title		Project Title		Date
		MECHANICAL NEW WORK PART FIRST/SECOND FLOOR PLANS		VAMC ENVIRONMENTAL CONTROLS		2/15/2012
		Approved: Chief Engineering Service		Drawn	Building Number	Project No.
		Michael Carcanogue		T. CHU	138	542-08-114
		Approved: Medical Center Director		Checked	Location	DRAWING No.
		Gary W. Devansky		D. GABRIEL	COATESVILLE, PENNSYLVANIA	138MH101
				Dwg. 160f17		

VA

VA