




three inches = one foot
one and one half inches = one foot
one inch = one foot
three quarters inch = one foot
one half inch = one foot
one quarter inch = one foot
one eighth inch = one foot

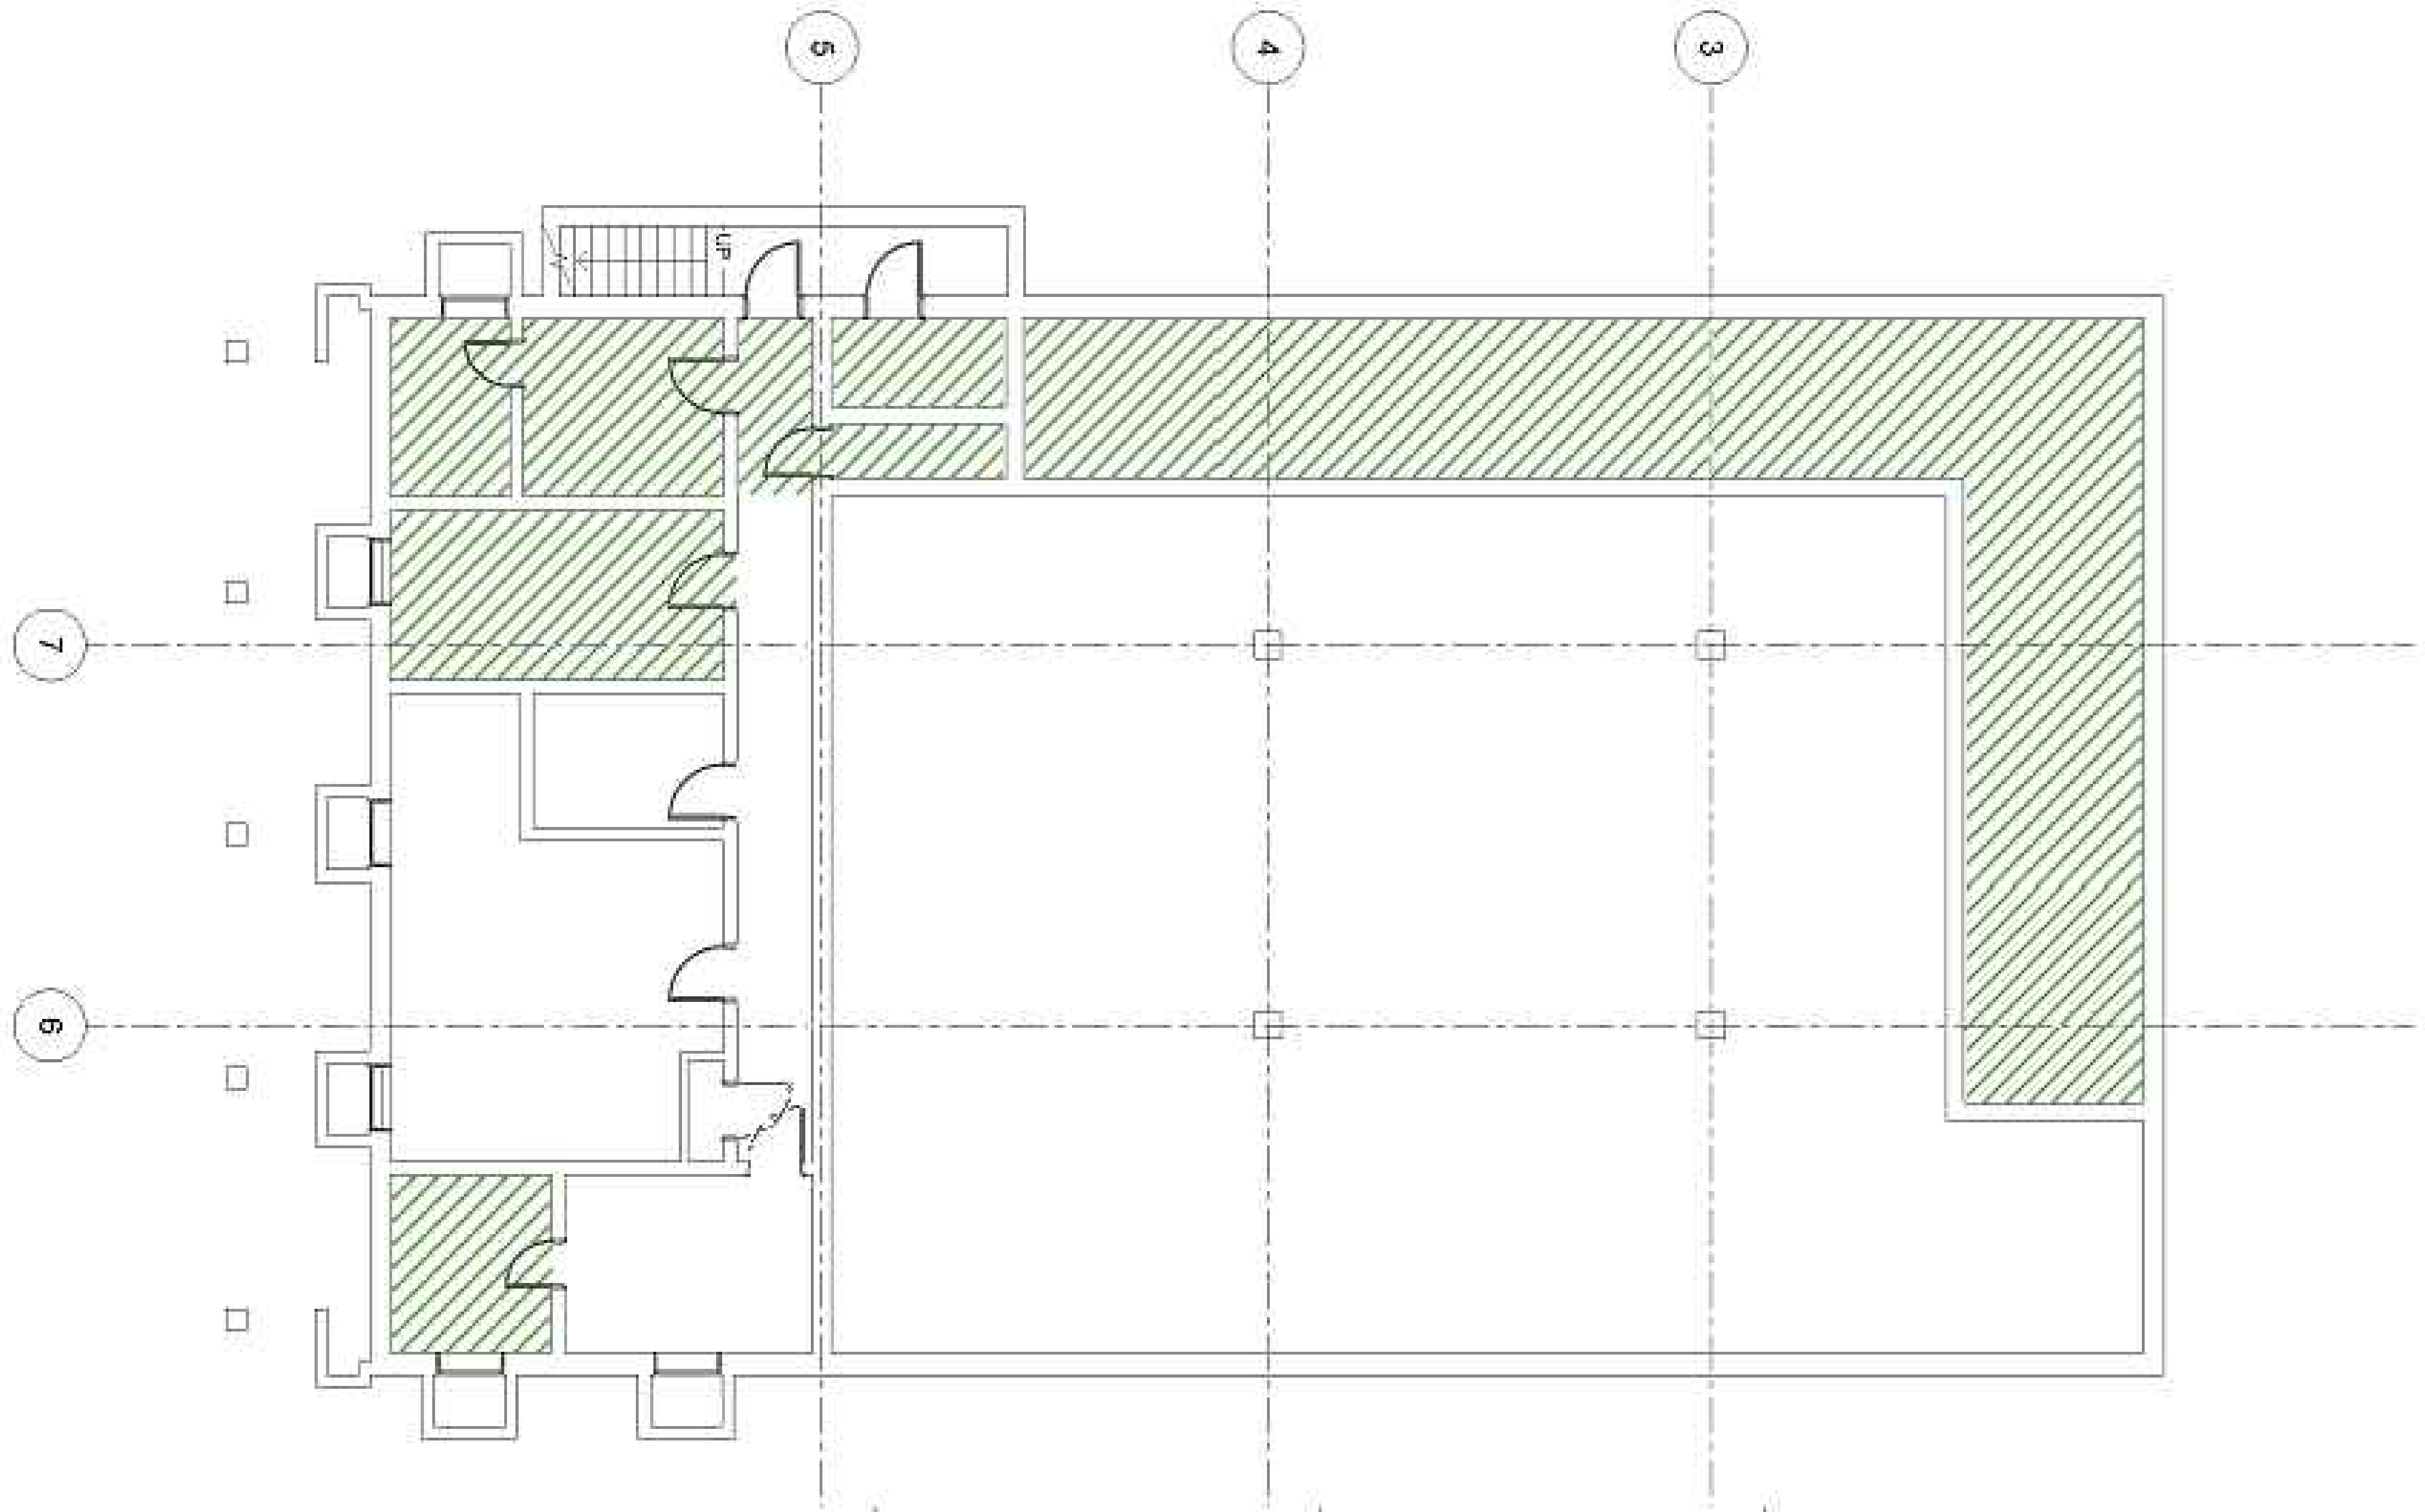

LEGEND

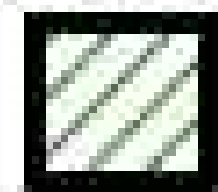

REMOVE ASBESTOS CONTAINING PIPE INSULATION, HARD FITTINGS AND ALL CONTAMINATED SOIL. ALL PIPE INSULATION & HARD FITTINGS SHALL BE ABATED UTILIZING GLOVEBAG ASBESTOS ABATEMENT METHODS AS OUTLINED IN SECTION 02.82.13.13.

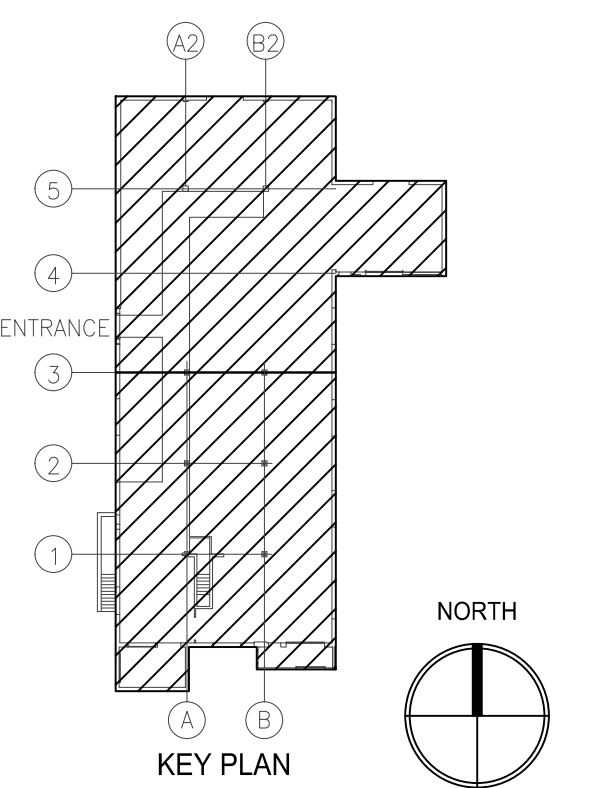

BID DOCUMENTS
FULLY SPRINKLERED

NO.	DESCRIPTION	DATE

CONSULTANTS:

ikm

architecture
planning
interior design
IKM Incorporated
One PPG Place
Pittsburgh, PA 15222


PennTerra
ENGINEERING INC.

CENTRAL PENNSYLVANIA REGION OFFICE: LANCASTER
3075 ENTERPRISE DRIVE, SUITE 100
STATE COLLEGE, PA 16801
PH: 814-237-6950
FAX: 814-237-2300

TTI ENVIRONMENTAL, INC.

A SERVICE DISABLED VETERAN OWNED SMALL BUSINESS (VOSB) CERTIFIED
1253 North Church Street
Moorestown, NJ 08057
T 856.840.8800
F 856.840.8815

Since 1985
Environmental, Inc.

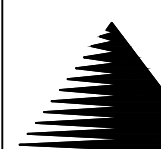

Miller-Remick LLC
M.E.P. & Structural Engineering
A Service Disabled Veteran Owned
Small Business
1010 KINGS HIGHWAY SOUTH
CHERRY HILL, NEW JERSEY 08034
PHONE: (856)425-4000
FAX: (856)425-5012
MR PROJECT NO: 0499-0044





Drawing Title BASEMENT	Project Title RENOVATE BUILDING 6	Project Number 529-13-106
Approved: Project Director	Location VA BUTLER HEALTHCARE BUTLER, PA	Building Number 6
Date 10-12-2017	Checked JAG	Drawn DDC

Project Title RENOVATE BUILDING 6	Project Number 529-13-106
Location VA BUTLER HEALTHCARE BUTLER, PA	Building Number 6
Date 10-12-2017	Checked JAG



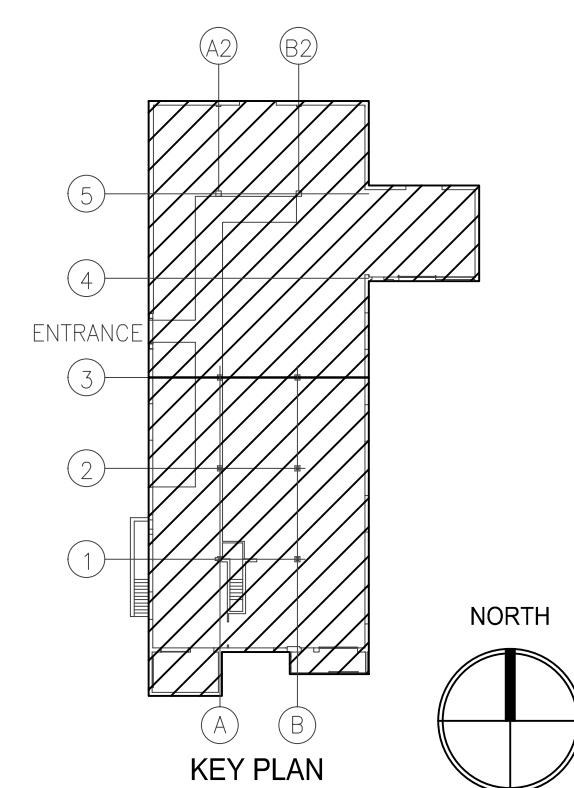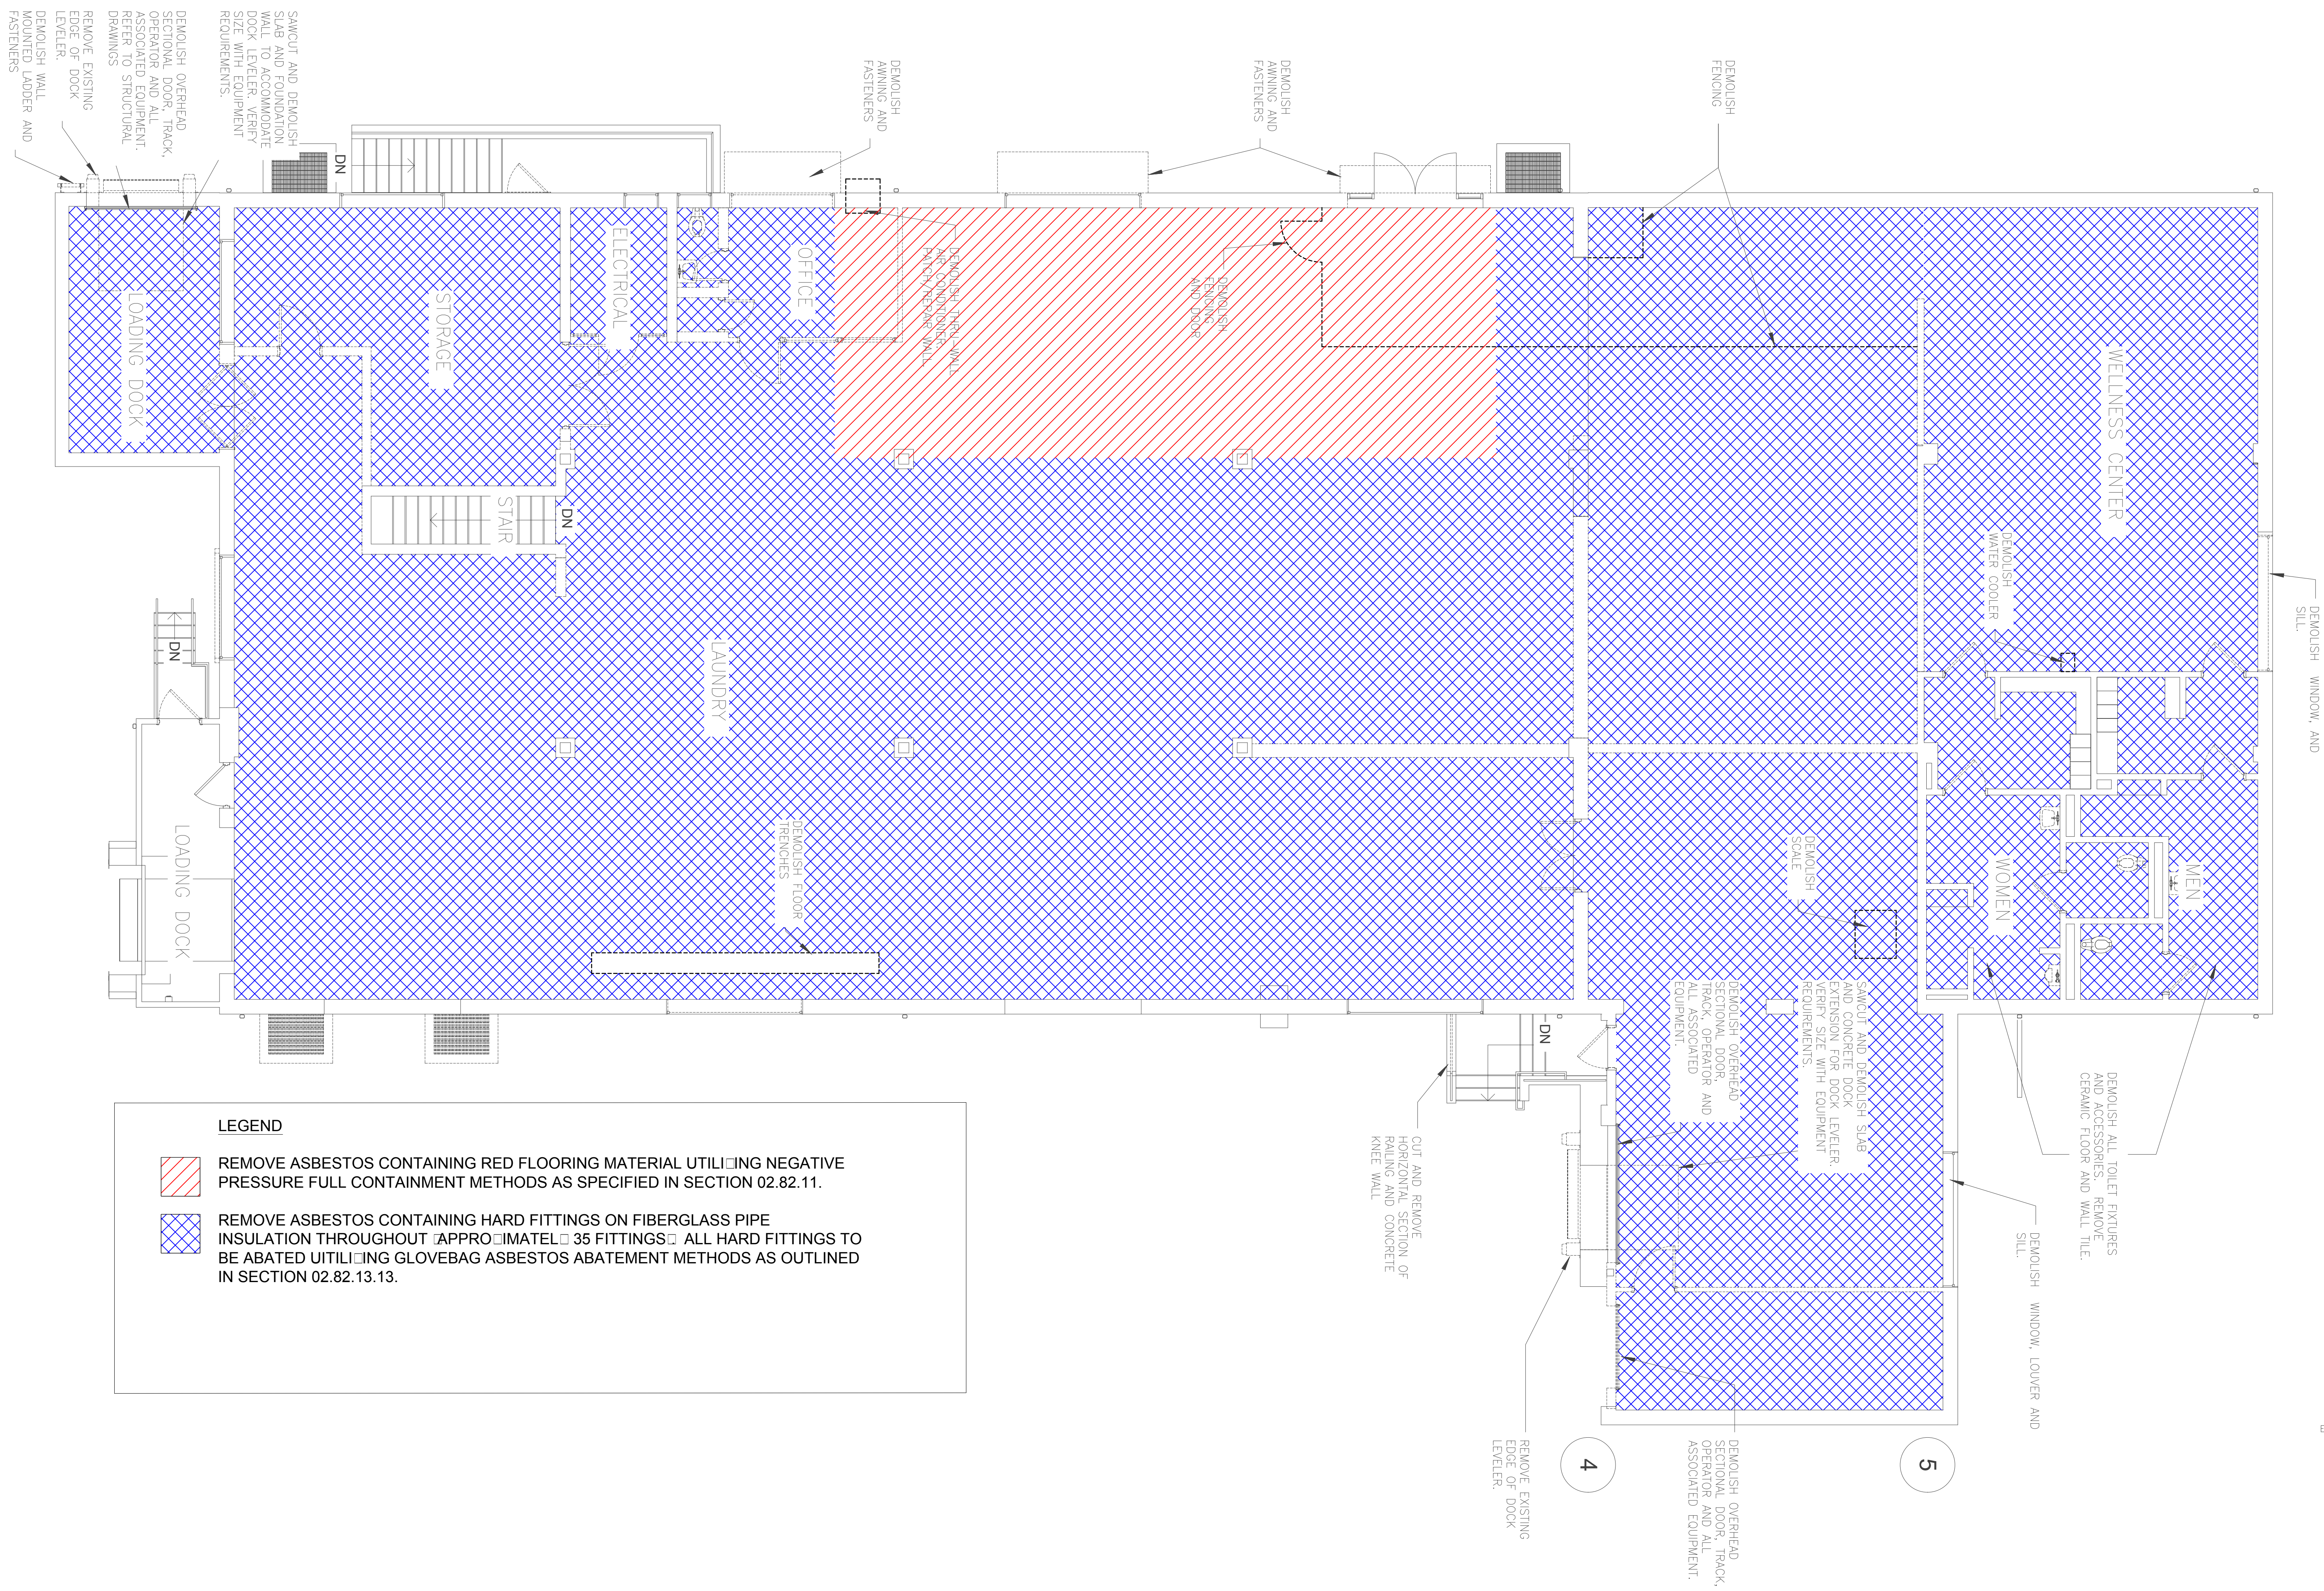


Project Number 529-13-106	Building Number 6

Office of Construction and Facilities Management	Department of Veterans Affairs




Office of
Construction
and Facilities
Management




			CONSULTANTS:			    			Drawing Title 1ST FLOOR			Project Title RENOVATE BUILDING 6			Project Number 529-13-106			Office of Construction and Facilities Management		
									Building Number 6			Drawing Number HA102								
NO. DESCRIPTION DATE						Approved: Project Director			Location VA BUTLER HEALTHCARE BUTLER, PA			Date 10-12-2017			Checked JAG			Drawn DDC		

three inches = one foot
one and one half inches = one foot
one inch = one foot
three quarters inch = one foot
one half inch = one foot
three eighths inch = one foot
one quarter inch = one foot
one eighth inch = one foot

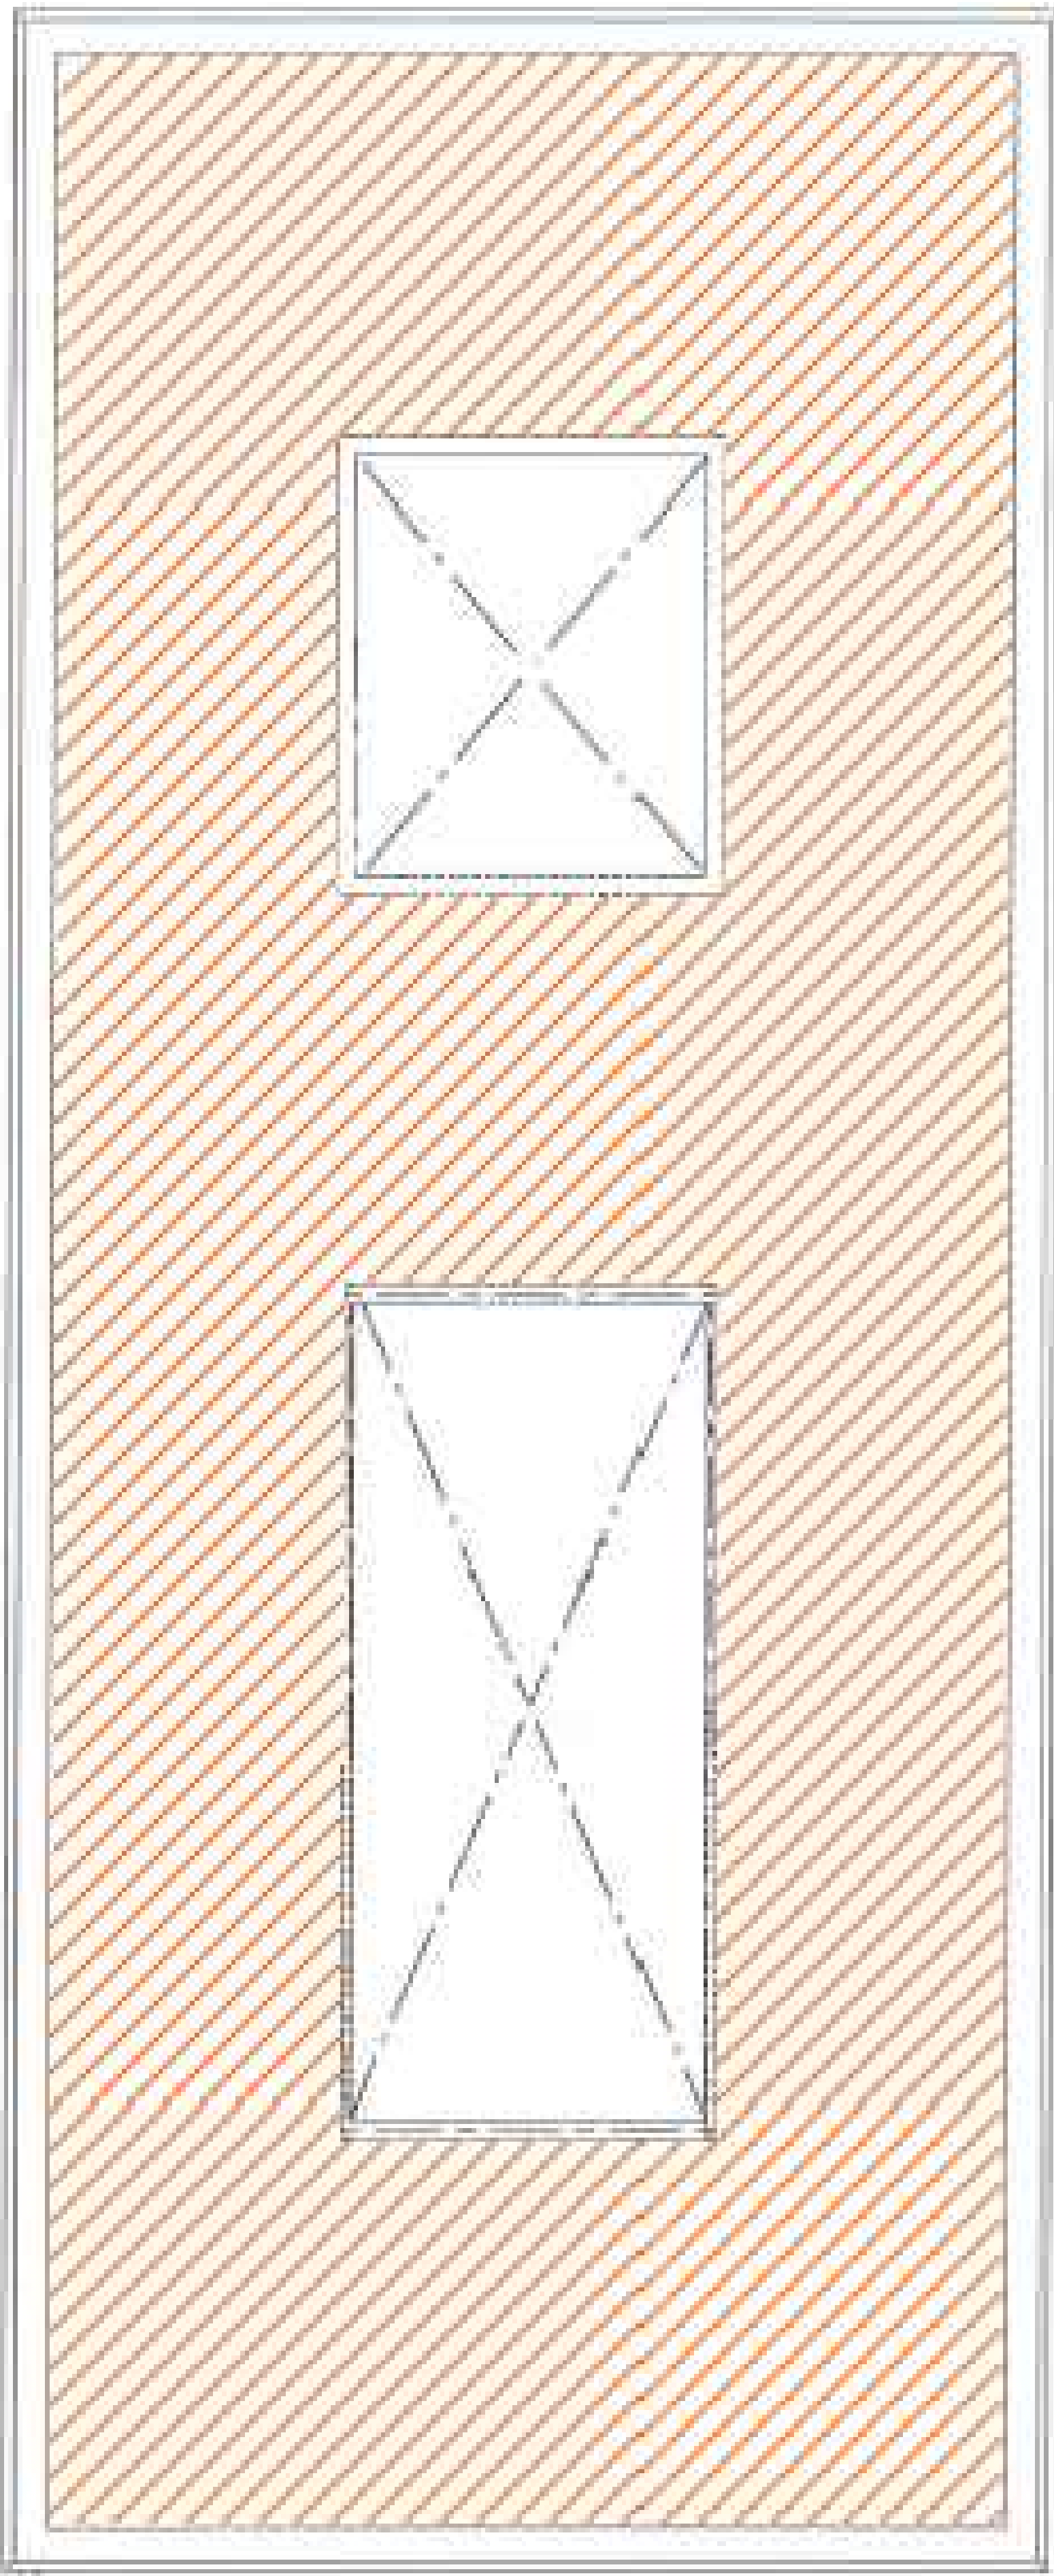

LEGEND

REMOVE APPROXIMATELY 200 SF OF ROOF FLASHING UTILIZING NEGATIVE PRESSURE FULL CONTAINMENT METHODS AS OUTLINED IN SECTION 02.82.11.

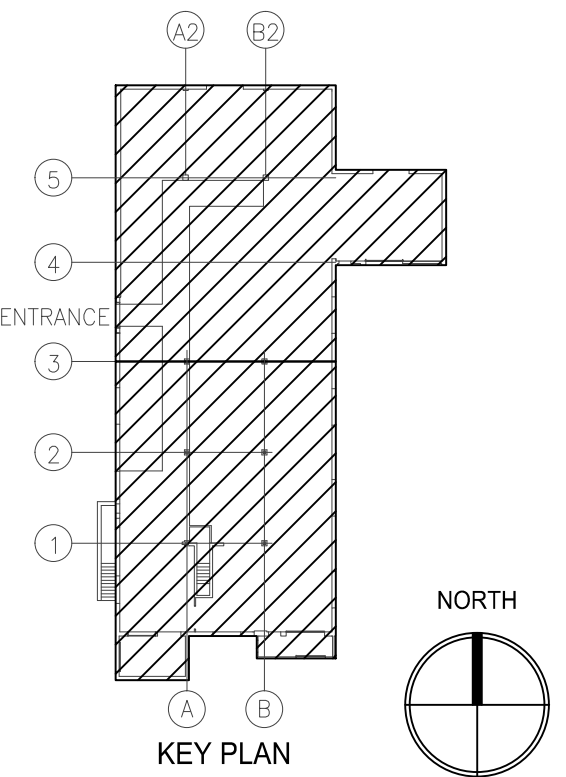

BID DOCUMENTS
FULLY SPRINKLERED

<div>VA FORM 08-6231</div>	CONSULTANTS:			<div><div>MILLER-REMICK CORPORATION PROFESSIONAL ENGINEER</div><div></div><div><div>Miller-Remick LLC M.E.P. & Structural Engineering A Service Disabled Veteran Owned Small Business 1010 KINGS HIGHWAY SOUTH CHERRY HILL, NEW JERSEY 08034 PHONE: (856)425-4000 FAX: (856)425-5012 MR PROJECT NO: 0499-0044</div><div></div></div></div>	Drawing Title ATTIC FLOOR		Project Title RENOVATE BUILDING 6		Project Number 529-13-106		<div>Office of Construction and Facilities Management</div> <div> Department of Veterans Affairs</div>
			Location VA BUTLER HEALTHCARE BUTLER, PA		Building Number 6						
			Date 10-12-2017		Checked JS		Drawn DC				
			Approved: Project Director		Drawing Number HA103						