

1 Level 1
1" = 20'-0"

Revisions:	Date

VA FORM 08-6231

CONSULTANTS:

ARCHITECT/ENGINEERS:


Drawing Title
FIRST FLOOR
Approved: Project Director


Project Title
BUILDING 163
Location
TEMPLE, TX
Date
4/28/2017 8:25:15 AM
Checked
TB
Drawn
TB

Project Number
N/A
Building Number
163
Drawing Number
103

Office of
Construction
and Facilities
Management

Department of
Veterans Affairs

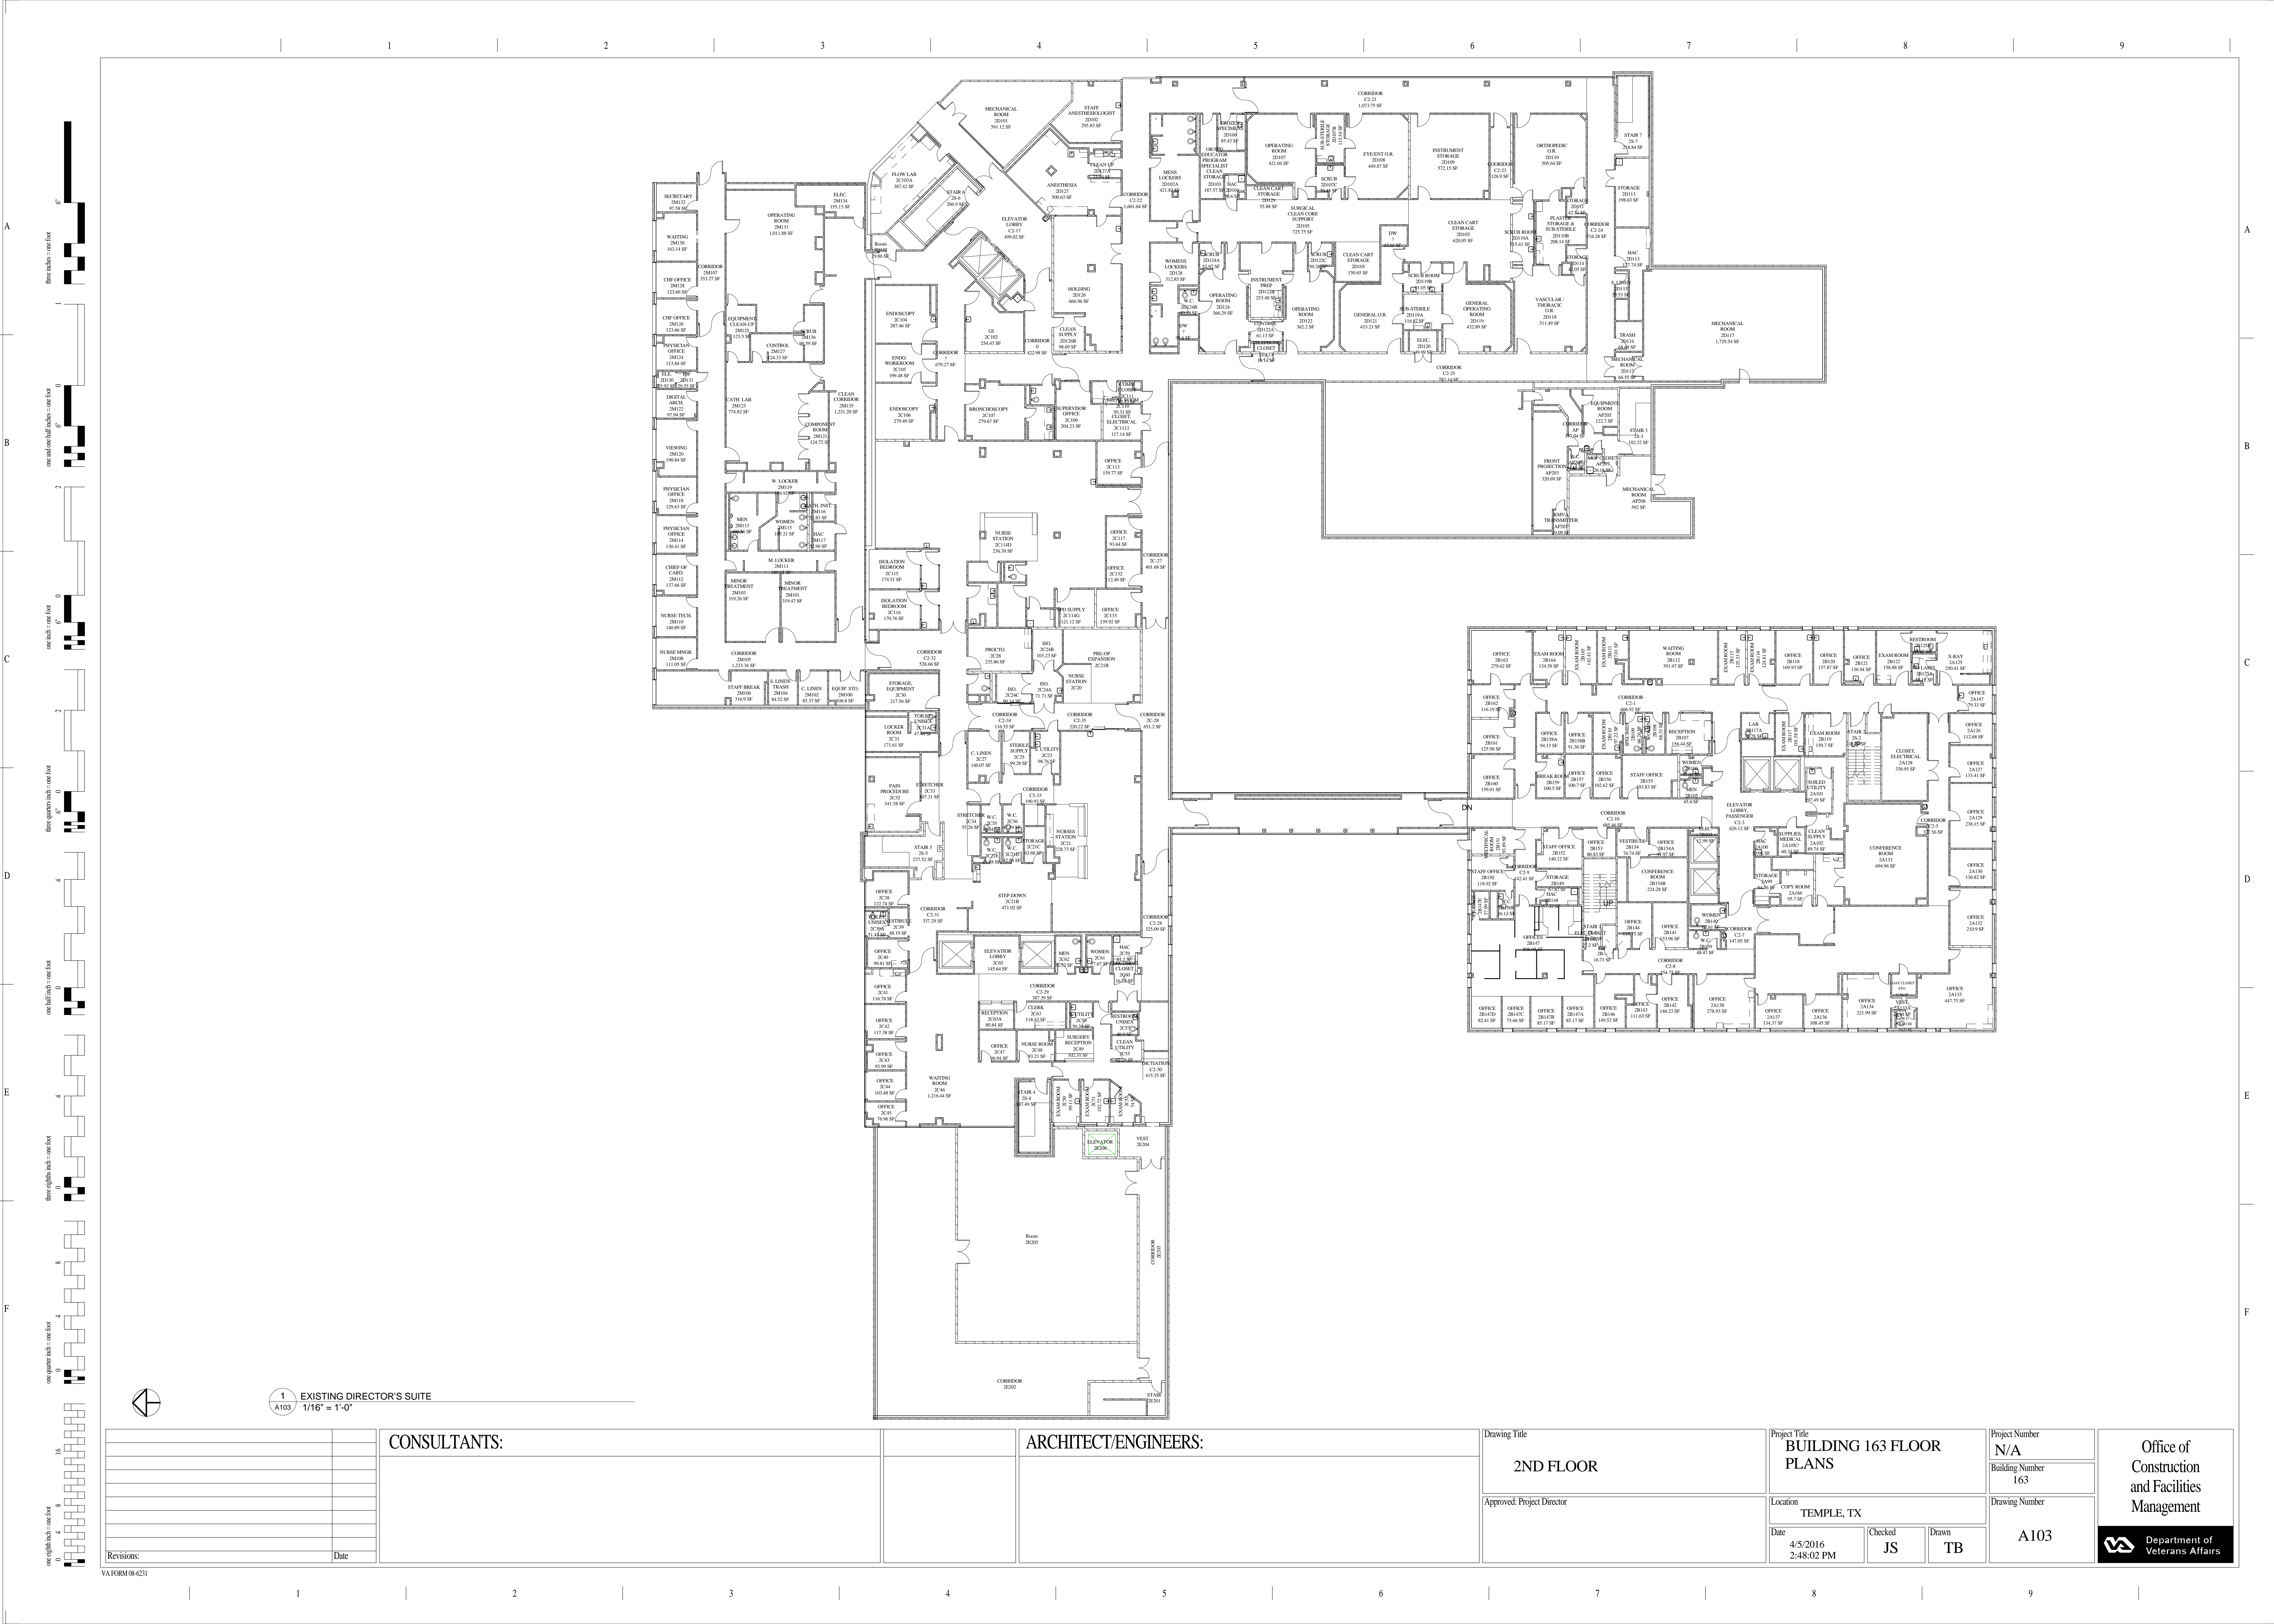


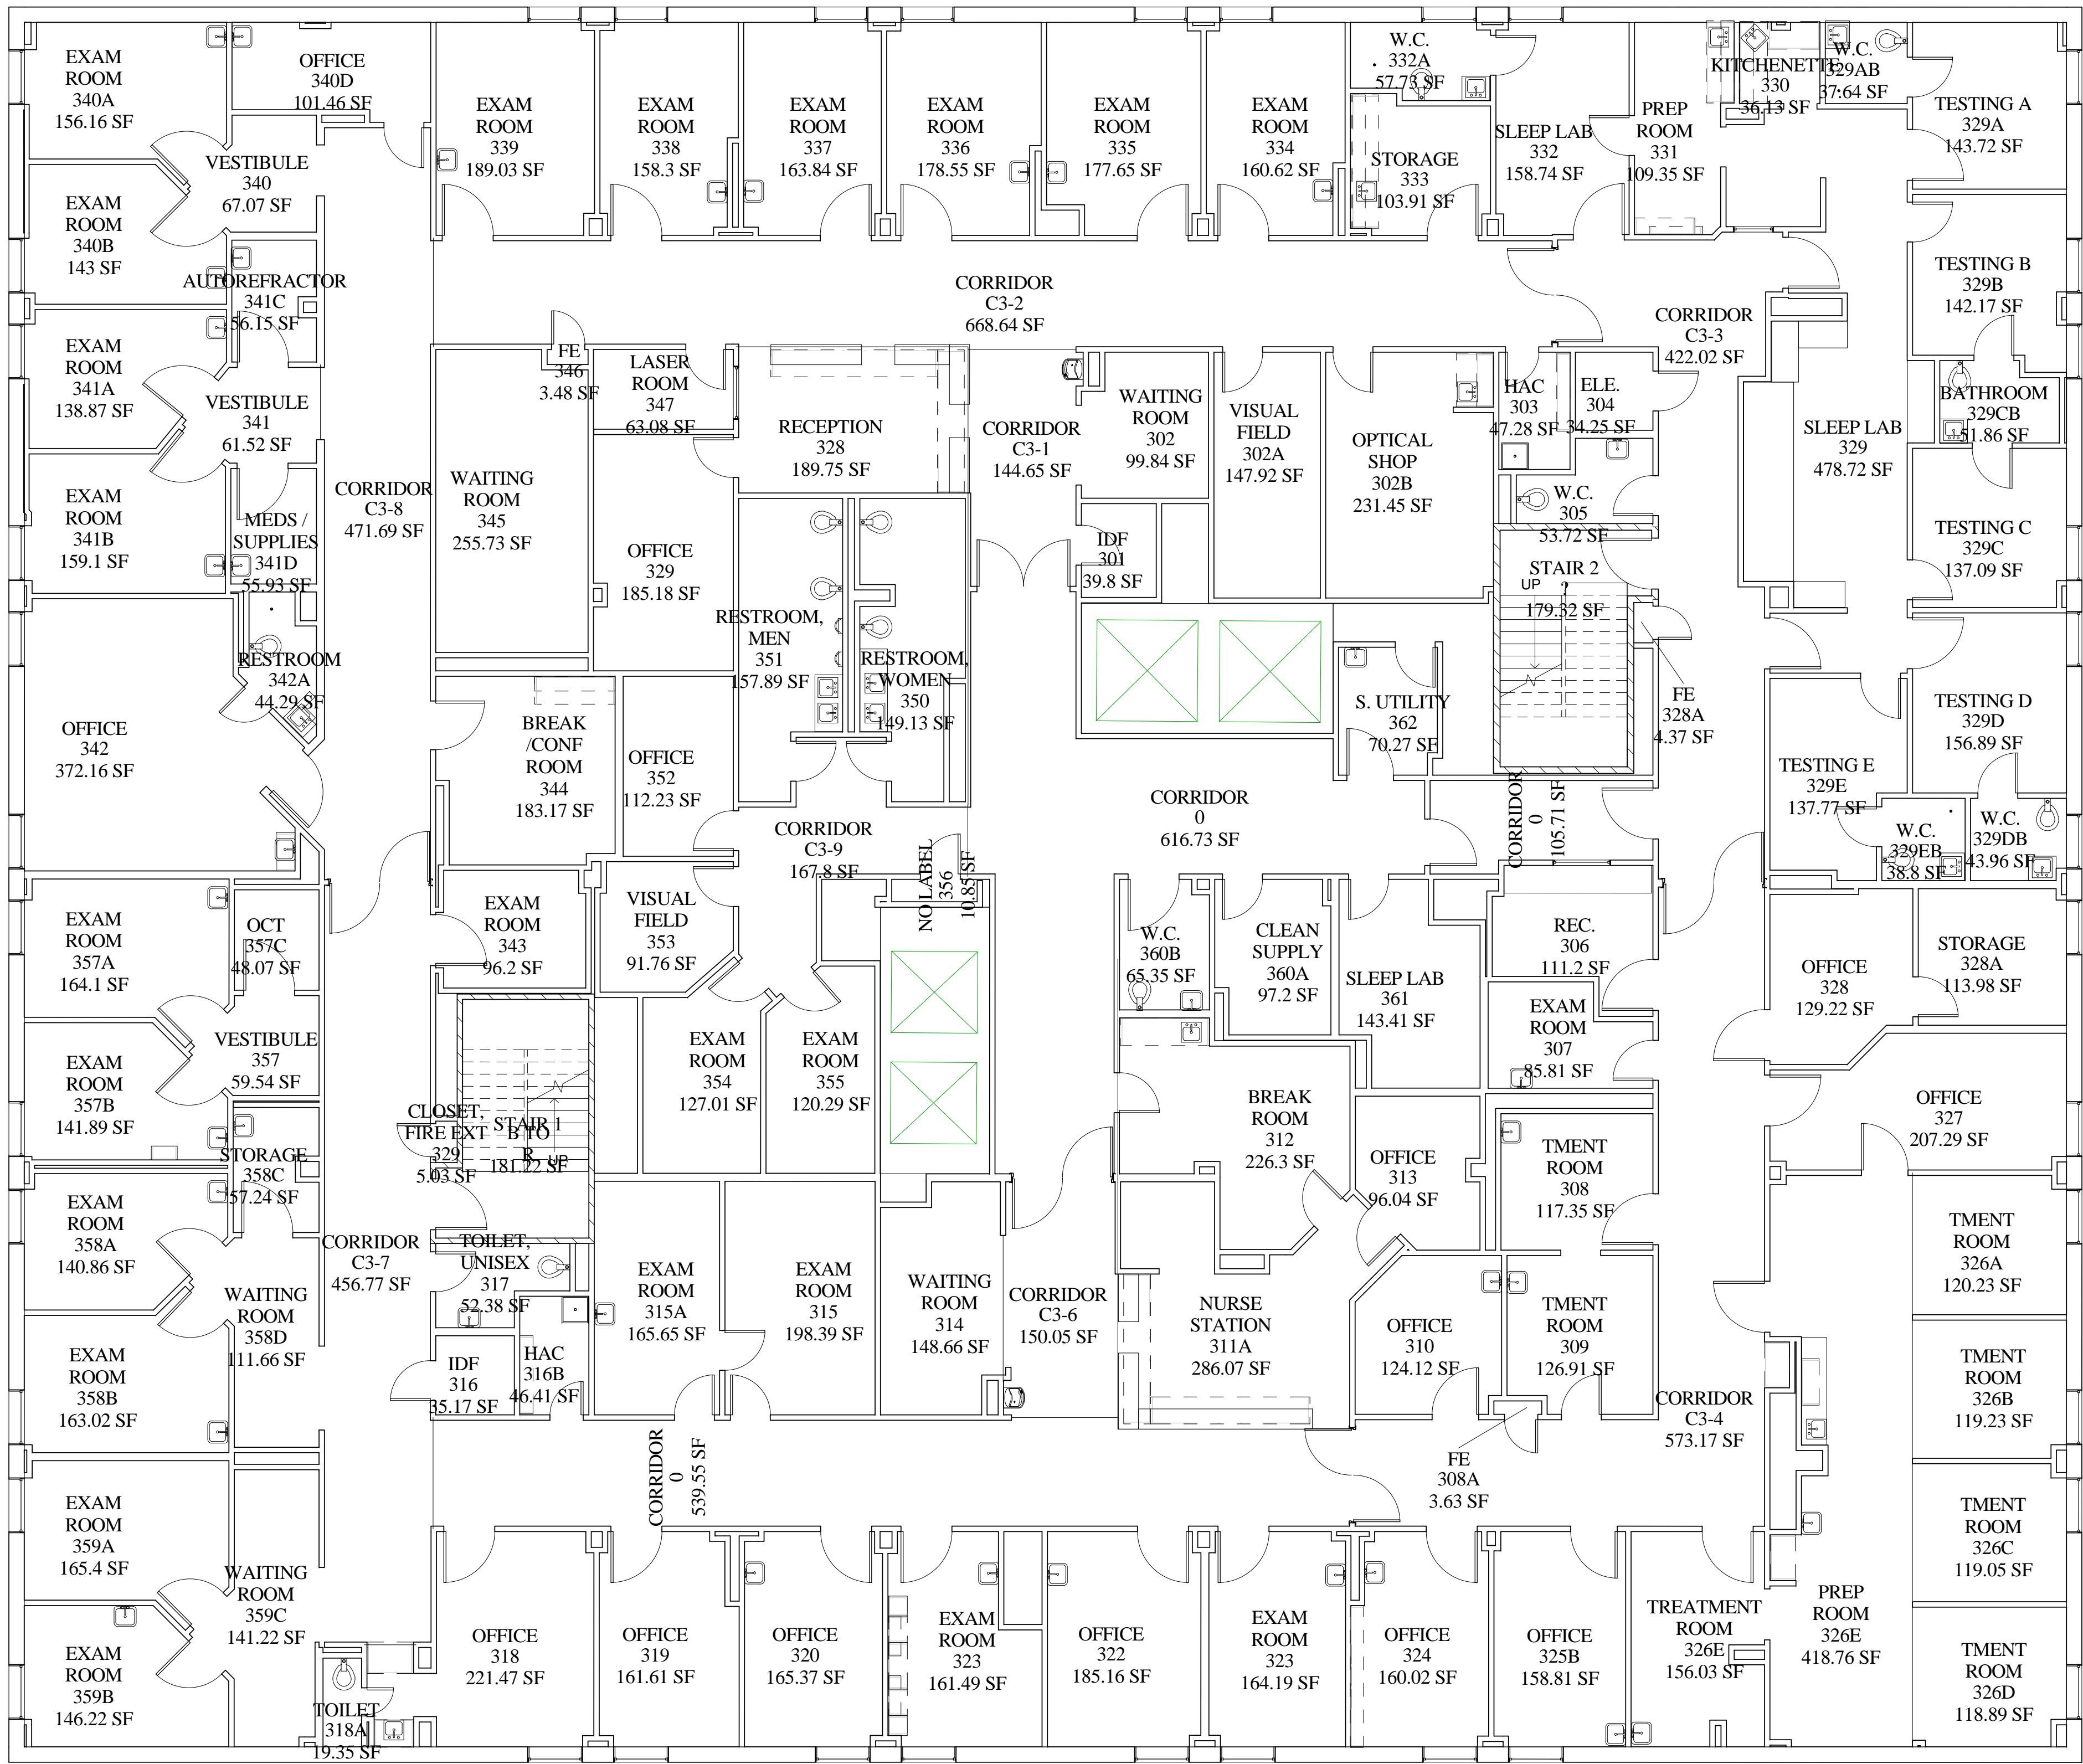[illegible]

ARCHITECT/ENGINEERS:


Office of
Construction
and Facilities
Management


Department of
Veterans Affairs

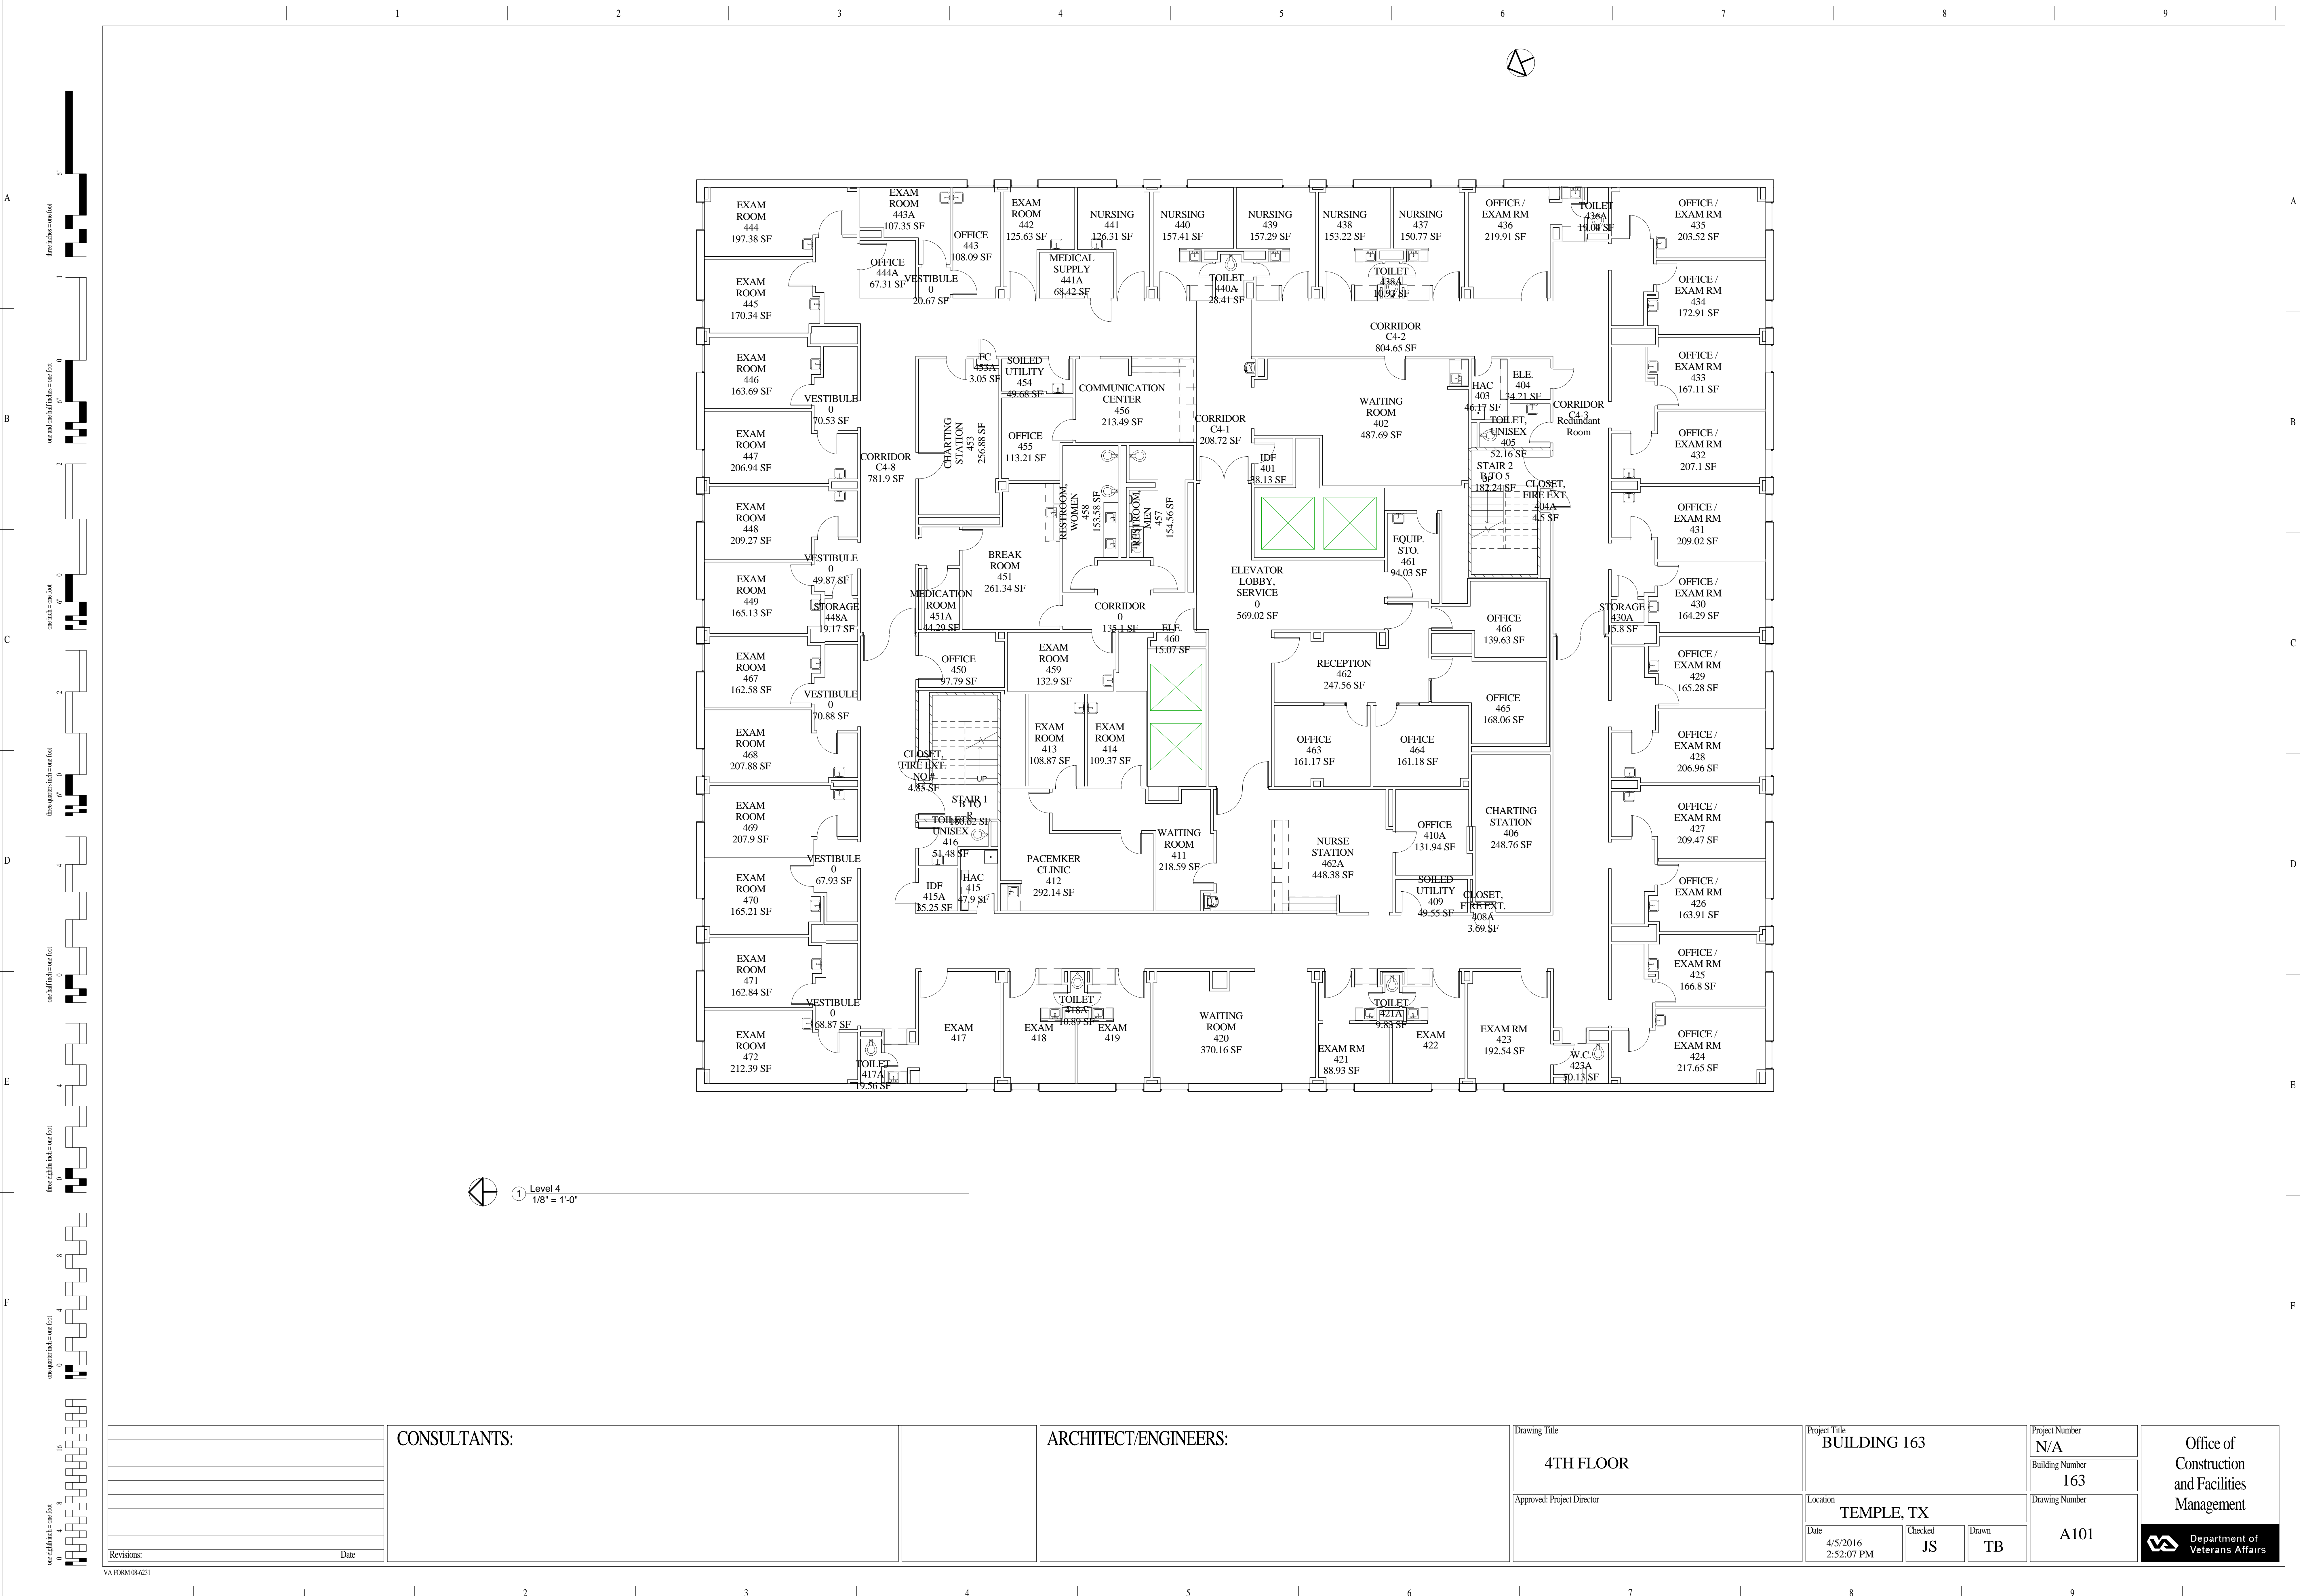




1 Level 5
A106 1/8" = 1'-0"


		CONSULTANTS:		ARCHITECT/ENGINEERS:		Drawing Title		Project Title		Project Number		Office of Construction and Facilities Management
						5TH FLOOR		BUILDING 163 FLOOR PLANS		N/A		
										Building Number 163		
										Drawing Number		
										A106		
Revisions:		Date						Date				 Department of Veterans Affairs

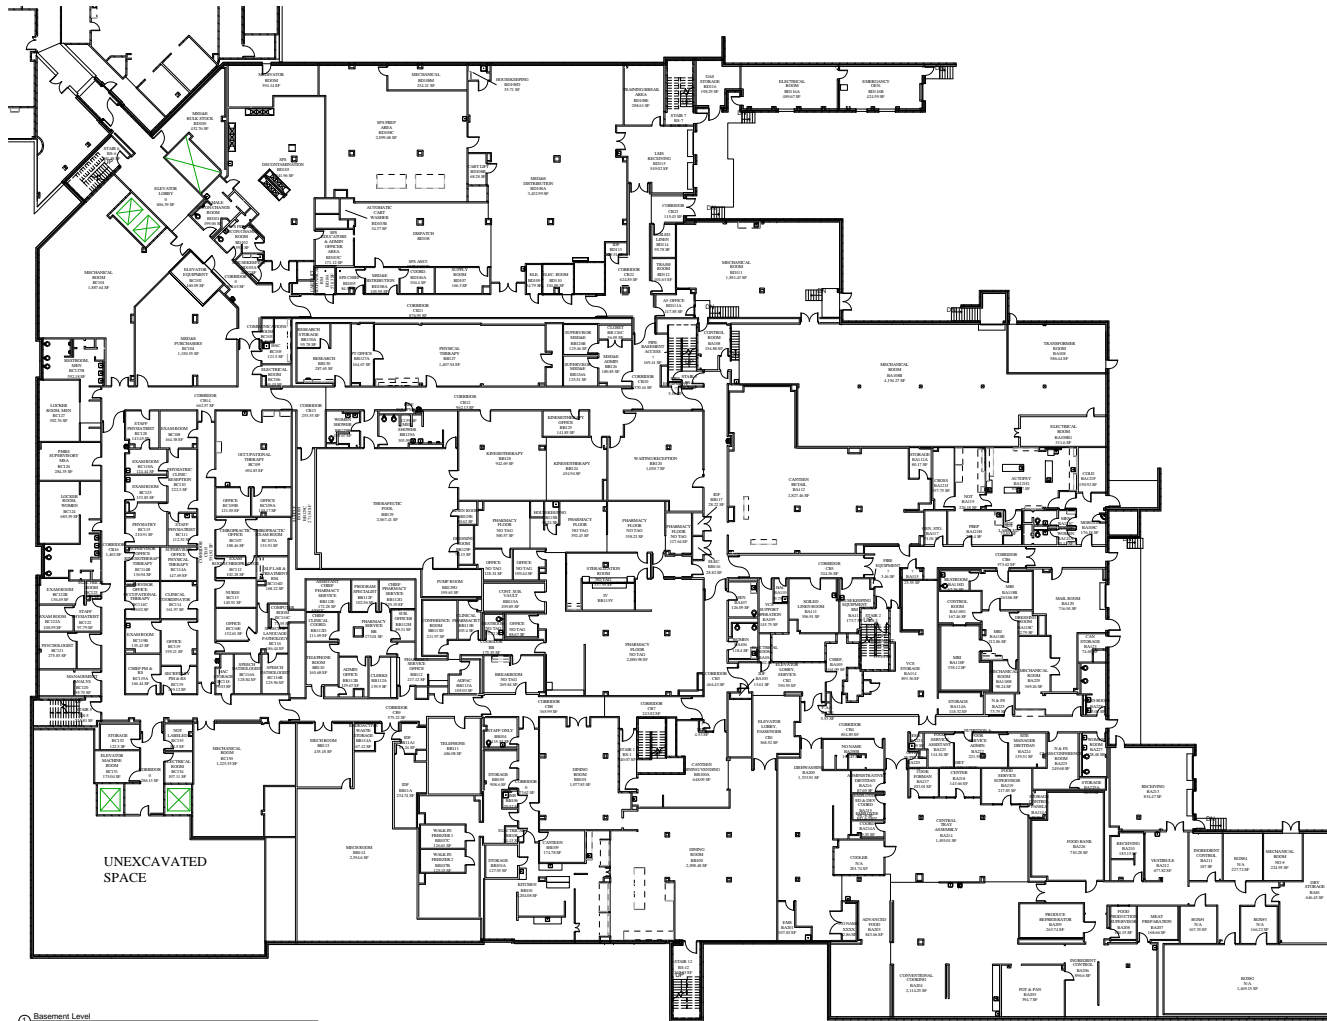

Basement Level
1/16" = 1'-0"

No color scheme assigned to view


		CONSULTANTS:		ARCHITECT/ENGINEERS:		Drawing Title		Project Title		Project Number		Office of Construction and Facilities Management
						BASEMENT	BUILDING 163 FLOOR PLAN		N/A			
							Building Number		163			
							Drawing Number		A100			
						Approved: Project Director		Location		TEMPLE, TX		
						Date		Checked		Drawn		
						7/14/2017 1:44:56 PM		JS		TB		
Revised:	Date											 Engineering Planning and Design

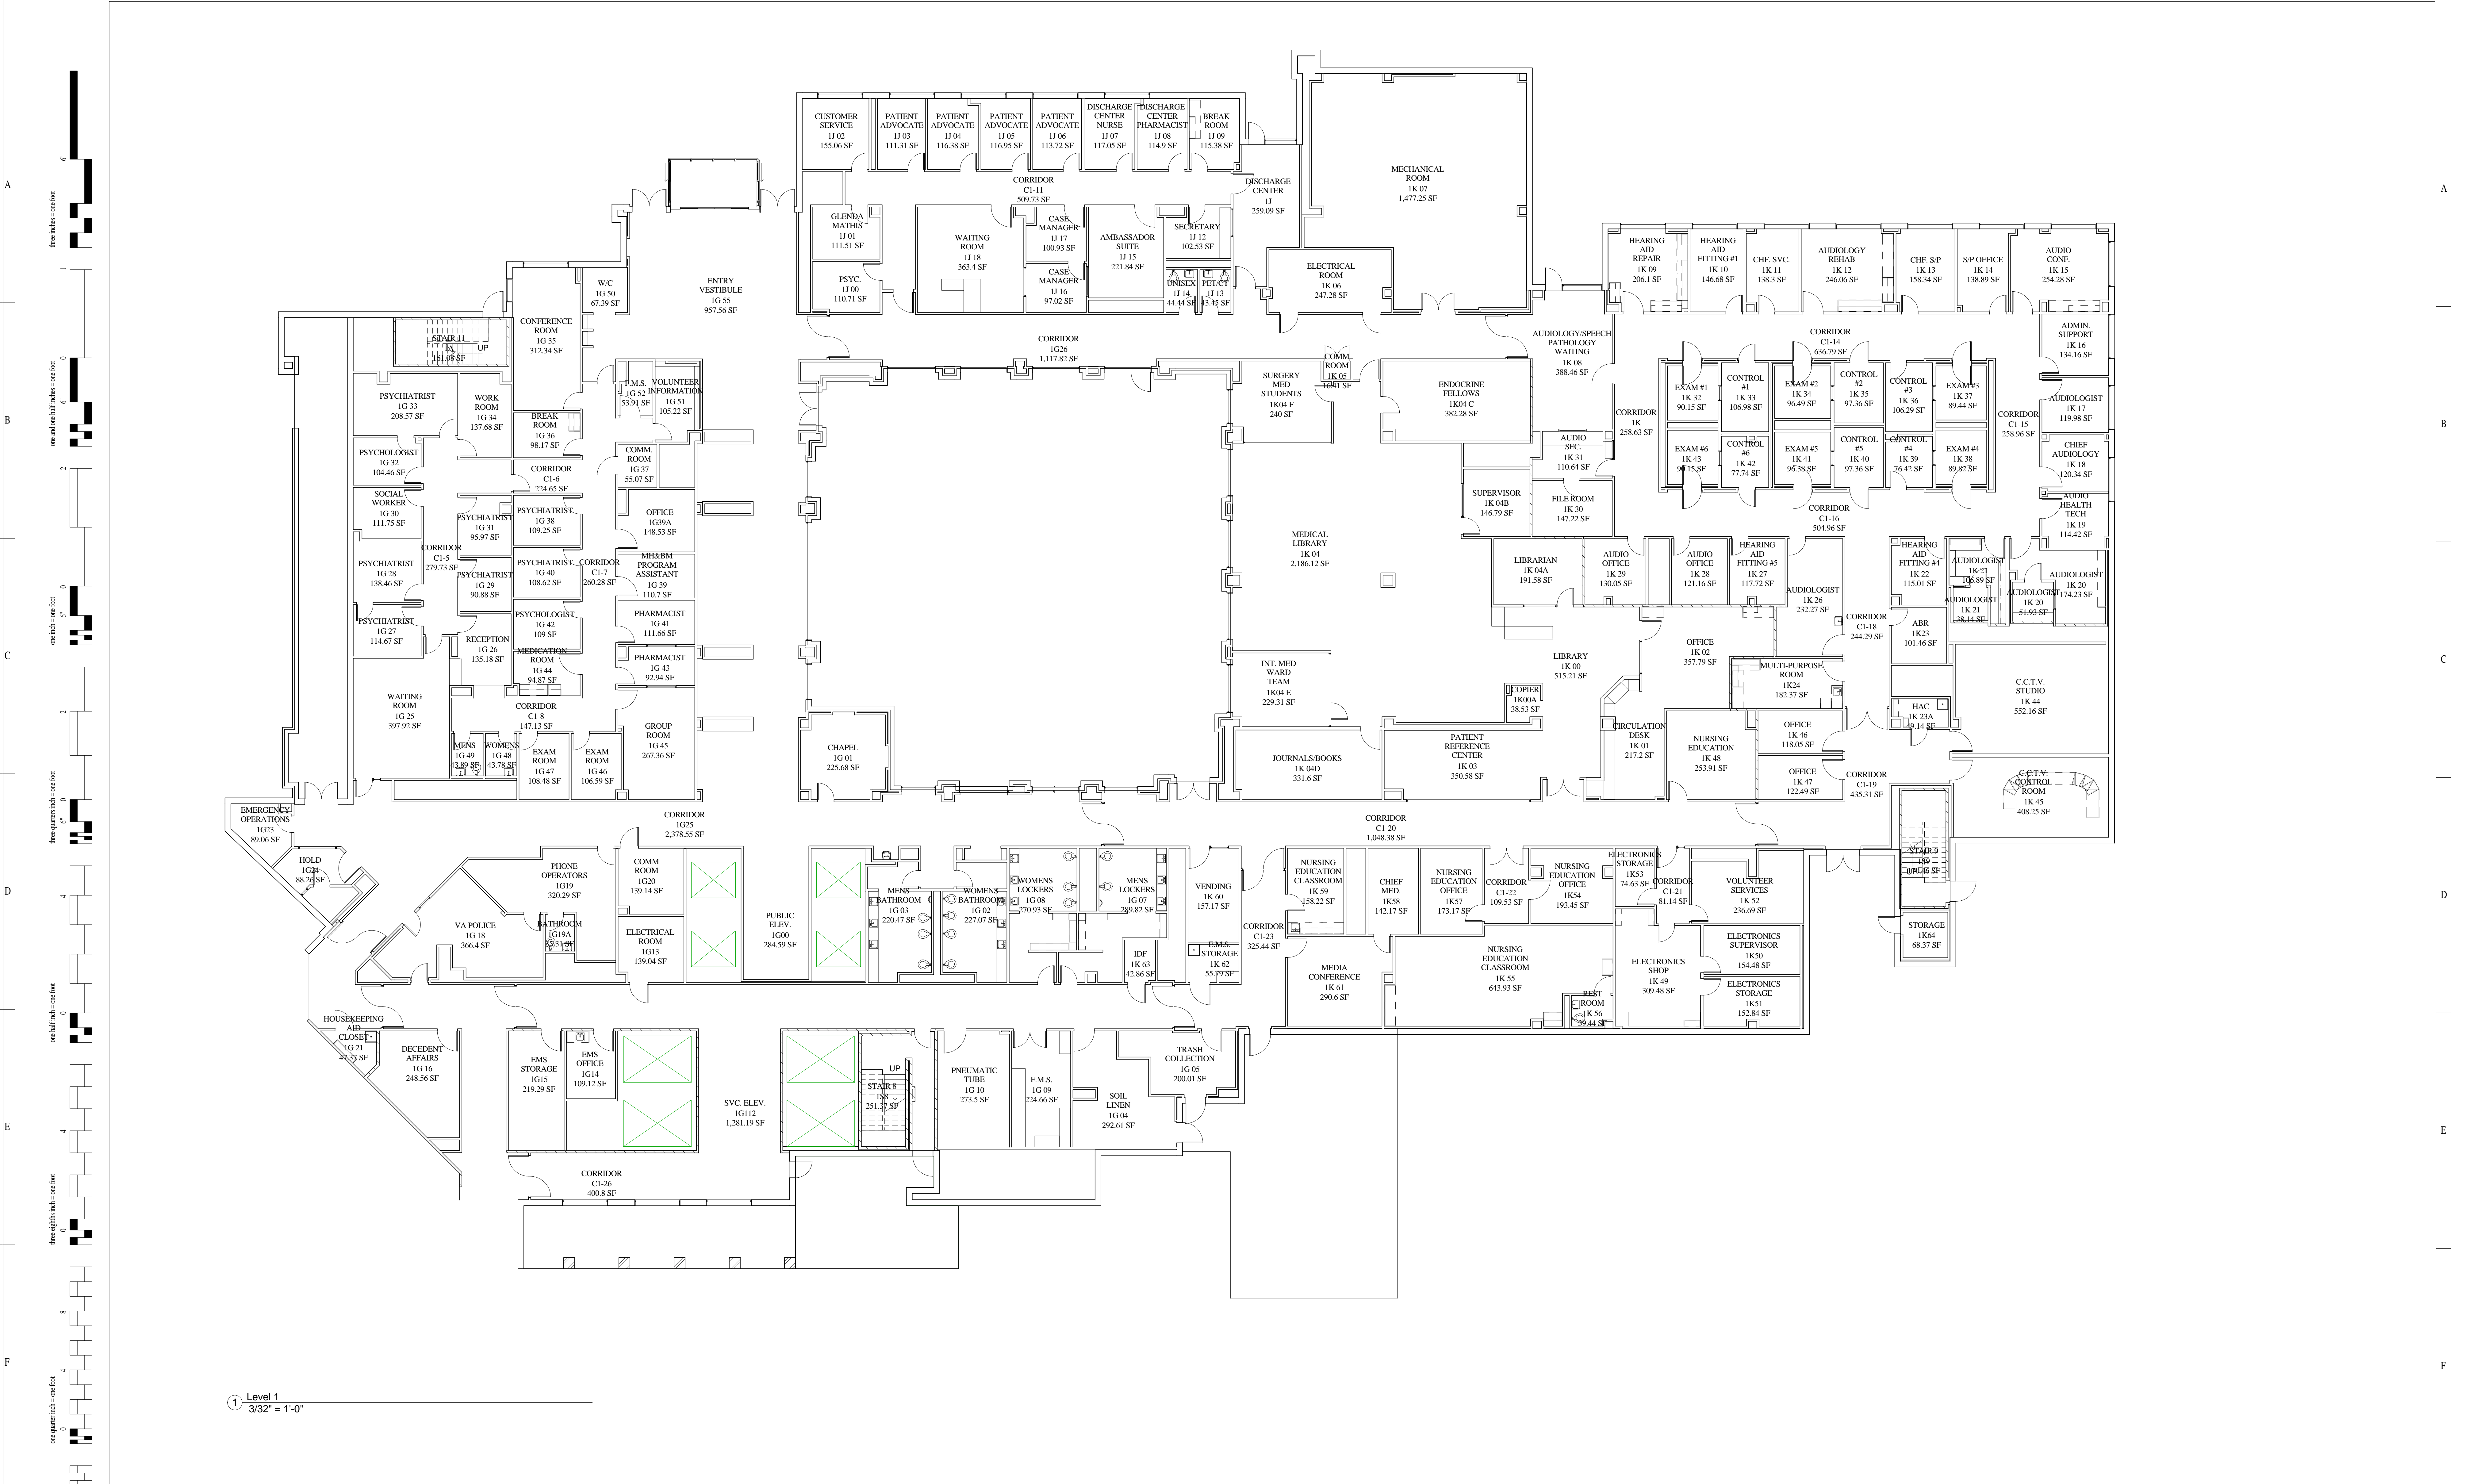

1 Level 1
3/32" = 1'-0"

		CONSULTANTS:		ARCHITECT/ENGINEERS:	Drawing Title	Project Title		Project Number		Office of Construction and Facilities Management
			FIRST FLOOR		BUILDING 204 FLOOR PLANS		Project Number			
						Building Number				
					Approved: Project Director	Location		Drawing Number		
Revisions:	Date					Date	Checked	Drawn		Department of Veterans Affairs
						9/29/2016 8:59:08 AM	TB	TB	A101	



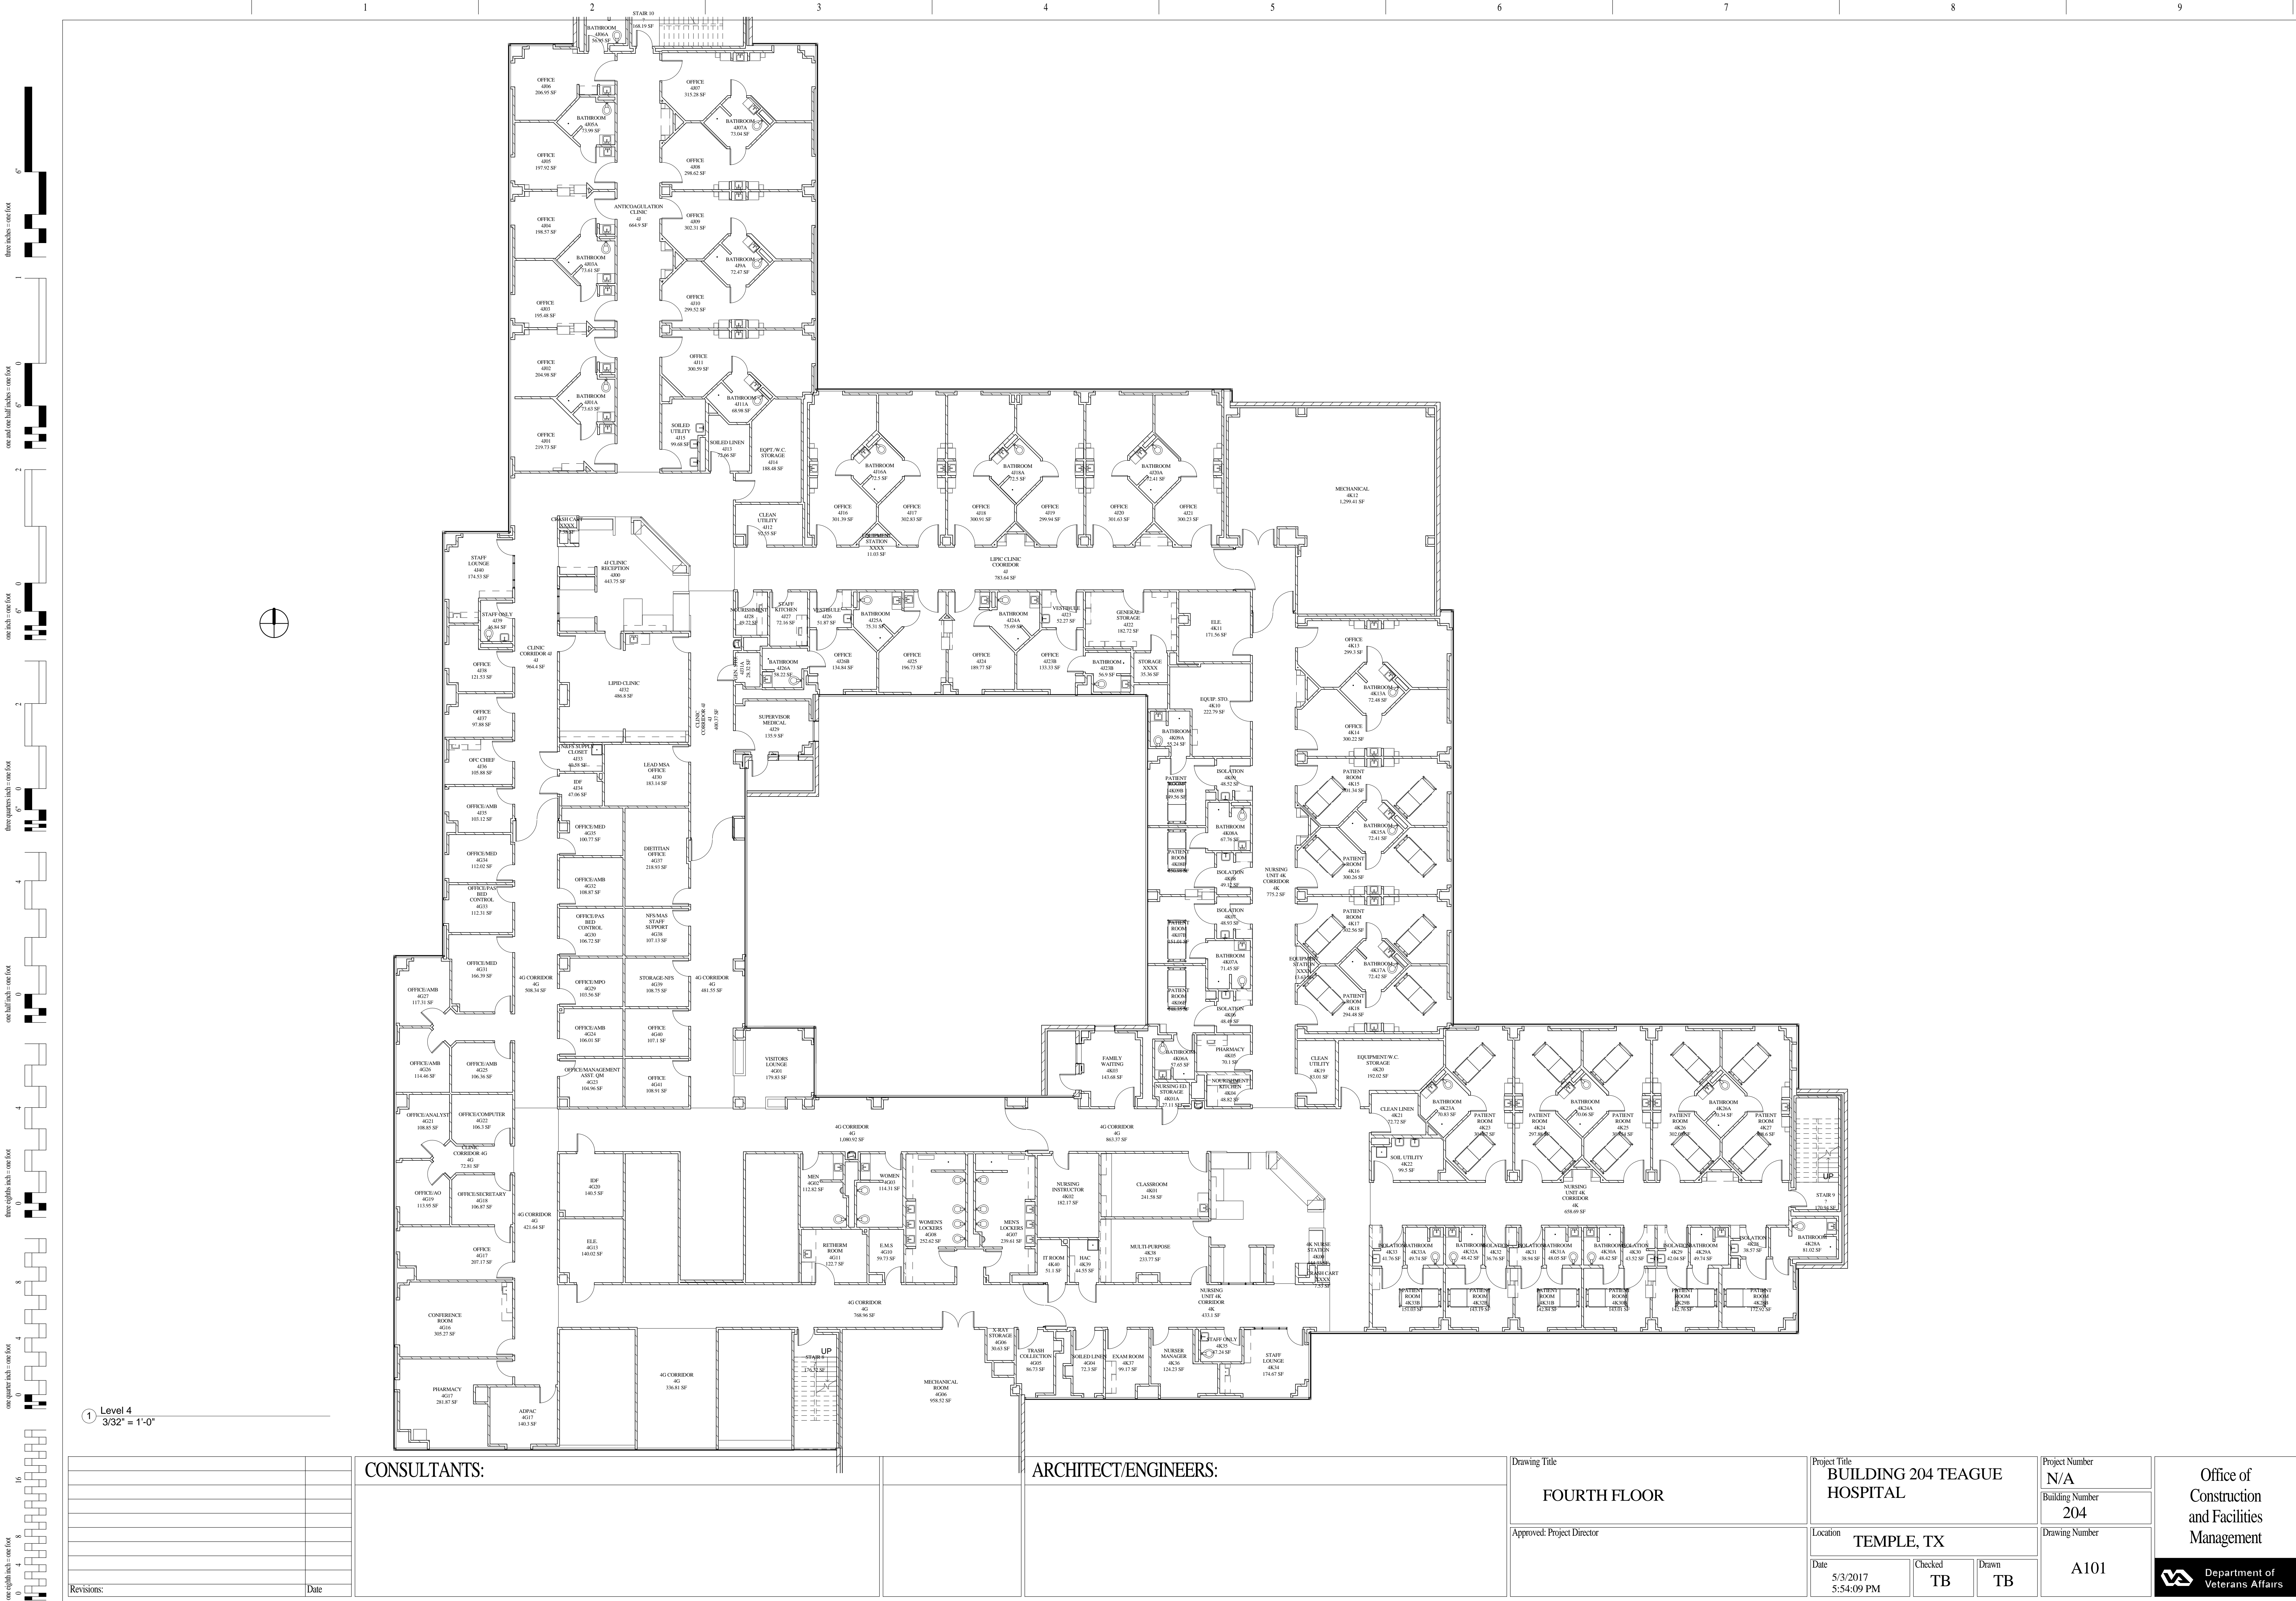

CONSULTANTS:

ARCHITECT/ENGINEERS:

FOURTH FLOOR

BUILDING 204 TEAGUE HOSPITAL

TEMPLE, TX


N/A

204

A101

Office of Construction and Facilities Management

Department of Veterans Affairs

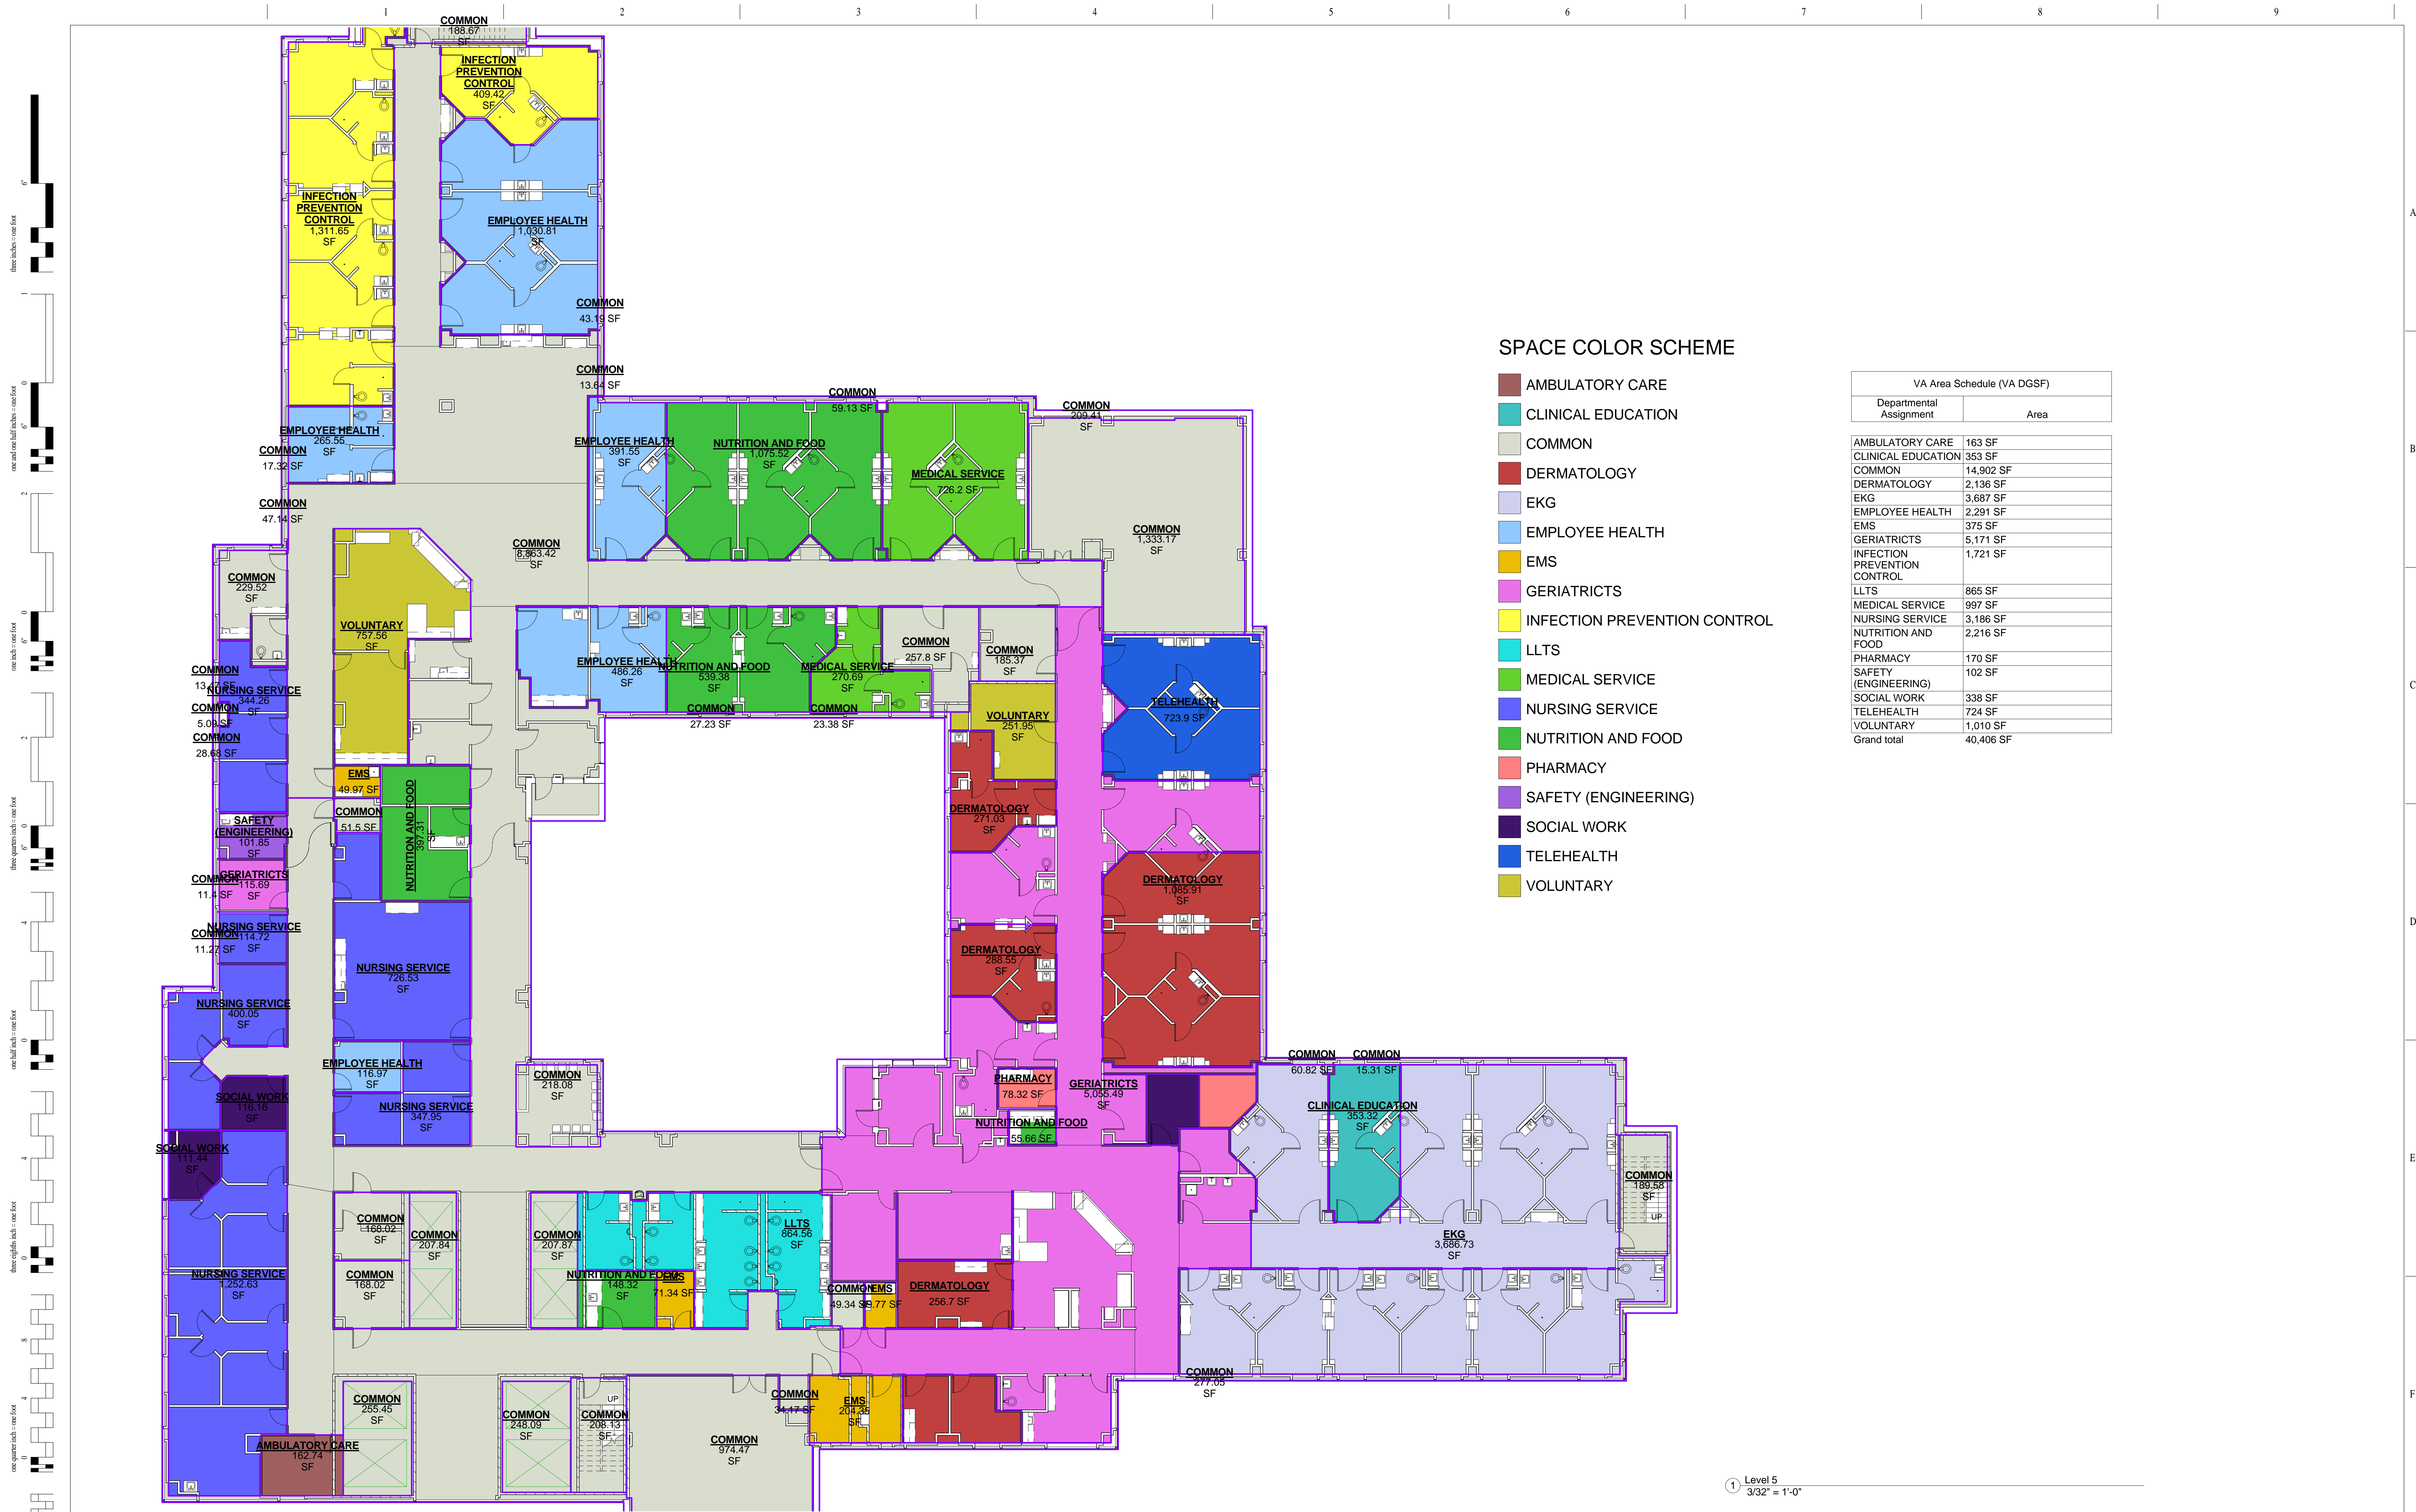


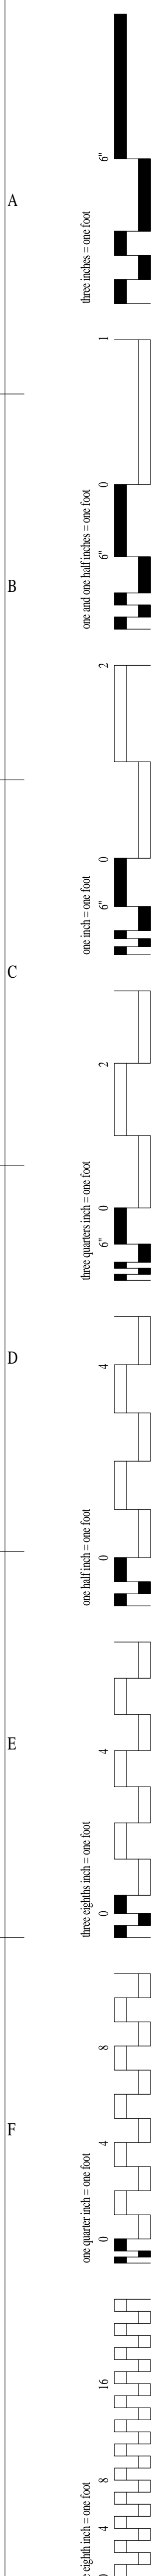
SPACE COLOR SCHEME

- AMBULATORY CARE
- CLINICAL EDUCATION
- COMMON
- DERMATOLOGY
- EKG
- EMPLOYEE HEALTH
- EMS
- GERIATRICS
- INFECTION PREVENTION CONTROL
- LLTS
- MEDICAL SERVICE
- NURSING SERVICE
- NUTRITION AND FOOD
- PHARMACY
- SAFETY (ENGINEERING)
- SOCIAL WORK
- TELEHEALTH
- VOLUNTARY

VA Area Schedule (VA DGSF)	
Departmental Assignment	Area
AMBULATORY CARE	163 SF
CLINICAL EDUCATION	353 SF
COMMON	14,902 SF
DERMATOLOGY	2,136 SF
EKG	3,687 SF
EMPLOYEE HEALTH	2,291 SF
EMS	375 SF
GERIATRICS	5,171 SF
INFECTION PREVENTION CONTROL	1,721 SF
LLTS	865 SF
MEDICAL SERVICE	997 SF
NURSING SERVICE	3,186 SF
NUTRITION AND FOOD	2,216 SF
PHARMACY	170 SF
SAFETY (ENGINEERING)	102 SF
SOCIAL WORK	338 SF
TELEHEALTH	724 SF
VOLUNTARY	1,010 SF
Grand total	40,406 SF

① Level 5
 $3/32'' = 1'-0''$

		CONSULTANTS:		ARCHITECT/ENGINEERS:	Drawing Title	Project Title		Project Number	Office of Construction and Facilities Management
					5TH FLOOR - AREA	BUILDING 204 TEAGUE HOSPITAL		N/A	
								Building Number	
								204	
					Approved: Project Director	Location		Drawing Number	
						TEMPLE, TX		A102	
						Date	Checked		Drawn
Revisions:	Date		4/10/2017 2:31:26 PM	TB	TB				
								 Department of Veterans Affairs	

[illegible]

CONSULTANTS:

ARCHITECT/ENGINEERS:

SIXTH FLOOR

Approved: Project Director

Project Title	6TH FLOOR
---------------	-----------

Location	TEMPLE, TX
----------	------------

Date
9/29/2016
9:08:13 AM

Checked	T
---------	---

Drawn
TE

Project Number	XXX-XX-XXXX
Building Number	204
Drawing Number	

A101

Office of
Construction
and Facilities
Management



