




BLDG 68 EMERGENCY GENERATOR
SCALE: 1/8" = 1'-0"

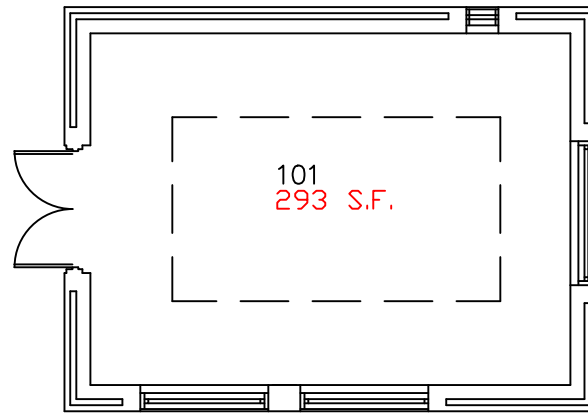


BLDG 69 EMERGENCY GENERATOR
SCALE: 1/8" = 1'-0"

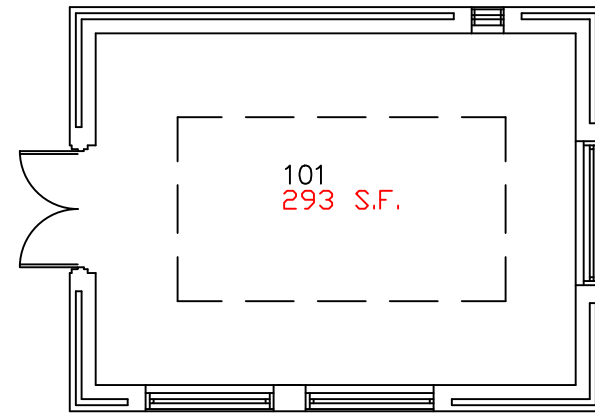


BLDG 70 EMERGENCY GENERATOR
SCALE: 1/8" = 1'-0"

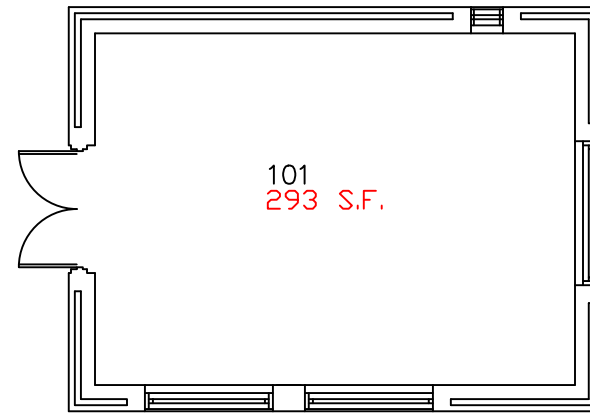


BLDG 71 SWITCHGEAR BUILDING
SCALE: 1/8" = 1'-0"

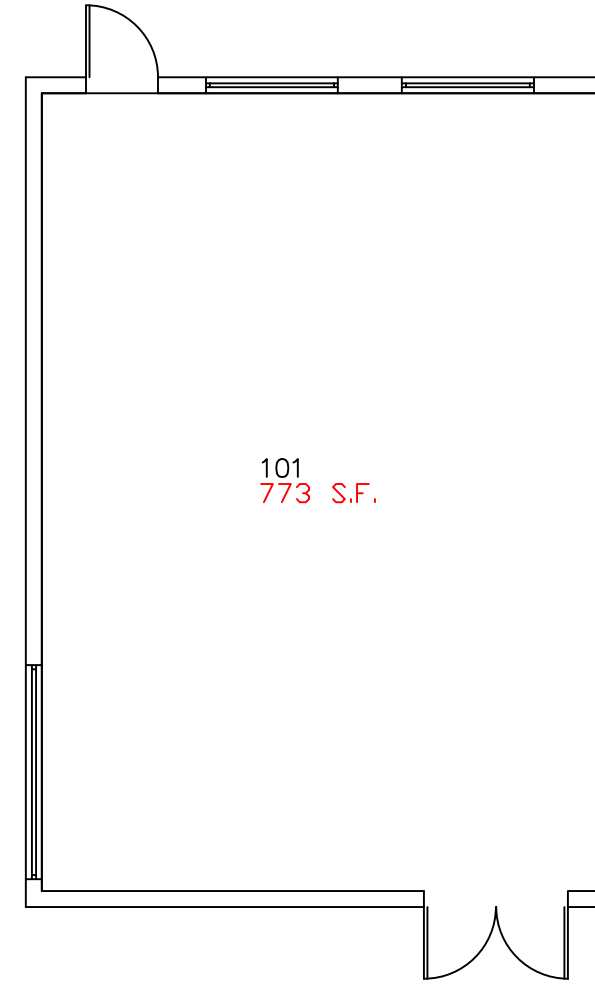


BLDG 67 EMERGENCY GENERATOR
SCALE: 1/8" = 1'-0"

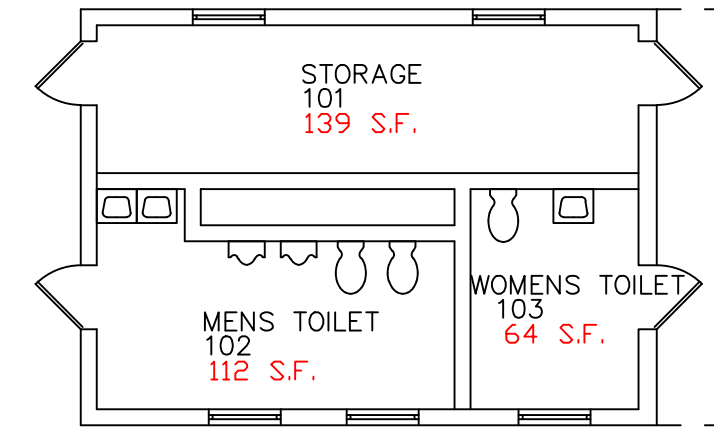

BLDG 64 RESTROOMS
SCALE: 1/8" = 1'-0"

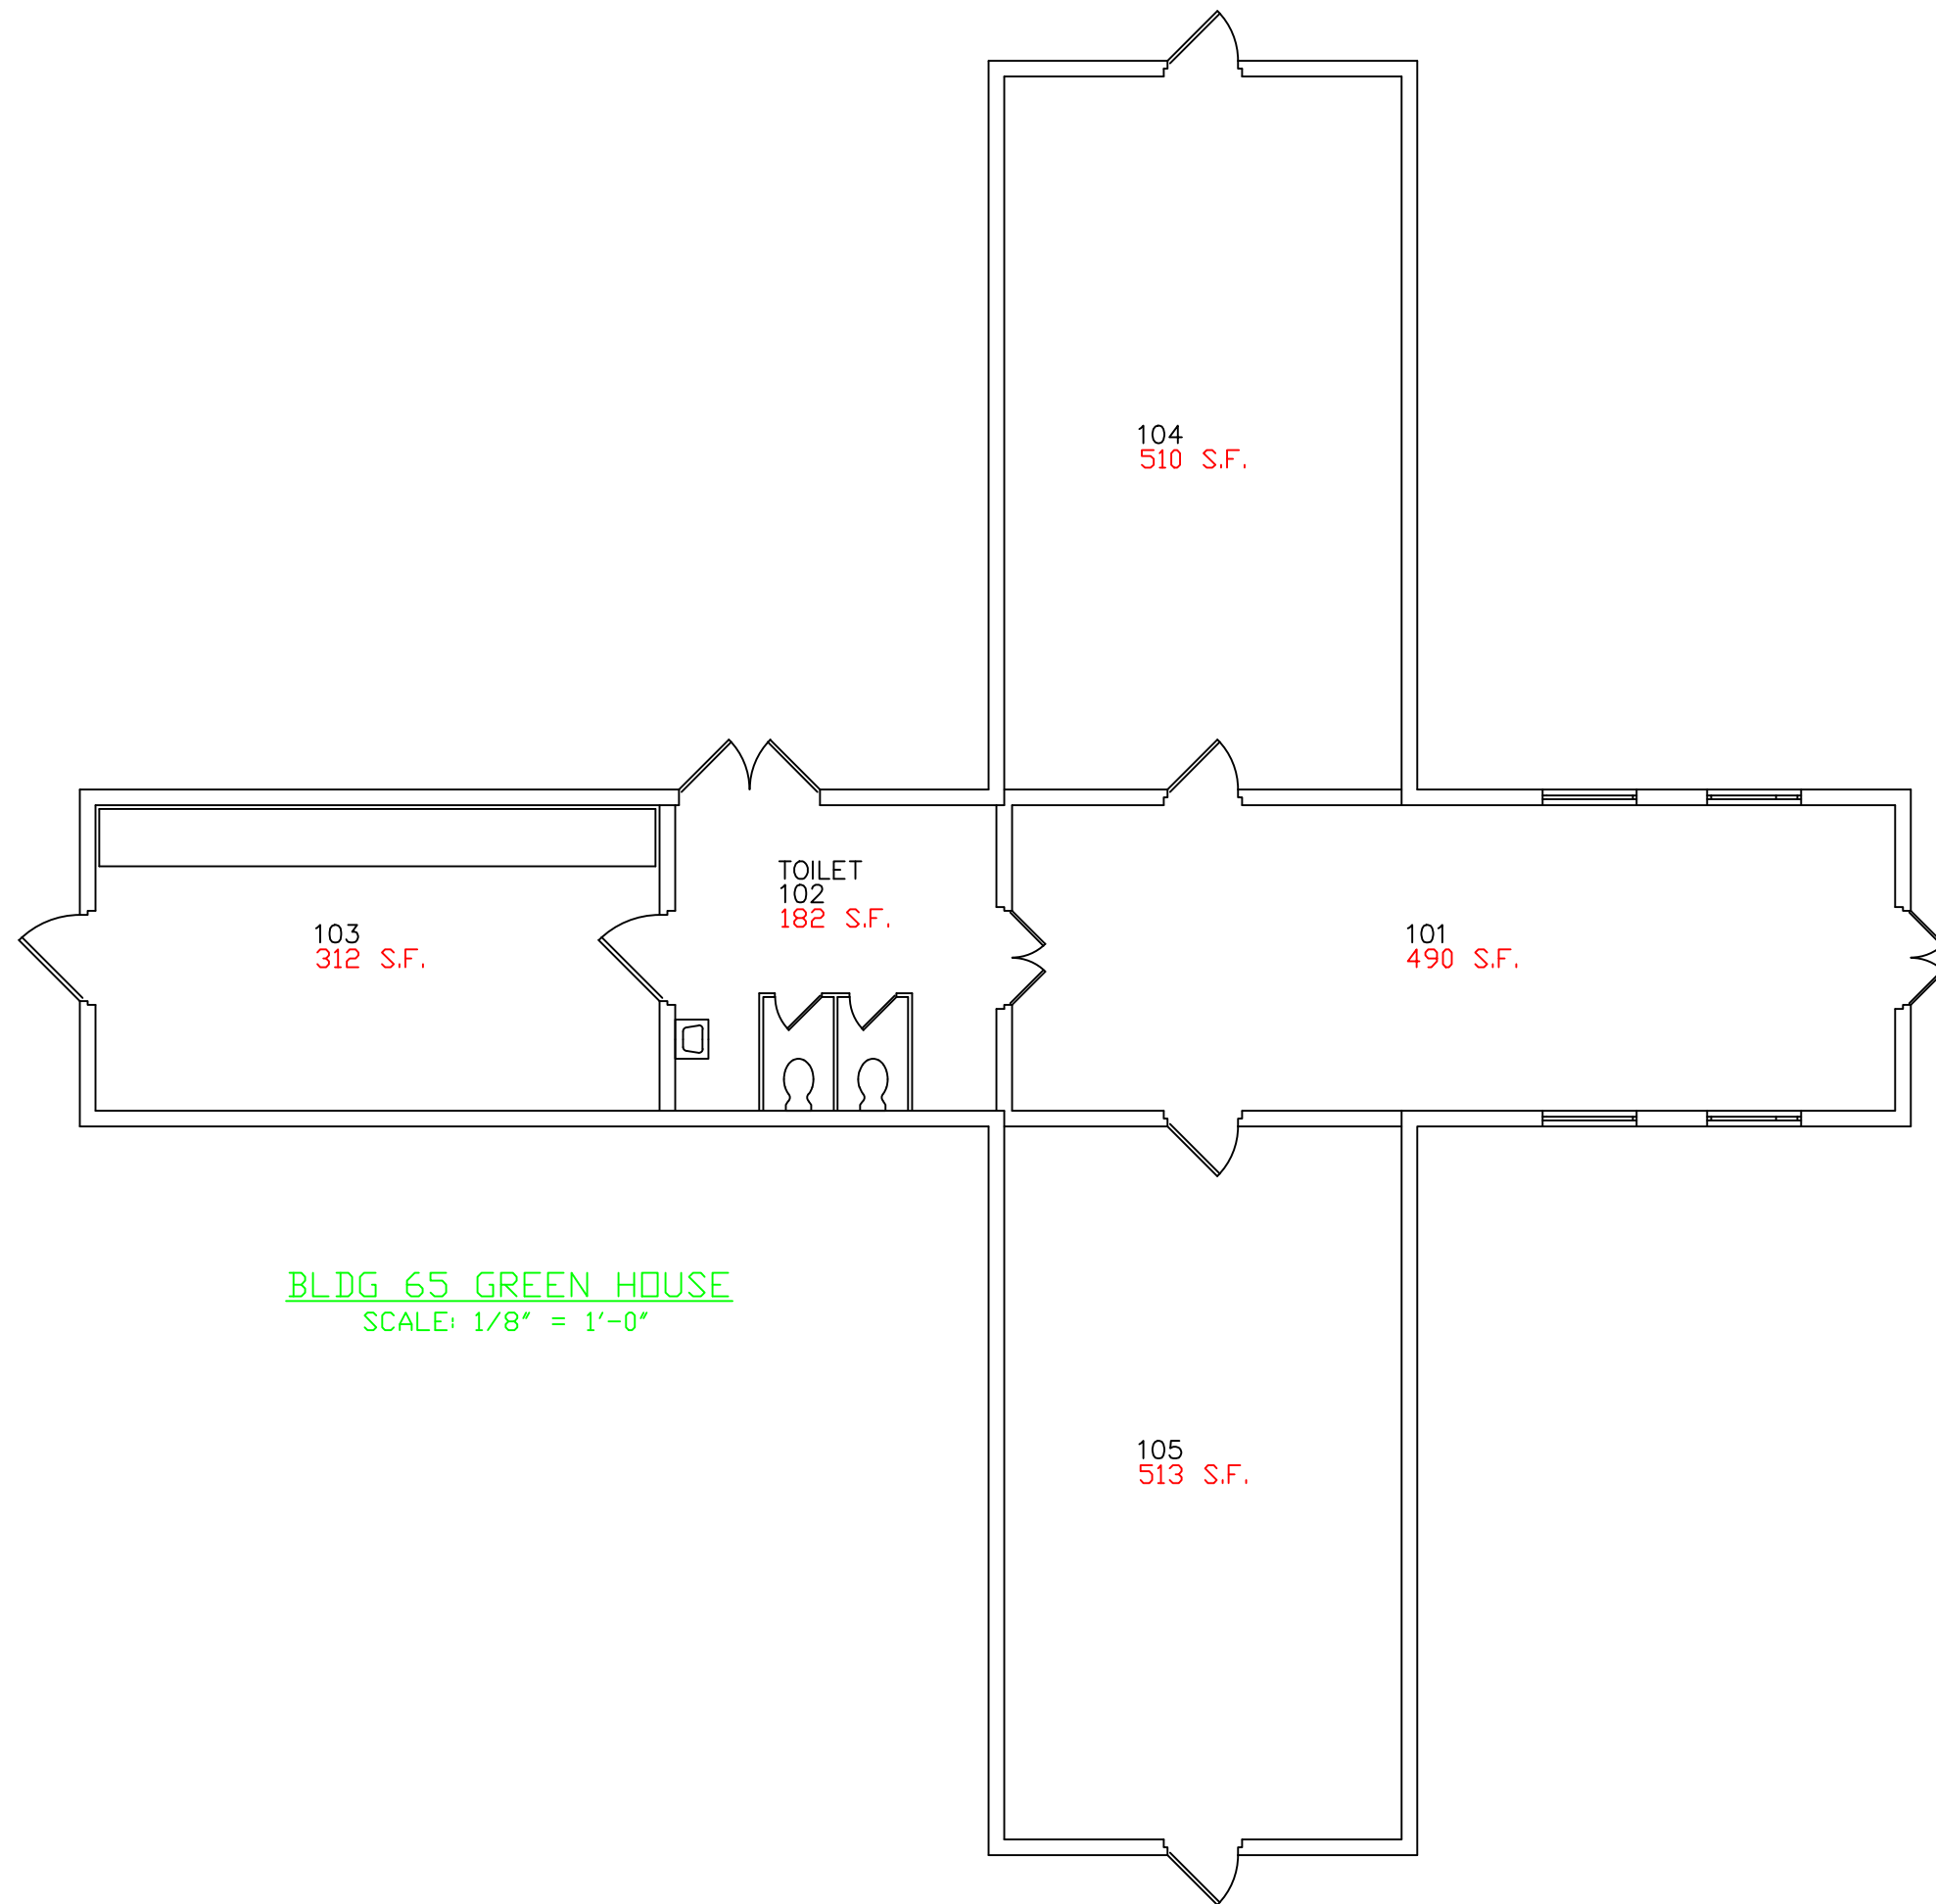

BLDG 65 GREEN HOUSE
SCALE: 1/8" = 1'-0"

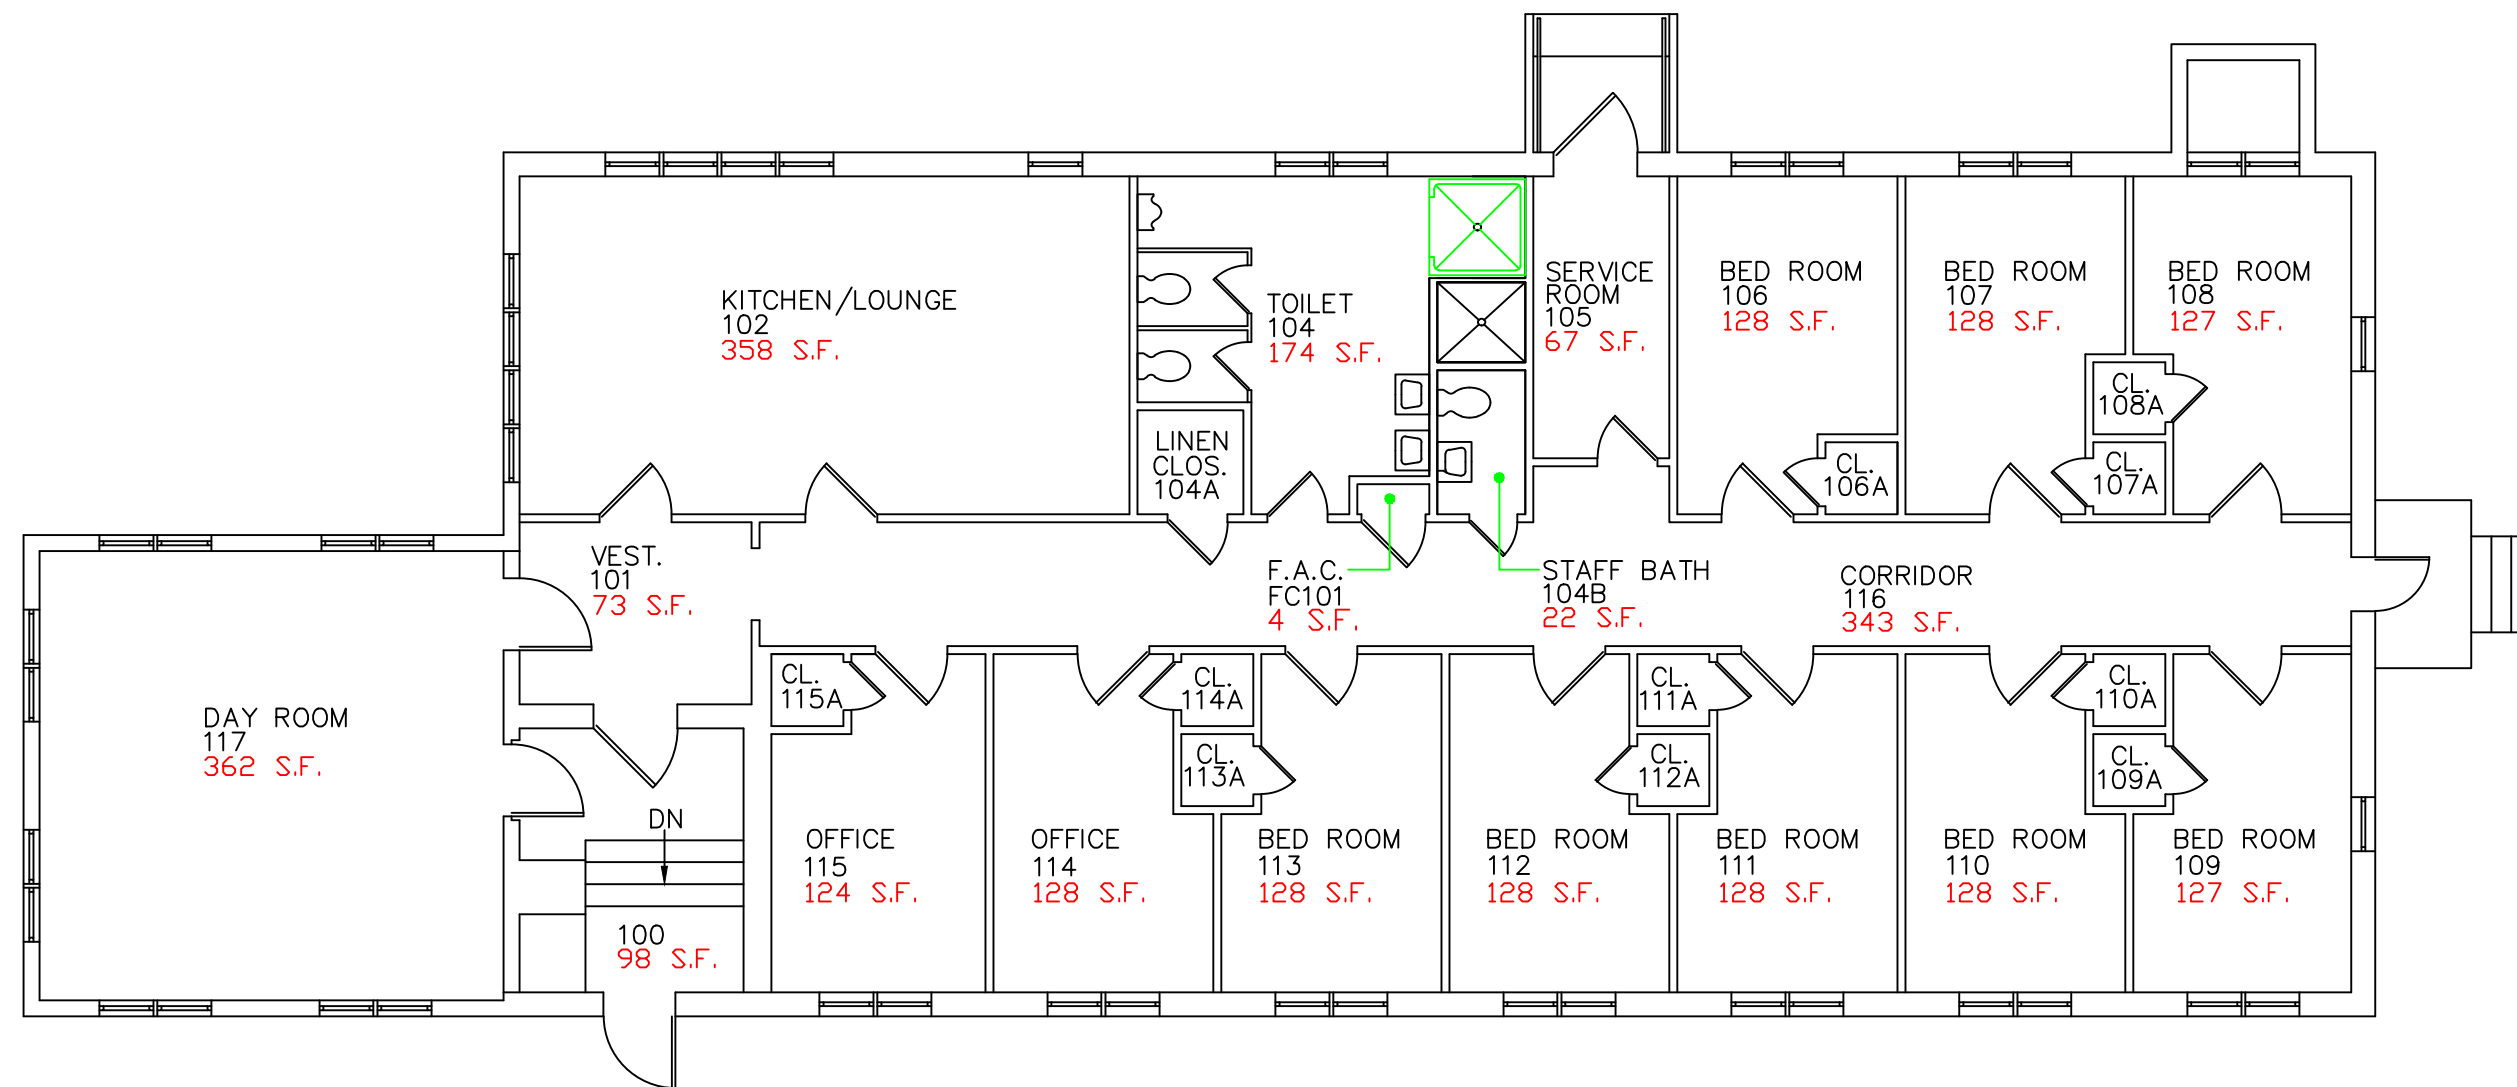

BLDG 62 1ST FLOOR PLAN
SCALE: 1/8" = 1'-0"

Project Title FLOOR PLANS ARCHITECTURAL AS-BUILT			Date 8-24-17		Department of Veterans Affairs VA	
			Project No.			
Building Number 62,64,65 67-71			Checked RSH	Drawn PL		Drawing No.
Location VABHS, BROCKTON MASS.						