



BLDG 61 SECOND FLOOR PLAN
SCALE: 1/16" = 1'-0"

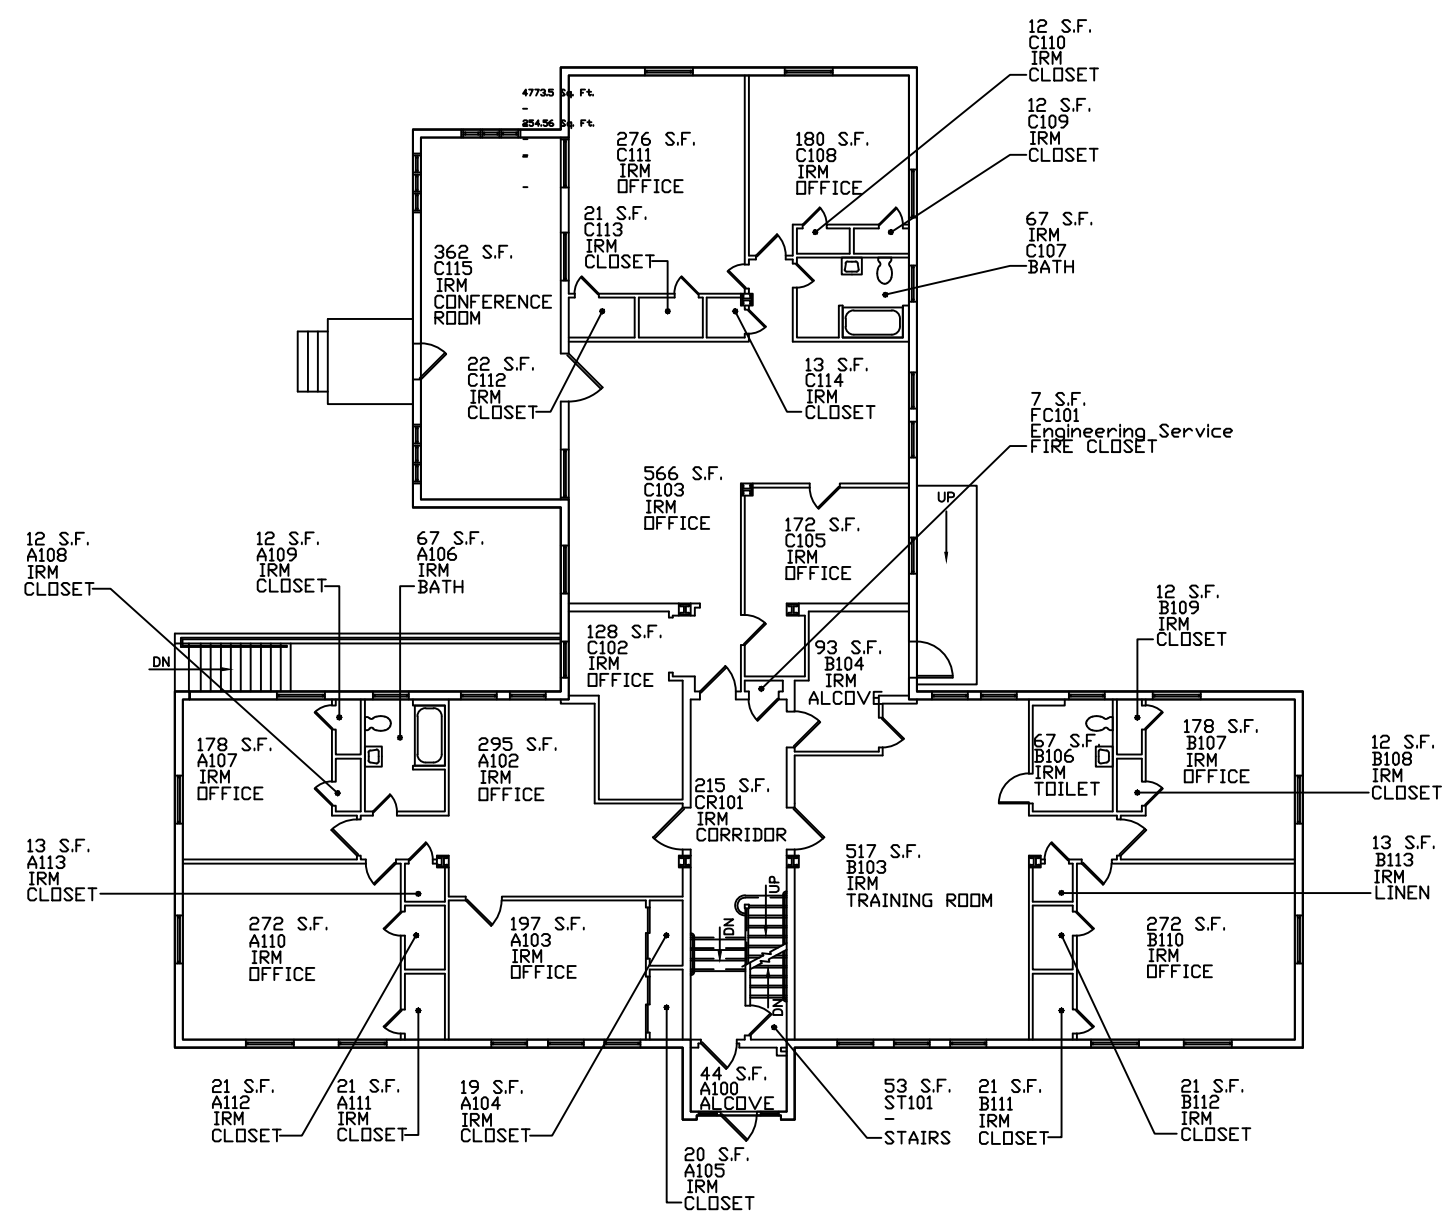

BLDG 61 FIRST FLOOR PLAN
SCALE: 1/16" = 1'-0"

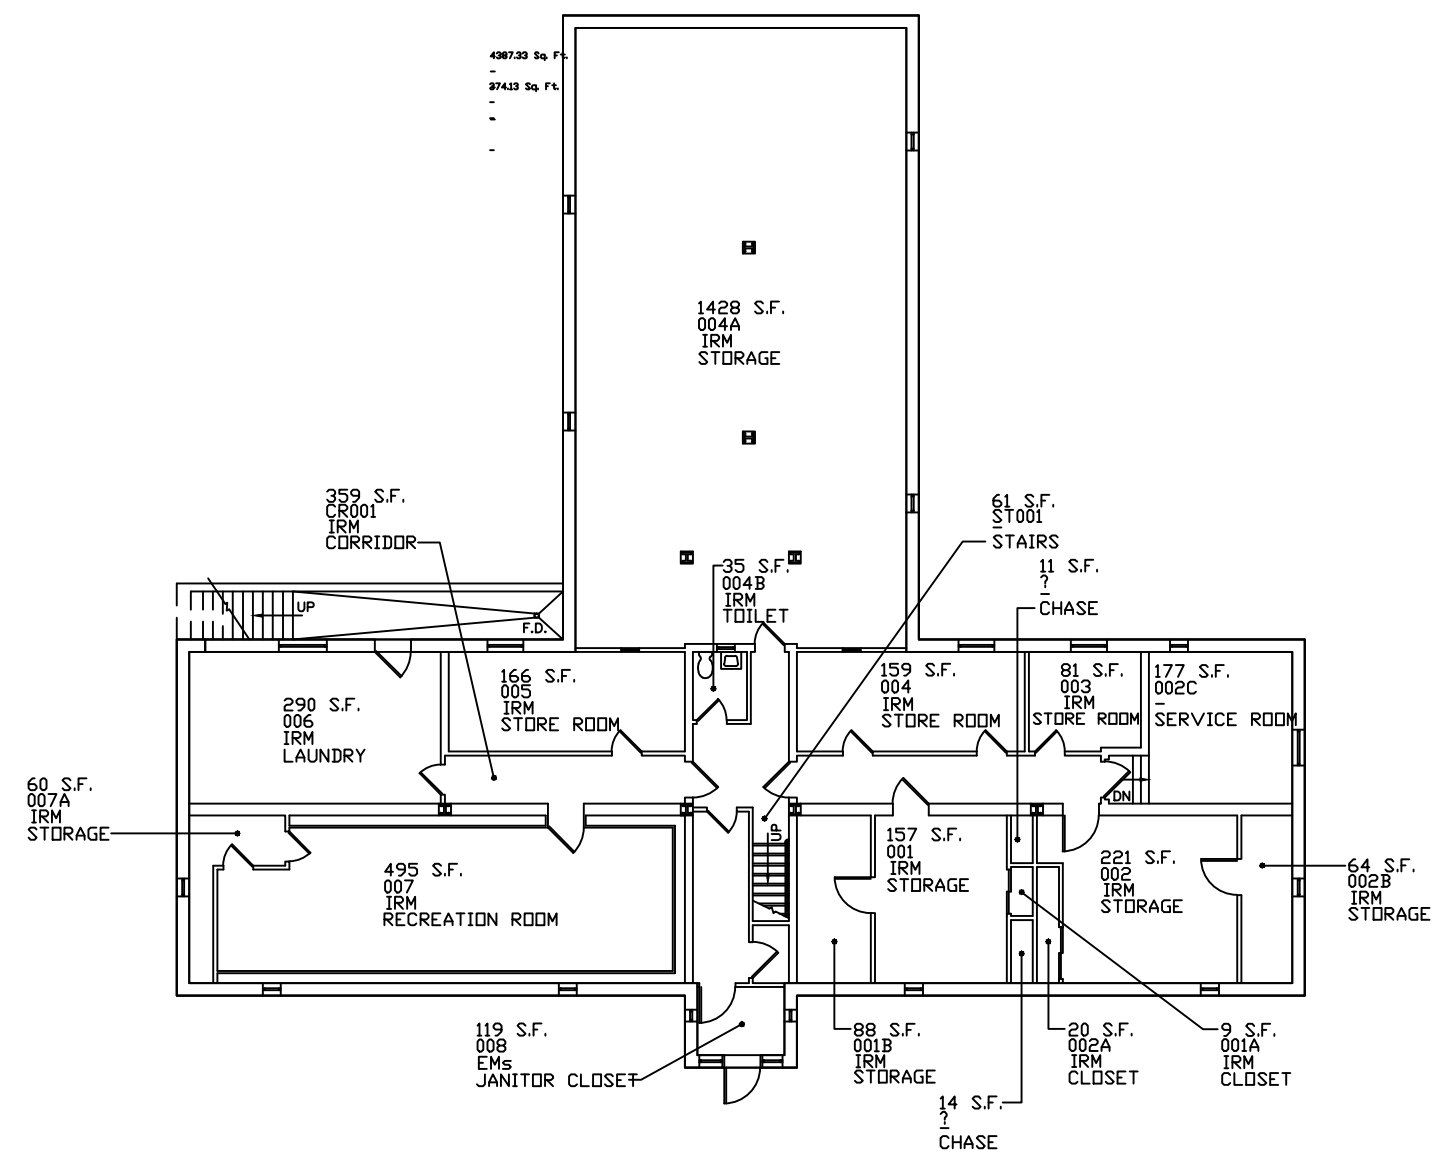

BLDG 61 BASEMENT FLOOR PLAN
SCALE: 1/16" = 1'-0"

LEGEND
IRM = Information Resource Management
EMS = Environmental Management service

Project Title FLOOR PLANS ARCHITECTURAL AS-BUILT			Date 10-7-15
Building Number 61			Project No.
Location VABHS, BROCKTON MASS.			Drawing No.
Checked PL	Drawn RSH		

Department of
Veterans Affairs
VA