


3D/INTERNATIONAL AND STONE, MARRACCINI AND PATTERSON 3D/I • SMP A JOINT VENTURE HOUSTON, TEXAS 1900 WEST LOOP SOUTH SUITE 200 HOUSTON, TEXAS 77027 TELEPHONE (713) 871-7000 STRUCTURAL AND CIVIL MECHANICAL AND ELECTRICAL WALTER P. MOORE AND ASSOCIATES, INCORPORATED PANEL & MILLER, INC. AND 3D/INTERNATIONAL		PHASE IV Drawing Title POWER PLAN BASEMENT		REPLACEMENT / MODERNIZATION MEDICAL CENTER		Date 11 FEB 87		Project No. 580-040		Drawing No. 211-E5		VAMC HOUSTON, TEXAS	
Approved Project Director		Building Number 211		Checked MH		Drawn VS		Location VAMC HOUSTON, TEXAS		Date 5 OCT 87			




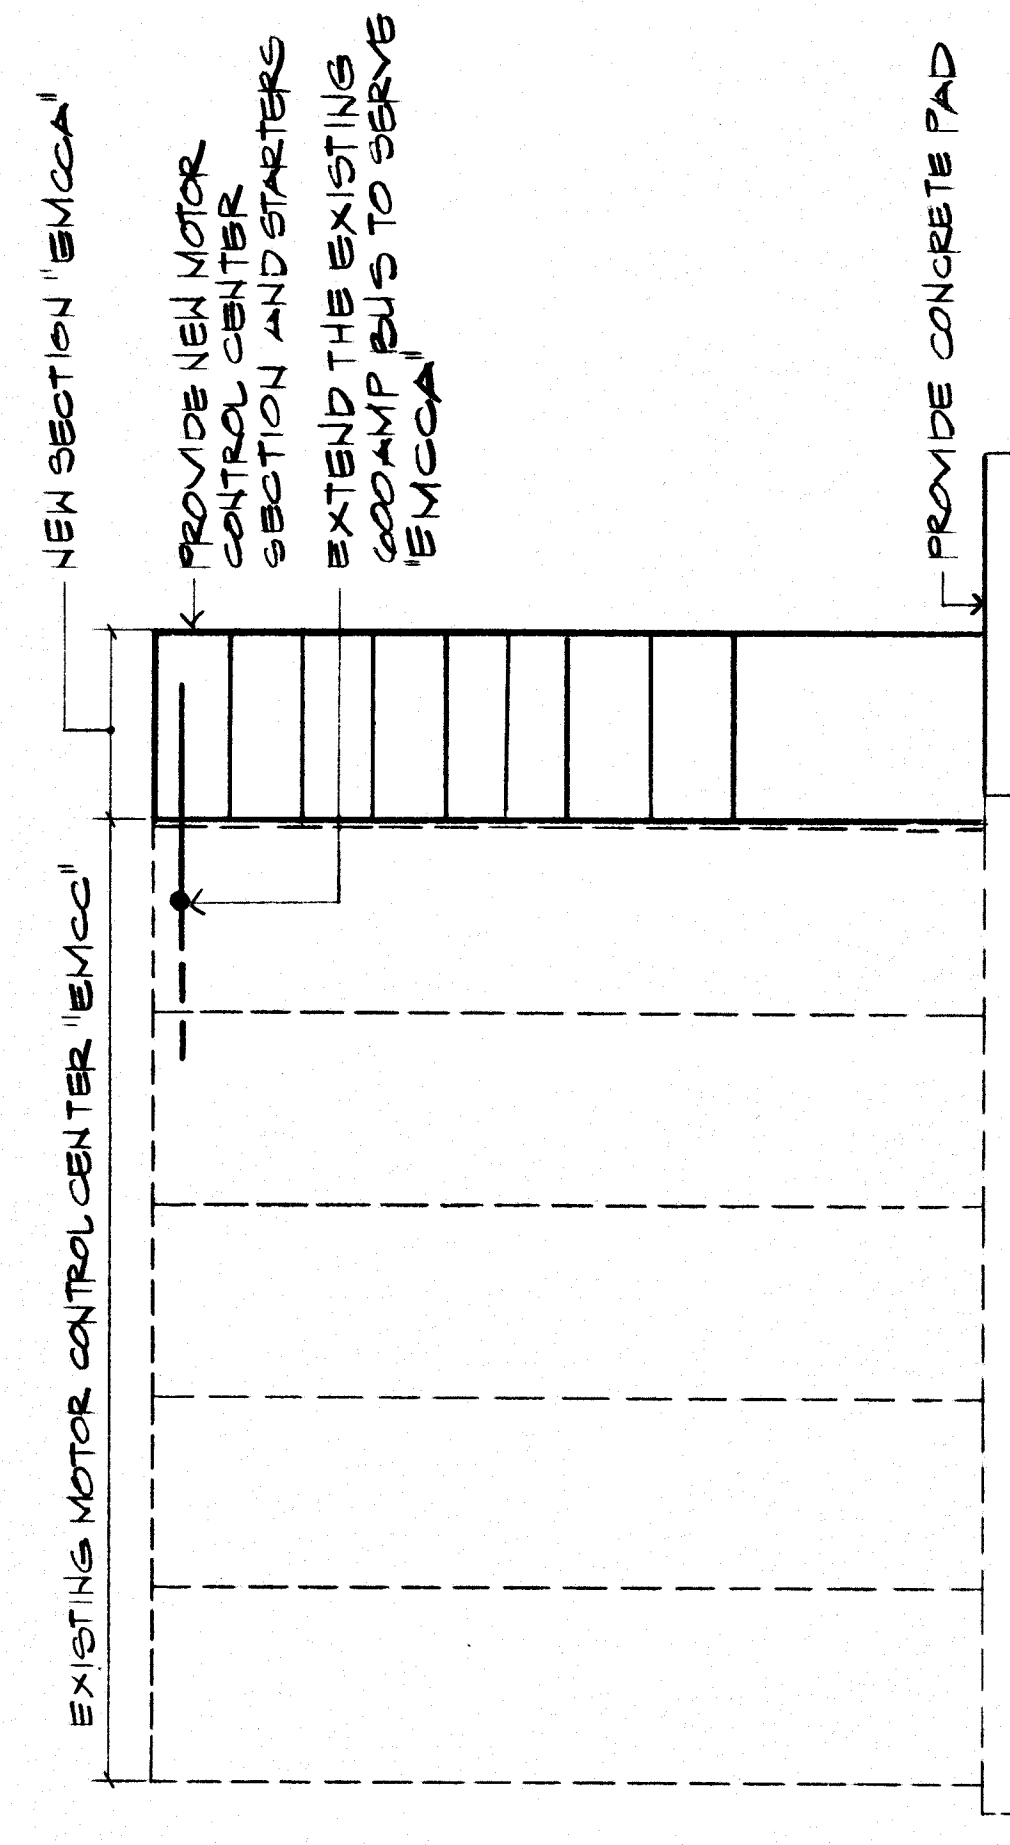


MOTOR CONTROL CENTER "EMCCA"  
NOT TO SCALE









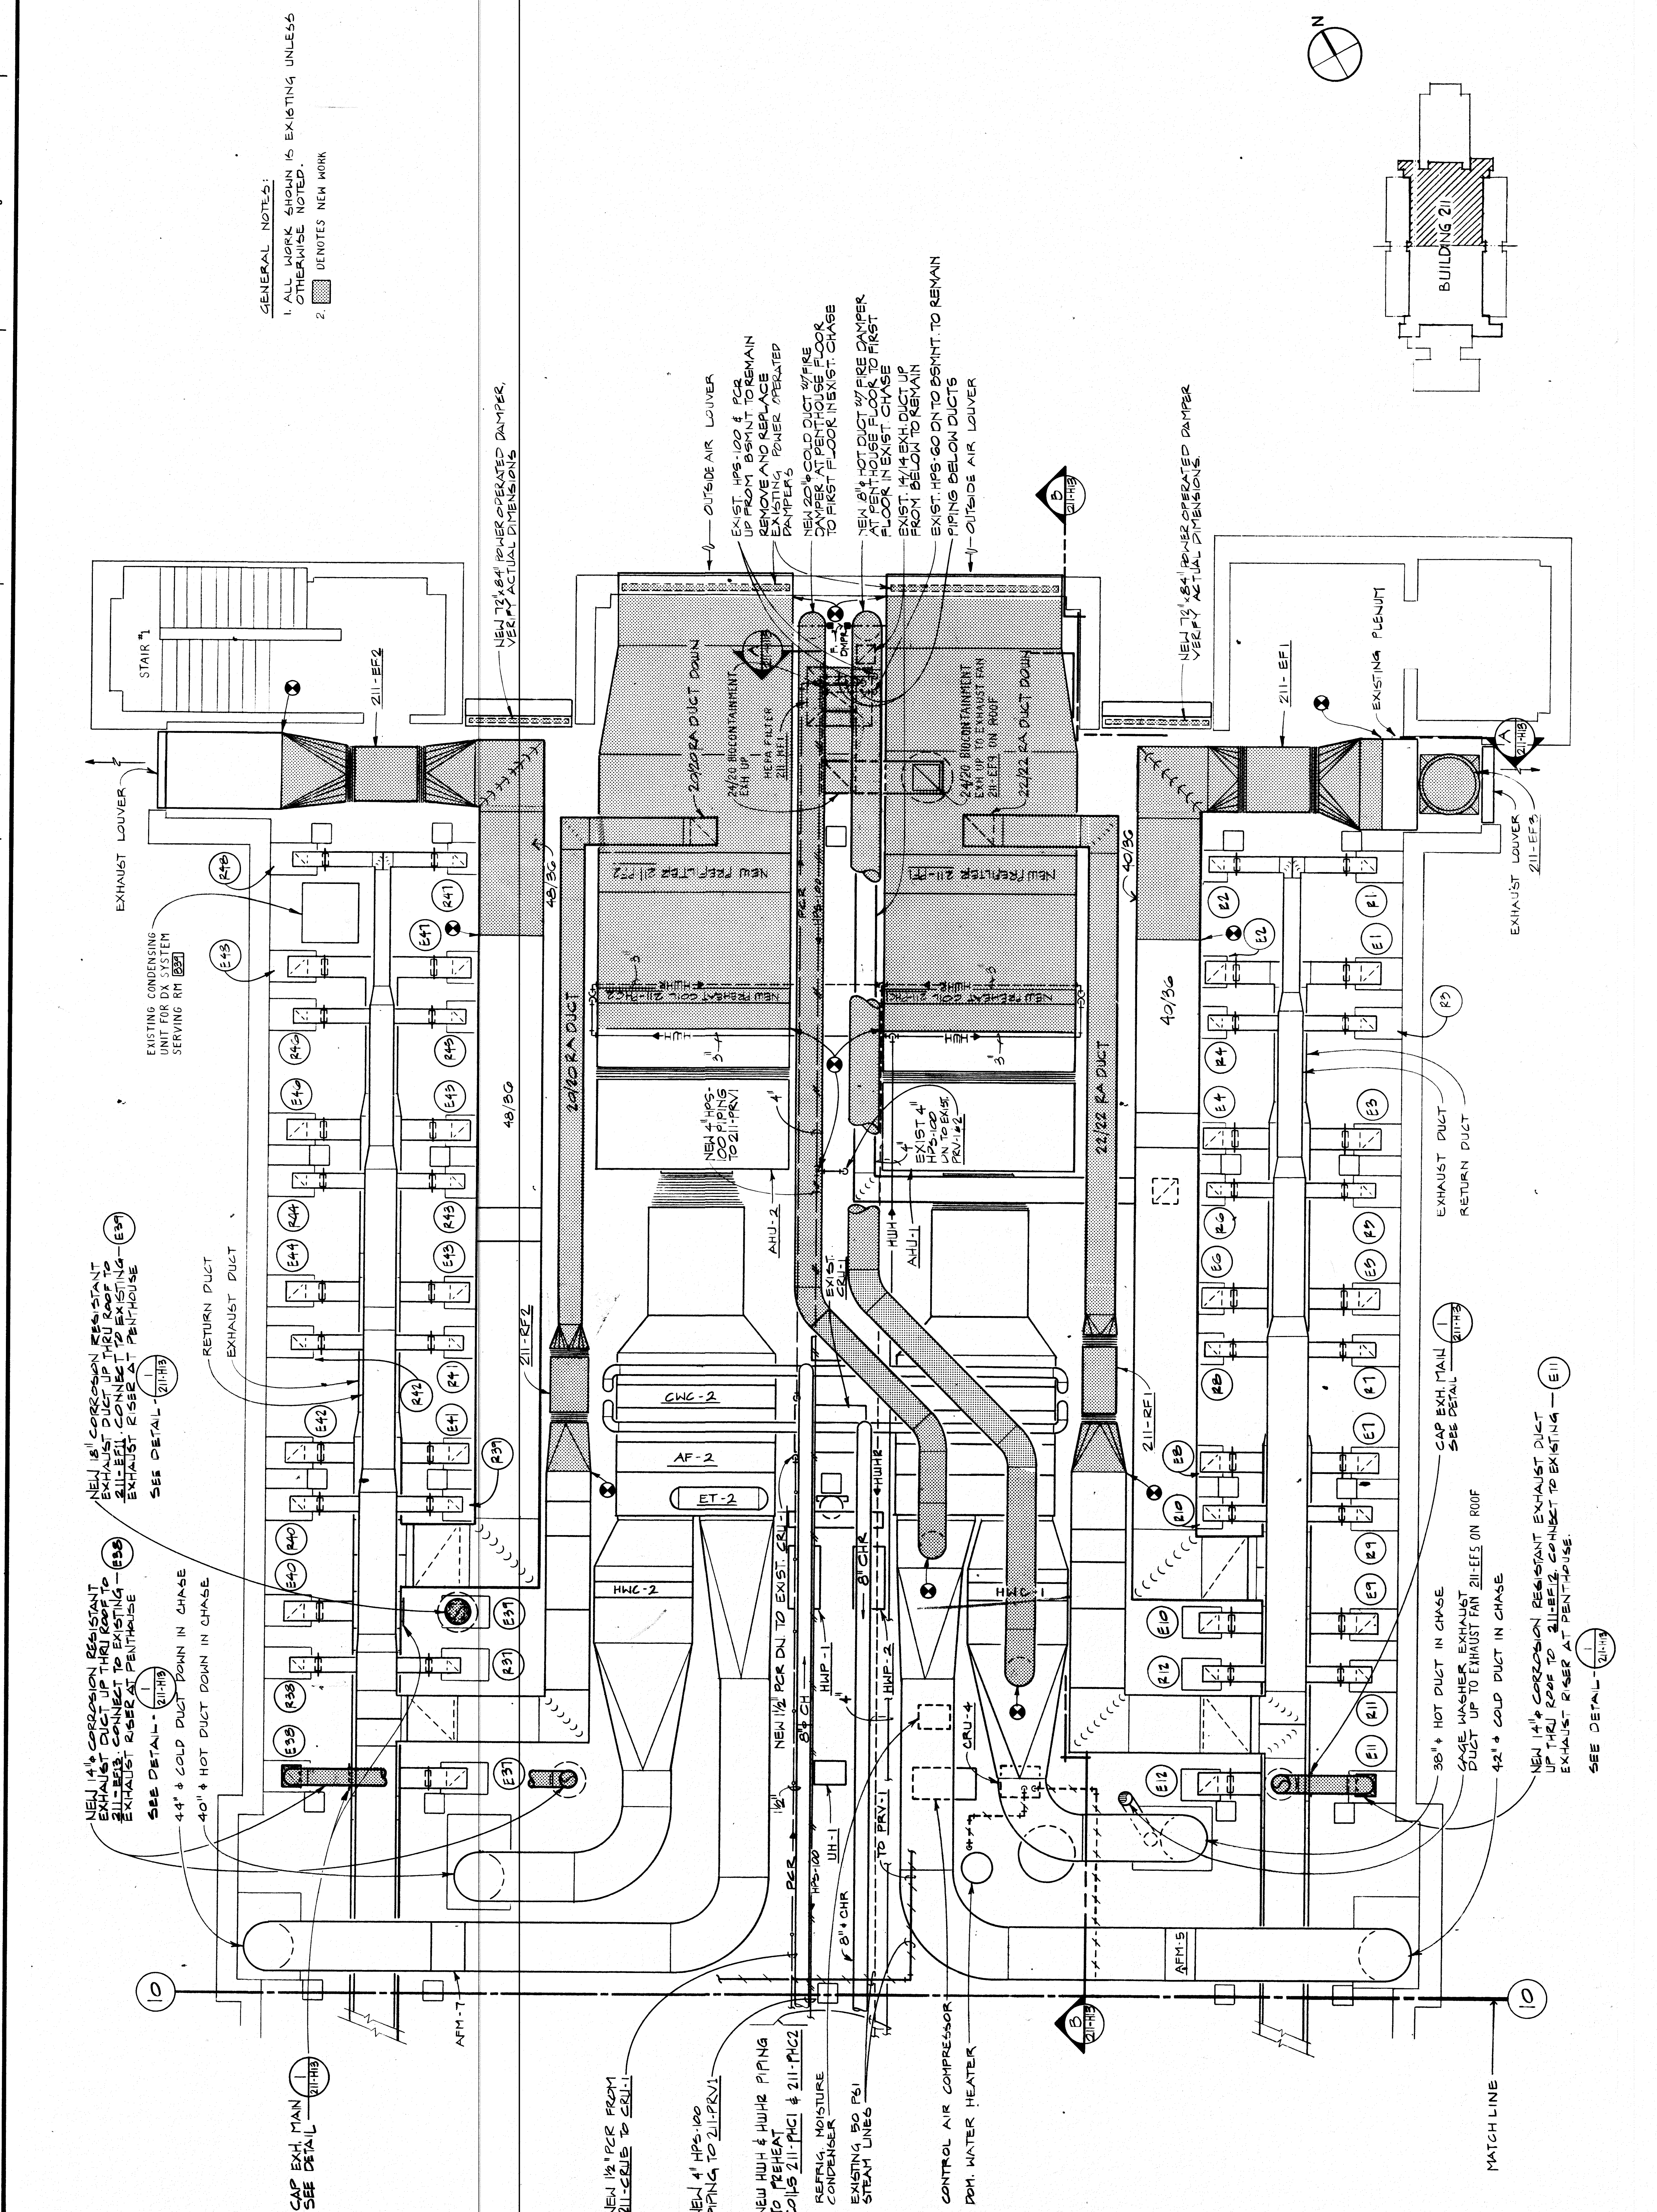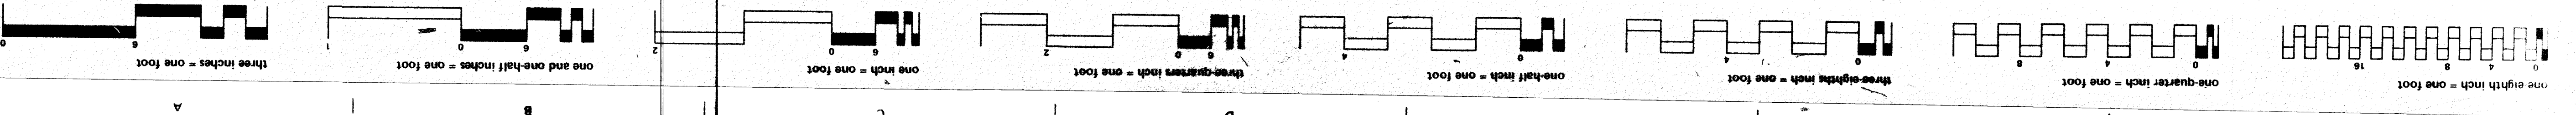

GENERAL NOTES:  
1. ALL WORK SHOWN IS EXISTING UNLESS OTHERWISE NOTED.  
2. DENOTES NEW WORK

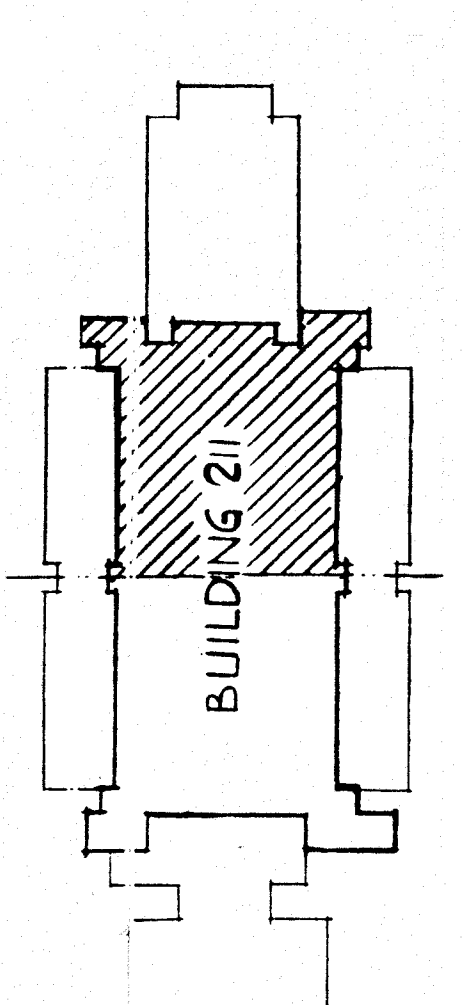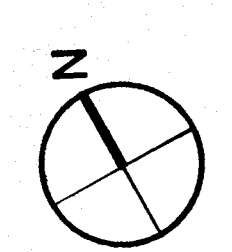

3D/INTERNATIONAL AND STONE, MARRACCHINI AND PATTERSON  
3D/1 SMP  
1900 WEST LOOP SOUTH, SUITE 200 HOUSTON, TEXAS 77027 TELEPHONE (713) 671-7000

STRUCTURAL AND CIVIL  
MECHANICAL AND ELECTRICAL

WALTER P. MOORE AND ASSOCIATES, INCORPORATED  
YARBELL & MILLER, INC. AND 3D / INTERNATIONAL

PHASE IV  
Drawing Title  
MECHANICAL ROOM PLAN  
- AREA A - HVAC

Project No.  
580-040

Drawing No.  
211-H11

Project Date  
11 FEB 87

Project Location  
VAMC HOUSTON, TEXAS

Approved Project Director  
*[Signature]*



Checked  
L.P.

Drawn  
M.M./JC

SCALE: 1/4" = 1'-0"

DATE  
11/1/86



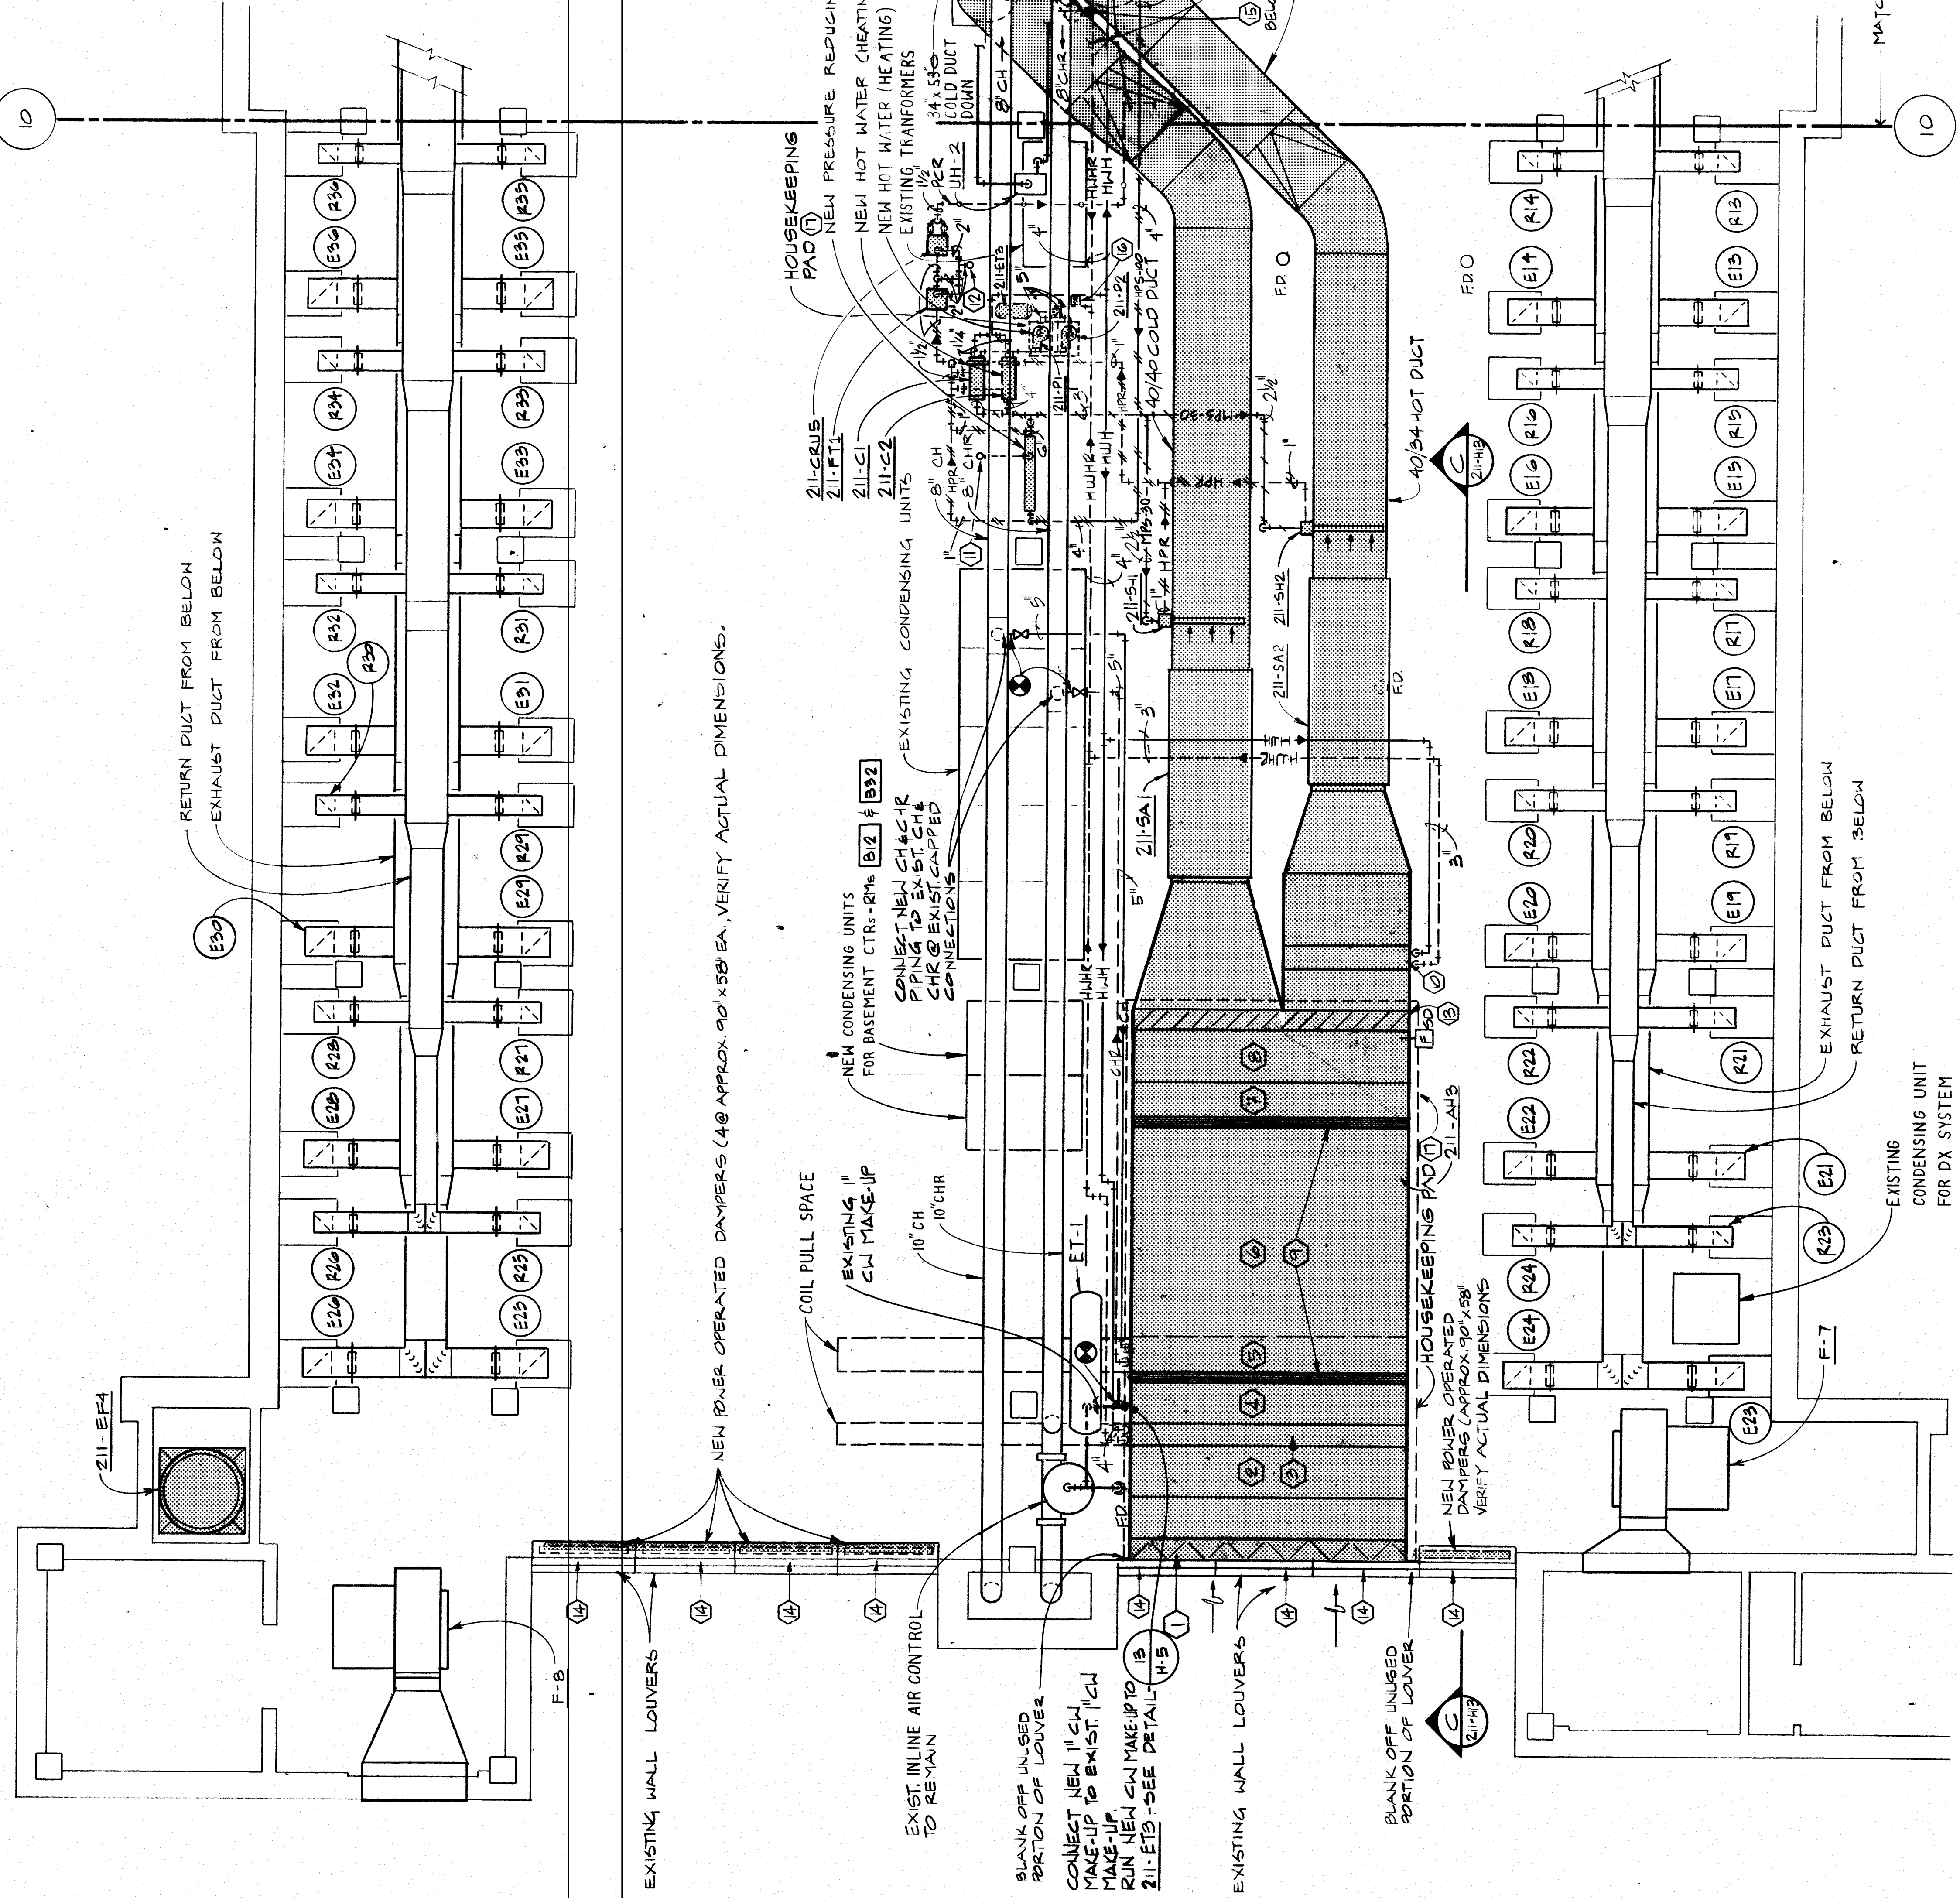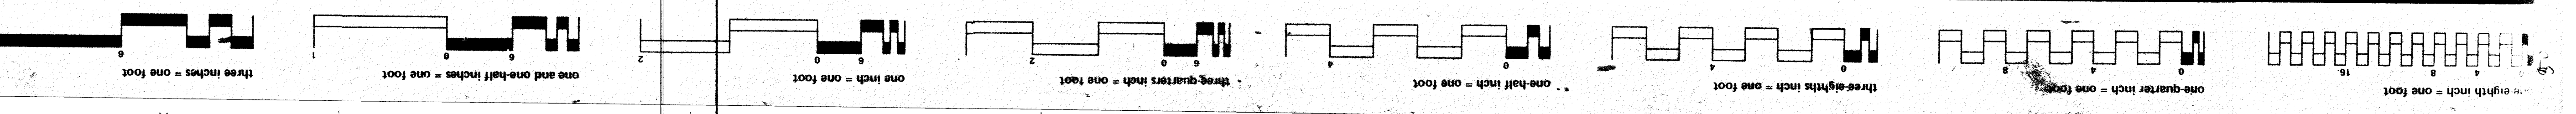

- GENERAL NOTES:**  
1. ALL WORK SHOWN IS EXISTING UNLESS NOTED OTHERWISE.  
2. DENOTES NEW WORK.  
3. DENOTES STAINLESS STEEL DUCT.  
4. A HOUSEKEEPING PAD SHALL BE PROVIDED UNDER 211-PAV AND 211-PAO. PAD SHALL EXTEND MINIMUM OF 4' BEYOND PERIMETER OF EQUIPMENT.

- NOTES BY SYMBOL:**  
1. OUTSIDE AIR DAMPER  
2. PREHEAT SECTION - 211-PE3  
3. PREHEAT COIL SECTION - 211-PE4  
4. ACCESS SECTION  
5. COOLING COIL  
6. FAN SECTION - 211-AH3  
7. DIFFUSER SECTION  
8. AFTER-FILTER SECTION - 211-AF3  
9. FLEX SECTION  
10. HEATING COIL - 211-HC3  
11. SAFETY RELIEF VENT UP THRU ROOF  
12. 2\"/>

3D/INTERNATIONAL AND STONE, MARRACCINI AND PATTERSON  
3D/I • SMP  
1900 WEST LOOP SOUTH, SUITE 200 HOUSTON, TEXAS 77027 TELEPHONE (713) 871-7000

STRUCTURAL AND CIVIL  
MECHANICAL AND ELECTRICAL

WALTER P. MOORE AND ASSOCIATES, INCORPORATED  
YANDELL & MILLER, INC. AND 30 / INTERNATIONAL

PHASE IV  
Drawing Title  
MECHANICAL ROOM PLANS  
- AREA B - HVAC

Project Title  
REPLACEMENT/  
MODERNIZATION  
MEDICAL CENTER

Approved Project Director  
*[Signature]*

DATE  
11 FEB 87

Project No.  
580-040

DRAWING NO.  
211-H12

Drawn  
M1/JC

Checked  
LB

Location  
VAMC HOUSTON, TEXAS



