


1 LINK HVAC PLAN  
1/8" = 1'-0"

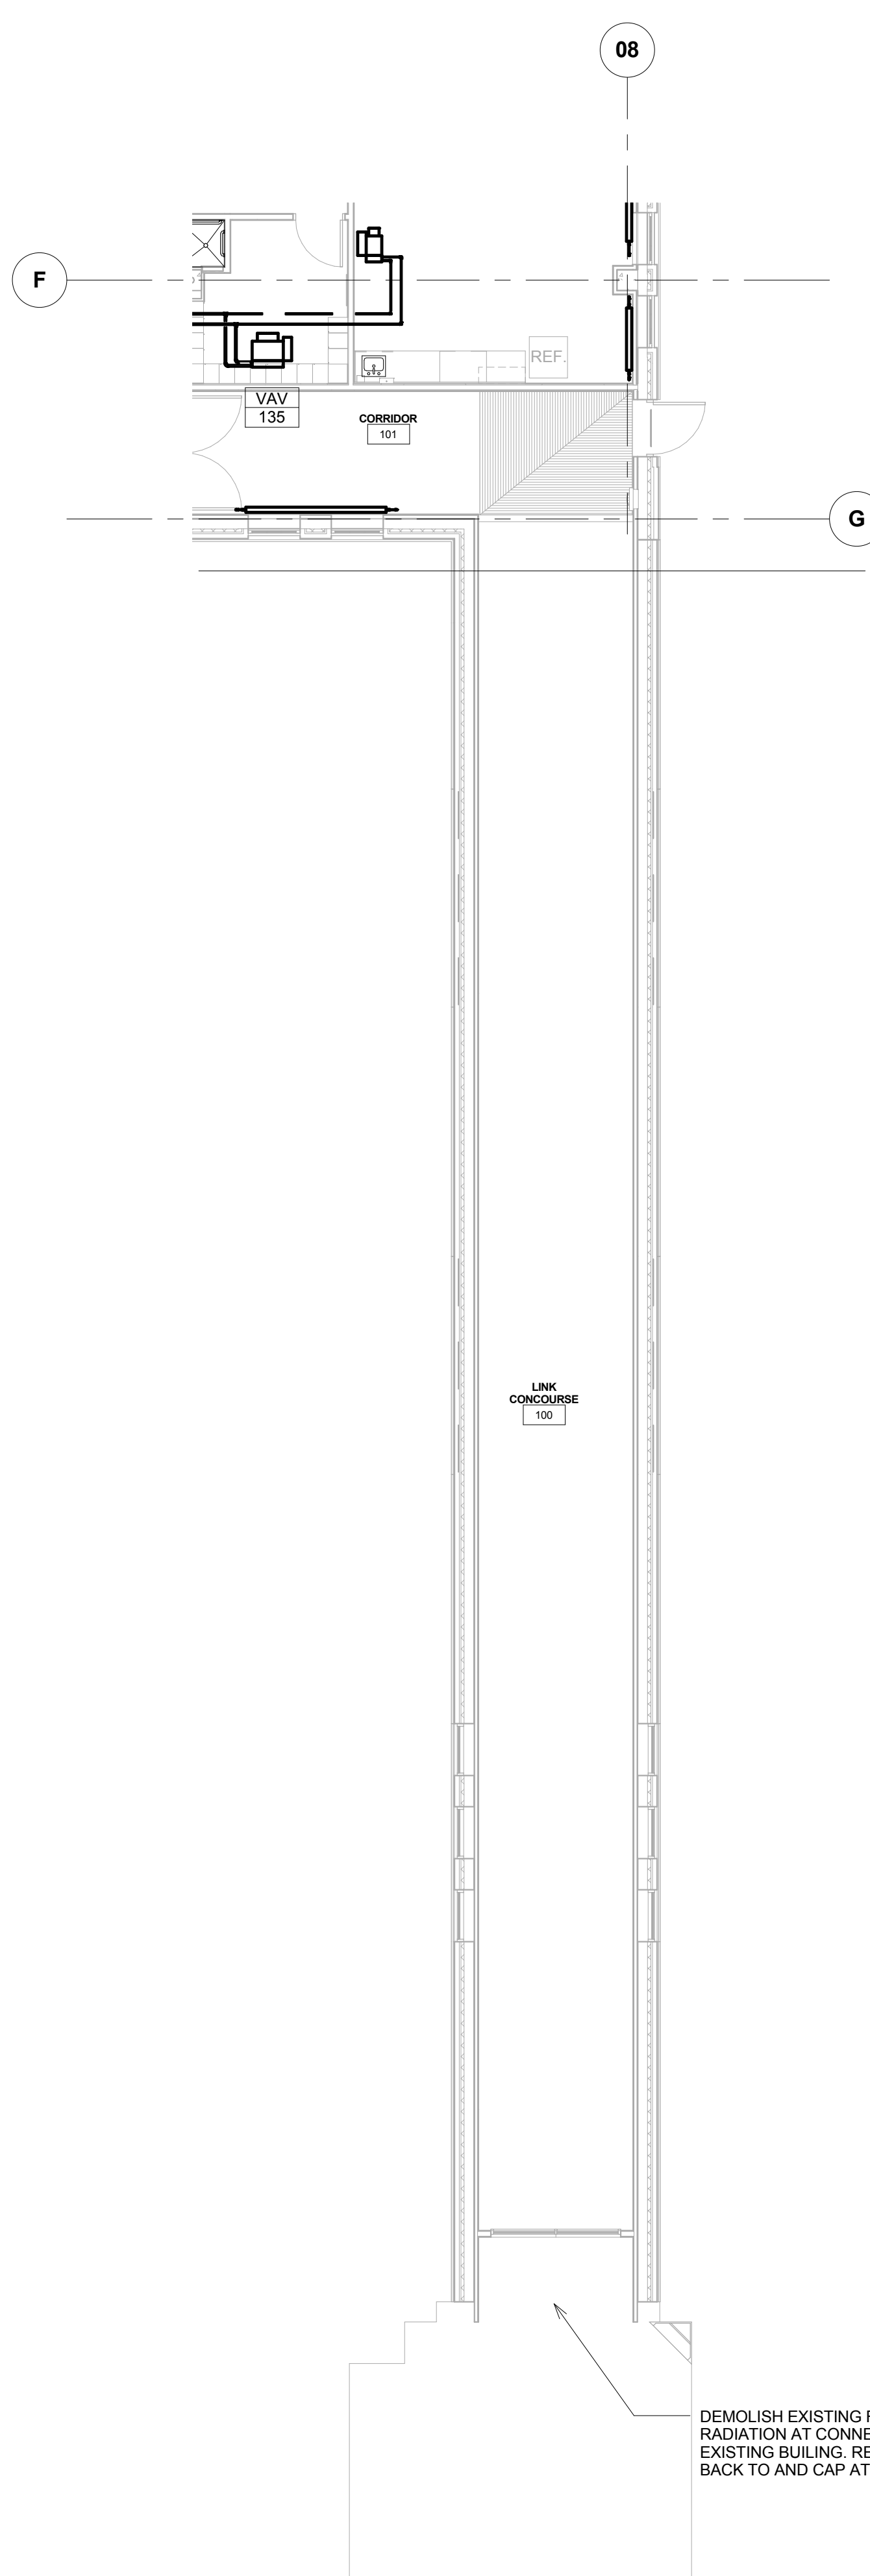

2 LINK PIPING PLAN  
1/8" = 1'-0"

100% OWNER REVIEW  
NOT FOR CONSTRUCTION  
12/16/2011



**RSP Architects**  
1220 Marshall Street NE  
Minneapolis  
Minnesota 55413-1036  
612.677.7100  
612.677.7499 fax  
www.rsparch.com

NOTICE: The designs shown and described herein including all technical drawings, graphics, and models thereof, are proprietary and cannot be copied, duplicated or commercially exploited, in whole or in part, without express written permission of RSP Architects. These are available for limited review and evaluation by clients, consultants, contractors, government agencies, vendors and office personnel only in accordance with this Notice.

© Copyright RSP Architects 2011. All rights reserved.



CONSULTANTS:

**Structural**  
Van Sickle, Allen & Assoc.  
2955 Xenium Lane N  
Suite 10  
Plymouth, MN 55441

**Civil**  
EVS  
10250 Valley View Road  
Suite 113  
Eden Prairie, MN 55344

**Landscape**  
Damon Farber Assoc.  
923 Nicollet Mall  
Minneapolis, MN 55402

**Fire Protection**  
Gary Travinski Associates  
Engineering  
94 Boston Hill  
Larksville, PA 18851-3298

**MEP**  
**DUNHAM**  
60 South Sixth Street / Suite 100  
Minneapolis, Minnesota 55402-1000  
phone 612.444.7000  
fax 612.444.7001  
www.dunhaminc.com  
mechanical & electrical  
consulting engineering  
TOWNSHIP LICENSED

I hereby certify that this plan, specification or report was prepared by me or under my direct supervision and that I am a duly licensed Engineer under the laws of the State of Minnesota.

Signature

Registration No.

Date 11/17/2011

APPROVED: SERVICE LINE DIRECTOR	DATE	APPROVED: INFECTION CONTROL NURSE	DATE
APPROVED: GEMS COORDINATOR	DATE	APPROVED: PATIENT SAFETY	DATE
APPROVED: PROJECTS SECTION MANAGER	DATE	APPROVED: CHIEF OF POLICE	DATE
APPROVED: DIRECTOR FMS	DATE	APPROVED: SAFETY MANAGER	DATE

DRAWING TITLE LINK HVAC AND PIPING PLANS			
APPROVED: CHIEF OF STAFF	DATE	APPROVED: MEDICAL CENTER DIRECTOR	DATE

PROJECT TITLE LONG TERM / INTERMEDIATE PSYCHIATRIC UNIT			
BUILDING No.	DM	ISSUED BY	BB
LOCATION	4801 VETERANS DR. SAINT CLOUD, MN		

DATE	12/16/2011
PROJECT NO.	2012.001.00
DWG. NO.	M103
DATE	12/16/2011

