


1 GRADING PLAN
SCALE 1" = 20'

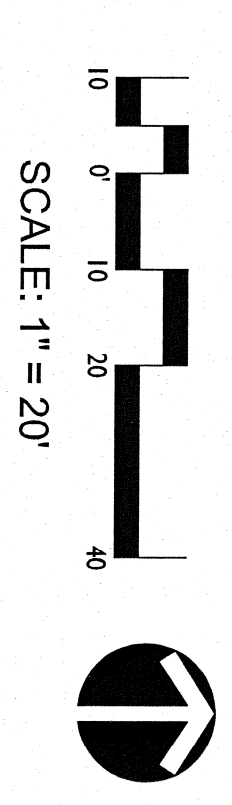

100% CONSTRUCTION DOCUMENTS

ENGINEERS/ARCHITECT:		Professional Stamp/Seal	
APOGEE Consulting Group, PA www.apogee.com WSP-SELLS TRANSPORTATION & INFRASTRUCTURE		WALDON STUDIO ARCHITECTS & PLANNERS, PC www.waldonstudio.com	
Drawing Title		Project Title	
GRADING PLAN		COATESVILLE - VA MEDICAL CENTER A/E INSTALL EMERGENCY GENERATOR	
Checked		Building Number	
TMG		COATESVILLE, PENNSYLVANIA	
Date		Project No.	
9/23/11		542-11-104	
Dwgn. No.		C-103	
3 of 3		VA	