


KEY

- 111 REPLACE COMMON FLOORING 1-2, 8&9/11NRM|REPLACE FLOORING|695-11-157|C10763
- A AUDIOLOGY CLINIC/04NRM/|REMODEL CLINIC|695-04-120E5
- B DENTAL EXPANSION 07/07NRM|CLINIC EXPANSION|695-07-124|C50366, C40843, C60776, C60829, C70640, C60780 & C60776
- C 8A NHCU NURSE CALL/10NRM|UPDATE NURSE CALL|695-CSI-319|C70753
- D NURSE CALL SYSTEM 8AS NHCU/11NRM/695-11-176
- E AMBULATORY PROCEDURE CENTER/MINORS/00 MINORS|WARD REMODEL|695-206|V69DC-191
- F ACUTE CARE MODIFICATIONS/04 MINORS|WARD REMODEL|695-225|Z40004
- G 111 UPGRADE PUBLIC RESTROOMS/11NRM|F111 JOC|111 UPGRADE PUBLIC RESTROOMS
- H 111 EXPAND DENTAL CLINIC 8C/13NRM|695-13-105
- I AMBULATORY SURGERY CENTER/MINORS/00/695-205
- J 111 TUC AND SAFETY CORRECTIONS F2015/15NRM/695-15-122
- K 111 INSTALL DENTAL LABORATORY CASEWORK/15NRM/695-15-140

ENTIRE FLOOR: REPLACE FIRE ALARM SYSTEM/09NRM|695-09-151|C90855  
111 REKEY BLDG/12NRM/695-12-124

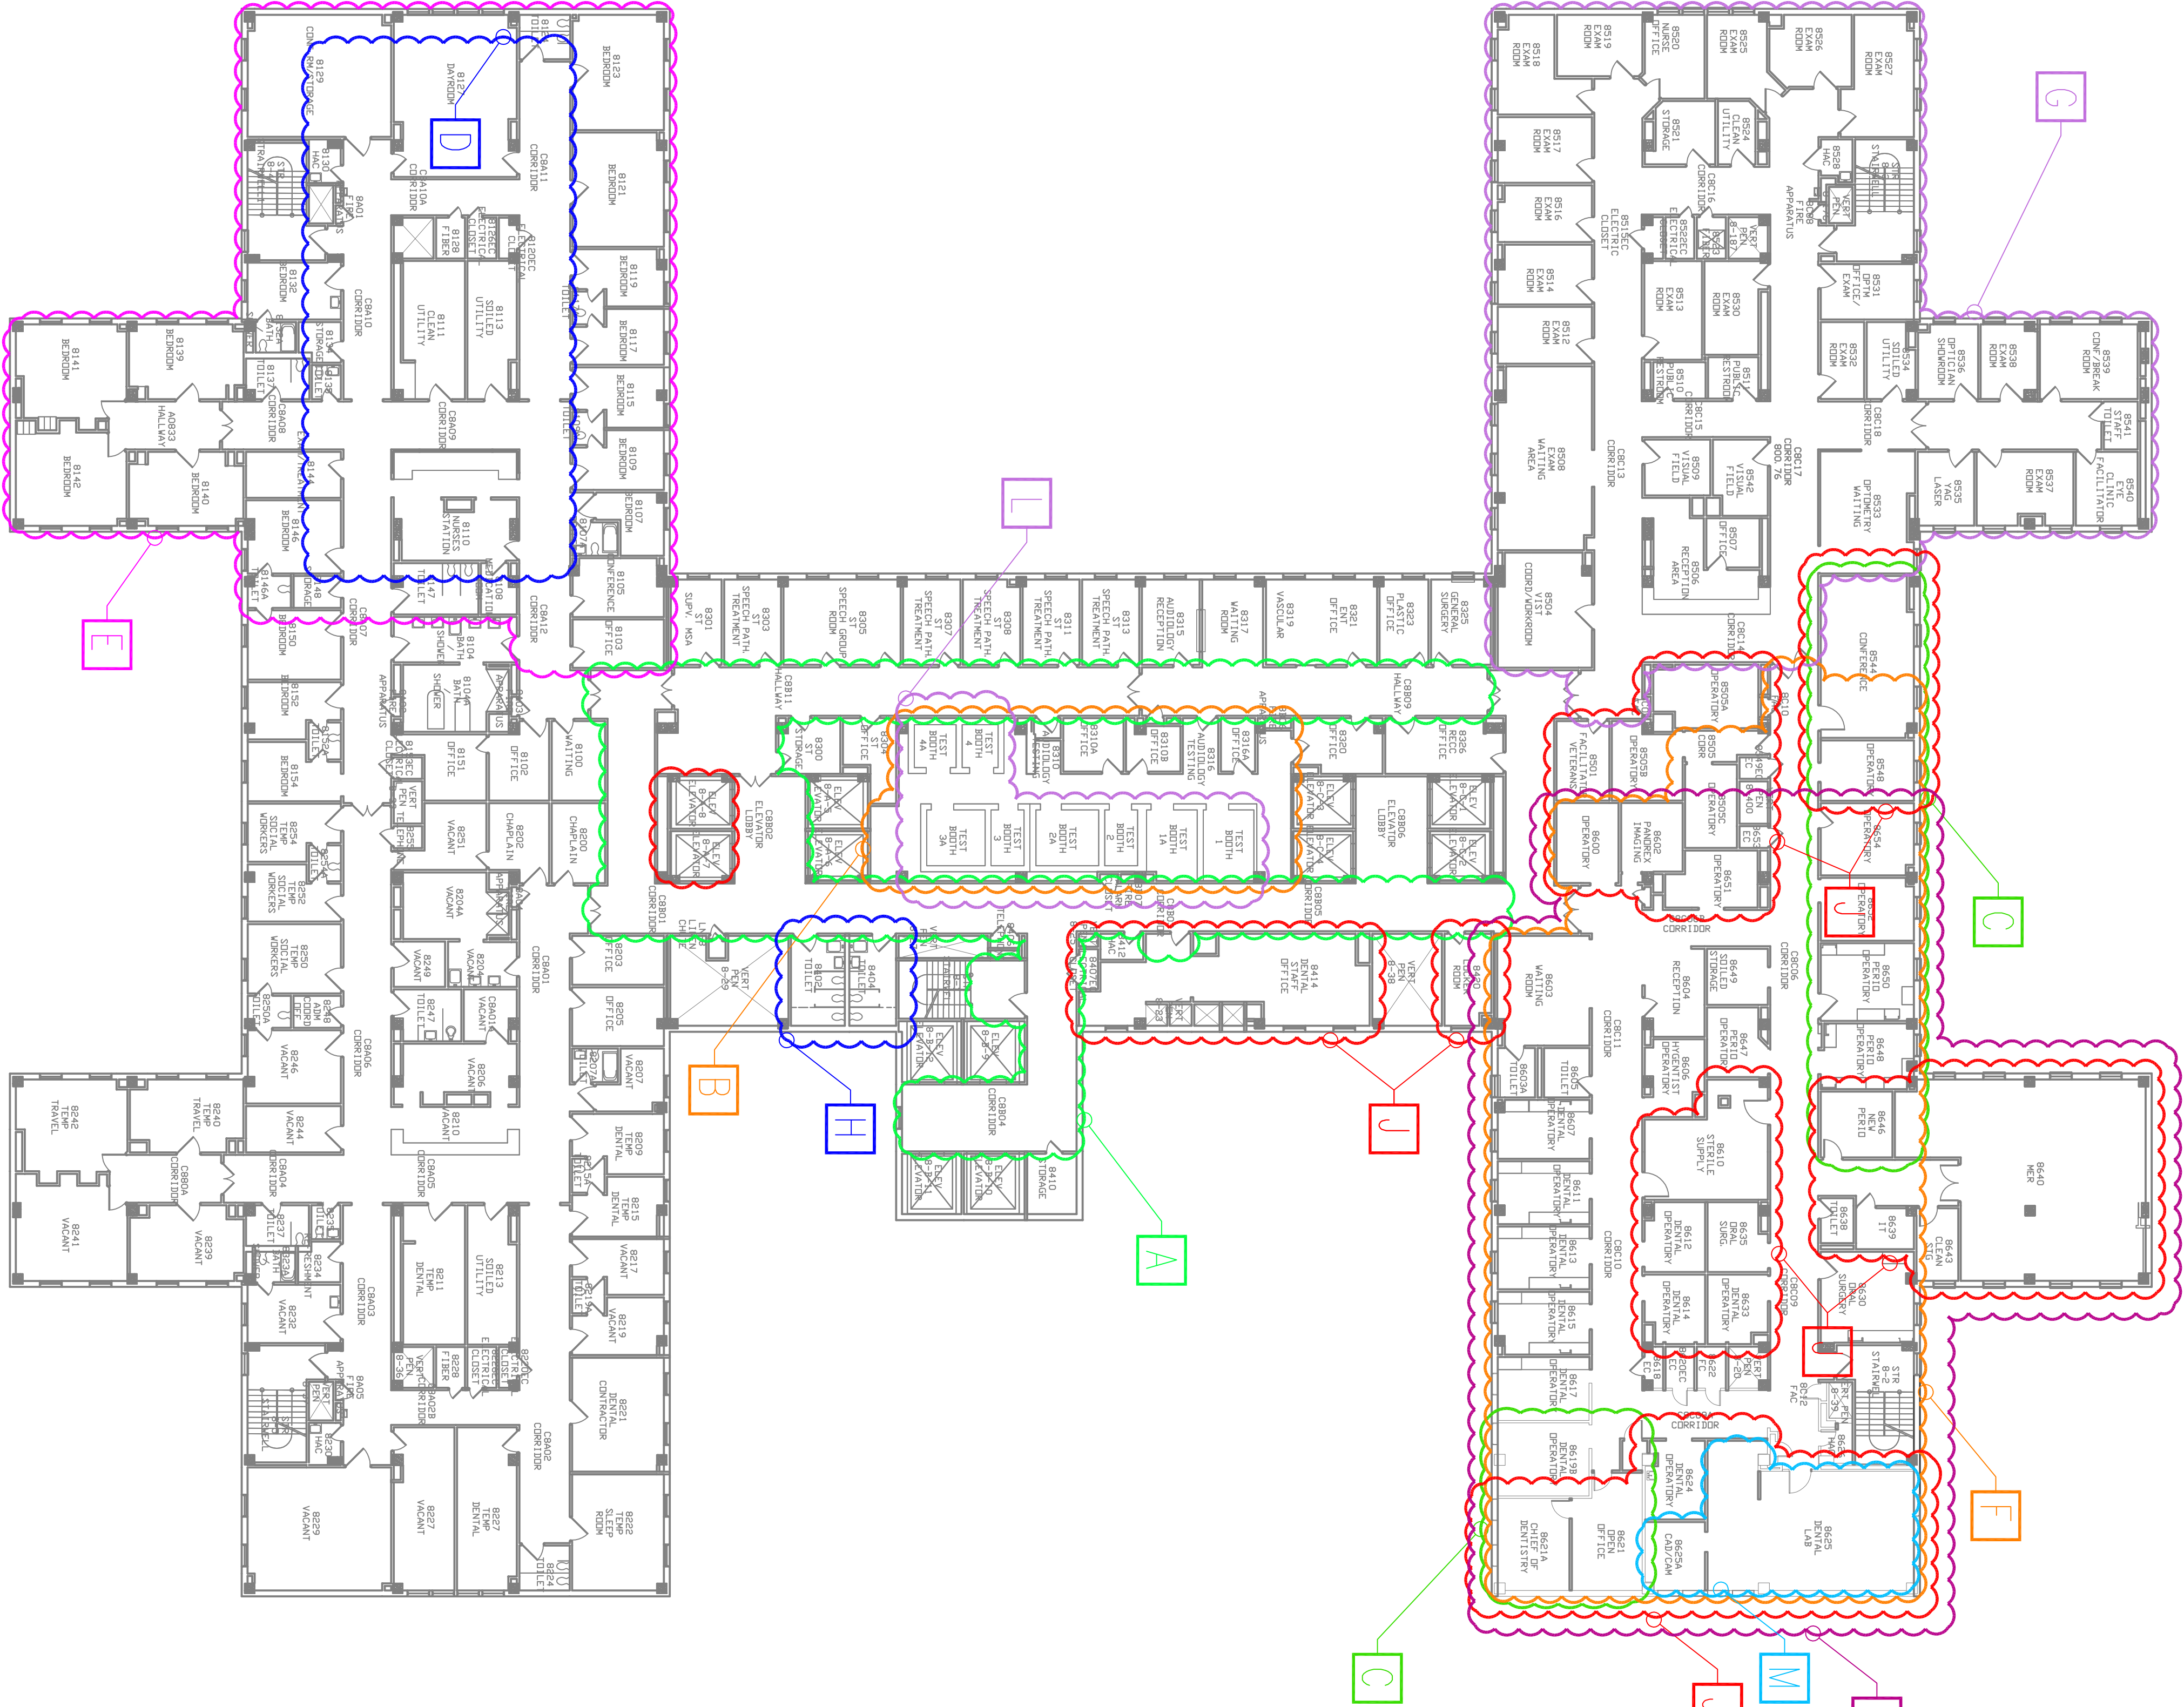

EIGHTH FLOOR PLAN

N.T.S.

Project Title		Project Title		Project Number	
EIGHTH FLOOR PLAN FLOOR AS-BUILT RECORD		-		Building Number 111-08	
Approved Project Director		Location VA Medical Center, Milwaukee, WI		Drawing Number 9 of 14	
Date 11/13/2017		Checked -		Drawn mm	
VA FORM 08-5231		Dept. of Veterans Affairs Medical Center 5000 W. National Avenue Milwaukee, WI		Office of Construction and Facilities Management Department of Veterans Affairs	