




- KEY**
- 111REPLACE COMMON FLOORING 1-2, 8&9/11NRM|REPLACE FLOORING|695-11-157|C10763
 - NHCU MODIFICATION 9A/MINORS/09MINORS//WARD REMODEL|695-07-124, 695-CA-3233|C29005
 - NHCU MODIFICATION 9C/MINORS/04MINORS|WARD REMODEL|695-221, 695-220|Z2002, Z4001
 - 111 UPGRADE PUBLIC RESTROOMS/11NRM|F11 JOC|111 UPGRADE PUBLIC RESTROOMS
 - 111 UPGRADE 9C FLOORING/13NRM/695-12-202
 - 111 UPGRADE WANDERGUARD SYSTEM/15NRM/695-15-142
 - 111 TJC AND SAFETY CORRECTIONS/15NRM/695-15-122
 - SITE ELECTRICAL CORRECTIONS/16NRM/695-16-117
 - ENTIRE FLOOR: REPLACE FIRE ALARM SYSTEM/09NRM|695-09-151|C90855
 - 111 REKEY BLDG/12NRM/695-12-124

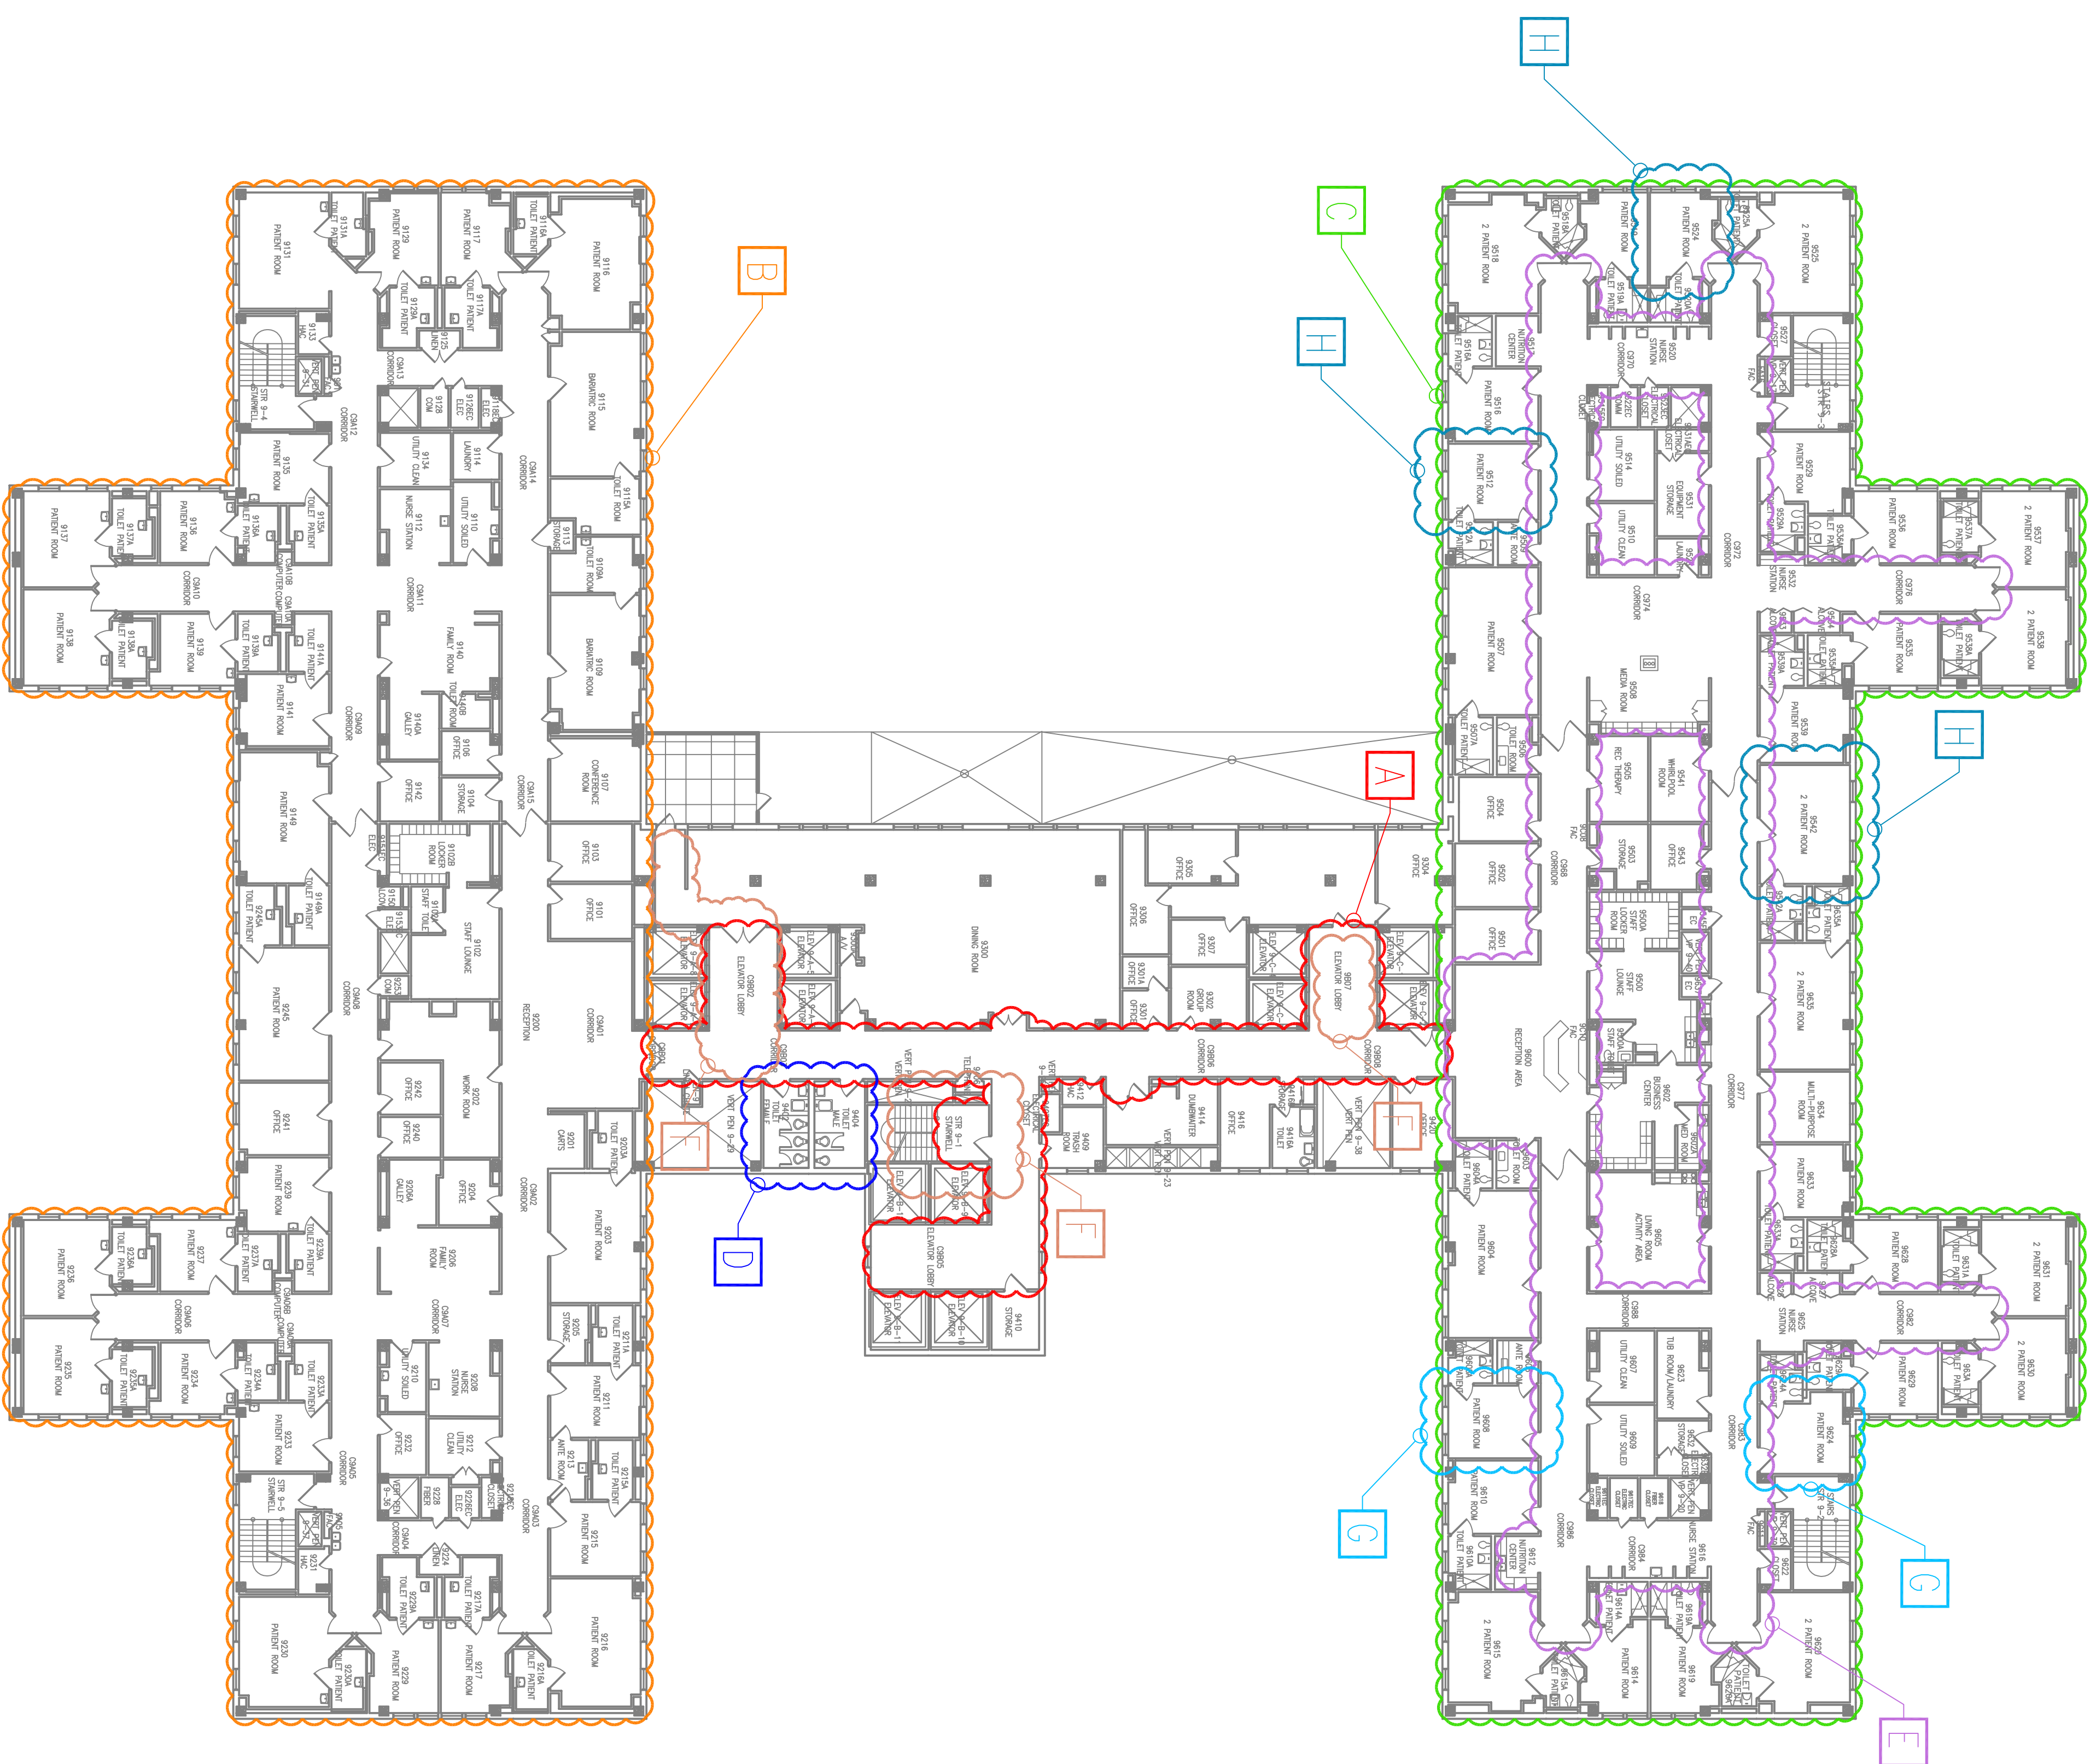

NINTH FLOOR PLAN
N.T.S.

Project Title		Project Title		Project Title	
NINTH FLOOR PLAN		NINTH FLOOR PLAN		NINTH FLOOR PLAN	
FLOOR AS-BUILT RECORD		FLOOR AS-BUILT RECORD		FLOOR AS-BUILT RECORD	
Approved Project Director		Approved Project Director		Approved Project Director	
Location		Location		Location	
VA Medical Center, Milwaukee, WI		VA Medical Center, Milwaukee, WI		VA Medical Center, Milwaukee, WI	
Date		Date		Date	
11/13/2017		11/13/2017		11/13/2017	
Checked		Checked		Checked	
mm		mm		mm	
Drawing Number		Drawing Number		Drawing Number	
111-09		111-09		111-09	
10 of 14		10 of 14		10 of 14	
Office of Construction and Facilities Management		Office of Construction and Facilities Management		Office of Construction and Facilities Management	
Department of Veterans Affairs		Department of Veterans Affairs		Department of Veterans Affairs	