 



KEY


- A AHU V-15 and S-5 REPLACEMENT/07NRW/|||INSTALL V-15 AHU||695-07-132||C0608, C00876
- B DAY TANK LINING/10NRW/695-10-132||
- C 111 REPAIR EXPANSION TANK AND HVAC PIPING/13 NRW/695-13-122

ENTIRE FLOOR: REPLACE FIRE ALARM SYSTEM/09NRW||695-09-151||C90855
111 REKEY BLDG/12NRW/695-12-124

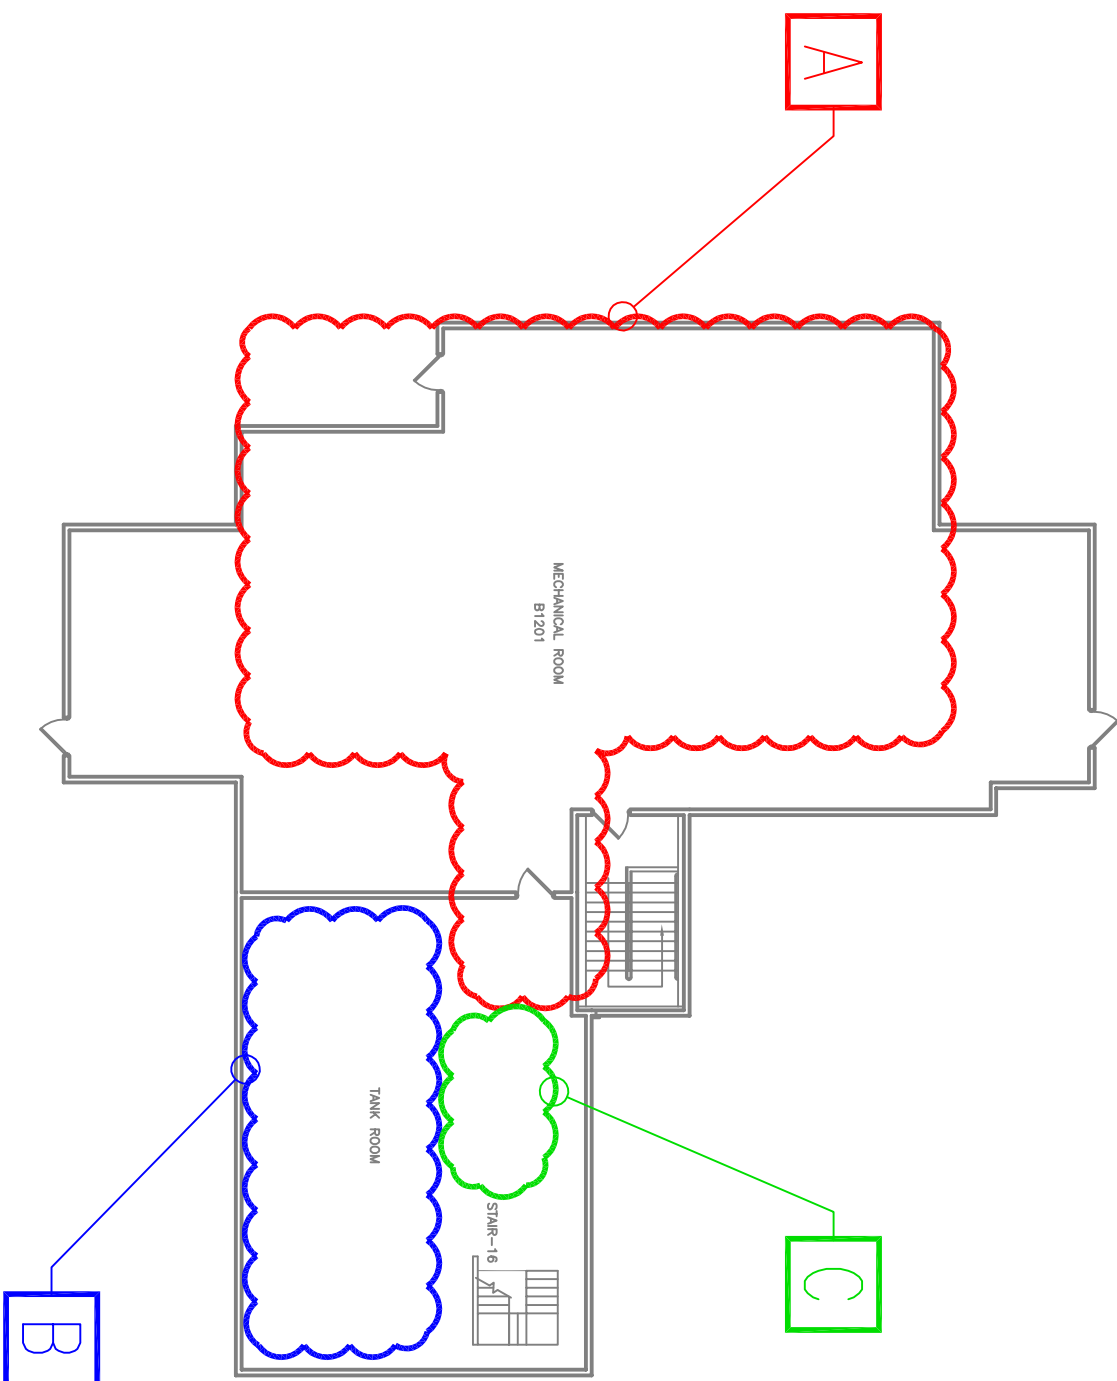


THIRTEENTH FLOOR PLAN


N.T.S.

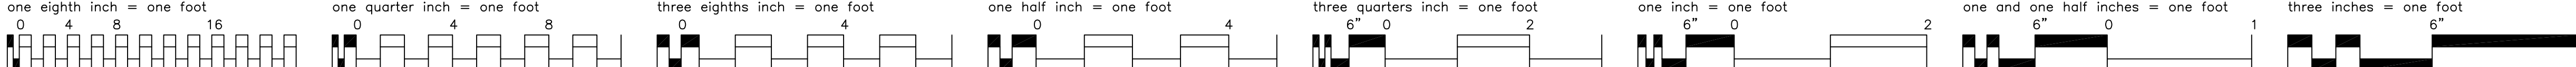

Revision	Date

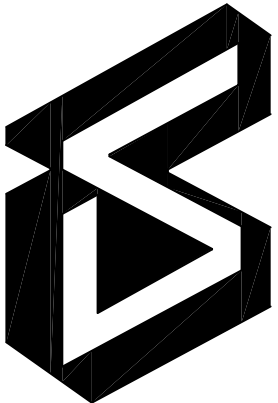

Dept. of Veterans Affairs
Medical Center
5000 W. National Avenue
Milwaukee, WI

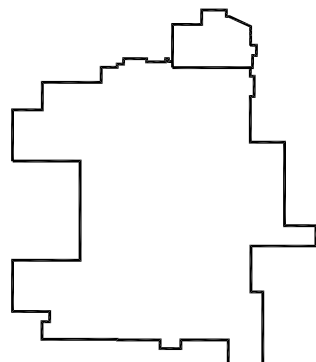

KEY PLAN: ↗

ENGINEER:

ARCHITECT:

Drawing Title
THIRTEENTH FLOOR PLAN
FLOOR AS-BUILT RECORD

Approved Project Director

Project Title

-

Project Number

-

Building Number
111

Drawing Number
111-13

14 of 14

Office of
Construction
and Facilities
Management

