

 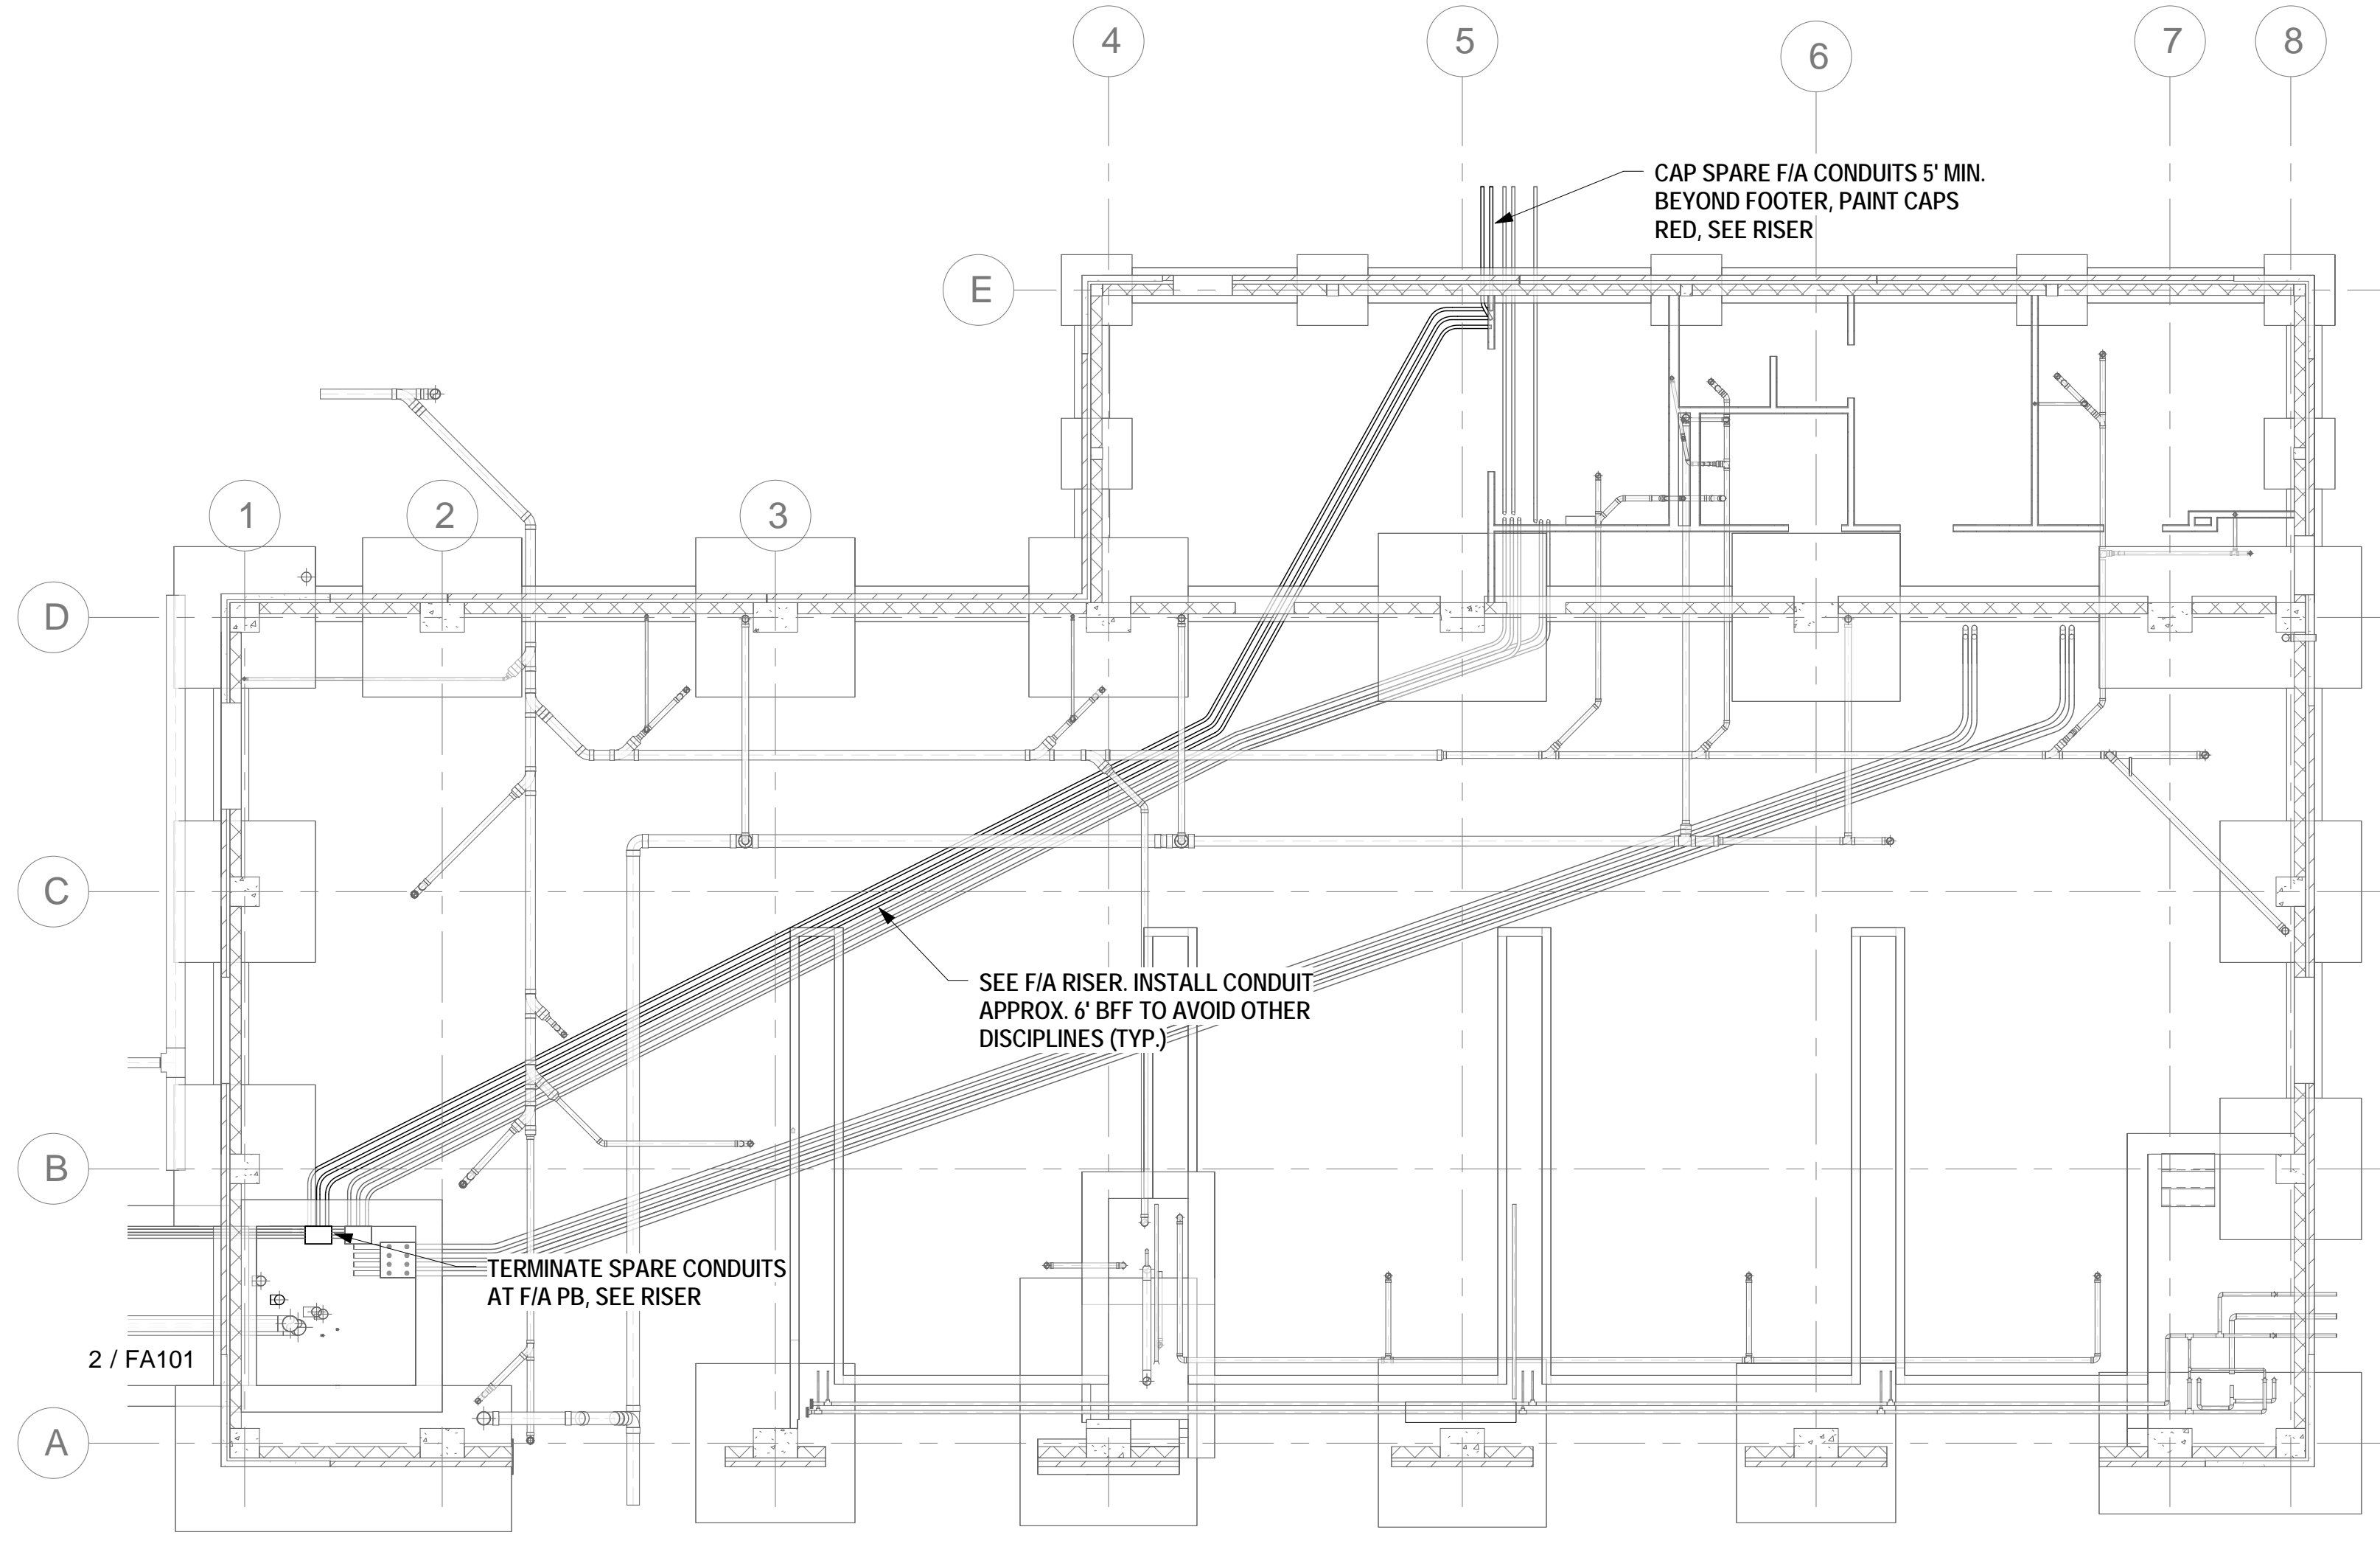




three inches = one foot
one and one half inches = one foot
two inches = one foot
one inch = one foot
three quarters inch = one foot
one half inch = one foot
three eighths inch = one foot
one quarter inch = one foot
one eighth inch = one foot

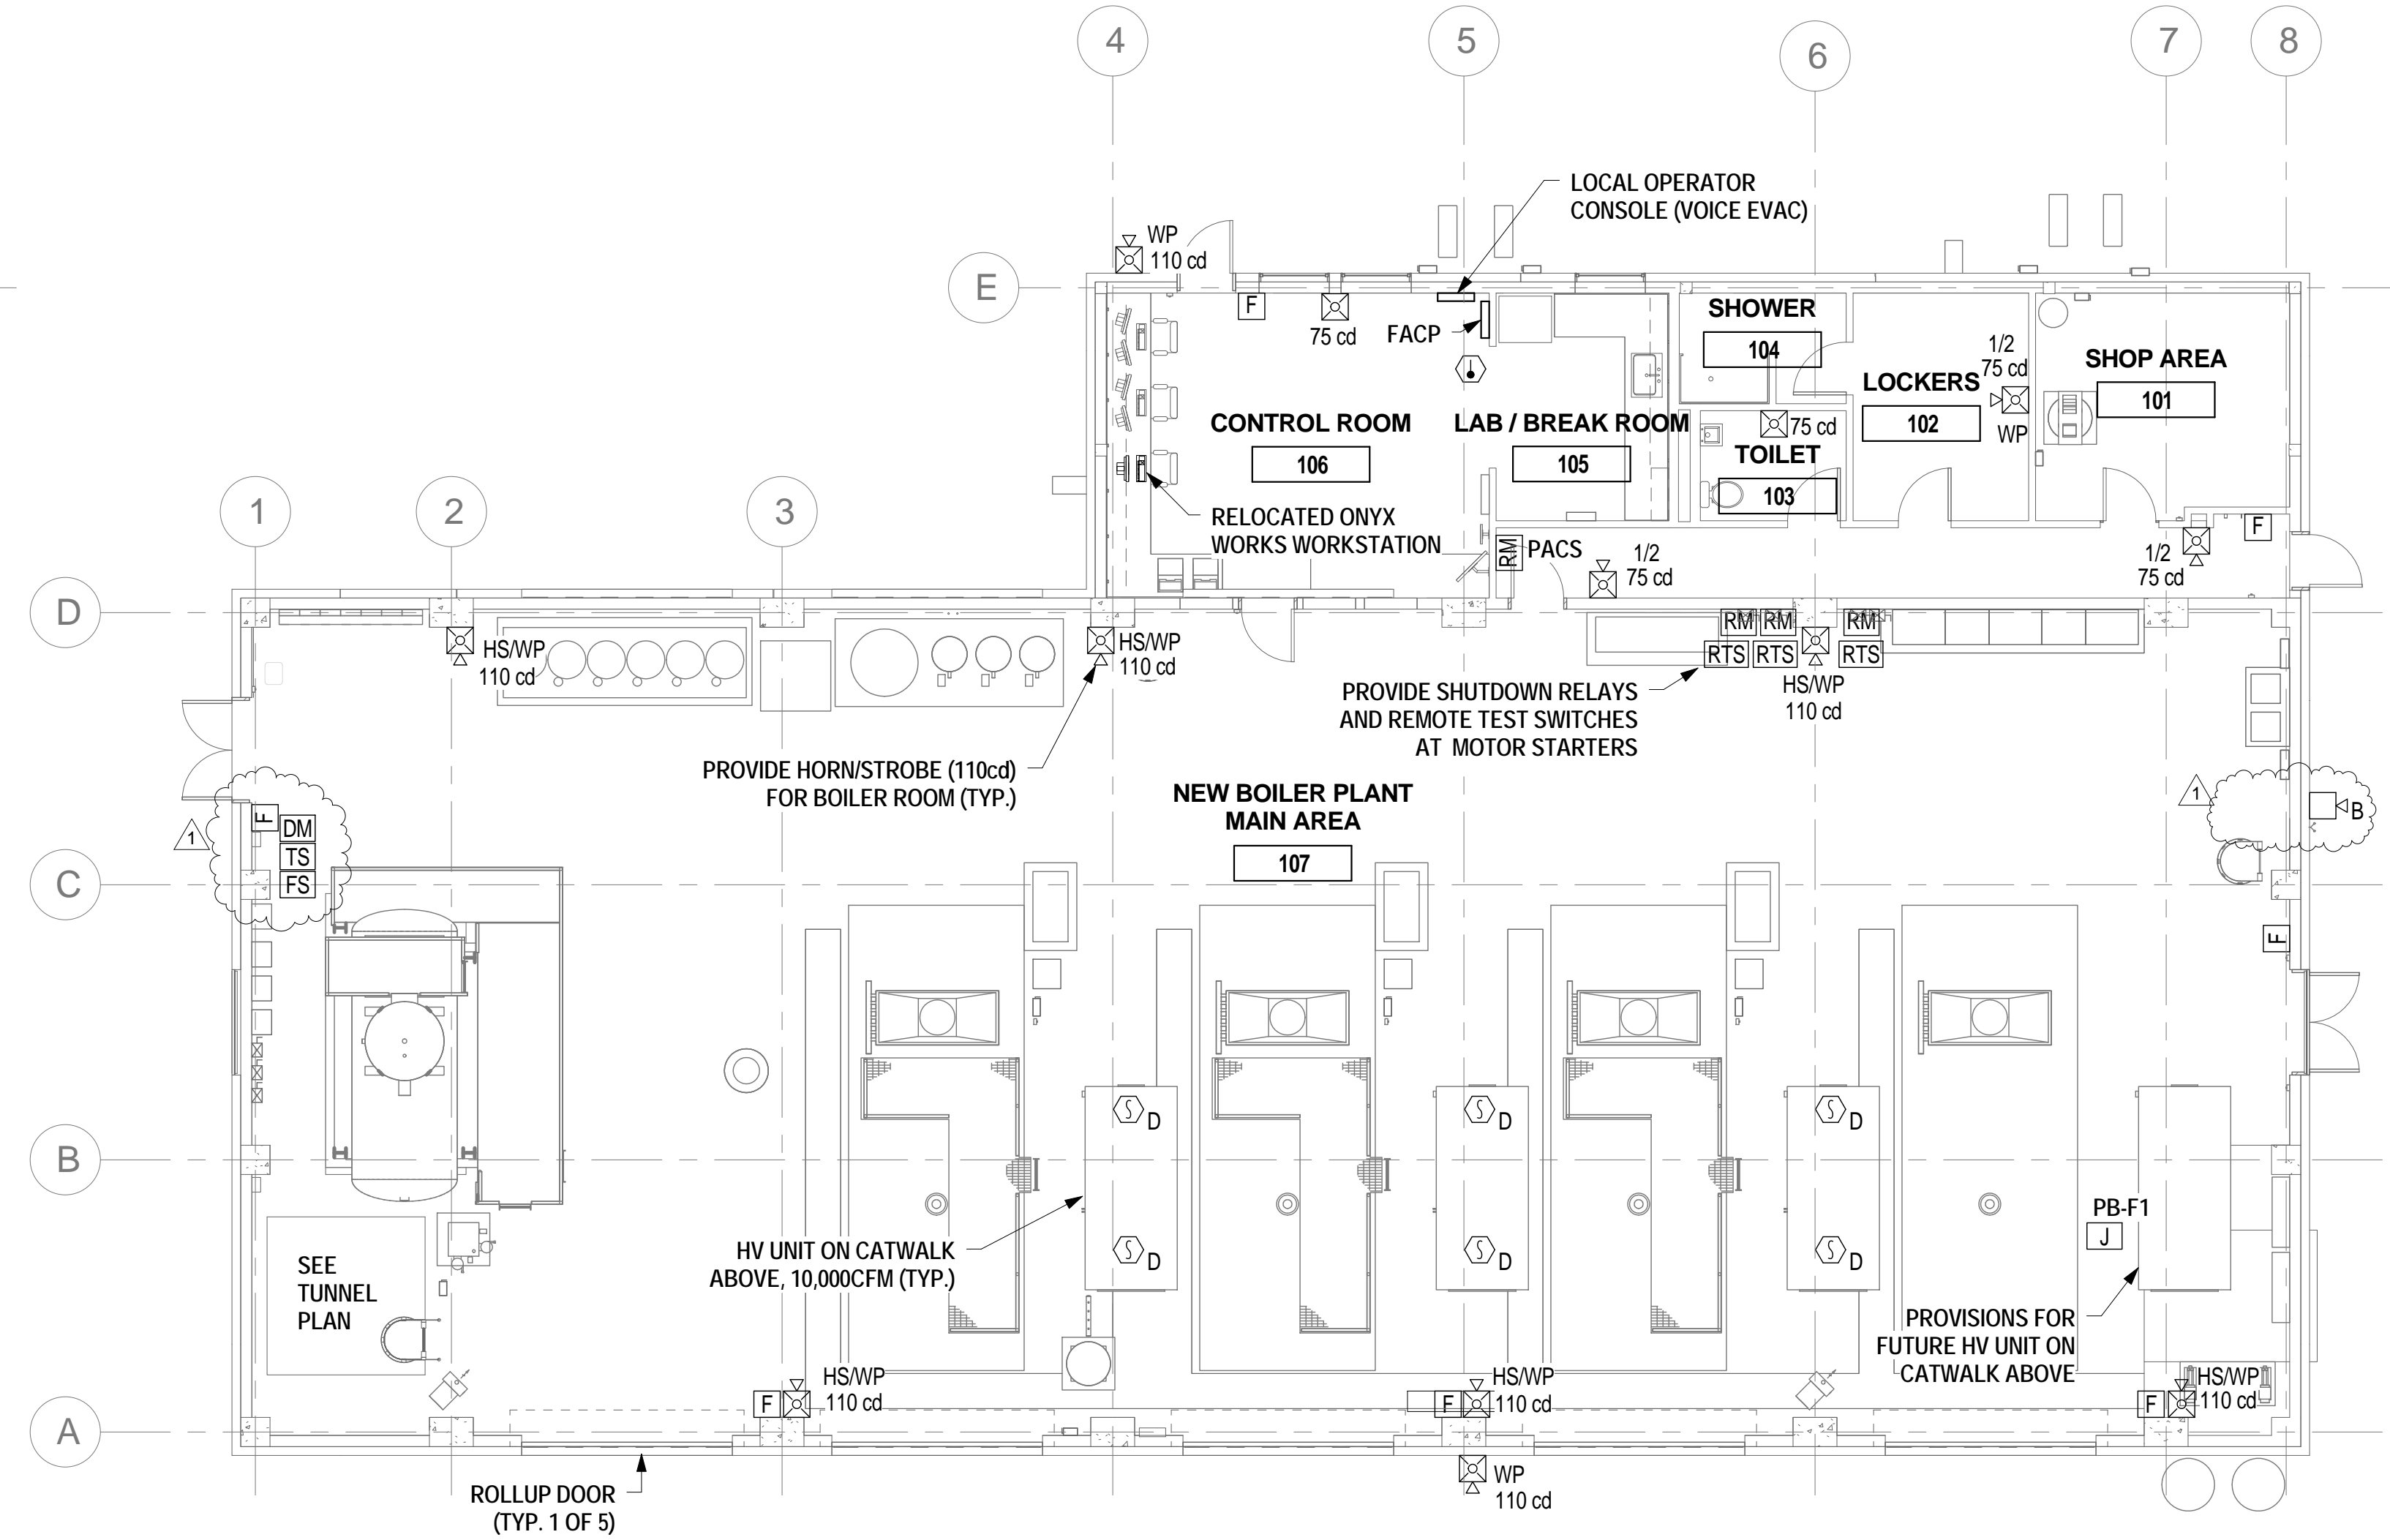


3 BOILER PLANT - BELOW GRADE - FIRE ALARM
1/8" = 1'-0"



 1 BOILER PLANT - FIRE ALARM
1/8" = 1'-0"

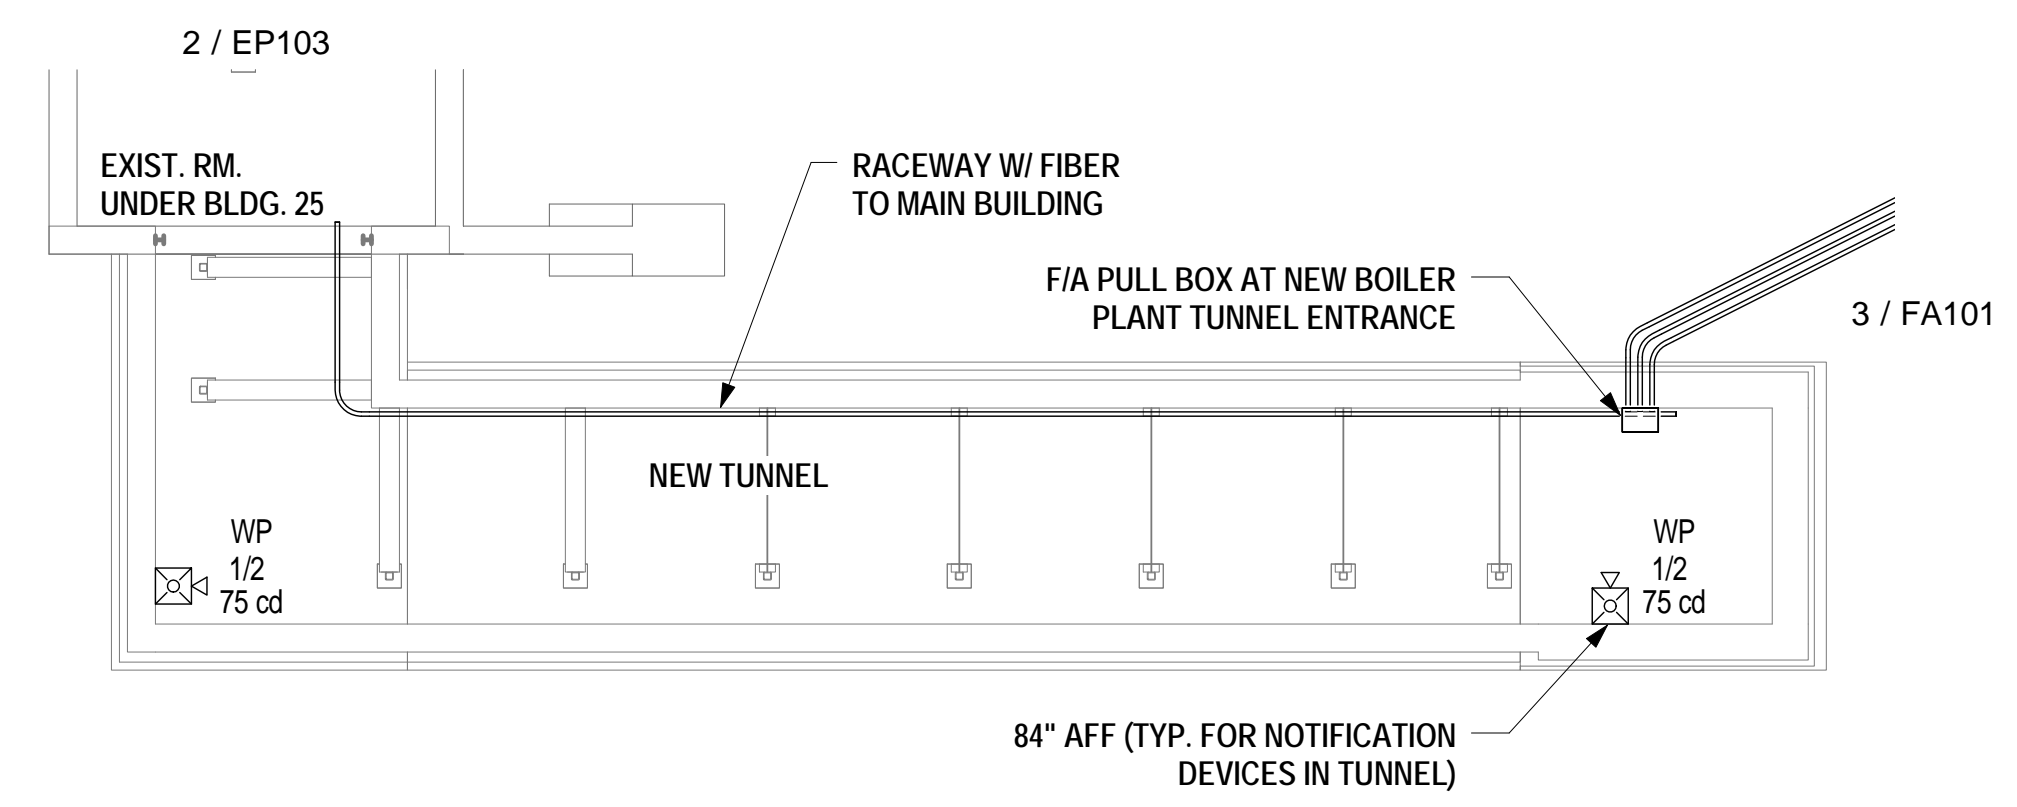


2 NEW TUNNEL - FIRE ALARM
1/8" = 1'-0"

 

FULLY SPRINKLERED BUILDING
FINAL DESIGN
APPROVED FOR CONSTRUCTION

| | | | | | | | | | | |
|---|--------------|--|--|----------------------------|--|--|--------------|-------------------------|--|--|
| <div>REV 1 - SFCCP</div> <div>5/31/2018</div> <div>Revisions:</div> <div>Date</div> | CONSULTANTS: | ENGINEER-OF-RECORD CHAD J. FRALICK FL P.E. NO. 73811 | ARCHITECT/ENGINEERS: <div>AKEA INC. 3603 NW 98th Street, Suite B Gainesville, FL 32606 Phone: (352) 474-6124 Fax: (352) 553-4437 COA: FL #26693 AKEA Project No. 083-14</div> | Drawing Title | | Project Title | | Project Number | | Office of Construction and Facilities Management |
| | | | | FIRE ALARM FLOOR PLANS | | REPLACE BOILERS - FCA D, ENERGY AT THE MALCOM RANDALL VAMC | | 573-14-600 | | |
| | | | | Approved: Project Director | | Location GAINESVILLE, FLORIDA | | Building Number | | |
| | | | | Date FEBRUARY 28, 2018 | | Checked CJF | Drawn CJF | Drawing Number FA101 | | |
| | | | | | | | | | | |

 Department of Veterans Affairs