
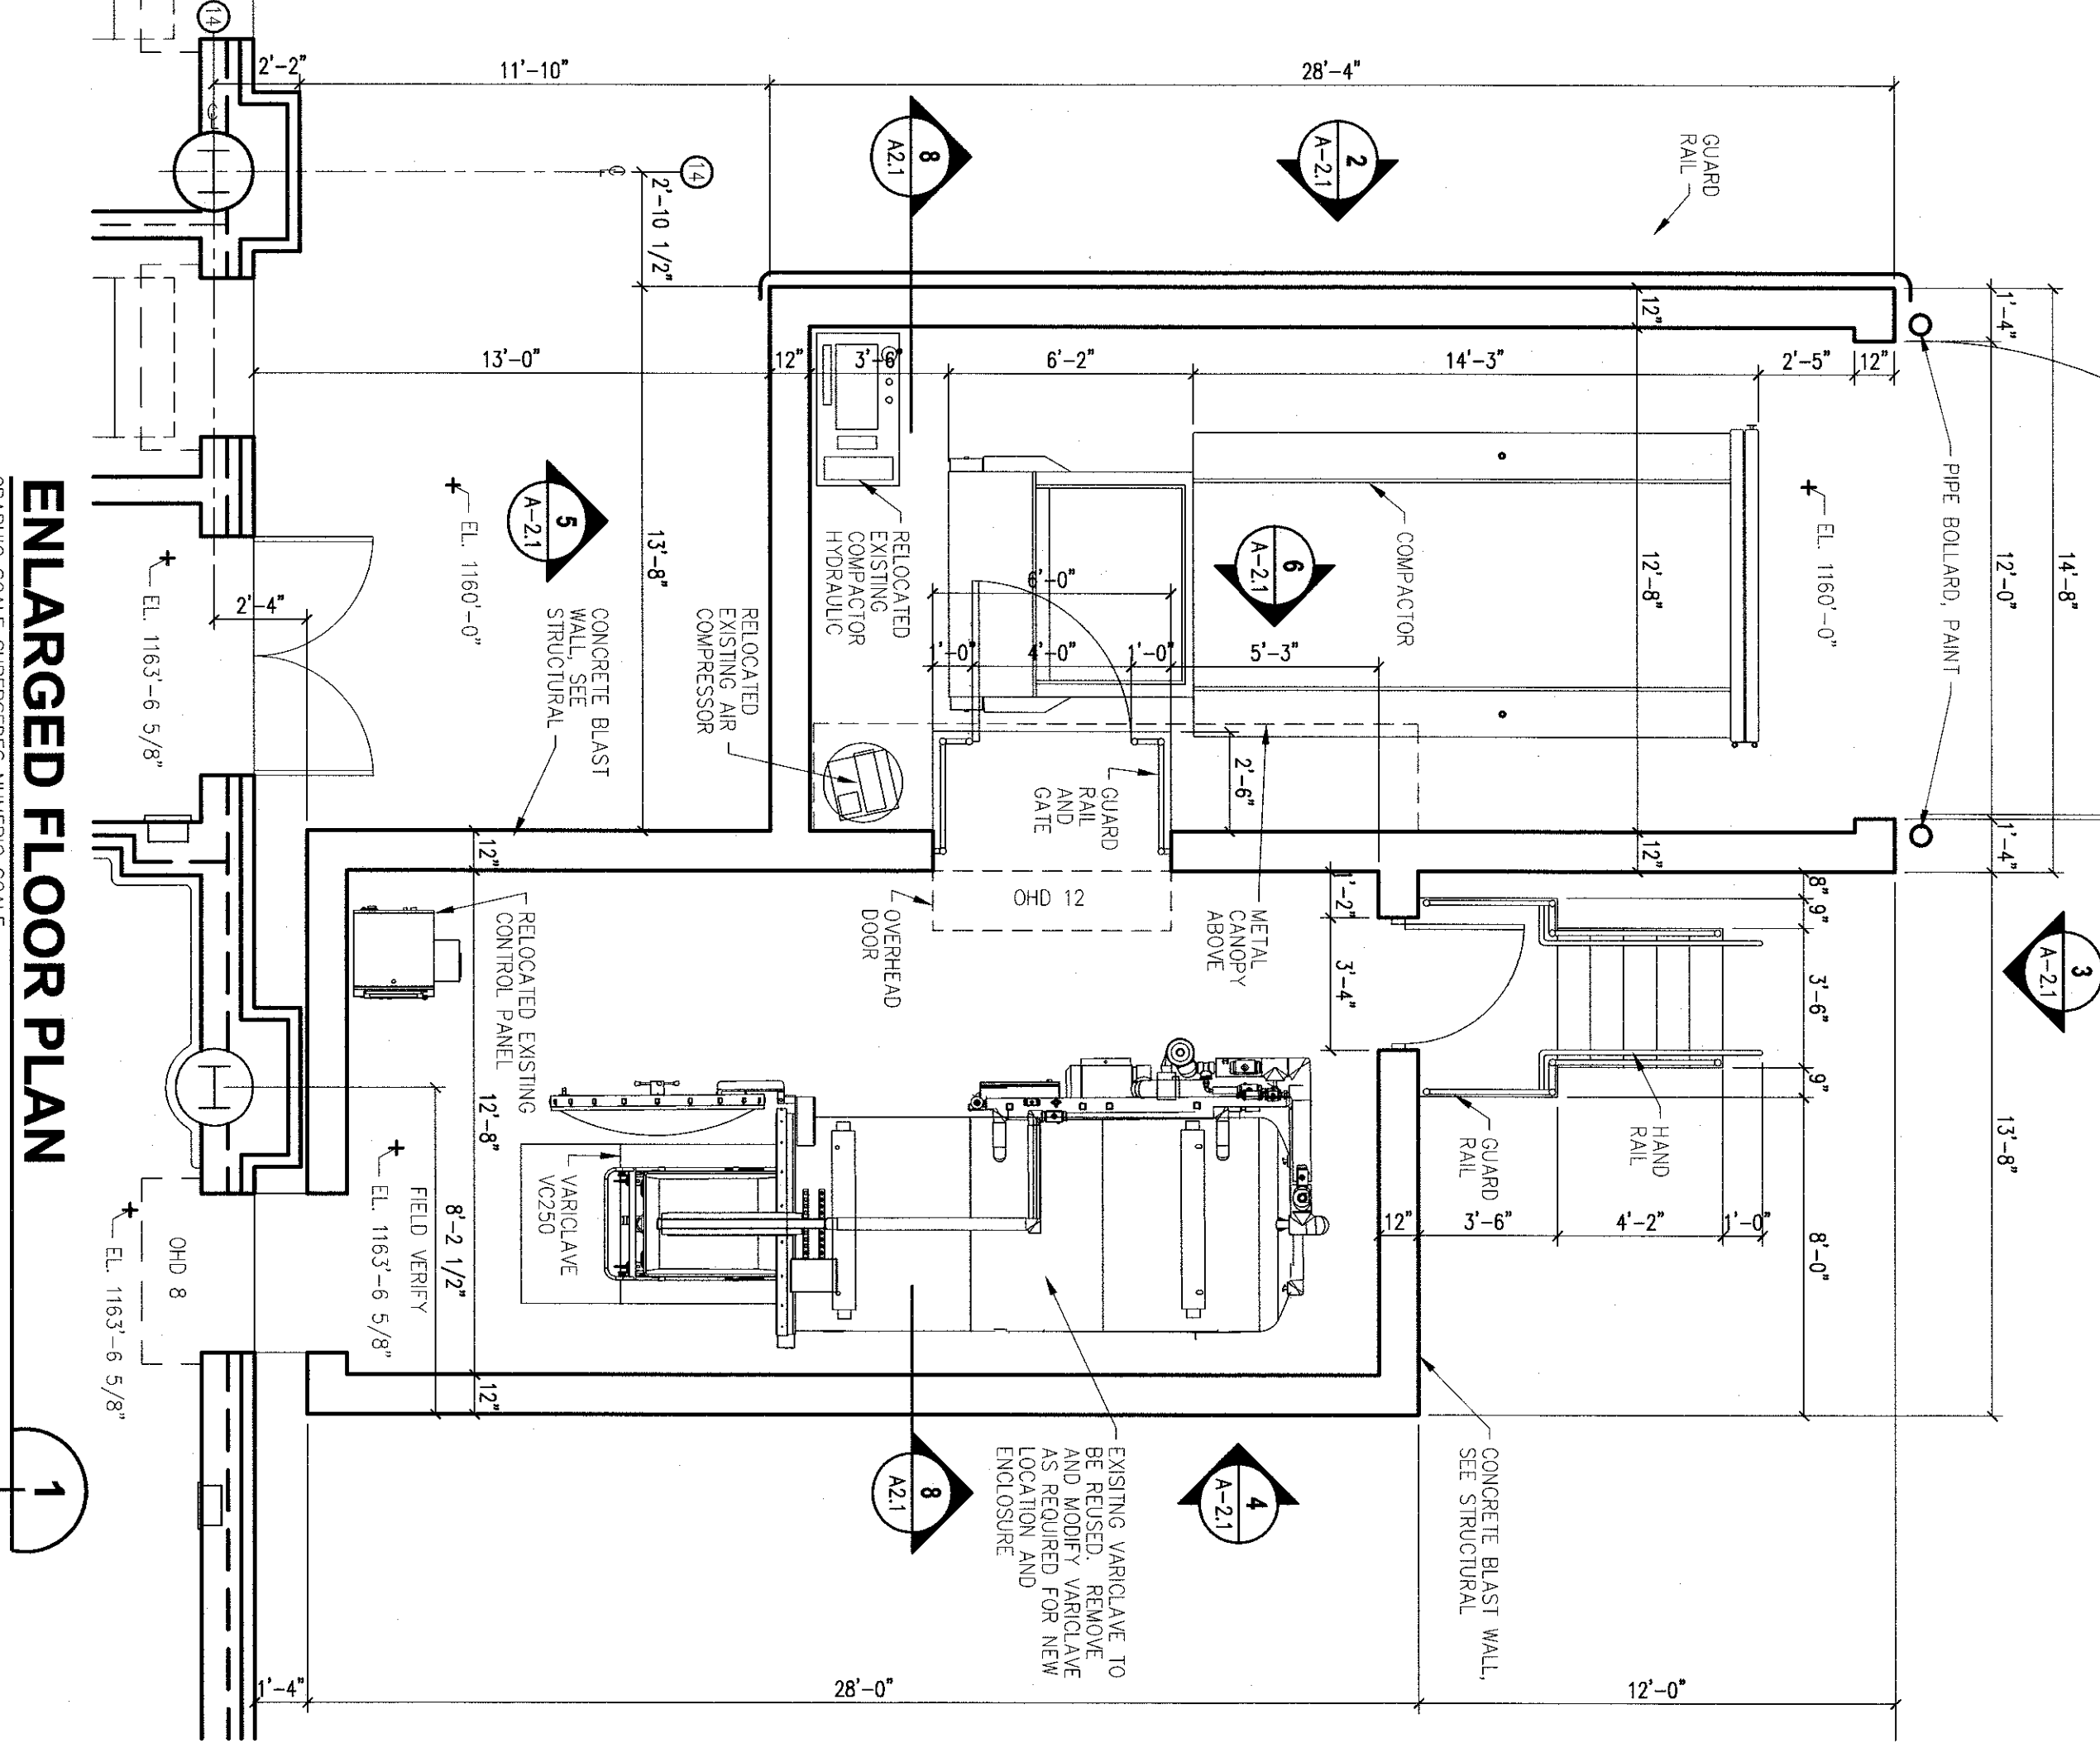
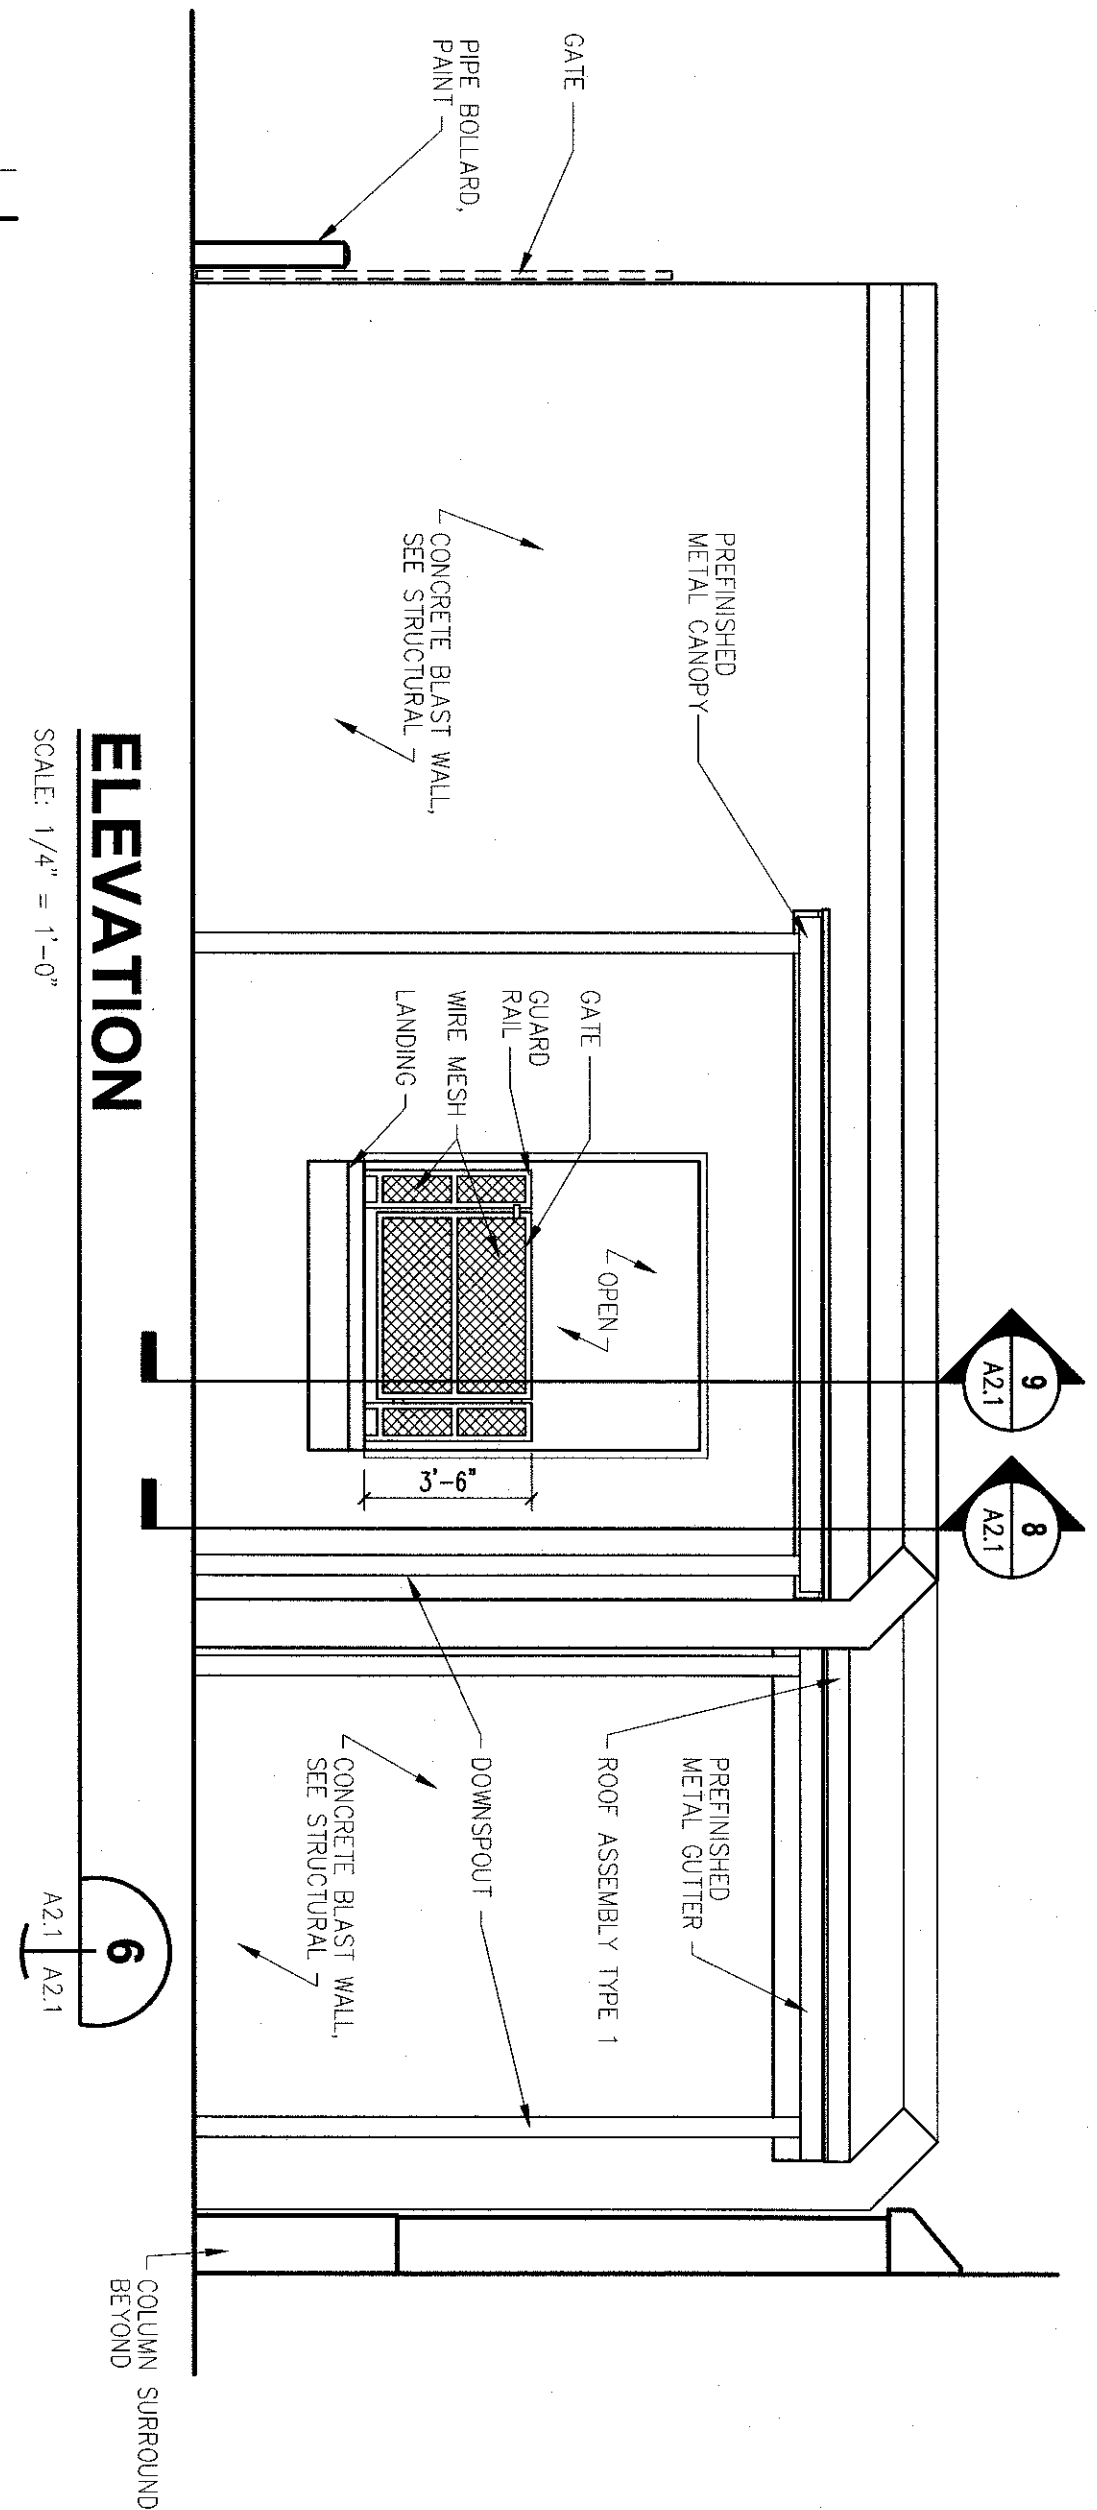
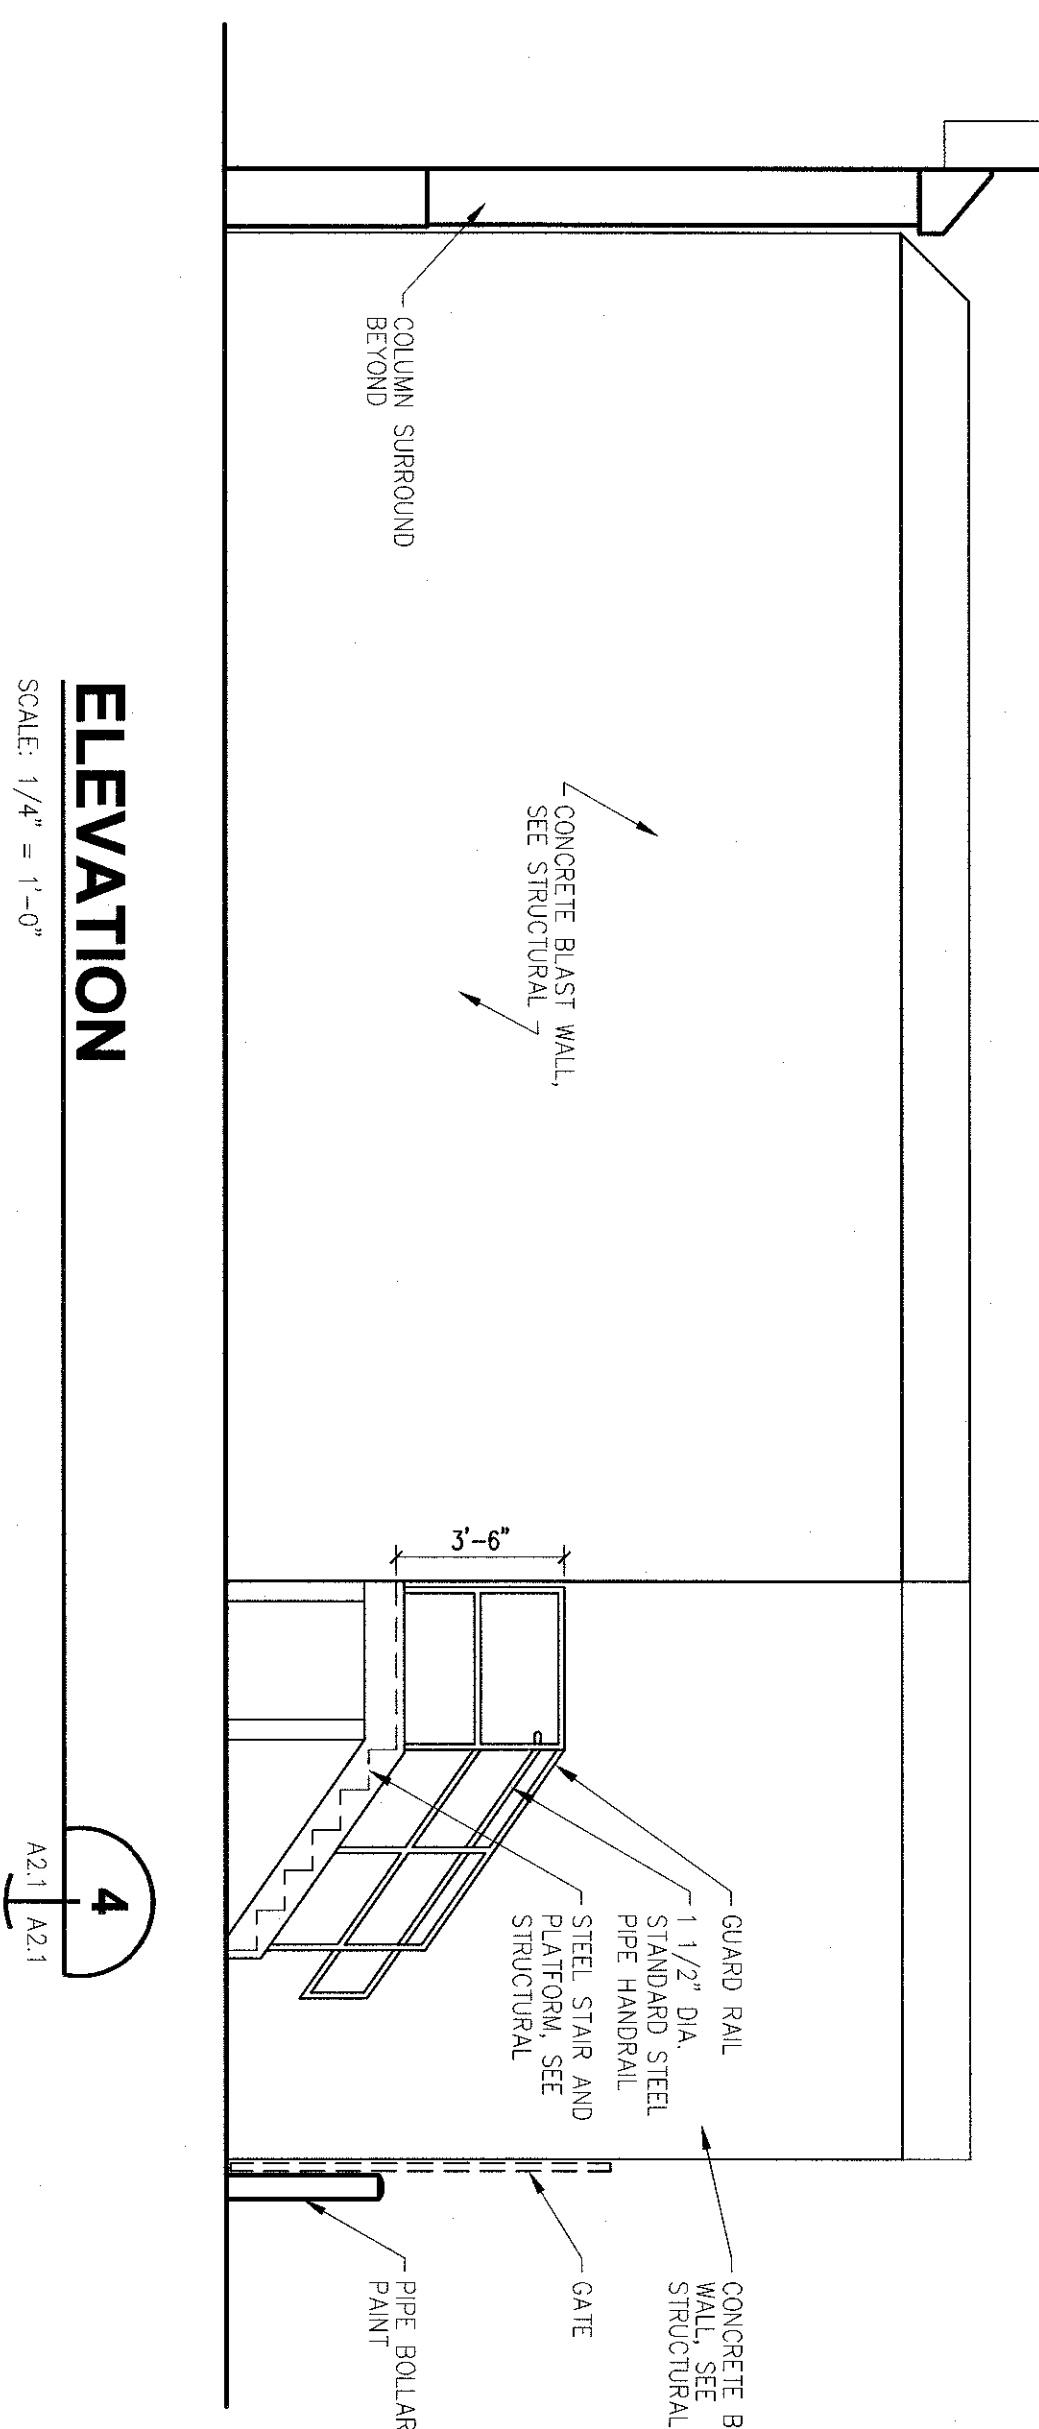


SECTION
GRAPHIC SCALE SUPERSEDES NUMERIC SCALE
0 1' 2' 4'
SCALE: 1/2" = 1'-0"

SECTION
GRAPHIC SCALE SUPERSEDES NUMERIC SCALE
0 1' 2' 4'
SCALE: 1/2" = 1'-0"



ROOF PLAN
SCALE: 1/4" = 1'-0"

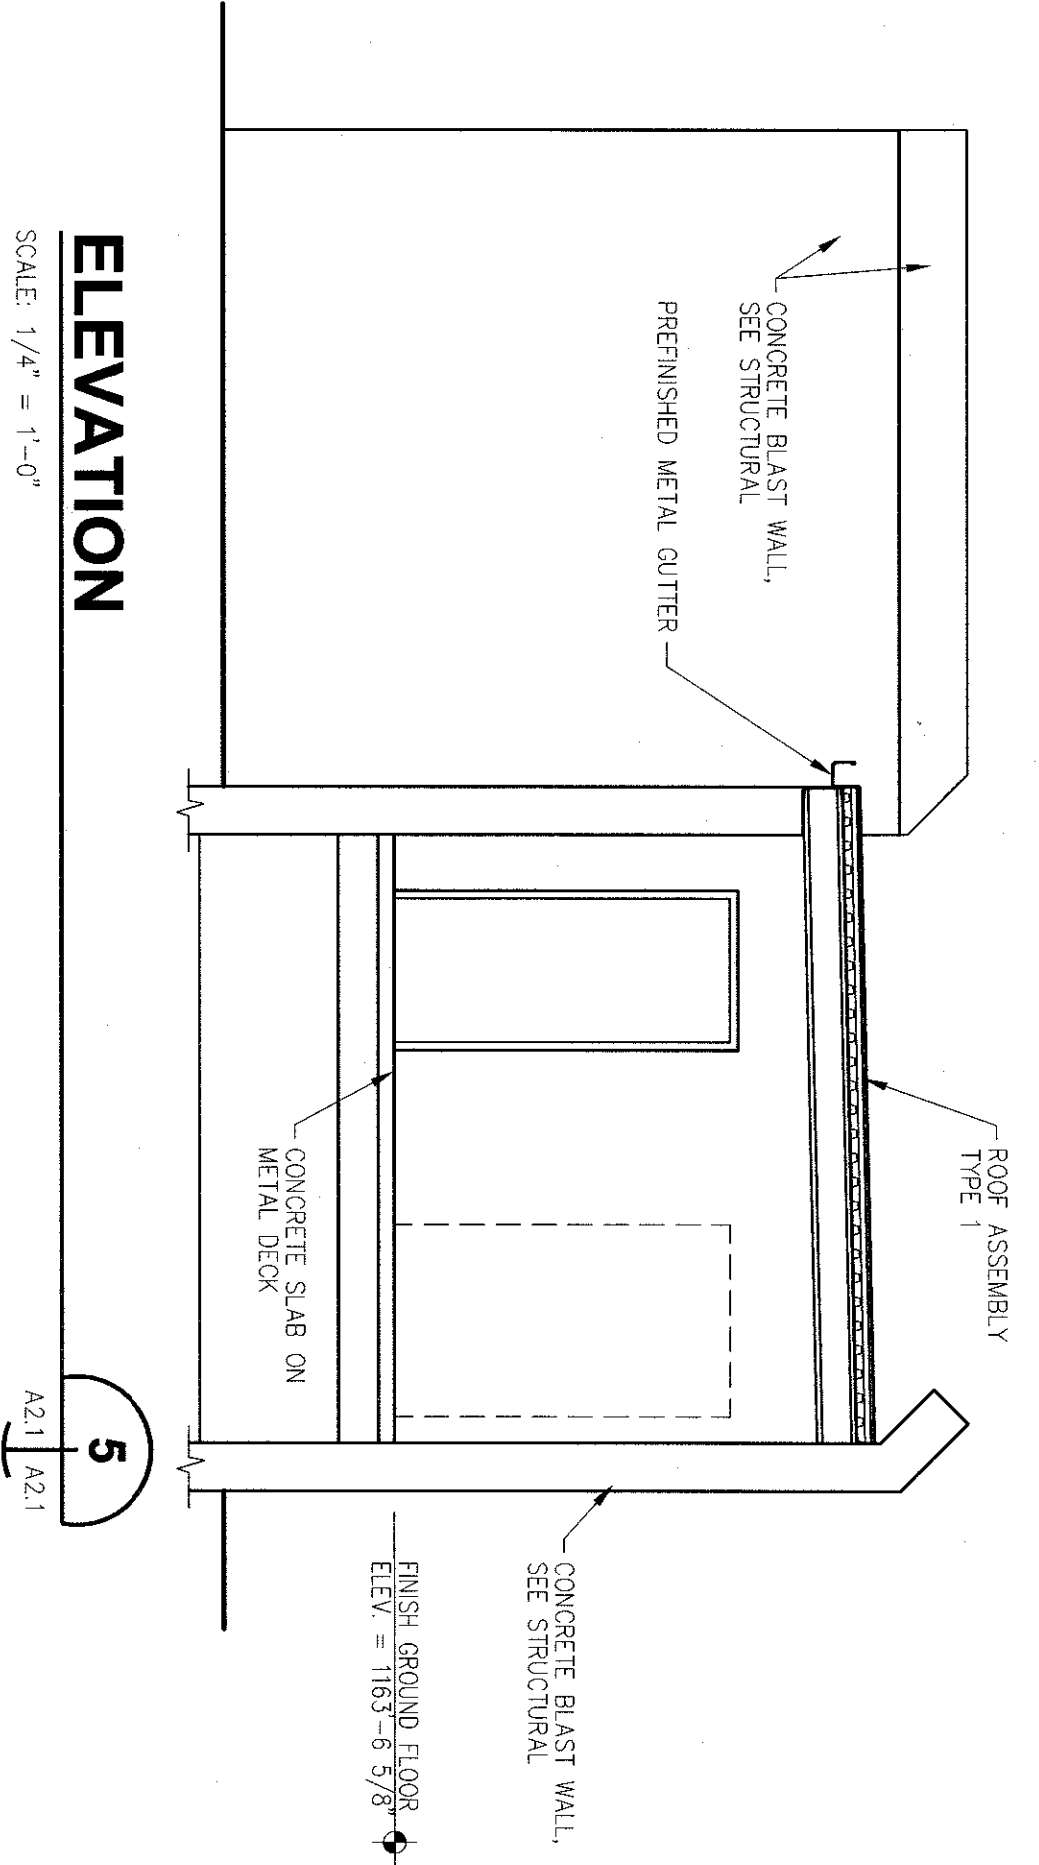

ELEVATION
SCALE: 1/4" = 1'-0"


ELEVATION
SCALE: 1/4" = 1'-0"

ENLARGED FLOOR PLAN
GRAPHIC SCALE SUPERSEDES NUMERIC SCALE
0 2' 4' 8'
SCALE: 1/4" = 1'-0"

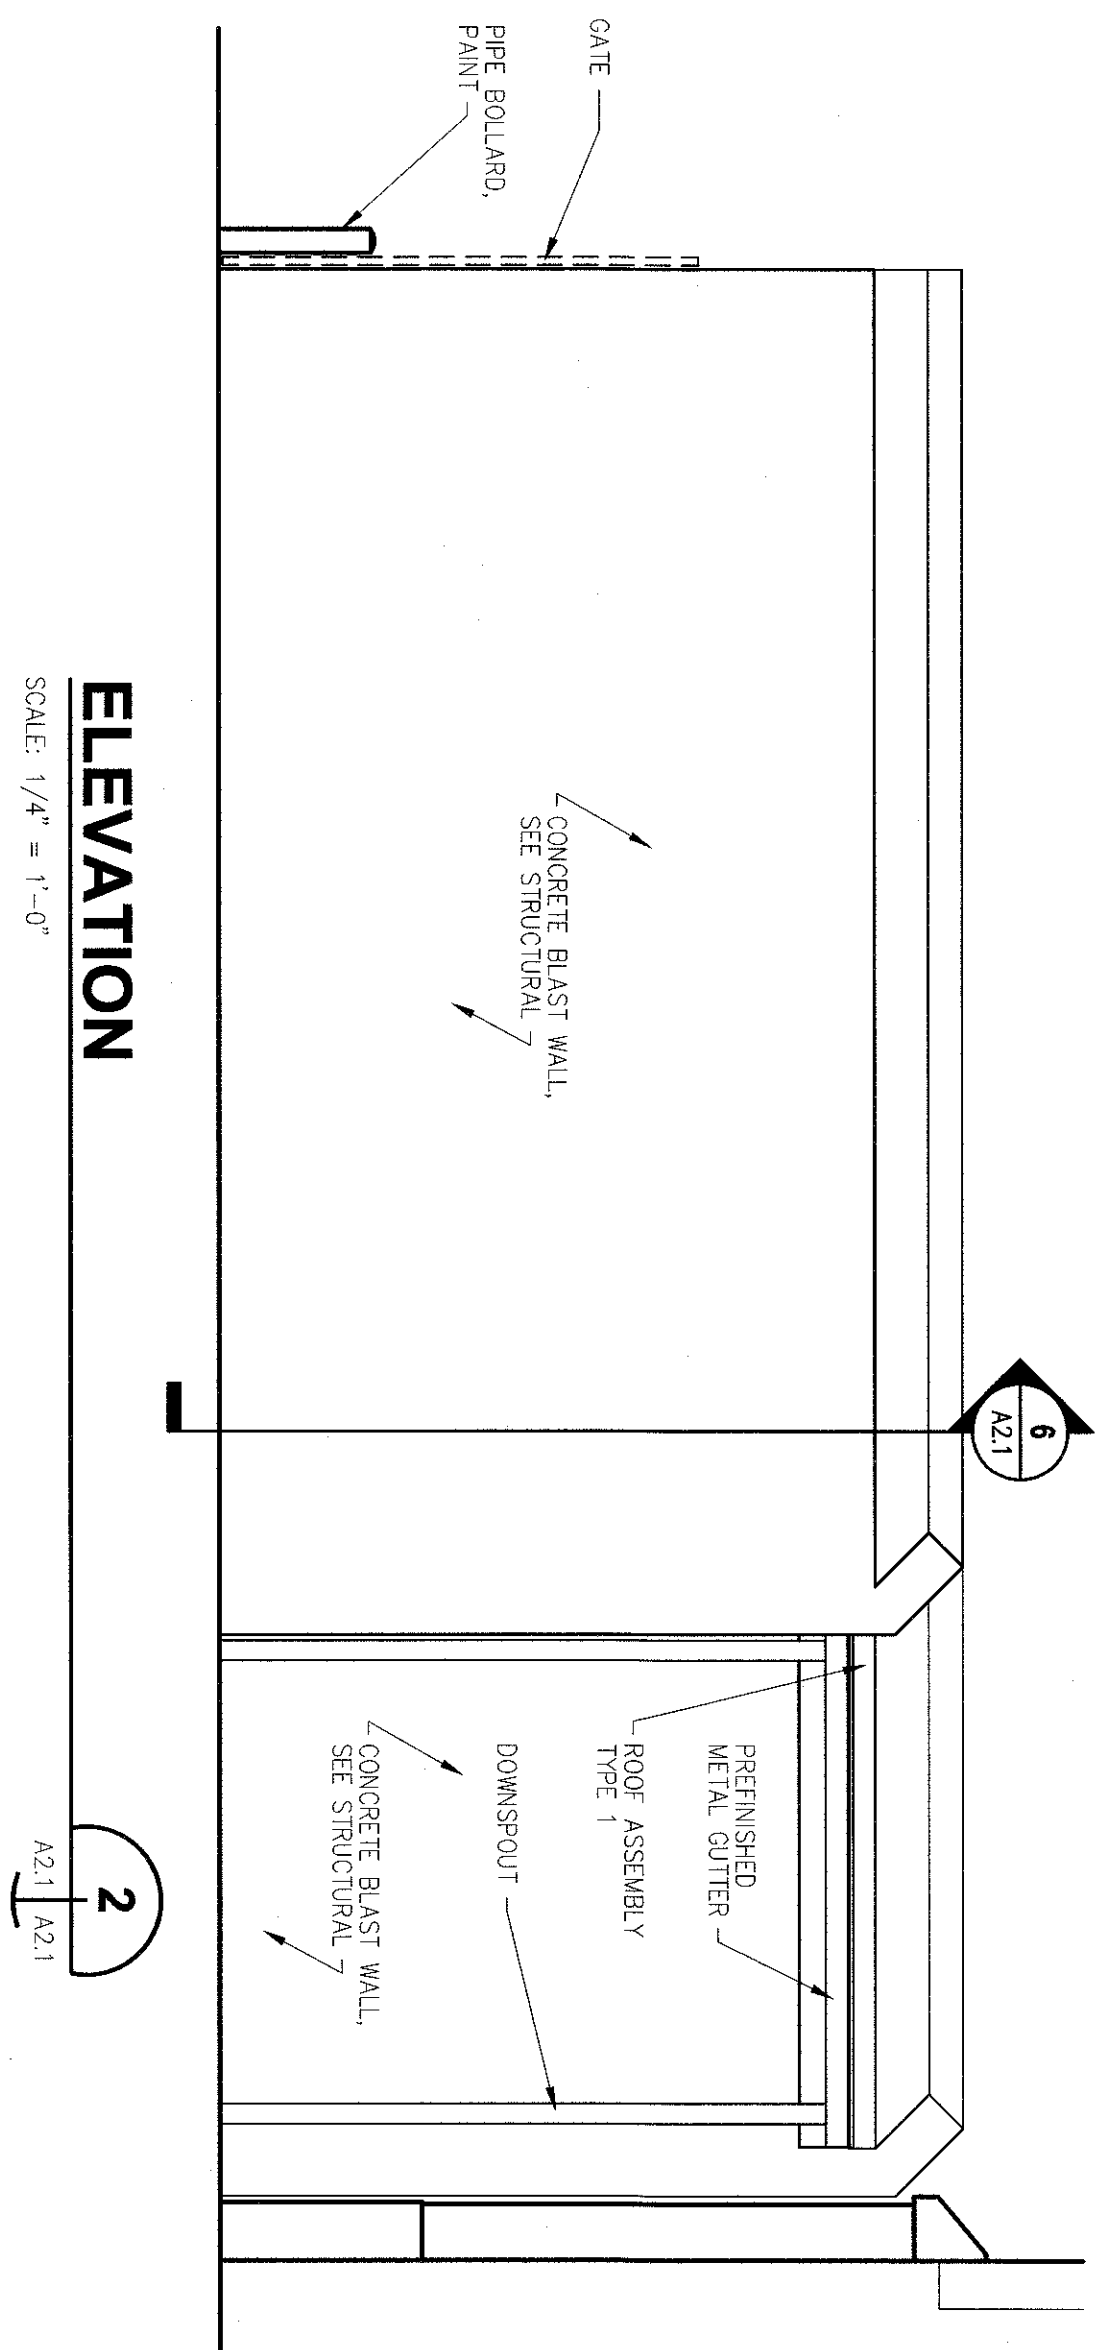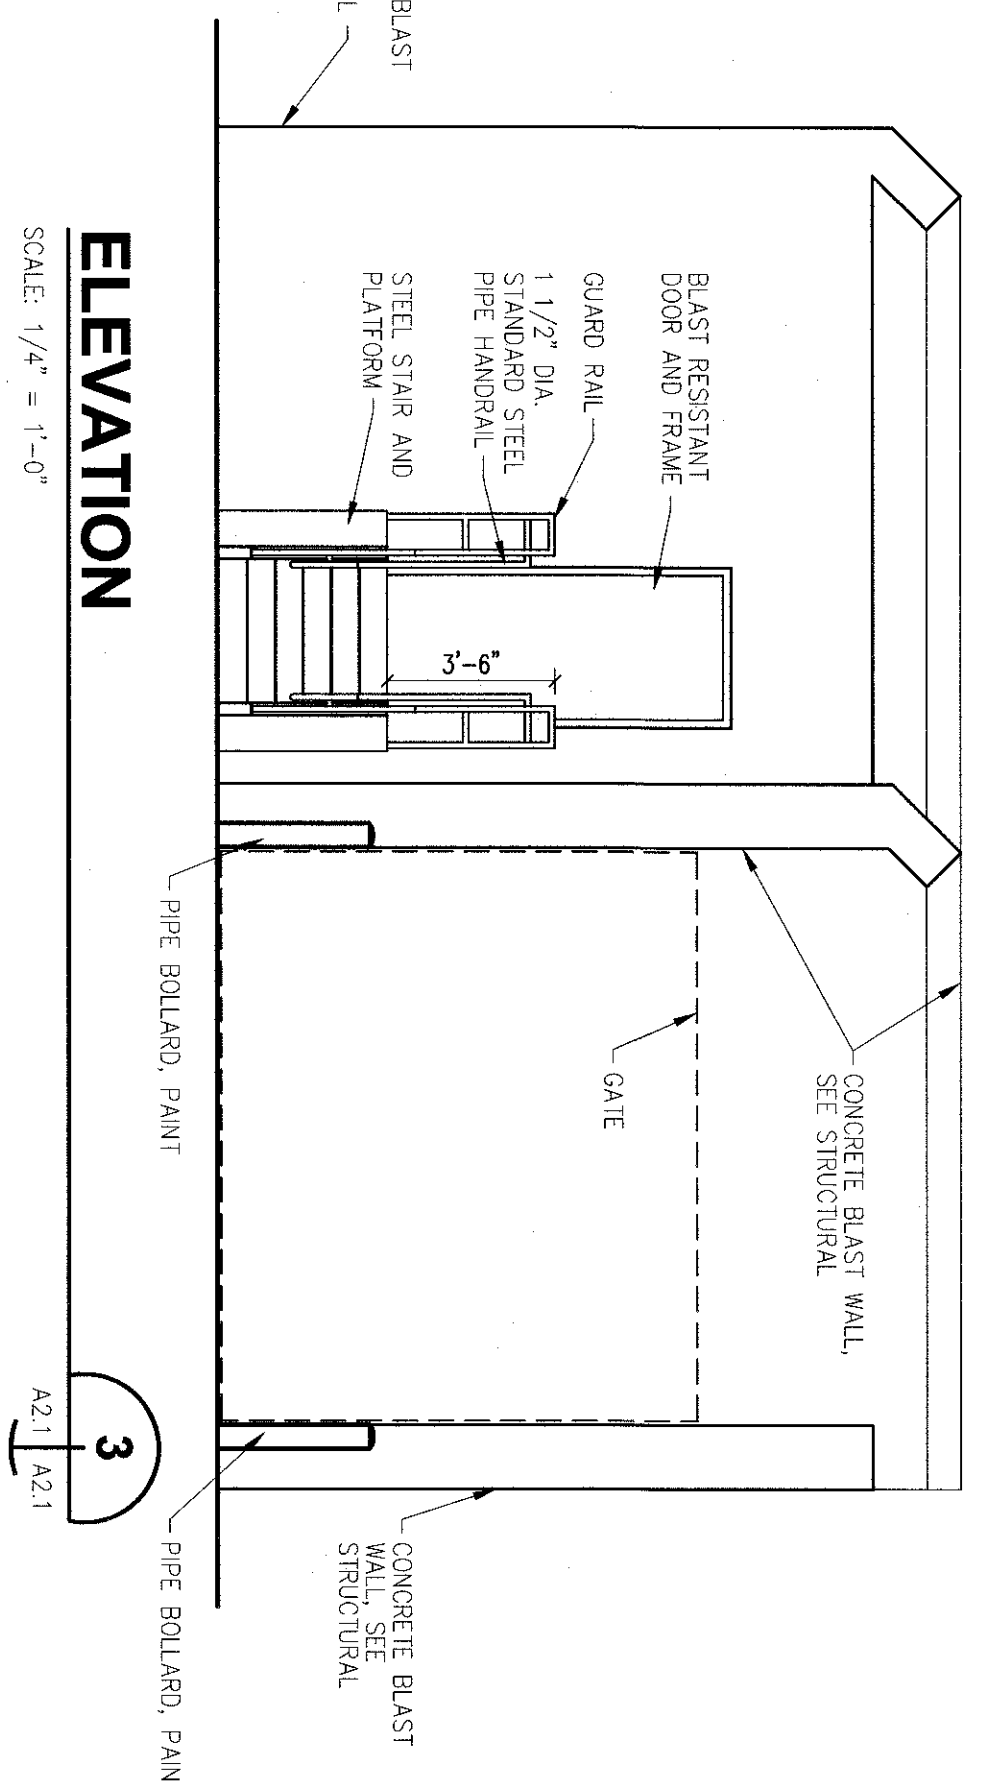

ELEVATION
SCALE: 1/4" = 1'-0"

ELEVATION
SCALE: 1/4" = 1'-0"

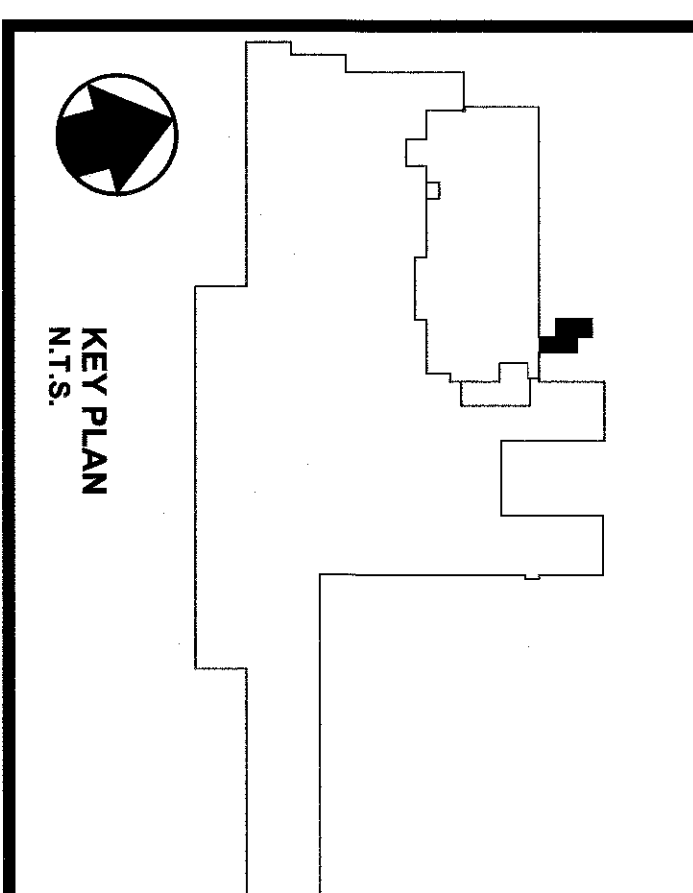

FULLY SPRINKLERED BUILDING
BID DOCUMENTS

NO.	REVISIONS	DATE
1		
2		
3		
4		
5		
6		
7		
8		



Department of
Veterans Affairs

UPGRADE SPD AND SECURITY DOCK
PROJECT: 646-367
VA PITTSBURGH
HEALTHCARE SYSTEM
UNIVERSITY DRIVE C
PITTSBURGH, PENNSYLVANIA 15240

PARADIGM
ENGINEERS AND CONSTRUCTORS
PO BOX 496828
Louisville, Kentucky 40253
502-339-8511 www.paradigmusa.com

