
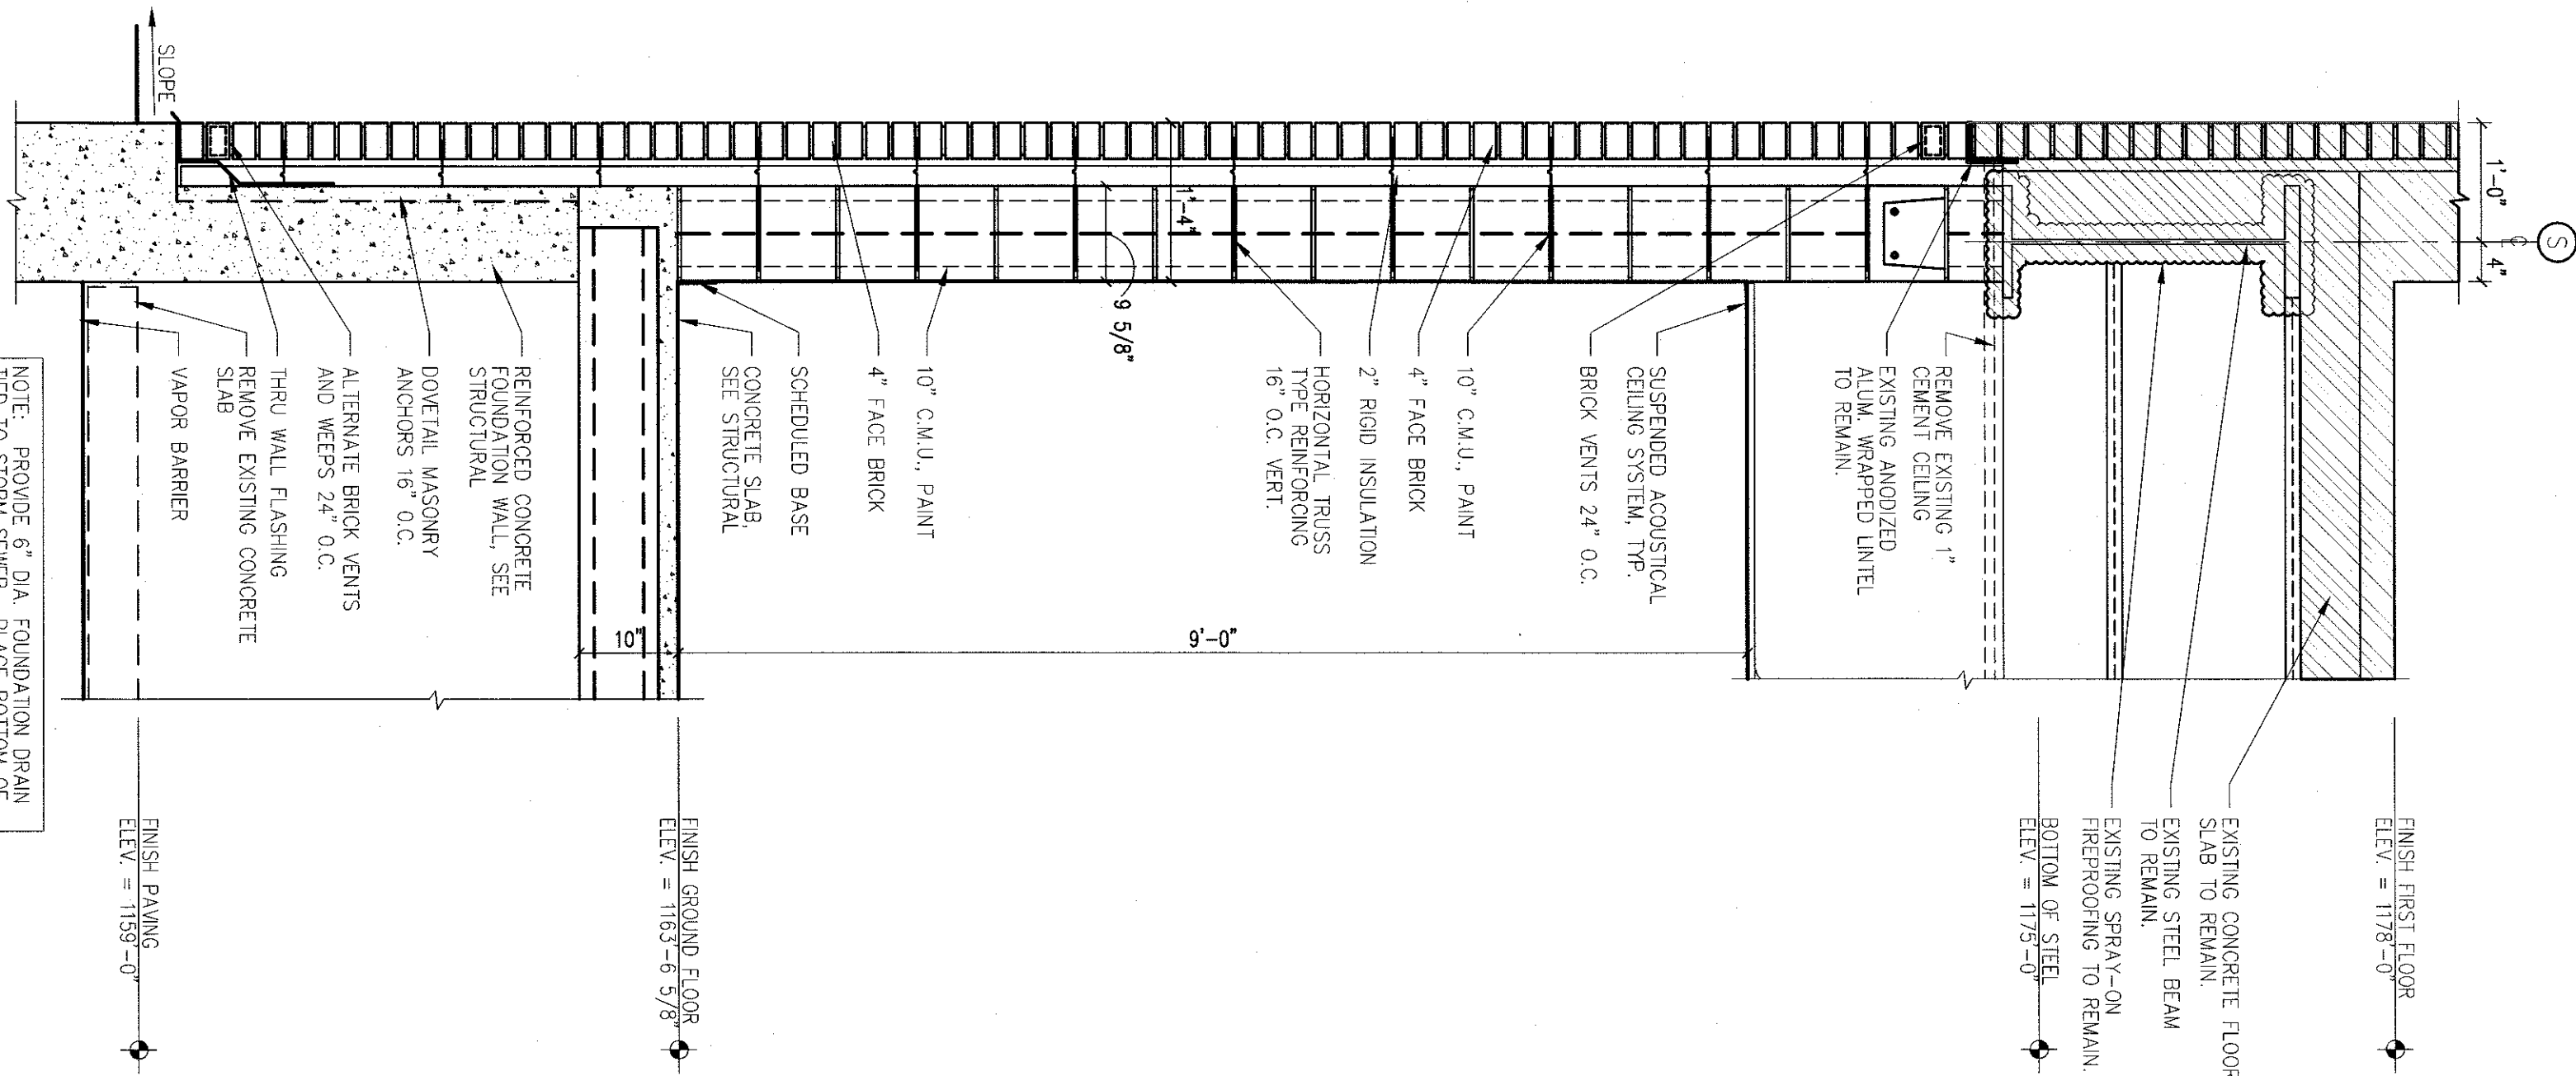
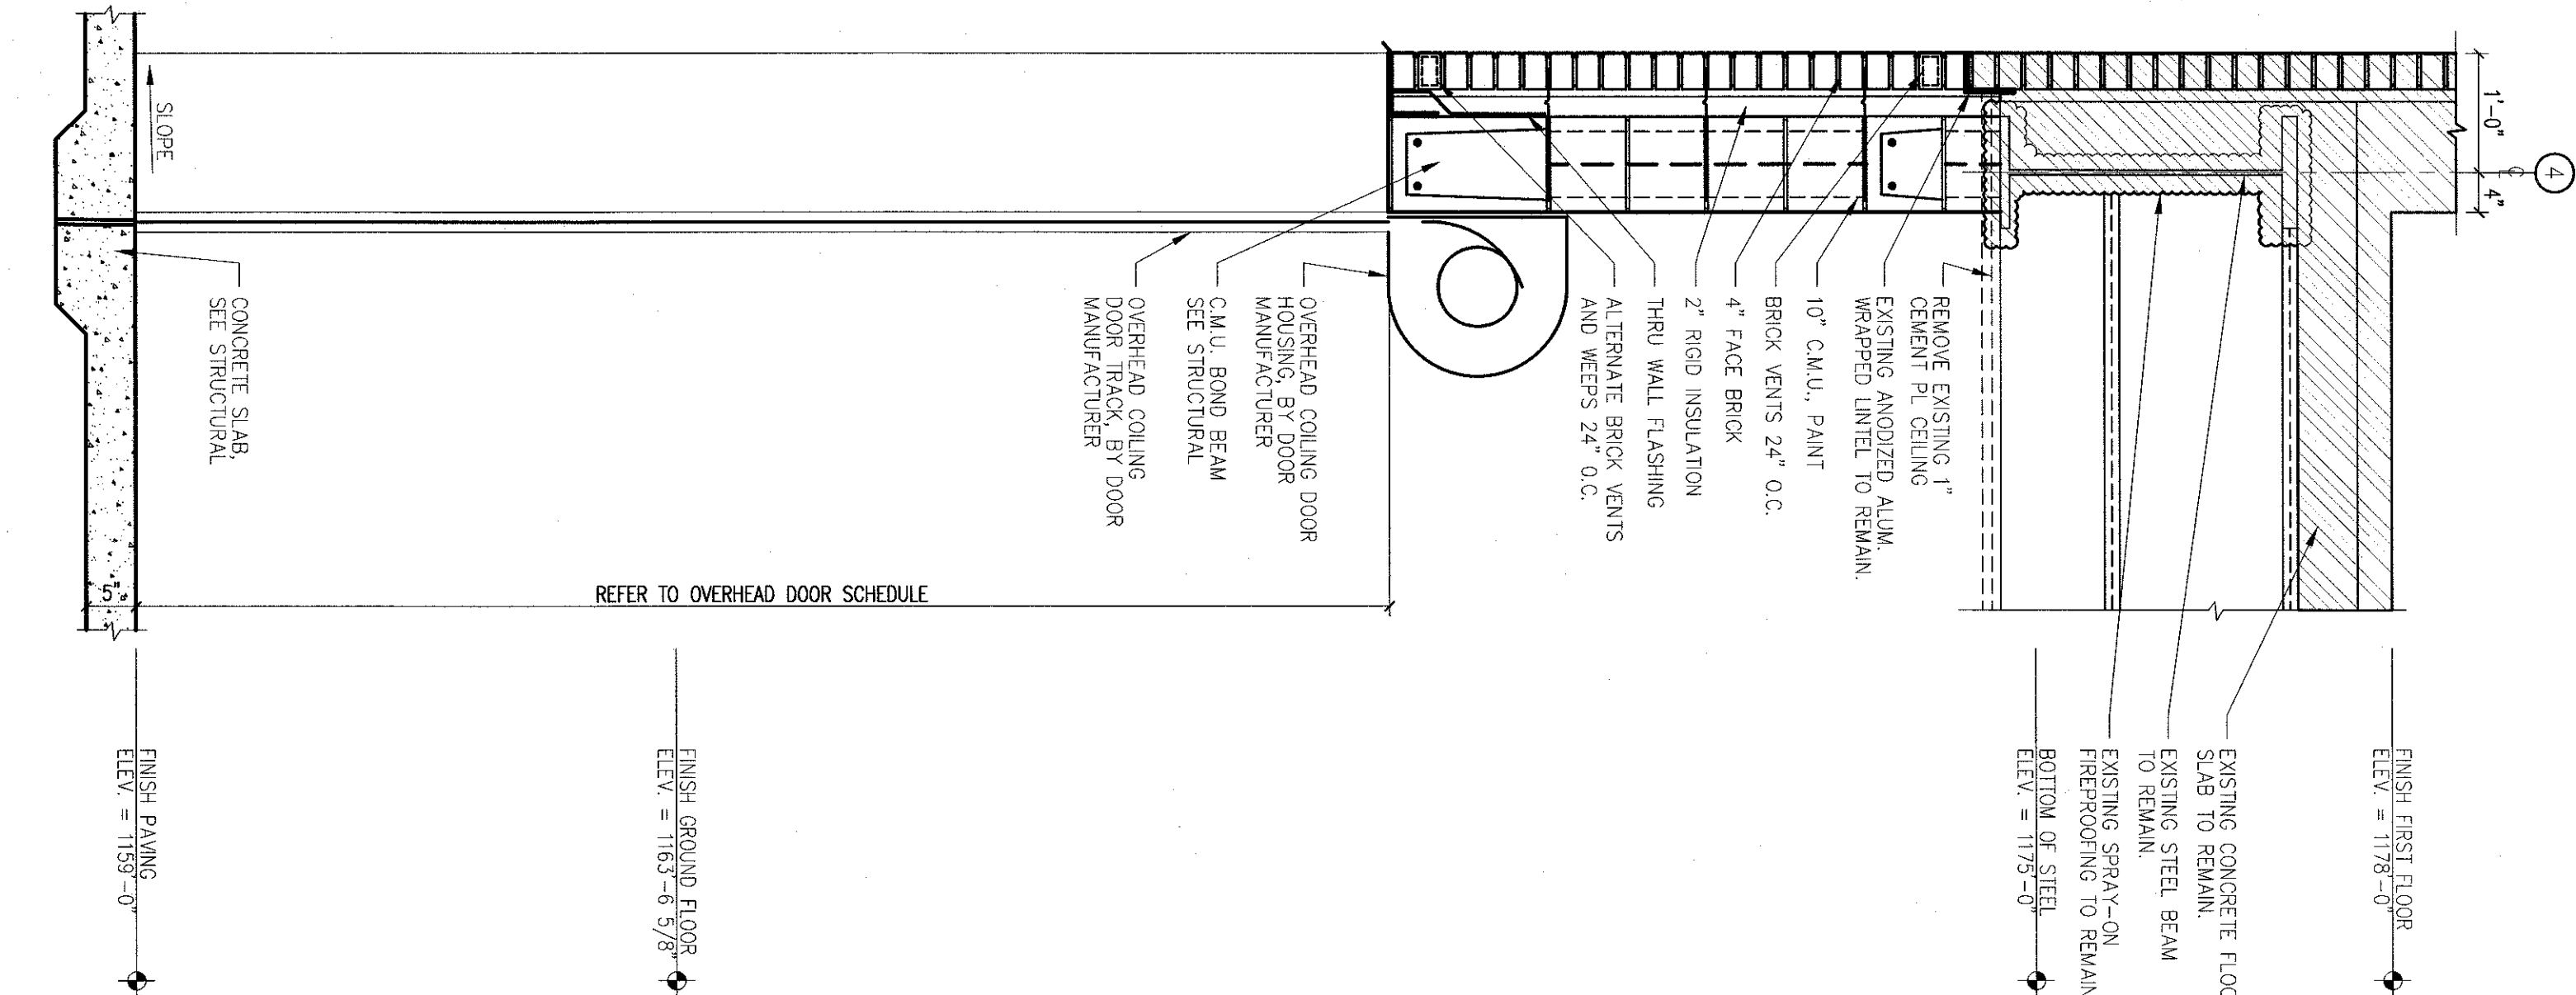
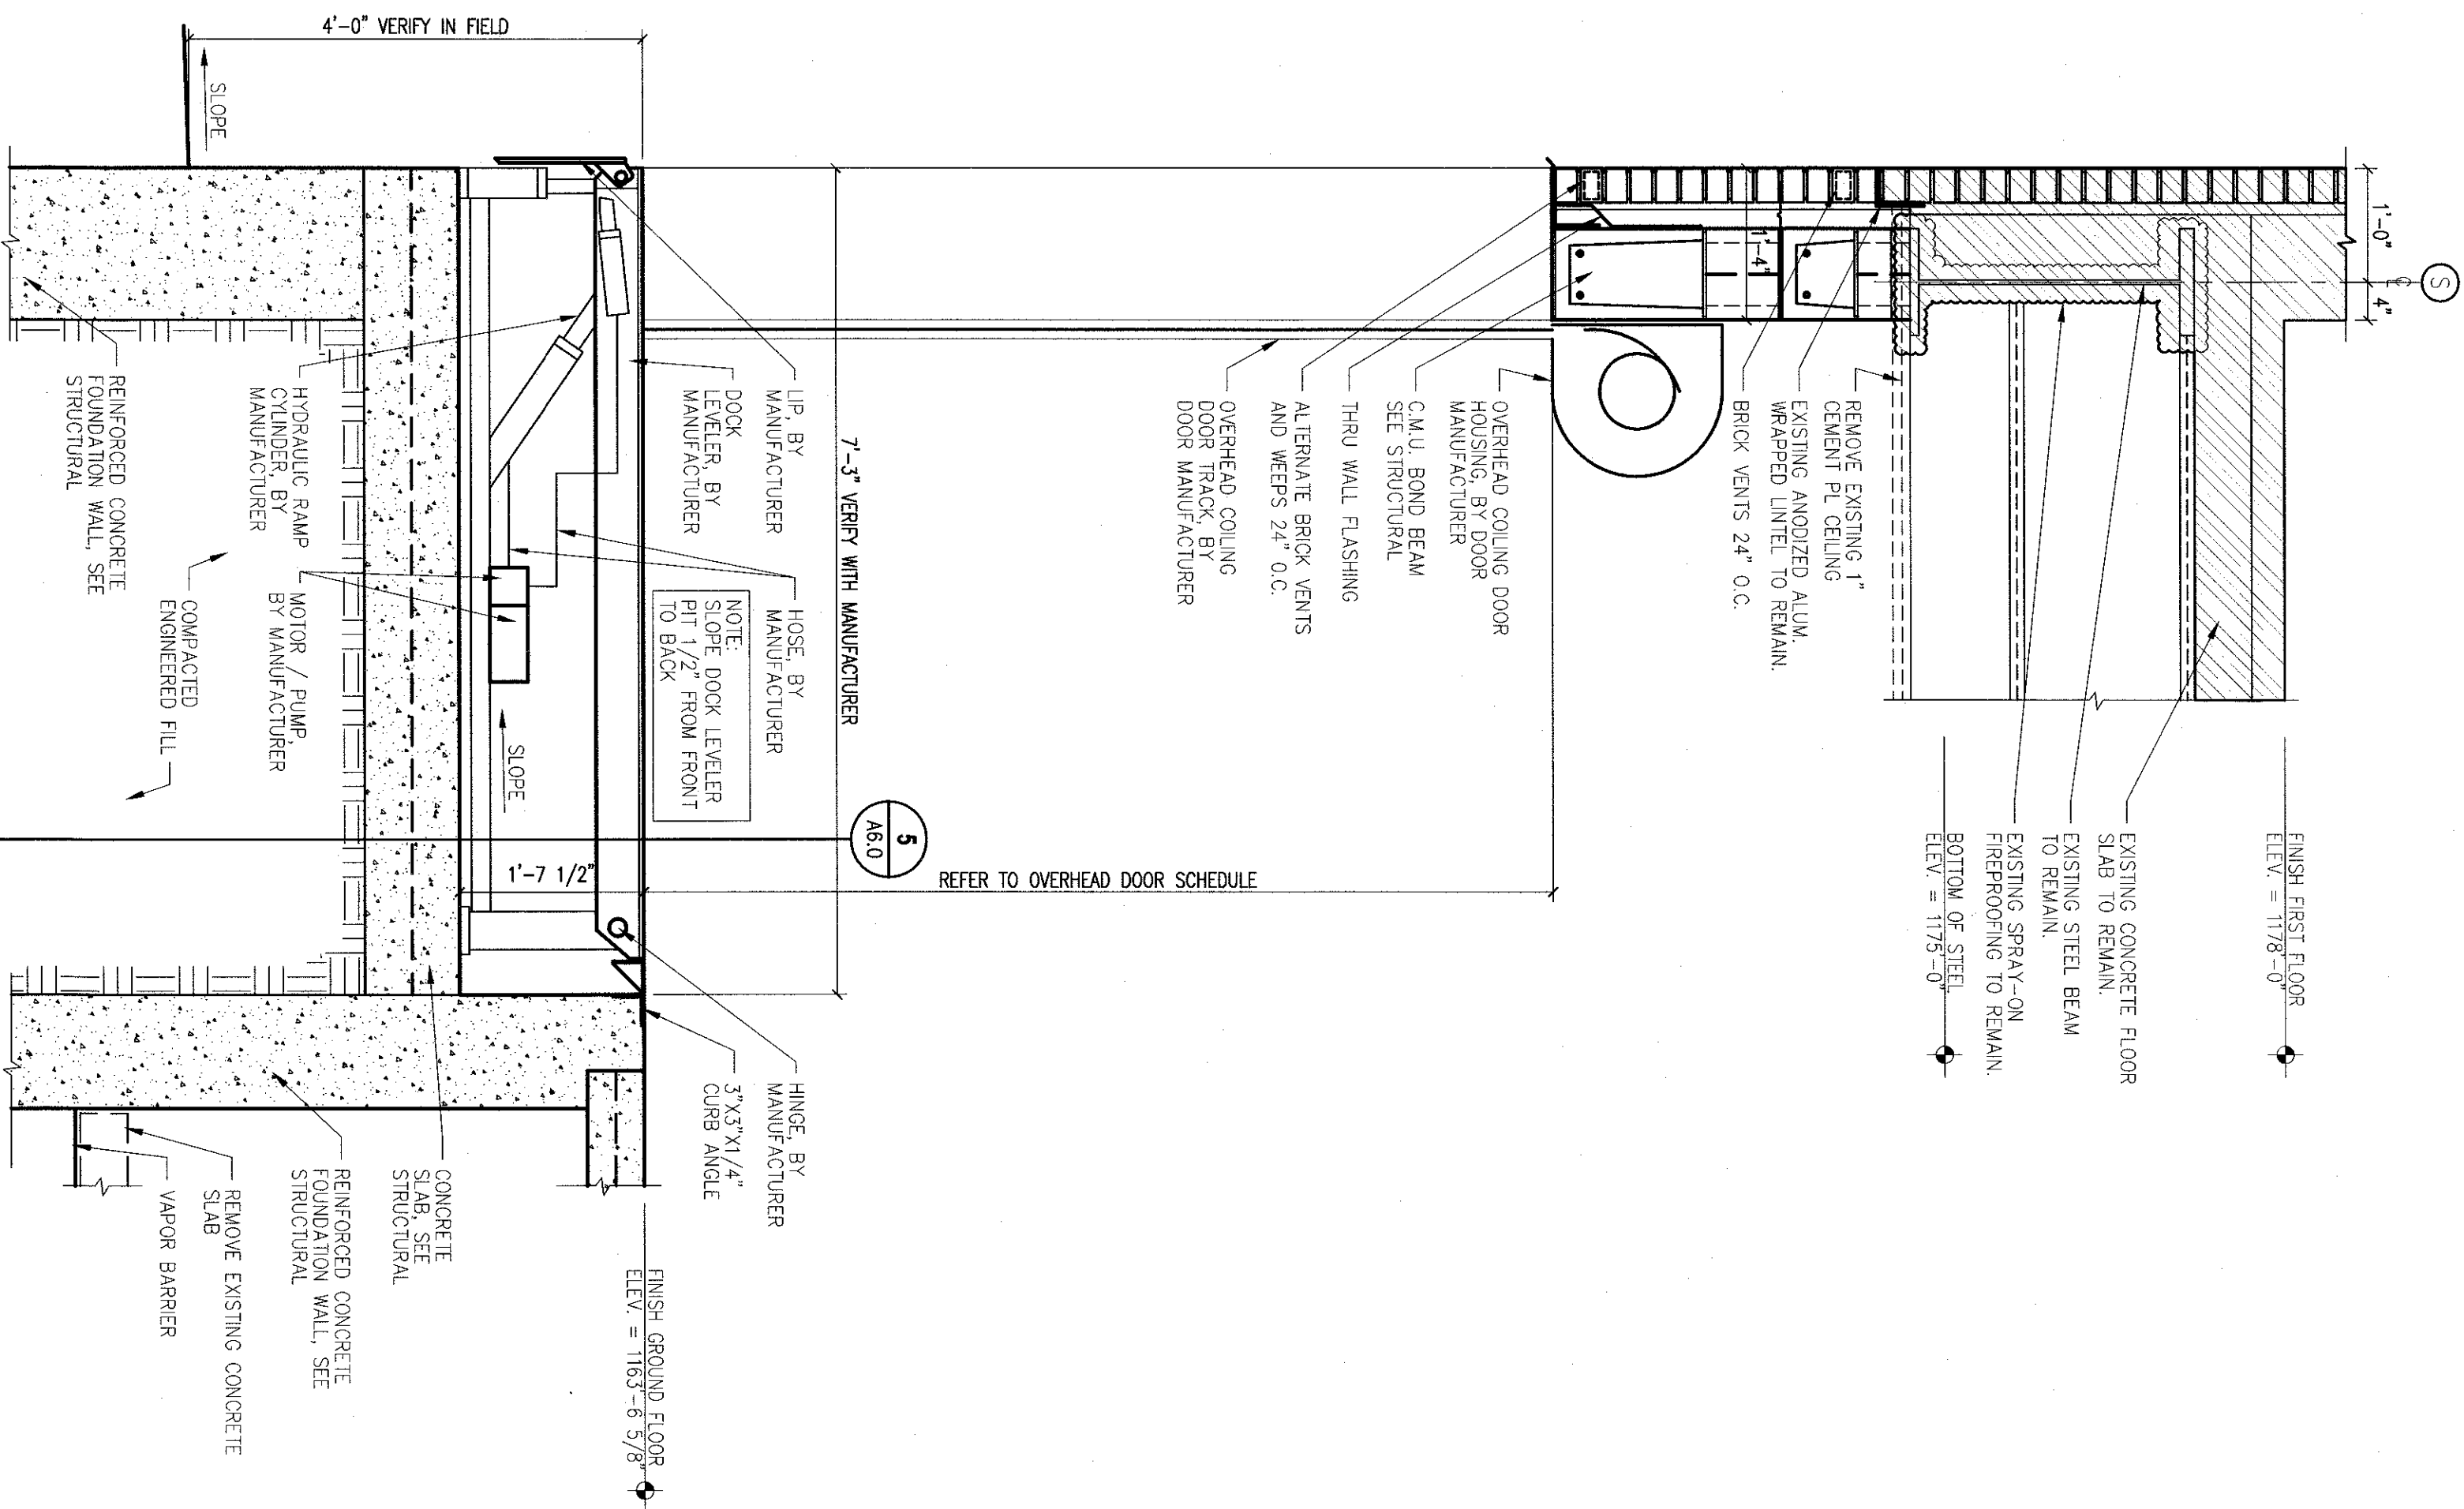


SCISSOR LIFT  
SECTION

DOCK LEVELER  
PIT DETAIL

GRAPHIC SCALE SUPERSEDES NUMERIC SCALE  
0 8' 16' 32'  
SCALE 3/4" = 1'-0"

GRAPHIC SCALE SUPERSEDES NUMERIC SCALE  
0 8' 16' 32'  
SCALE 3/4" = 1'-0"

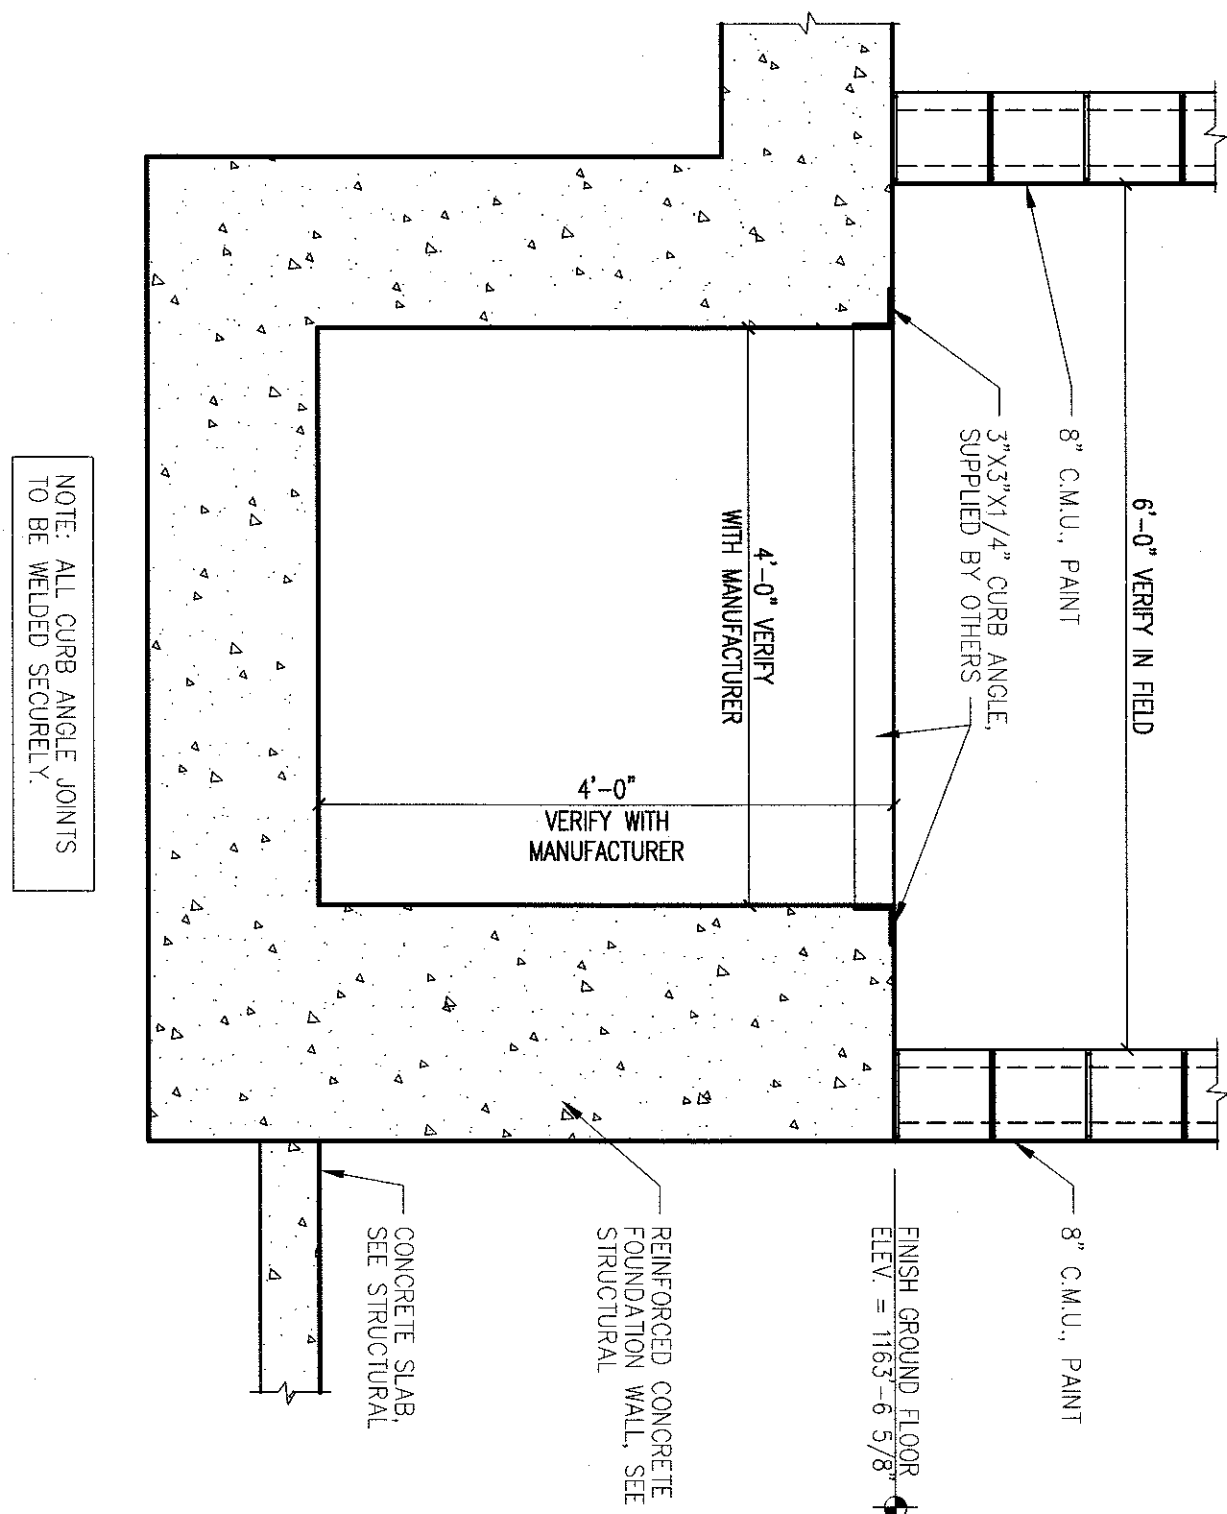

DOCK LEVELER  
WALL SECTION

DOCK LEVELER  
WALL SECTION

WALL SECTION

WALL SECTION

GRAPHIC SCALE SUPERSEDES NUMERIC SCALE  
0 8' 16' 32'  
SCALE 3/4" = 1'-0"

GRAPHIC SCALE SUPERSEDES NUMERIC SCALE  
0 8' 16' 32'  
SCALE 3/4" = 1'-0"

GRAPHIC SCALE SUPERSEDES NUMERIC SCALE  
0 8' 16' 32'  
SCALE 3/4" = 1'-0"

GRAPHIC SCALE SUPERSEDES NUMERIC SCALE  
0 8' 16' 32'  
SCALE 3/4" = 1'-0"

NO.	REVISION	DATE
1		
2		
3		
4		
5		
6		
7		
8		
9		
10		

FULLY SPRINKLERED BUILDING  
BID DOCUMENTS



**PARADIGM**  
ENGINEERS AND CONSTRUCTORS  
PO BOX 436223  
Louisville, Kentucky 40263  
502-339-8511 www.paradigmusa.com

UPGRADE SPD AND SECURITY DOCK  
PROJECT: 646-367  
VA PITTSBURGH  
HEALTHCARE SYSTEM  
UNIVERSITY DRIVE C  
PITTSBURGH, PENNSYLVANIA 15240

