

PARADIGM
ENGINEERS AND CONSTRUCTORS
PO BOX 436223
Louisville, Kentucky 40253
502-338-8511 www.paradigmusa.com

UPGRADE SPD AND SECURITY DOCK
PROJECT: 646-367
**VA PITTSBURGH
HEALTHCARE SYSTEM**
UNIVERSITY DRIVE C
PITTSBURGH, PENNSYLVANIA 15240




Department of
Veterans Affairs

DATE	BY	REVISION
7-28-11	JG	1
		2
		3
		4
		5
		6
		7
		8
		9
		10

WALL SECTIONS

A6.3

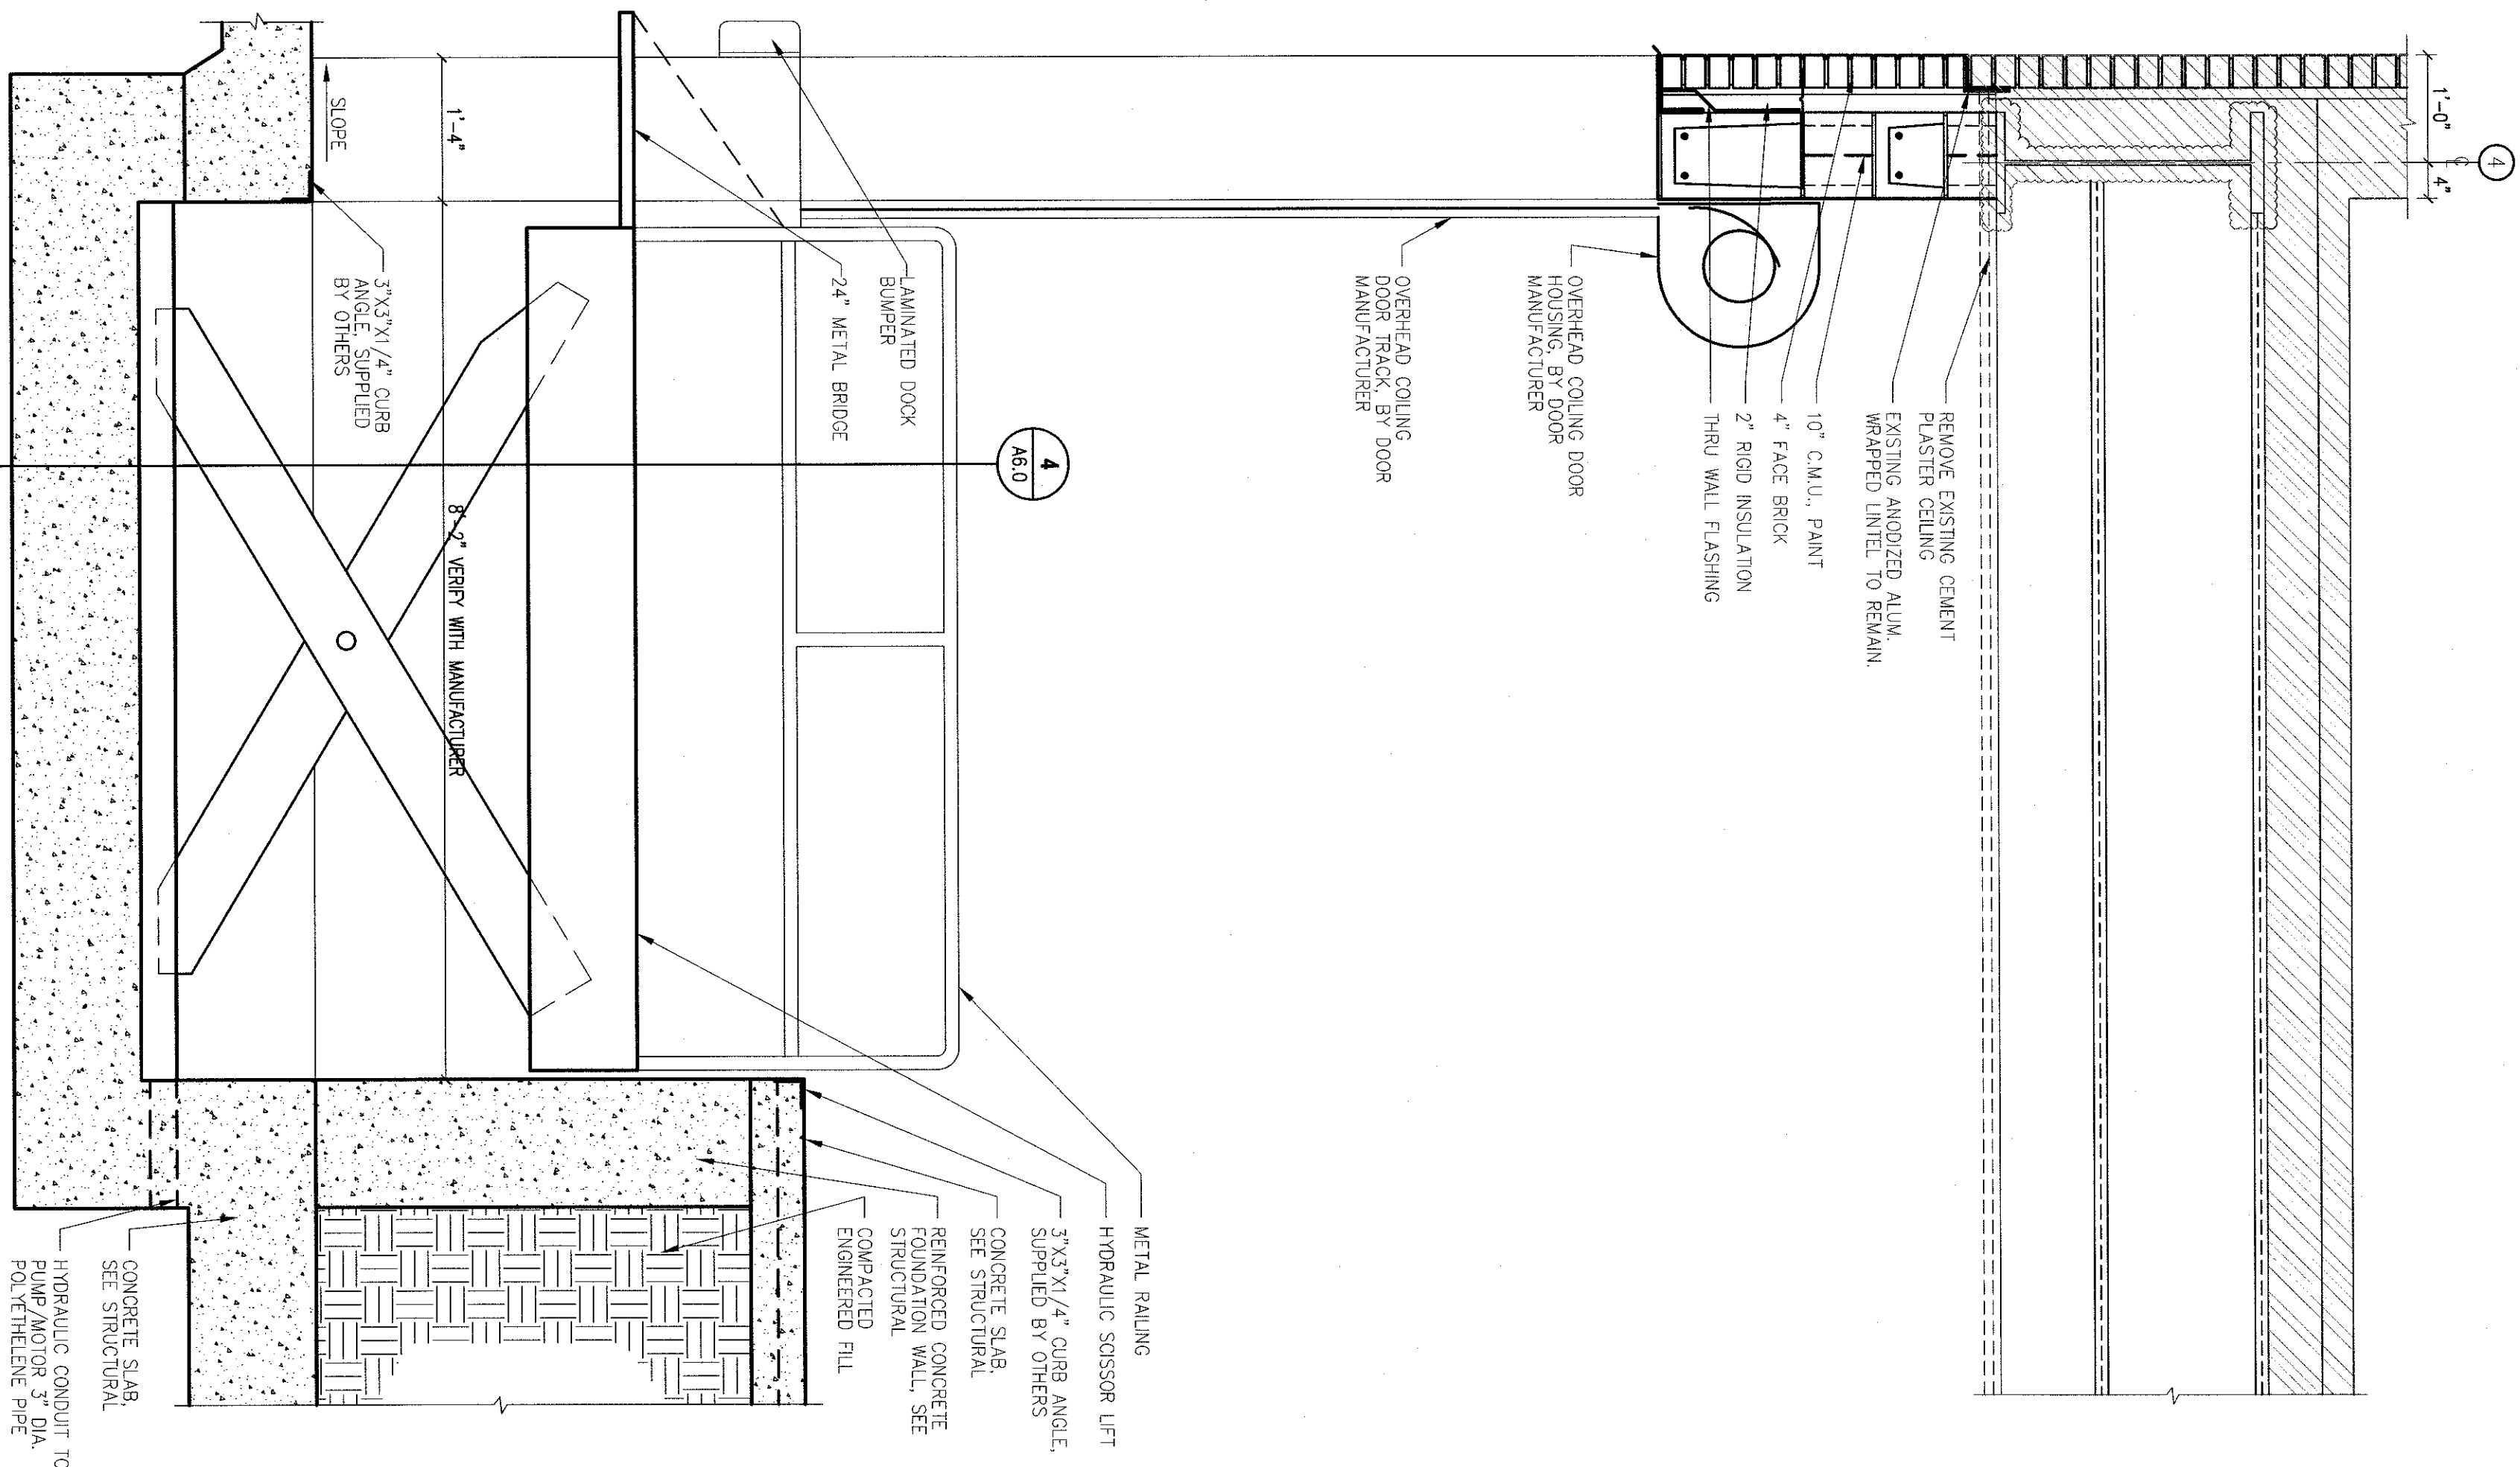

NOTE: PROVIDE 6" DIA. FOUNDATION DRAIN
TIED TO STORM SEWER. PLACE BOTTOM OF
FOUNDATION 12" BELOW FINISH GRADE. PROVIDE
PERMANENTLY OPEN EXTERIOR WALL.

WALL SECTION

GRAPHIC SCALE SHEETED NUMBER SCALE
0 8' 16' 32'
SCALE: 3/4" = 1'-0"

FULLY SPRINKLERED BUILDING
BID DOCUMENTS