



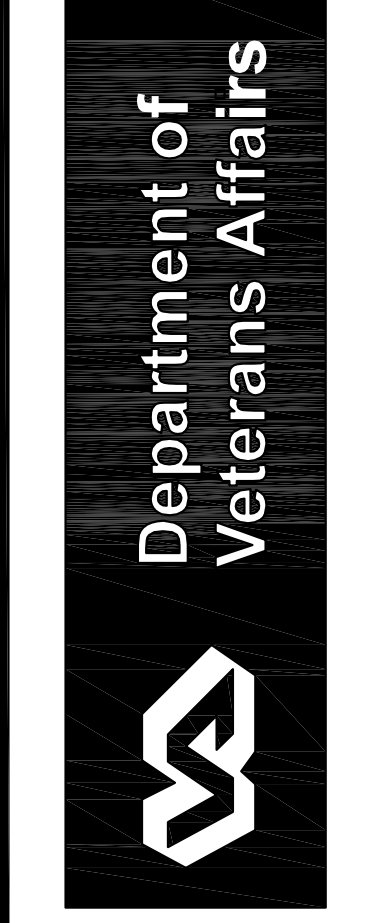


PARADIGM
ENGINEERS AND CONSTRUCTORS
PO BOX 436223
Louisville, Kentucky 40253
502-339-8511 www.paradigmusa.com

UPGRADE SPD AND SECURITY DOCK
PROJECT: 646-367
VA PITTSBURGH
HEALTHCARE SYSTEM
UNIVERSITY DRIVE C
PITTSBURGH, PENNSYLVANIA 15240




| | |
|-----------------|---------|
| MADE BY | CHECKED |
| DATE | 2-09-11 |
| FOUNDATION PLAN | |
| DRAWING NO. | BD PXL |
| S1.0 | |

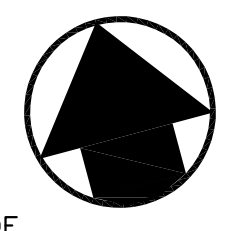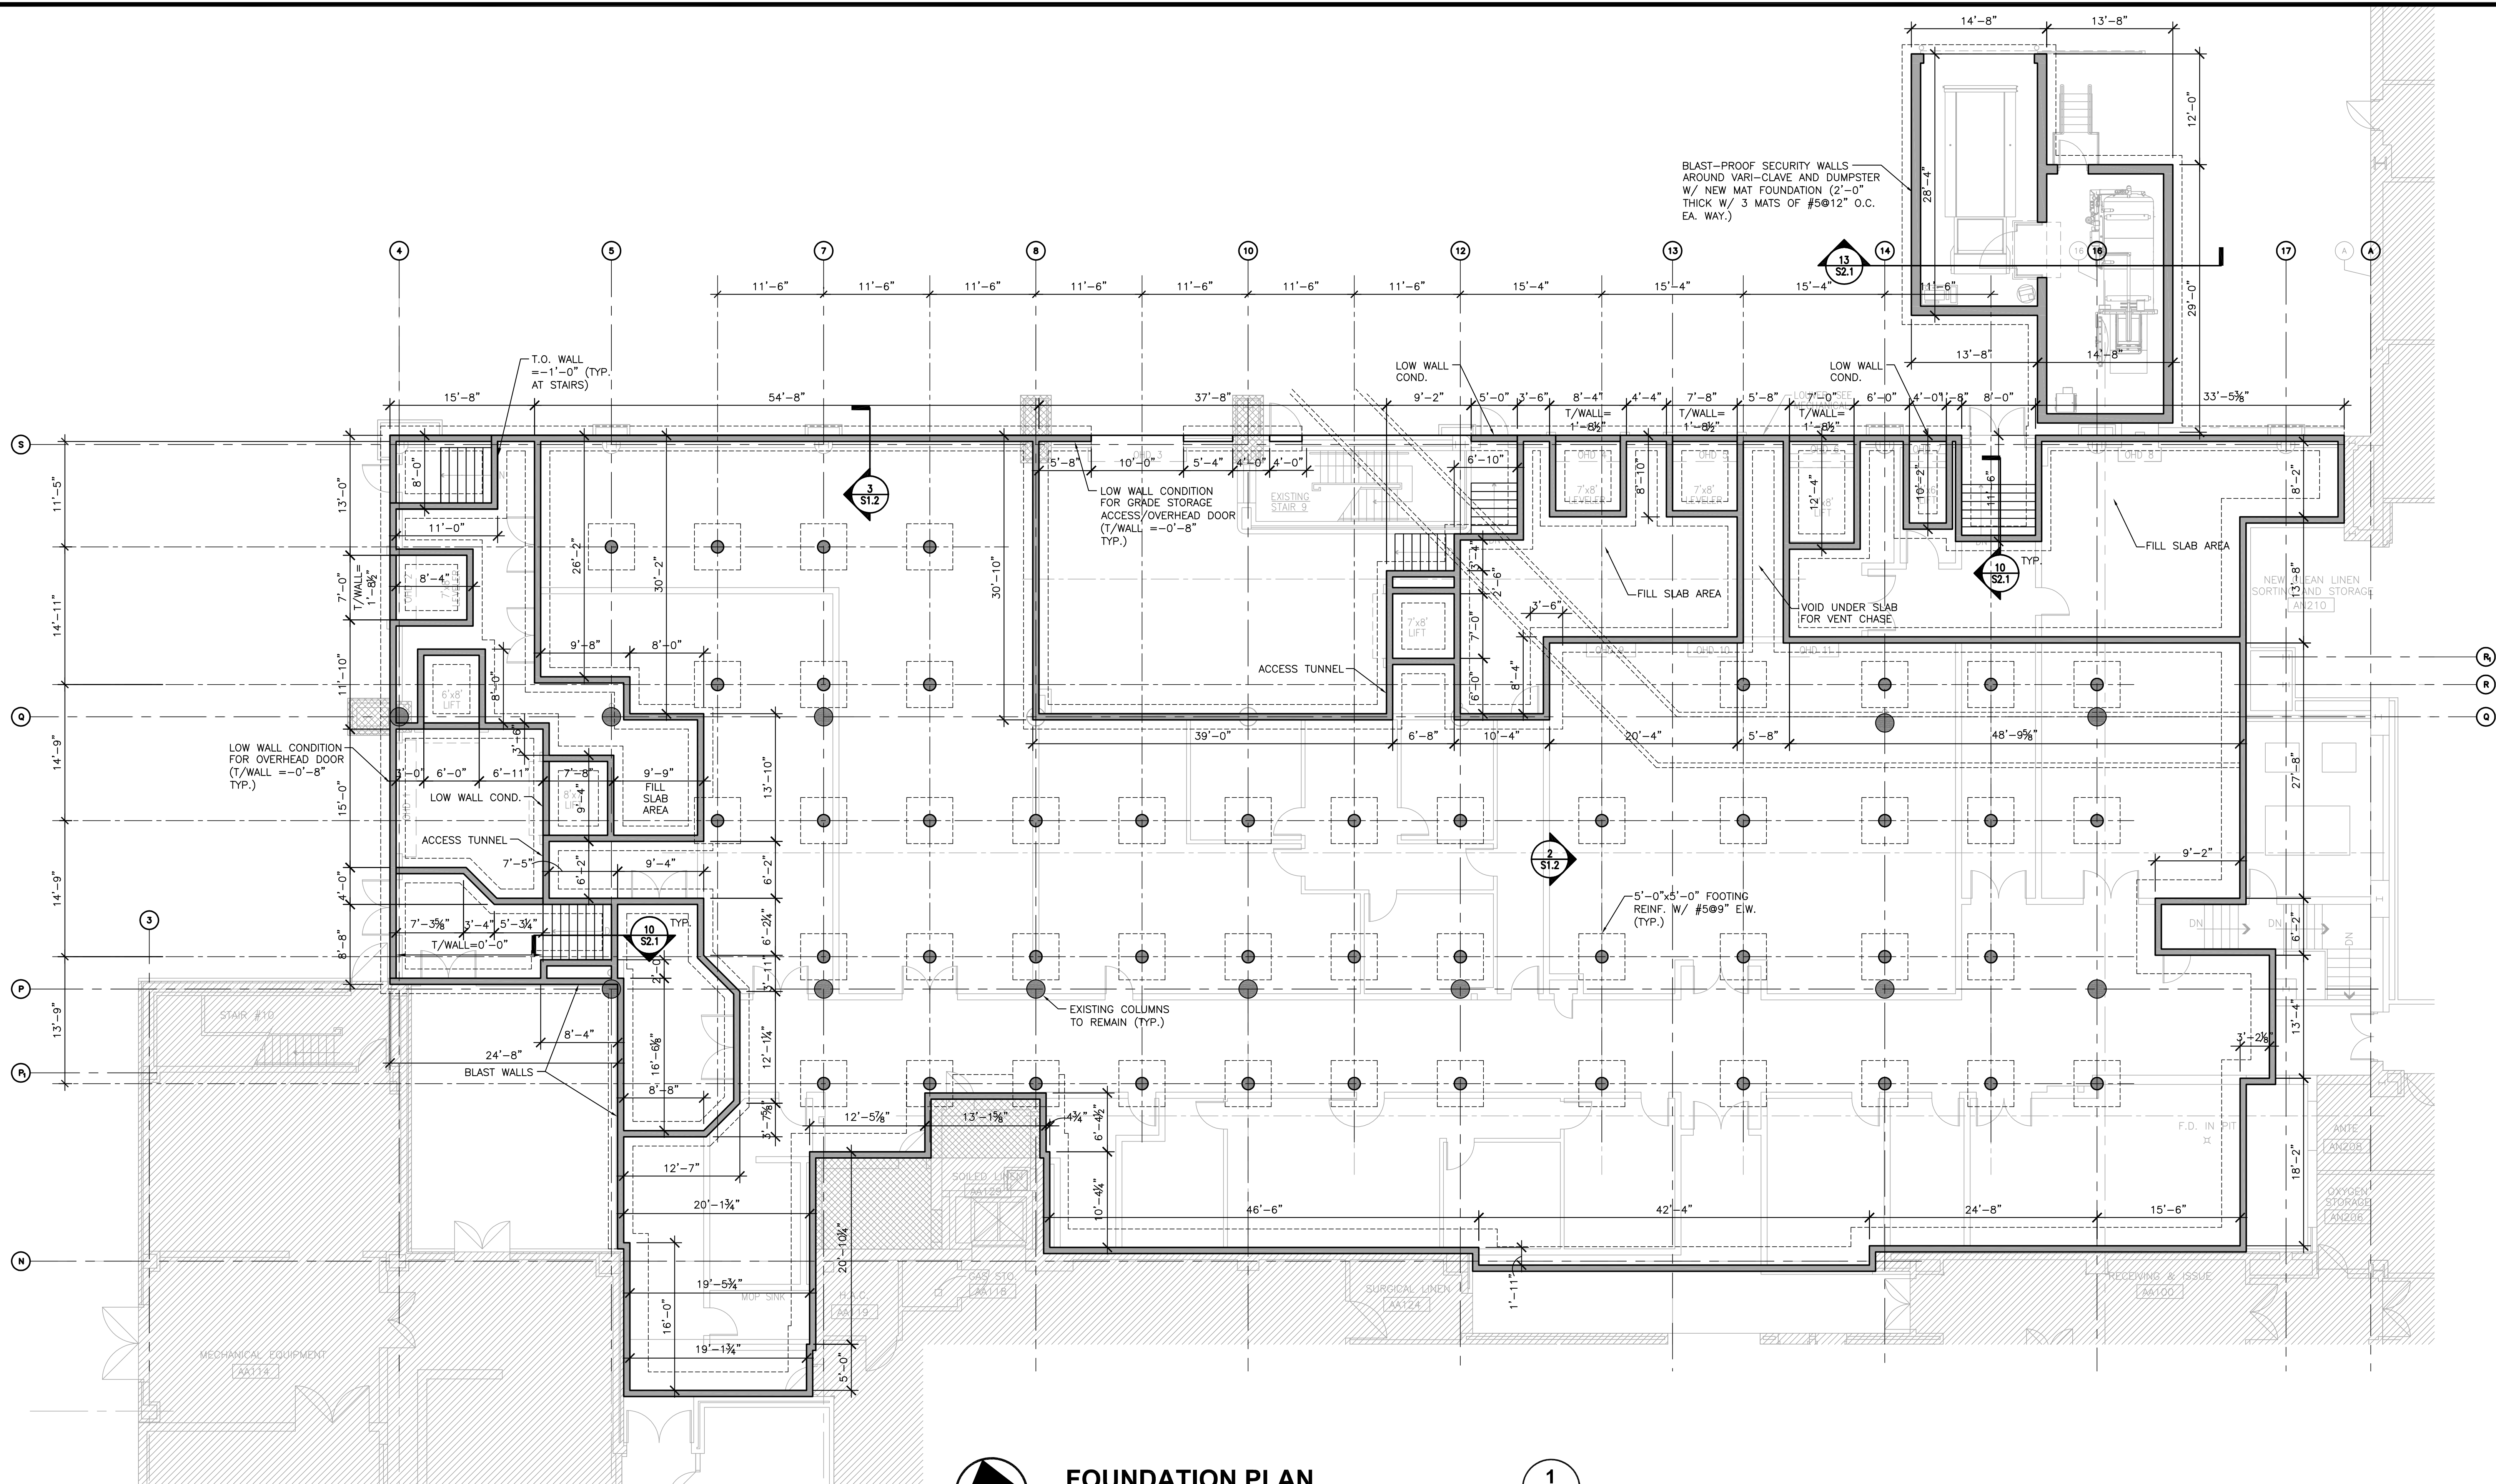


FOUNDATION PLAN
GRAPHIC SCALE SUPERSEDES NUMERIC SCALE
0 4' 8' 16'
SCALE: 1/8" = 1'-0"


GENERAL NOTES
1. ALL CONSTRUCTION/DEMOLITION WORK SHALL COORDINATE WITH AND REFER TO ARCHITECTURAL PHASING PLAN, PH1.0.

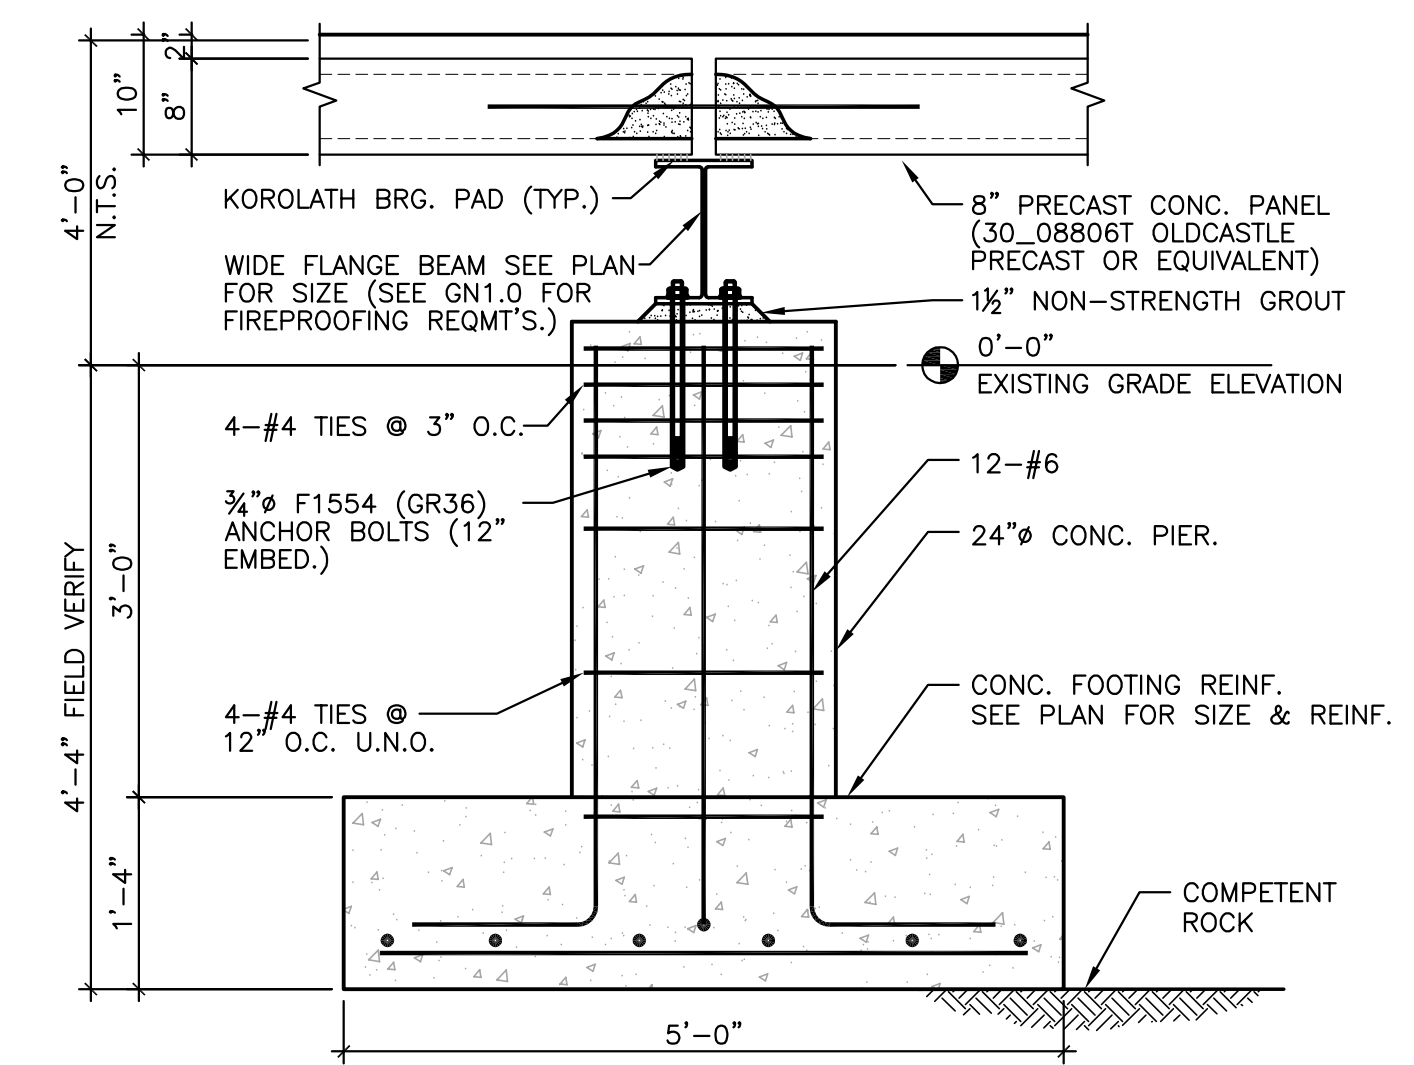


SECTION AT INTERIOR H.C. PRECAST PANEL
GRAPHIC SCALE SUPERSEDES NUMERIC SCALE
0 8" 16" 32"
SCALE: 3/4" = 1'-0"

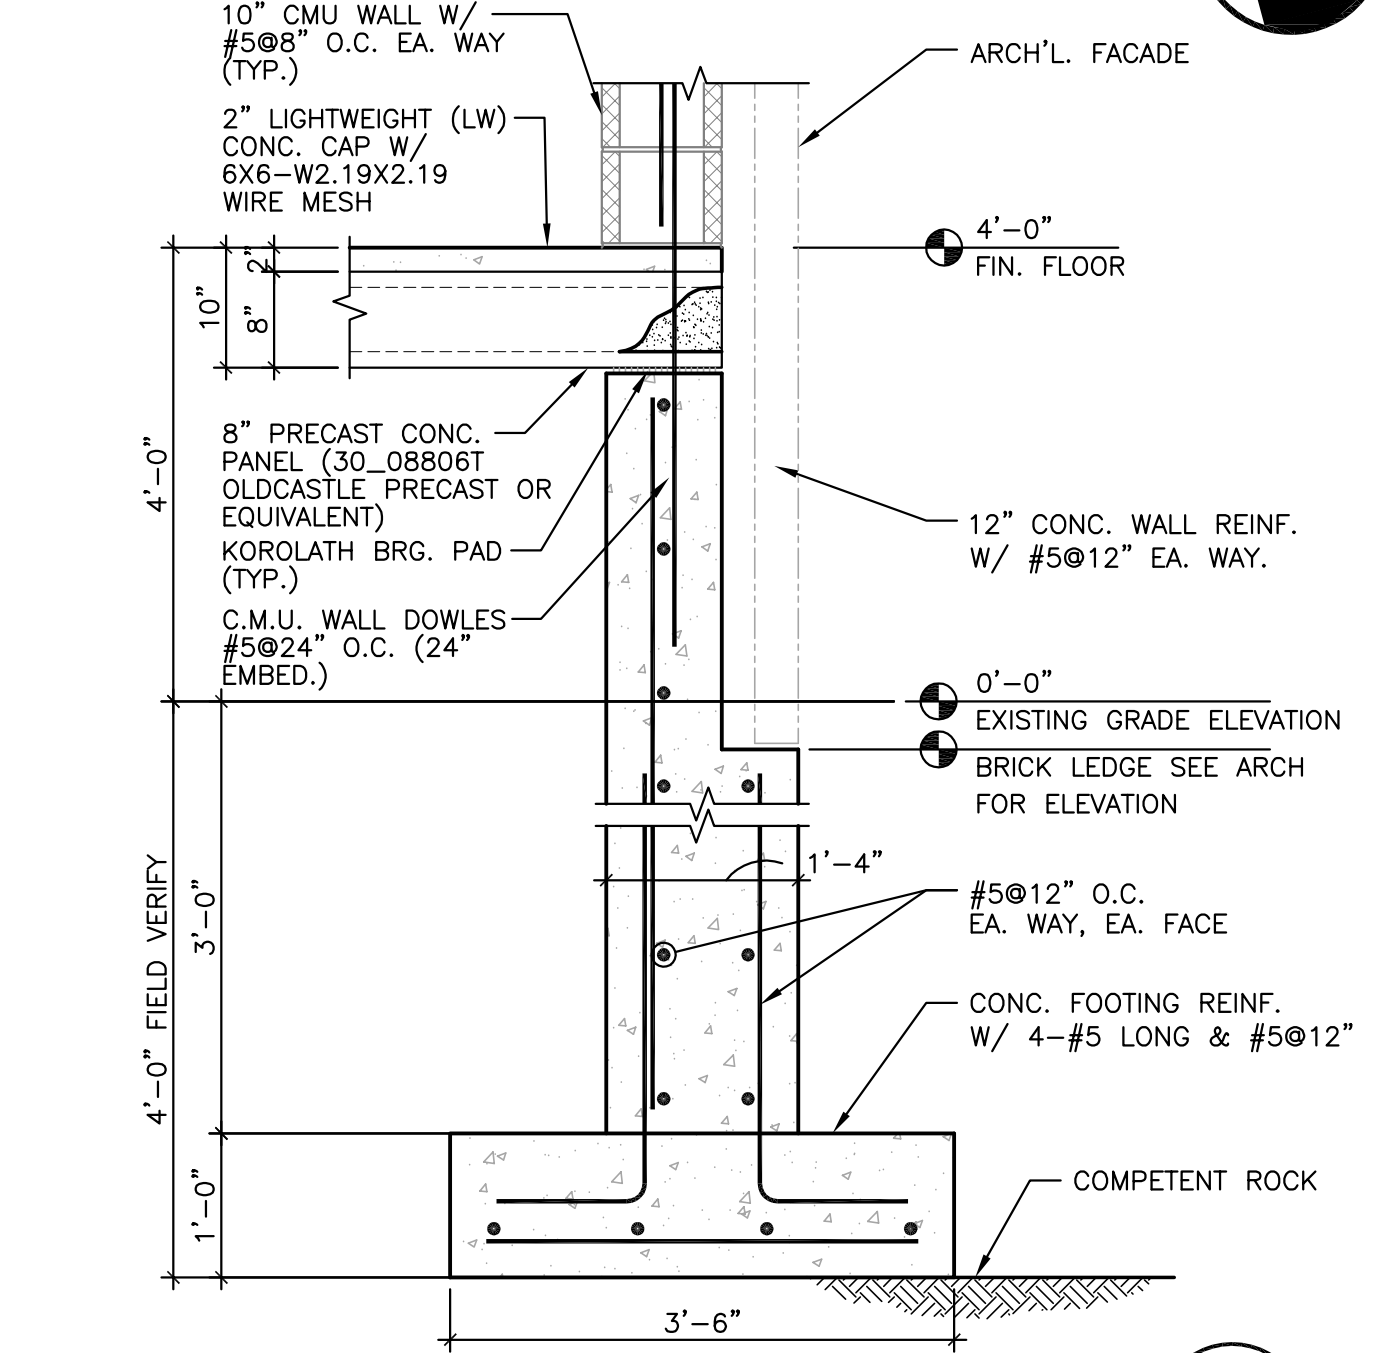


SECTION AT PERIMETER WALL
GRAPHIC SCALE SUPERSEDES NUMERIC SCALE
0 8" 16" 32"
SCALE: 3/4" = 1'-0"

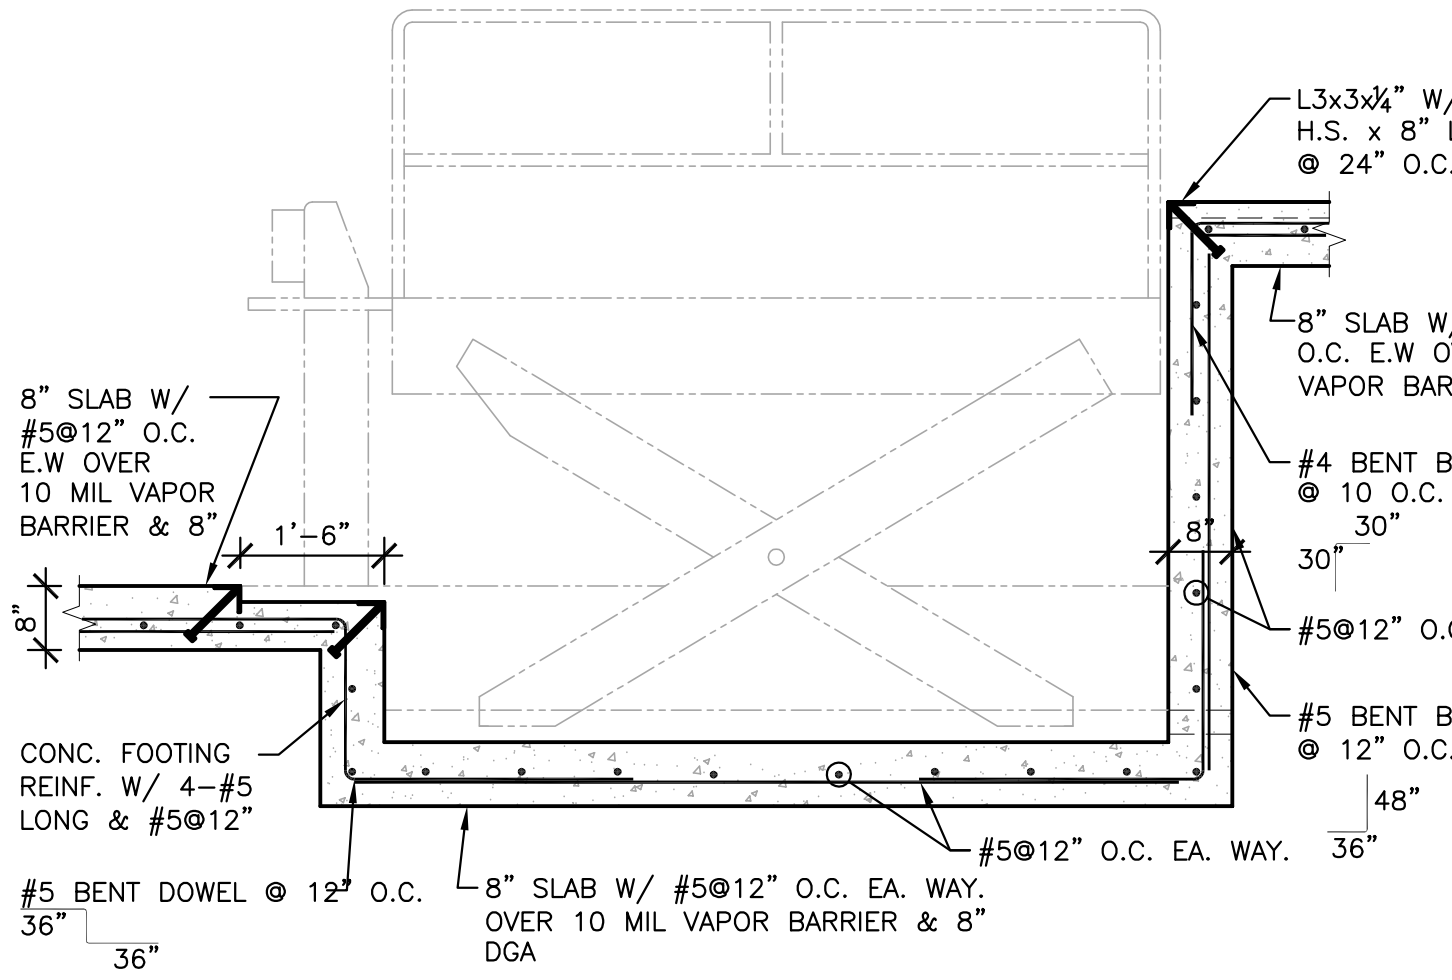

SECTION AT LIFT
GRAPHIC SCALE SUPERSEDES NUMERIC SCALE
0 8" 16" 32"
SCALE: 3/4" = 1'-0"

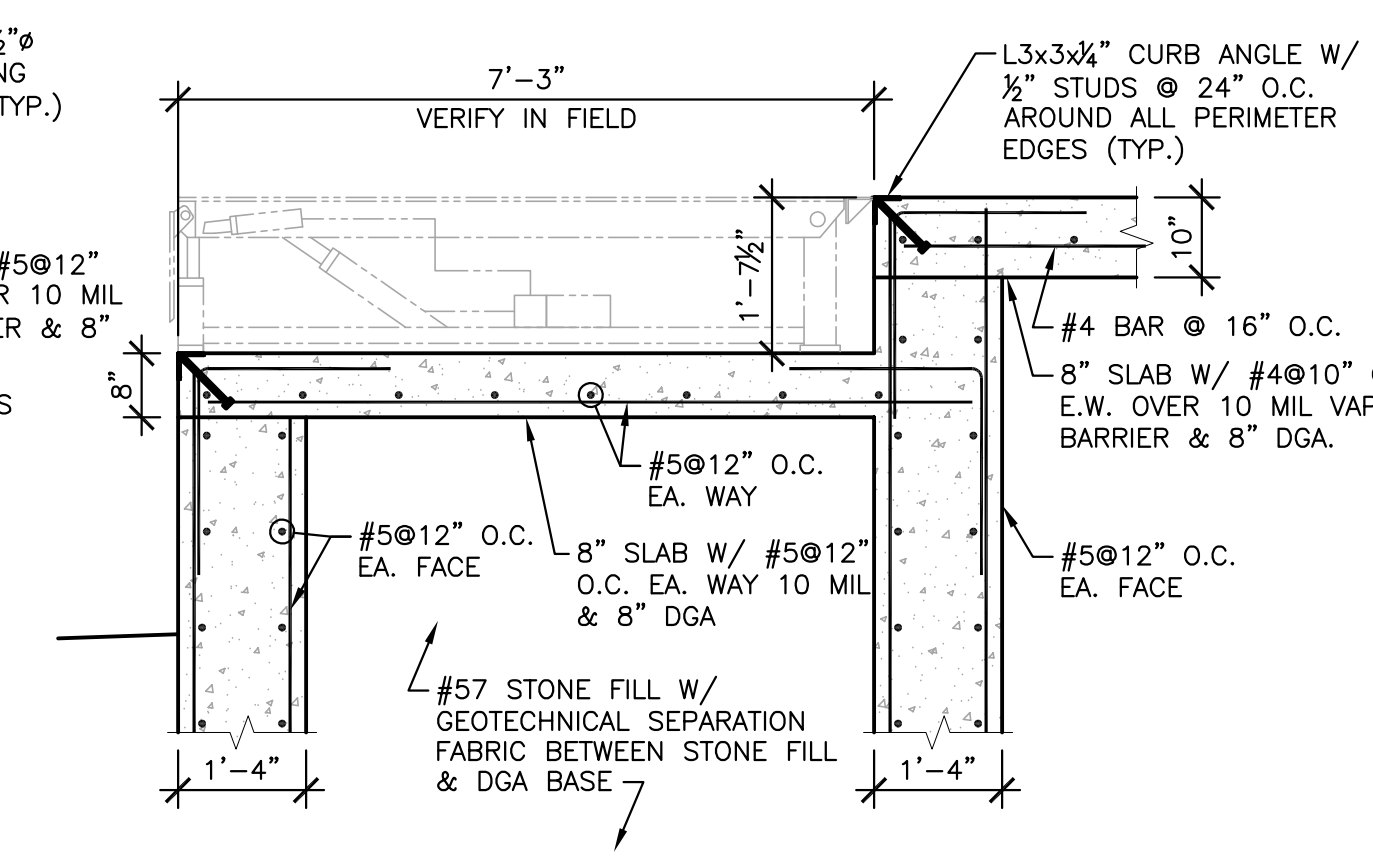

SECTION AT LIFT
GRAPHIC SCALE SUPERSEDES NUMERIC SCALE
0 8" 16" 32"
SCALE: 3/4" = 1'-0"

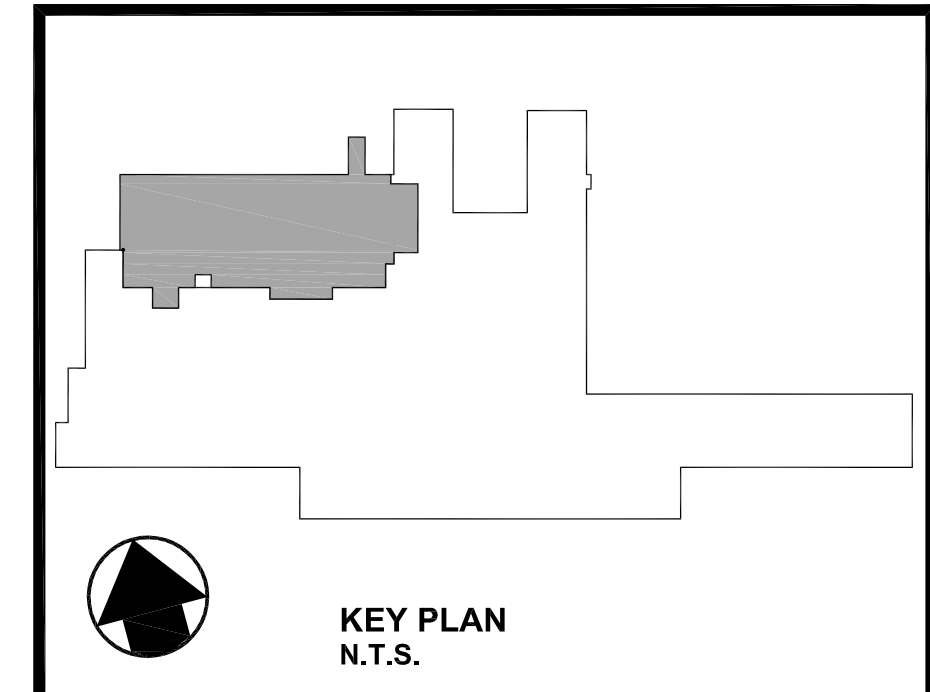

| REVISIONS | DATE |
|-----------|------|
| 1 | |
| 2 | |
| 3 | |
| 4 | |
| 5 | |
| 6 | |
| 7 | |
| 8 | |

FULLY SPRINKLERED BUILDING
100% BID DOCUMENTS SUBMITTAL