


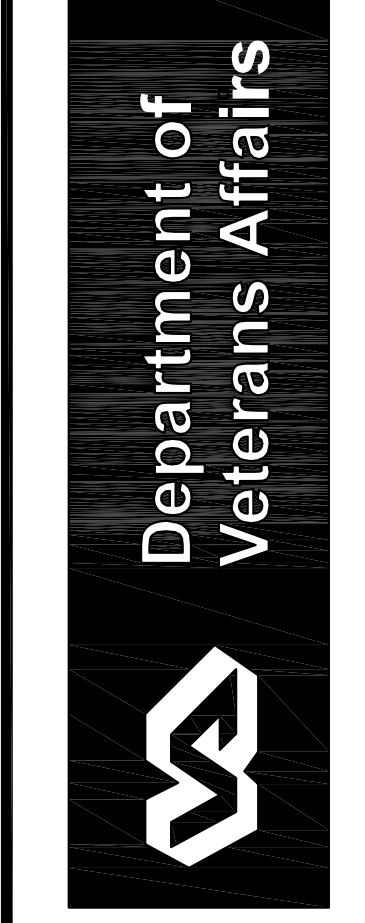


PARADIGM
ENGINEERS AND CONSTRUCTORS
PO BOX 436223
Louisville, Kentucky 40253
502-338-8511 www.paradigmusa.com


UPGRADE SPD AND SECURITY DOCK
PROJECT: 646-367
VA PITTSBURGH
HEALTHCARE SYSTEM
UNIVERSITY DRIVE C
PITTSBURGH, PENNSYLVANIA 15240





MADE BY	CHECKED
DATE	2-09-11
STRUCTURAL GROUND LEVEL FLOOR PLAN	
DRAWING NO.	BID Pkg.
S1.1	

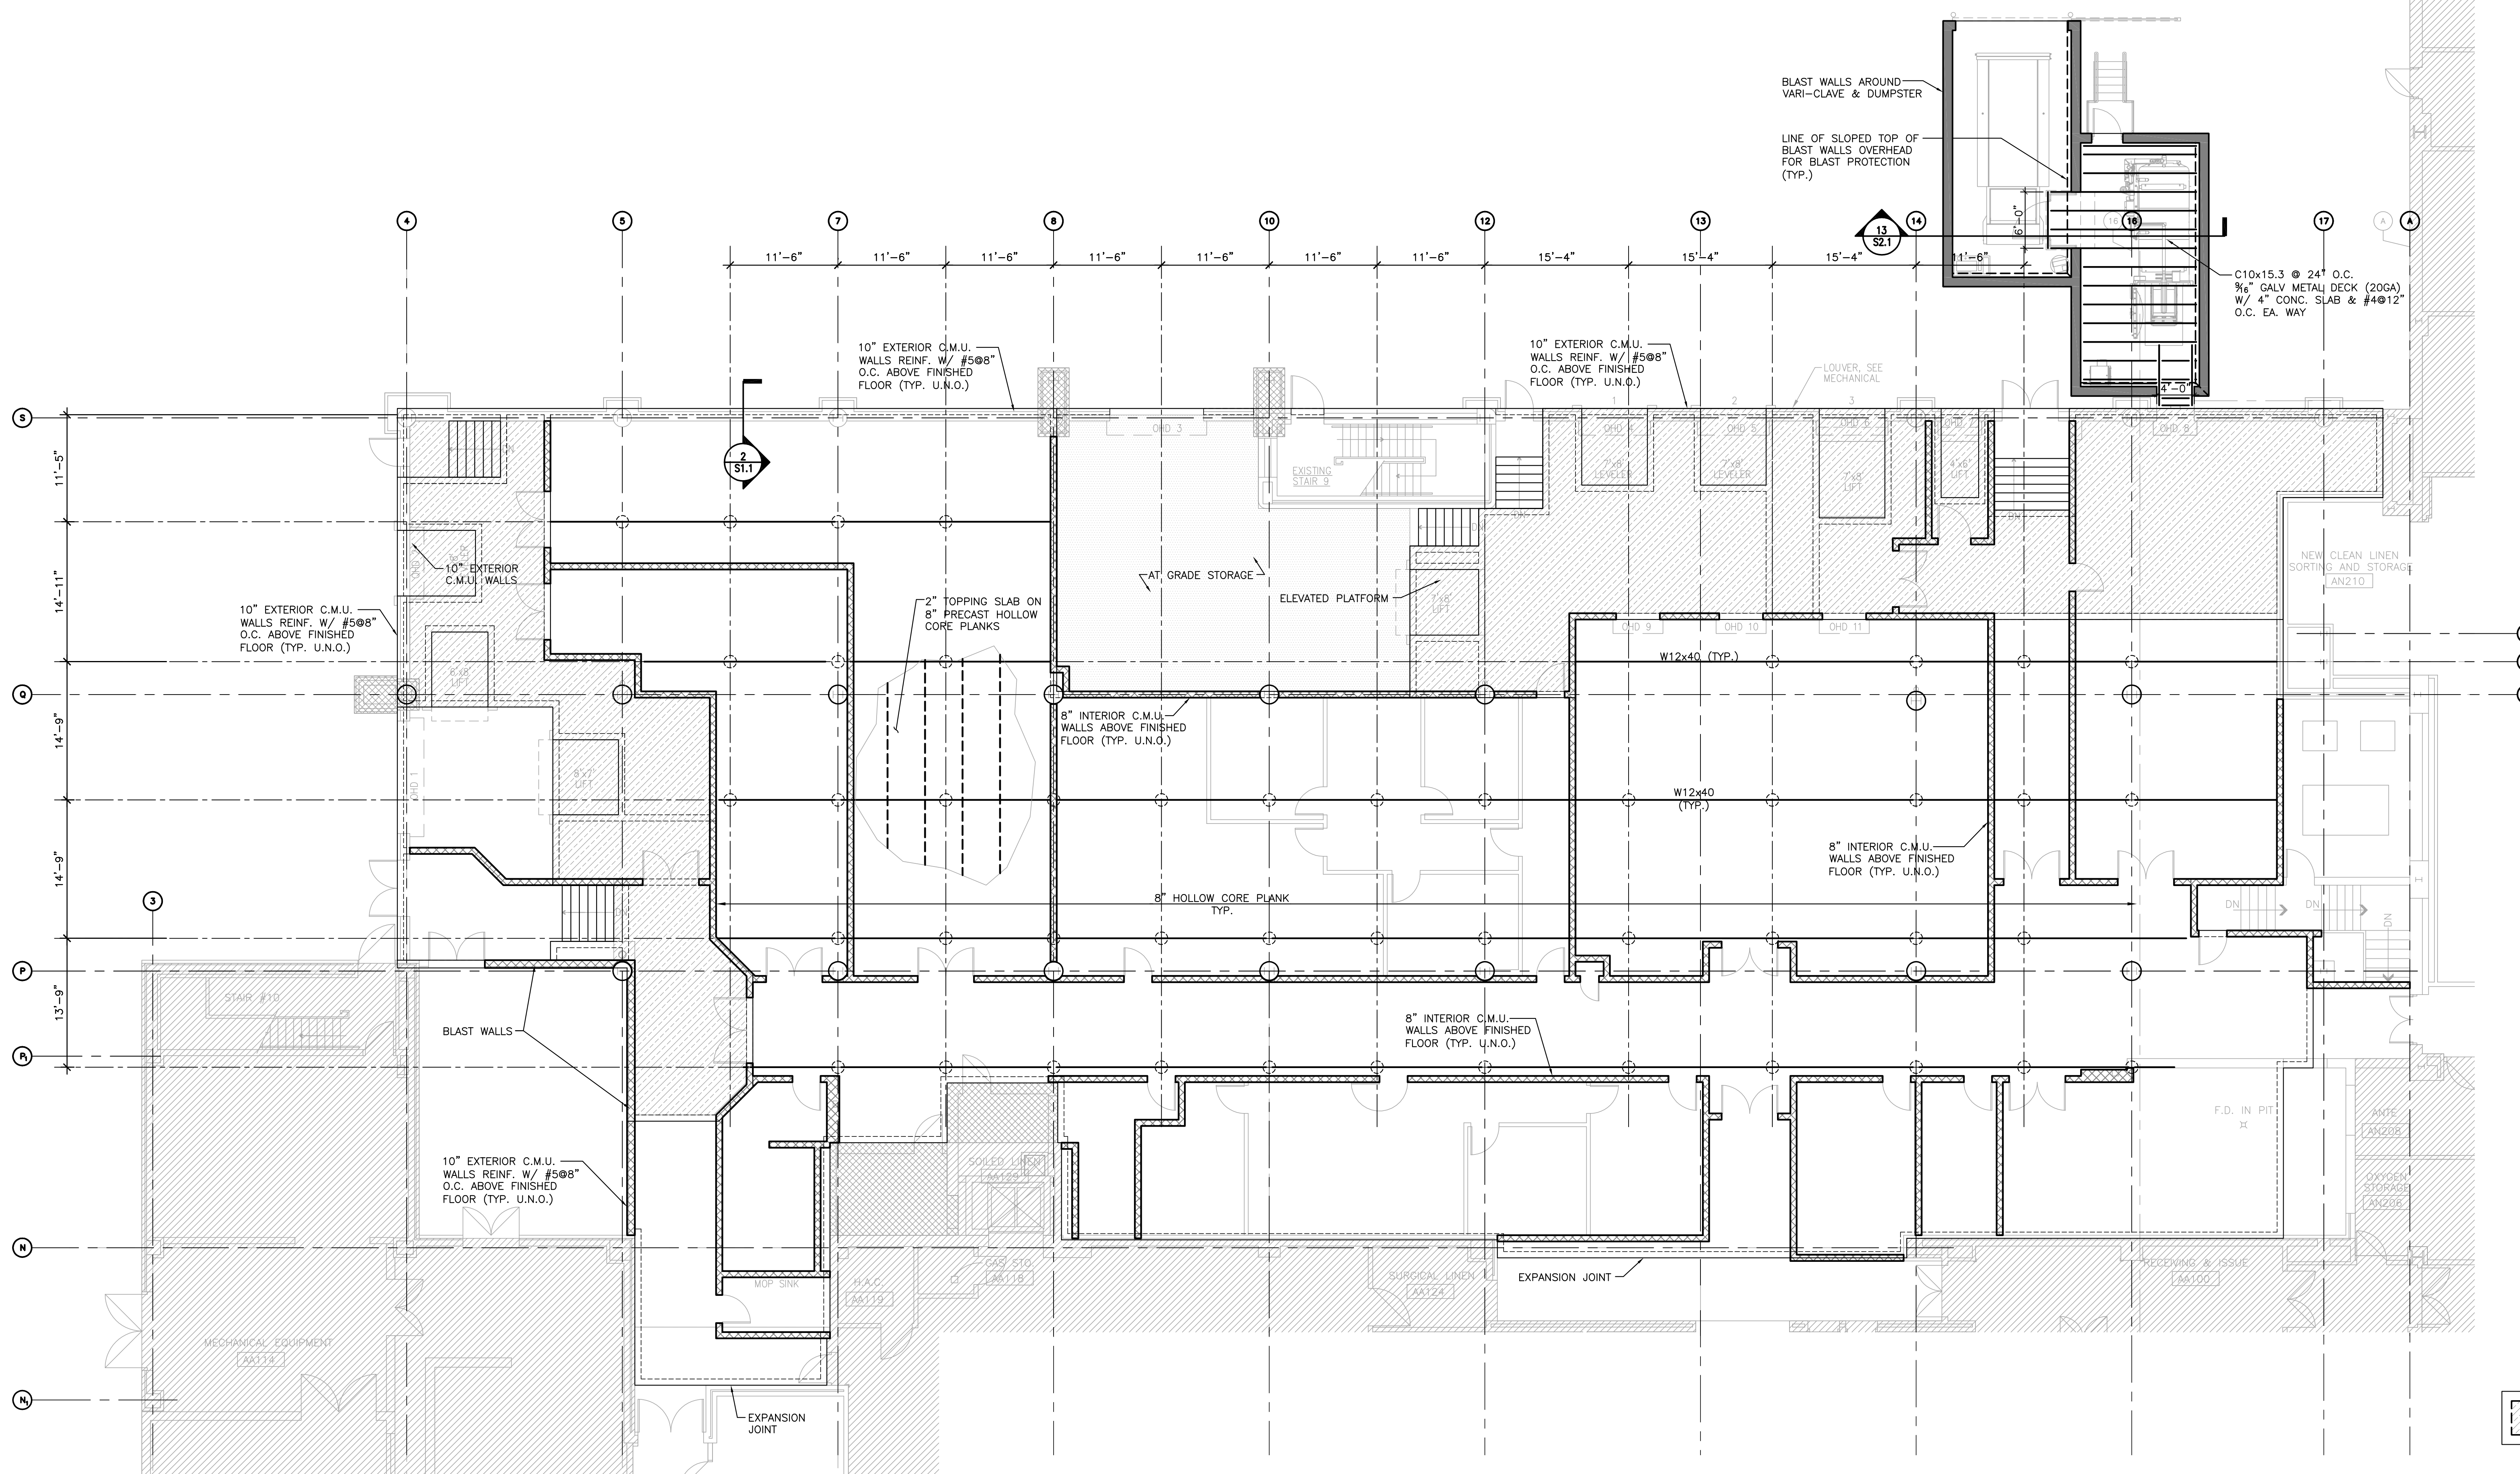

STRUCTURAL GROUND LEVEL FLOOR PLAN 1
GRAPHIC SCALE SUPERSEDES NUMERIC SCALE
0 4' 8' 16'
SCALE: 1/8" = 1'-0"

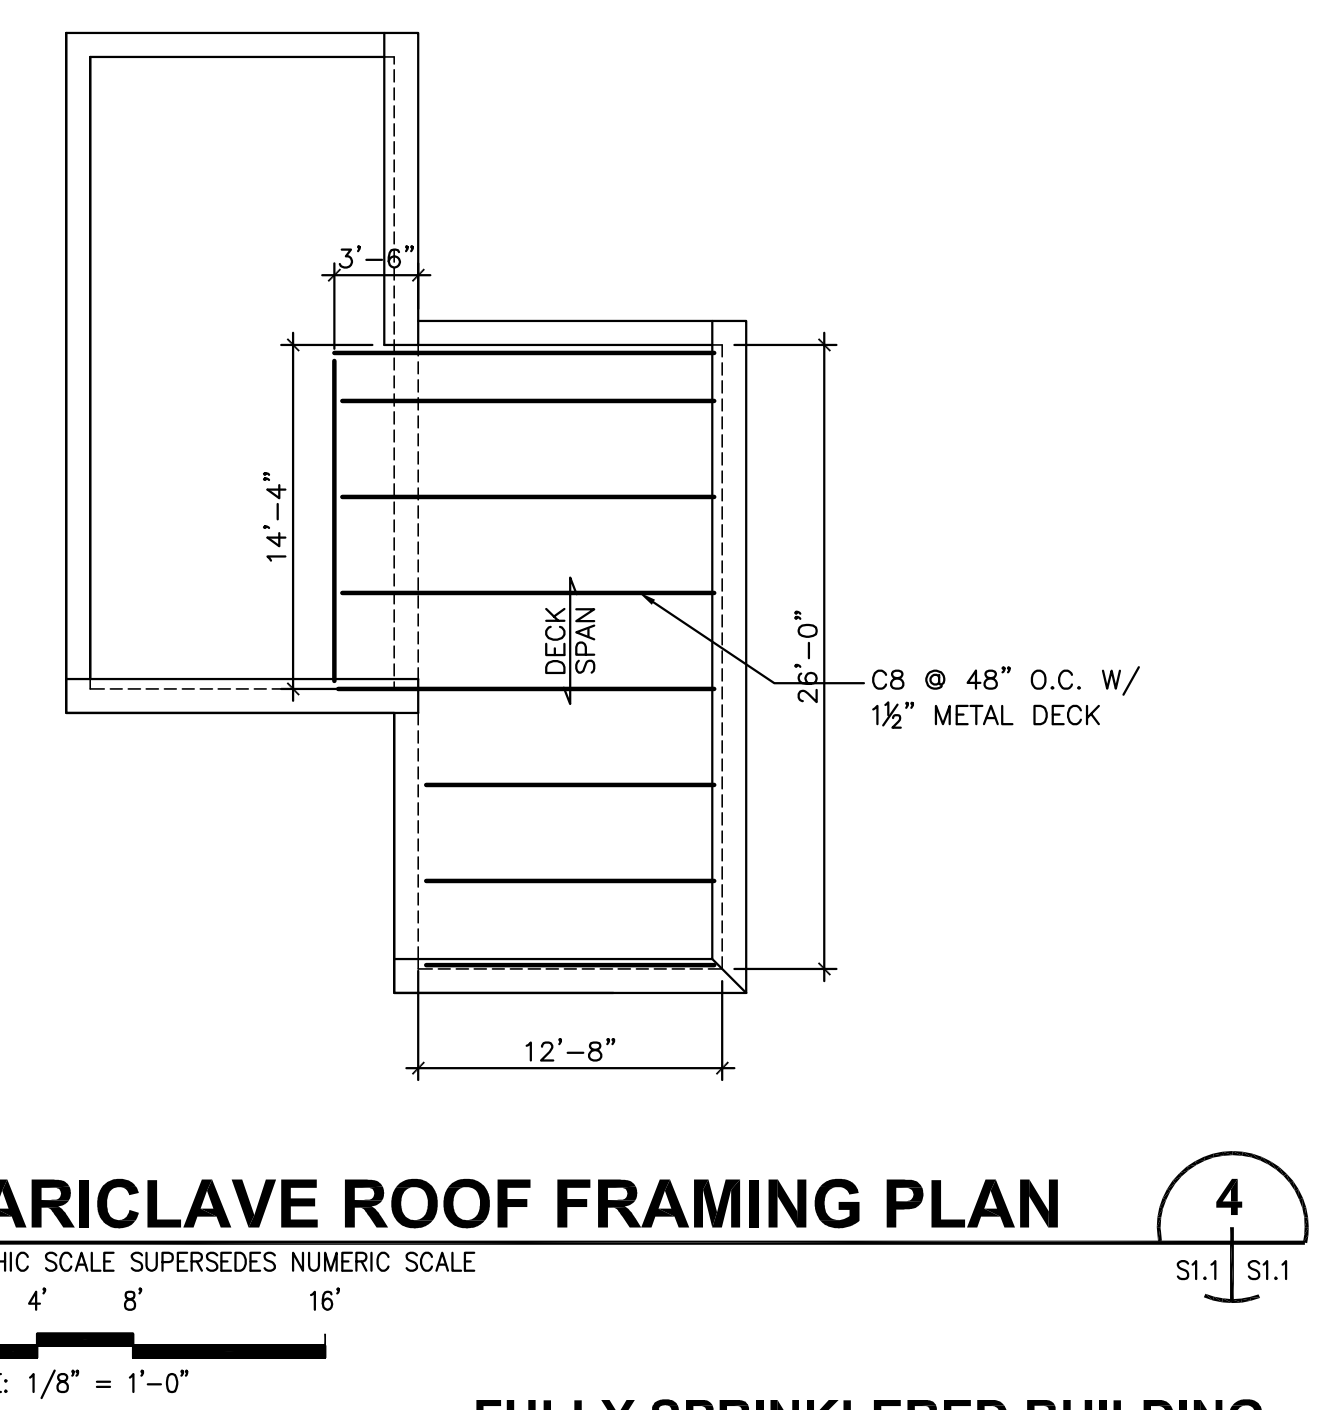

VARICLAVE ROOF FRAMING PLAN 4
GRAPHIC SCALE SUPERSEDES NUMERIC SCALE
0 4' 8' 16'
SCALE: 1/8" = 1'-0"

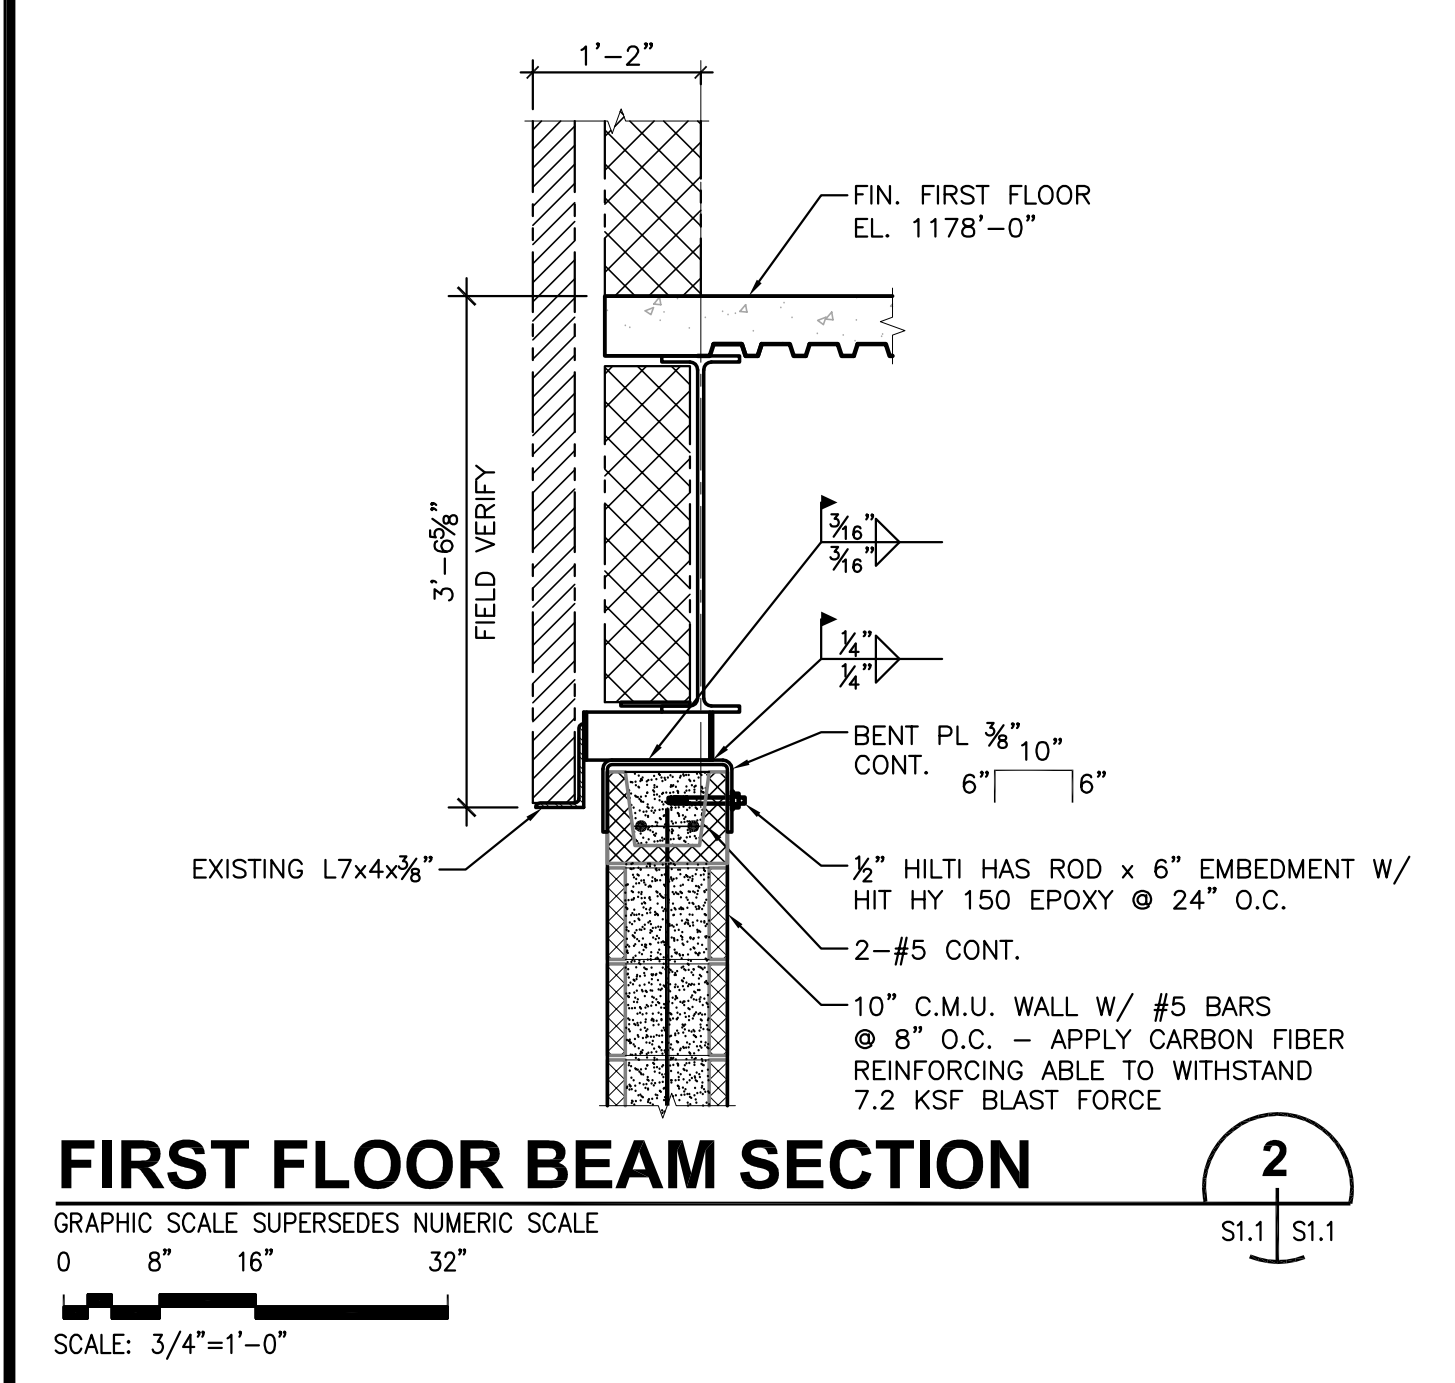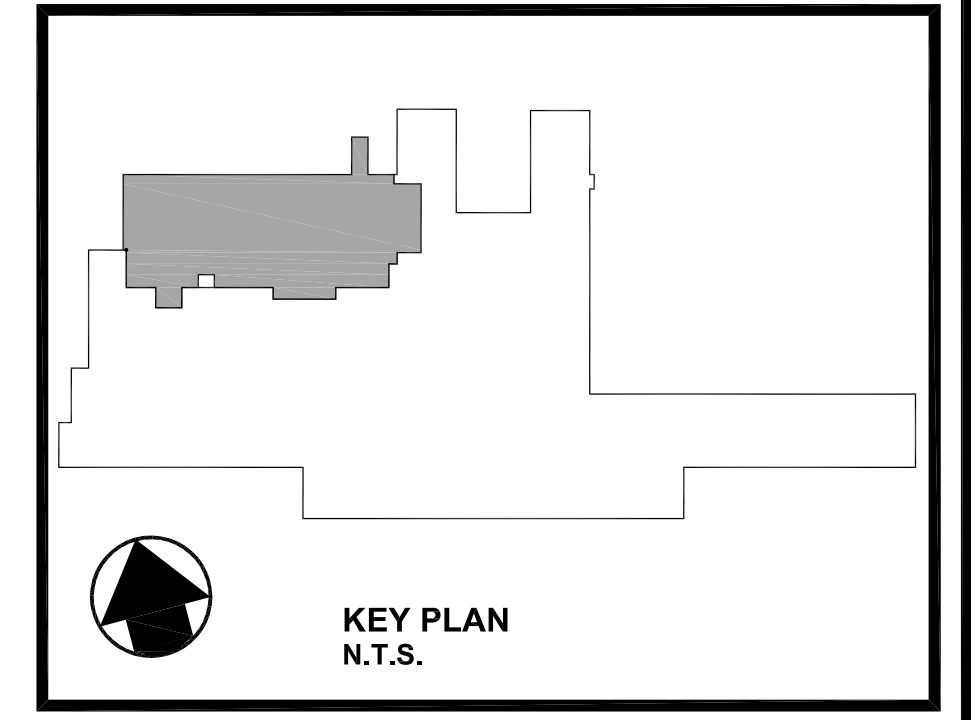

INTERIOR NON-LOAD BEARING CMU WALL ON HOLLOW CORE P'CST 3
GRAPHIC SCALE SUPERSEDES NUMERIC SCALE
0 8' 16' 32'
SCALE: 3/4" = 1'-0"

100% BID DOCUMENTS SUBMITTAL