
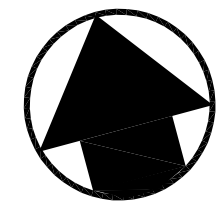


### DUMPSTER PLATFORM FRAMING PLAN

GRAPHIC SCALE SUPERSEDES NUMERIC SCALE  
0 2' 4' 8'  
SCALE: 1/4" = 1'-0"


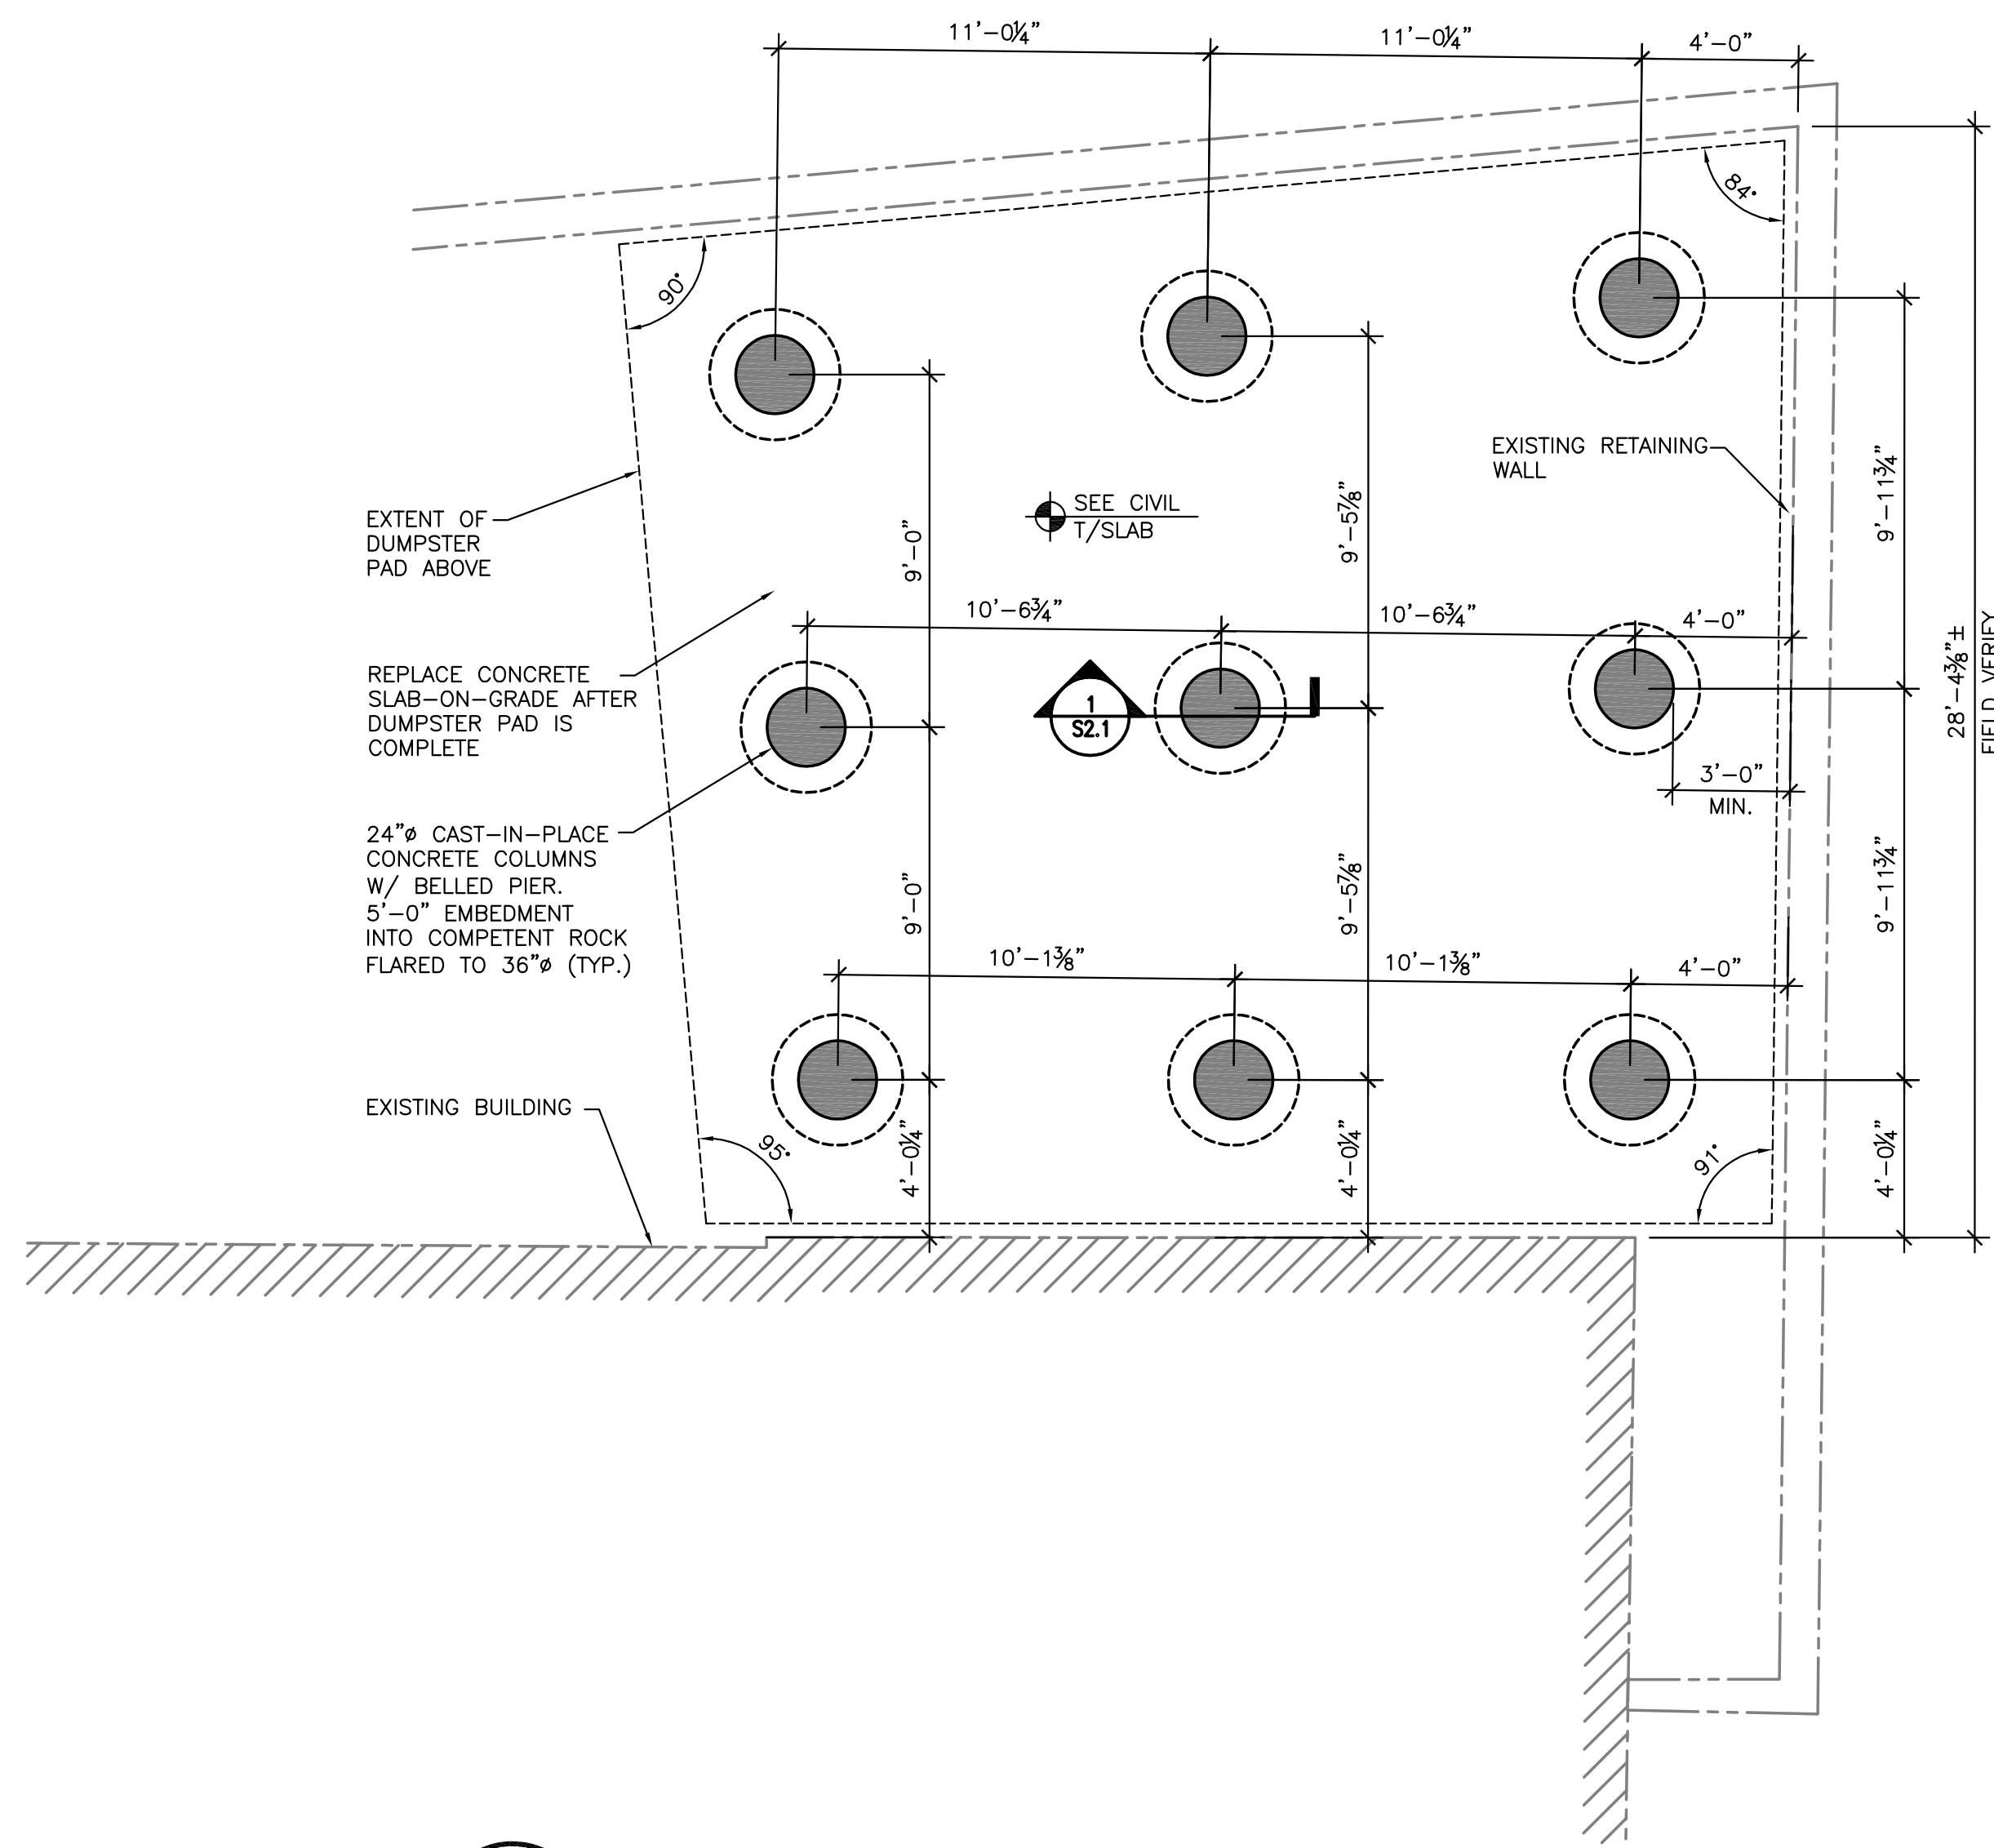


### DUMPSTER PLATFORM FOUNDATION PLAN

GRAPHIC SCALE SUPERSEDES NUMERIC SCALE  
0 2' 4' 8'  
SCALE: 1/4" = 1'-0"

### GENERAL NOTES

1. ALL CONSTRUCTION/DEMOLITION WORK SHALL COORDINATE WITH AND REFER TO ARCHITECTURAL PHASING PLAN, PH1.0.

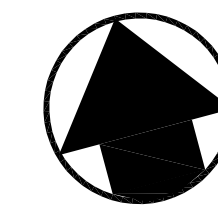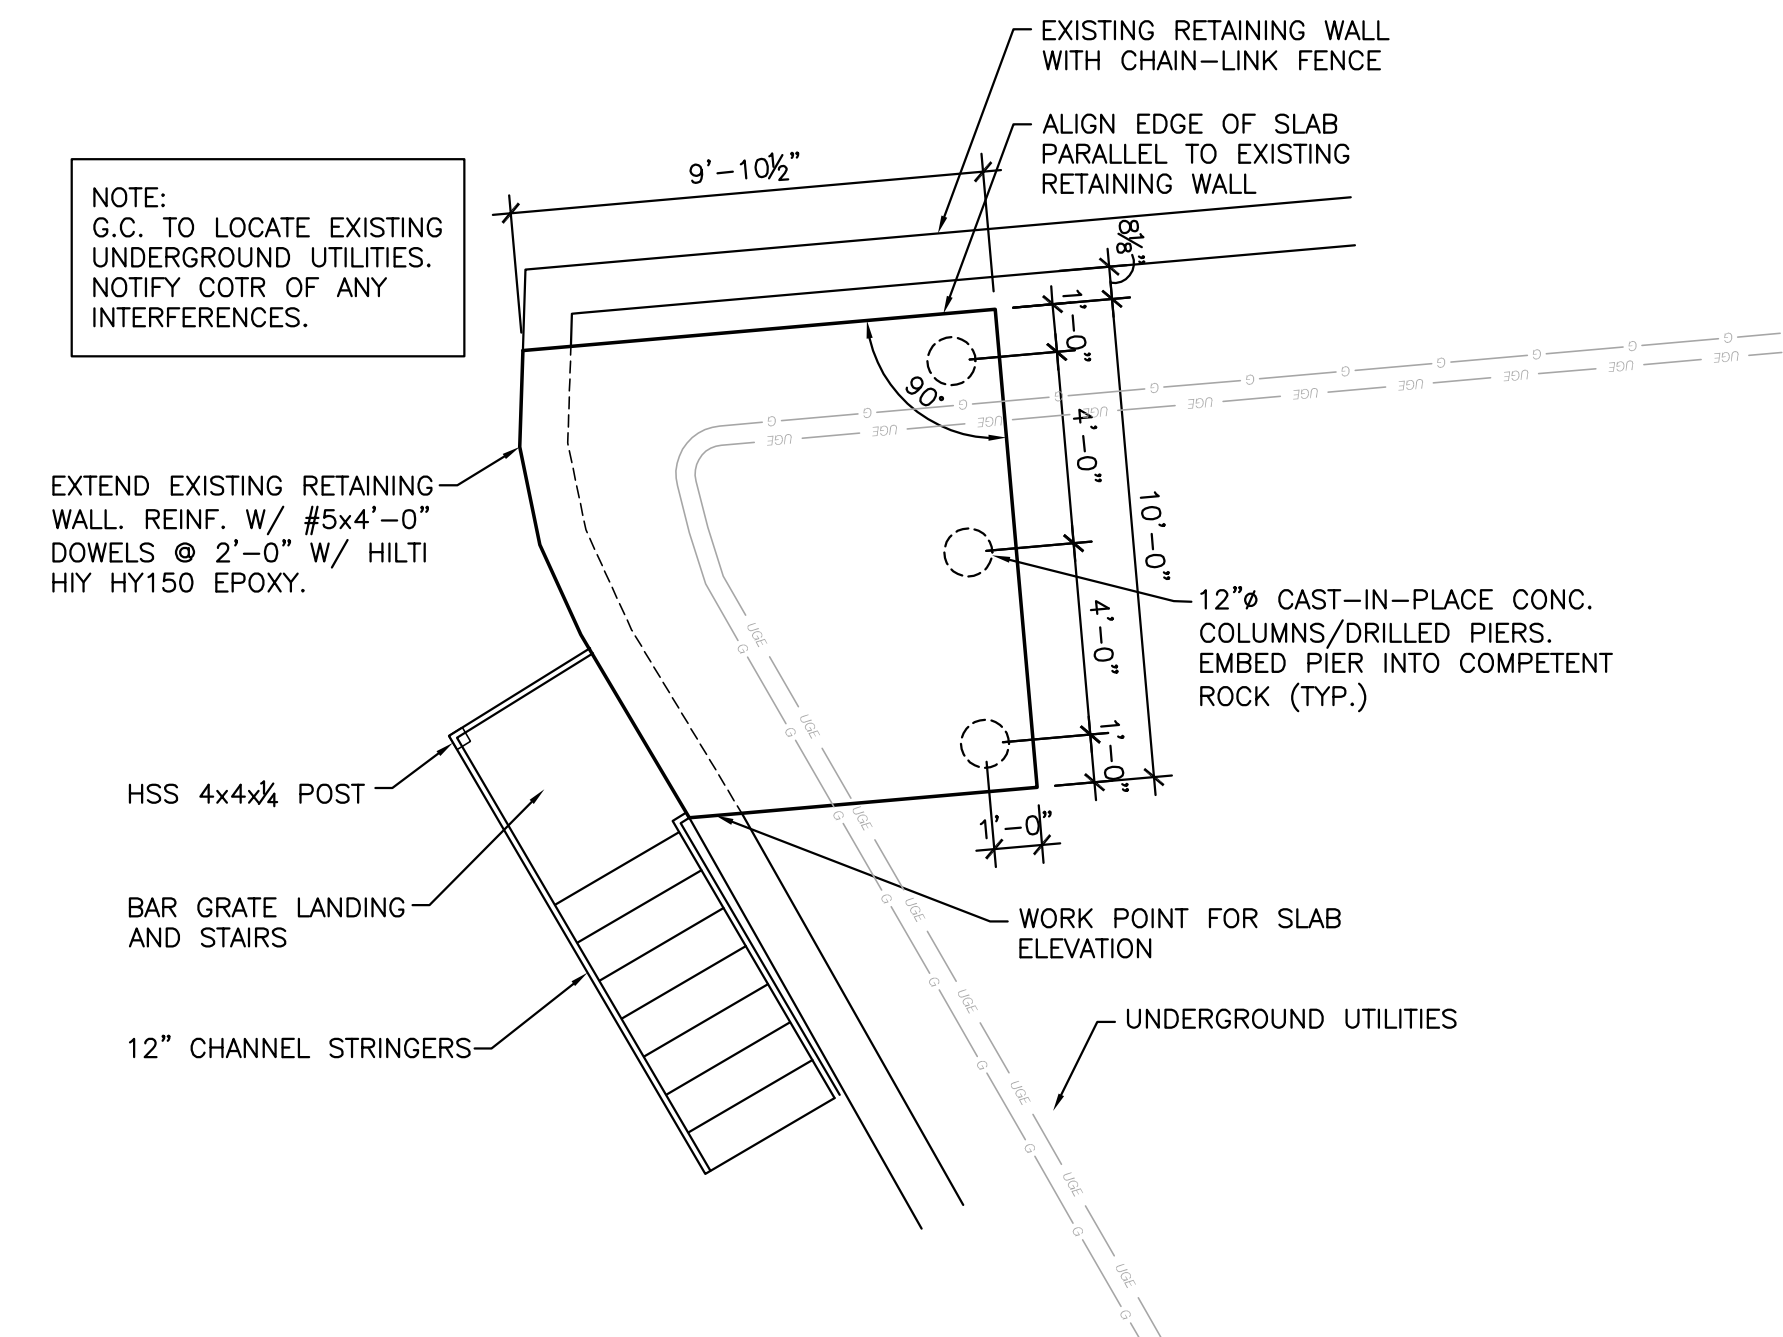

### GUARD HOUSE PLATFORM

GRAPHIC SCALE SUPERSEDES NUMERIC SCALE  
0 2' 4' 8'  
SCALE: 1/4" = 1'-0"

FULLY SPRINKLERED BUILDING  
**100% BID DOCUMENTS SUBMITTAL**


REVISIONS	DATE
1	
2	
3	
4	
5	
6	
7	
8	



**PARADIGM**  
ENGINEERS AND CONSTRUCTORS  
PO BOX 498223  
Louisville, Kentucky 40253  
502-839-8511 www.paradigmusa.com

UPGRADE SPD AND SECURITY DOCK  
PROJECT: 646-367  
**VA PITTSBURGH**  
**HEALTHCARE SYSTEM**  
UNIVERSITY DRIVE C  
PITTSBURGH, PENNSYLVANIA 15240

Department of  
Veterans Affairs

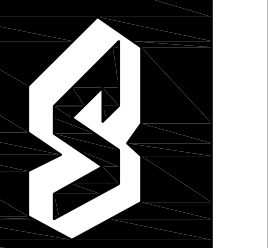

MADE BY	CHECKED
DATE	2-09-11
DUMPSTER PLATFORM AND GUARD HOUSE PLANS	
DRAWING NO. <b>S2.0</b>	REV. NO.