



ONE INCH = FORTY FEET (1" = 40')


ONE AND ONE HALF INCHES = ONE FOOT

ONE QUARTER INCH = ONE FOOT

ONE HALF INCH = ONE FOOT

ONE EIGHT INCH = ONE FOOT

ONE SIXTEENTH INCH = ONE FOOT

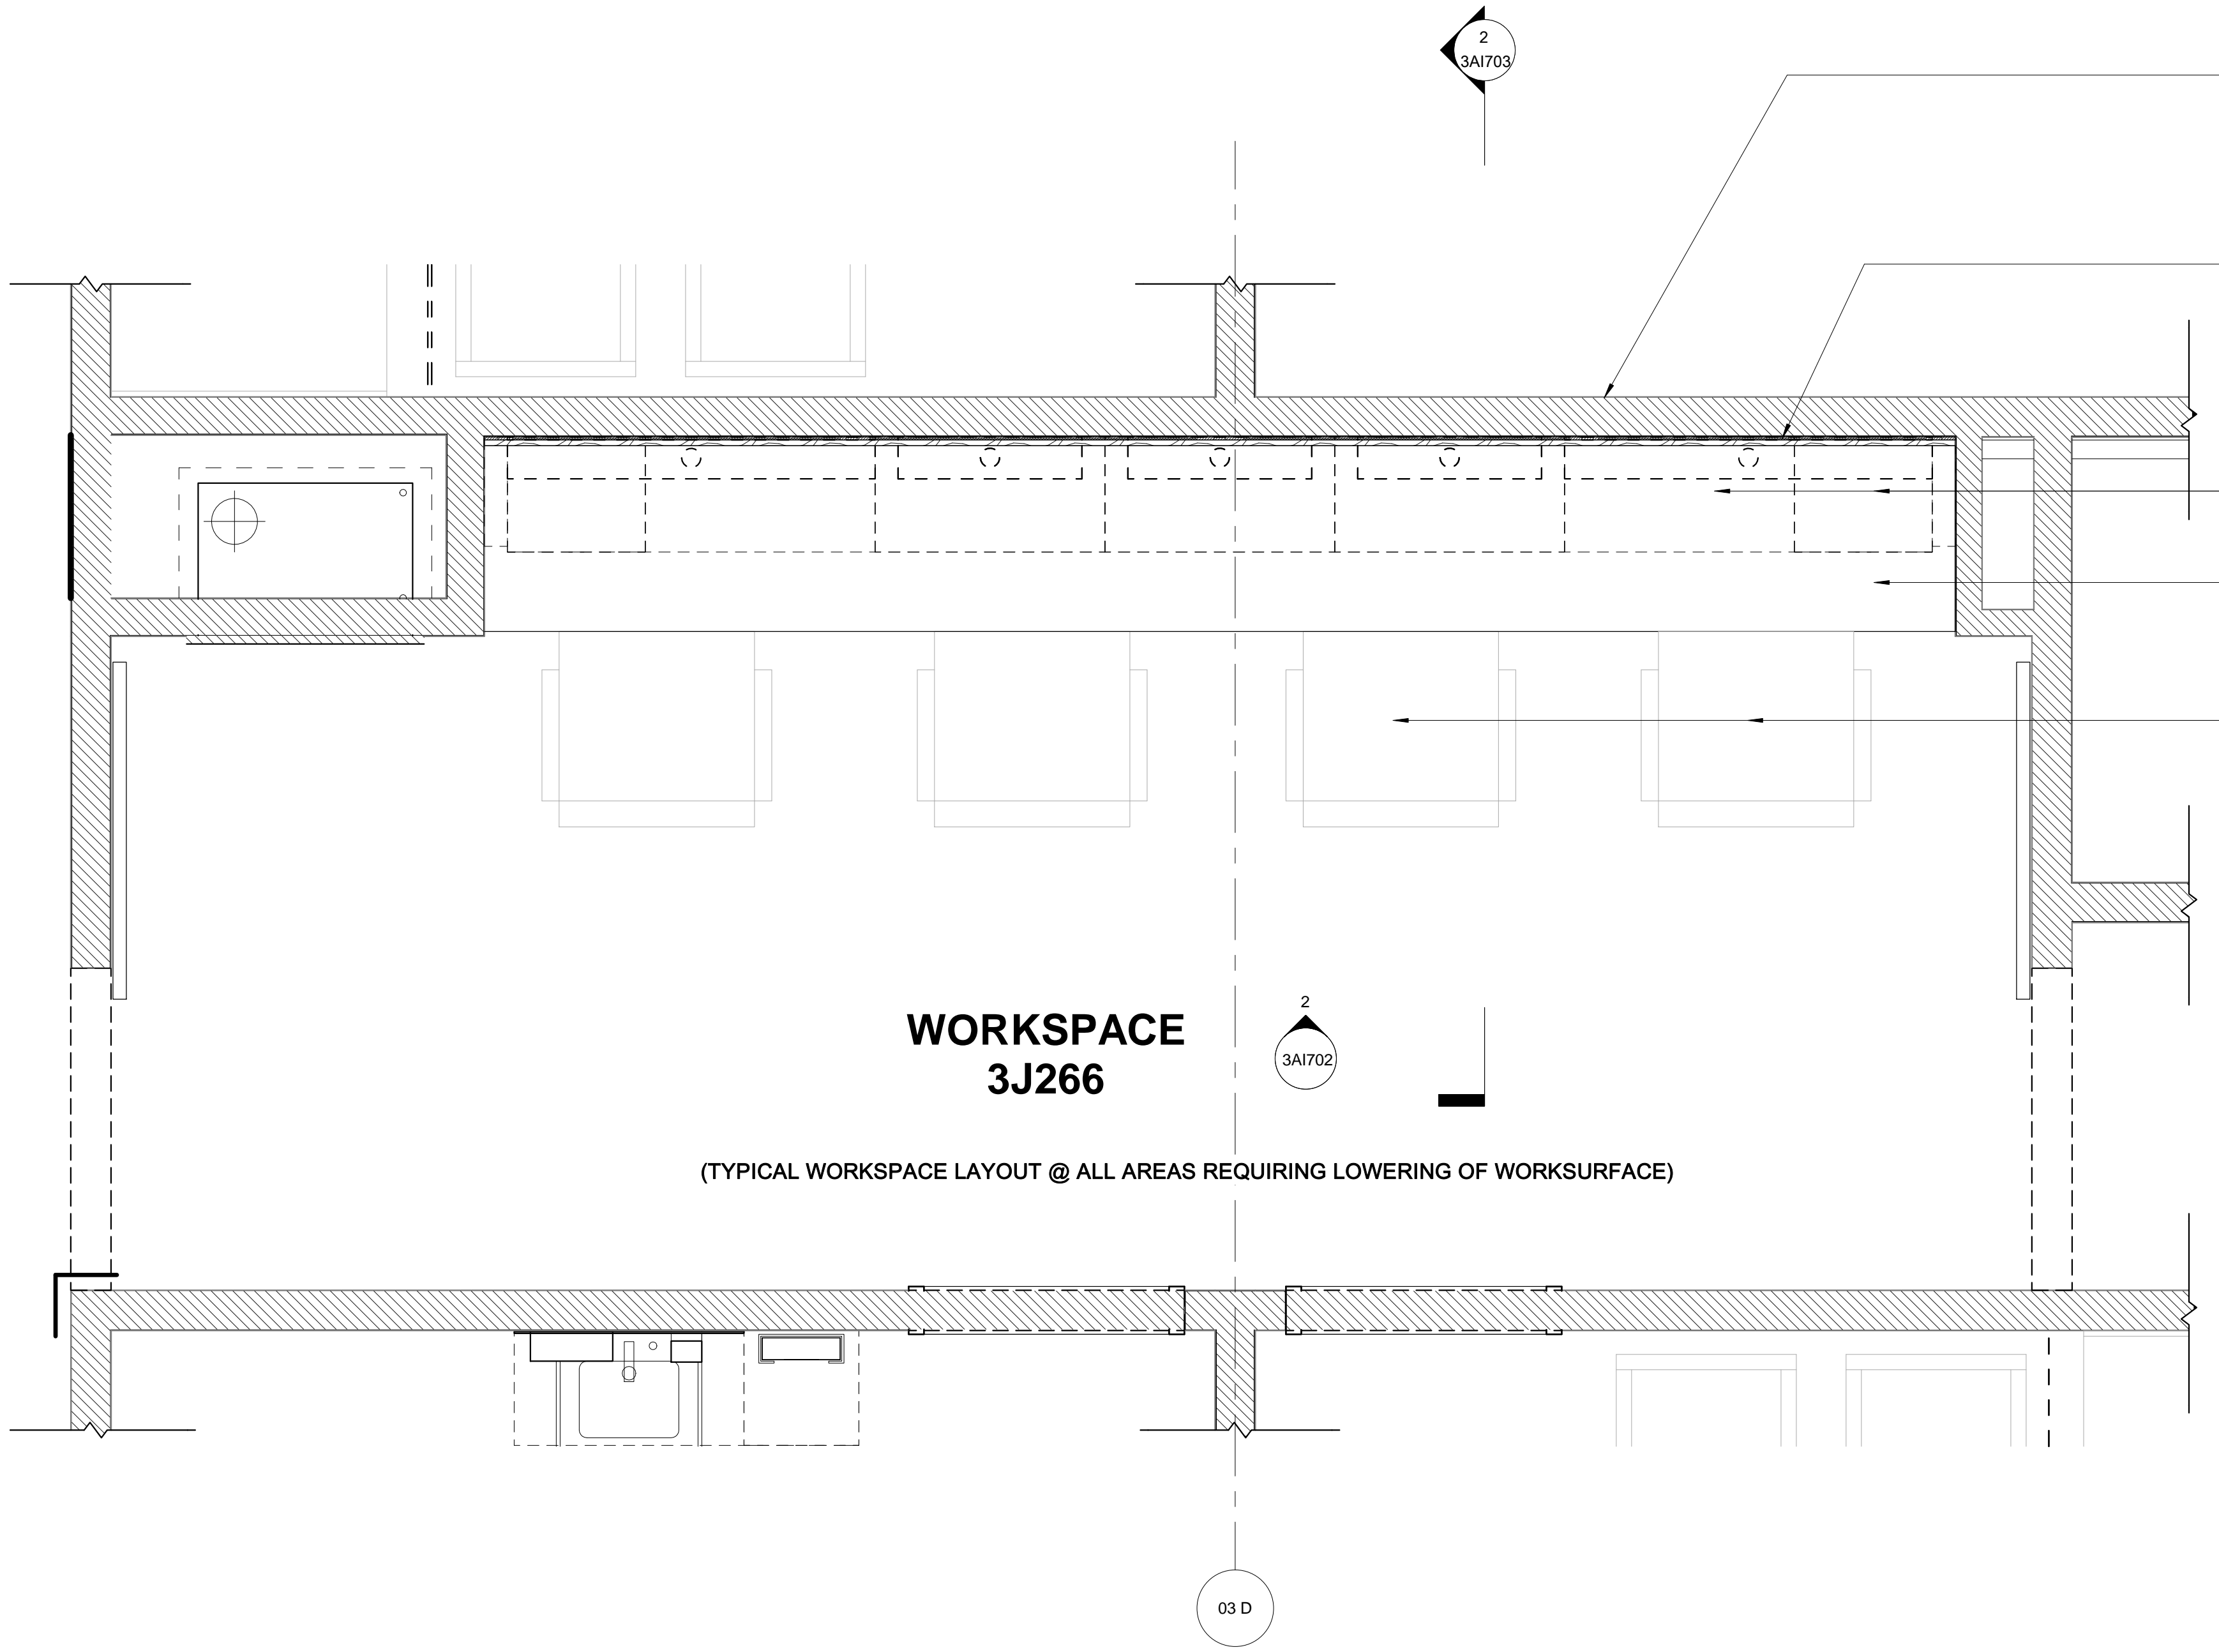

**EXISTING WALL:**  
DESCRIPTION - ACOUSTIC 5 1/4" WALL  
4" STUD WALL W/ 1 LAYER GYP. BOARD EACH SIDE  
ASSEMBLY DESCRIPTION - PARTITION WALL W/ METAL STUD  
FIRE RATING - 0 HR  
(MUST VERIFY EXISTING WALL CONDITIONS IN FIELD)

EXISTING BACKSPLASH TO BE REMOVED AND REPLACED  
(TYPICAL @ ALL WORKSPACES)

EXISTING WALL HUNG CABINETS TO REMAIN  
(TYPICAL @ ALL WORKSPACES)

EXISTING WORKSURFACE TO BE LOWERED  
(TYPICAL @ ALL WORKSPACES)

CHAIRS

**NURSES WORKSPACE LOCATION(S) AND ROOM NUMBER(S):**

OUT-PATIENT BUILDING (2ND FLOOR)  
1. 2J255  
2. 2J254  
3. 2J285

OUT-PATIENT BUILDING (3RD FLOOR)  
1. 3J247  
2. 3J266  
3. 3J287  
4. 3J296

OUT-PATIENT BUILDING (4TH FLOOR)  
1. 4J237  
2. 4J256

OUT-PATIENT BUILDING (5TH FLOOR)  
1. 5J246  
2. 5J247  
3. 5J425








OUT-PATIENT BUILDING (6TH FLOOR)  
1. 6J247  
2. 6J266  
3. 6J267  
4. 6J407  
5. 6J426  
6. 6J427

OUT-PATIENT BUILDING (7TH FLOOR)  
1. 7J235 - 2 COUNTERS IN SPACE  
2. 7J257  
3. 7J416  
4. 7J426  
5. 7J436


TOTAL = 24 WORKSURFACE COUNTERS

1 03 Third Floor Plans - TYPICAL WORKSPACE  
SCALE: 3/4" = 1'-0"

		CONSULTANTS:		ARCHITECT/ENGINEERS:		DRAWING TITLE EXISTING WORKSPACE TYPICAL FLOOR PLAN		PROJECT TITLE LOWER WORKSURFACE COUNTERS IN OUT-PATIENT BUILDING		PROJECT NUMBER 629-18-108		BUILDING NUMBER OUT-03		OFFICE OF CONSTRUCTION AND FACILITIES MANAGEMENT  Department of Veterans Affairs	
						APPROVED: PROJECT DIRECTOR		LOCATION NEW ORLEANS, LOUISIANA		DOCUMENT SET PACKAGE		DRAWING NUMBER 3A1701			
REVISIONS:		DATE						DATE 04/24/18		CHECKED BAKER		DRAWN FEMI			

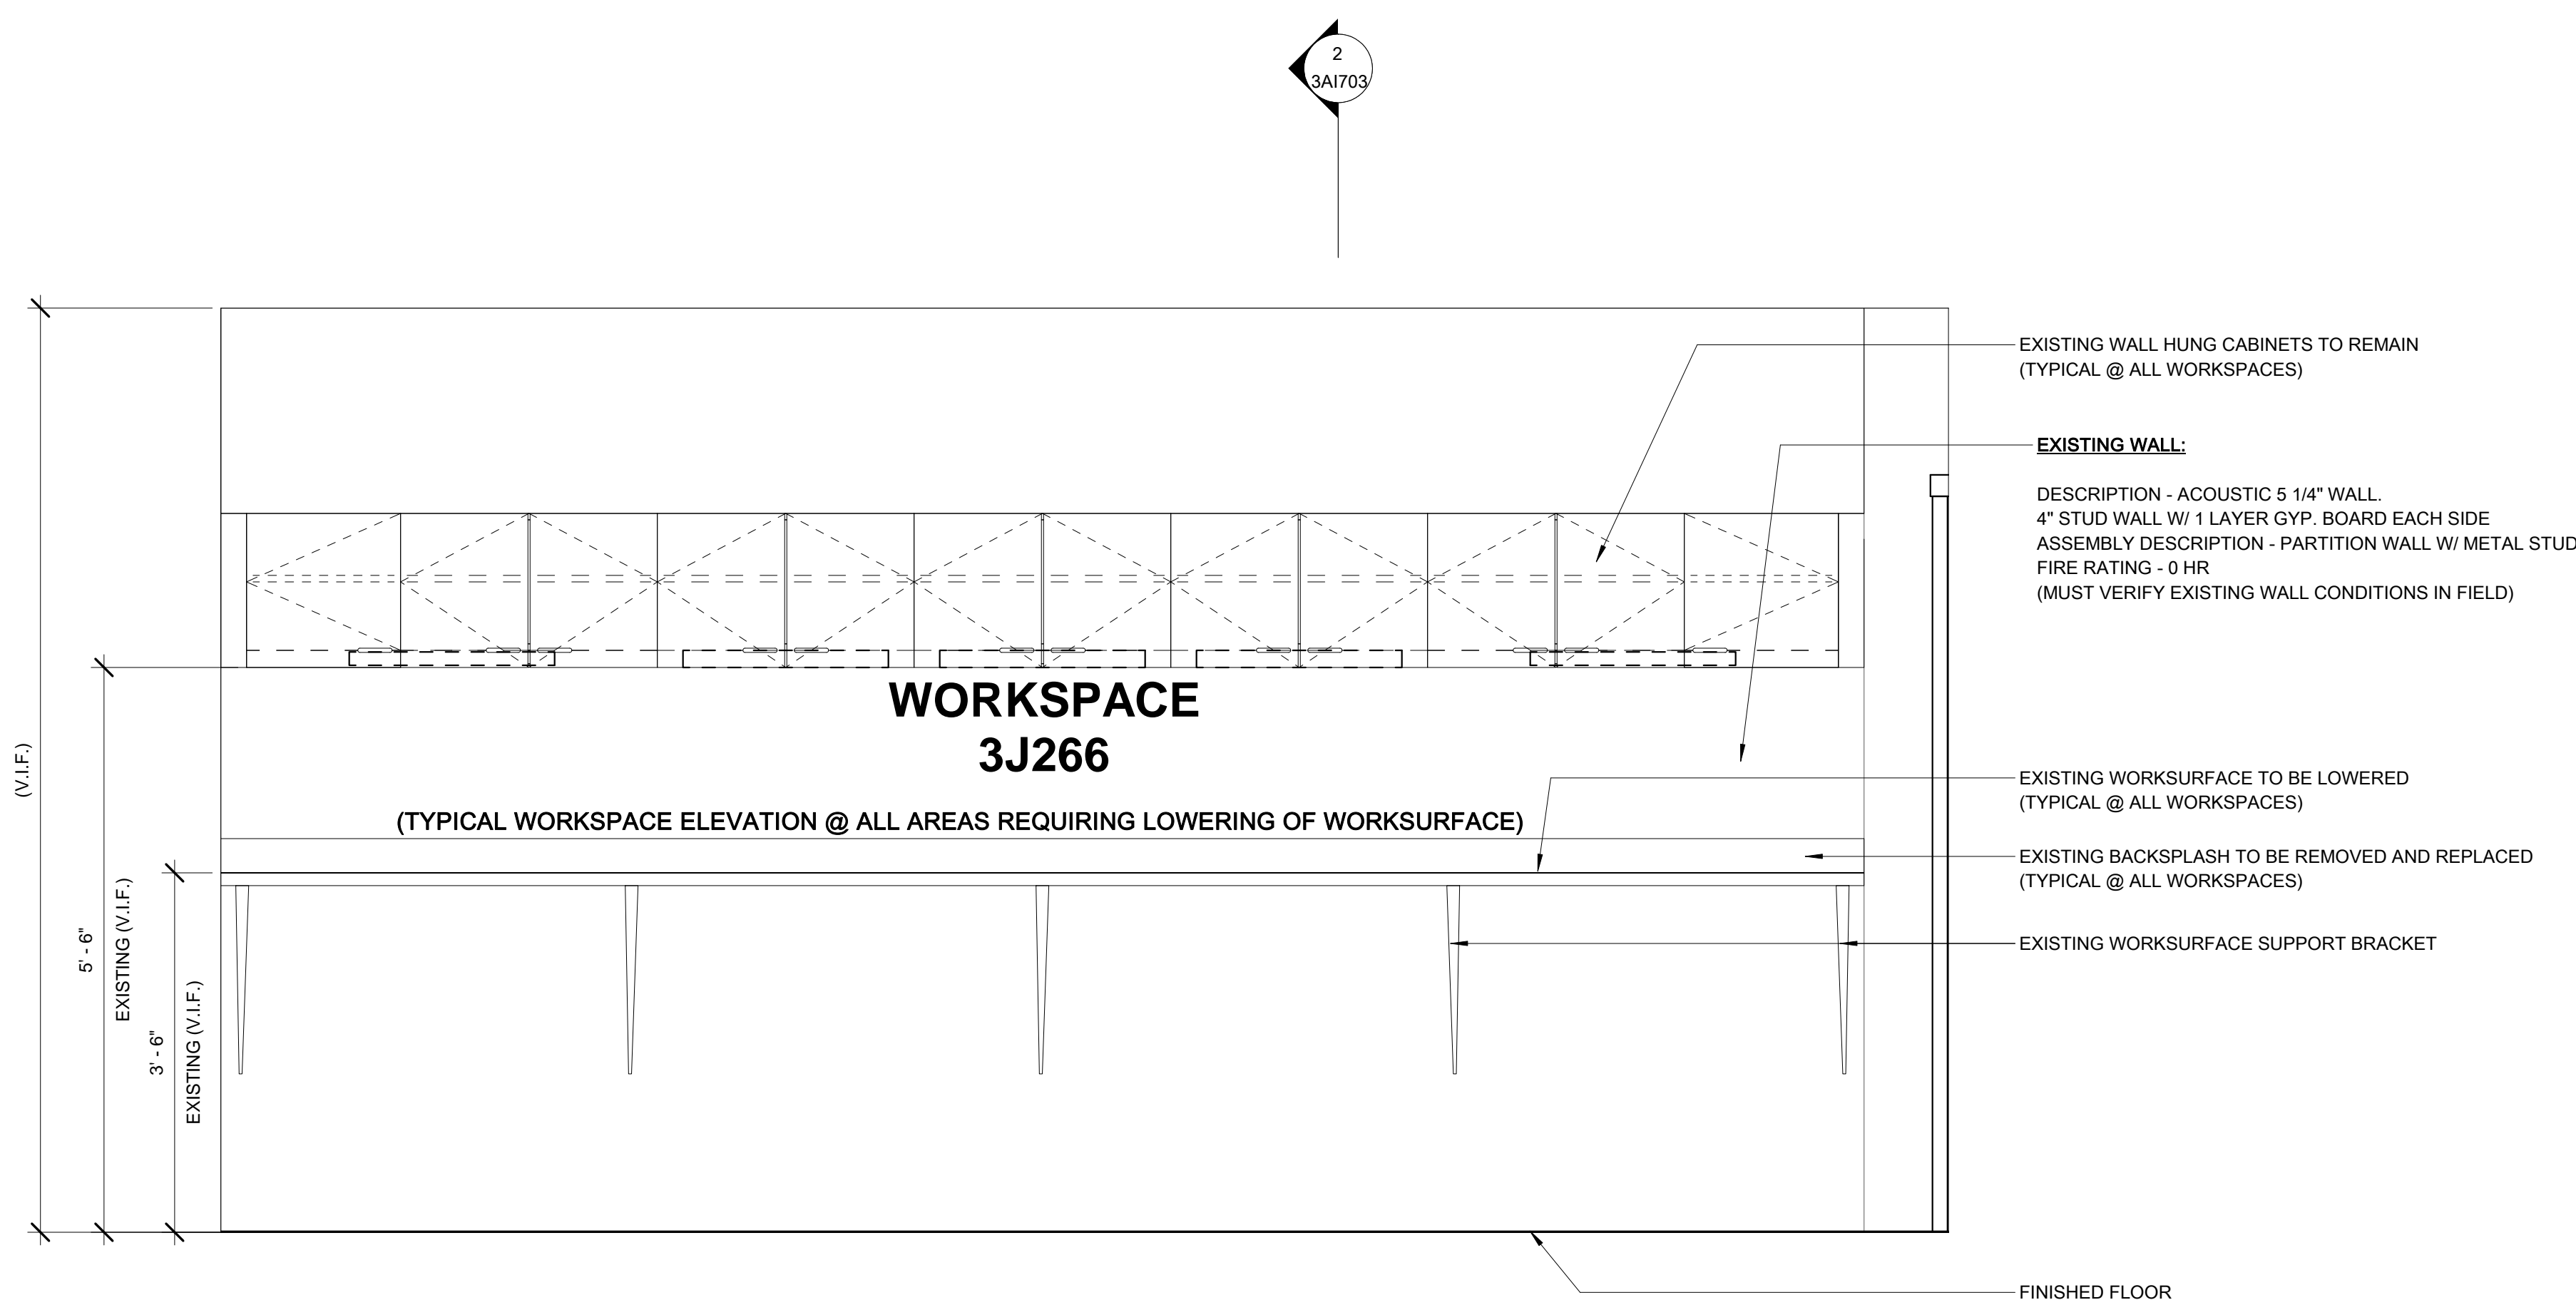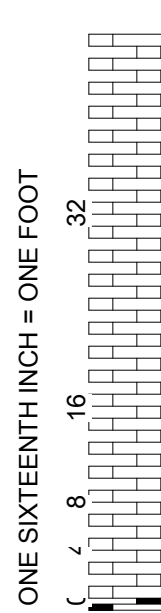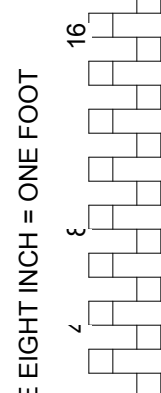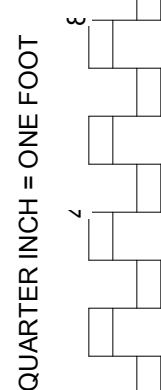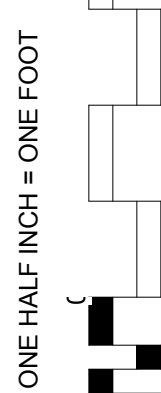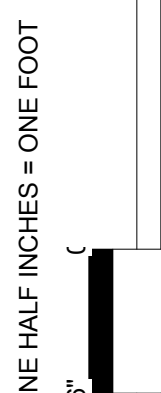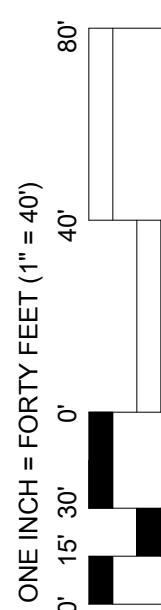

1 TYPICAL ELEVATION @ EXISTING WORKSURFACE  
SCALE: 3/4" = 1'-0"

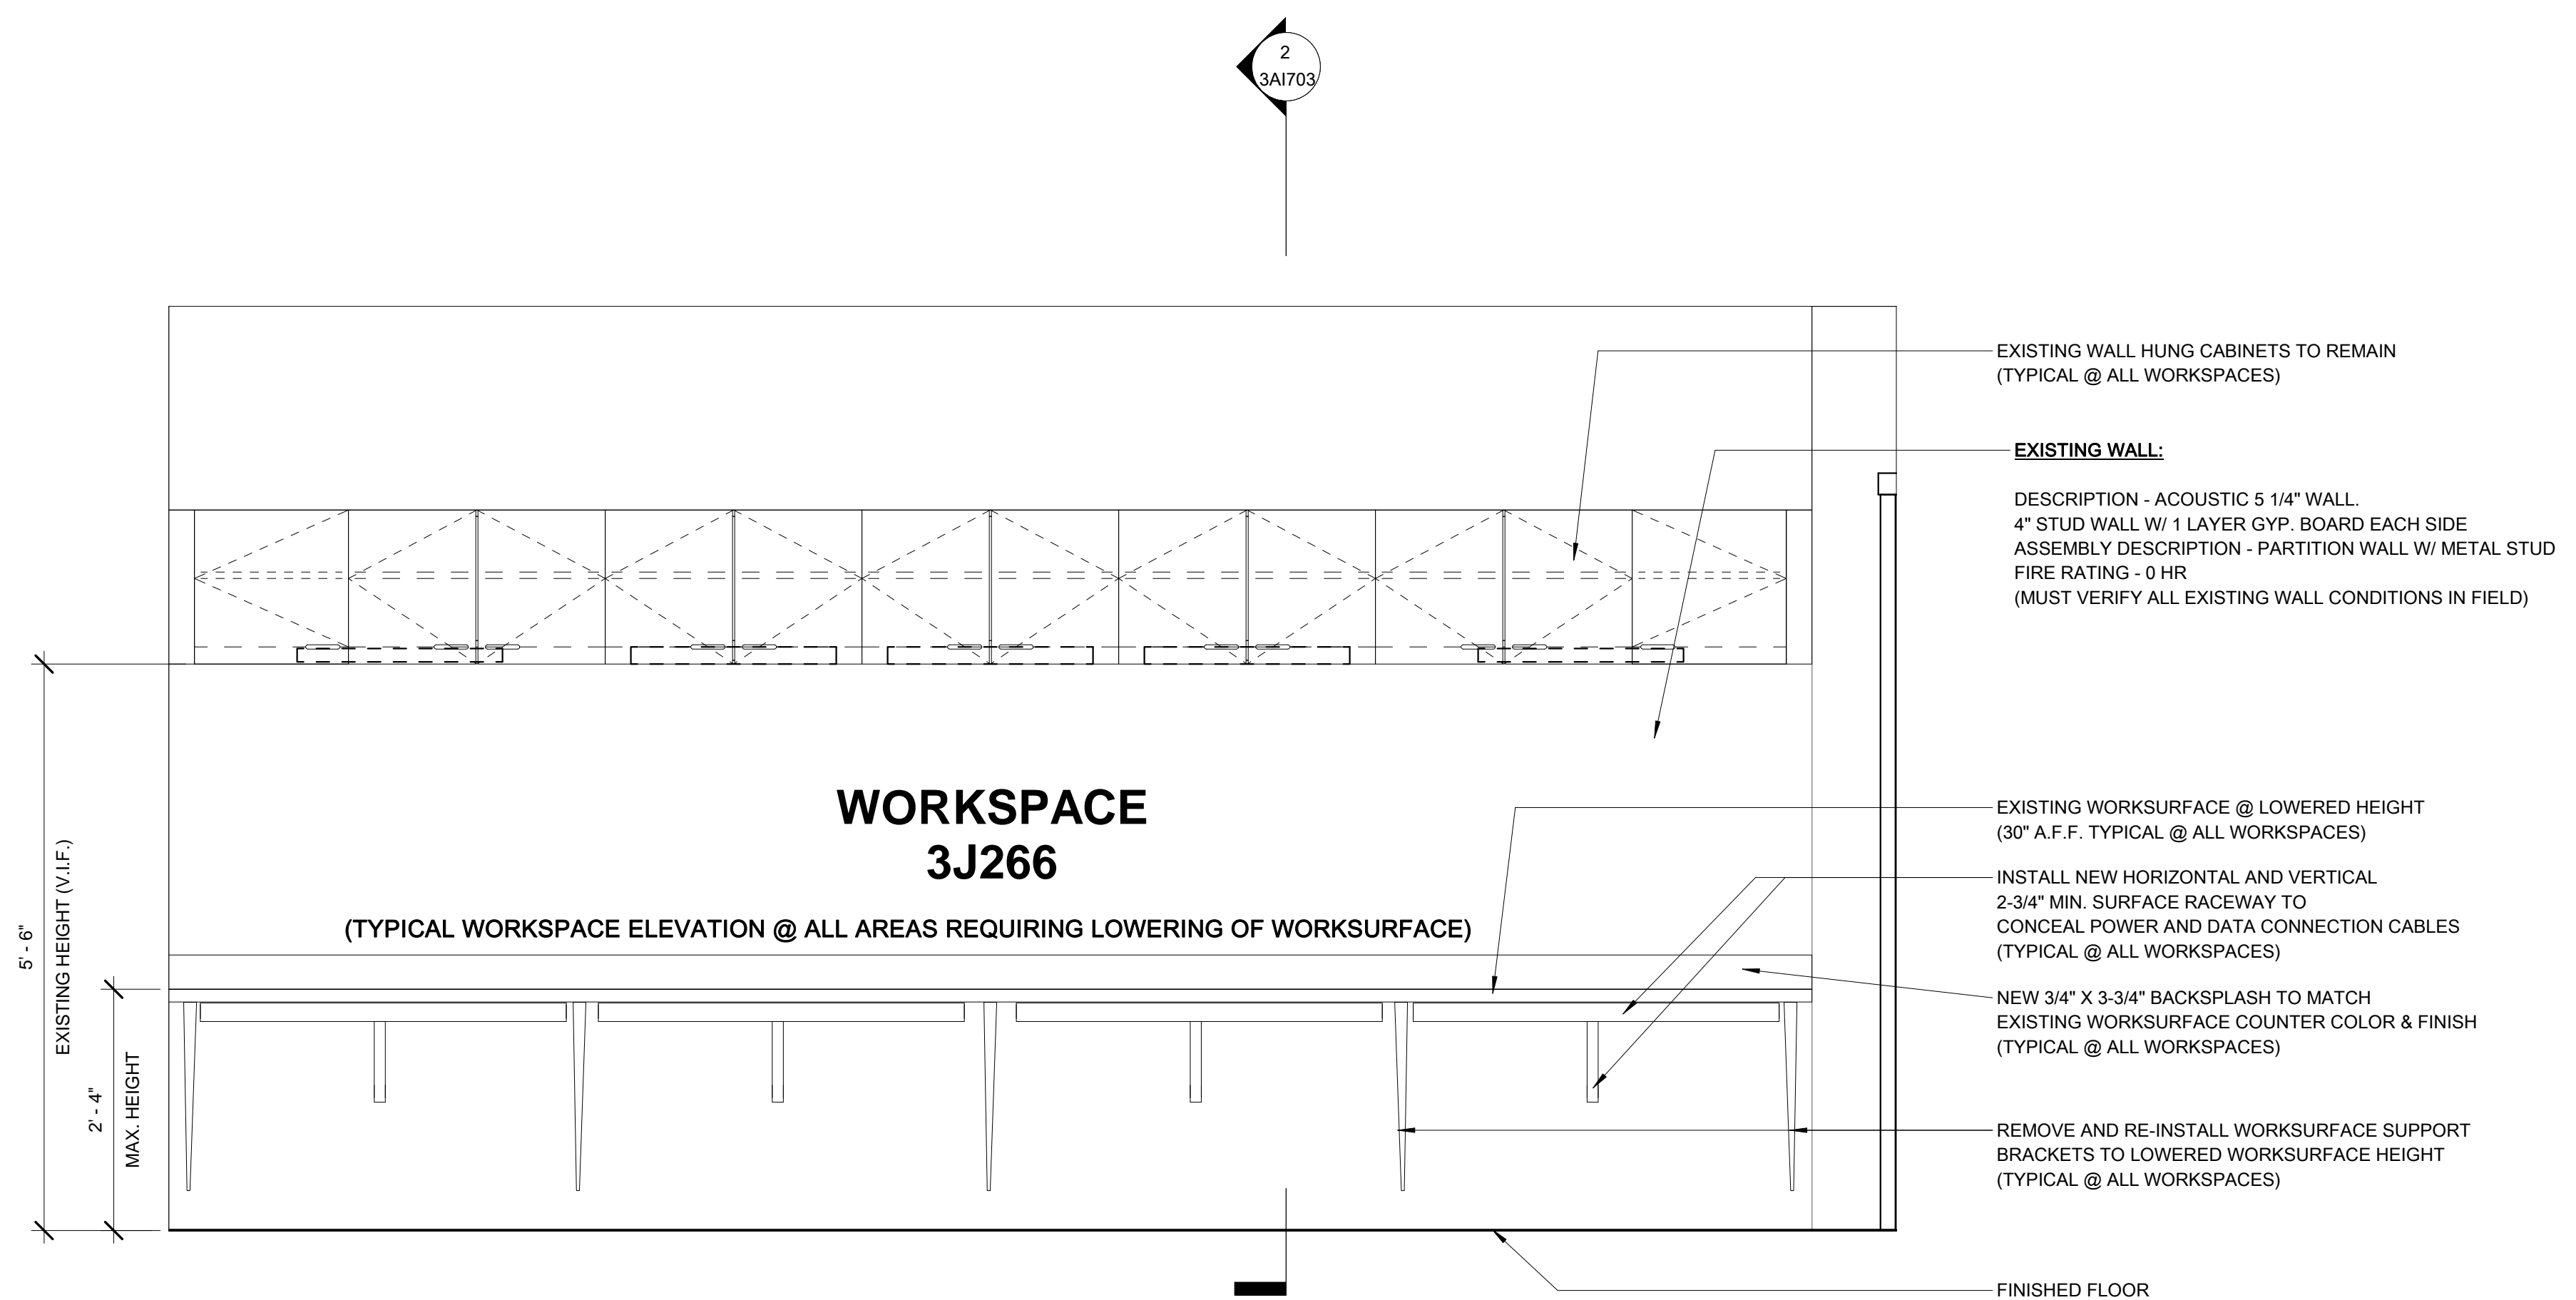


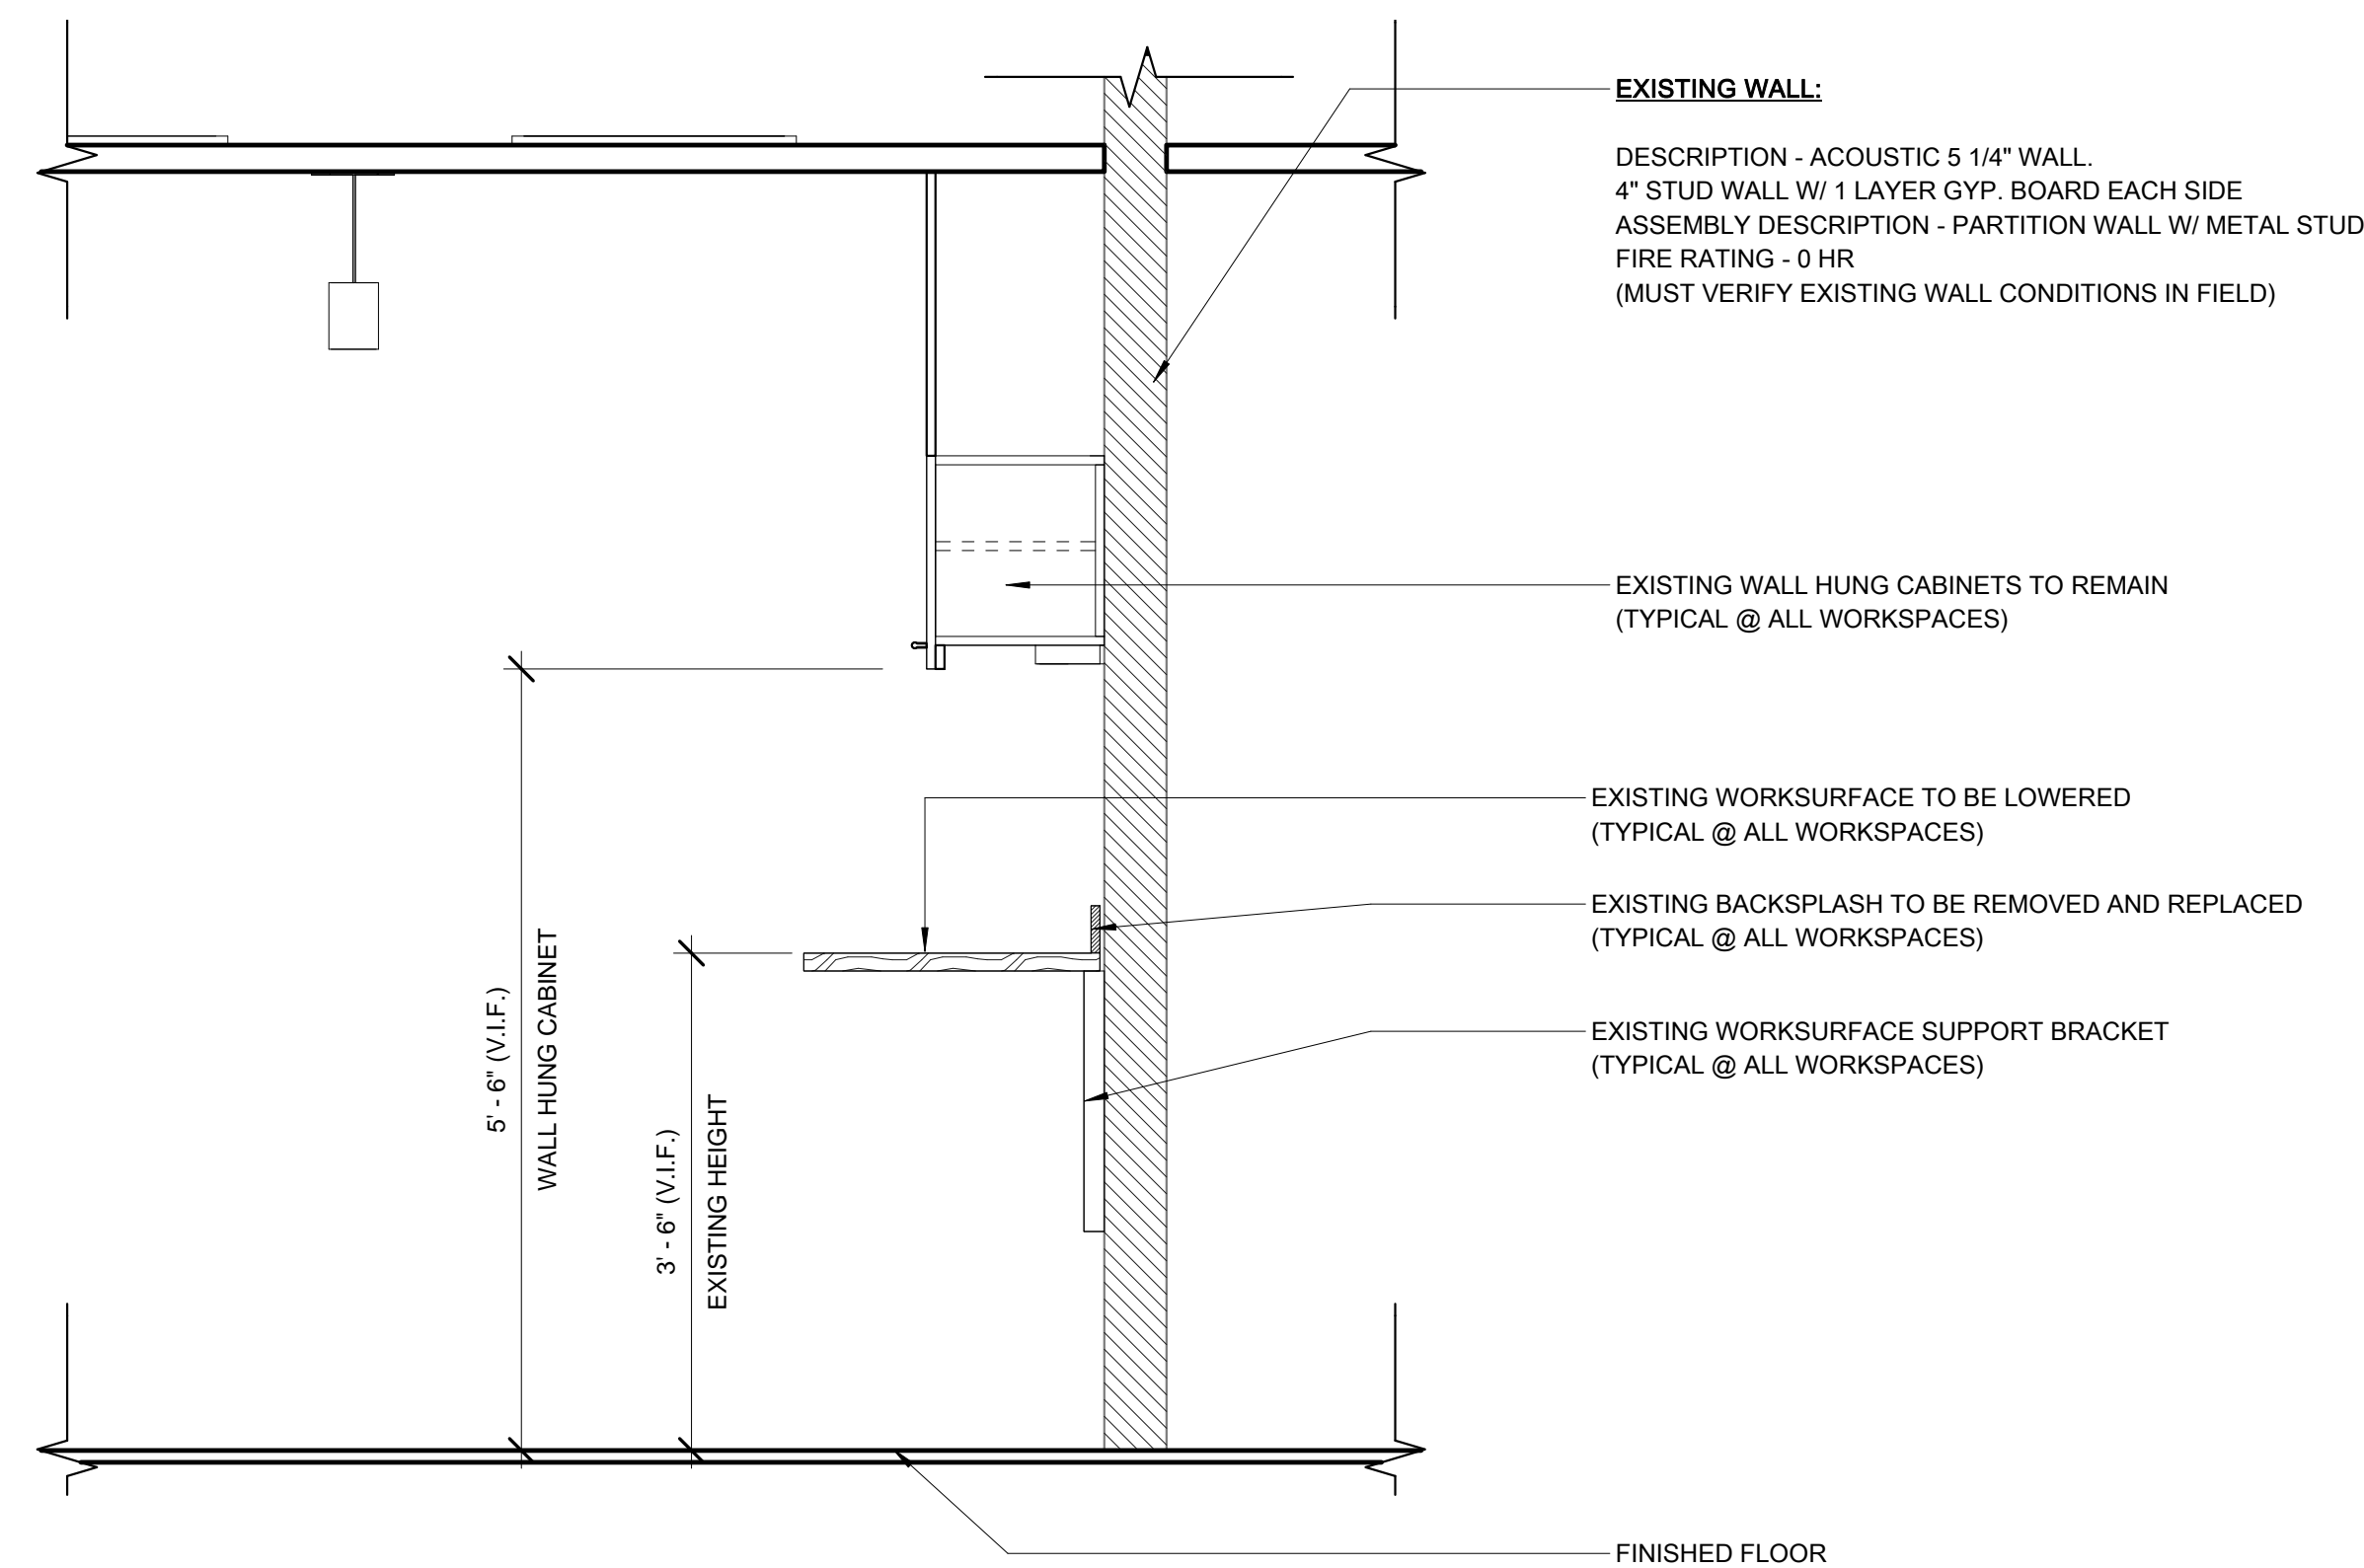
2 TYPICAL ELEVATION @ LOWERED WORKSURFACE  
SCALE: 3/4" = 1'-0"

[illegible]

CONSULTANTS:

ARCHITECT/ENGINEERS:

DRAWING TITLE TYPICAL WORKSPACE - ELEVATIONS		PROJECT TITLE LOWER WORKSURFACE COUNTERS IN OUT-PATIENT BUILDING			PROJECT NUMBER 629-18-108	BUILDING NUMBER BLDG-03	OFFICE OF CONSTRUCTION AND FACILITIES MANAGEMENT
					DOCUMENT SET PACKAGE		
APPROVED: PROJECT DIRECTOR		LOCATION NEW ORLEANS, LOUISIANA			DRAWING NUMBER		
		DATE 04/24/18	CHECKED BAKER	DRAWN FEMI	3A1702		 Department of Veterans Affairs



**WORKSPACE**  
**3J266**

(TYPICAL WORKSPACE LAYOUT @ ALL AREAS REQUIRING LOWERING OF WORKSURFACE)

**1 TYPICAL SECTION @ EXISTING WORKSURFACE**  
SCALE: 3/4" = 1'-0"

REVISIONS:		DATE

CONSULTANTS:

ARCHITECT/ENGINEERS:

DRAWING TITLE

TYPICAL WORKSPACE - SECTIONS

APPROVED: PROJECT DIRECTOR

PROJECT TITLE  
LOWER WORKSURFACE COUNTERS  
IN OUT-PATIENT BUILDING

LOCATION NEW ORLEANS, LOUISIANA	
DATE 04/23/18	CHECK BAK


PROJECT NUMBER 629-18-108	BUILDING NUMBER BLDG-03
DOCUMENT SET PACKAGE	

3A1703

OFFICE OF  
CONSTRUCTION  
AND FACILITIES  
MANAGEMENT



Department of  
Veterans Affairs

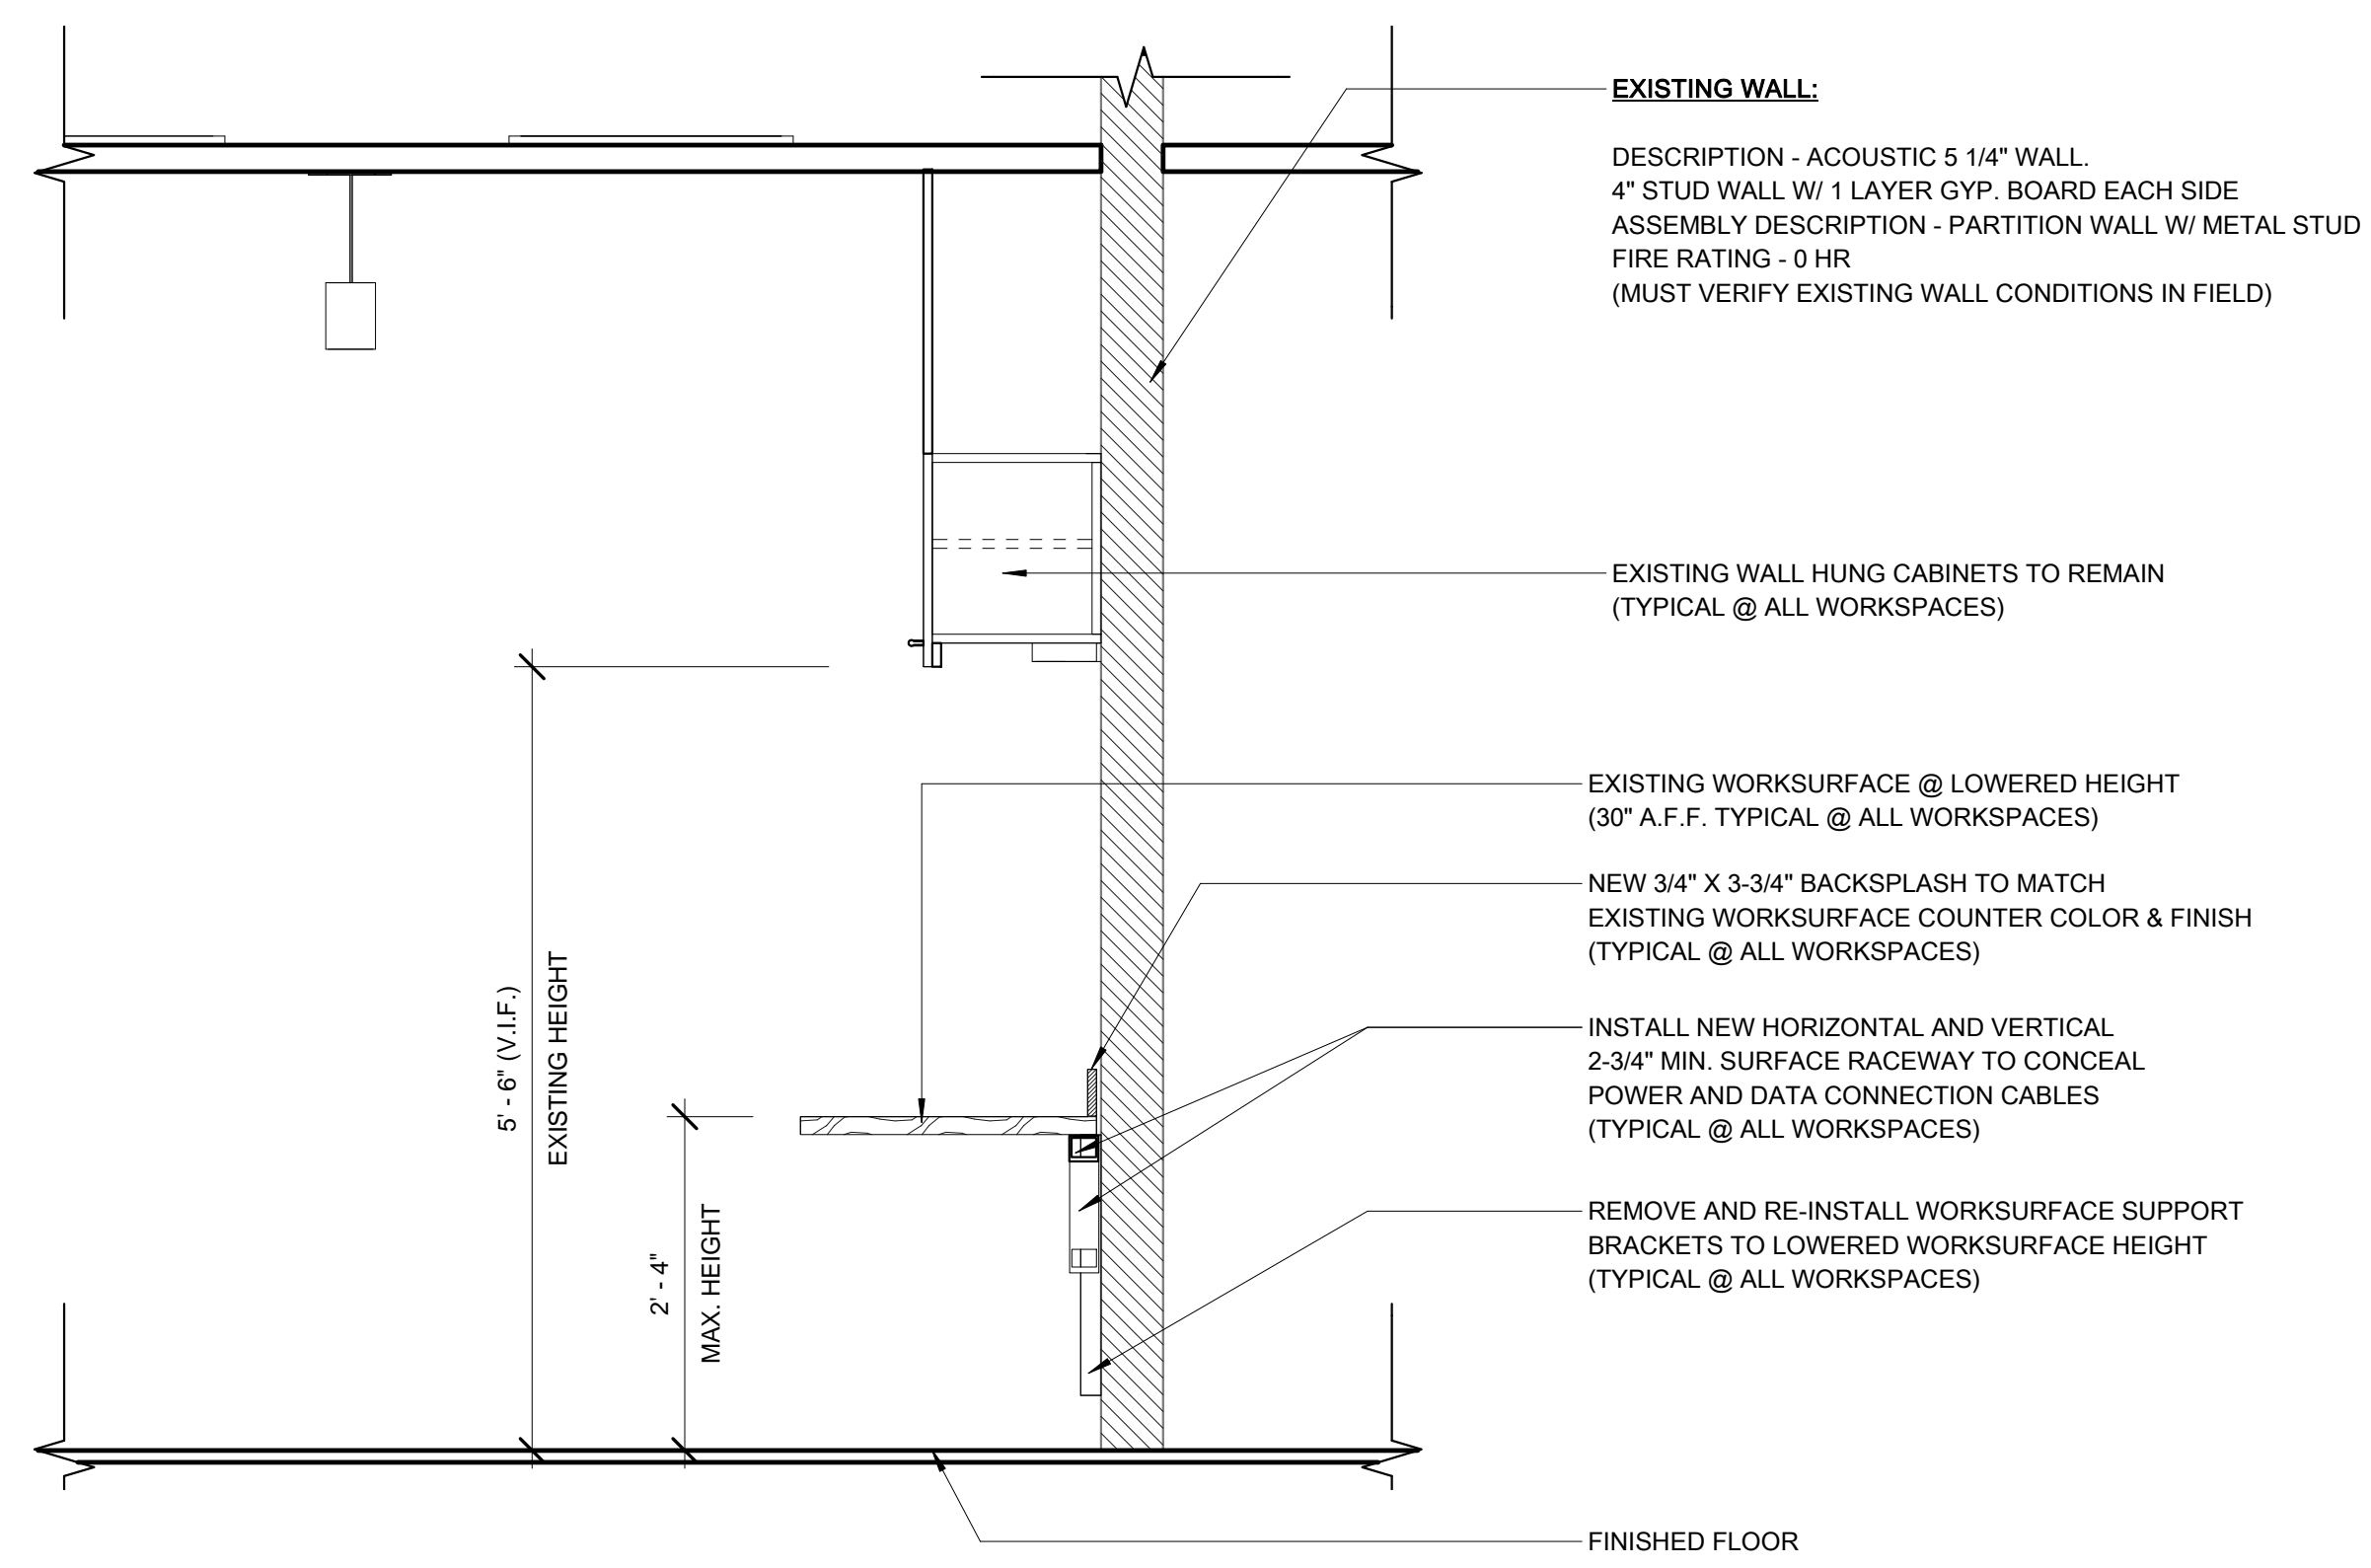

**WORKSPACE**  
**3J266**

(TYPICAL WORKSPACE LAYOUT @ ALL AREAS REQUIRING LOWERING OF WORKSURFACE)

2 TYPICAL SECTION @ NEW WORKSURFACE  
SCALE: 3/4" = 1'-0"

ONE INCH = FORTY FEET (1" = 40')

ONE AND ONE HALF INCHES = ONE FOOT


THREE QUARTERS INCH = ONE FOOT

ONE HALF INCH = ONE FOOT

ONE QUARTER INCH = ONE FOOT

ONE EIGHT INCH = ONE FOOT


ONE SIXTEENTH INCH = ONE FOOT

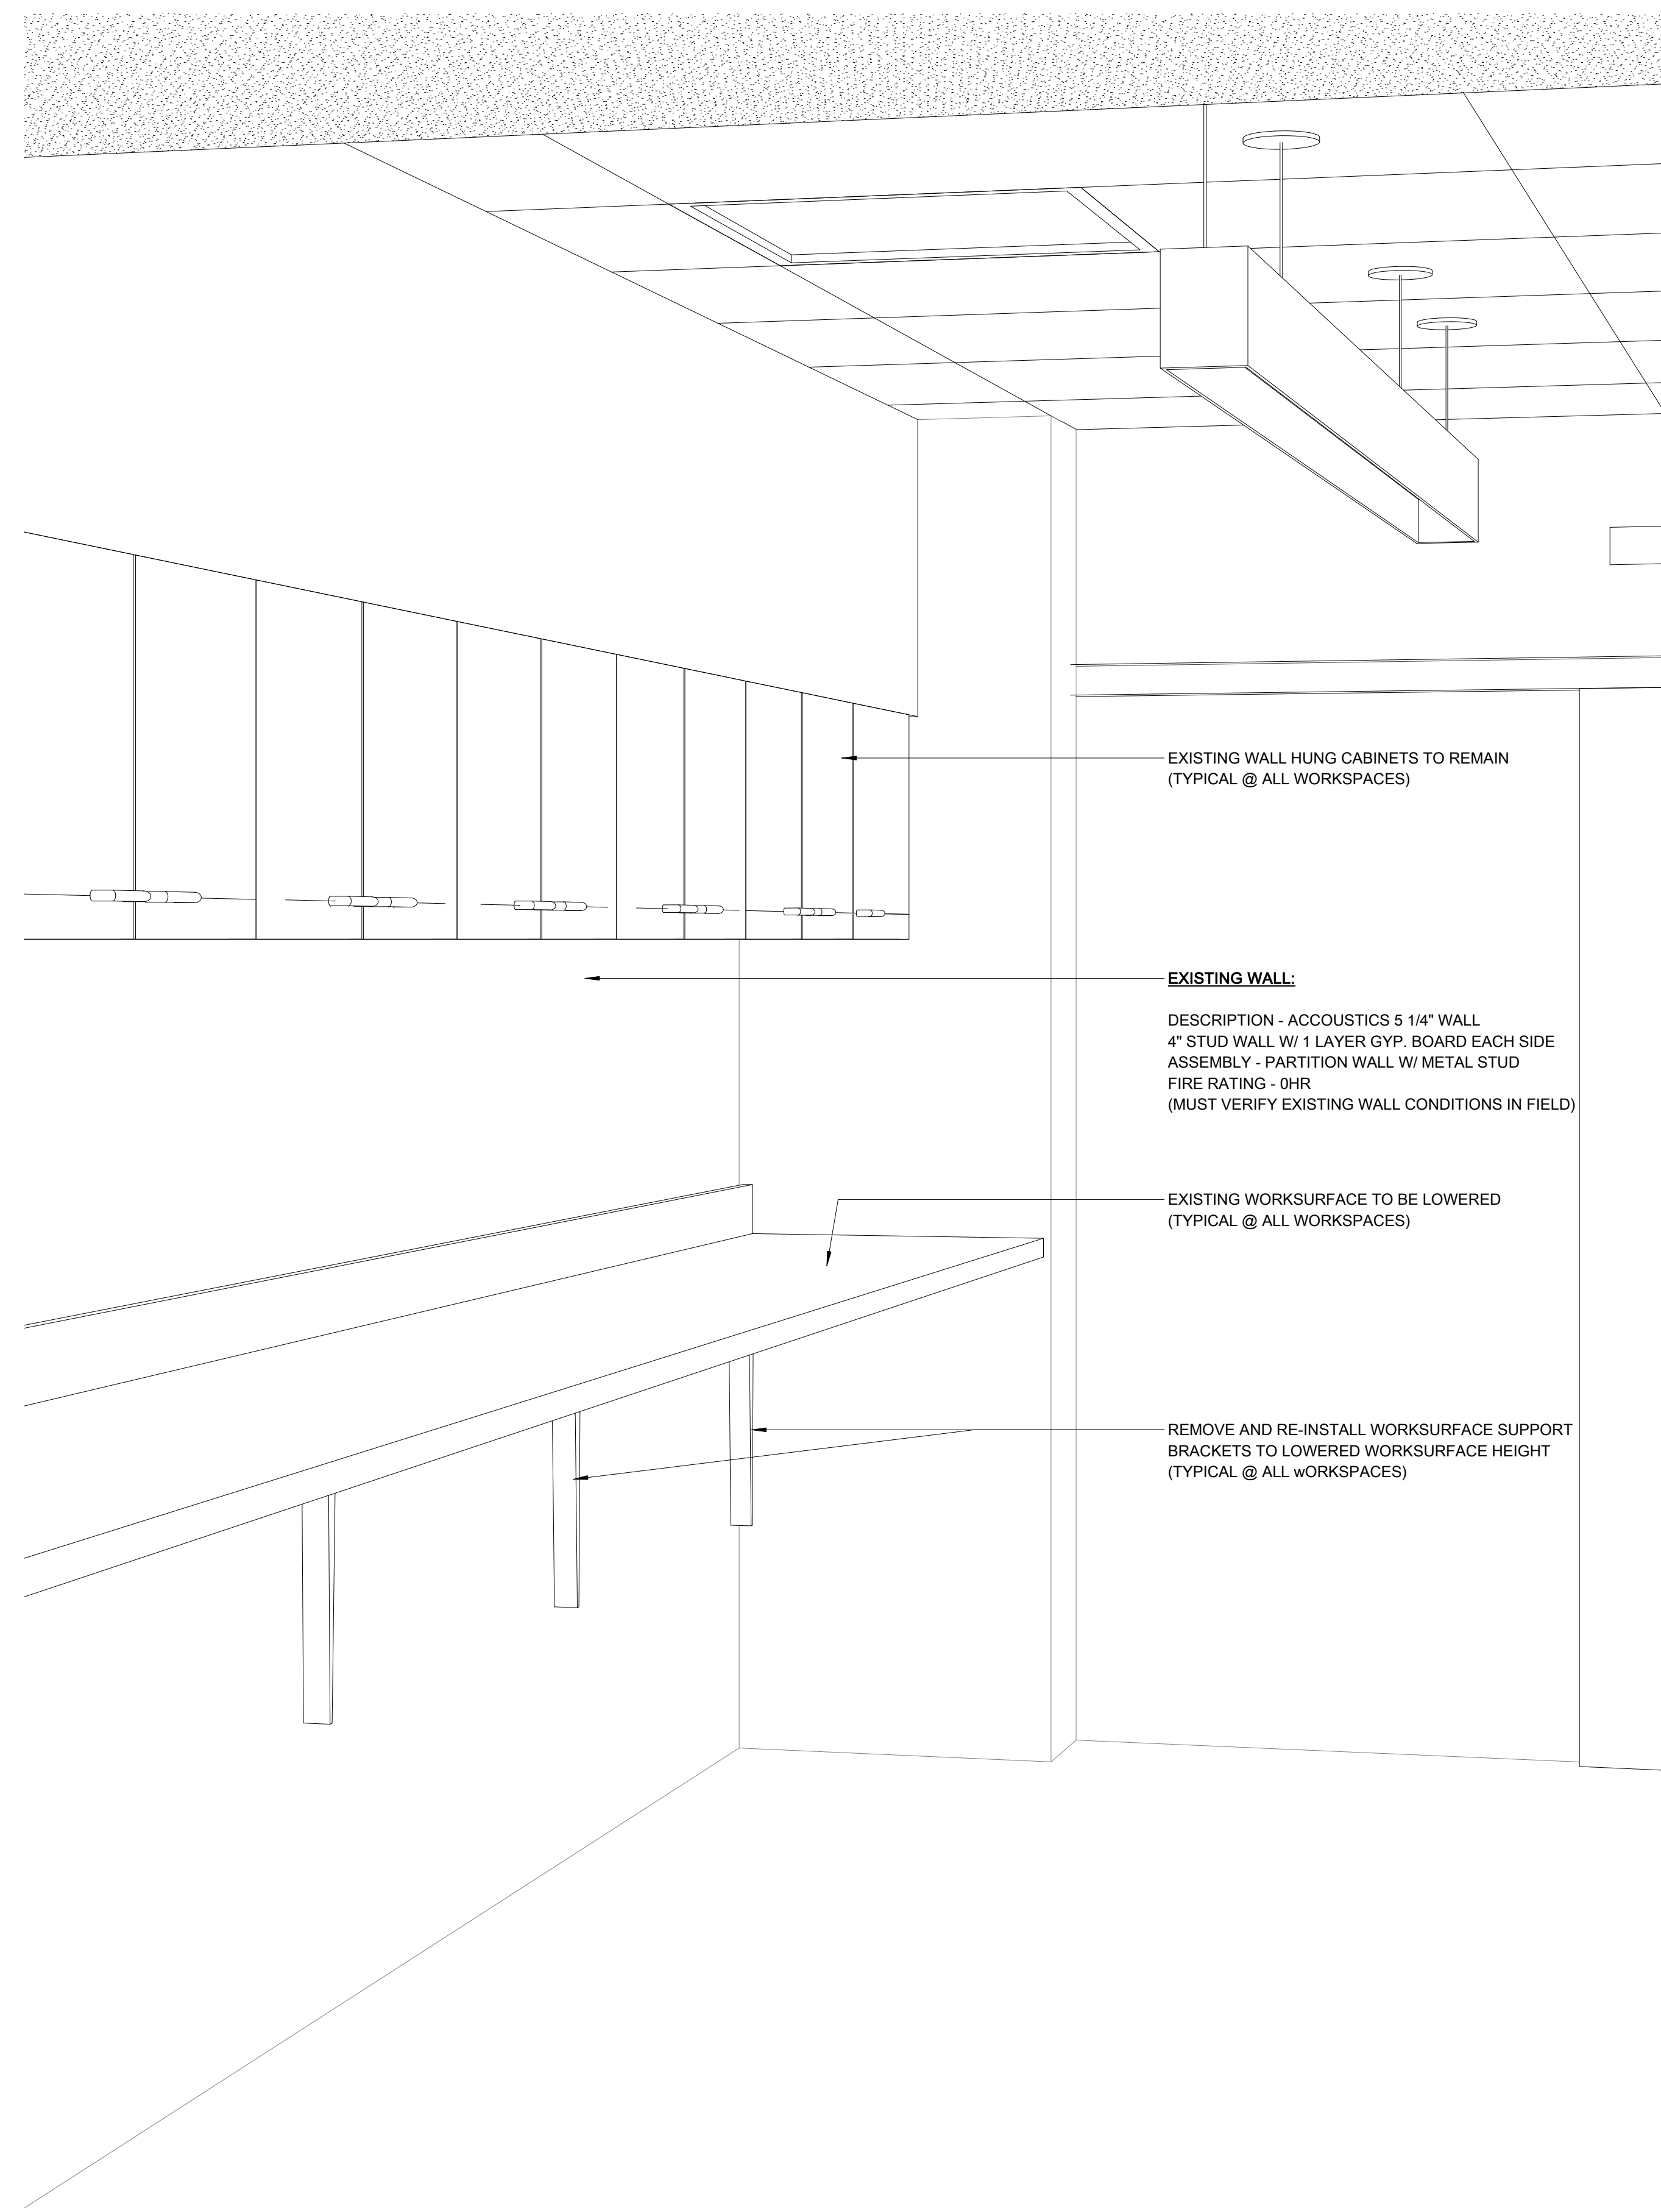

1

3D VIEW @ TYPICAL EXISTING WORKSPACE

SCALE:

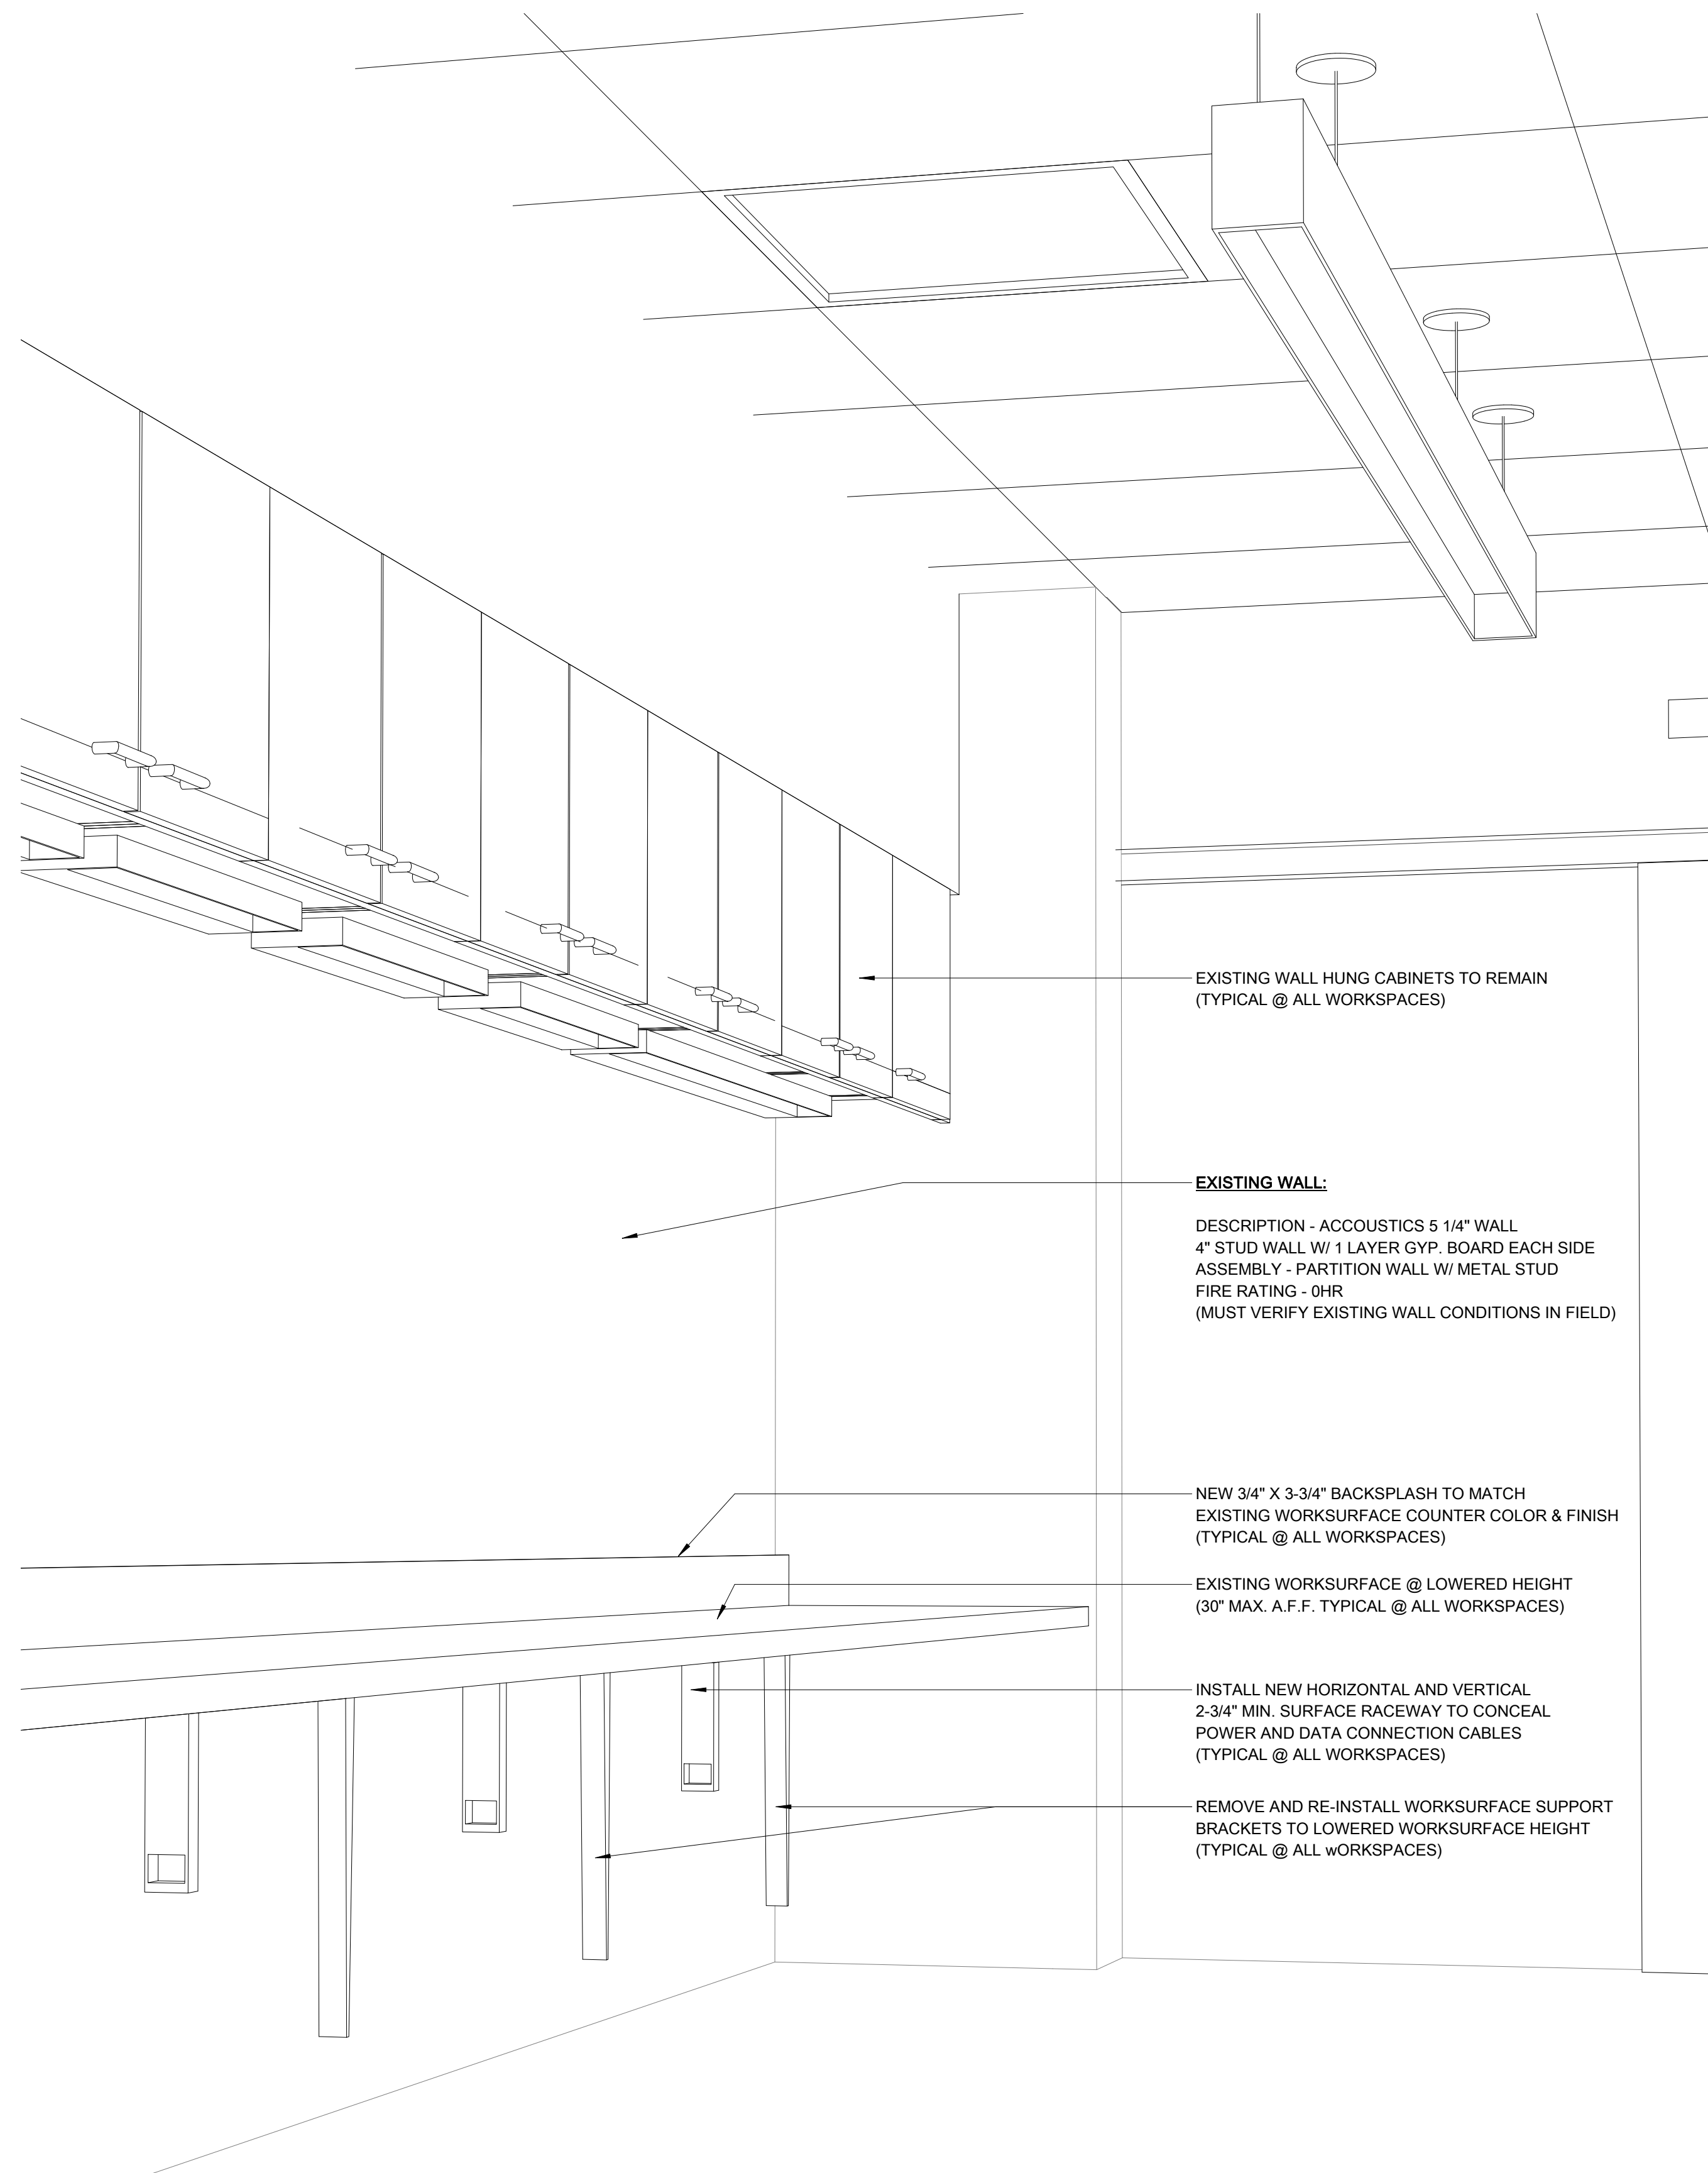

2

3D VIEW @ TYPICAL LOWERED WORKSPACE

SCALE:

<div>REVISIONS:</div> <div>DATE</div>		<div>CONSULTANTS:</div>		<div>ARCHITECT/ENGINEERS:</div>		<div>DRAWING TITLE</div> <div>ANNOTATED 3D VIEWS</div>		<div>PROJECT TITLE</div> <div>LOWER WORKSURFACE COUNTERS IN OUT-PATIENT BUILDING</div>		<div>PROJECT NUMBER</div> <div>629-18-108</div>		<div>BUILDING NUMBER</div> <div>BLDG-03</div>		<div>OFFICE OF CONSTRUCTION AND FACILITIES MANAGEMENT</div> <div> Department of Veterans Affairs</div>	
						<div>APPROVED: PROJECT DIRECTOR</div>		<div>LOCATION</div> <div>NEW ORLEANS, LOUISIANA</div>		<div>DOCUMENT SET PACKAGE</div>		<div>DRAWING NUMBER</div> <div>3A1704</div>			
								<div>DATE</div> <div>04/23/18</div>		<div>CHECKED</div> <div>BAKER</div>		<div>DRAWN</div> <div>FEMI</div>			