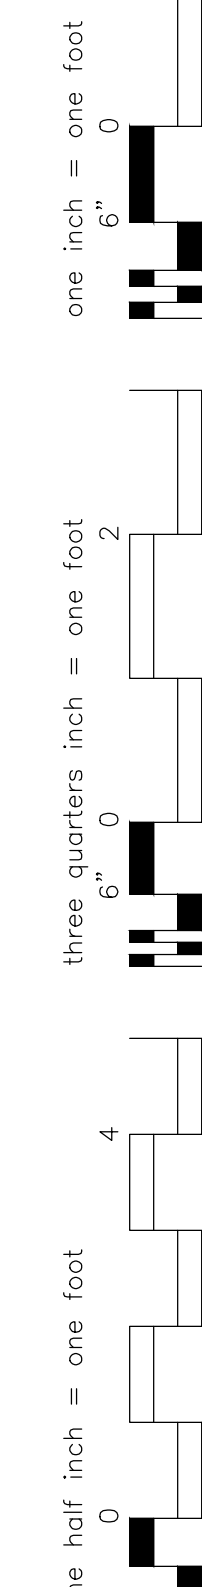
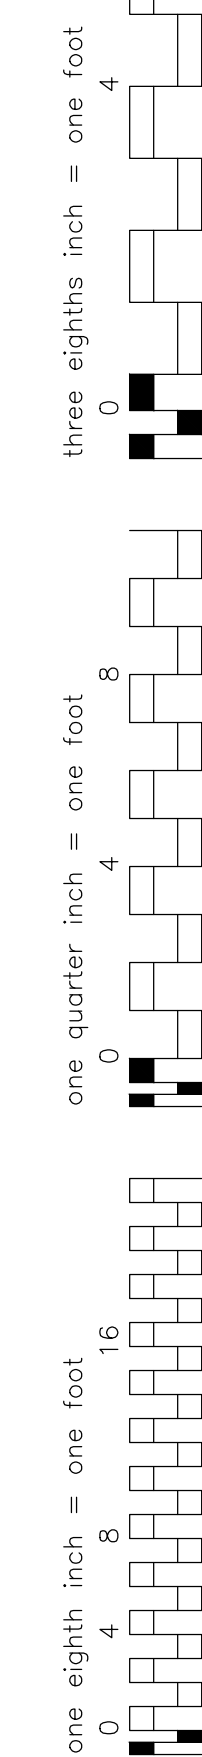

$$1/8'' = 1'-0''$$

DEMOLITION NOTES

- DEMOLITION NOTES THIS SHEET**
- 1 REMOVE EXISTING DUCTWORK AND CEILING AIR DEVICE AS INDICATED.


$$1/8'' = 1'-0''$$

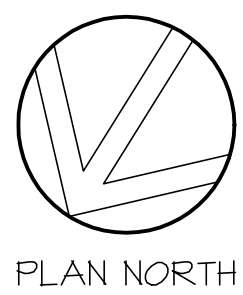
5


$$1/8'' = 1'-0''$$

 

4


$$1/\partial'' = 1' - \partial'$$

3

 $1/8" = 1' - 0"$

--	--

		ARCHITECT/ENGINEERS:		Approved Energy Engineer	Approved Infection Control	Approved Service Chief	Drawing Title: PARTIAL FLOOR PLANS - HVAC	Project Title: Patient Dining Area CLC VA Medical Center SFCS Commission Number: 6527.00	Project Number: 658-307	Office of Construction and Facilities Management	
		 SFCS Inc. • 305 South Jefferson Street Roanoke, Virginia 24011.2003 540.344.6664 • Fax 540.343.6925 www.sfcs.com	CONSTRUCTION DOCUMENTS	Approved Safety Manager	Approved Chief of Staff	Approved Chief of Facility Management Services	Location: Salem, Virginia	Building Number(s): 2/2A	Drawing Number: M1.3 Dwg. 53 of 65		
				Approved GEMS Coordinator	Approved Associate Director	Approved Medical Center Director	Date: 03/15/12	Checked: -			Drawn: DES/PA
Revisions:	Date:										