
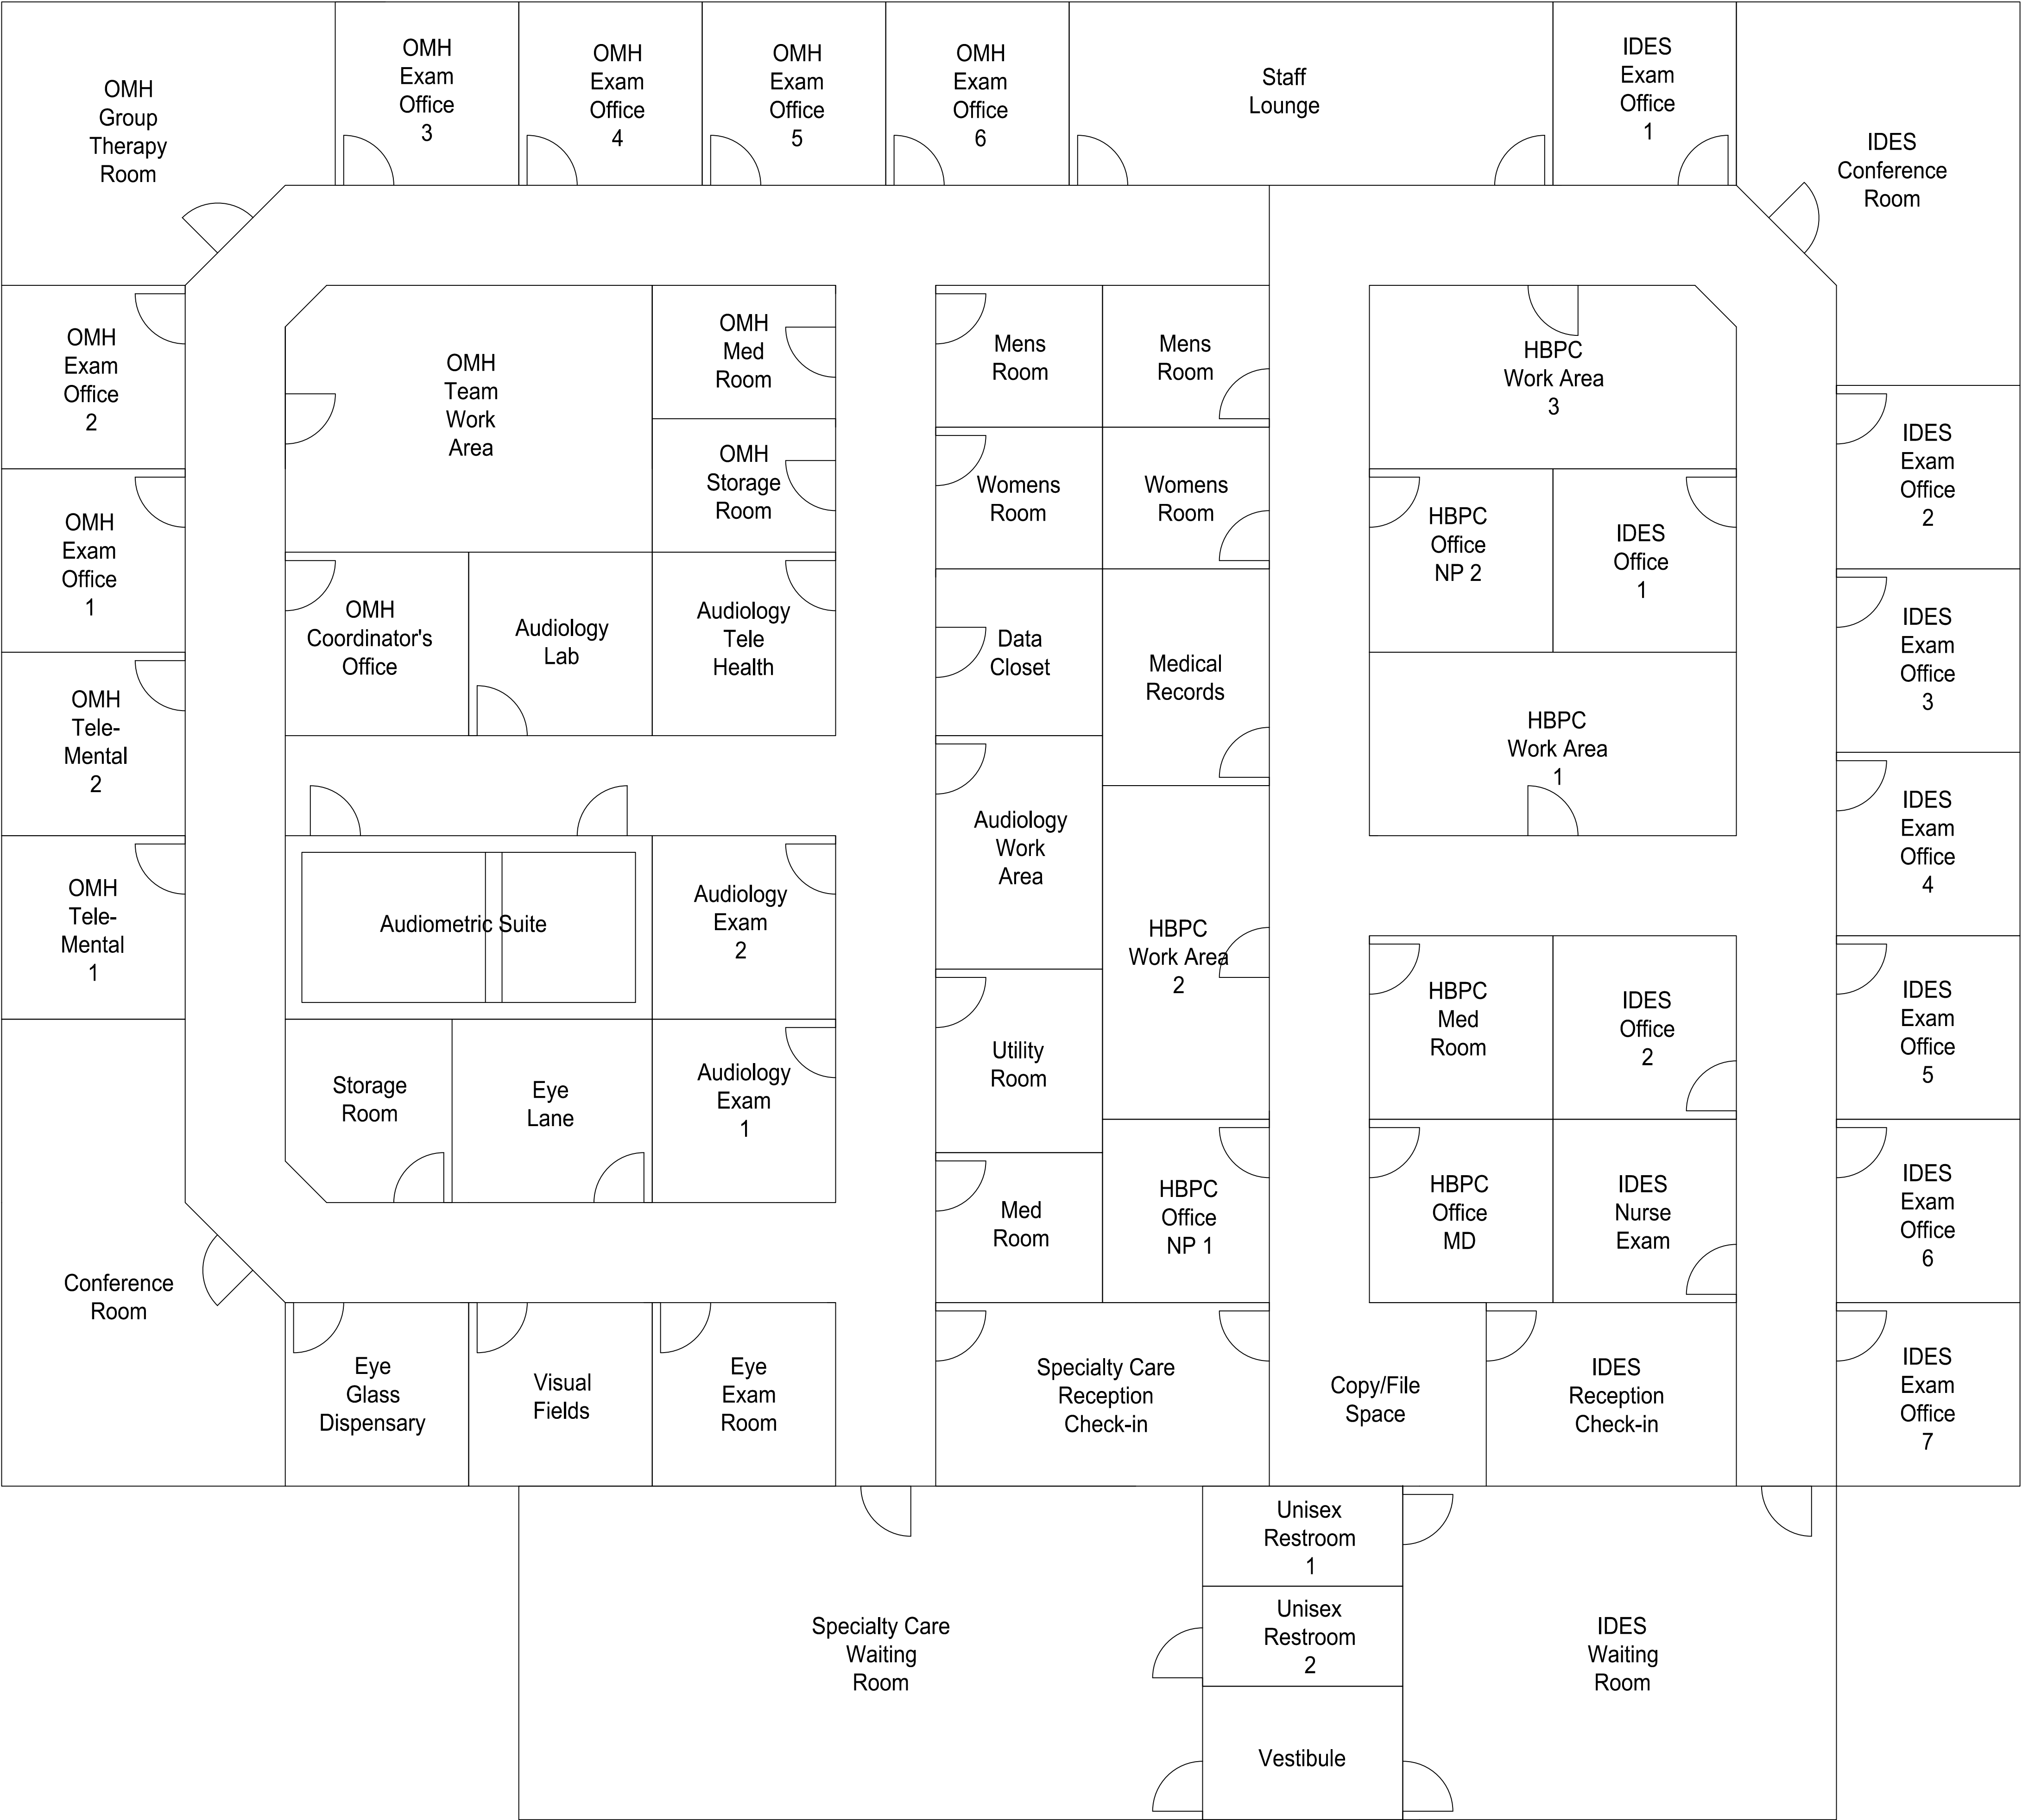


A
B
C
D
E
F

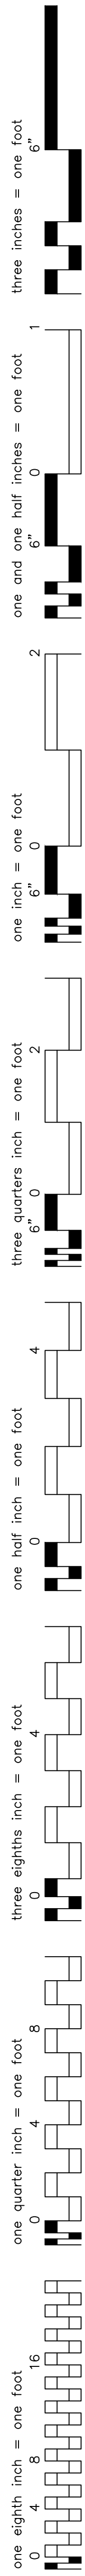

A
B
C
D
E
F

12/5/2016	-
-	-
-	-
-	-
-	-
-	-
-	-
-	-
-	-
Revisions	Date

Drawing Title	FLOOR PLAN
Approved Project Director	

Project Title	Watertown Specialty Care Clinic Lease
Parent Facility Location	800 IRVING AVE SYRACUSE NY
Date	12/5/2016
Checked	FMS
Drawn	TLH
Lease Number	VA528-16-R-0144
Building Number	XXXX
Drawing Number	A-111
Dwg	of 1

Office of Construction and Facilities Management

Department of Veterans Affairs